

 
AS BUILT PLANS


INDEX * DRAWINGS		
DWG. NO.	SHT. NO.	DESCRIPTION
		<u>ARCHITECTURAL</u>
A-1	1	TITLE • LOCATION MAP • PLOT PLAN • INDEX
A-2	2	FLOOR PLAN
A-3	3	EXTERIOR ELEVATIONS
A-4	4	ROOF PLAN • SECTIONS
A-5	5	INTERIOR ELEVATIONS • DETAILS
A-6	6	MILLWORK DETAILS
A-7	7	MISCELLANEOUS EXTERIOR DETAILS
		<u>STRUCTURAL</u>
S-1	8	FOUNDATION & FLOOR FRAMING PLANS
S-2	9	ROOF FRAMING PLAN • DETAILS
		<u>MECHANICAL</u>
M-1	10	MECHANICAL LAYOUT
		<u>ELECTRICAL</u>
E-1	11	ELECTRICAL LAYOUT
E-2	12	ELECTRICAL DETAILS

MATERIALS LEGEND

	WOOD PARTITION
	CONCRETE BLOCK
	CONCRETE

GENERAL NOTES


 — DETAIL OR SECTION
 — DRAWING NUMBER

 
EXTENT OF GRADING
UNDER THIS CONTRACT

NOTE:
ALL CHANGES MADE DURING
CONSTRUCTION HAVE BEEN NOTED
IN RED ON THESE TRACINGS
AND CHECKED BY:

Chas C. Schuster
DISTRICT ENGINEER
2/12/62
DATE

APPROVAL:

<i>John C. Myers</i> Chas. L. Myers	FRANK SOMMERFELD	SEP 29 1960
CHIEF DEPUTY FIRE MARSHAL,		DATE
<i>John C. Myers</i>	JOHN C. MYATT	Sept 29, 1960
DEPUTY STATE HIGHWAY ENGINEER		DATE
<i>Francis J. Cook</i>	BERNARD J. McMOERON	9/29/60
FOR DIRECTOR OF SANITATION, BOARD OF HEALTH		DATE
<i>Gary O. Cook</i>	E. H. COOK	10/3/60
DIRECTOR OF LAND AND NATURAL RESOURCES		DATE
<i>Tim Ho</i>	TIM HO	10/17/60
DIRECTOR OF TRANSPORTATION		DATE

ARCHITECT:
SHOSU KAGAWA
1507 SOUTH KING ST.,
HONOLULU 14, HAWAII

STRUCTURAL ENGINEER
JACK K. TANIYAMA
BOWLING CITY BUILDING
HONOLULU, HAWAII

ELECTRICAL ENGINEER
WYNN M. NAKAMURA
1507 SOUTH KING STREET
HONOLULU, HAWAII

MECHANICAL ENGINEER
CLARENCE I. NAKASHIMA
1111 W. MANU, SUITE 7,
HONOLULU, HAWAII






DEPARTMENT OF TRANSPORTATION
DIVISION OF HIGHWAYS
STATE OF HAWAII

TITLE • LOCATION MAP
PLOT PLAN • INDEX

OFFICE & LABORATORY BUILDINGS
DEPT. OF TRANSPORTATION, HILLO HAWAII

JOB NO. 3130-02-60	DRAWING NO. A 1
DATE SEPT. 30, 1960	1 OF 12 SHEETS

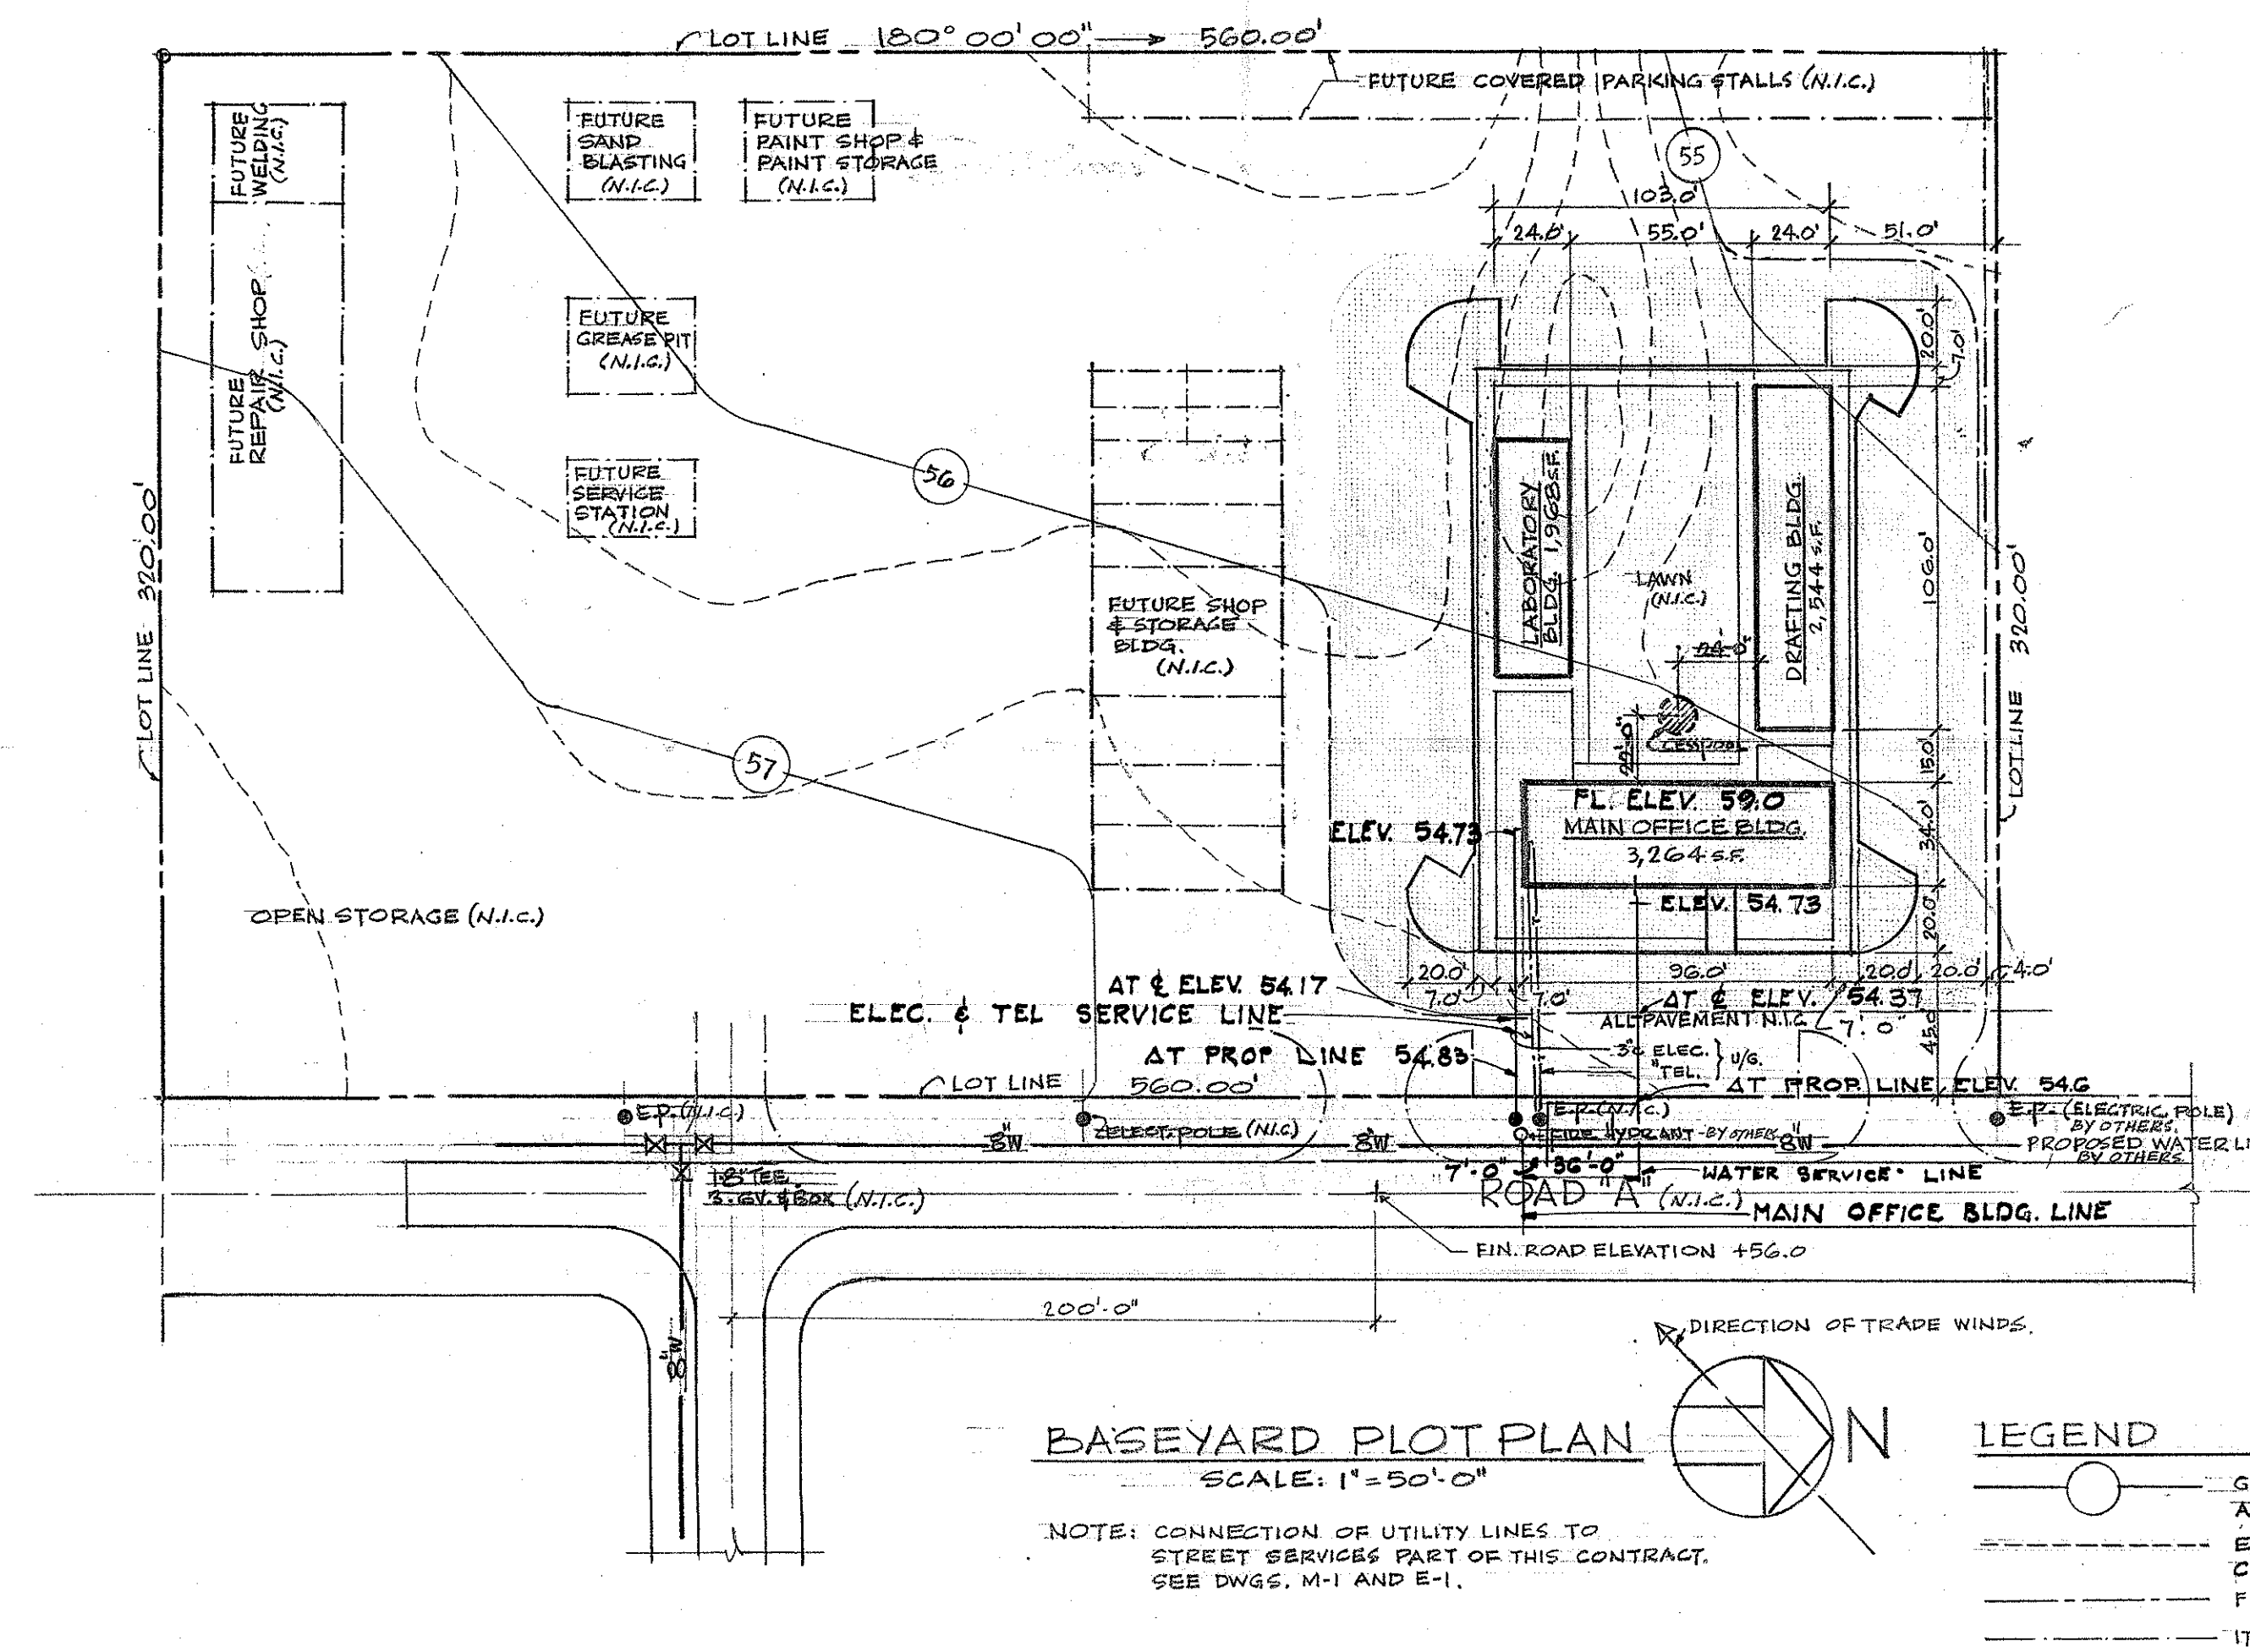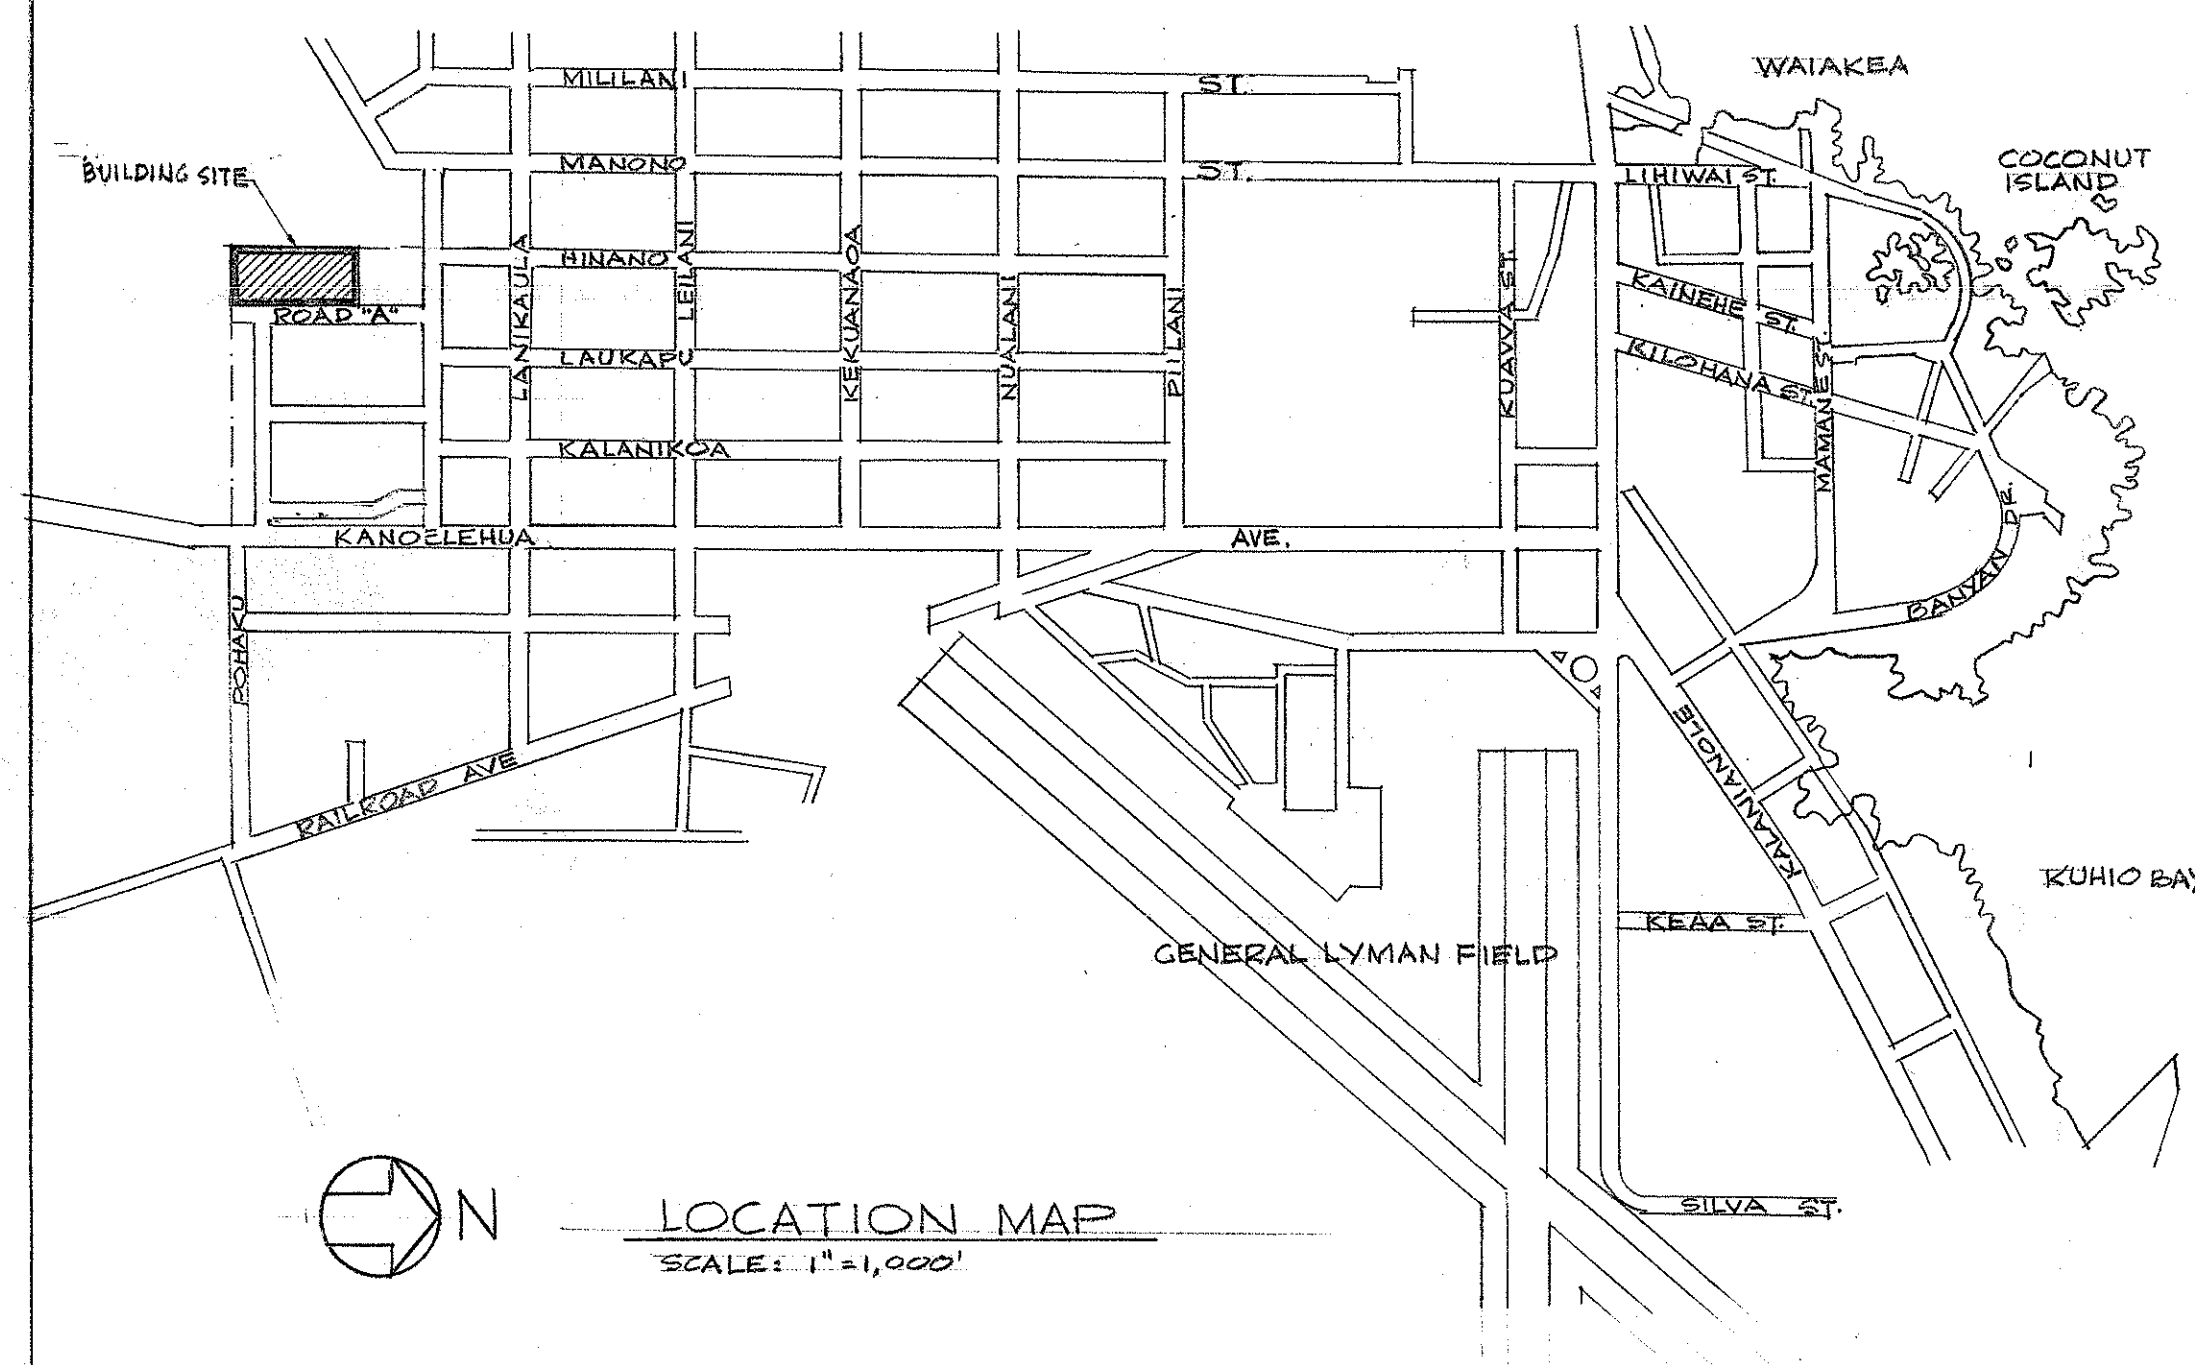

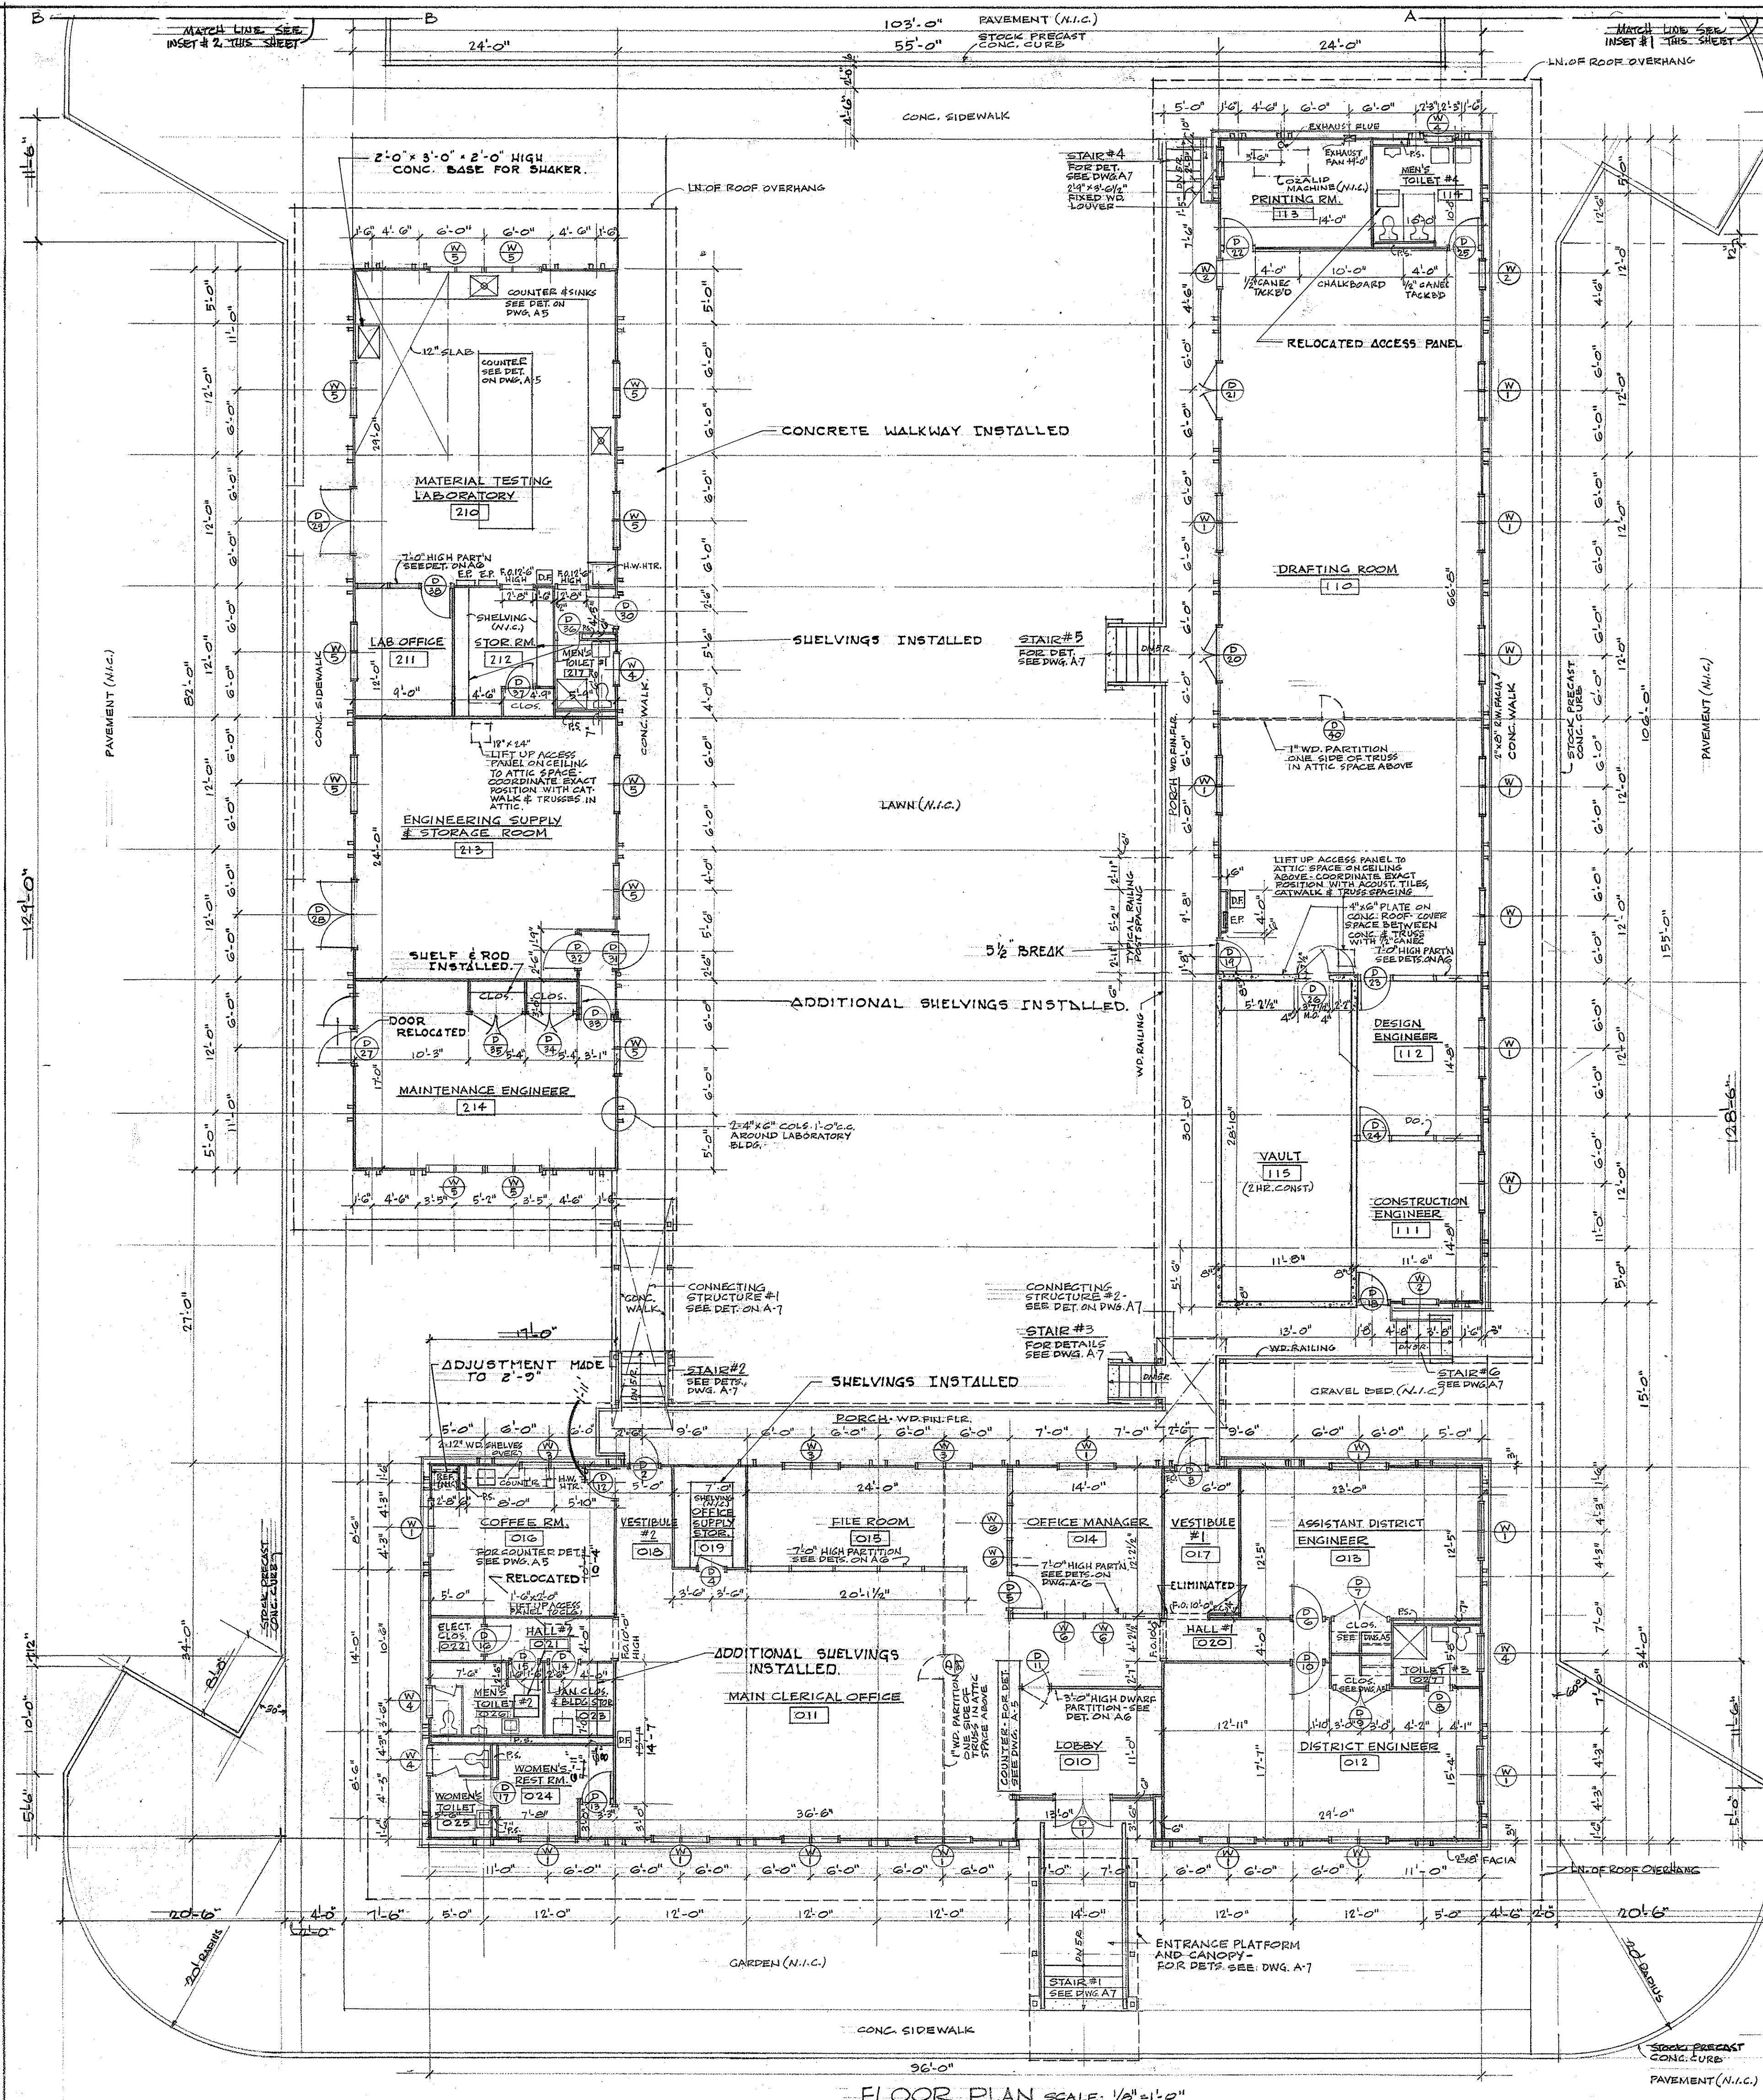

SCHEDULE OF INTERIOR FINISHES

BUILDING	ROOM OR SPACE	SPACE NUMBER	FLOOR					WALL	CEILING	REMARKS
			CONCRETE	WOOD	NO BASE	WOOD	NO BASE			
MAIN OFFICE BUILDING	LOBBY	010								
	MAIN CLERICAL OFFICE	011								
	DISTRICT ENGINEER'S OFFICE	012								
	ASST. DISTRICT ENGINEER	013								
	OFFICE MANAGER'S OFFICE	014								SEE DWG. A-5 FOR DETS. OF 7'-0" PARTITIONS
	FILE ROOM	015								
	COFFEE ROOM	016								
	VESTIBULE #1	017								
	VESTIBULE #2	018								
	OFFICE SUPPLY STOR. RM.	019								
DRAFTING BLDG.	HALL #1	020								
	HALL #2	021								
	ELECTRICAL CLOSET	022								
	JANITOR'S CLOS. & BLDG. STOR.	023								WAINSCOT AS SHOWN ON DWG. A-5
	WOMEN'S REST ROOM	024								
	MEN'S TOILET #1	025								
	MEN'S TOILET #2	026								CHANGED TO CERAMIC TILE
	TOILET #3	027								
	DRAFTING ROOM	110								
	CONSTRUCTION ENGINEER'S OFF.	111								SEE DWG. A-5 FOR DETS. OF 7'-0" PARTITIONS
LAB. BLDG.	DESIGN ENGINEER'S	112								
	PRINTING ROOM	113								
	MEN'S TOILET #4	114								CHANGED TO CERAMIC TILE
	VAULT	115								
	MATERIAL TESTING LAB	210								
	LAB OFFICE	211								
	STORAGE RM.	212								SEE DWG. A-5 FOR DETS. OF 7'-0" PARTITIONS
	ENGINEERING SUPPLY & STOR.	213								
	MAINTENANCE ENGINEER	214								
	VESTIBULE #3	215								

NOTE: ALL CLOSETS SHALL RECEIVE SAME FINISH AS THE SPACES THEY ADJOIN.


DOOR SCHEDULE

LOCATION	MARK	TYPE	SIZE	THICKNESS	FRAME DETAIL	SILL	REMARKS
MAIN OFFICE BUILDING	D1	D	2'-2" 6" x 7'-0"	1 3/4"	B-1 / ON DWG. A-5	OAK	
	D2	A	3'-0" x 7'-0"	1 3/4"	B-2 DO	OAK	
	D3	A	3'-0" x 7'-0"	1 3/4"	B-2 DO	OAK	
	D4	C	2'-0" x 7'-0"	1 3/4"	B-2 DO	NONE	
	D5	A	3'-0" x 7'-0"	1 3/4"	DETS. 23, 24, 25 ON DWG. A-5	DO	
	D6	A	2'-0" x 7'-0"	1 3/4"	B-6 / ON DWG. A-5	DO	
	D7	A	2'-0" x 7'-0"	1 3/4"	B-6 DO	DO	
	D8	A	2'-0" x 7'-0"	1 3/4"	B-6 DO	DO	
	D9	A	2'-0" x 7'-0"	1 3/4"	B-6 DO	DO	
	D10	A	2'-0" x 7'-0"	1 3/4"	B-6 DO	DO	
DRAFTING BLDG.	D11	E	2'-0" x 2'-7"	1 3/4"	DETS. 26, 27, 28 ON DWG. A-5	DO	DOOR DET. 26, 27 ON DWG. A-5
	D12	A	2'-0" x 7'-0"	1 3/4"	B-6 / ON DWG. A-5	DO	
	D13	A	2'-0" x 7'-0"	1 3/4"	B-6 DO	DO	
	D14	C	2'-0" x 7'-0"	1 3/4"	B-6 DO	DO	
	D15	A	2'-0" x 7'-0"	1 3/4"	B-6 DO	DO	
	D16	C	2'-0" x 7'-0"	1 3/4"	B-6 DO	DO	
	D17	A	2'-4" x 7'-0"	1 3/4"	B-6 DO	DO	
	D18	A	3'-0" x 7'-0"	1 3/4"	B-5 DO	OAK	
	D19	A	3'-0" x 7'-0"	1 3/4"	B-5 DO	OAK	
	D20	D	2'-0" x 7'-0"	1 3/4"	B-5 DO	OAK	
LAB. BLDG.	D21	D	2'-0" x 7'-0"	1 3/4"	B-5 DO	OAK	
	D22	A	3'-0" x 7'-0"	1 3/4"	B-5 DO	OAK	
	D23	A	3'-0" x 7'-0"	1 3/4"	DETS. 22, 23, 24 ON DWG. A-5	DO	
	D24	A	3'-0" x 7'-0"	1 3/4"	DO	DO	
	D25	A	2'-0" x 7'-0"	1 3/4"	B-6 / ON DWG. A-5	DO	
	D26	F	3'-0" x 7'-0"	1 3/4"	BY DOOR MFG'G.		2 HR. FIRE DOOR, 3' x 7' x 1 1/2" BENG. WALL, STG. 1/2" TR. CONG. JAMB.
	D27	D	3'-0" x 7'-0"	1 3/4"	B-5 / ON DWG. A-5	CONG.	
	D28	A	2'-3'-0" x 7'-0"	1 3/4"	B-4 DO	CONG.	
	D29	A	2'-3'-0" x 7'-0"	1 3/4"	B-4 DO	CONG.	
	D30	A	3'-0" x 7'-0"	1 3/4"	B-2 DO	CONG.	


WINDOW SCHEDULE

MARK	SIZE	FRAME DETAIL	REMARKS
W-1	5'-1 1/2" x 6'-2 1/2"	W-1 / ON DWG. A-5	WINDOW SECTIONS SHOWN WITH FRAME DETAILS - SEE DWG. A-5
W-2	3'-0" x 6'-2 1/2"	W-2 DO	
W-3	5'-1 1/2" x 3'-6 1/4"	W-3 DO	
W-4	2'-9" x 3'-6 1/4"	W-4 DO	
W-5	5'-1 1/2" x 4'-10 1/2"	W-5 DO	
W-6	8'-0" x 1'-10 1/2"	DETS. 23, 24, 25, 26 ON DWG. A-5	

NOTE: GLASS TYPES SHOWN ON ELEVATIONS, DWG. A-5.

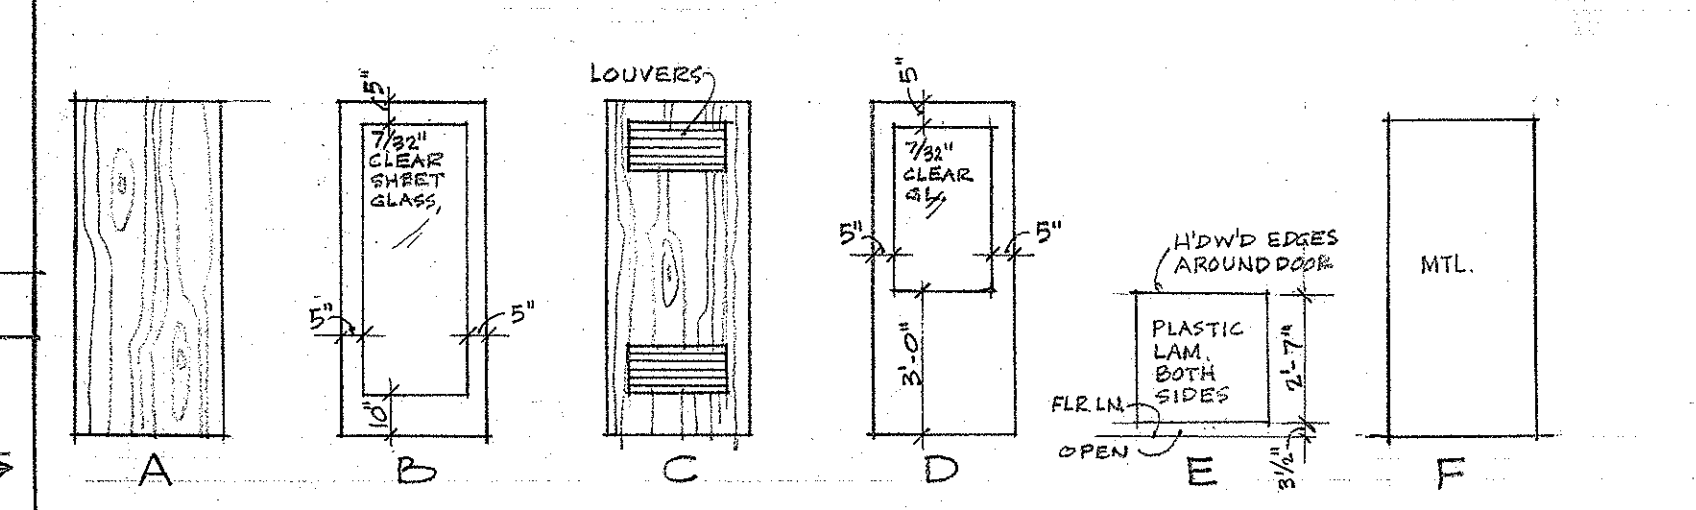

DOOR TYPES

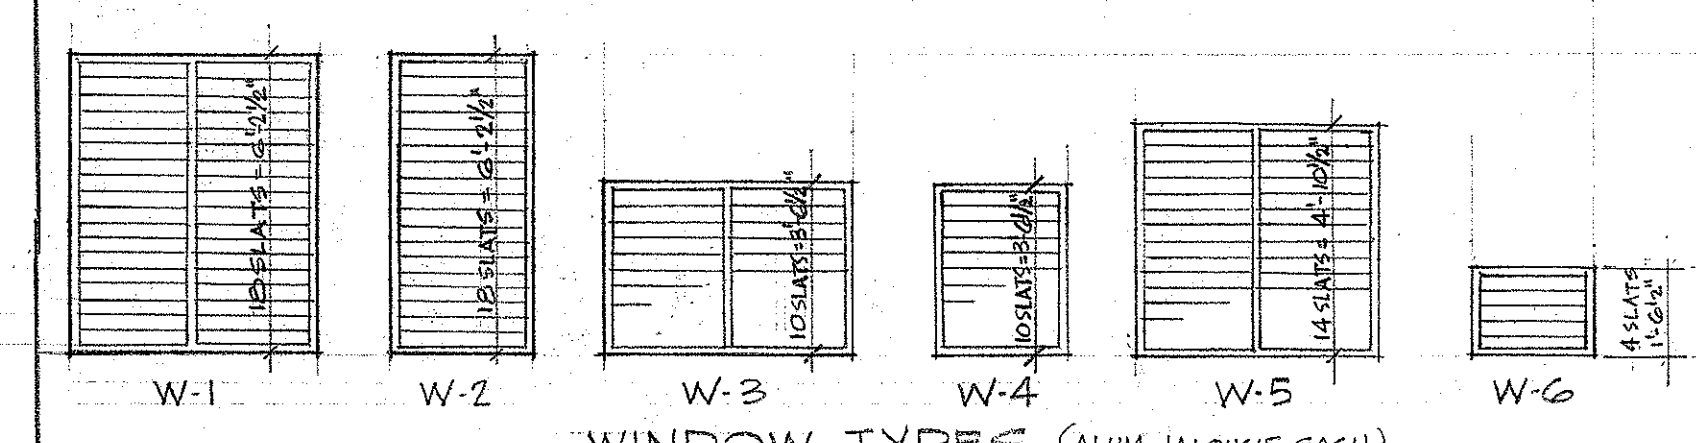

WINDOW TYPES (ALUM. JALOUSIE SASH)












- ABBREVIATIONS
- 1. H.W. HTR. = HOT WATER HEATER
 - 2. P.S. = PIPE SPACE
 - 3. F.O. = FRAMED OPENING
 - 4. D.R. = DRINKING FOUNTAIN
 - 5. E.P. = ELECTRIC PANEL
 - 6. E.C. = ELECTRIC CHASE

DEPARTMENT OF TRANSPORTATION
DIVISION OF HIGHWAYS
STATE OF HAWAII

FLOOR PLAN

OFFICE & LABORATORY BUILDINGS
DEPT. OF TRANSPORTATION - HIL, HAWAII

JOB NO. 3130-02-60
DATE SEP. 25, 1960
DRAWING NO. A2
SHEET 2 OF 2

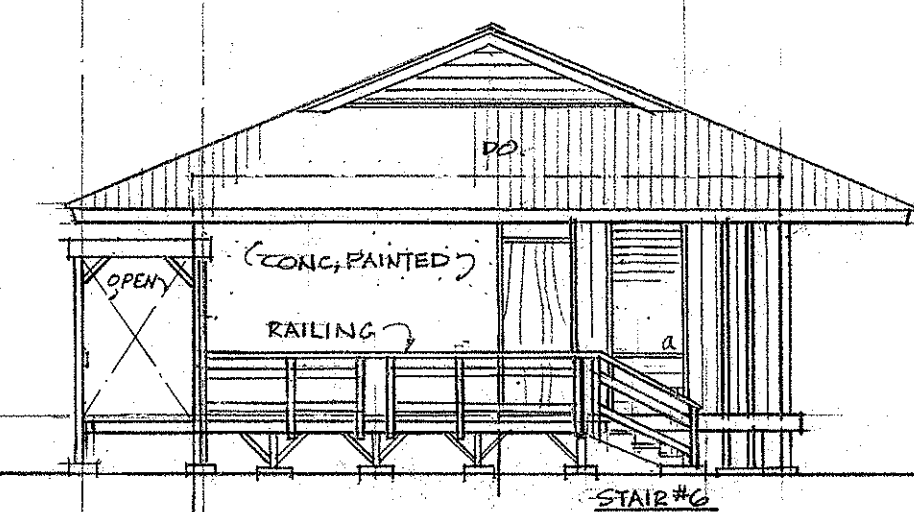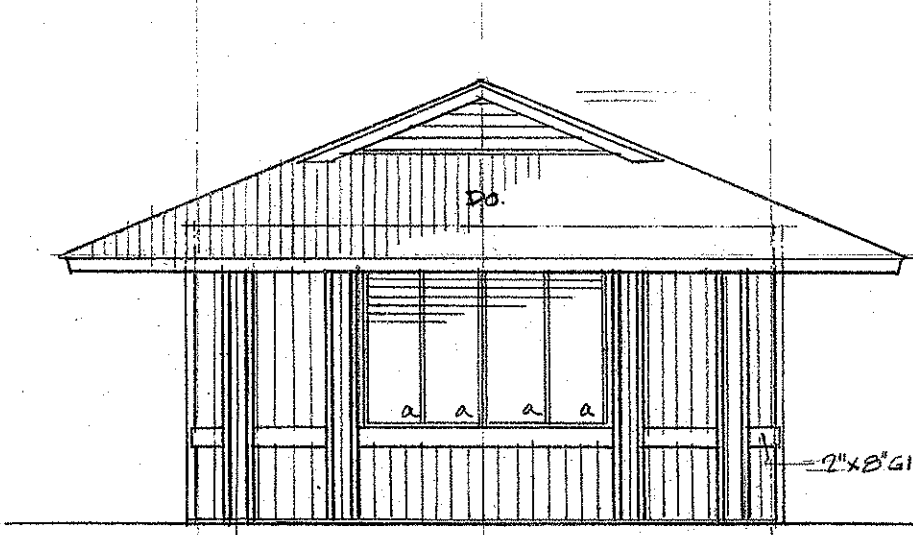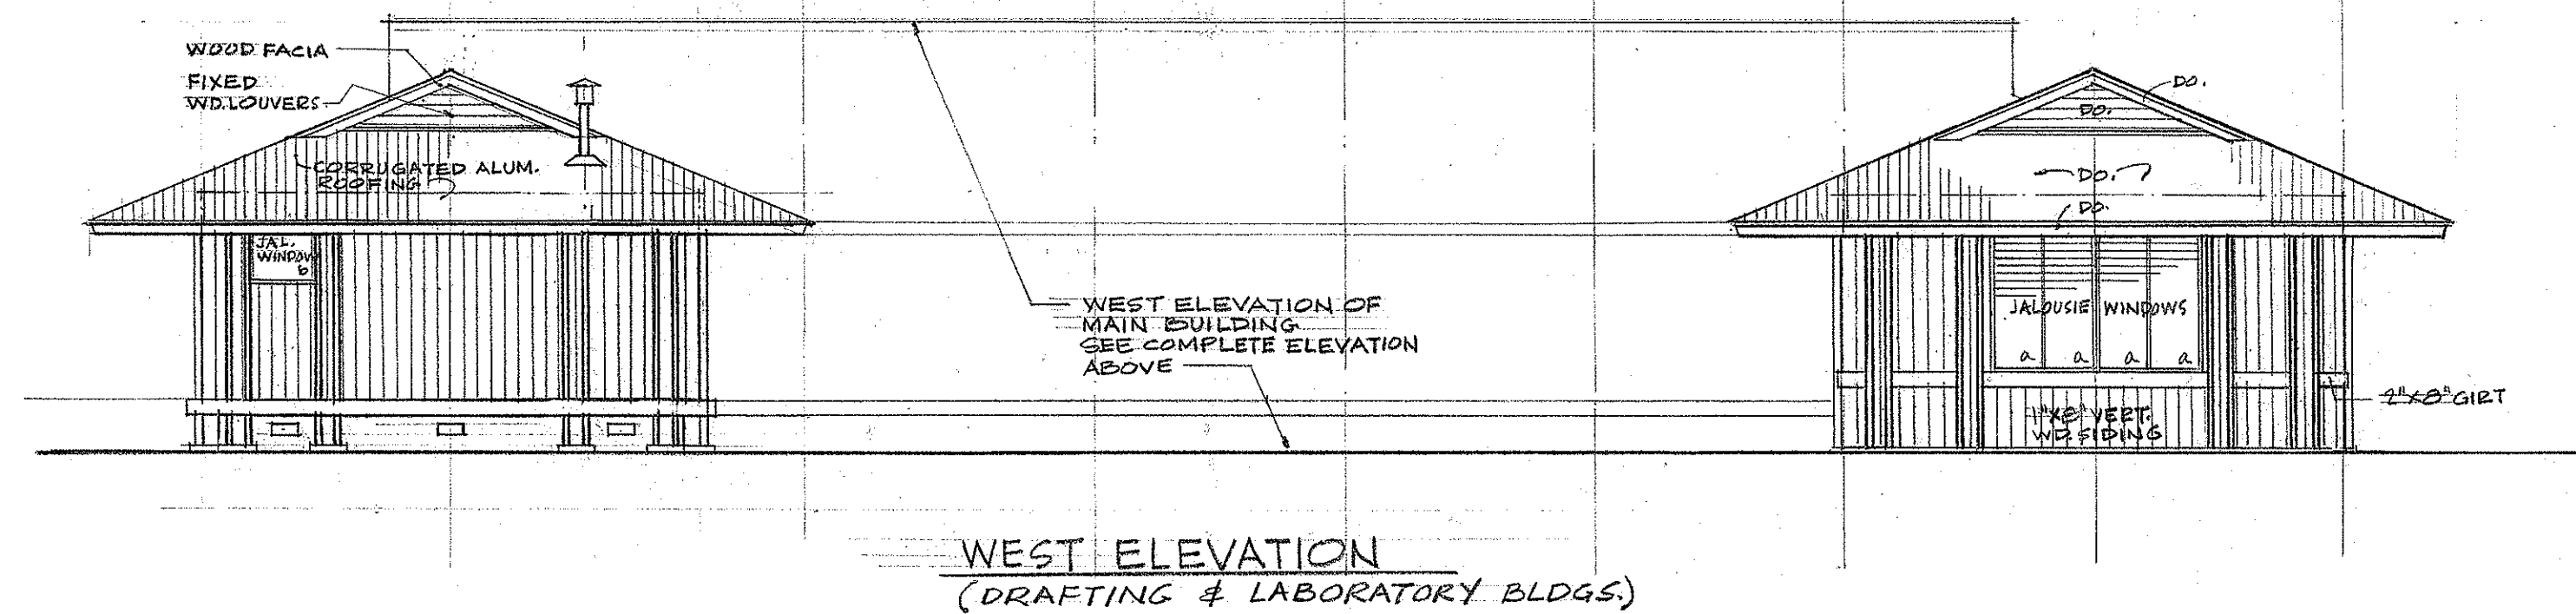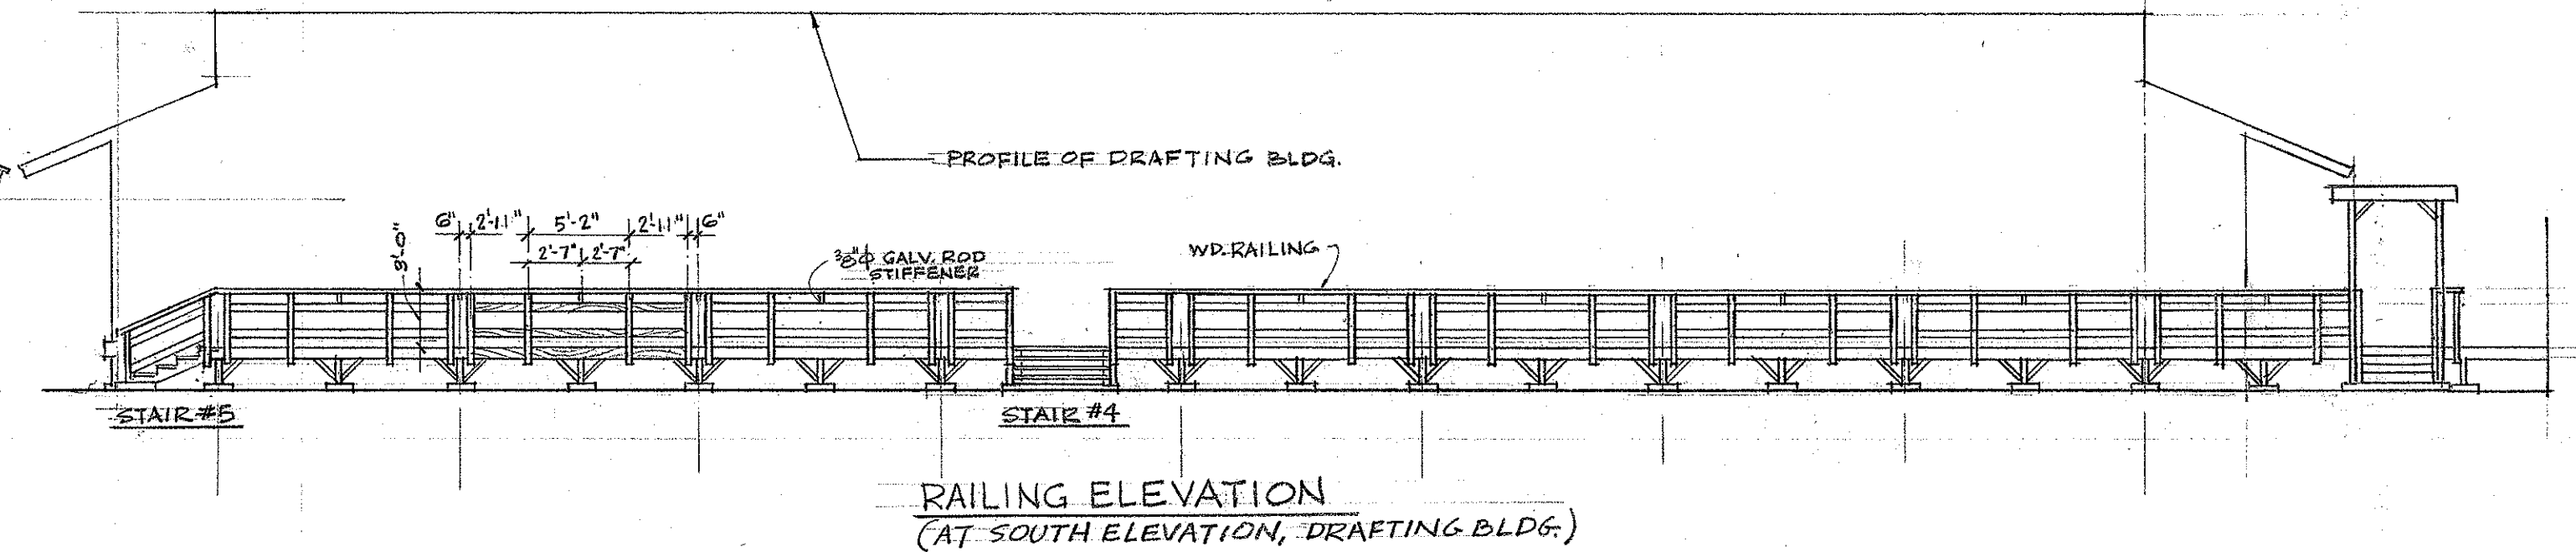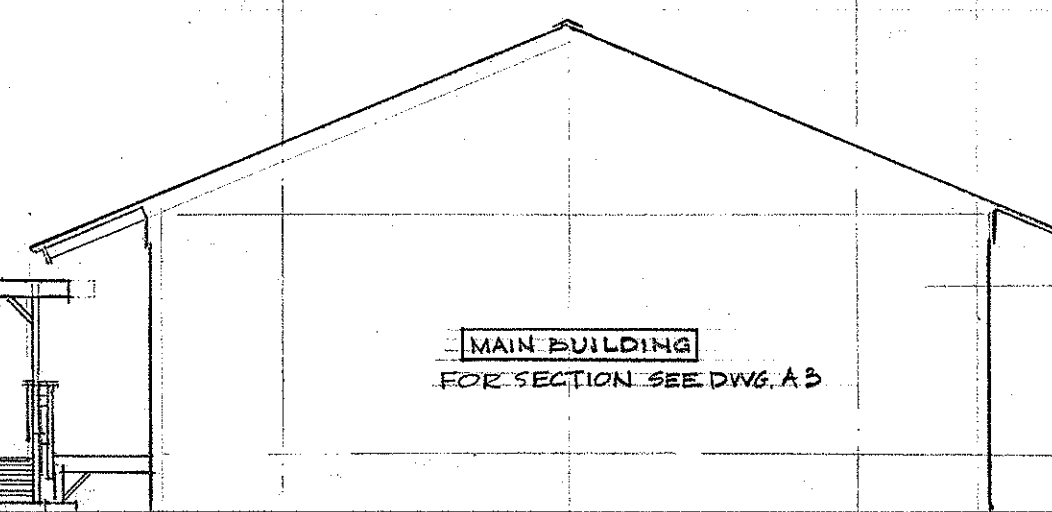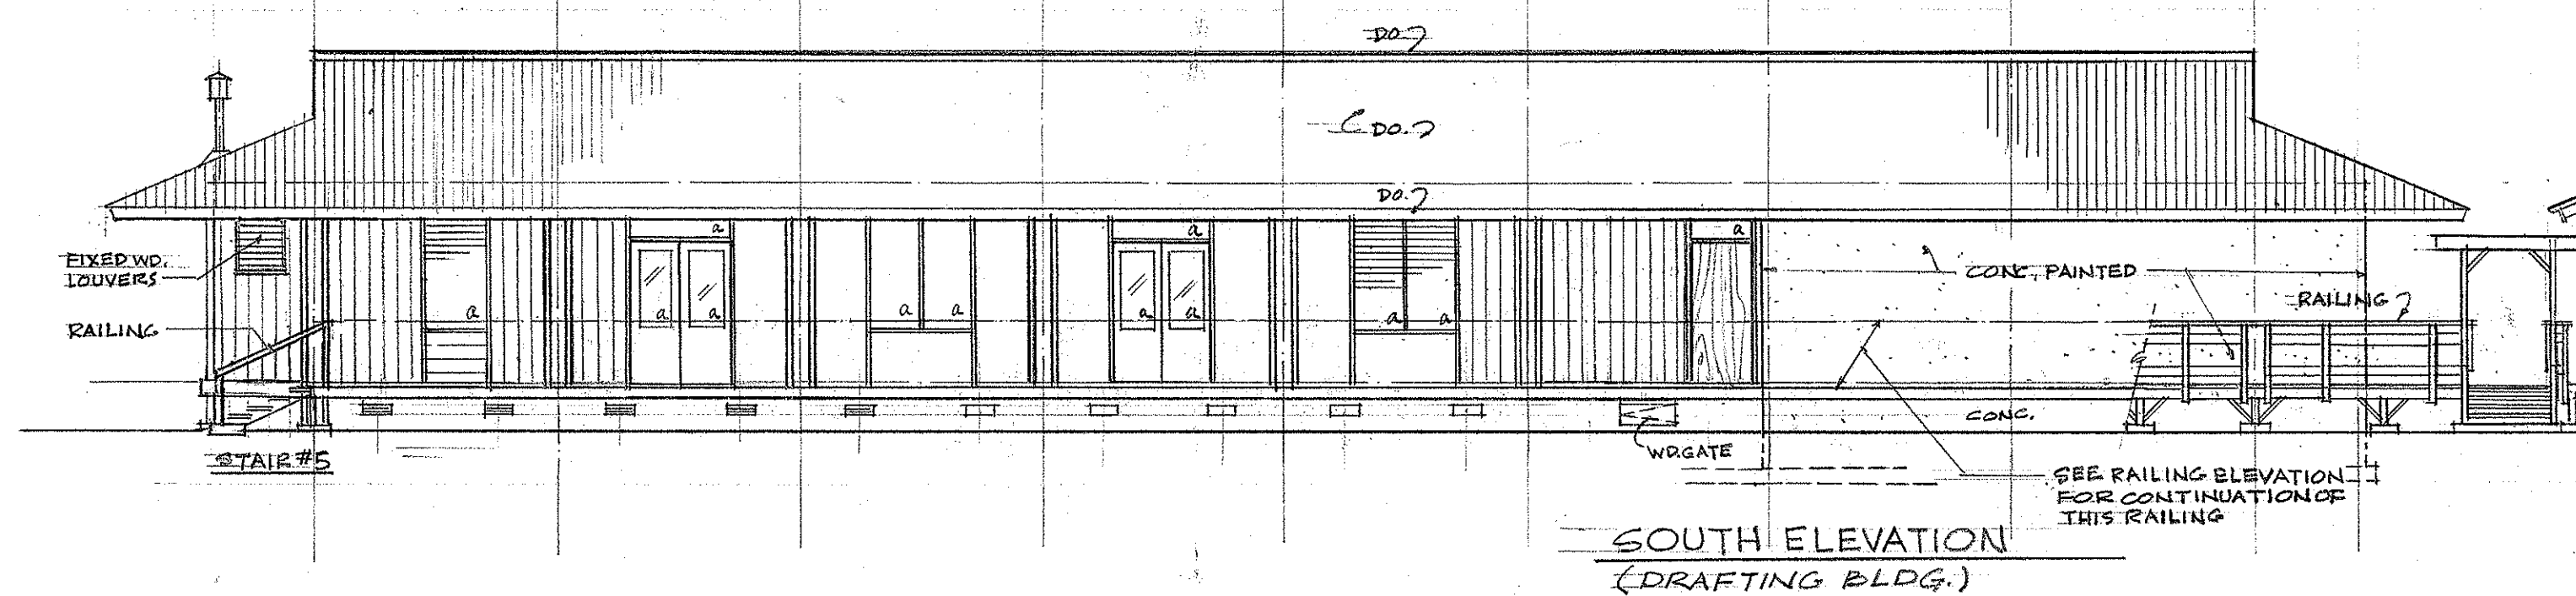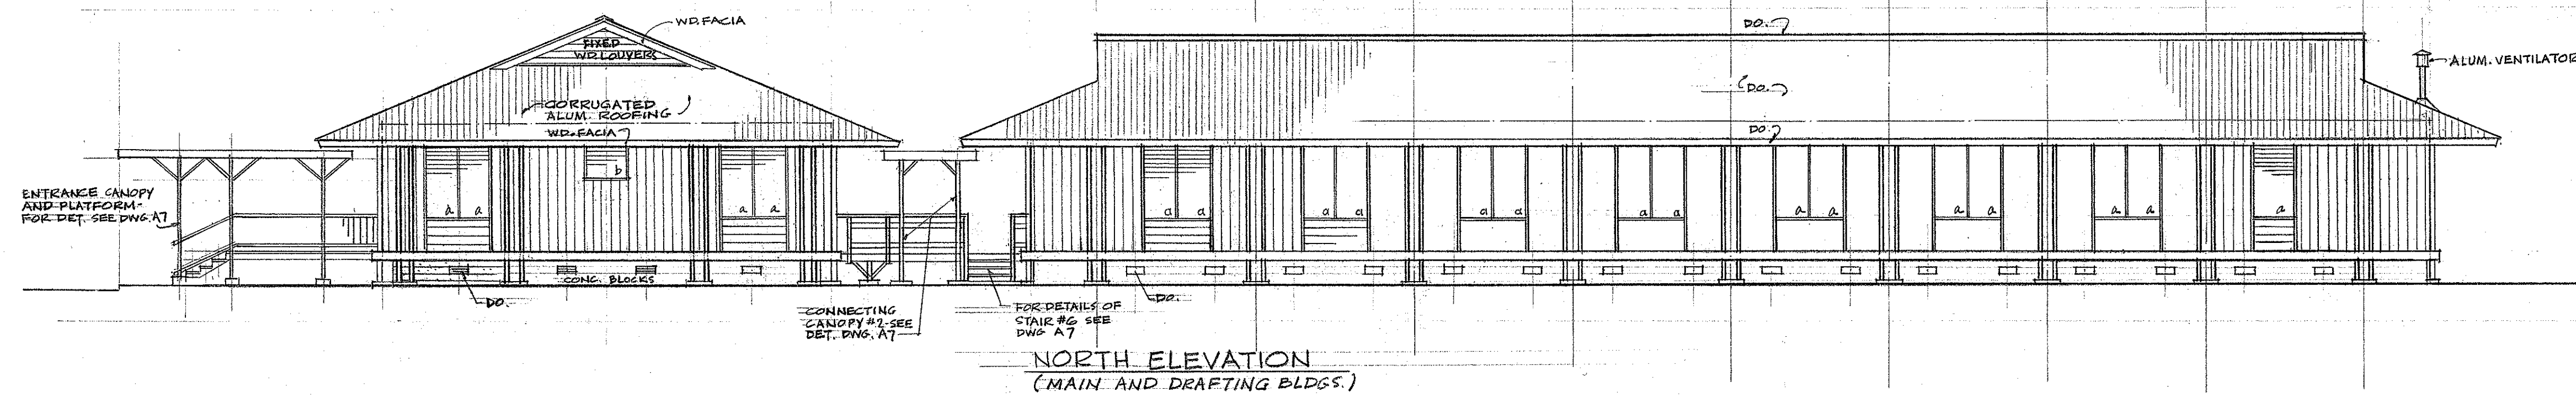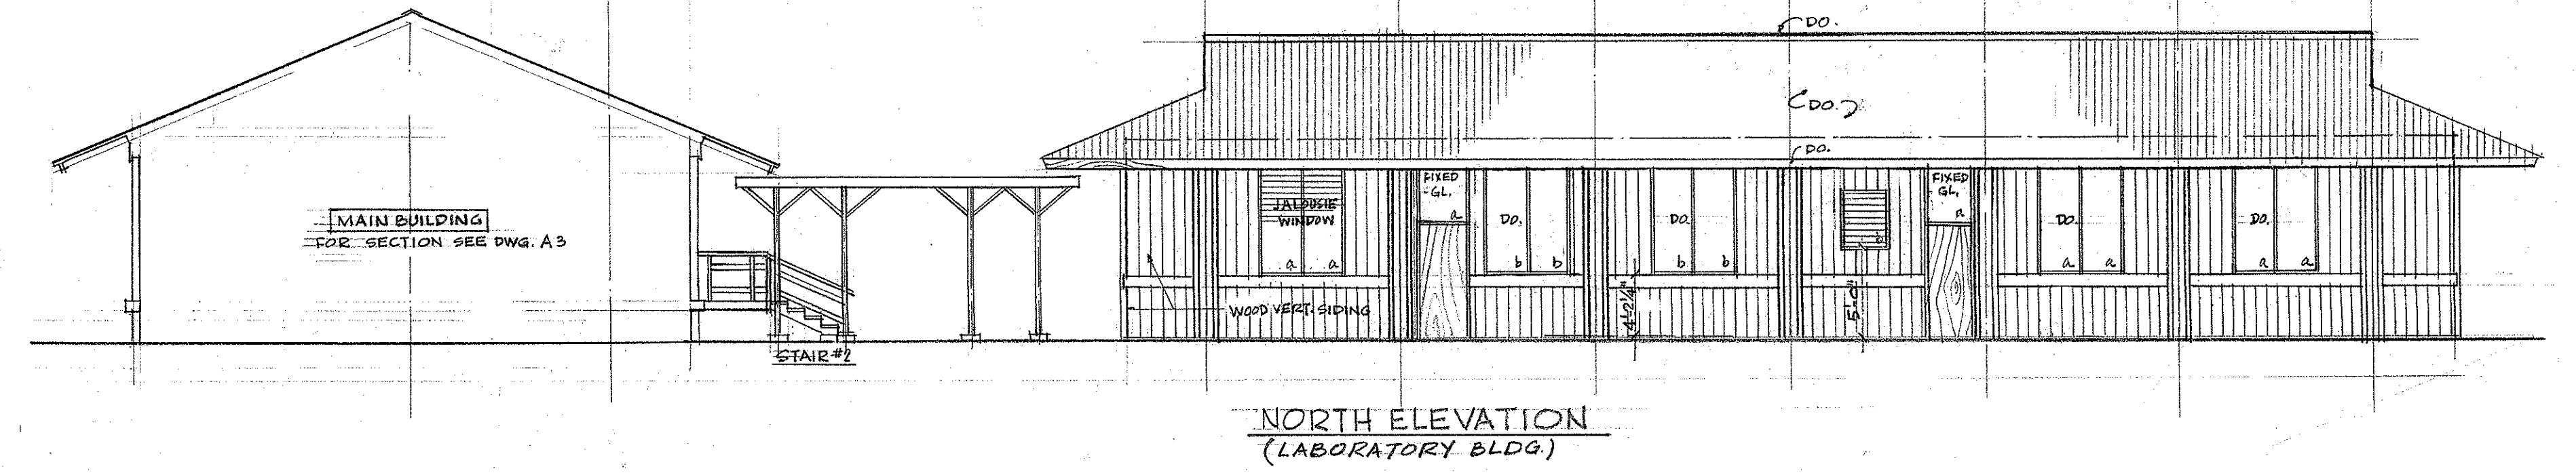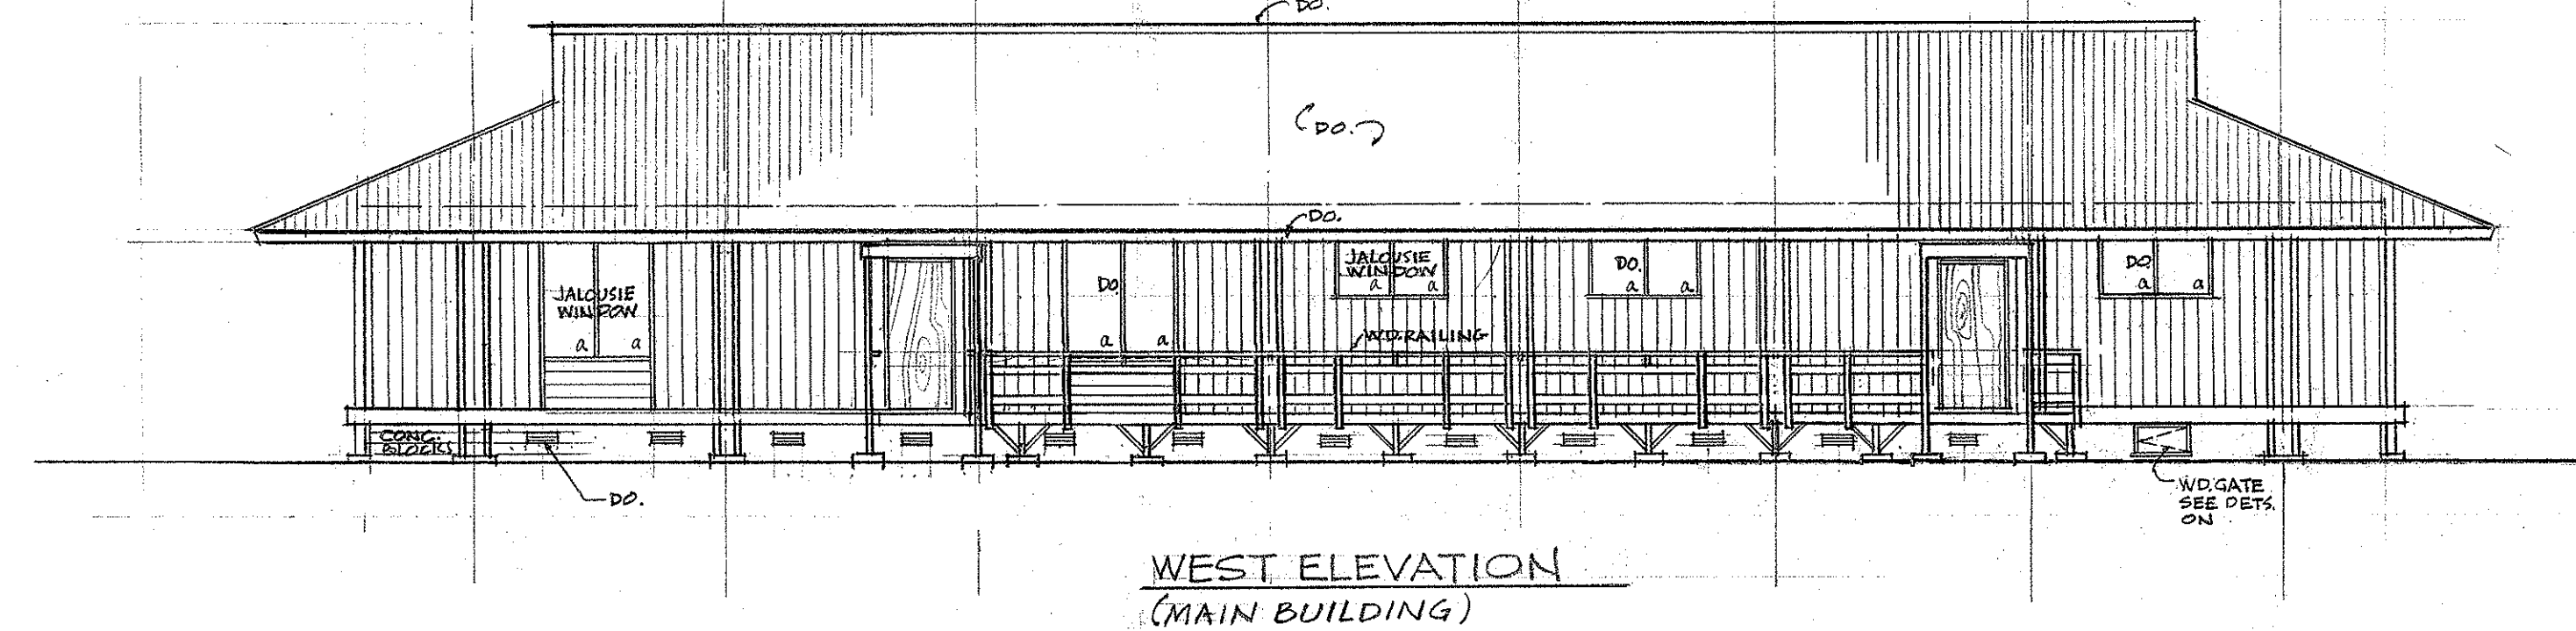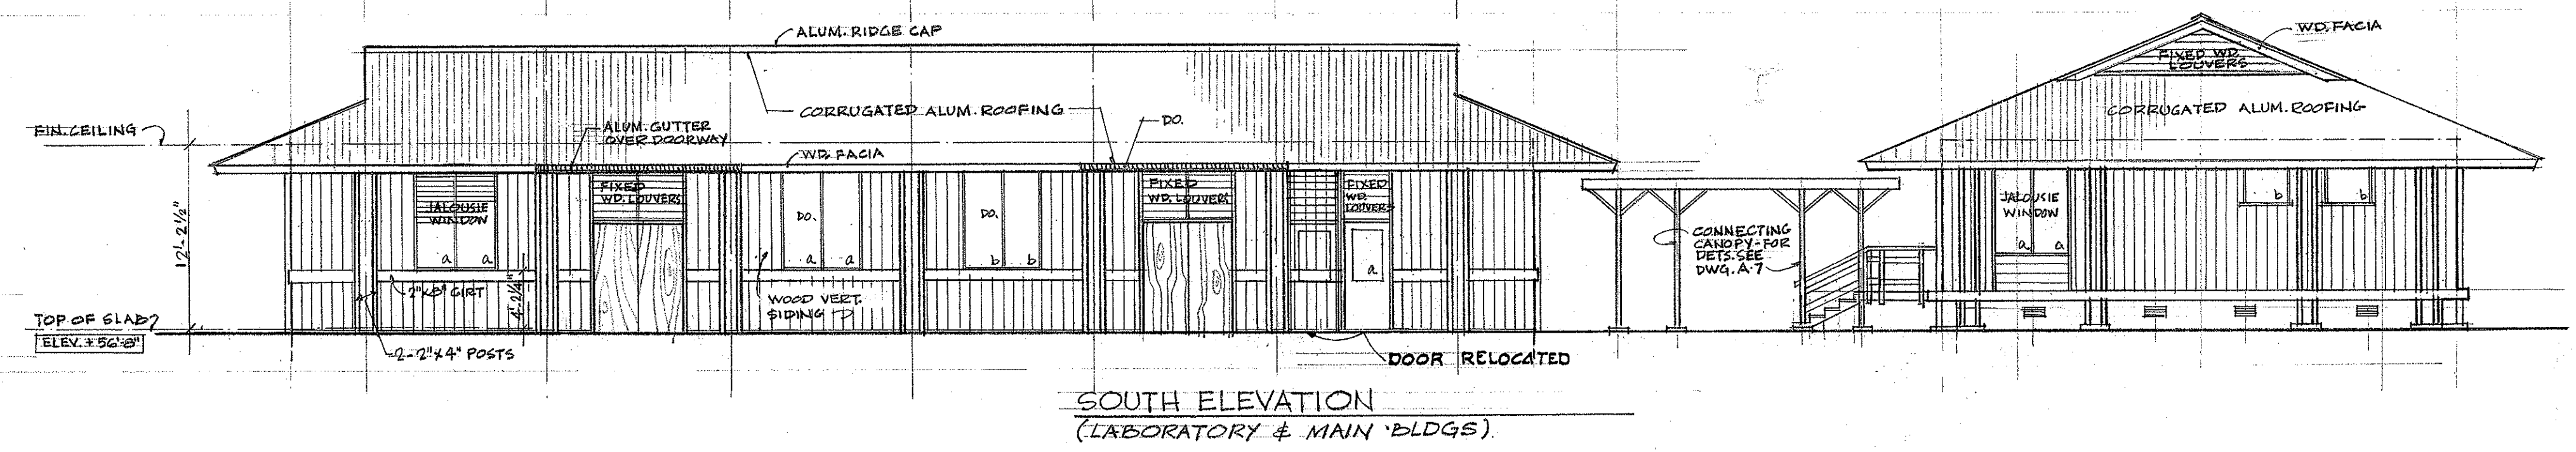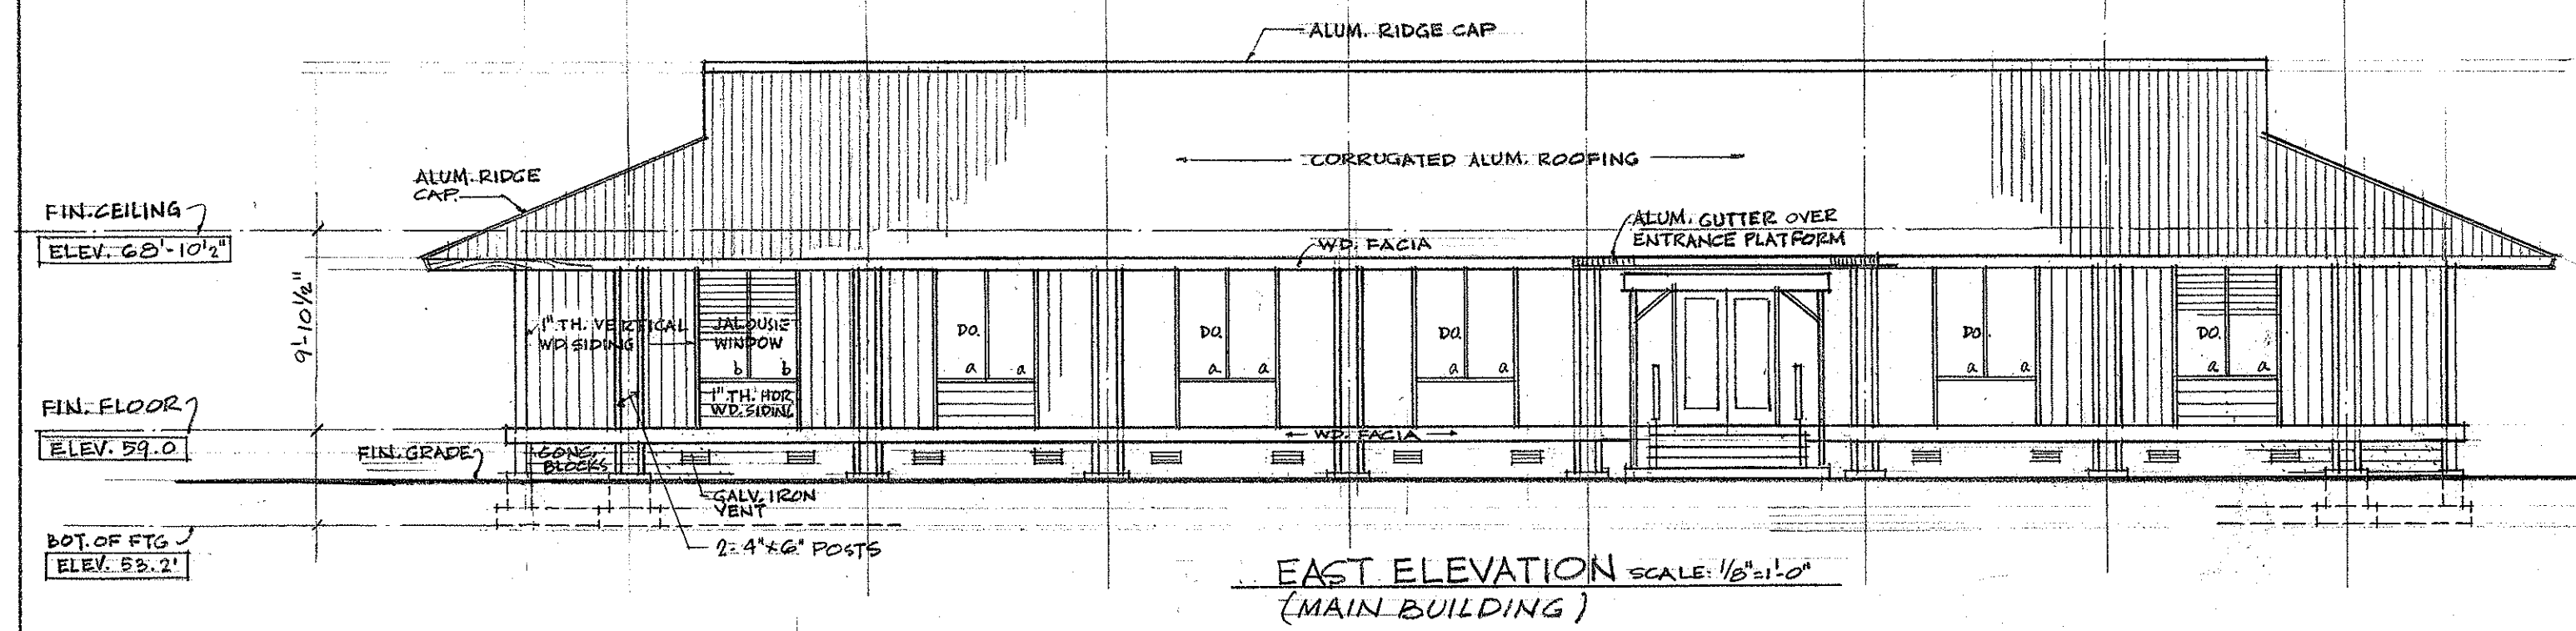


NOTE:


1. GLASS TYPES DENOTED AS FOLLOWS:

a. CLEAR GLASS


b. OBSCURE GLASS

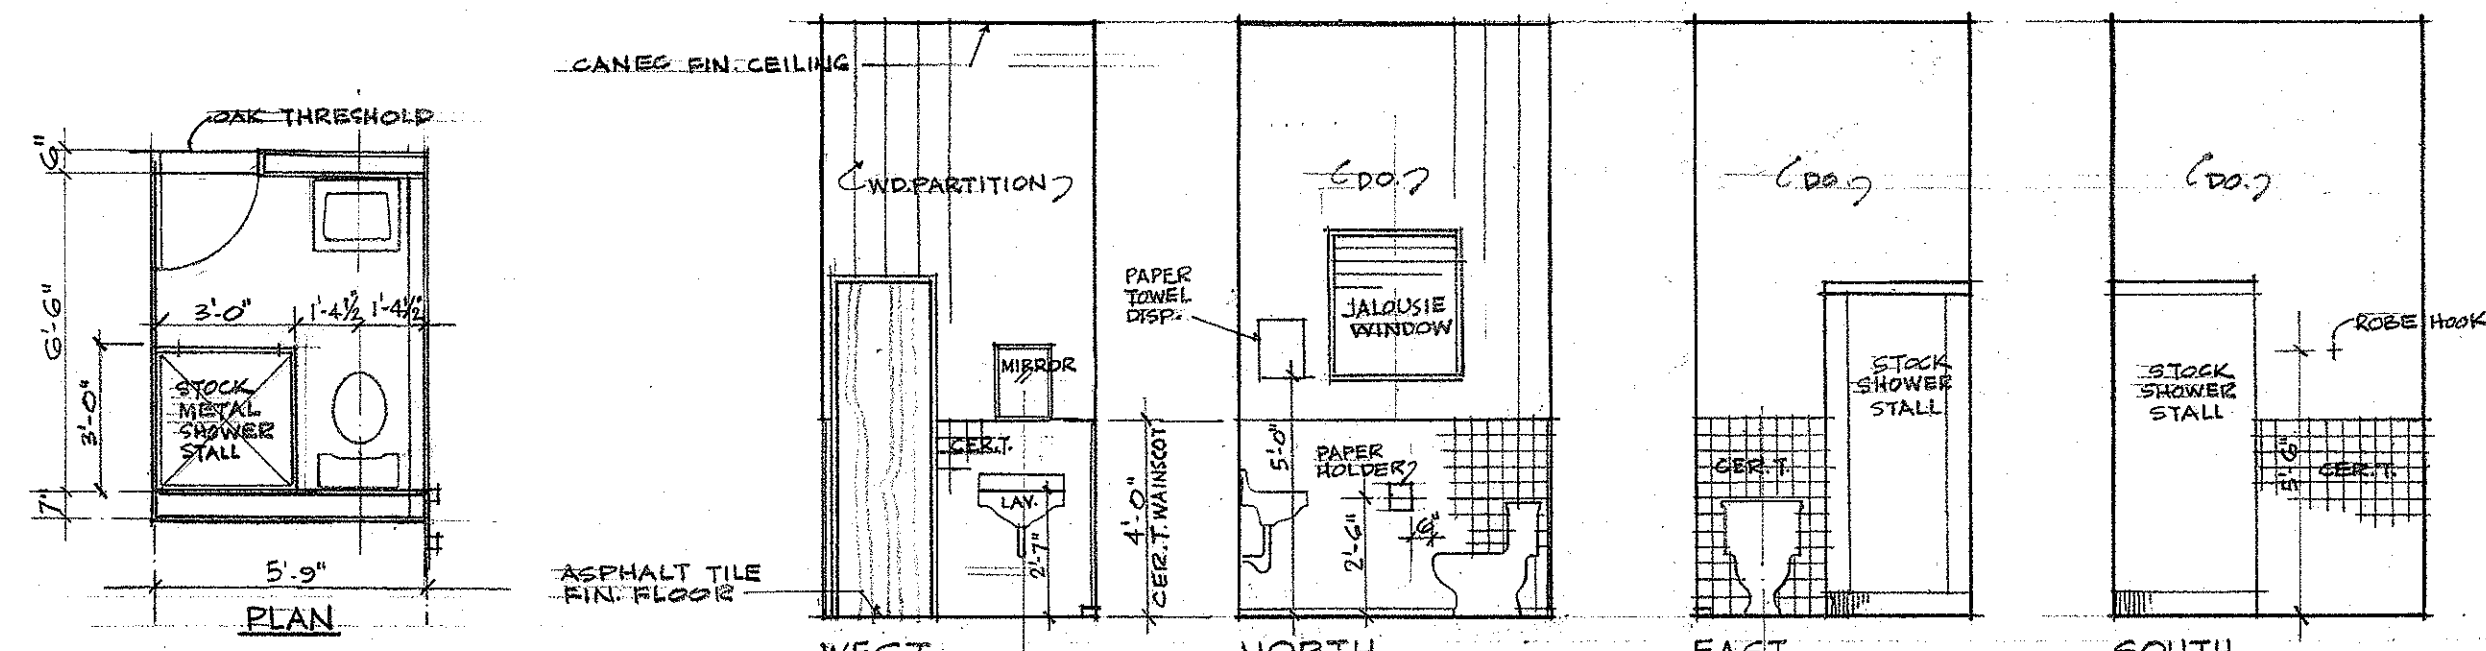


MEN'S TOILET #1 SCALE: 1/4"=1'-0"

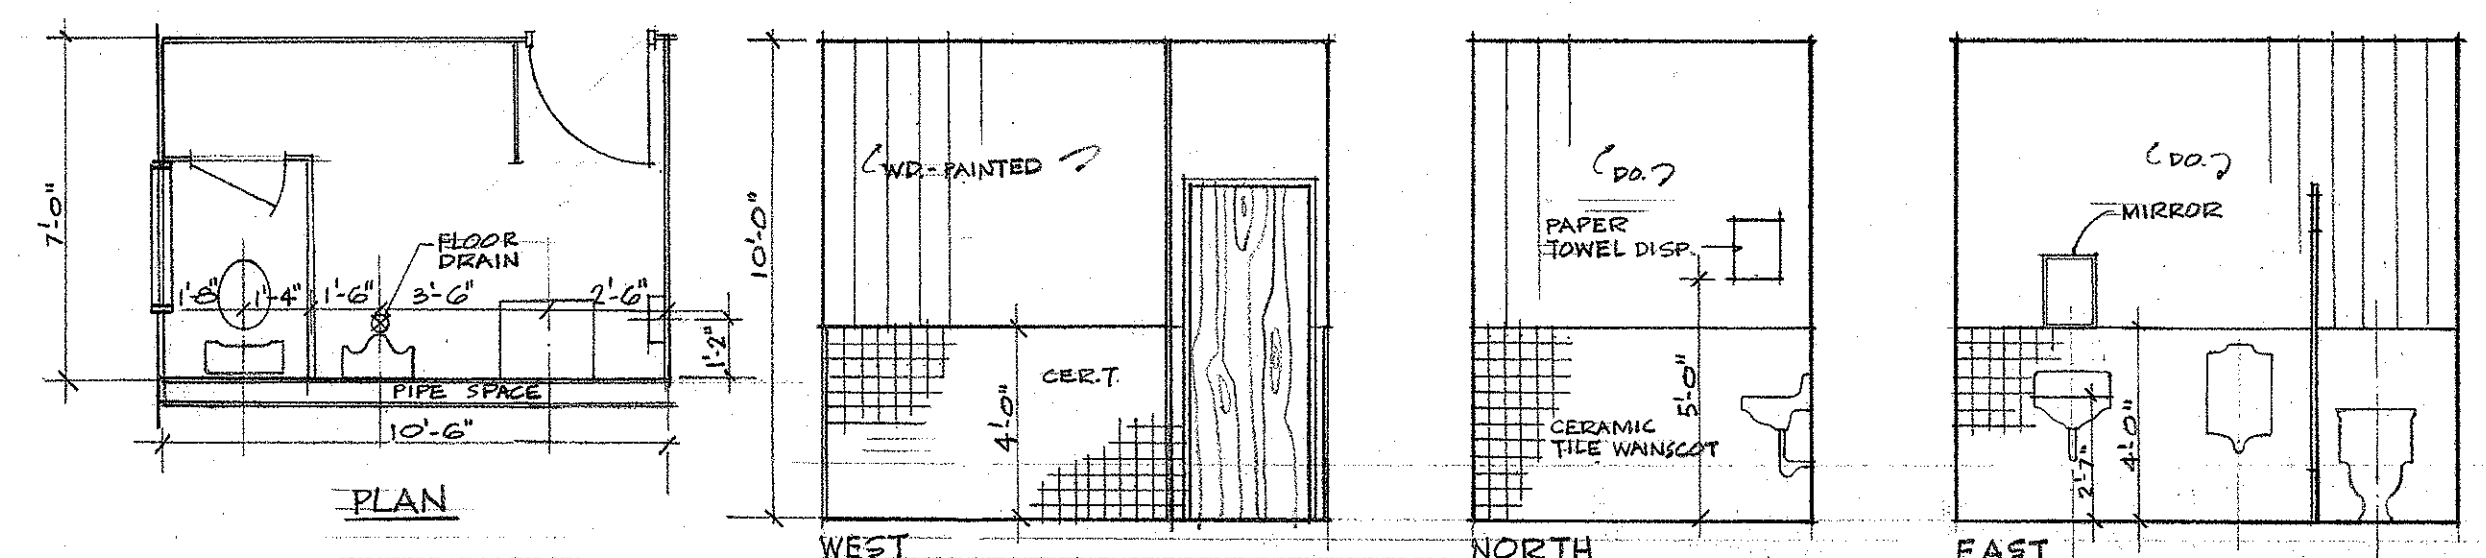


MEN'S TOILET #2 SCALE: 1/4"=1'-0"

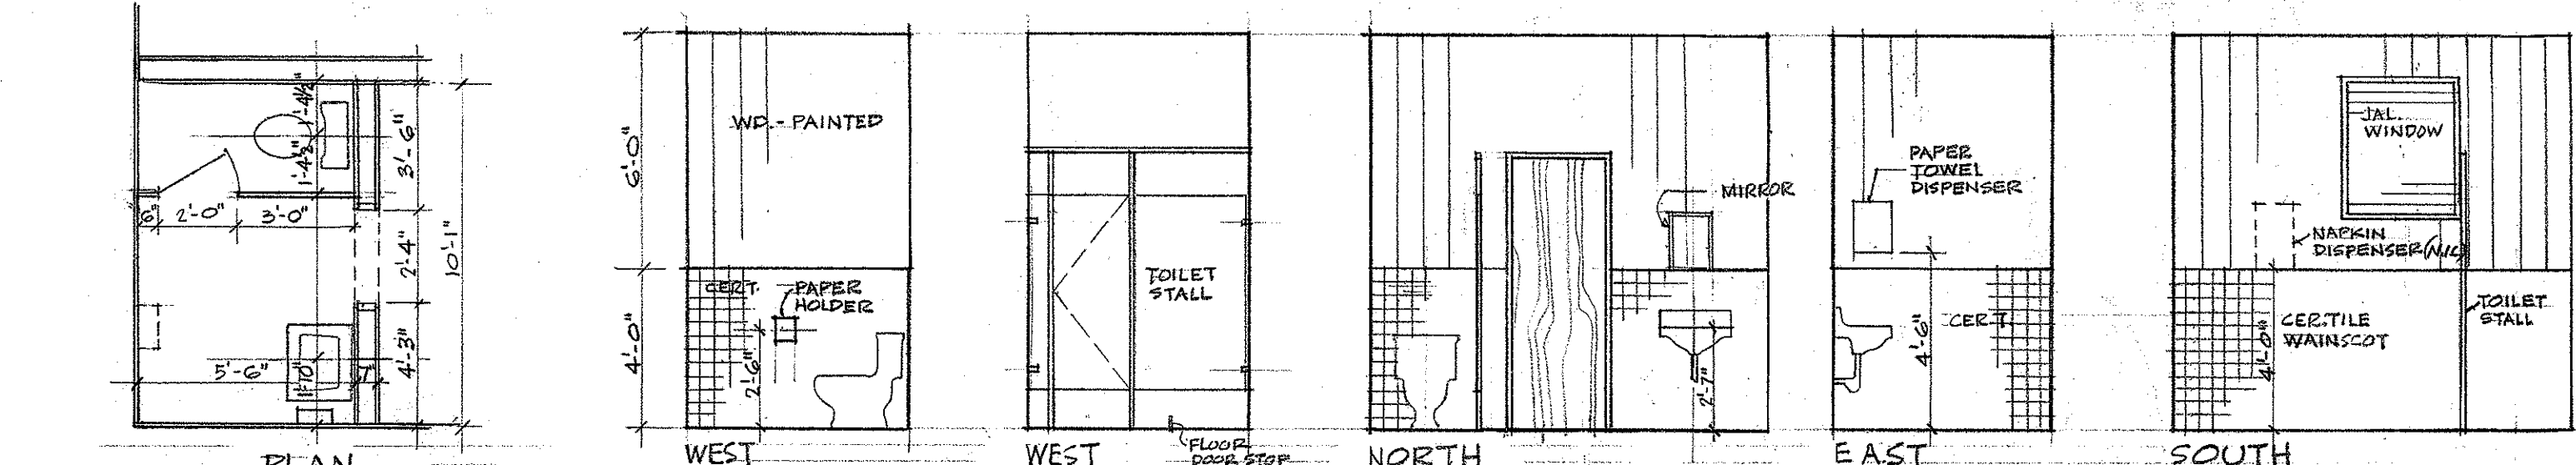


WOMEN'S TOILET

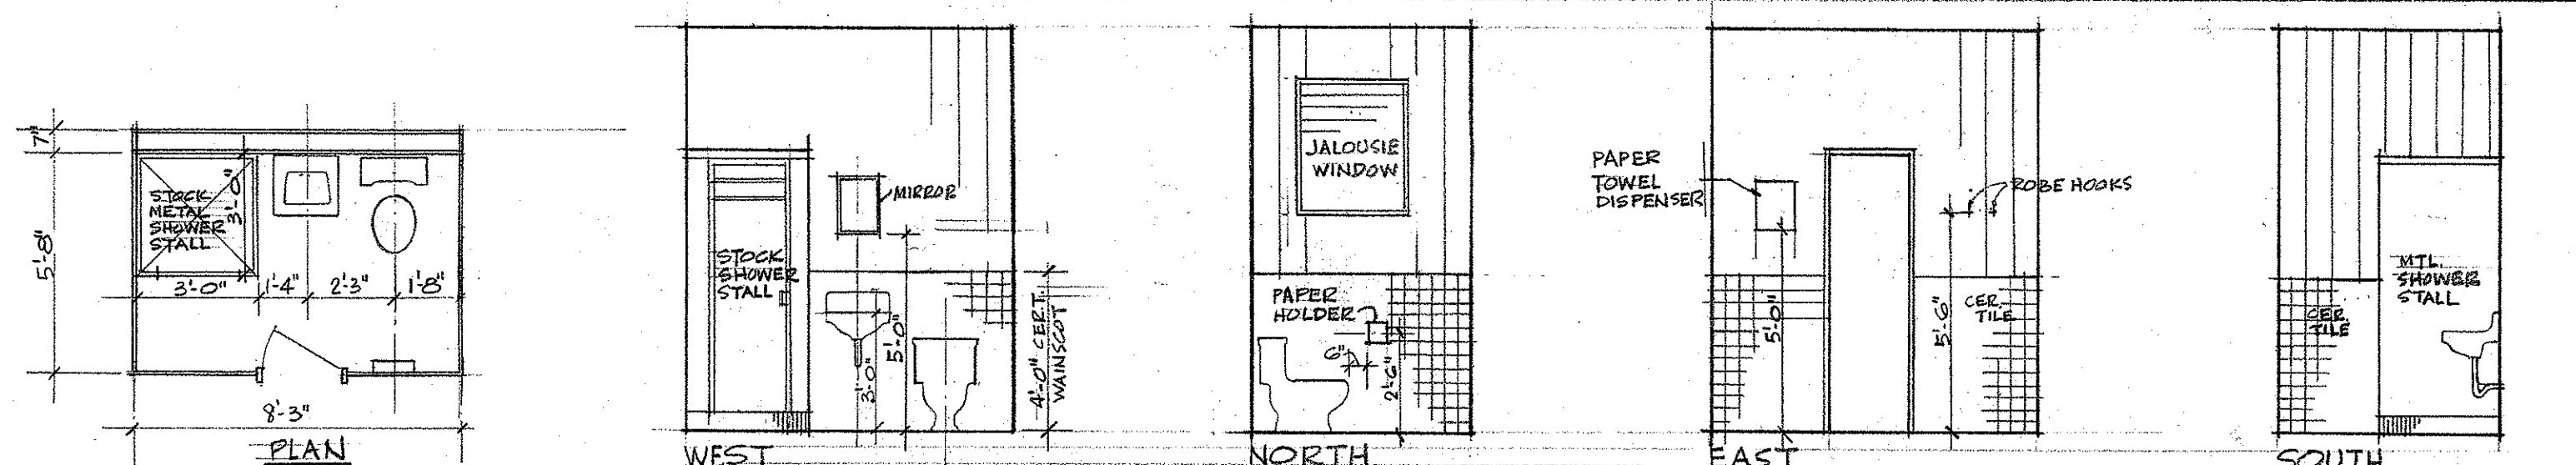


















TOILET #3 SCALE: 1/4"=1'-0"

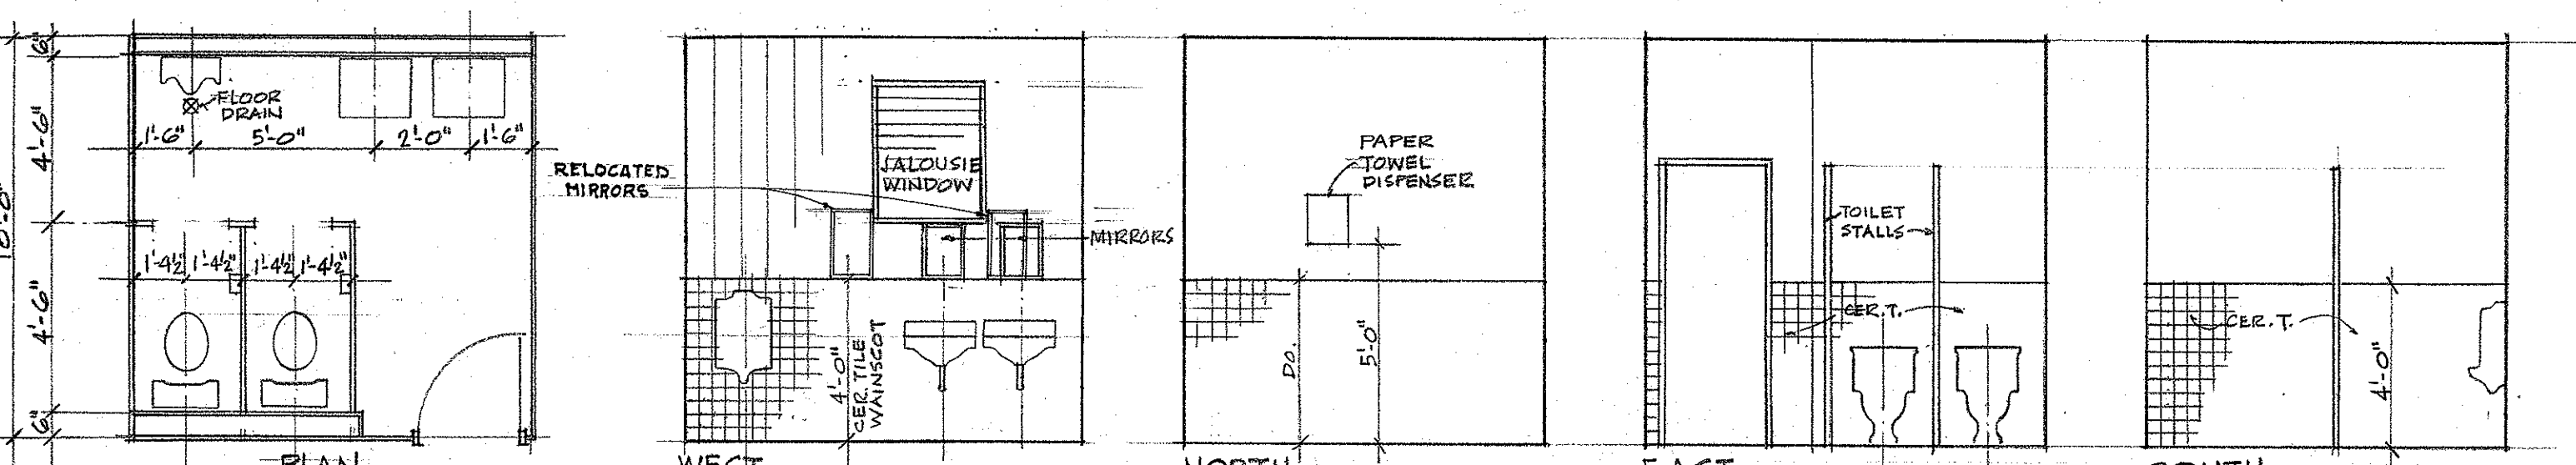

MEN'S TOILET #4 SCALE: 1/4"=1'-0"

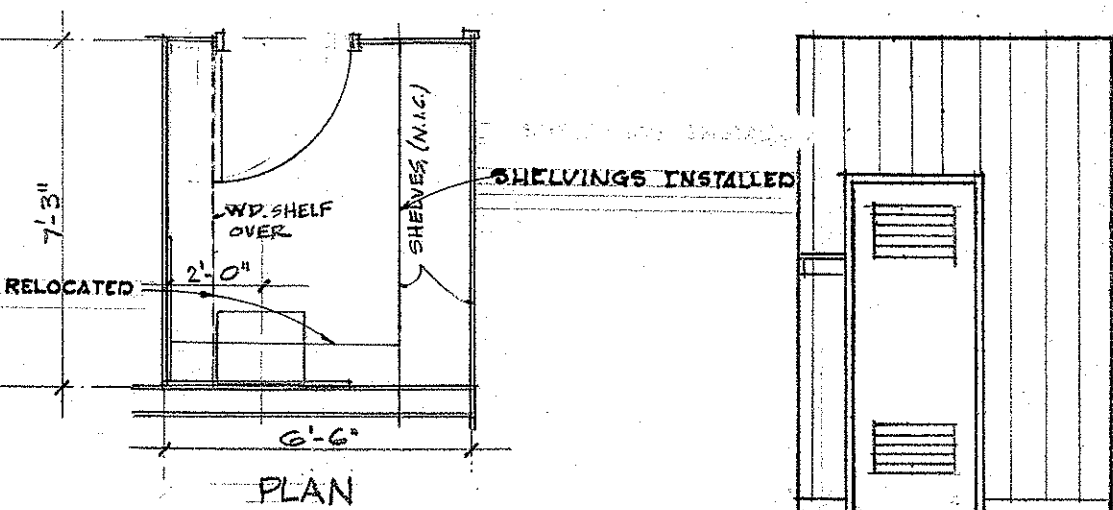


 JAN'S CLOS. & BLDG. SUPPLY STOR. SCALE: 1/4"=1'-0"

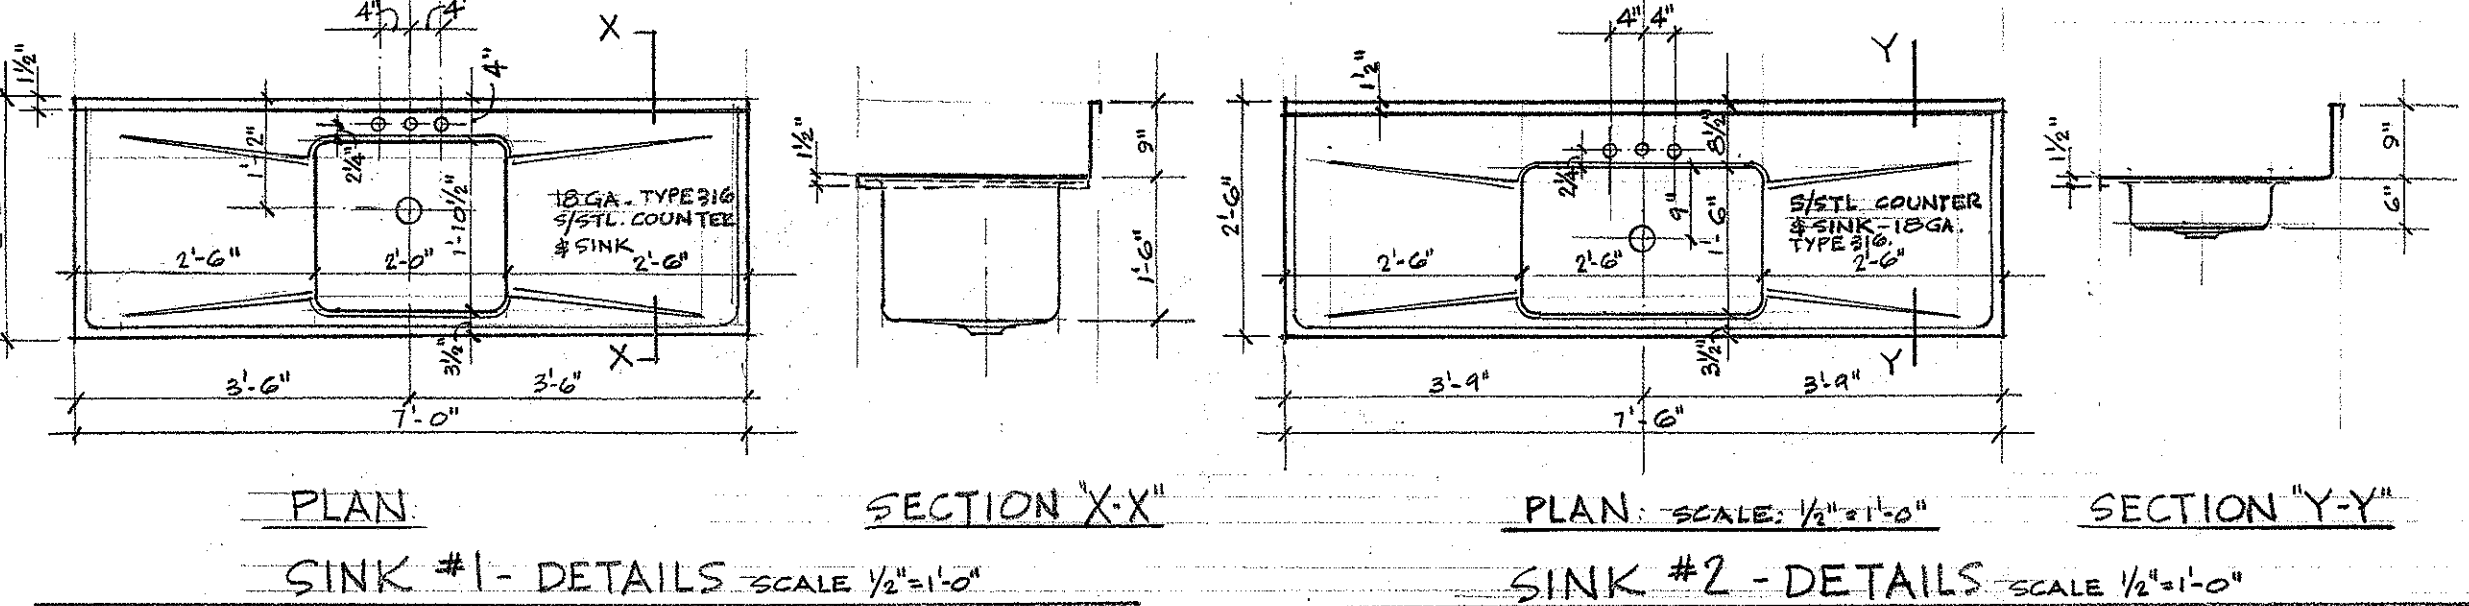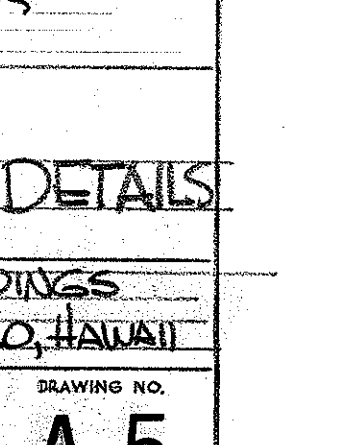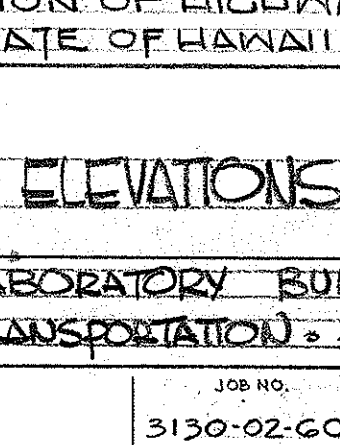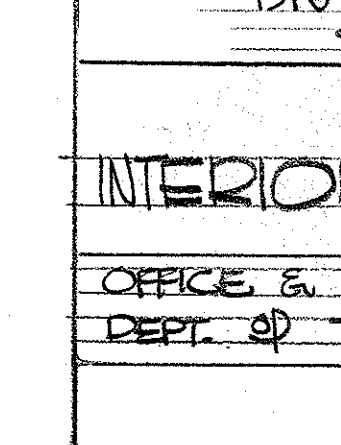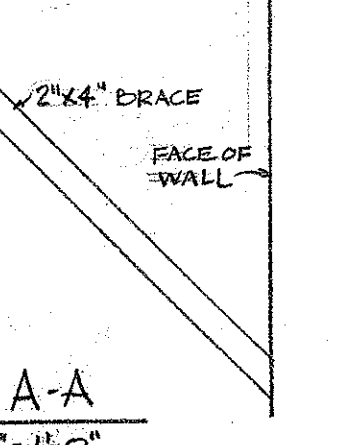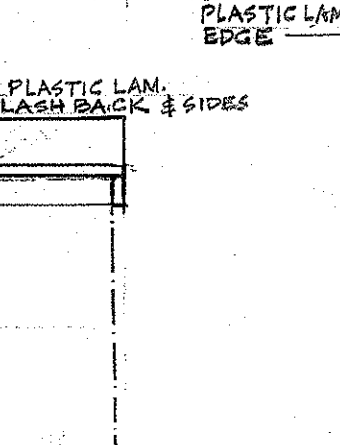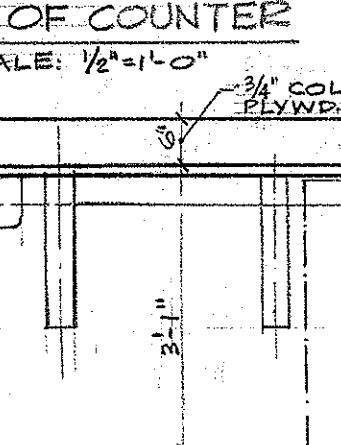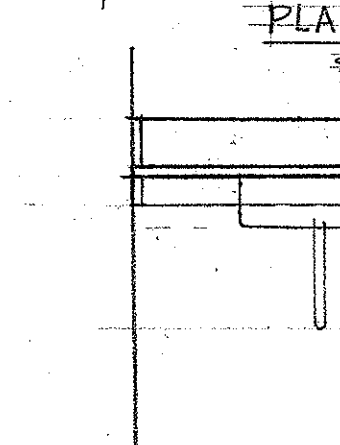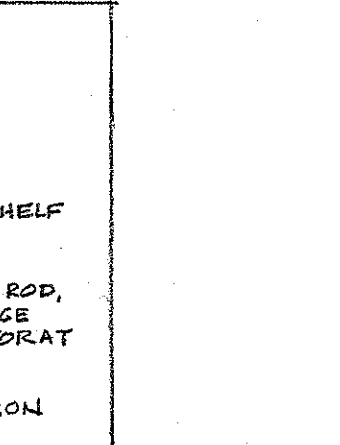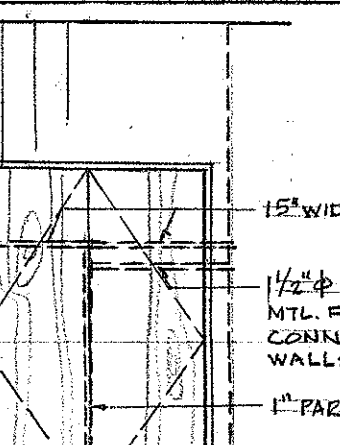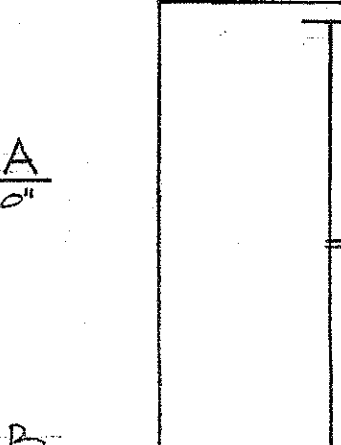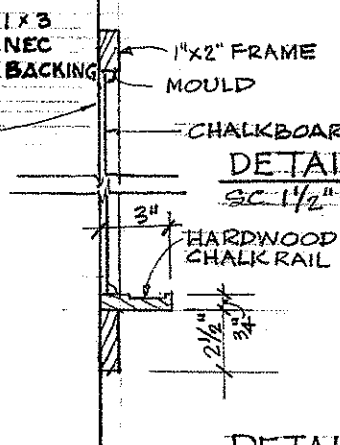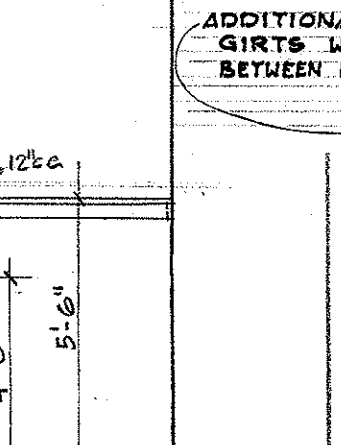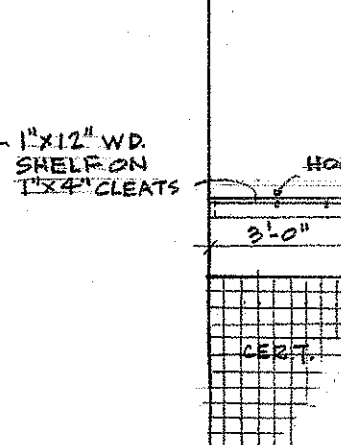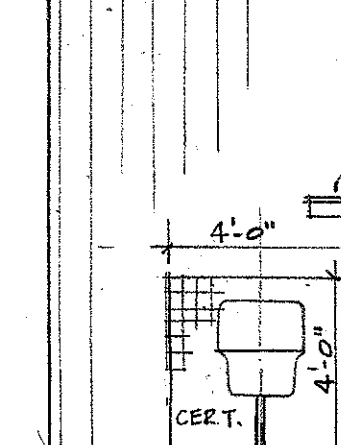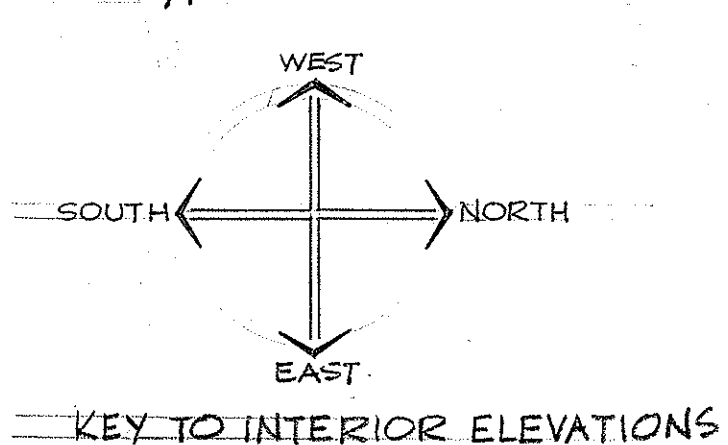

PLAN SINK #1- DETAILS SCALE: 1/2"=1'-0"


PLAN SINK #2- DETAILS SCALE: 1/2"=1'-0"

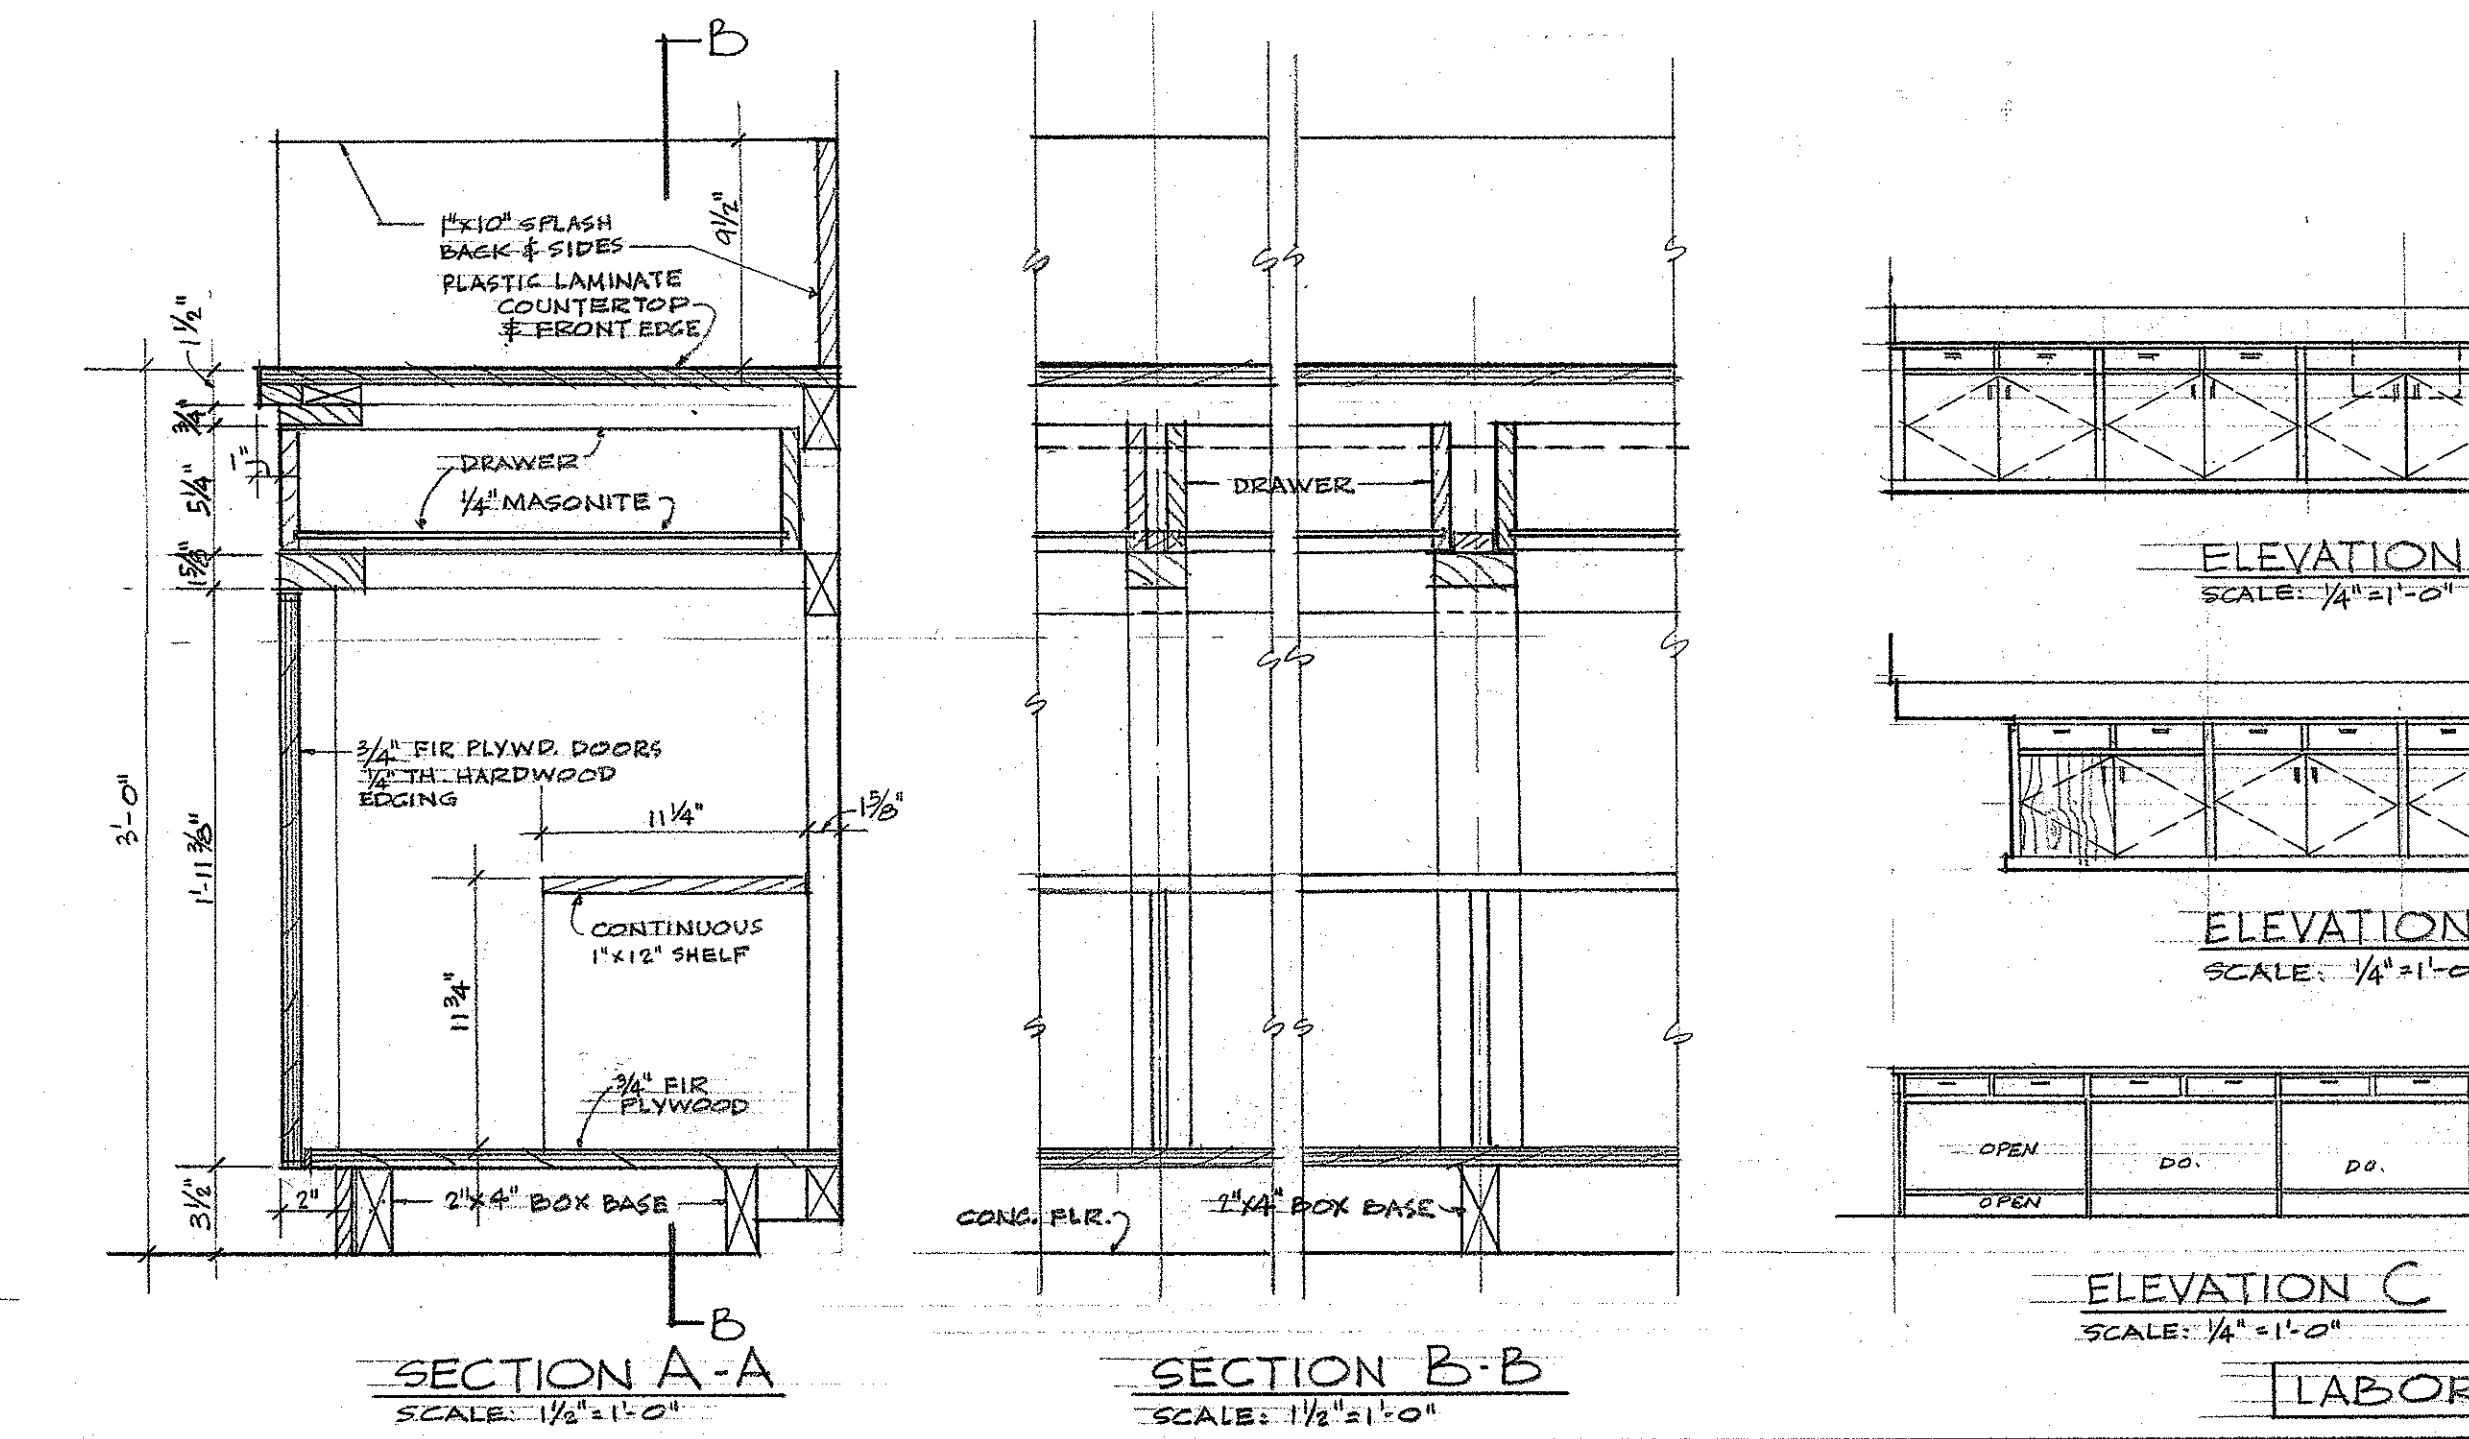

SECTION A-A SCALE: 1/2"=1'-0"

SECTION B-B SCALE: 1/2"=1'-0"

SECTION C-C SCALE: 1/2"=1'-0"

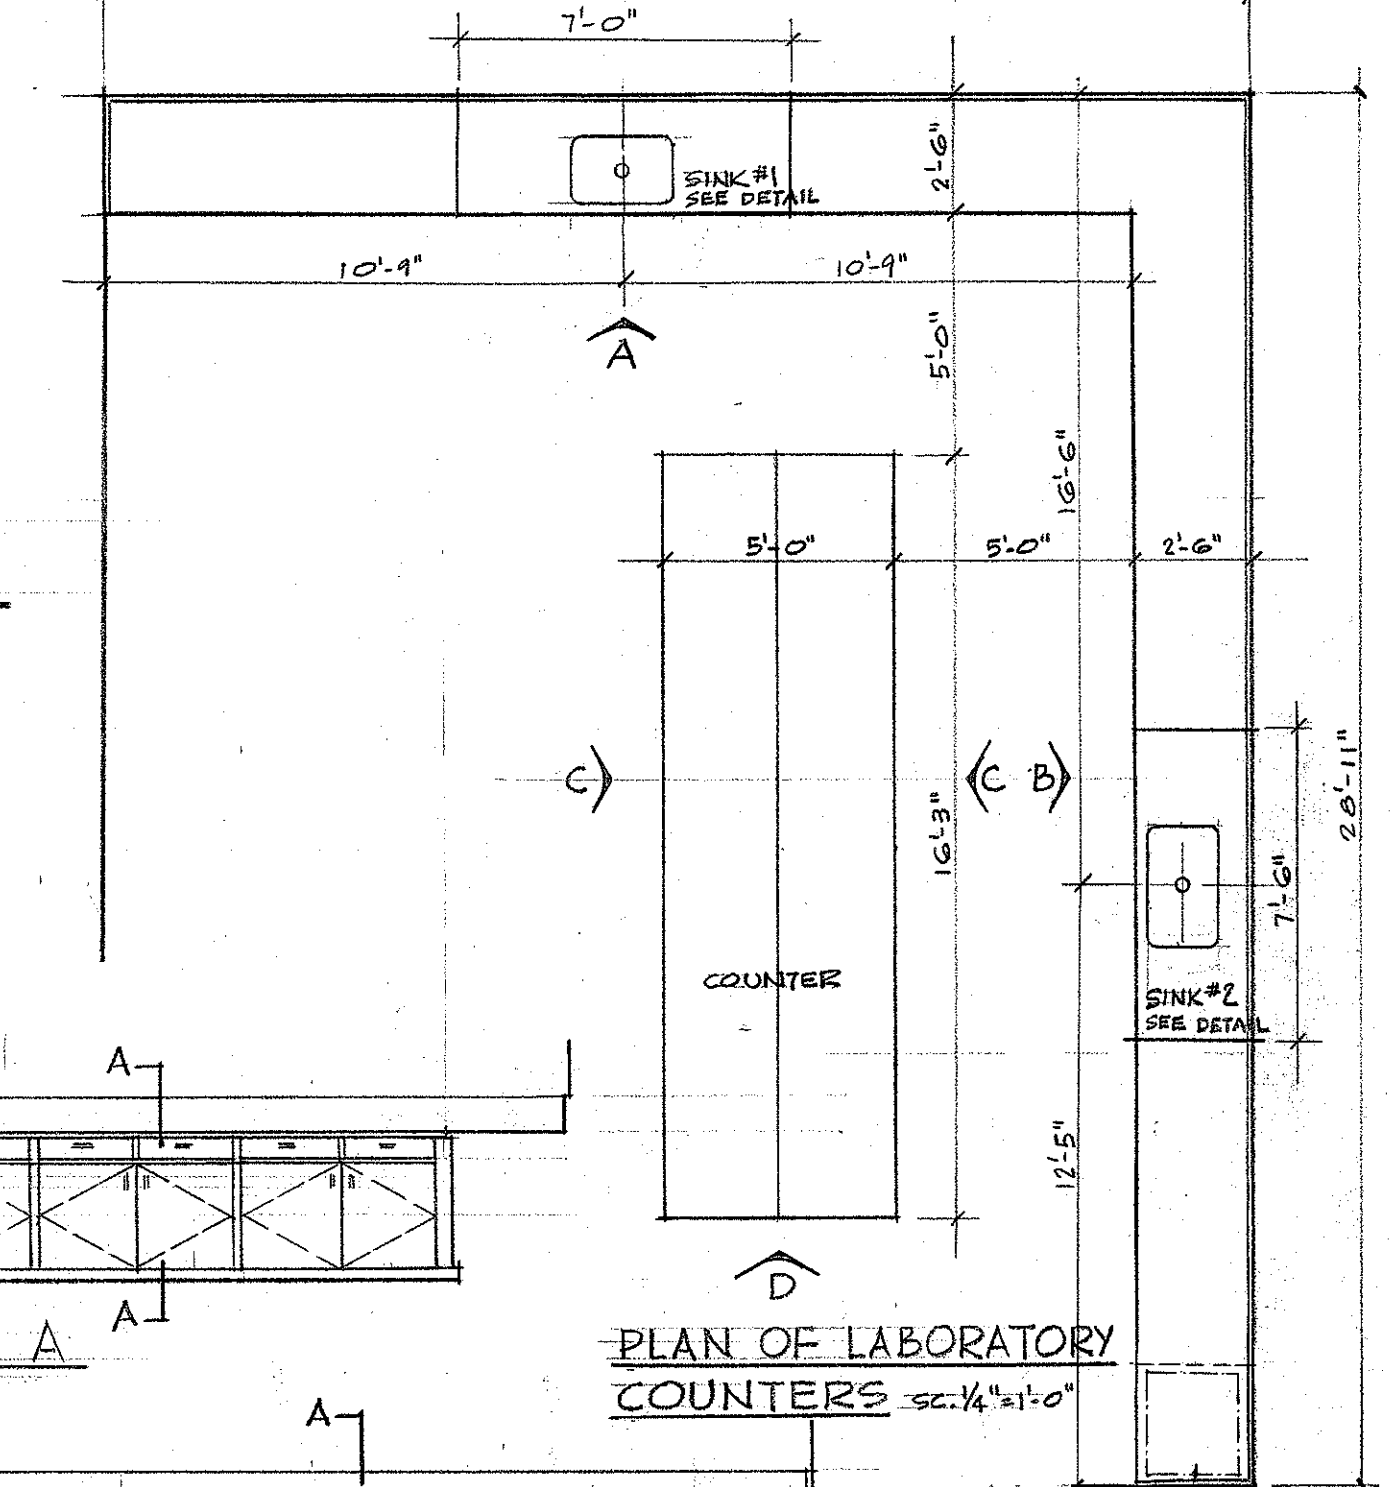

PLAN OF LABORATORY COUNTERS SCALE: 1/4"=1'-0"


ELEVATION A SCALE: 1/4"=1'-0"

ELEVATION B SCALE: 1/4"=1'-0"

ELEVATION C SCALE: 1/4"=1'-0"

ELEVATION D SCALE: 1/4"=1'-0"

LABORATORY COUNTERS & SINKS

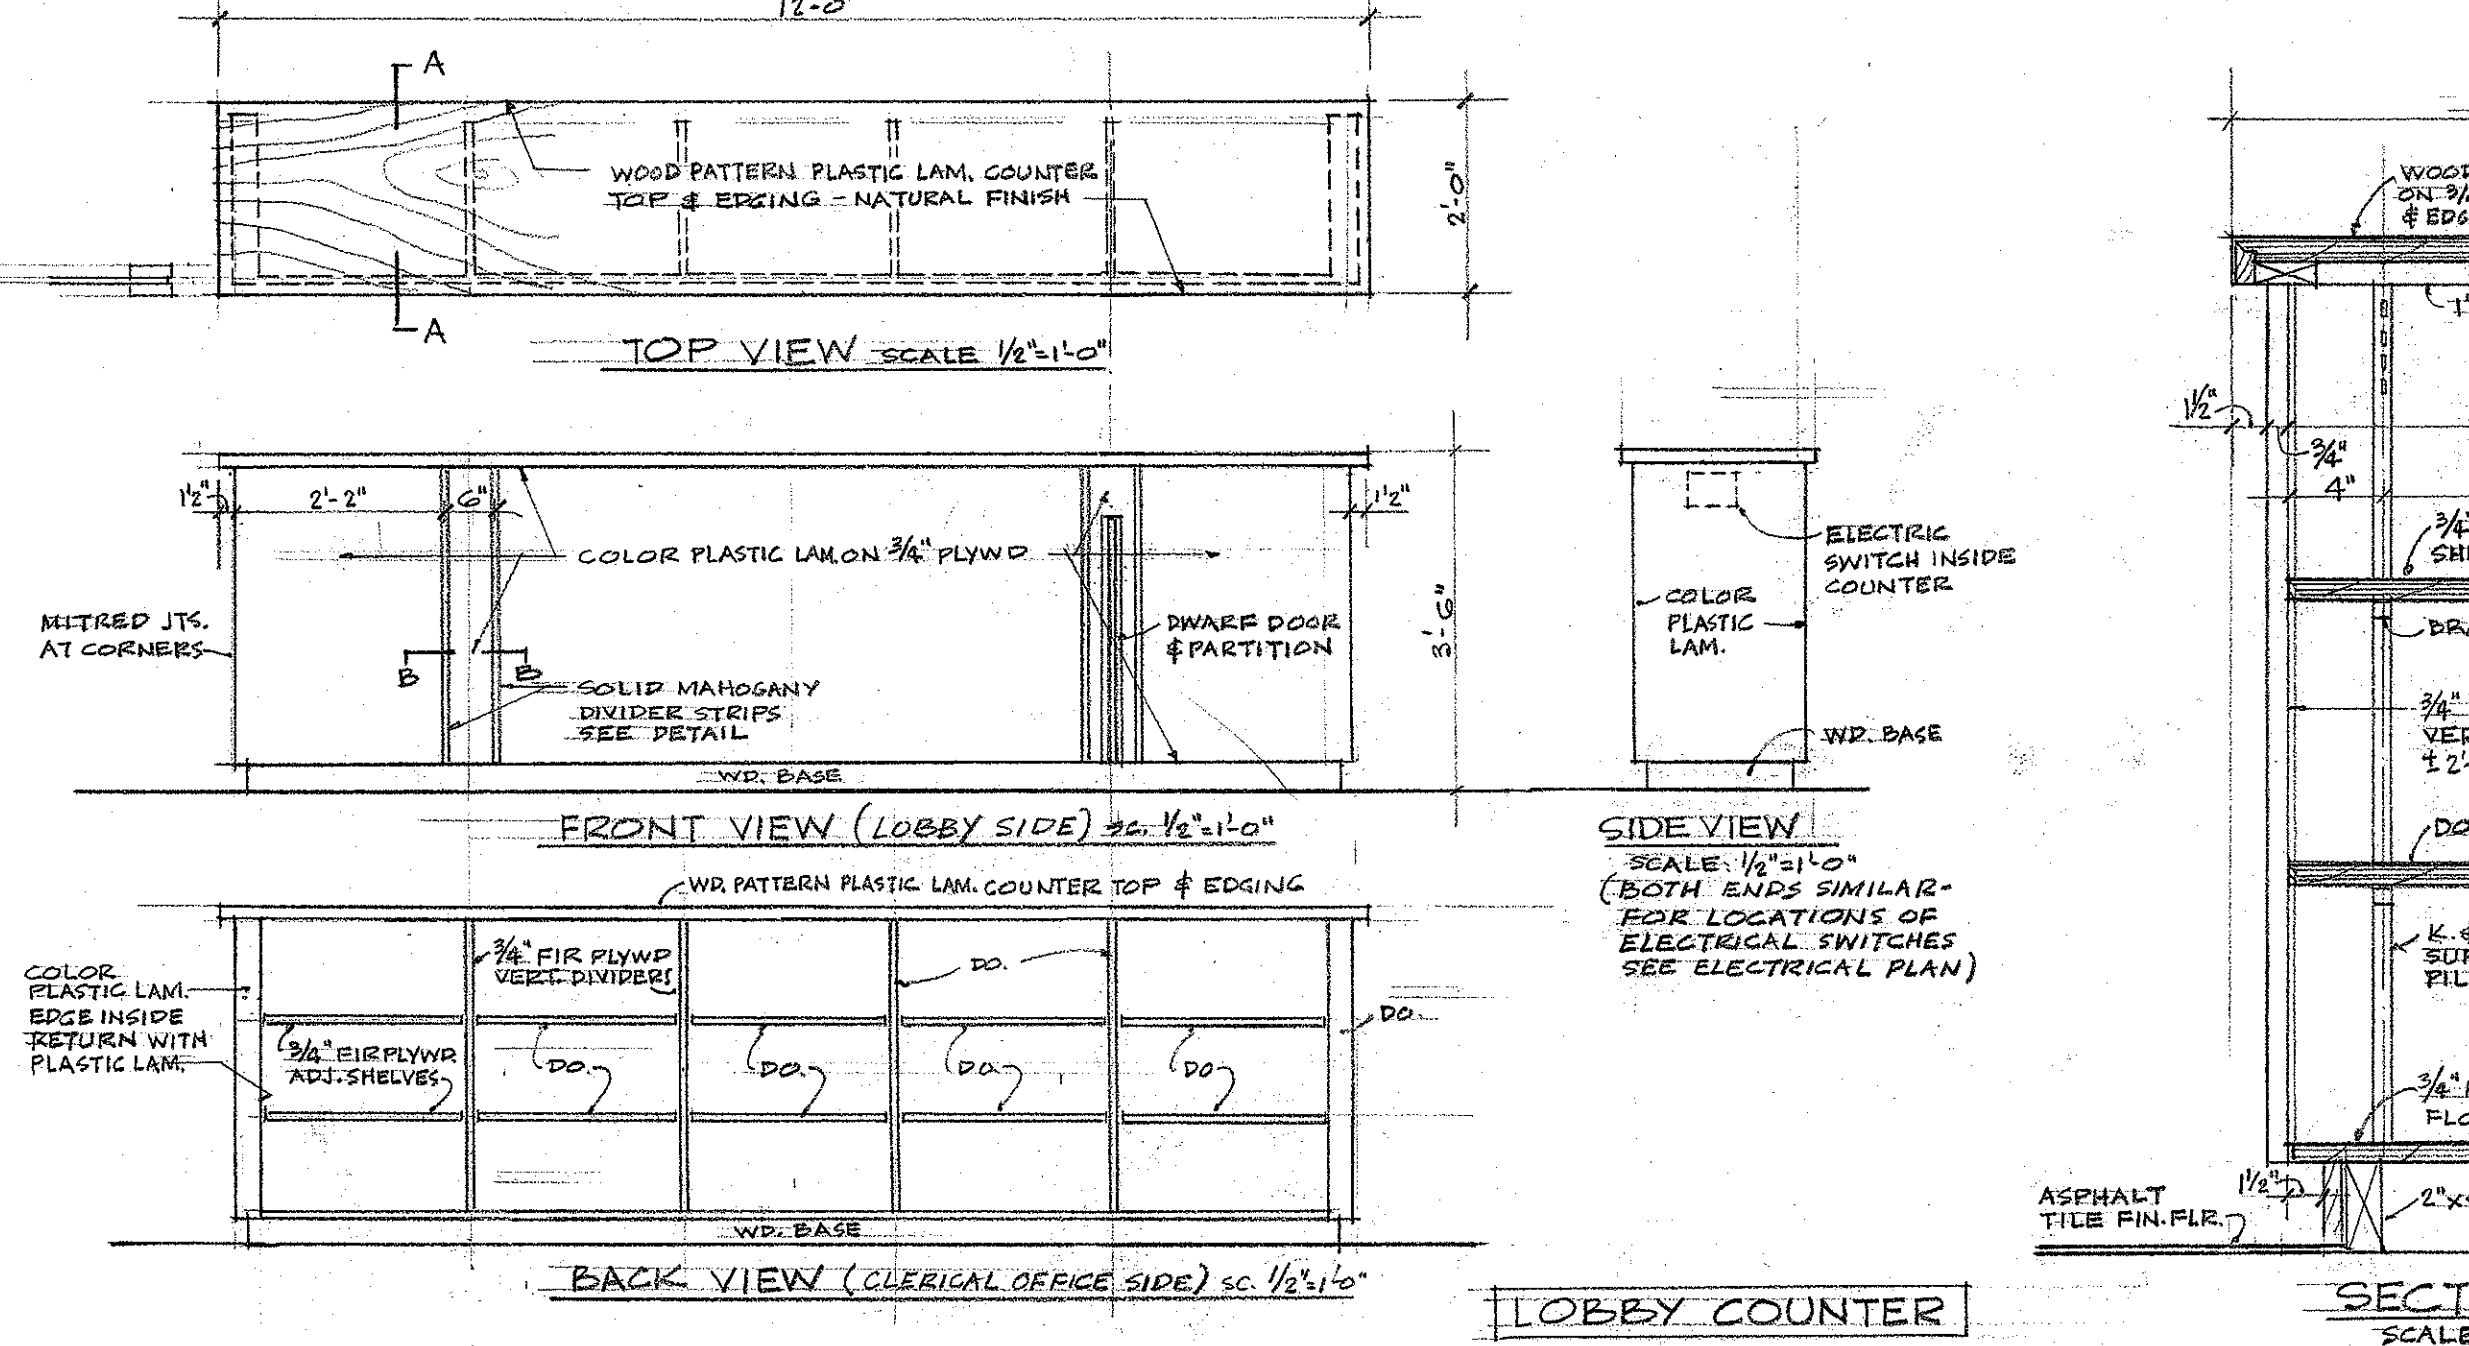


TOP VIEW SCALE: 1/2"=1'-0"

FRONT VIEW (LOBBY SIDE) SCALE: 1/2"=1'-0"

BACK VIEW (CLERICAL OFFICE SIDE) SCALE: 1/2"=1'-0"

SIDE VIEW SCALE: 1/2"=1'-0"

LOBBY COUNTER






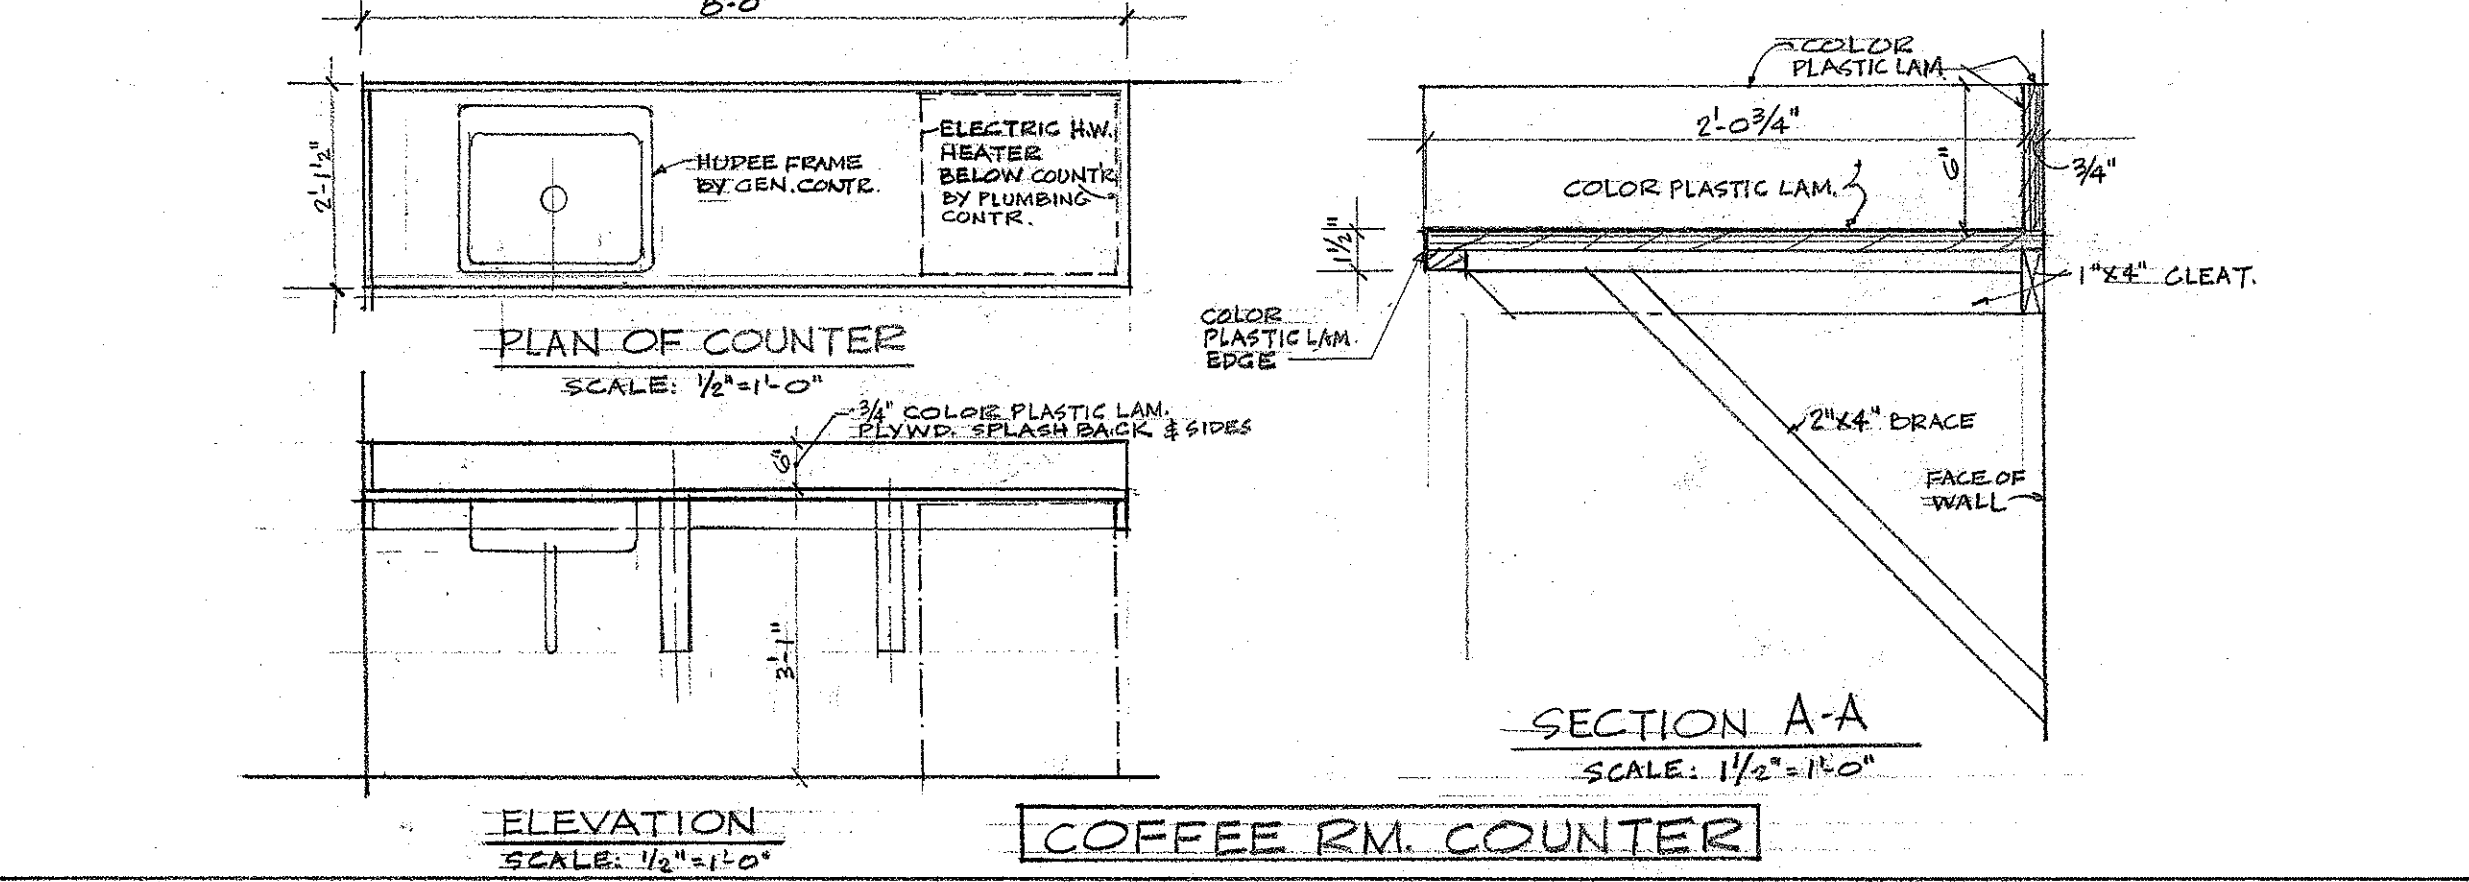


PLAN OF COUNTER SCALE: 1/2"=1'-0"

SECTION A-A SCALE: 1/2"=1'-0"

ELEVATION SCALE: 1/2"=1'-0"

COFFEE RM. COUNTER

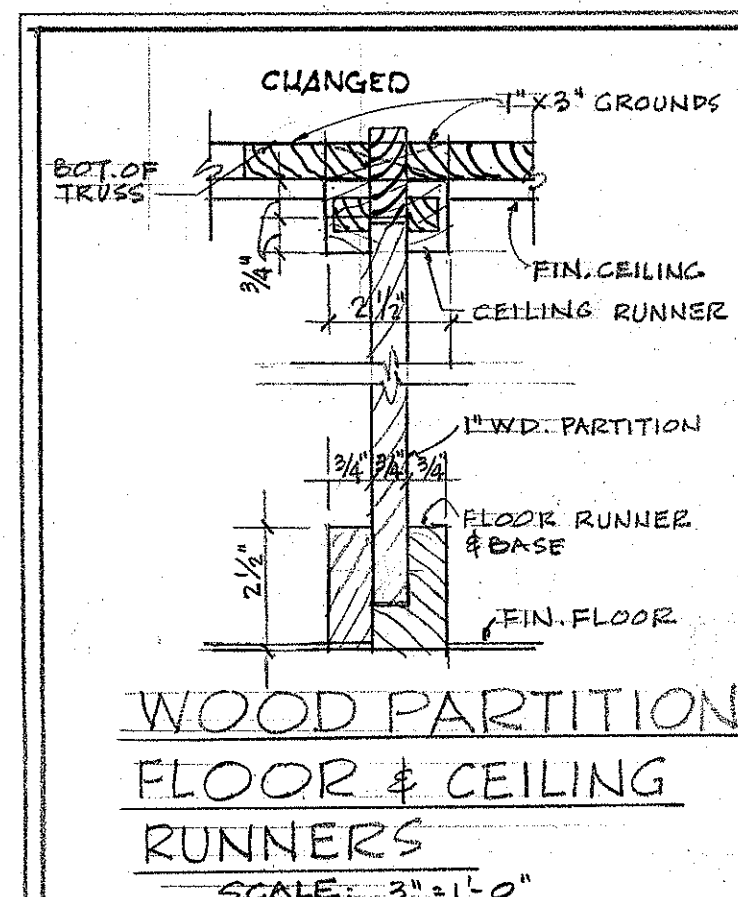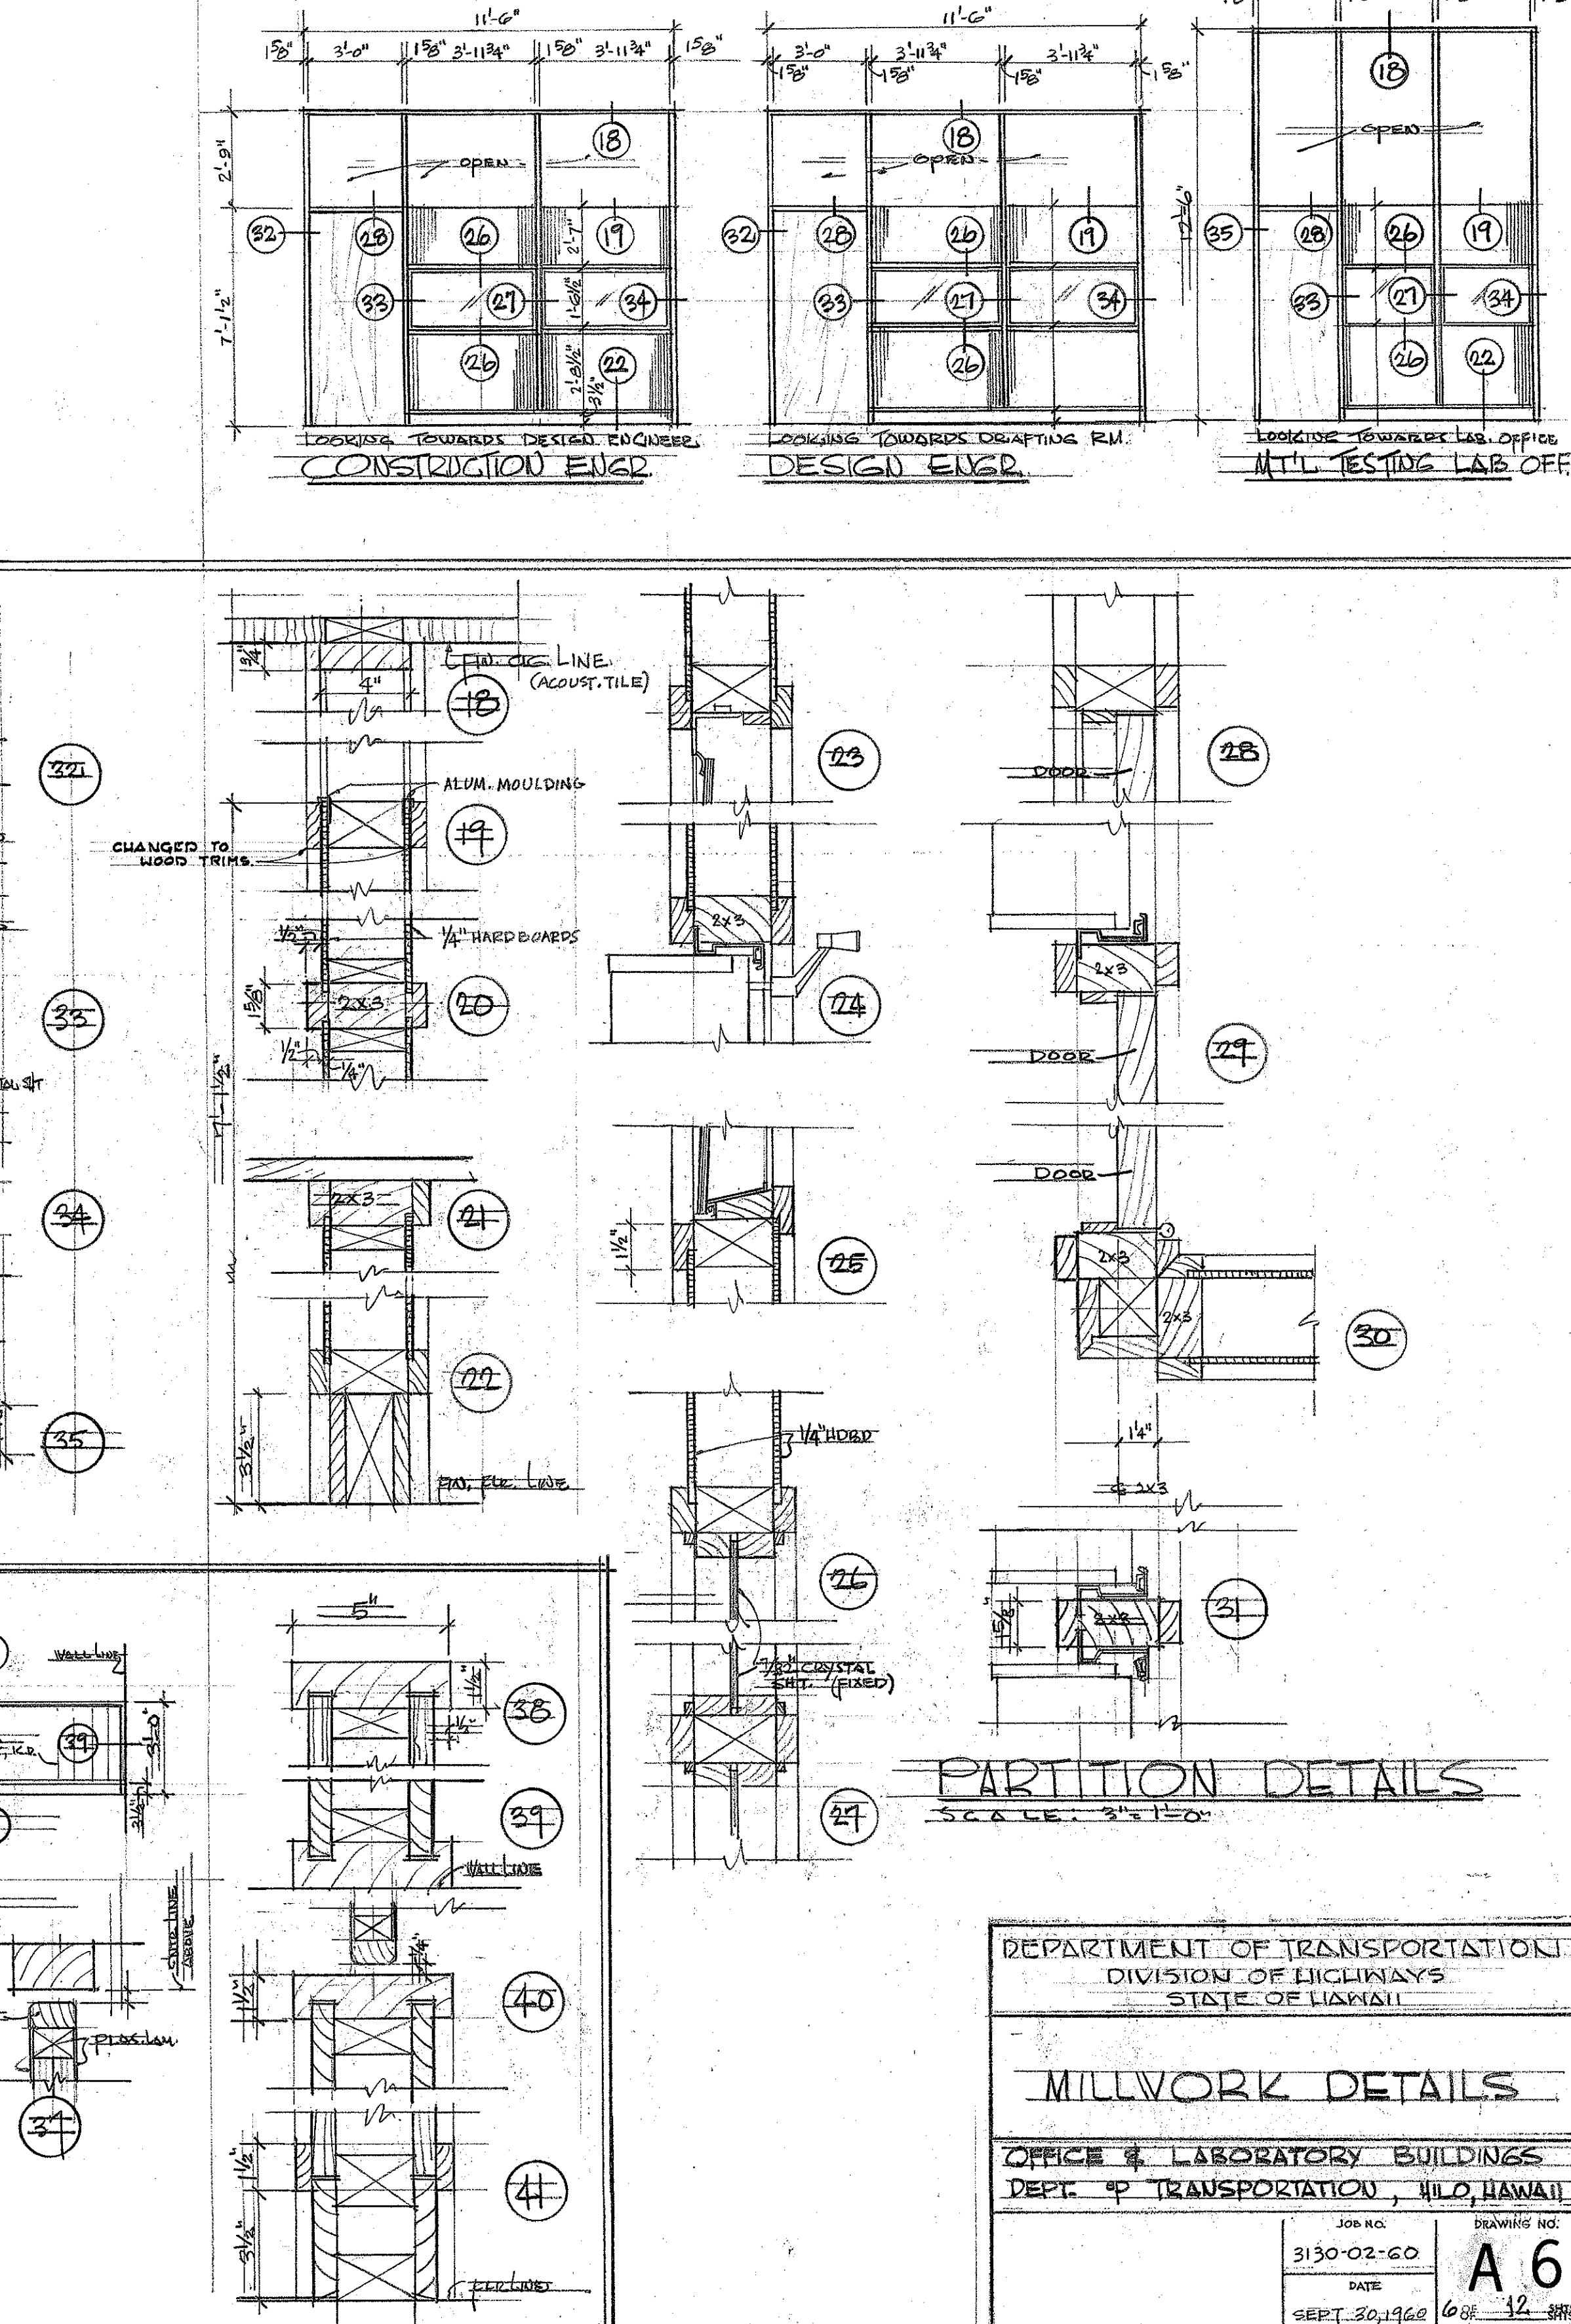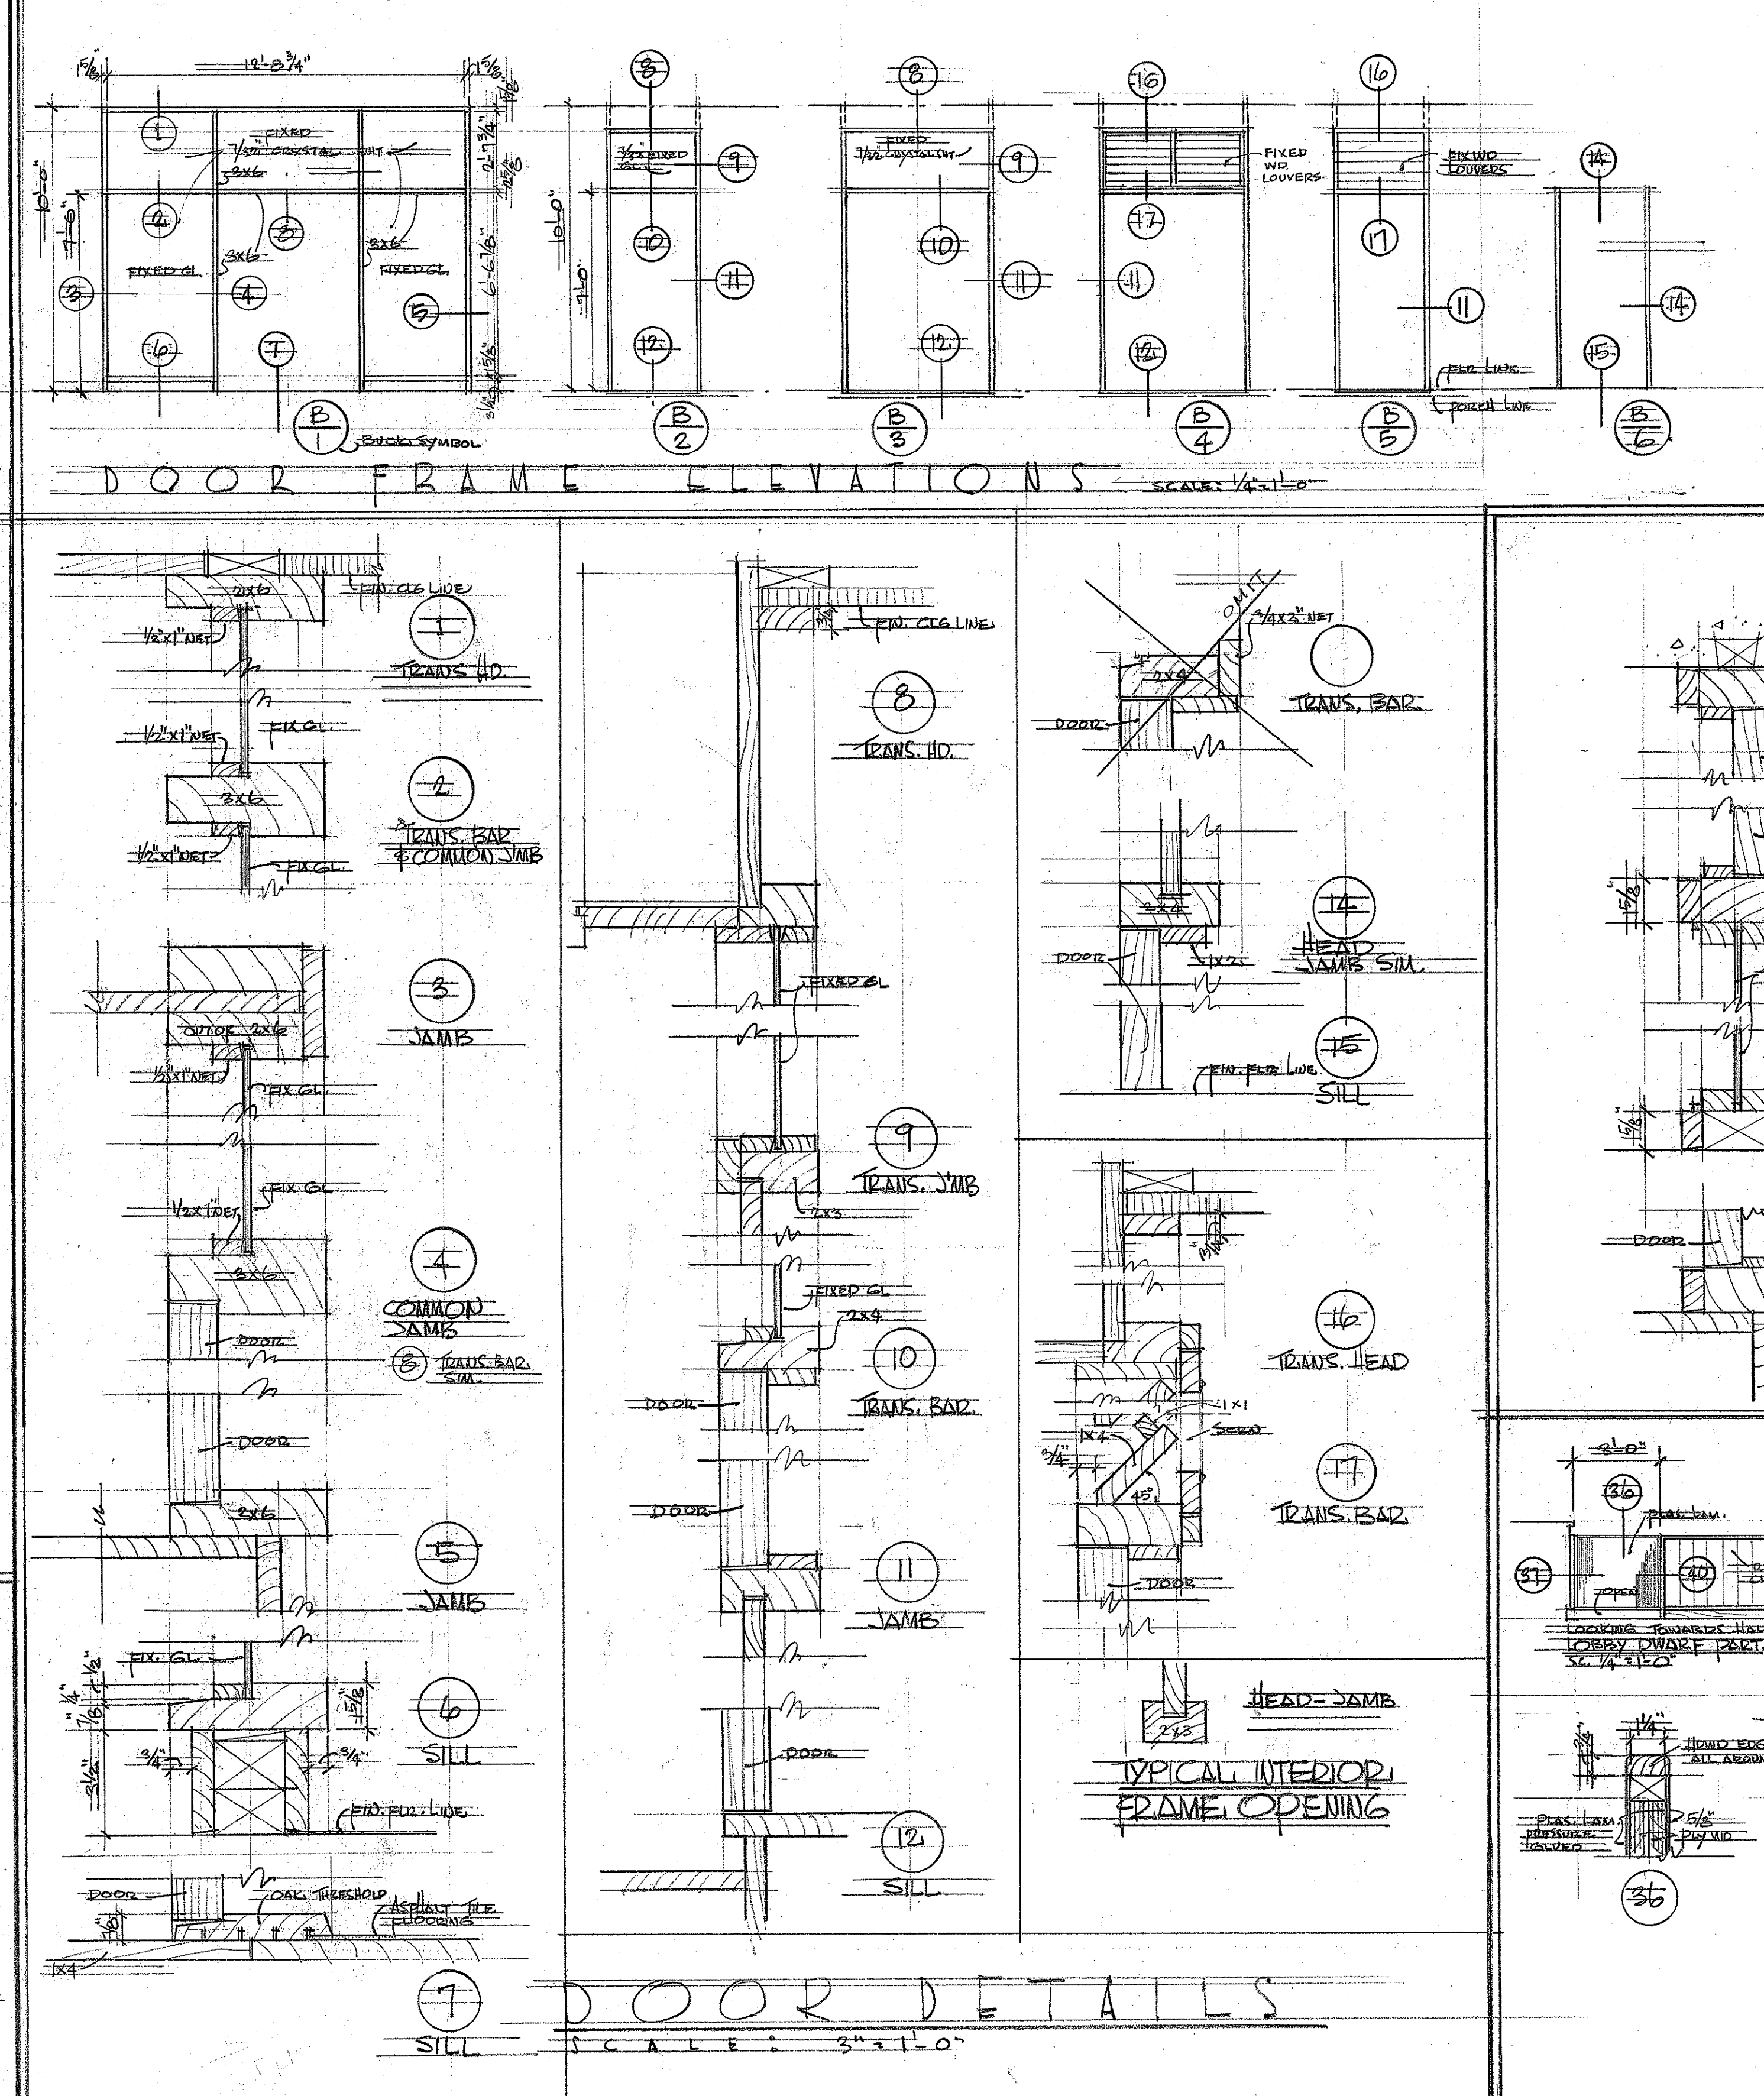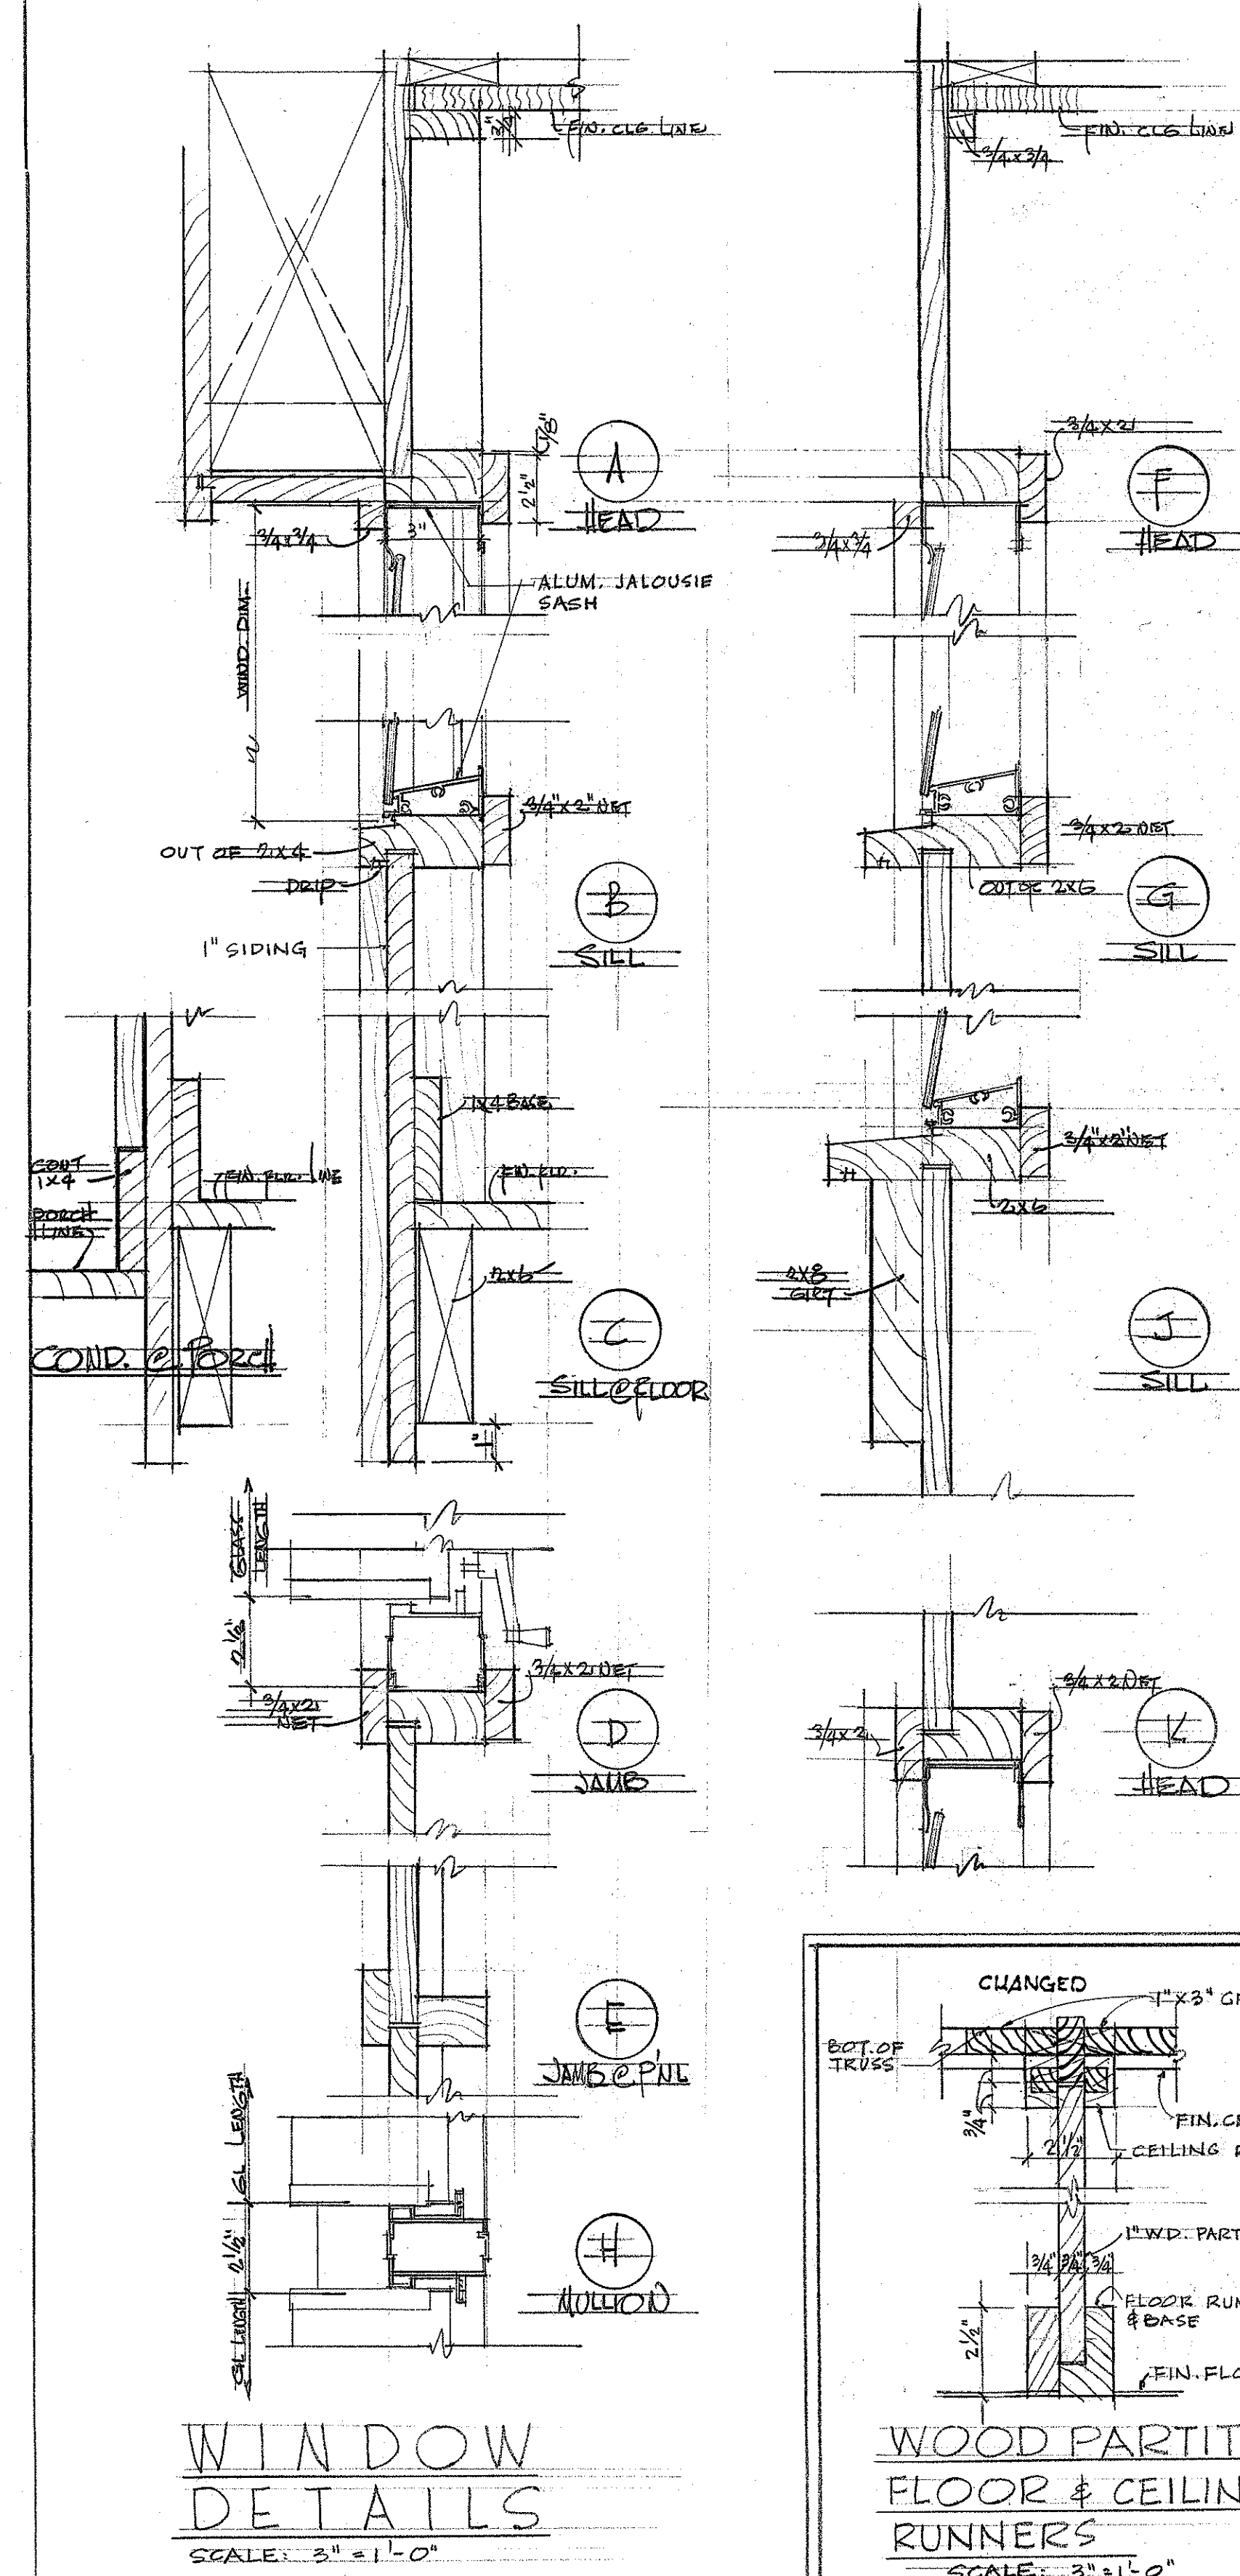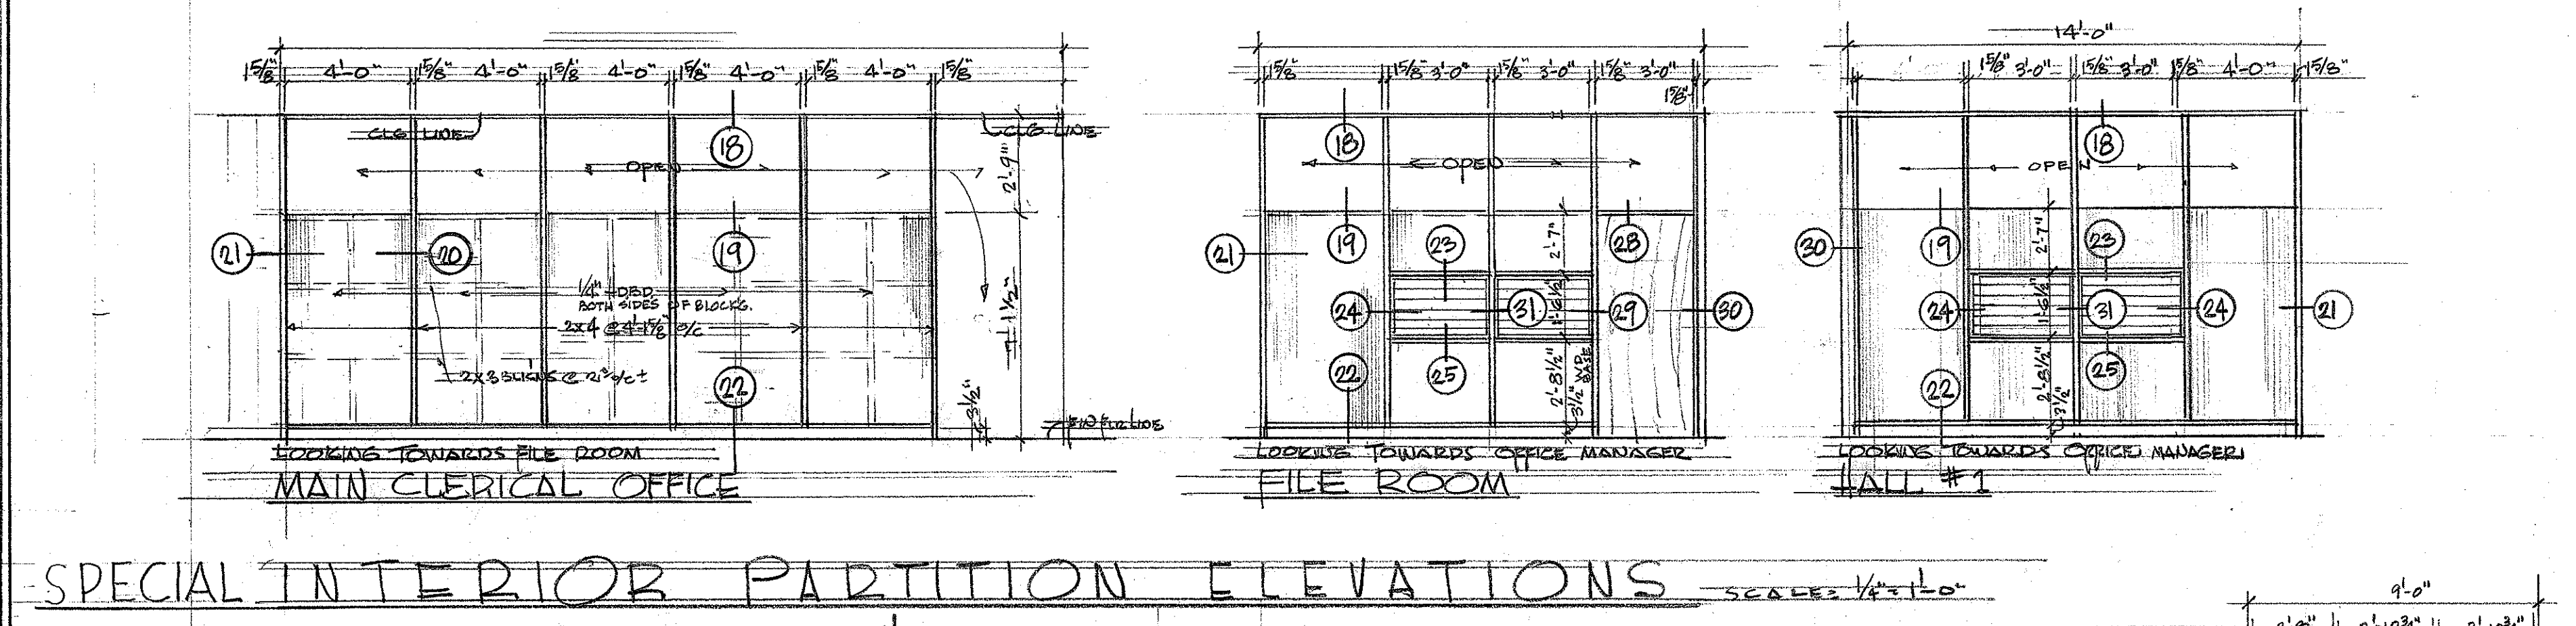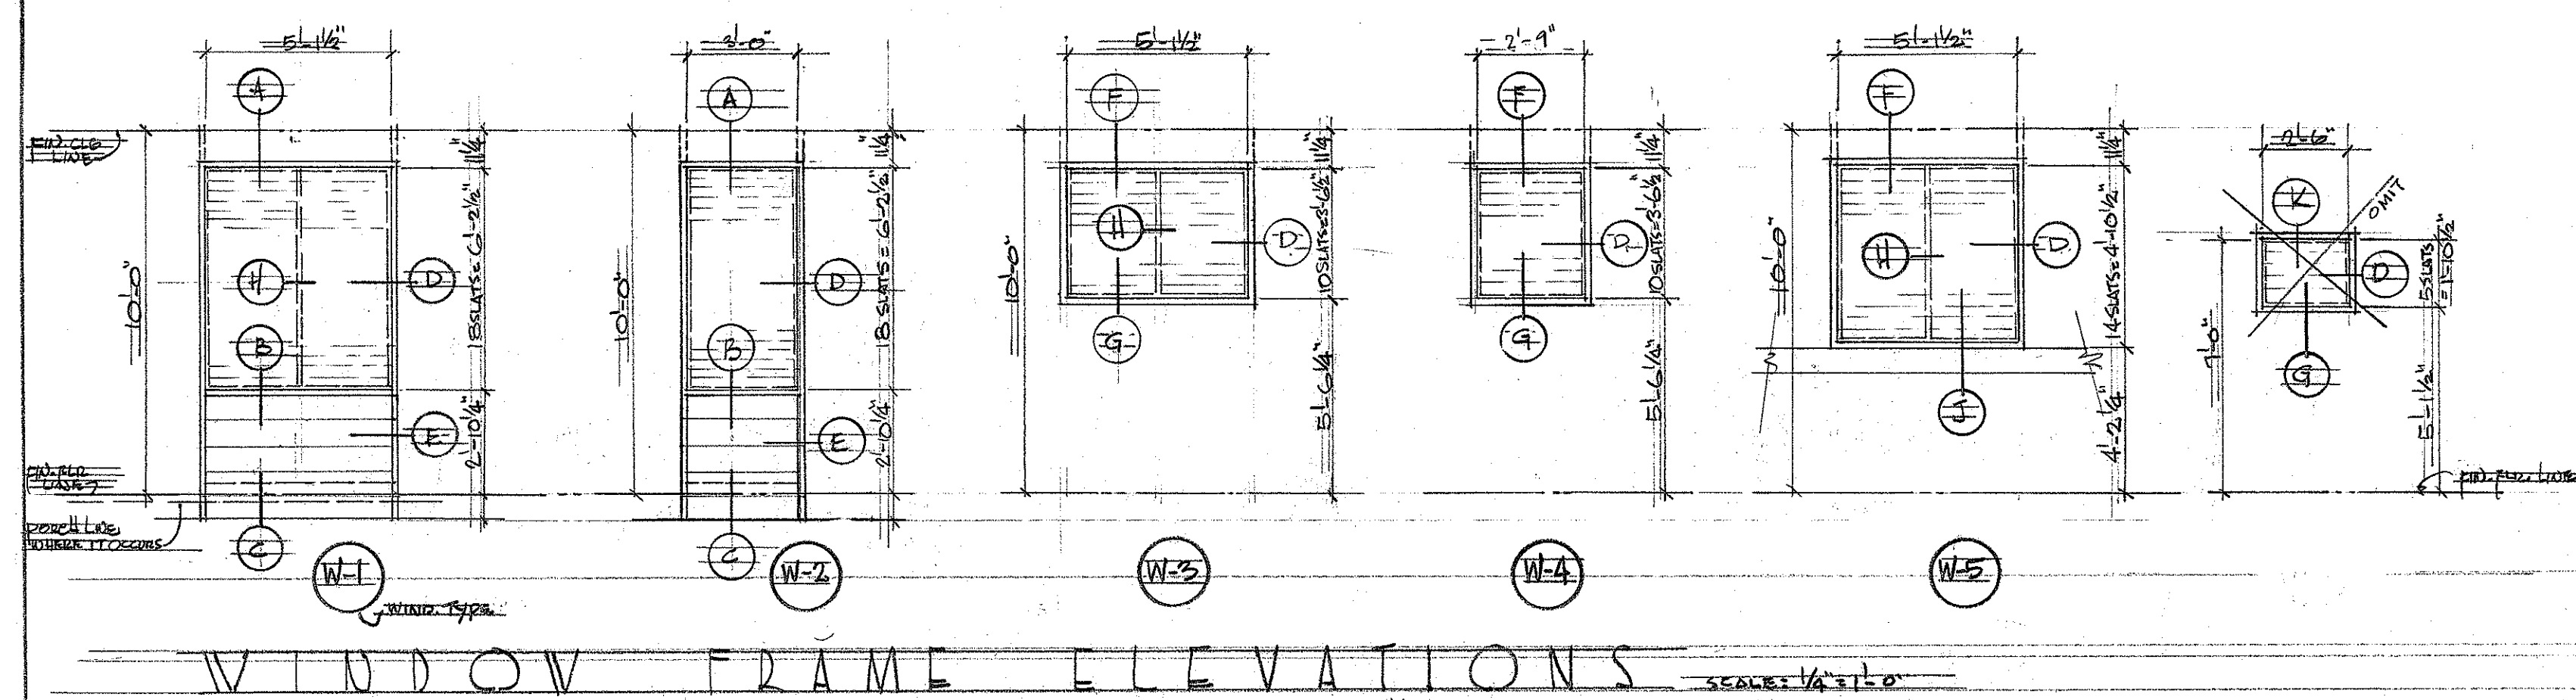

DOOR DETAILS
SCALE: 3/4"=1'-0"

