

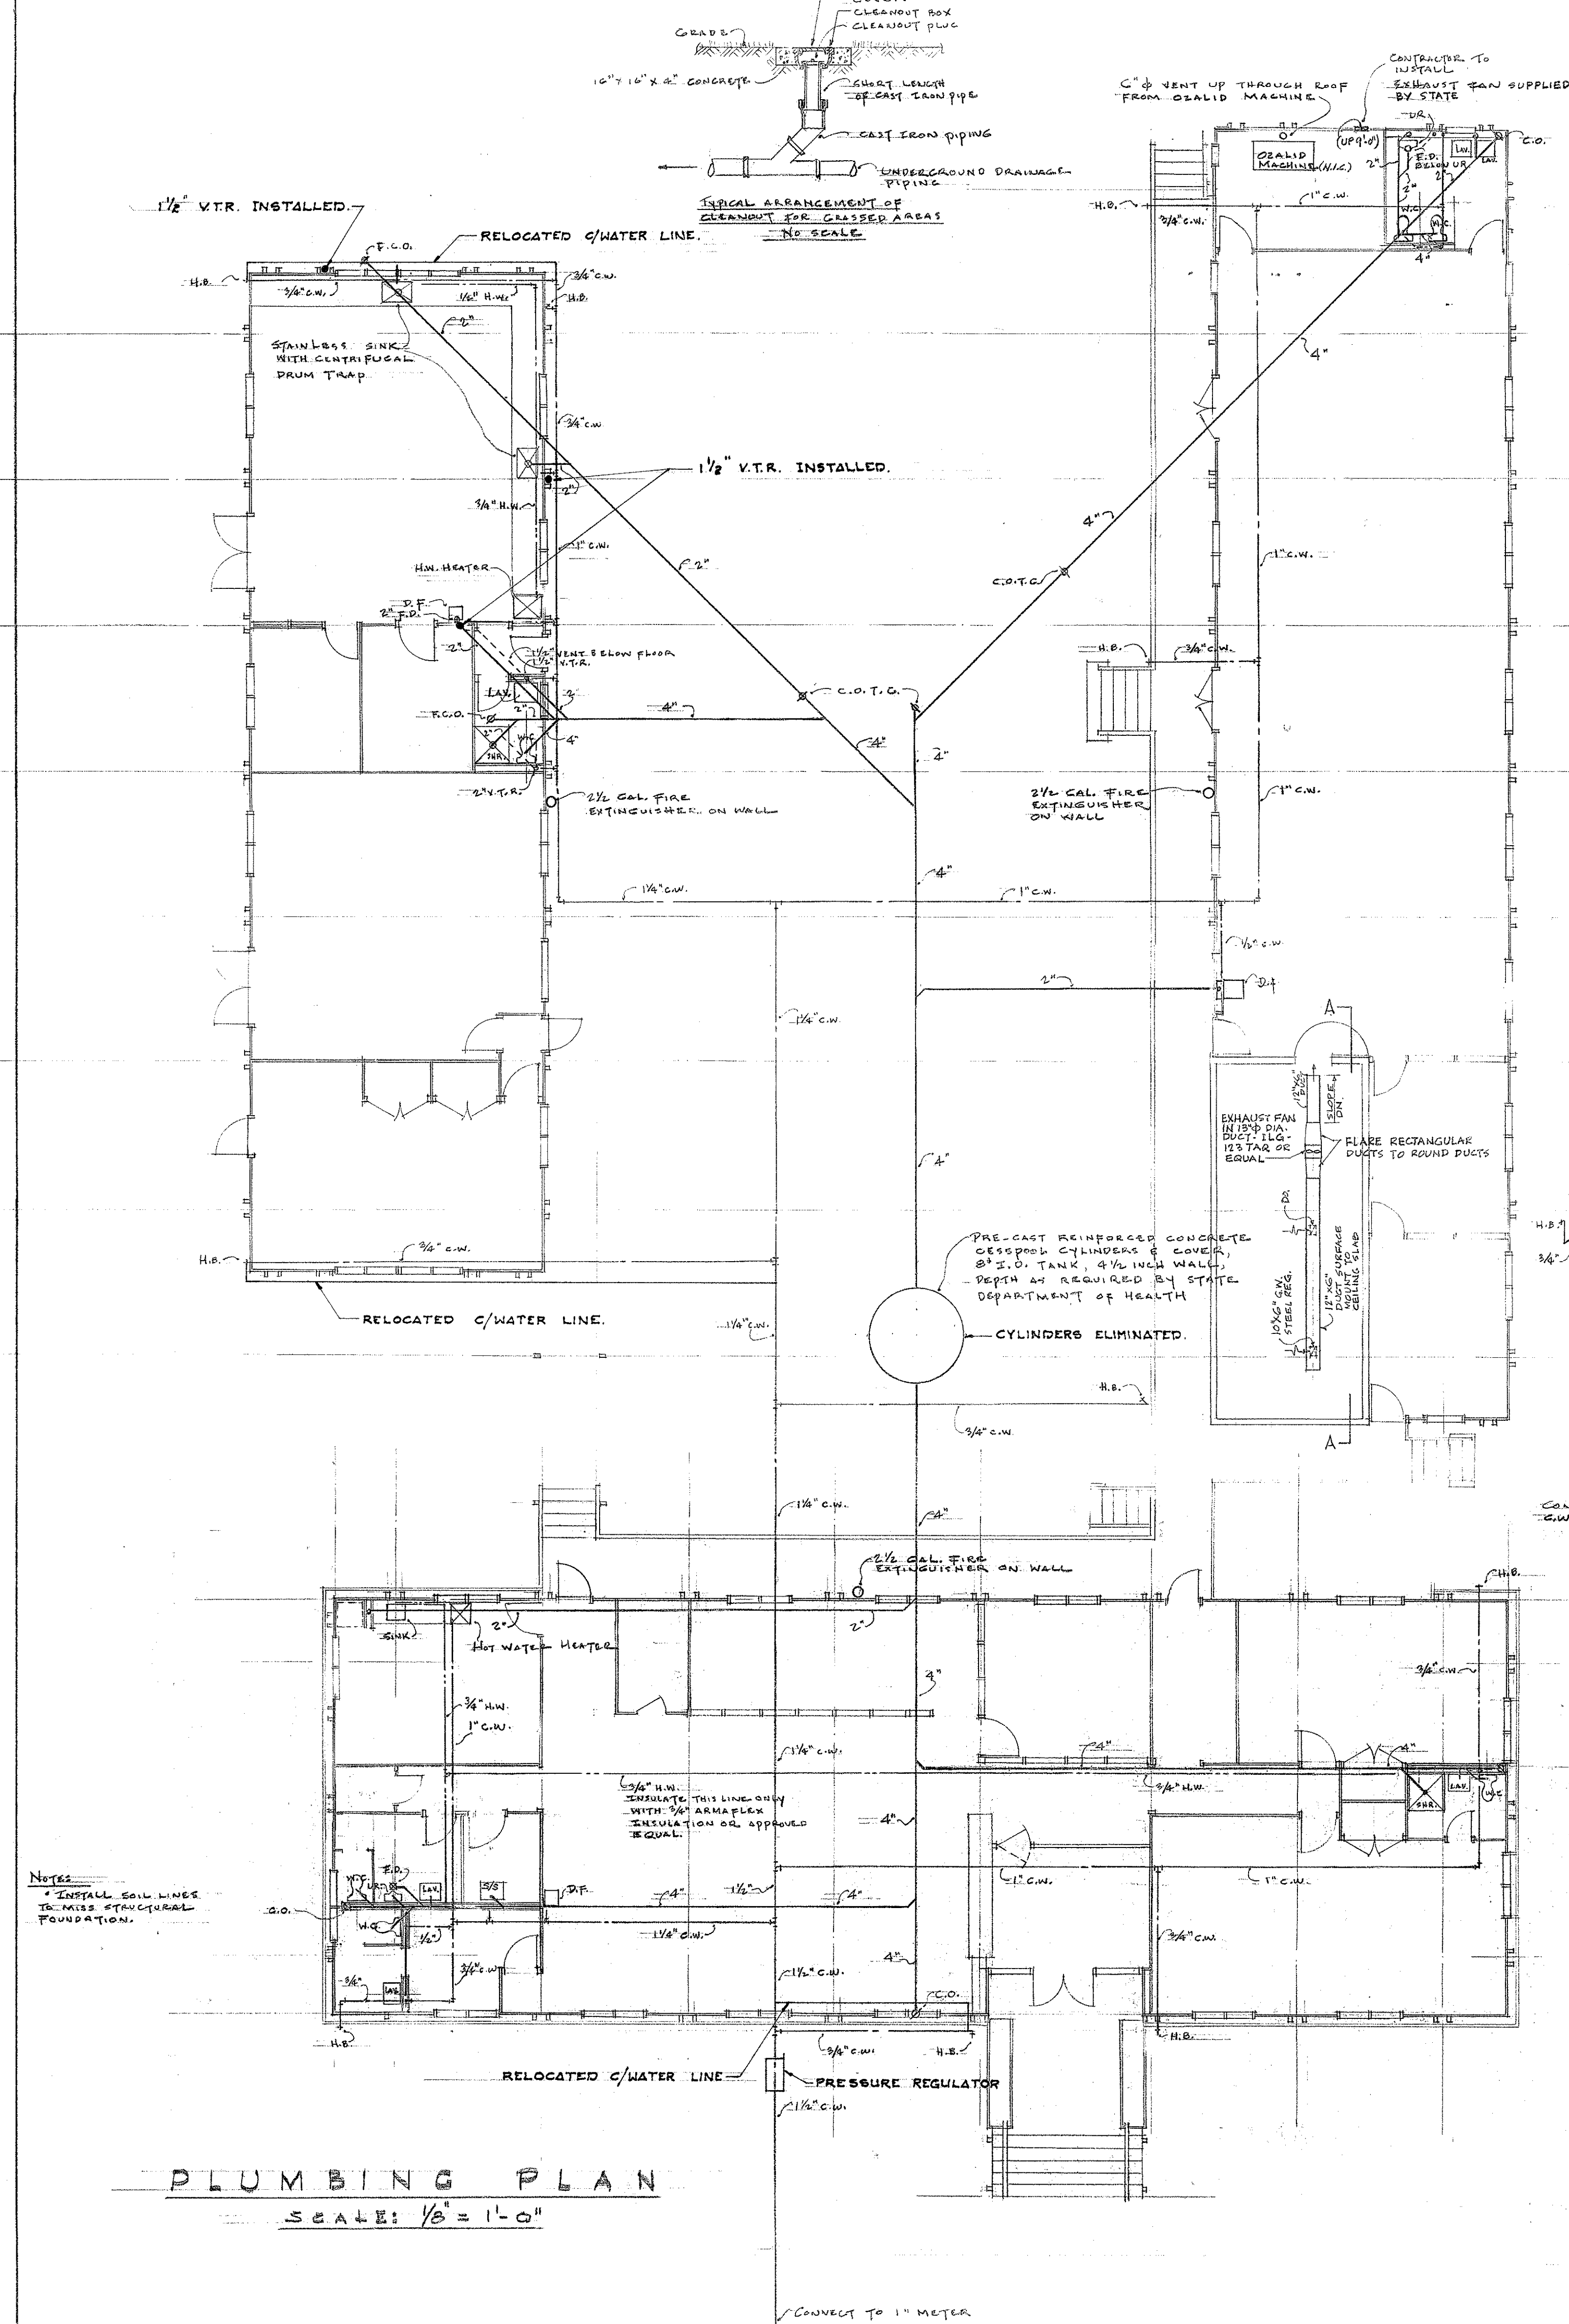
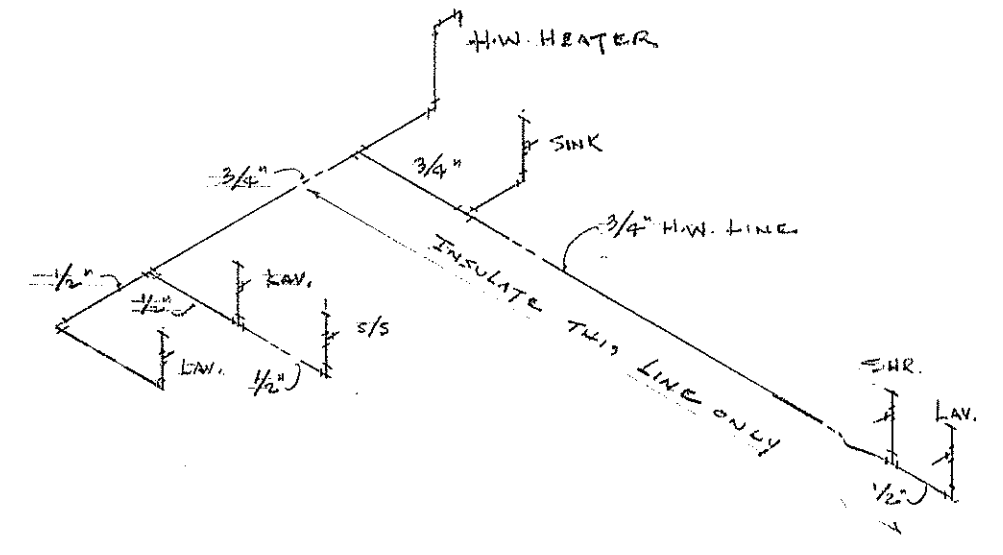
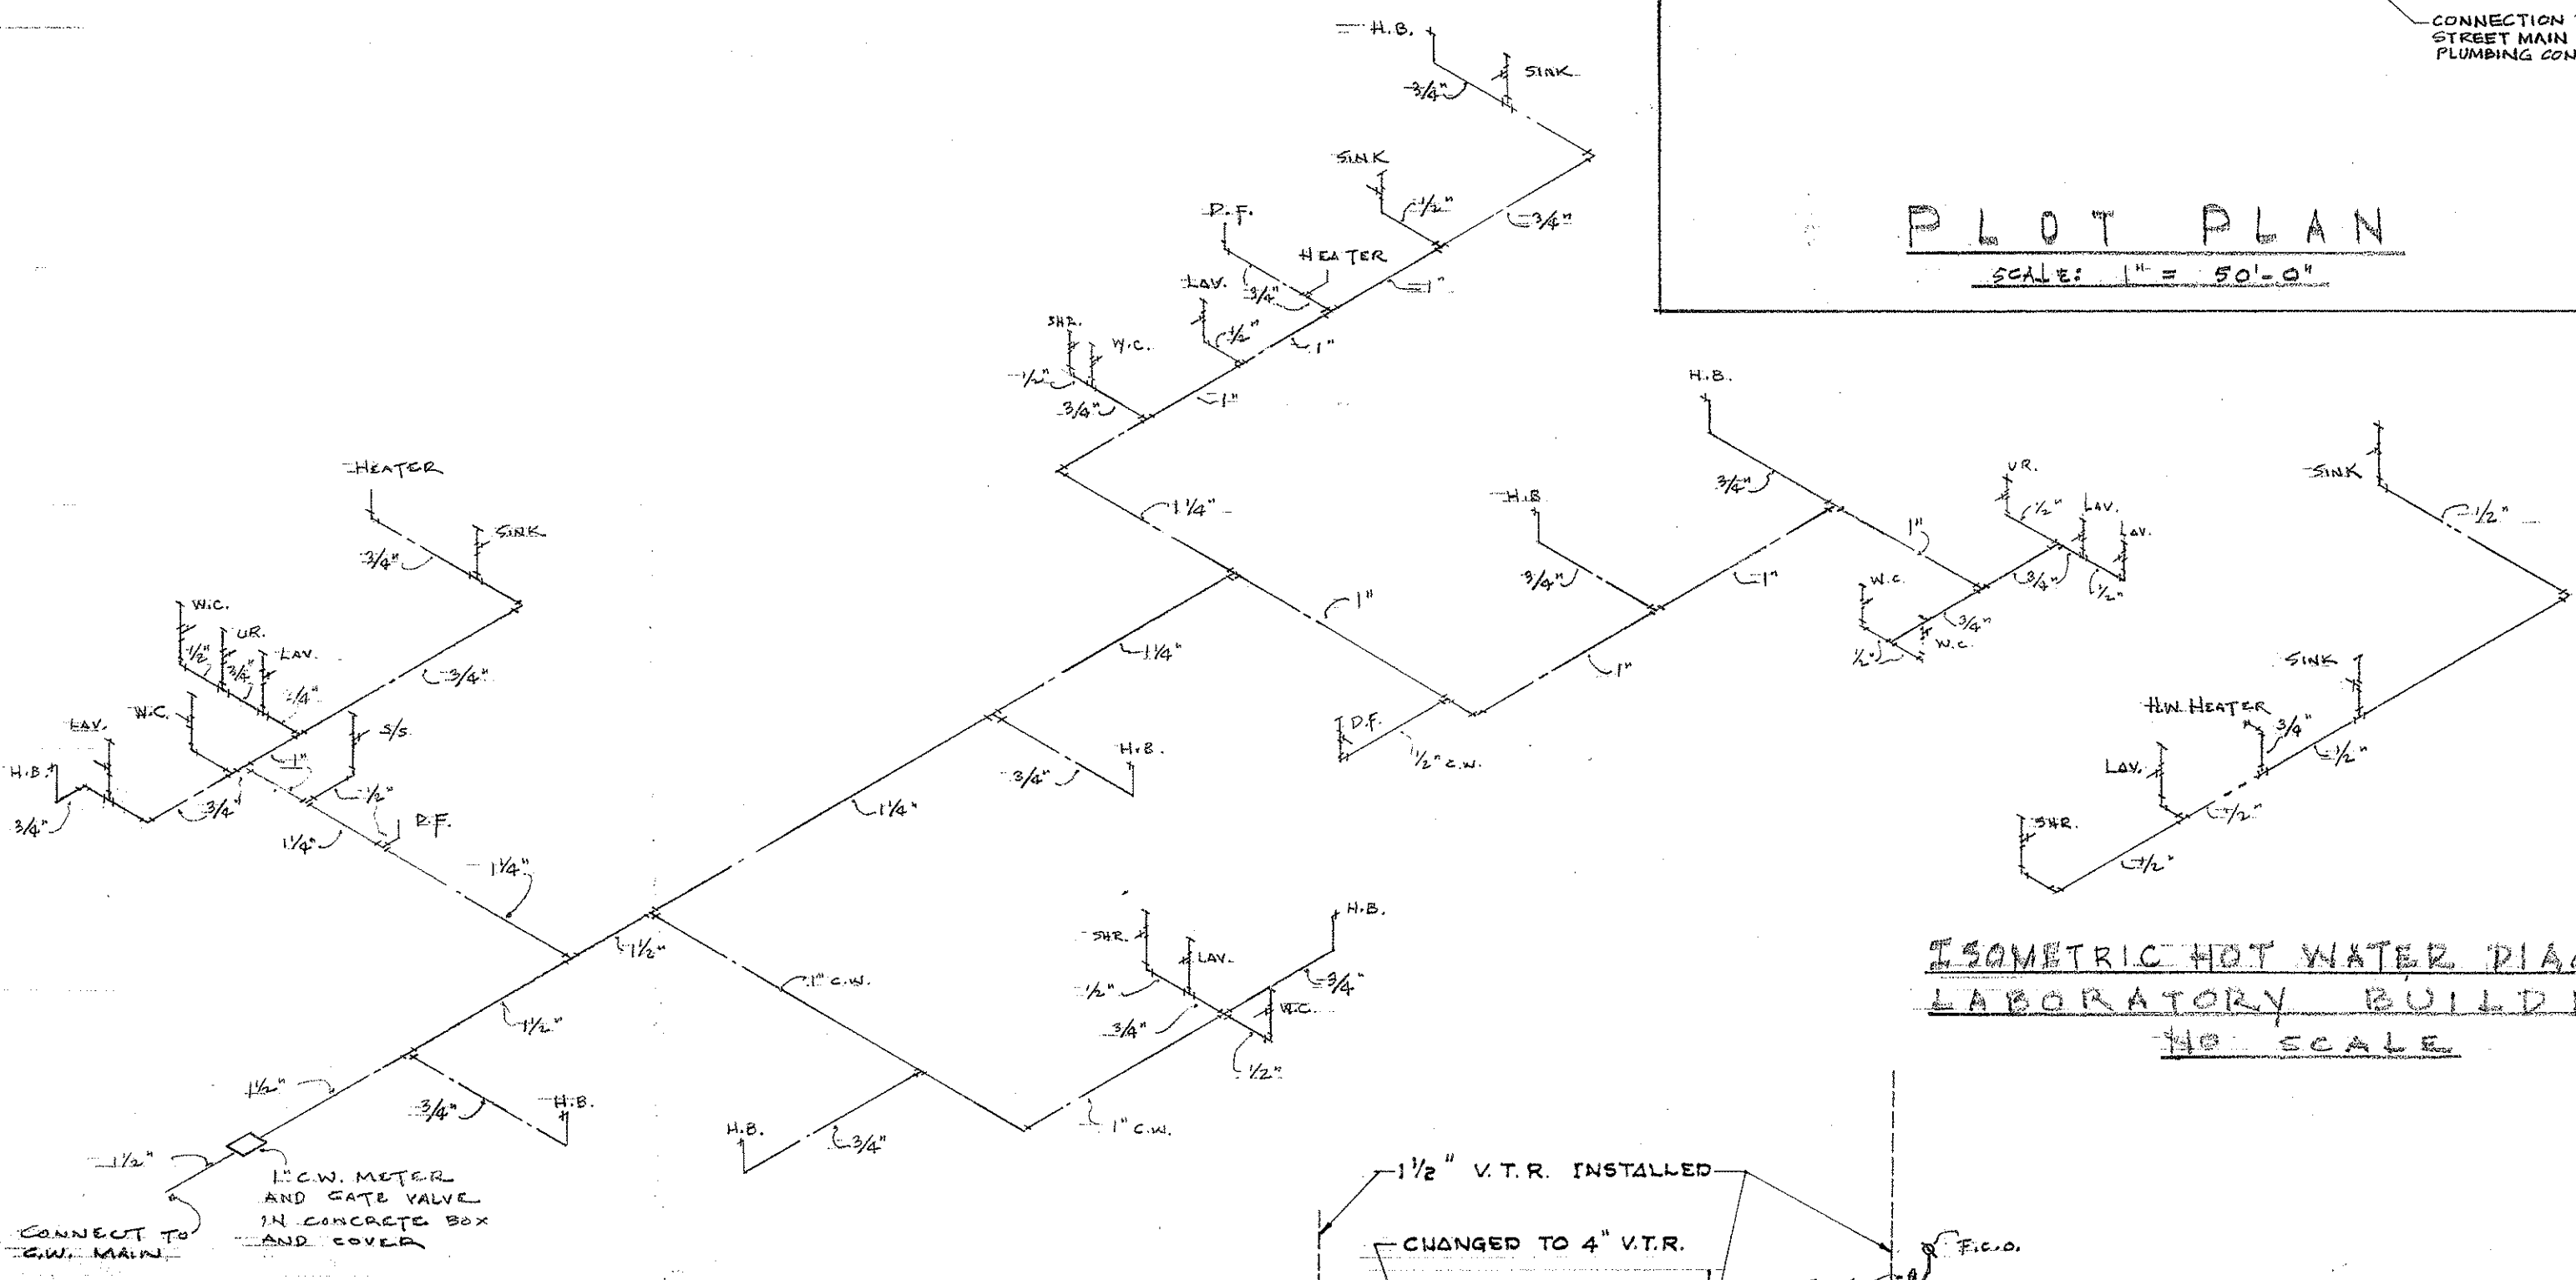
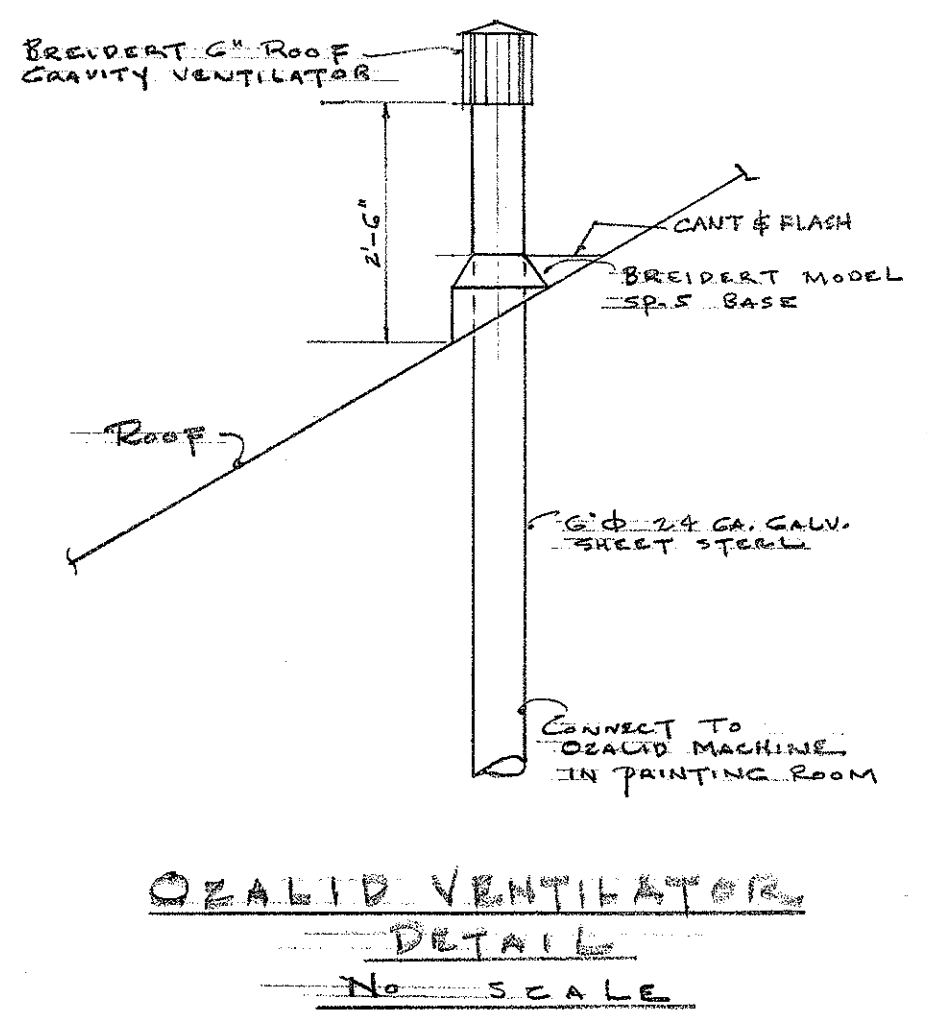


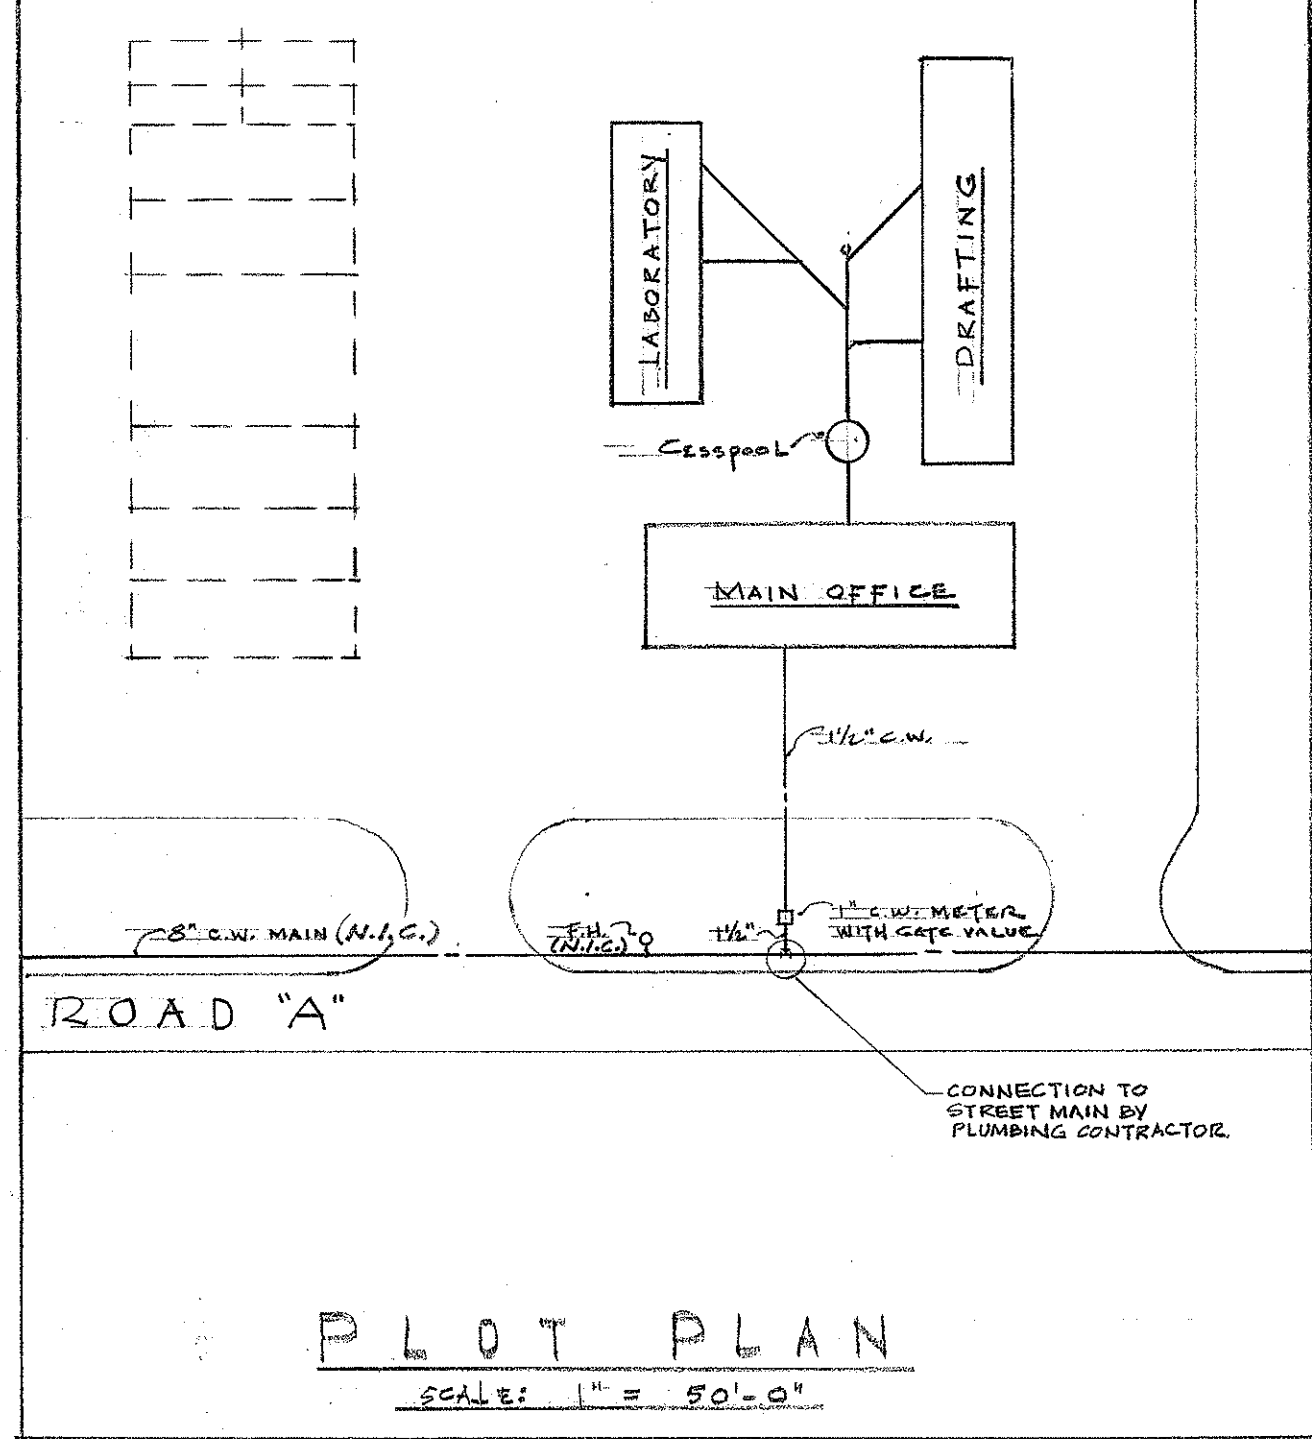


LEGEND

C.W.	COLD WATER
H.W.	HOT WATER
H.B.	HOSE BIBB
F.D.	FLOOR DRAIN
V.T.R.	VENT THROUGH ROOF
W.C.	WATER CLOSET
LAV.	LAVATORY
UR.	URINAL
SHR.	SHOWER
S/S	SERVICE SINK
D.F.	DRINKING FOUNTAIN
C.O.	CLEANOUT
F.C.O.	FLOOR CLEANOUT
C.O.T.G.	CLEANOUT THROUGH GRADE

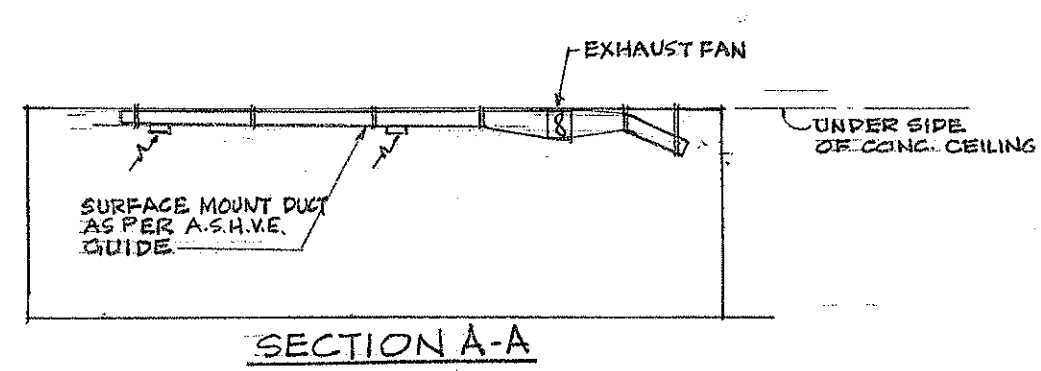

ISOMETRIC COLD WATER DIAGRAM
NO SCALE

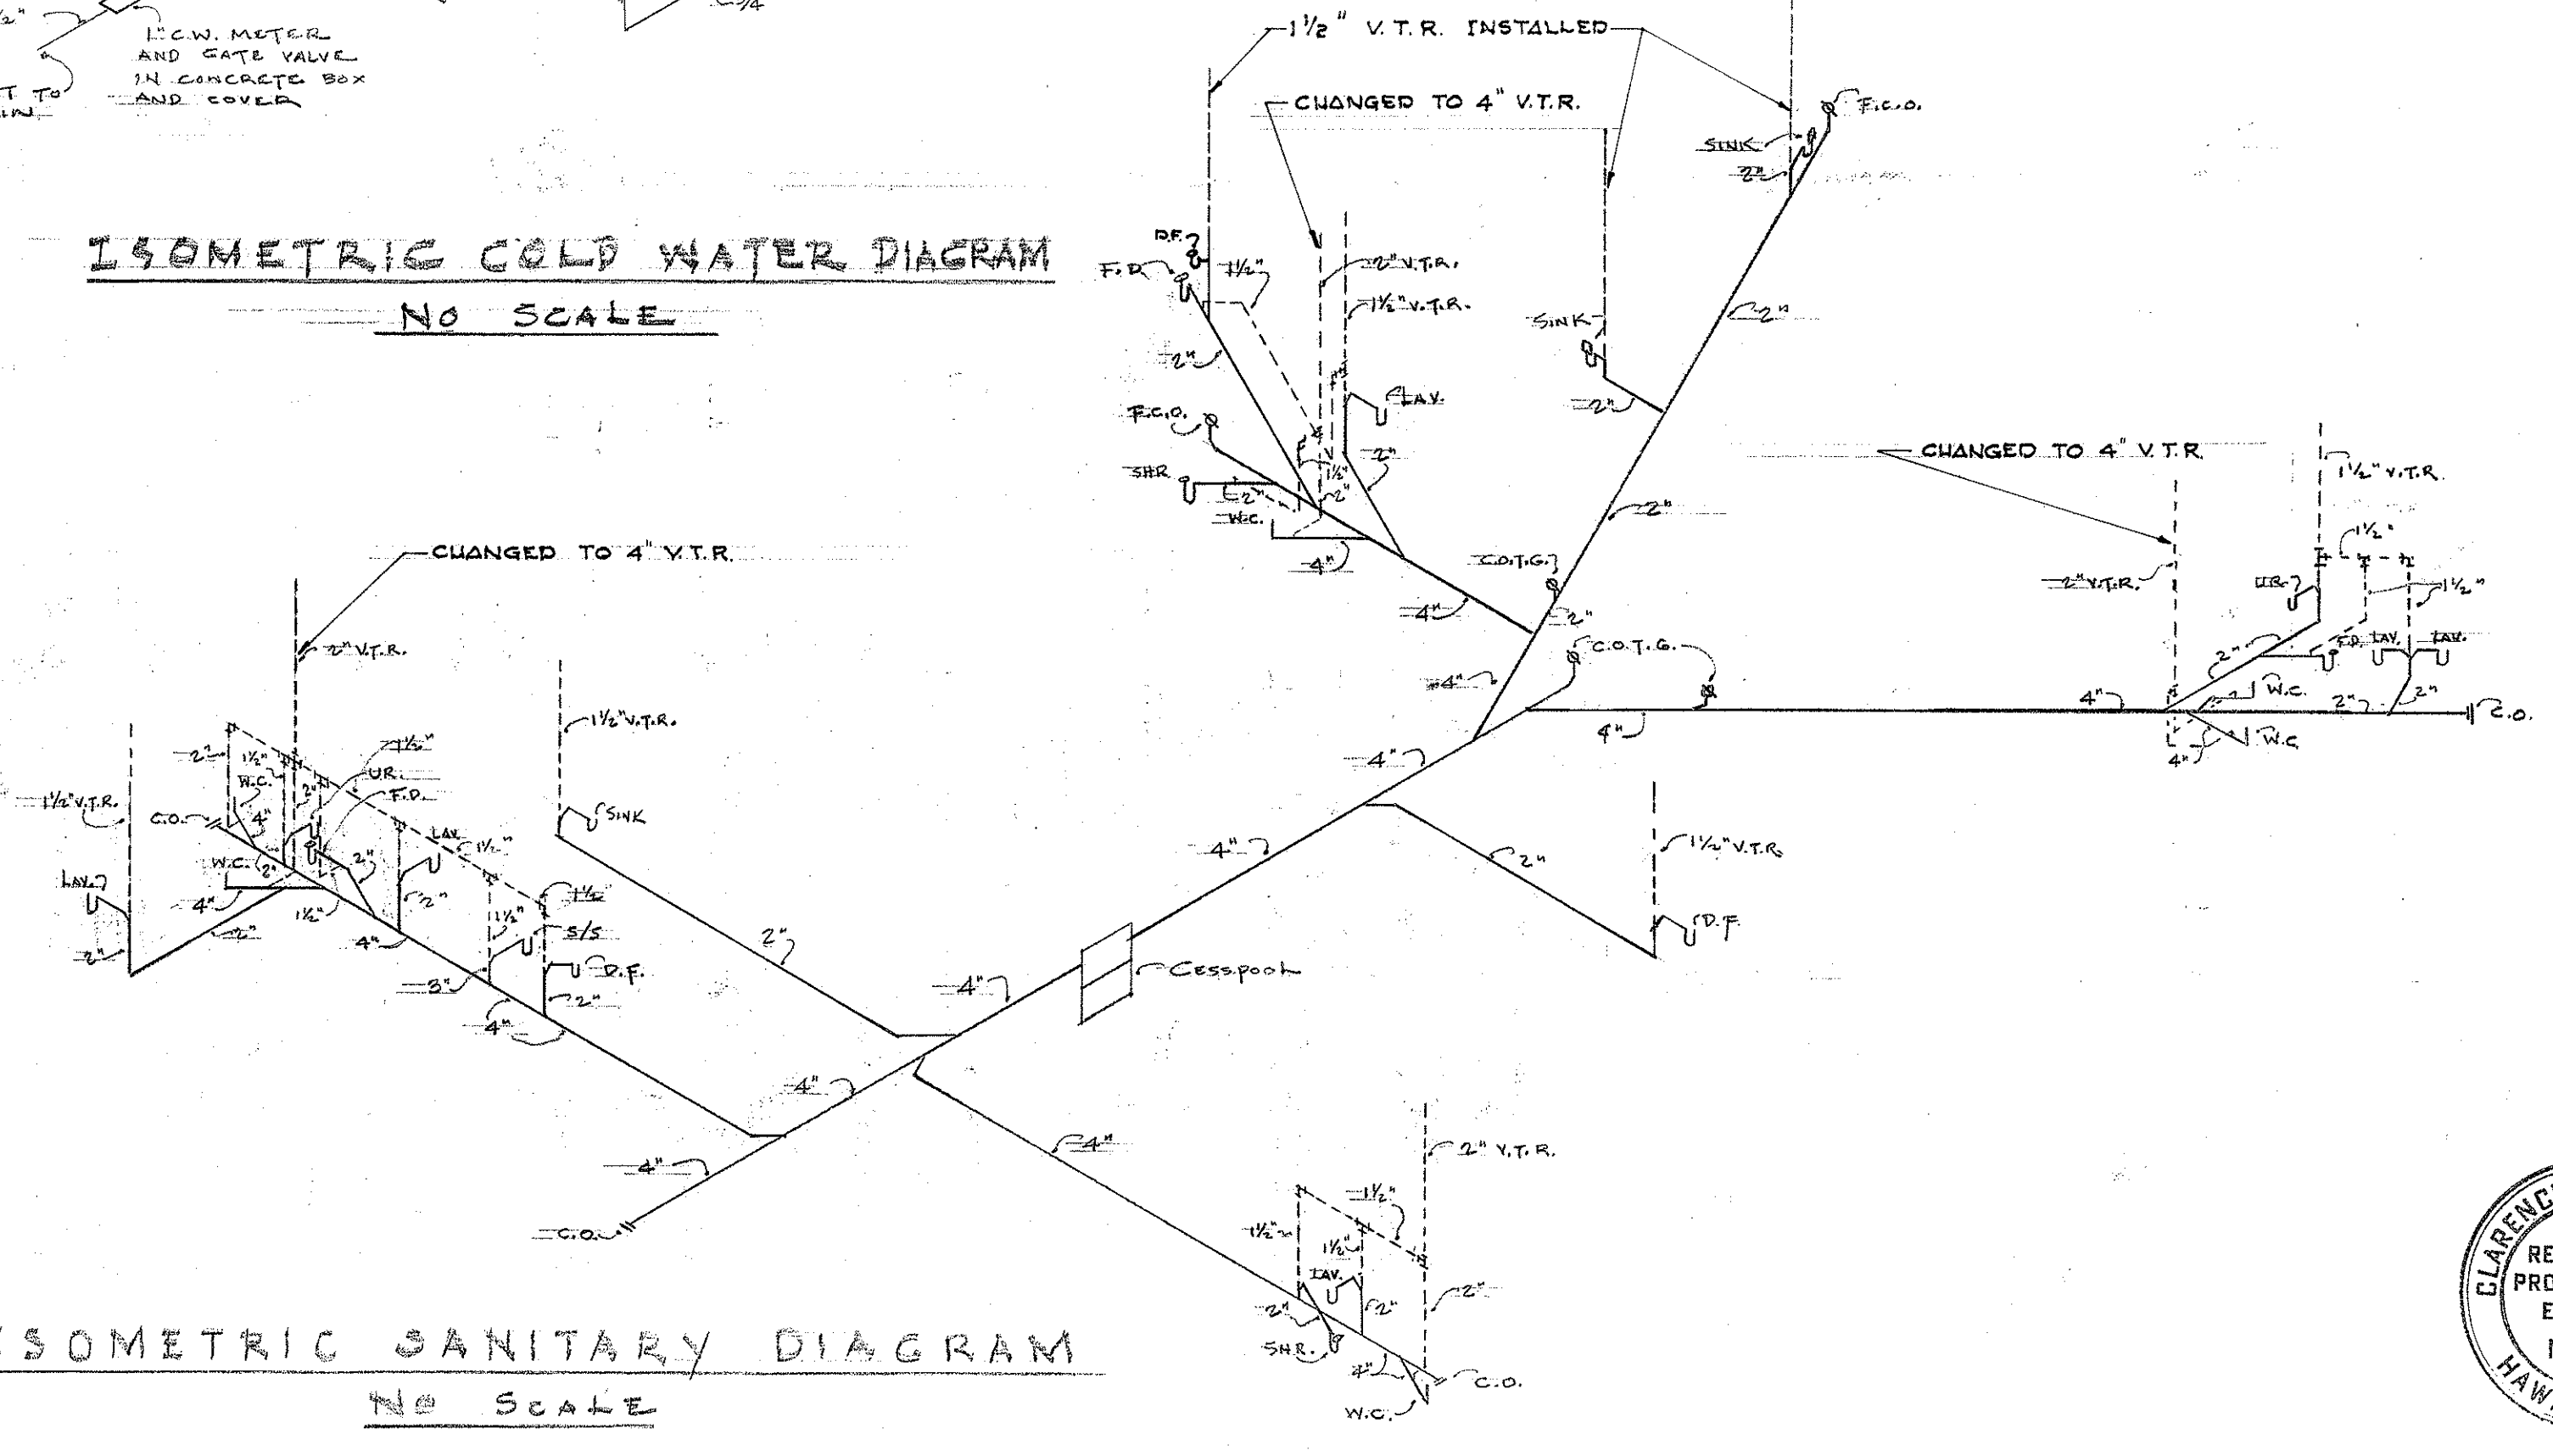

DEPARTMENT OF TRANSPORTATION
DIVISION OF HIGHWAYS
STATE OF HAWAII

MECHANICAL LAYOUT

OFFICE & LABORATORY BUILDINGS
DEPT. OF TRANSPORTATION - HILO, HAWAII

CLARENCE L. NAKASIMA
REGISTERED PROFESSIONAL ENGINEER
NO. 1142
HAWAII, U.S.A.

JOB NO. 3130-02-00
DATE SEPT. 22, 1964
DRAWING NO. **M1**
SHEET 12 OF 12