
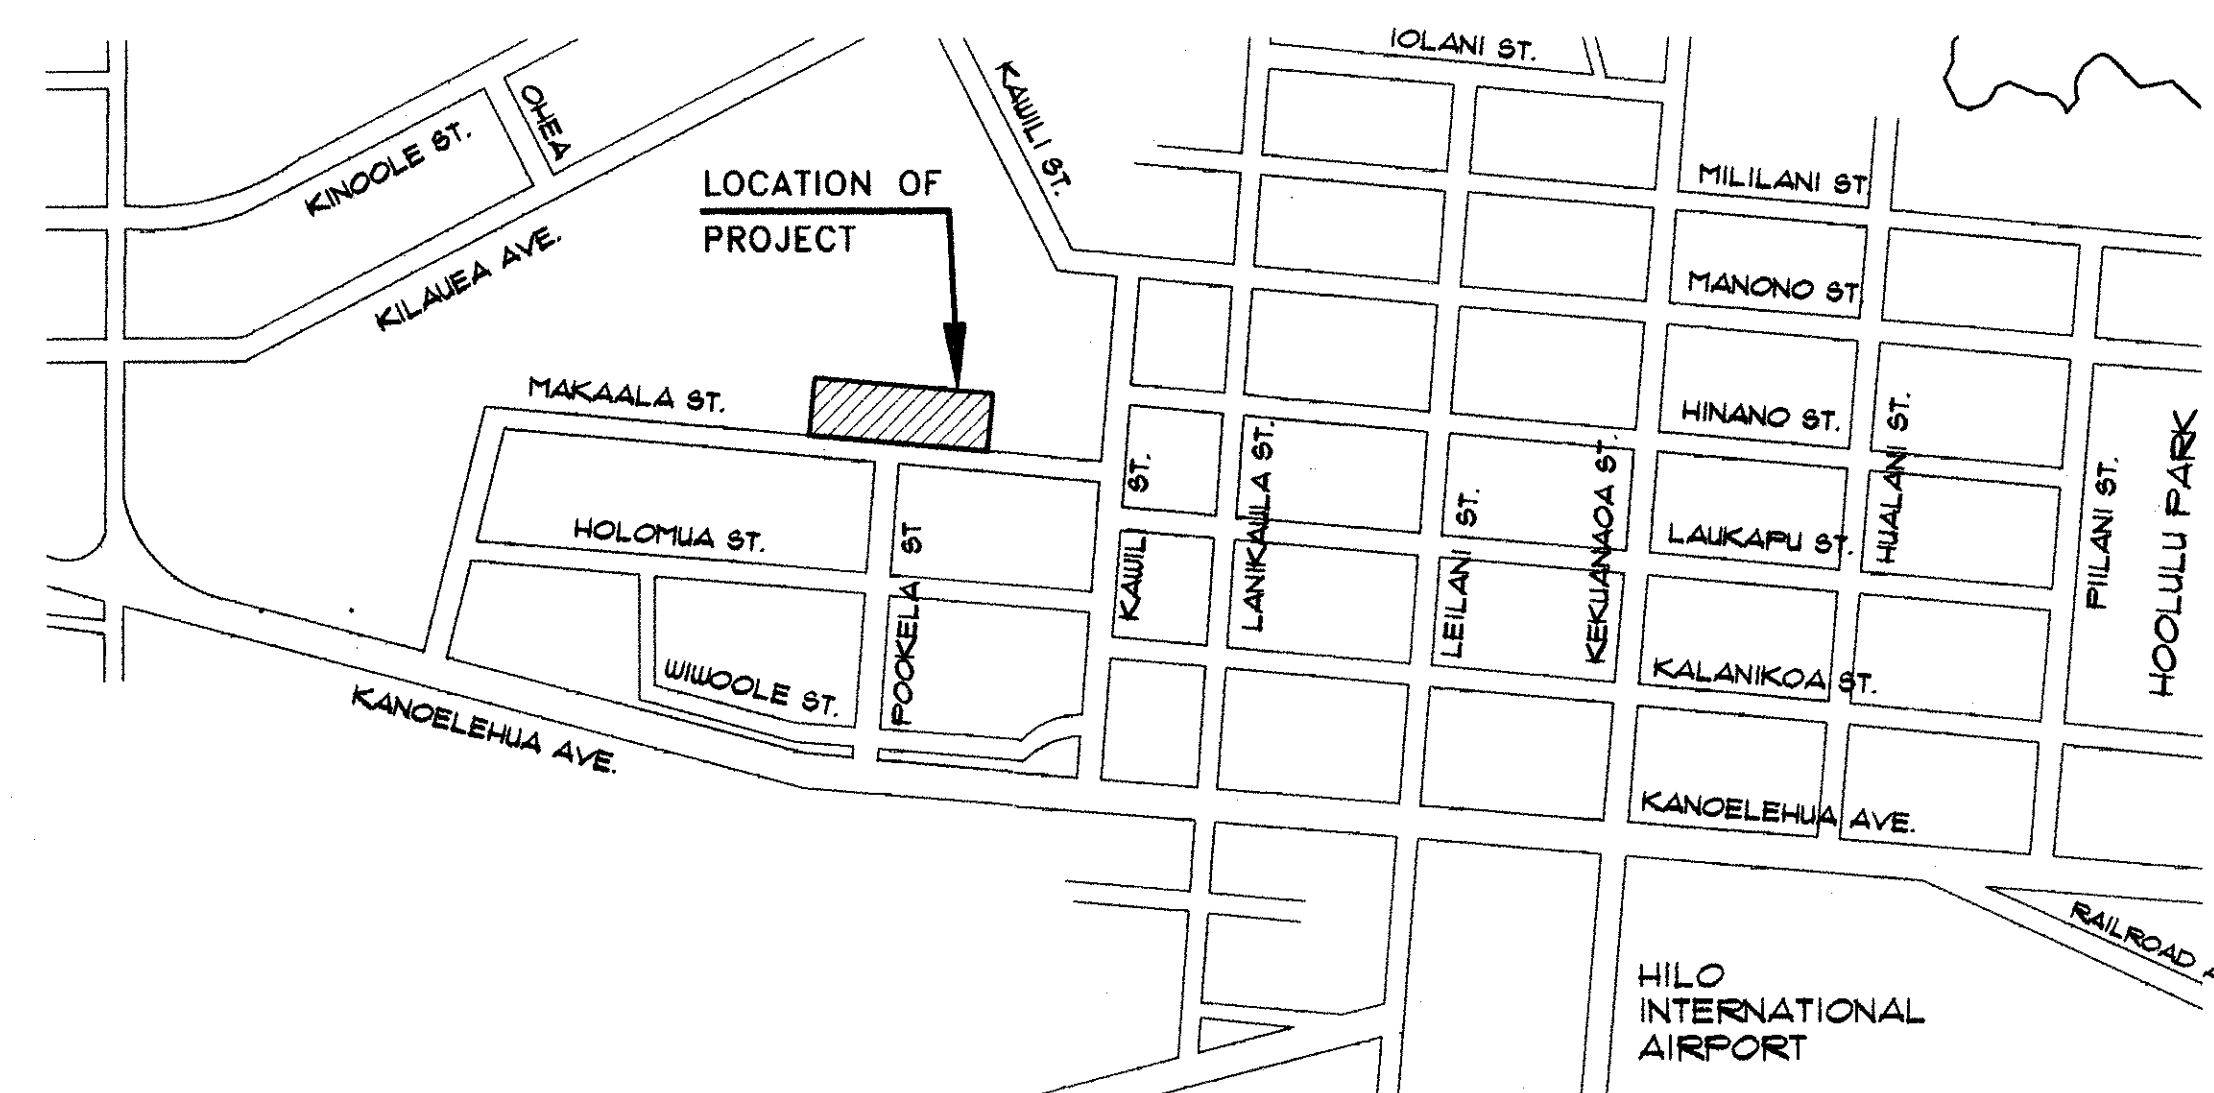


FED. ROAD DIST. NO.	STATE	PROJ. NO.	FISCAL YEAR	SHEET NO.	TOTAL SHEETS
HAWAII	HAW.	HWY-H-04-99M	2000	1	73

INDEX TO DRAWINGS	
SHEET NO.	DESCRIPTION
1	TITLE SHEET
2	GENERAL NOTES
3	EXISTING SITE PLAN
4	NEW SITE PLAN
5	ADAAG DETAILS
6	BUILDING A – EXISTING FLOOR PLAN
7	BUILDING A – NEW FLOOR PLAN
8	LANDING DETAILS
9	RAMP DETAILS
10	BUILDING A – DETAILS
11–12	BUILDING A2 – MODULAR TRAILER DETAILS
13	FUEL STATION
14	BUILDING B – ROOF PLAN & SECTION THRU BUILDING
15	BUILDING C – ROOF PLAN & SECTION THRU BUILDING
16	BUILDING D – ROOF PLAN & SECTION THRU BUILDING
17–19	FUEL CANOPY & STORAGE TRAILER PLANS
20	SITE PLAN, GENERAL NOTES, LEGEND–MECHANICAL
21	AIR CONDITIONING PLAN–MAIN OFFICE
22	AIR CONDITIONING PLAN–DRAFTING
23	AIR CONDITIONING PLAN–LAB
24	PARTIAL AIR CONDITIONING PLAN–STREET LEVEL BUILDING B
25	DUST COLLECTION SYSTEM PLAN–BUILDING C
26	PARTIAL AIR CONDITIONING PLAN–UPPER LEVEL BUILDING C
27	PARTIAL AIR CONDITIONING PLAN–STREET LEVEL BUILDING D
28	AIR CONDITIONING PLAN–BUILDING D EXTENSION
29	AIR CONDITIONING PLAN–MVSO OFFICE
30	DUST COLLECTOR DUCT DIAGRAM
31	DETAILS–DUST COLLECTION
32	DETAILS
33	EQUIPMENT SCHEDULE
34–36	A/C CALCULATIONS
37–73	ELECTRICAL PLAN

STATE OF HAWAII
DEPARTMENT OF TRANSPORTATION
HIGHWAYS DIVISION
HONOLULU, HAWAII

PLANS FOR
HILO BASEYARD
IMPROVEMENTS
PROJECT NO. HWY-H-04-99M
DISTRICT OF SOUTH HILO
ISLAND OF HAWAII

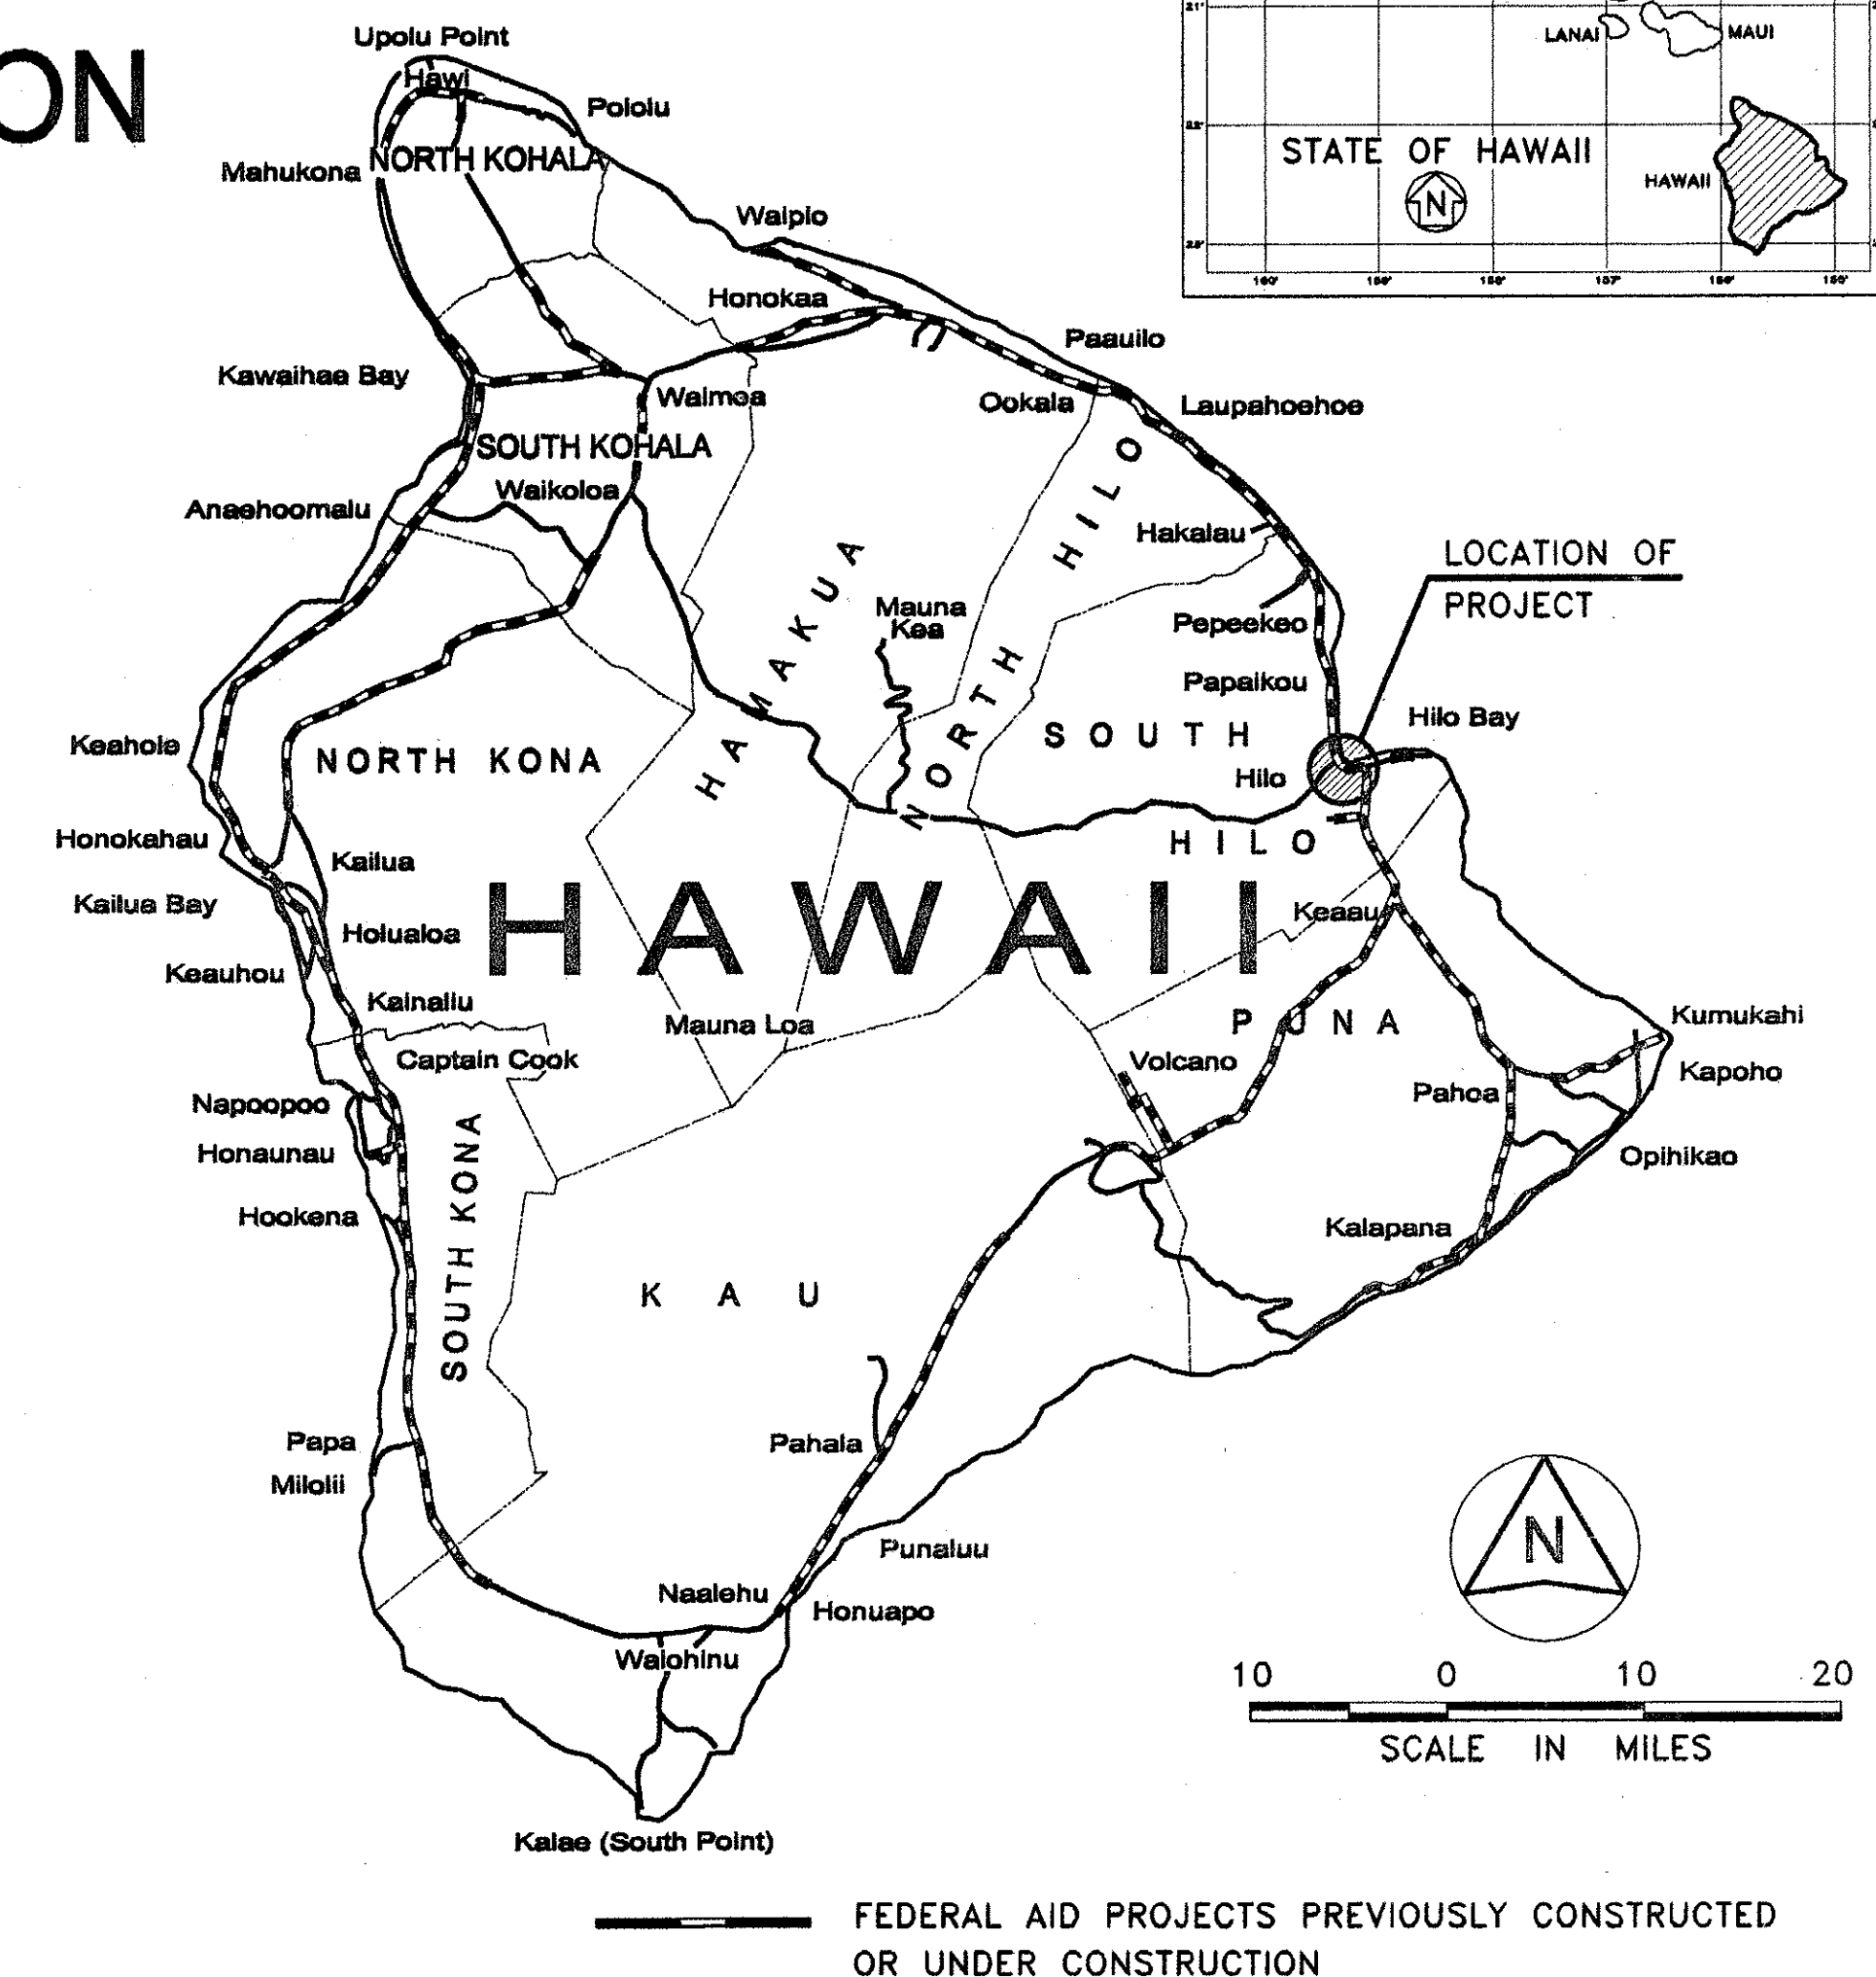

TAX MAP KEY: 2-2-50: 75

LOCATION MAP
(NOT TO SCALE)

DEPARTMENT OF TRANSPORTATION
STATE OF HAWAII

APPROVED: *Wayne Wayne White* 6/1/00

DIR. OF TRANSPORTATION DATE

Oda/McCarty Architects Ltd. DESIGNED BY R. Taira P.S. & E. BY 933-8866 PHONE April 2000 DATE