


HA-99030\_019mstateh.dgn  
4/4/2003 4:51:38 PM

SURVEY PLOTTED BY	DATE
DRAWN BY	
TRACED BY	
NOTED BY	
CHECKED BY	
ORIGINAL PLAN	
NOTE BOOK	
N.	


INDEX TO DRAWINGS		
DWG. NO.	SHT. NO.	DESCRIPTION
T-1	1	TITLE SHEET
G-1	2	GENERAL NOTES; WATER POLLUTION AND EROSION CONTROL NOTES
G-2	3	WATER POLLUTION AND EROSION CONTROL NOTES
A-1	4	DEMOLITION SITE PLAN
A-2	5	SITE PLAN & SYMBOLS
A-3	6	FIRST FLOOR PLANS
A-4	7	PARTIAL FLOOR PLANS
A-5	8	ROOF PLAN & REFL CLG PLAN
A-6	9	PARTIAL REFL CLG PLAN & SECTIONS
A-7	10	EXTERIOR ELEVATIONS
A-8	11	INTERIOR ELEVATIONS
A-9	12	PARTITION DETAILS
A-10	13	STAIR DETAILS
A-11	14	DOOR SCHEDULE & DETAILS
A-12	15	MISCELLANEOUS DETAILS
A-13	16	OFFICE TRAILER, TEMP TOILET FACILITY & CHEMICAL/ FLAMMABLE STORAGE PLANS
A-14	17	SECTIONS & DETAILS
A-15	18	PUMP STATION FLOOR PLAN & SECTIONS
S-1	19	STRUCTURAL GENERAL NOTES
S-2	20	STRUCTURAL GENERAL NOTES
S-3	21	STRUCTURAL SITE PLAN AND SECTIONS
S-4	22	PARTIAL FIRST AND MEZZANINE FLOOR PLAN
S-5	23	CONCRETE AND WOOD STAIR DETAILS
S-6	24	CMU WALL SECTIONS AND OFFICE ENTRY DETAILS
S-7	25	PUMP STATION PLANS AND SECTIONS
S-8	26	PUMP STATION ROOF FRAMING DETAILS
S-9	27	PUMP STATION ROOF, SLAB AND FOOTING DETAILS
S-10	28	OFFICE TRAILER FOUNDATION PLAN
S-11	29	OFFICE TRAILER ROOF PLAN
S-12	30	OFFICE TRAILER FOUNDATION DETAILS
S-13	31	OFFICE TRAILER CONC. RAMP SECTION AND DETAILS
S-14	32	OFFICE TRAILER RAMP, ROOF DETAILS
S-15	33	TYPICAL STRUCTURAL DETAILS
M-1	34	PARTIAL SITE PLAN, LEGEND AND ABBREVIATION AND NOTES
M-2	35	DEMOLITION AND MECHANICAL FLOOR PLANS AND DETAILS
M-3	36	PLUMBING FLOOR PLAN AND DIAGRAMS
E-1	37	ELECTRICAL SITE PLAN, ELECTRICAL SYMBOLS, SINGLE LINE DIAGRAM
E-2	38	ELECTRICAL DEMOLITION PLAN AND NOTES, DUCT SECTIONS, EQUIPMENT ELEVATION
E-3	39	ELECTRICAL PLANS - NEW WORK, TYPICAL FUEL PUMP AND NIGHT LIGHT WIRING DIAGRAM
E-4	40	LUMINAIRE DETAILS, PANELBOARD SCHEDULE

LUERSEN ARCHITECTS INC.  
DESIGNED BY  
R. TAIRA  
P. S. & E. BY  
933-8866  
PHONE  
DATE

STATE OF HAWAII  
DEPARTMENT OF TRANSPORTATION  
HIGHWAYS DIVISION  
HONOLULU, HAWAII  
"AS-BUILT"  
PLANS FOR  
WAIMEA BASEYARD IMPROVEMENTS  
PROJECT NO. HWY-H-05-00M  
DISTRICT OF SOUTH KOHALA  
ISLAND OF HAWAII

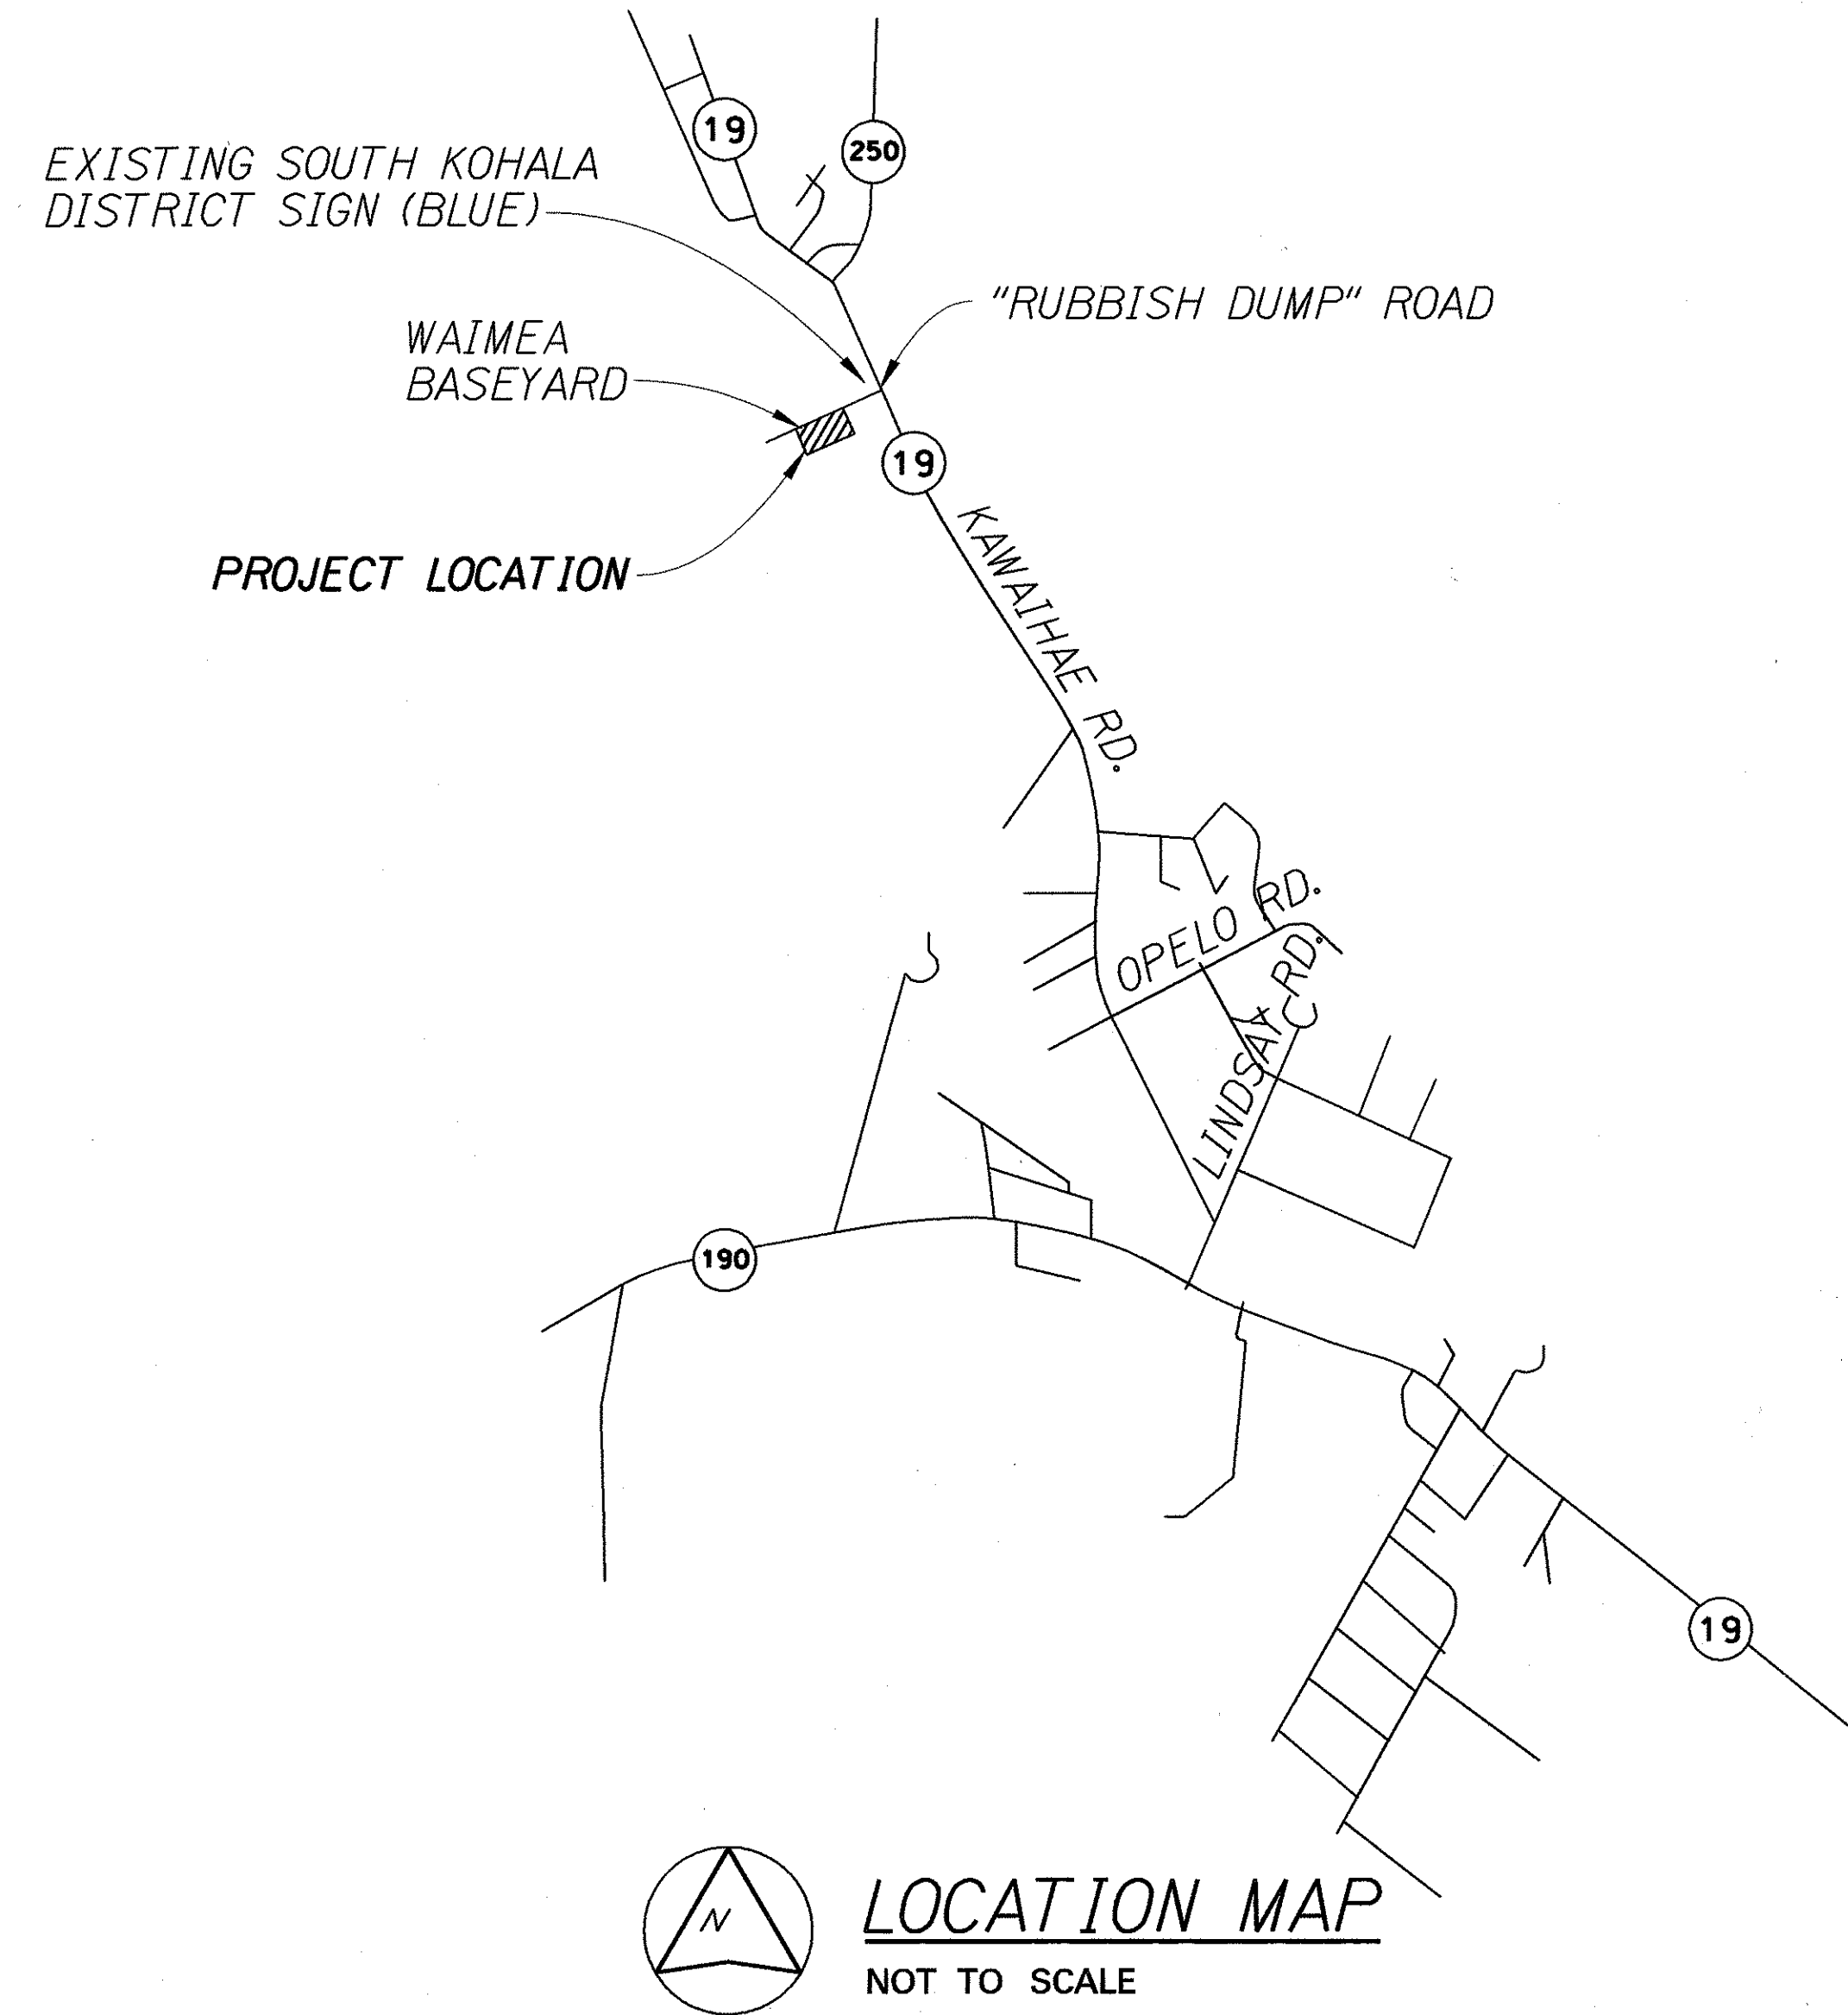

FED. ROAD DIST. NO.	STATE	PROJ. NO.	FISCAL YEAR	SHEET NO.	TOTAL SHEETS
HAWAII	HAW.	HWY-H-05-00M	2003	1	40

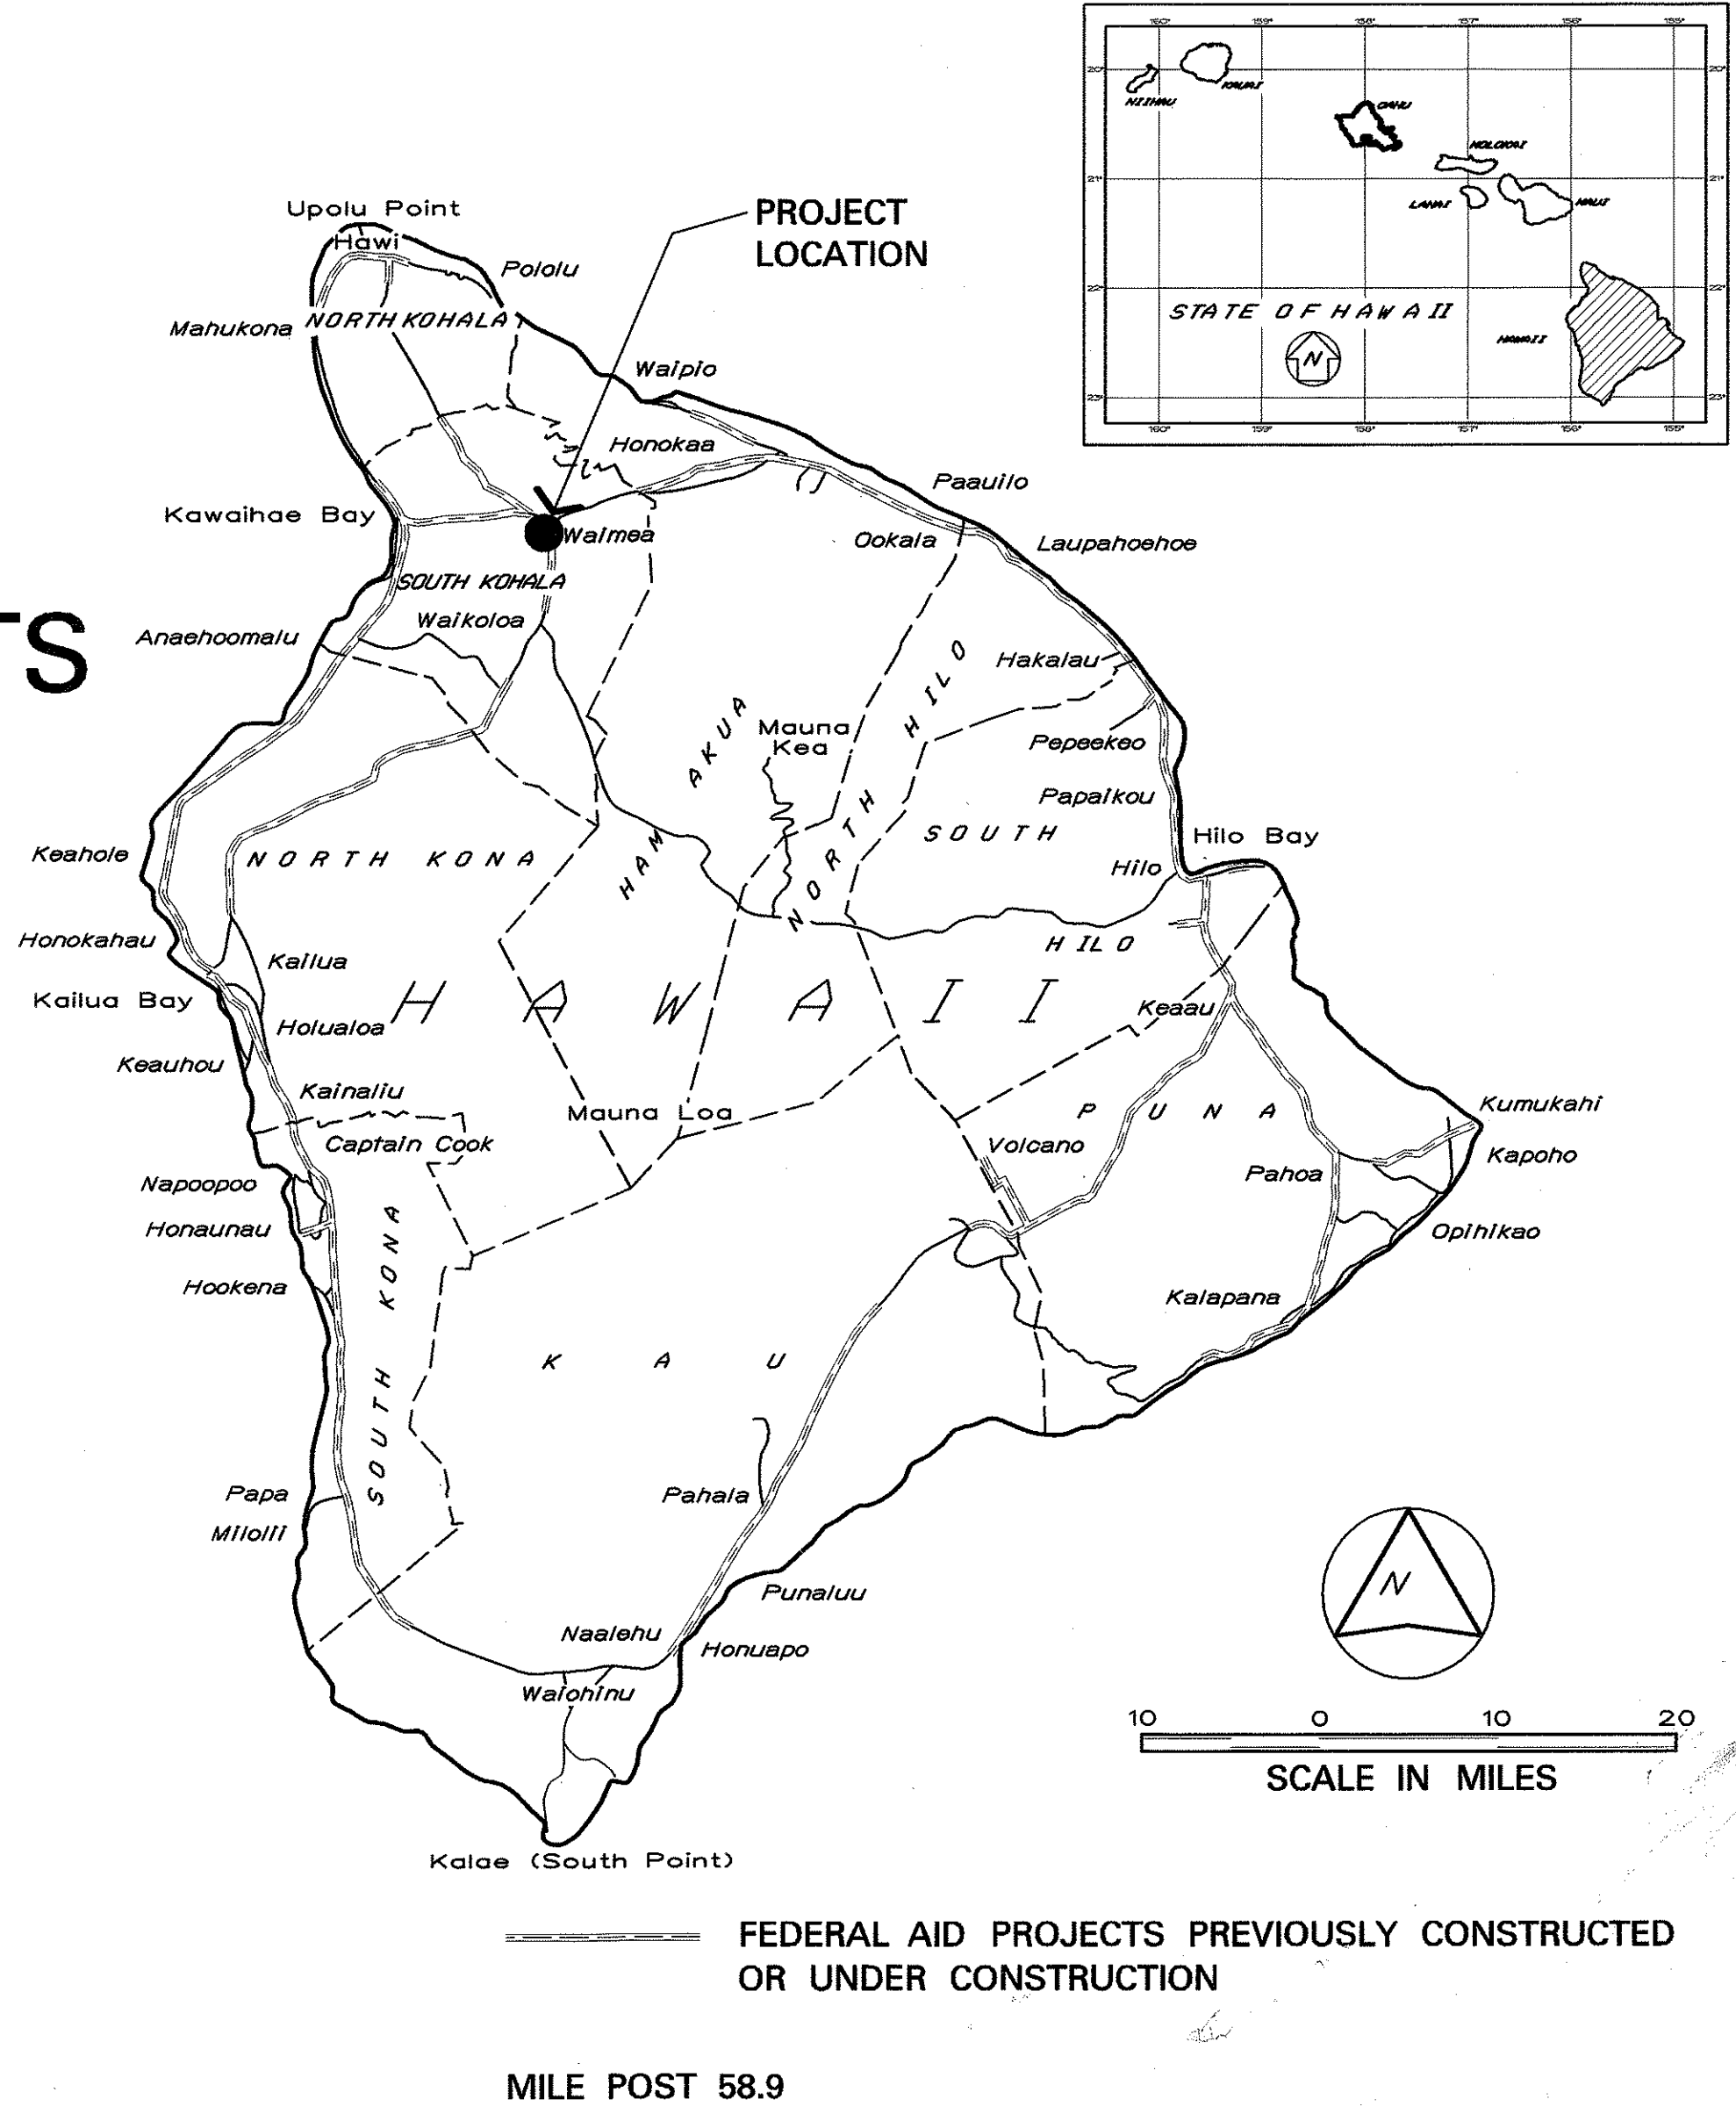

ROBERT ALAN LUERSEN  
LICENSED PROFESSIONAL ARCHITECT  
No. 3574  
HAWAII, USA

4/30/04

SIGNATURE  
This work was prepared by me or under my supervision.

CHANGES MADE DURING CONSTRUCTION HAVE BEEN INCORPORATED ON THESE PLANS EXCEPT CHANGES IN THE ORIGINAL THEORETICAL QUANTITIES. FOR ACTUAL QUANTITIES, REFER TO PROJECT LEDGER AND/OR COMPUTATION BOOK.

6/20/05  
DATE

DEPARTMENT OF TRANSPORTATION  
STATE OF HAWAII

APPROVED:

for DIR. OF TRANSPORTATION  
DATE  
4-21-03

SHEET No. 1 OF 1 SHEETS