


FED. ROAD DIST. NO.	STATE	PROJ. NO.	FISCAL YEAR	SHEET NO.	TOTAL SHEETS
HAWAII	HAW.	HWY-H-05-06	2008	55	64

DUCT SCHEDULE		
TYPE	DESCRIPTION	CABLES
1	1 1/2" C GRC, Power, Concrete Encased.	7#10, 1#10 GND
2	1" C GRC, Control, Concrete Encased.	Pullstring
3	1" C GRC, Lighting, Concrete Encased.	2#10, 1#10 GND


ORIGINAL PLAN	DATE
NO.	4/08
DESIGNED BY	4/08
CHECKED BY	4/08
DATE	4/08

5/9/08-13.38 Y:\087\087134\87-134-E02.dwg

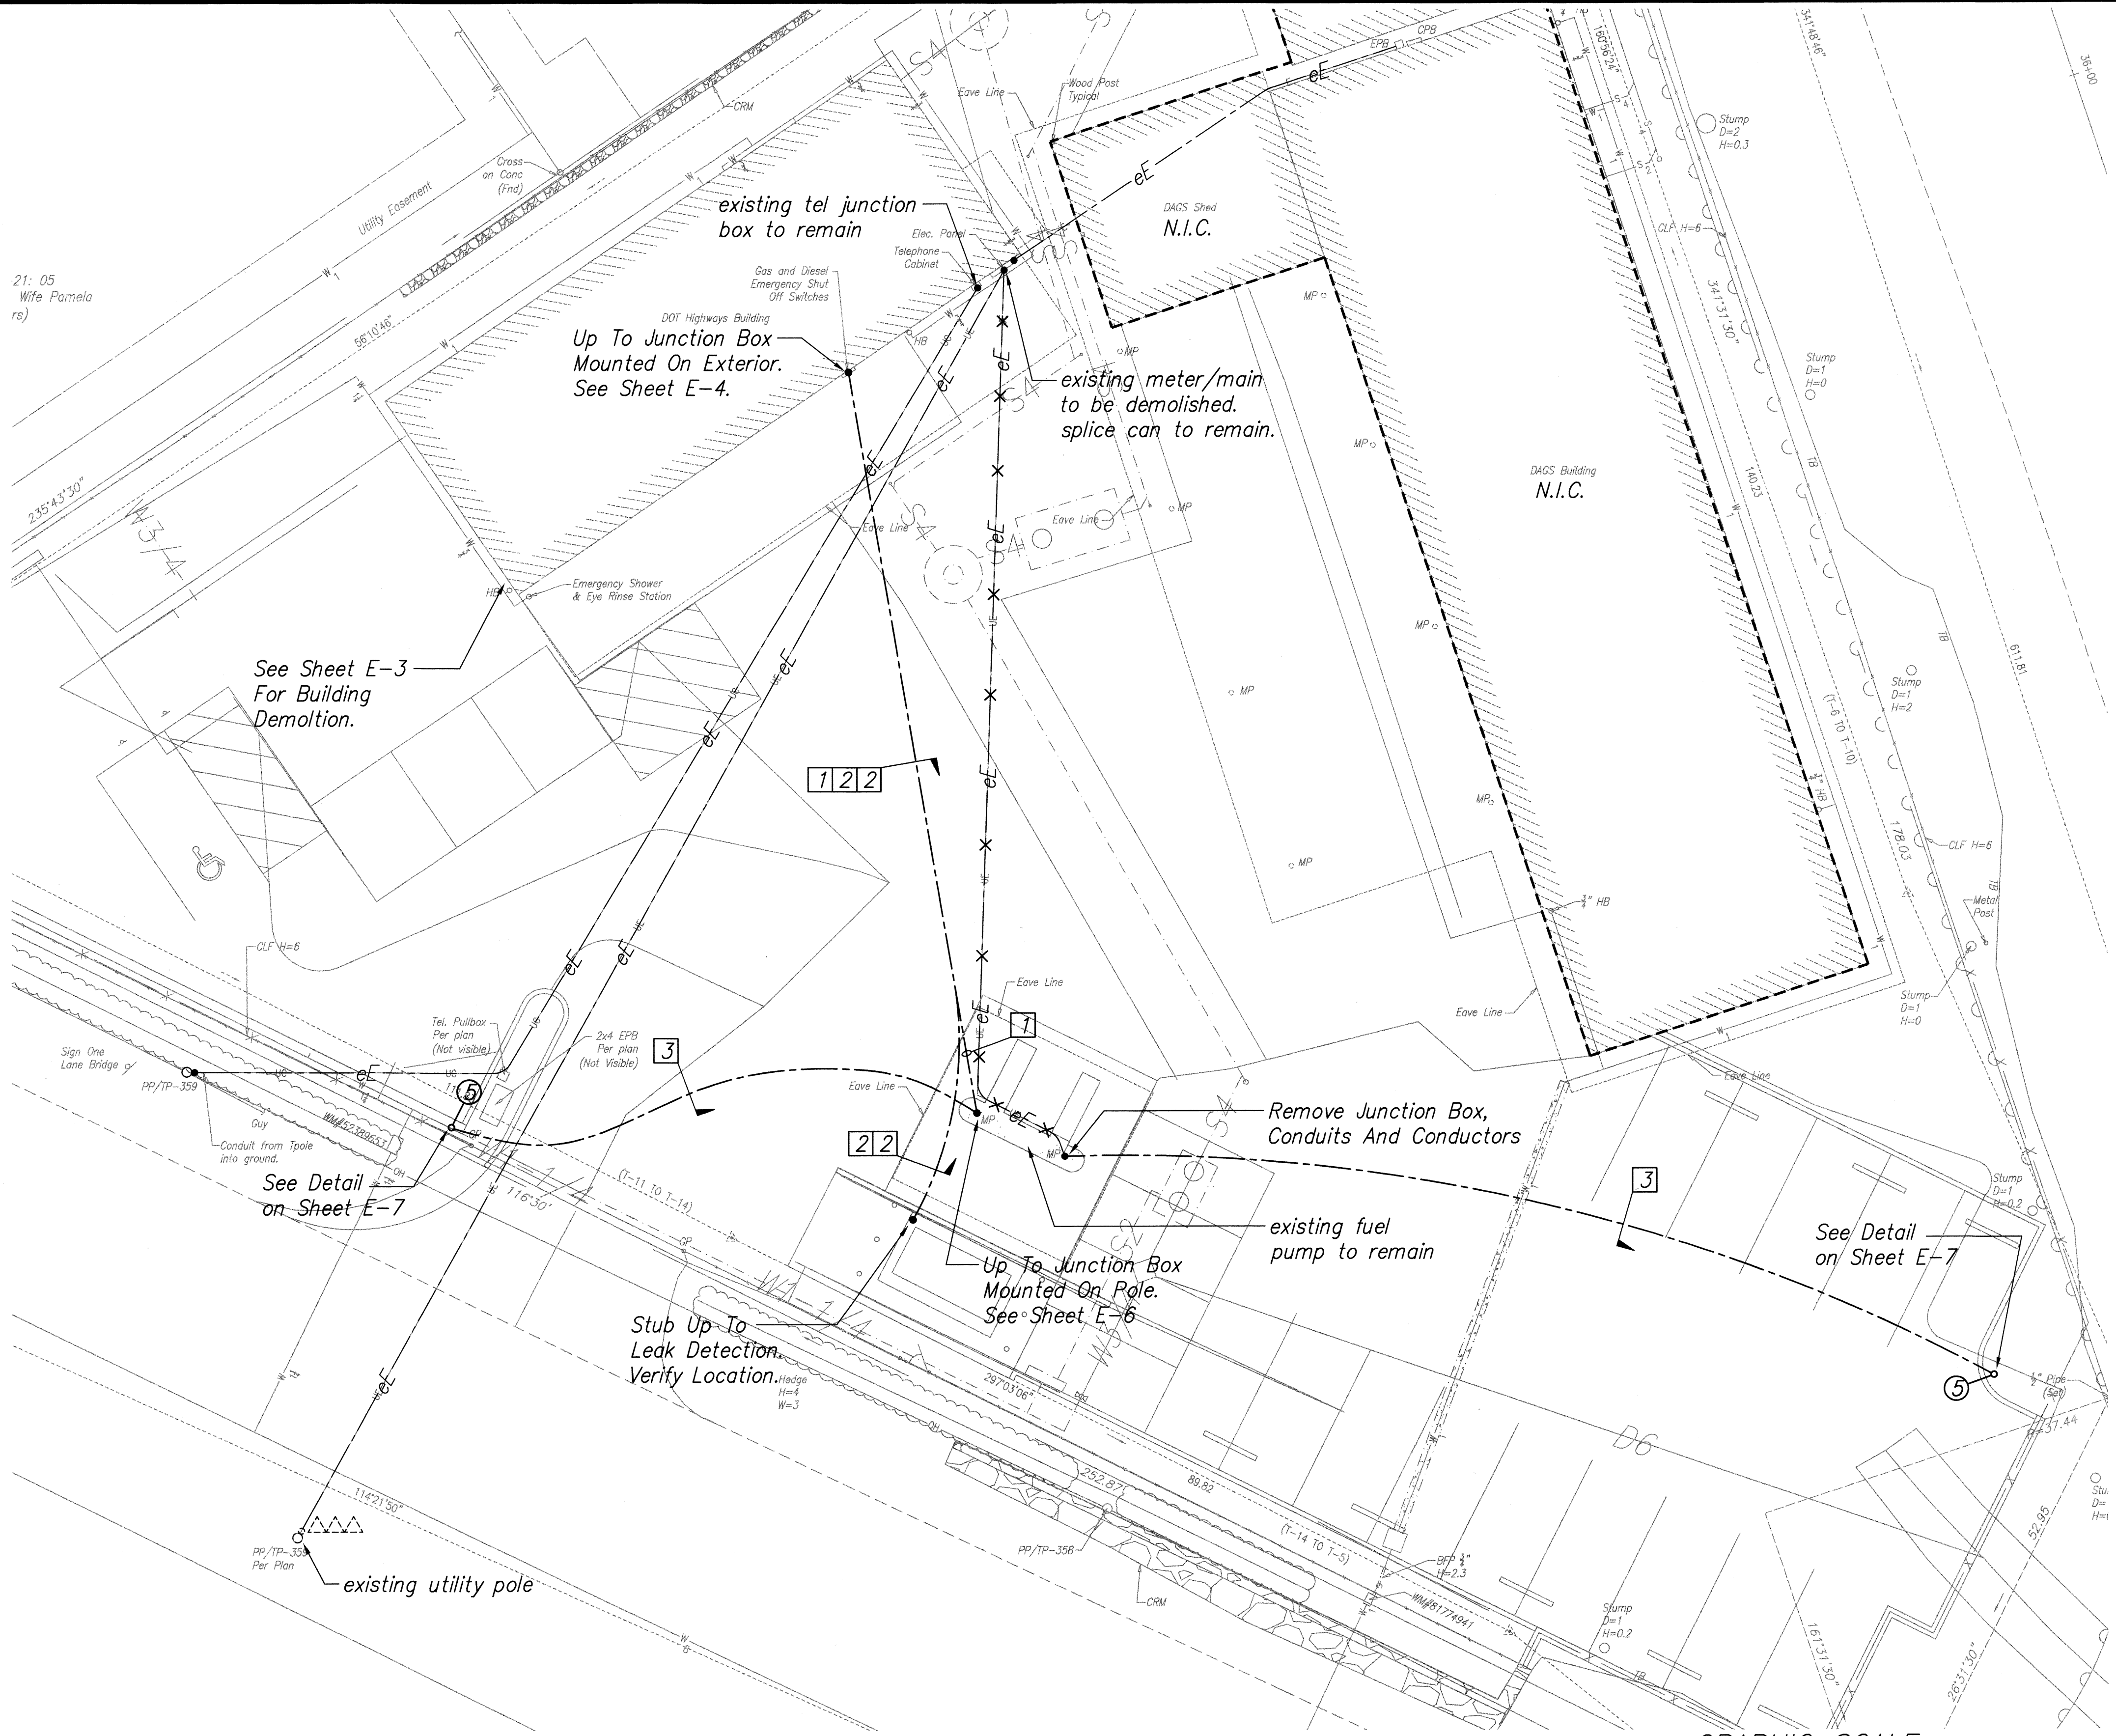


ELECTRICAL SITE PLAN


Scale: 1" = 10'

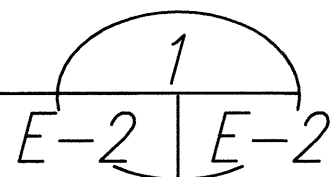

GRAPHIC SCALE:

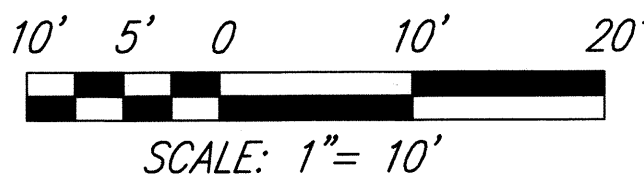

SCALE: 1" = 10'

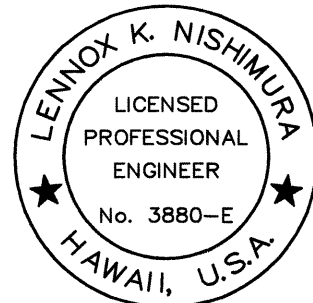

THIS WORK WAS PREPARED BY ME OR UNDER MY SUPERVISION.

PROJECT ENGINEER for ECS, Inc.
APRIL 30, 2010
EXPIRATION DATE OF THE LICENSE

STATE OF HAWAII
DEPARTMENT OF TRANSPORTATION
HIGHWAYS DIVISION

ELECTRICAL SITE PLAN


HONOKAA BASEYARD IMPROVEMENTS

Project No. HWY-H-05-06

Scale: As Noted Date: MAY 2008


SHEET No. E-2 OF E-7 SHEETS

FED. ROAD DIST. NO.	STATE	PROJ. NO.	FISCAL YEAR	SHEET NO.	TOTAL SHEETS
HAWAII	HAW.	HWY-H-05-06	2008	56	64

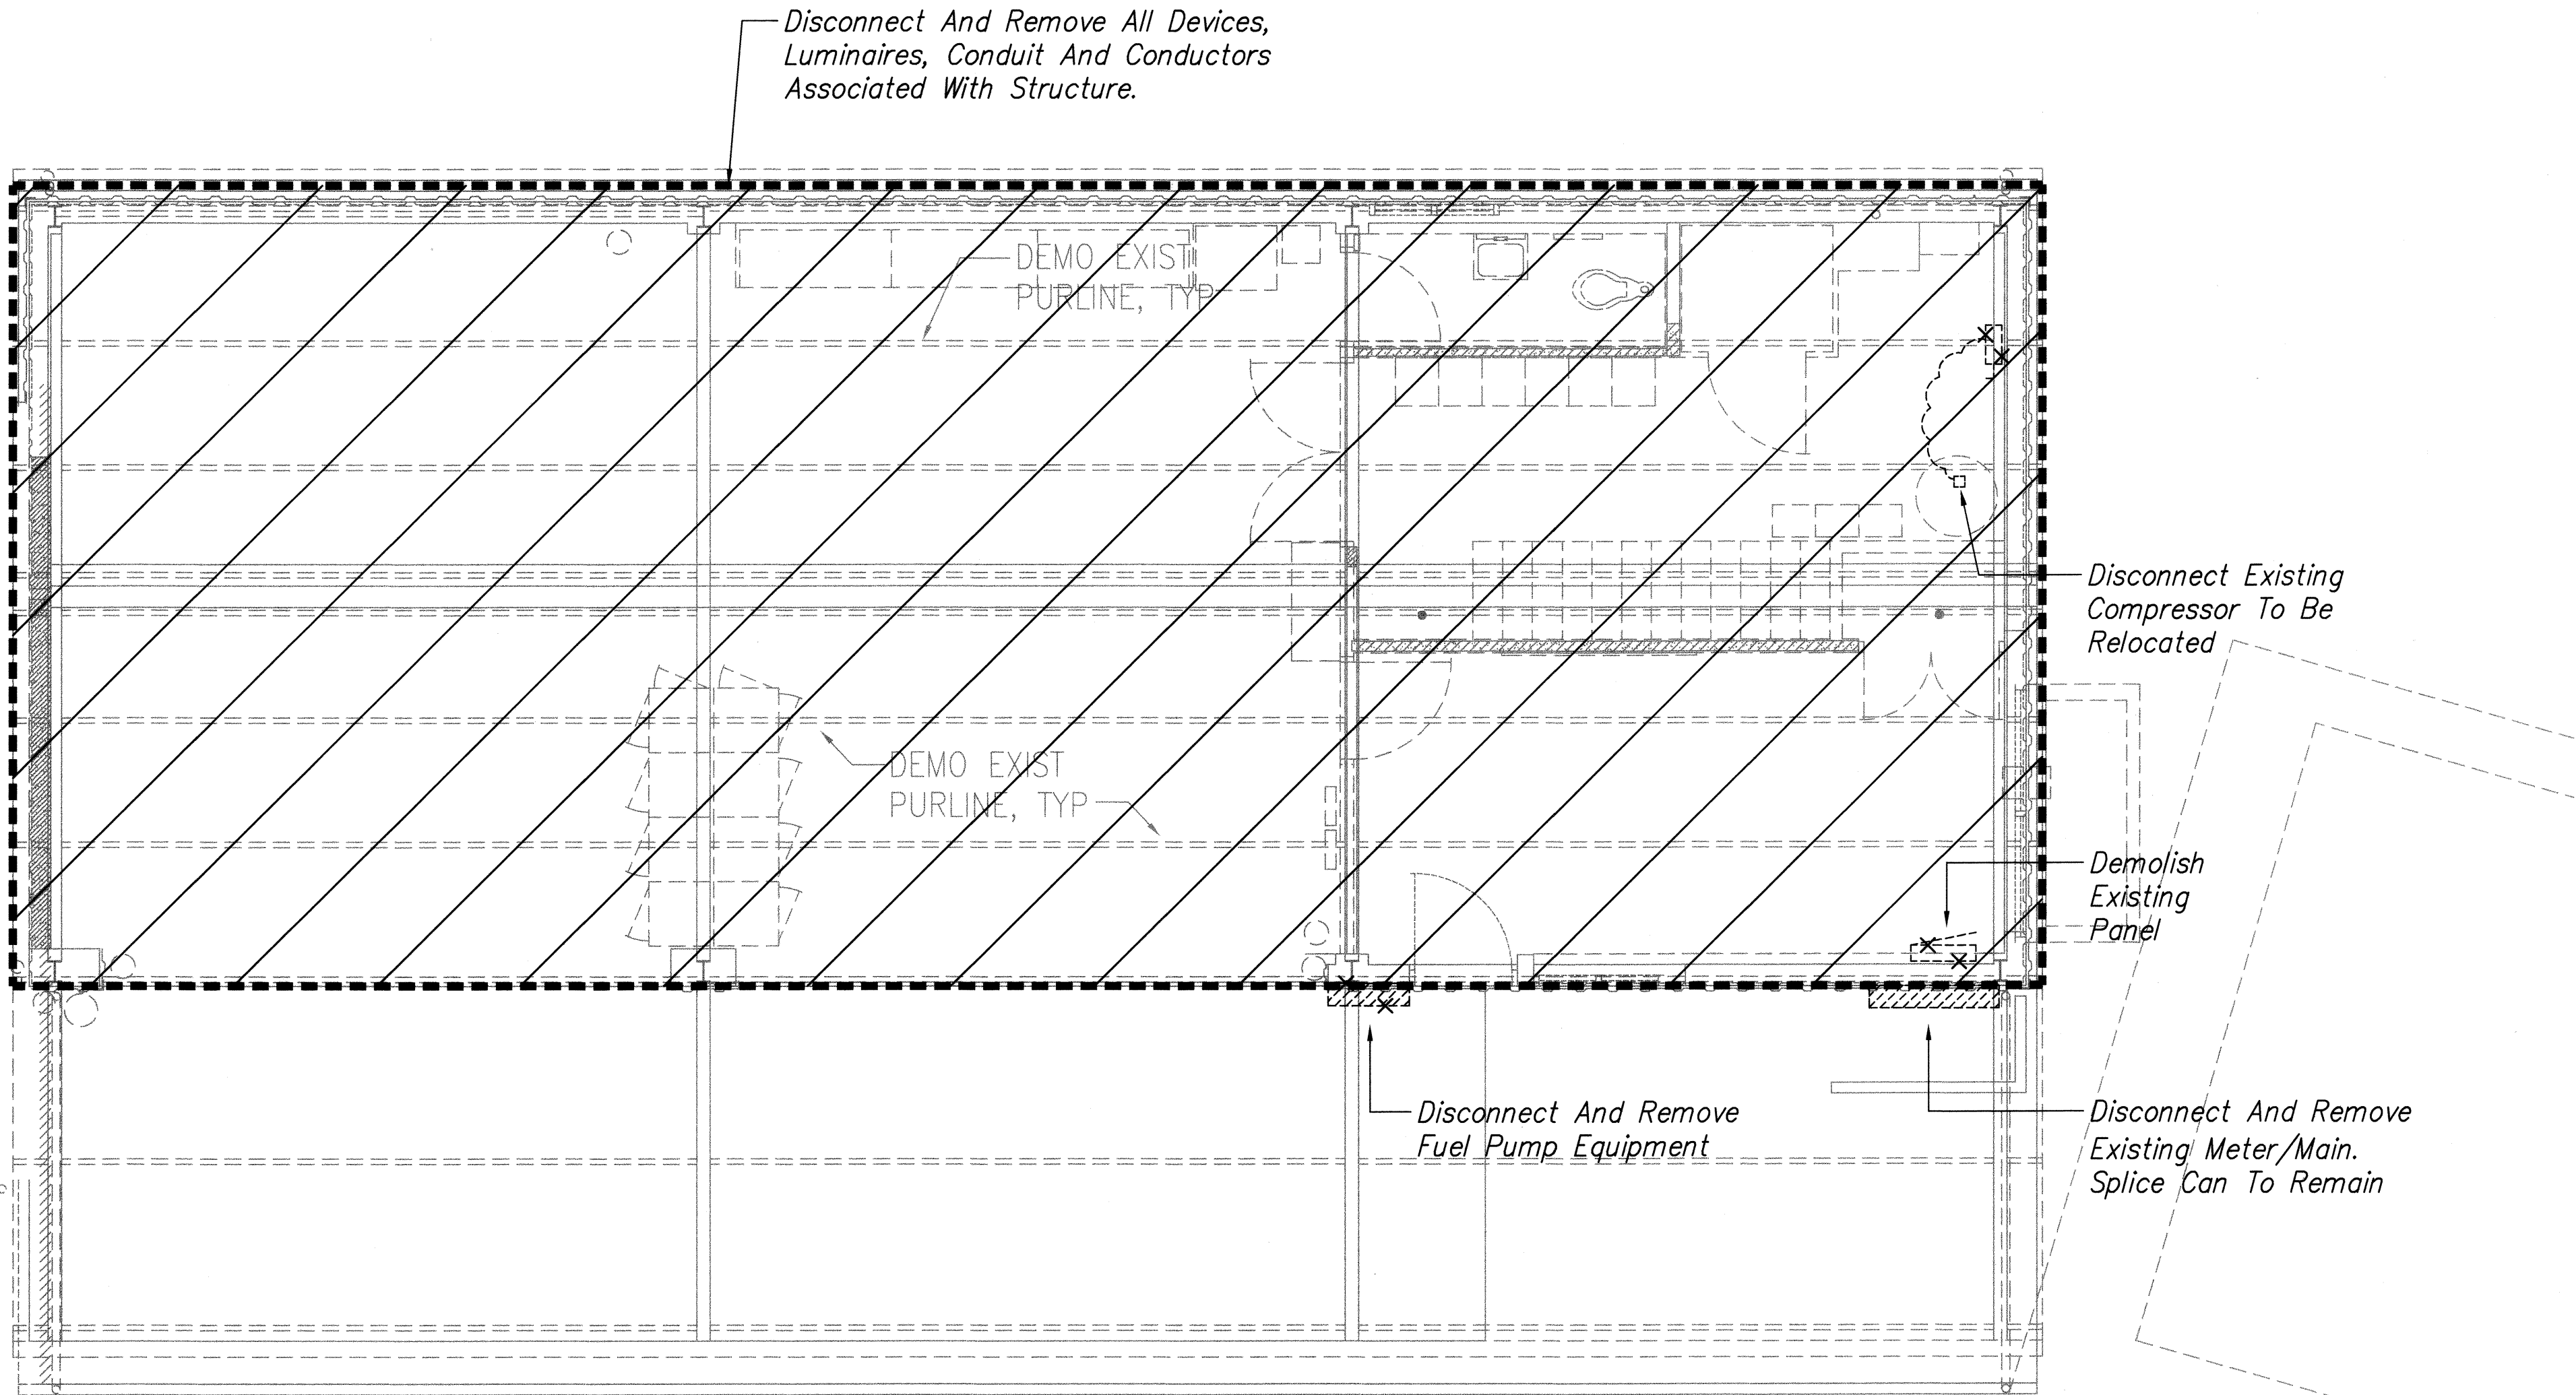


ELECTRICAL DEMOLITION PLAN

Scale: 1/4"= 1'-0"

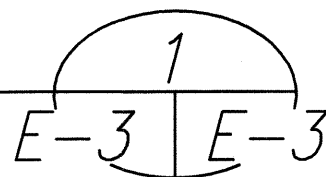

GRAPHIC SCALE:

 

SCALE: 1/4"= 1'-0"



THIS WORK WAS PREPARED BY ME OR UNDER MY SUPERVISION.

Lennox K. Nishimura
PROJECT ENGINEER for ECS, Inc.
APRIL 30, 2010
EXPIRATION DATE OF THE LICENSE

STATE OF HAWAII
DEPARTMENT OF TRANSPORTATION
HIGHWAYS DIVISION

ELECTRICAL DEMOLITION PLAN

HONOKAA BASEYARD IMPROVEMENTS

Project No. HWY-H-05-06


Scale: As Noted Date: MAY 2008

SHEET No. E-3 OF E-7 SHEETS


ORIGINAL PLAN	SURVEY PLOTTED BY	DATE
NOTE BOOK	DRAWN BY	4/08
	DESIGNED BY	4/08
	CHECKED BY	4/08

5/9/08-13:39 Y:\087\087134\87-134-E03.dwg

FED. ROAD DIST. NO.	STATE	PROJ. NO.	FISCAL YEAR	SHEET NO.	TOTAL SHEETS
HAWAII	HAW.	HWY-H-05-06	2008	59	64


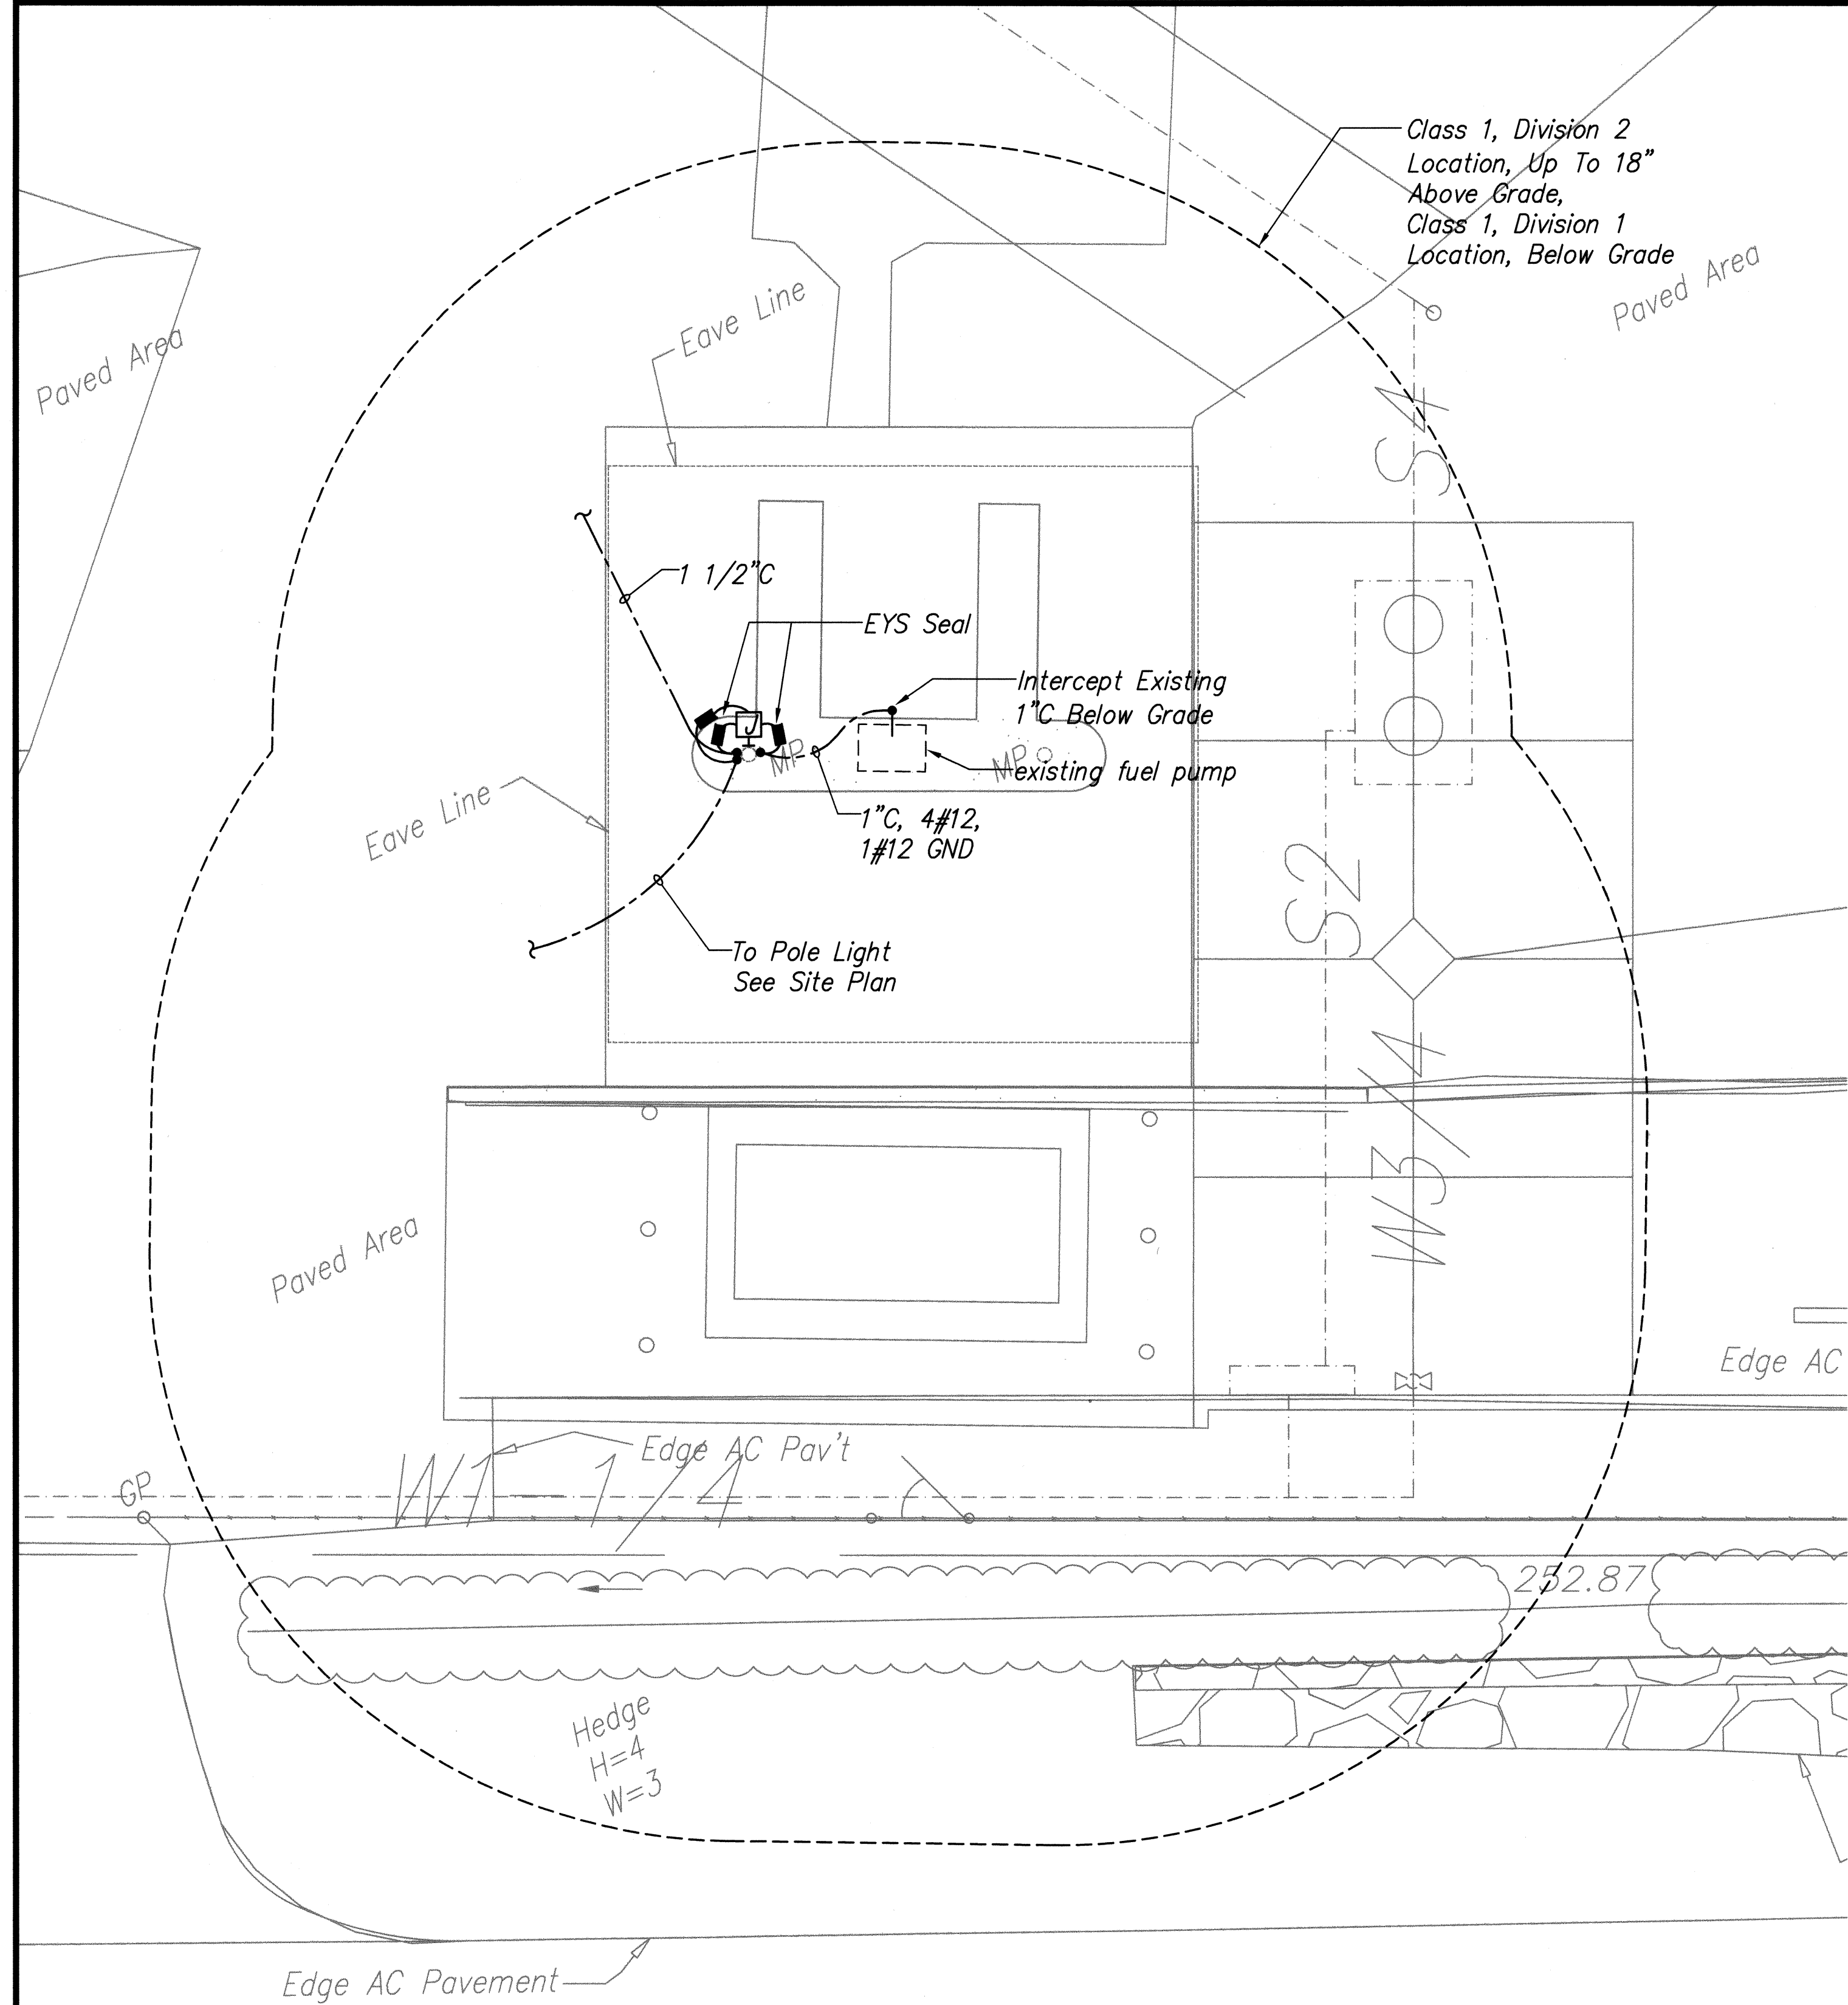


FUEL DISPENSER POWER PLAN
 Scale: 1/4" = 1'-0"
 E-6 | 1 | E-6

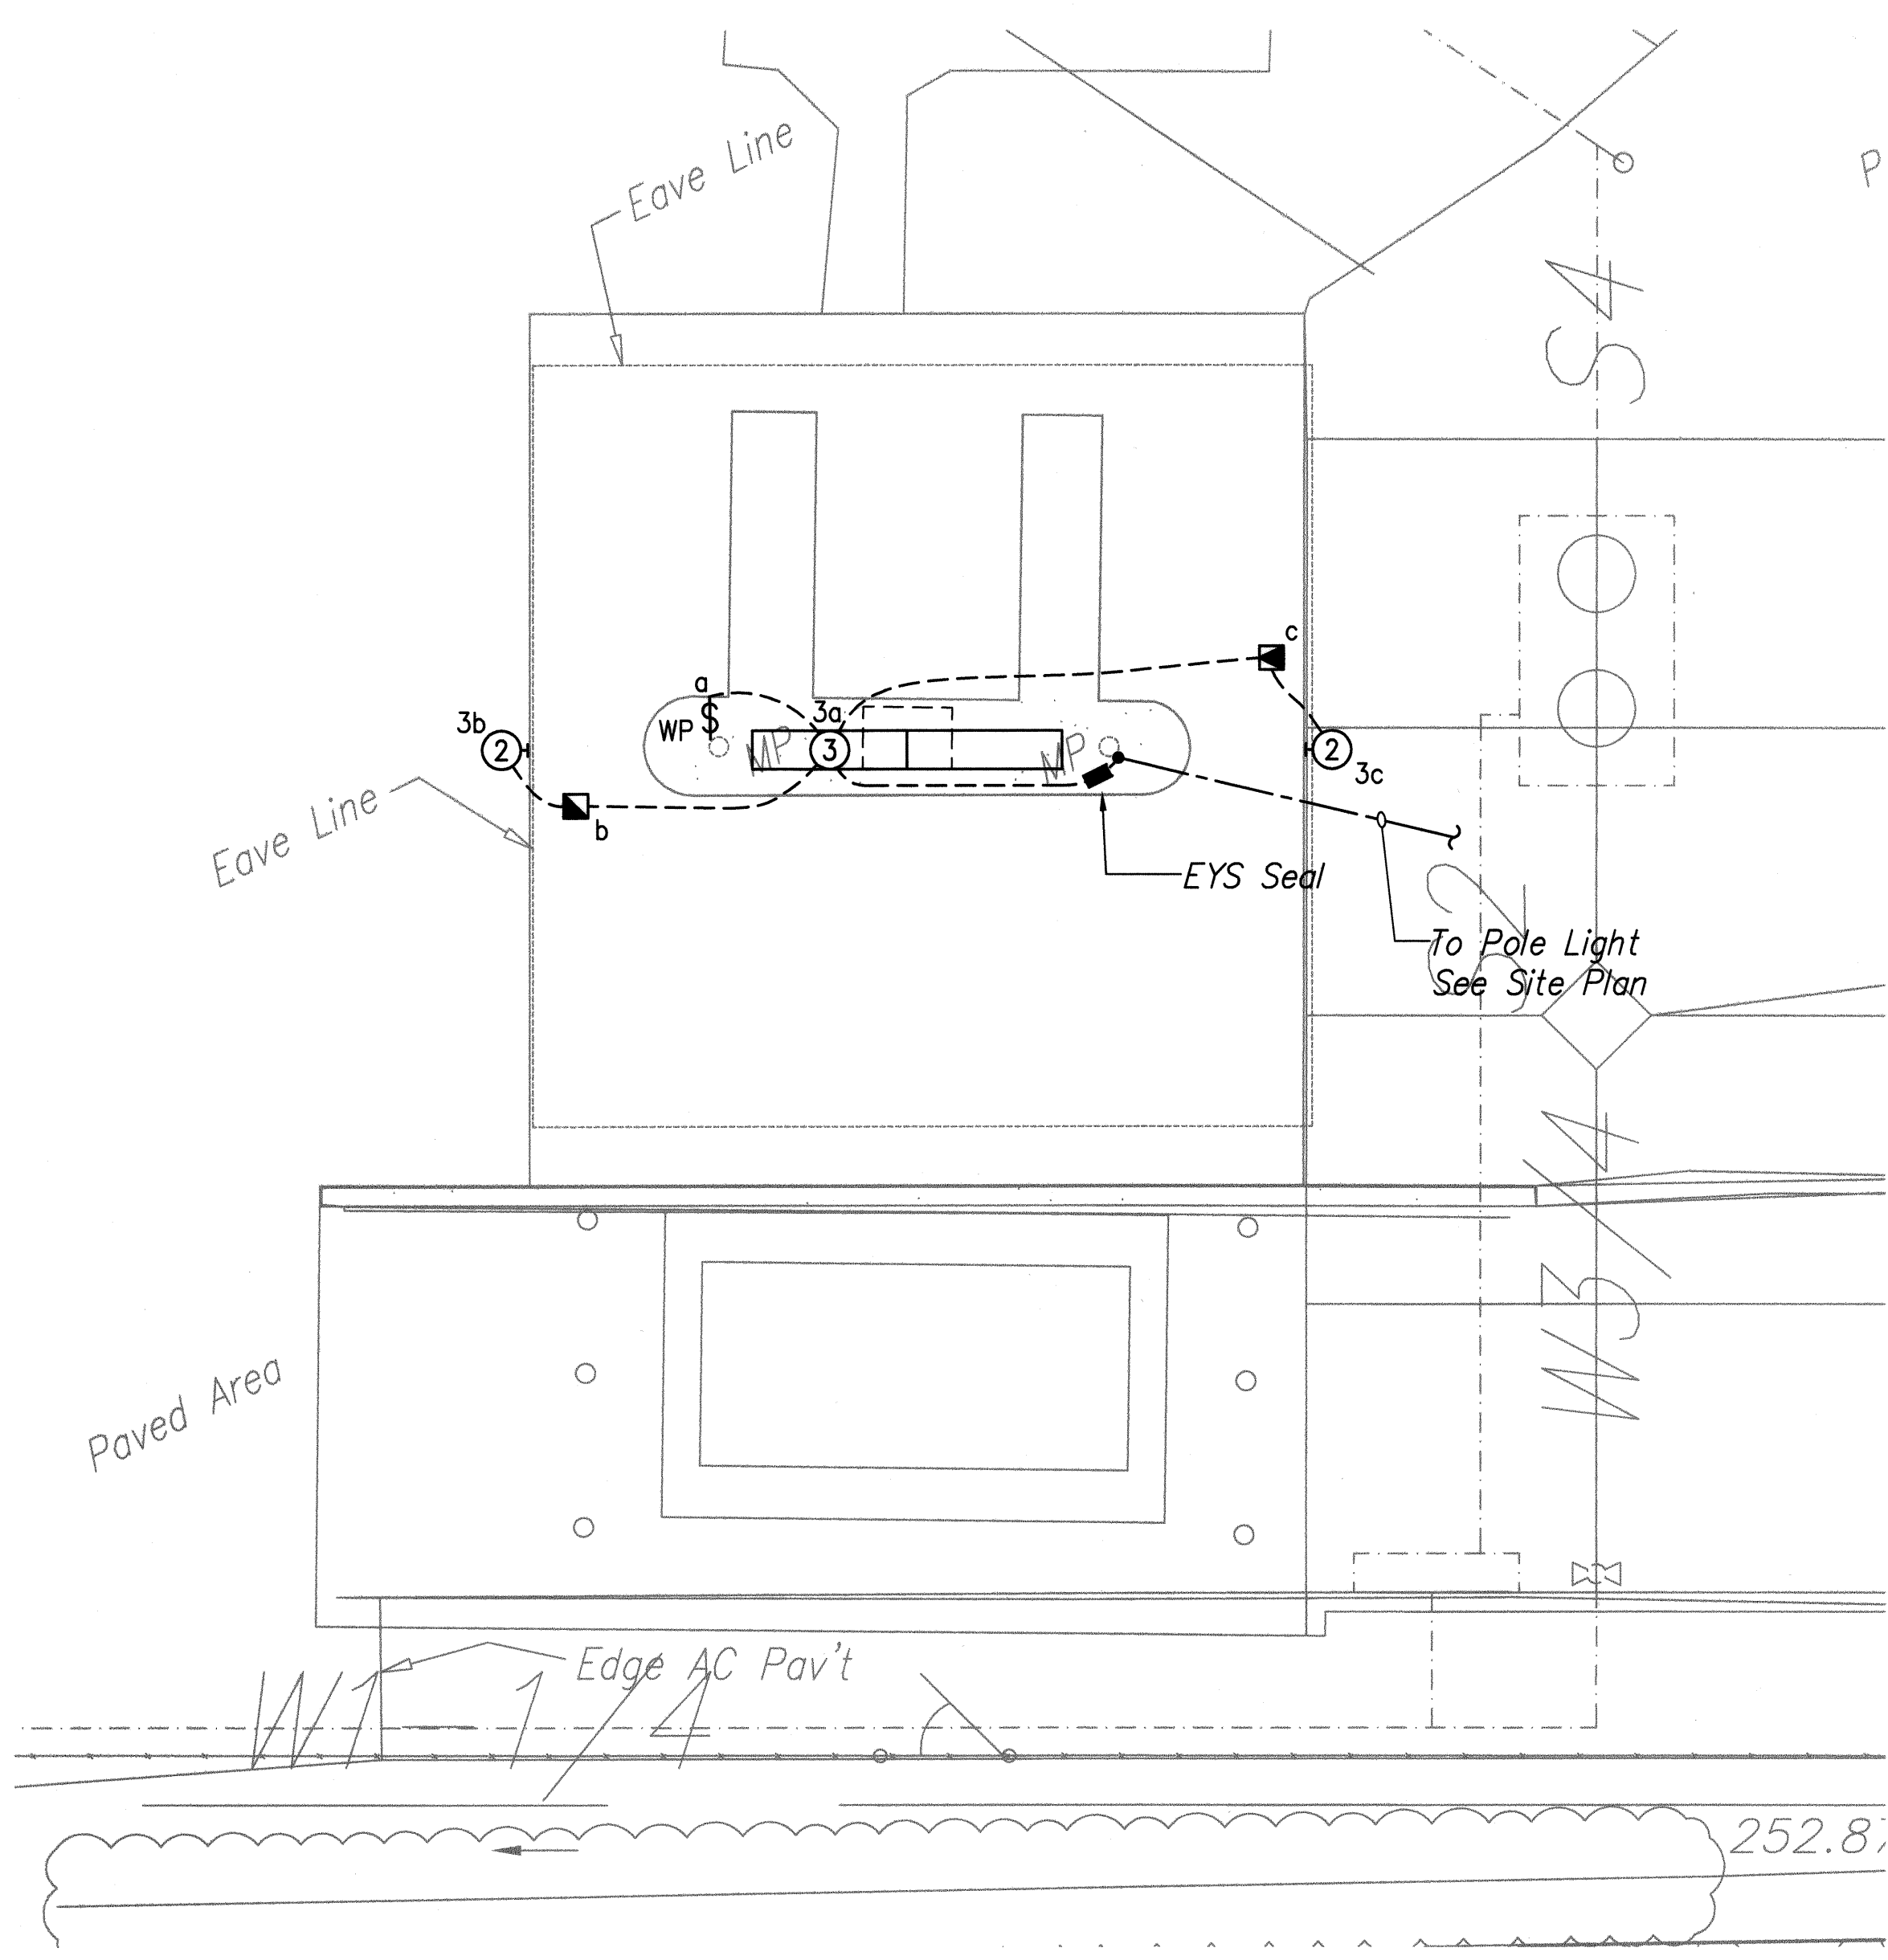

FUEL DISPENSER LIGHTING PLAN
 Scale: 1/4" = 1'-0"
 E-6 | 2 | E-6

GRAPHIC SCALE:

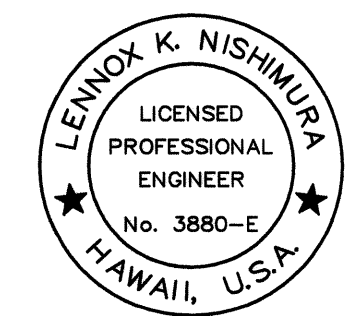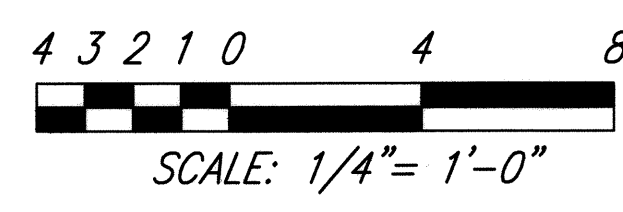

THIS WORK WAS PREPARED BY ME OR UNDER MY SUPERVISION.

Lennox K. Nishimura
 PROJECT ENGINEER for ECS, Inc.
 APRIL 30, 2010
 EXPIRATION DATE OF THE LICENSE

STATE OF HAWAII
DEPARTMENT OF TRANSPORTATION
HIGHWAYS DIVISION

**FUEL DISPENSER
ELECTRICAL PLANS**

HONOKAA BASEYARD IMPROVEMENTS

Project No. HWY-H-05-06

Scale: As Noted Date: MAY 2008

SHEET No. E-6 OF E-7 SHEETS

ORIGINAL PLAN	DATE
NO. 1	4/06
NO. 2	4/06
NO. 3	4/06
NO. 64	4/06

5/9/08-13:38 Y:\087\087134\87-104-E06.dwg

