
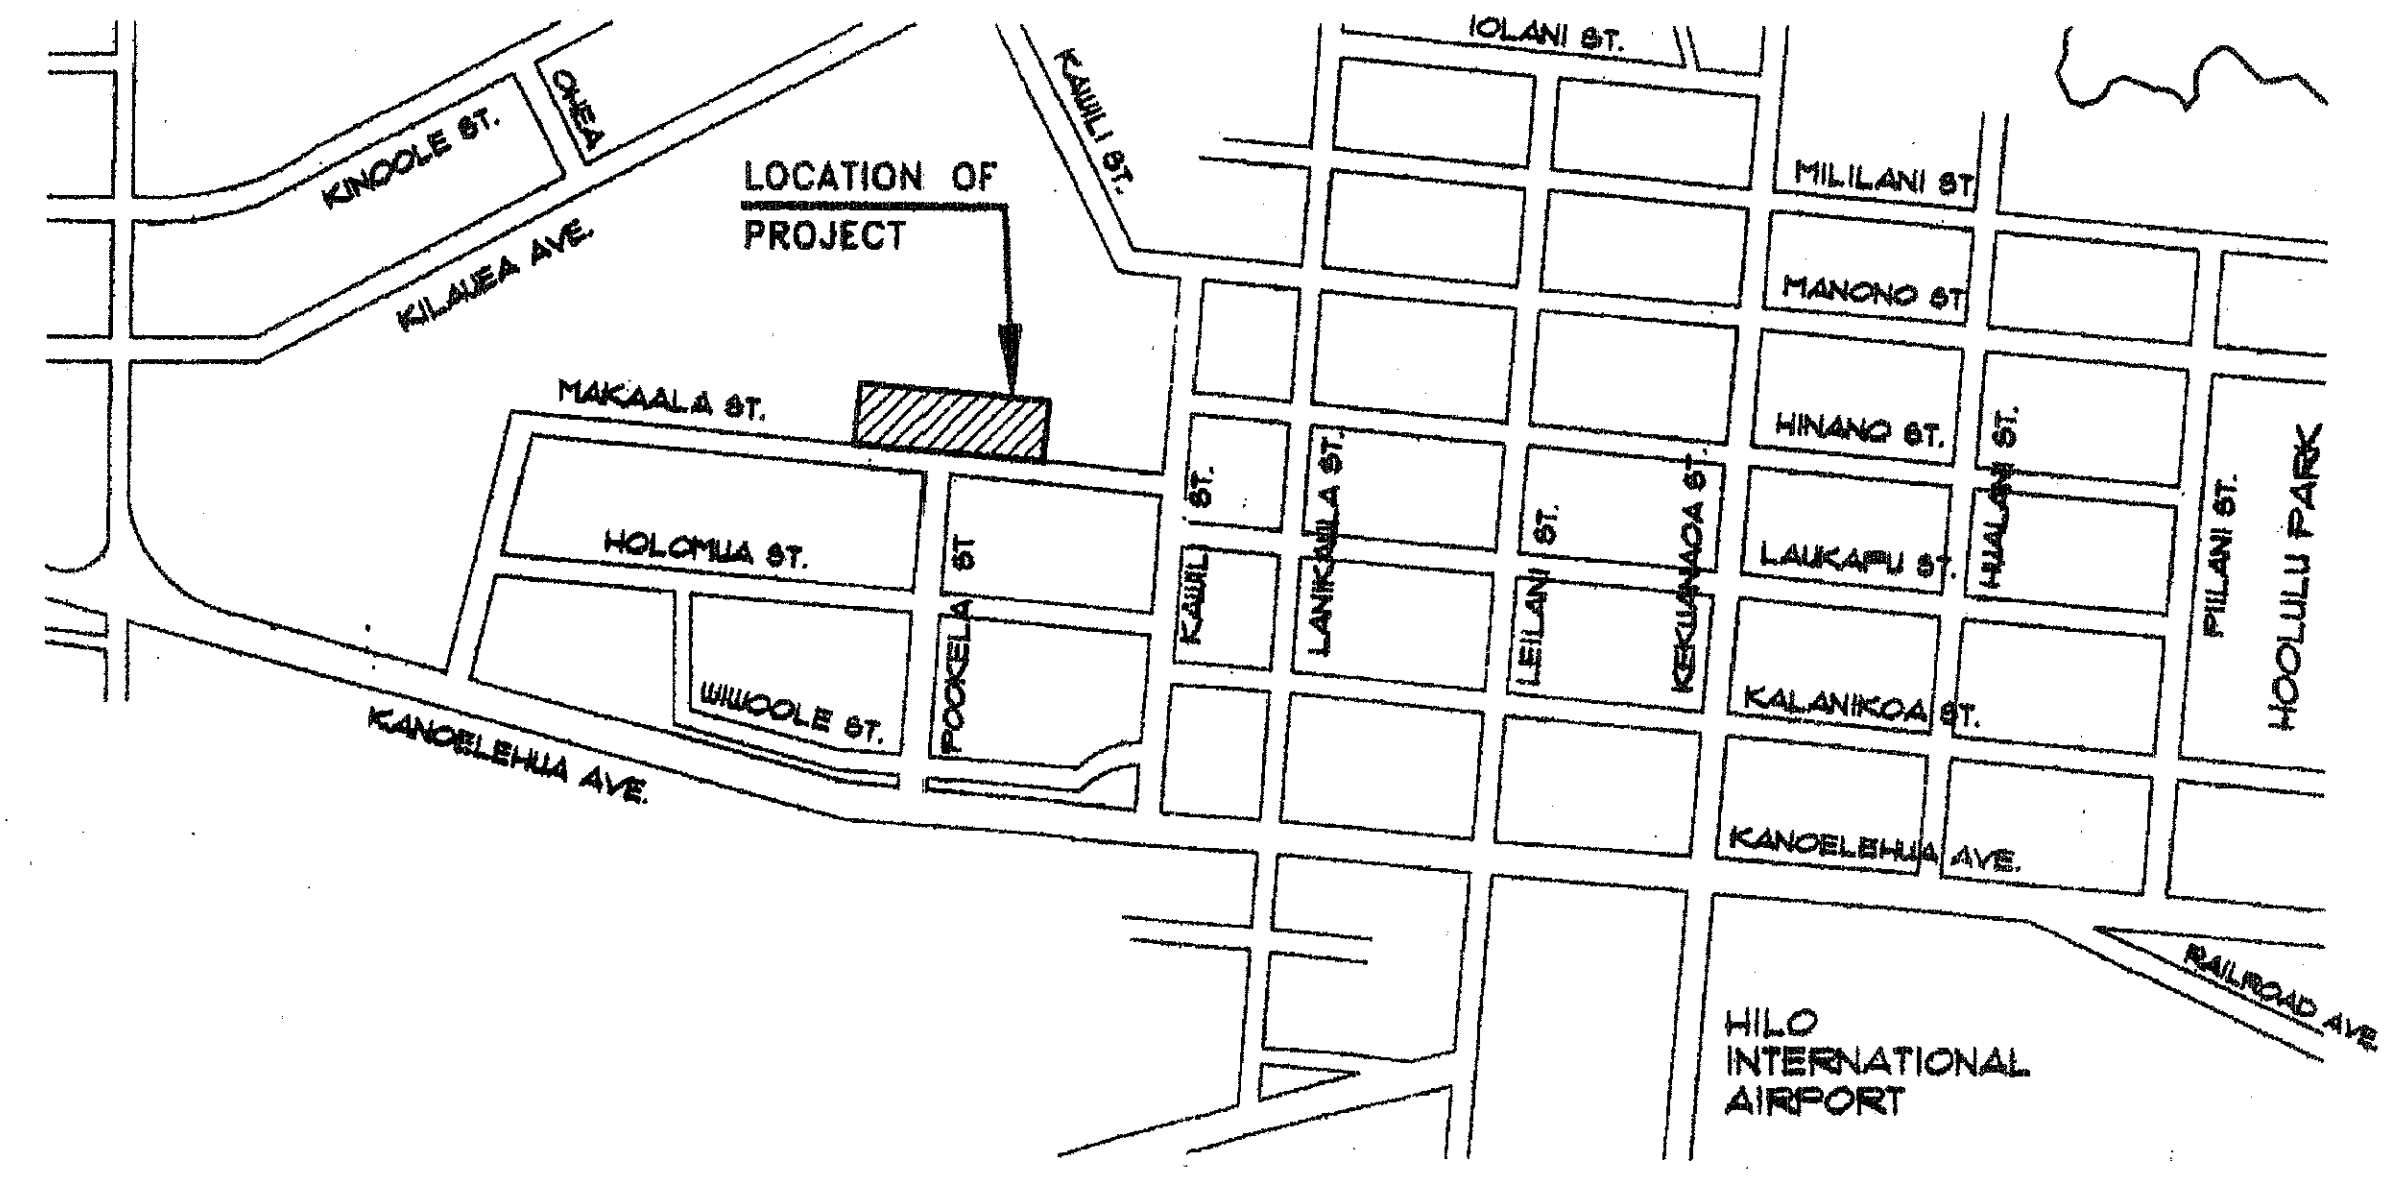
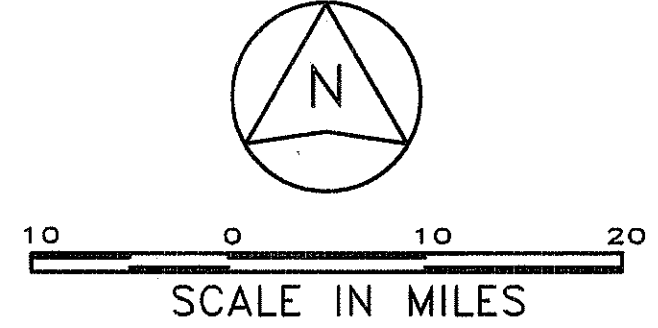
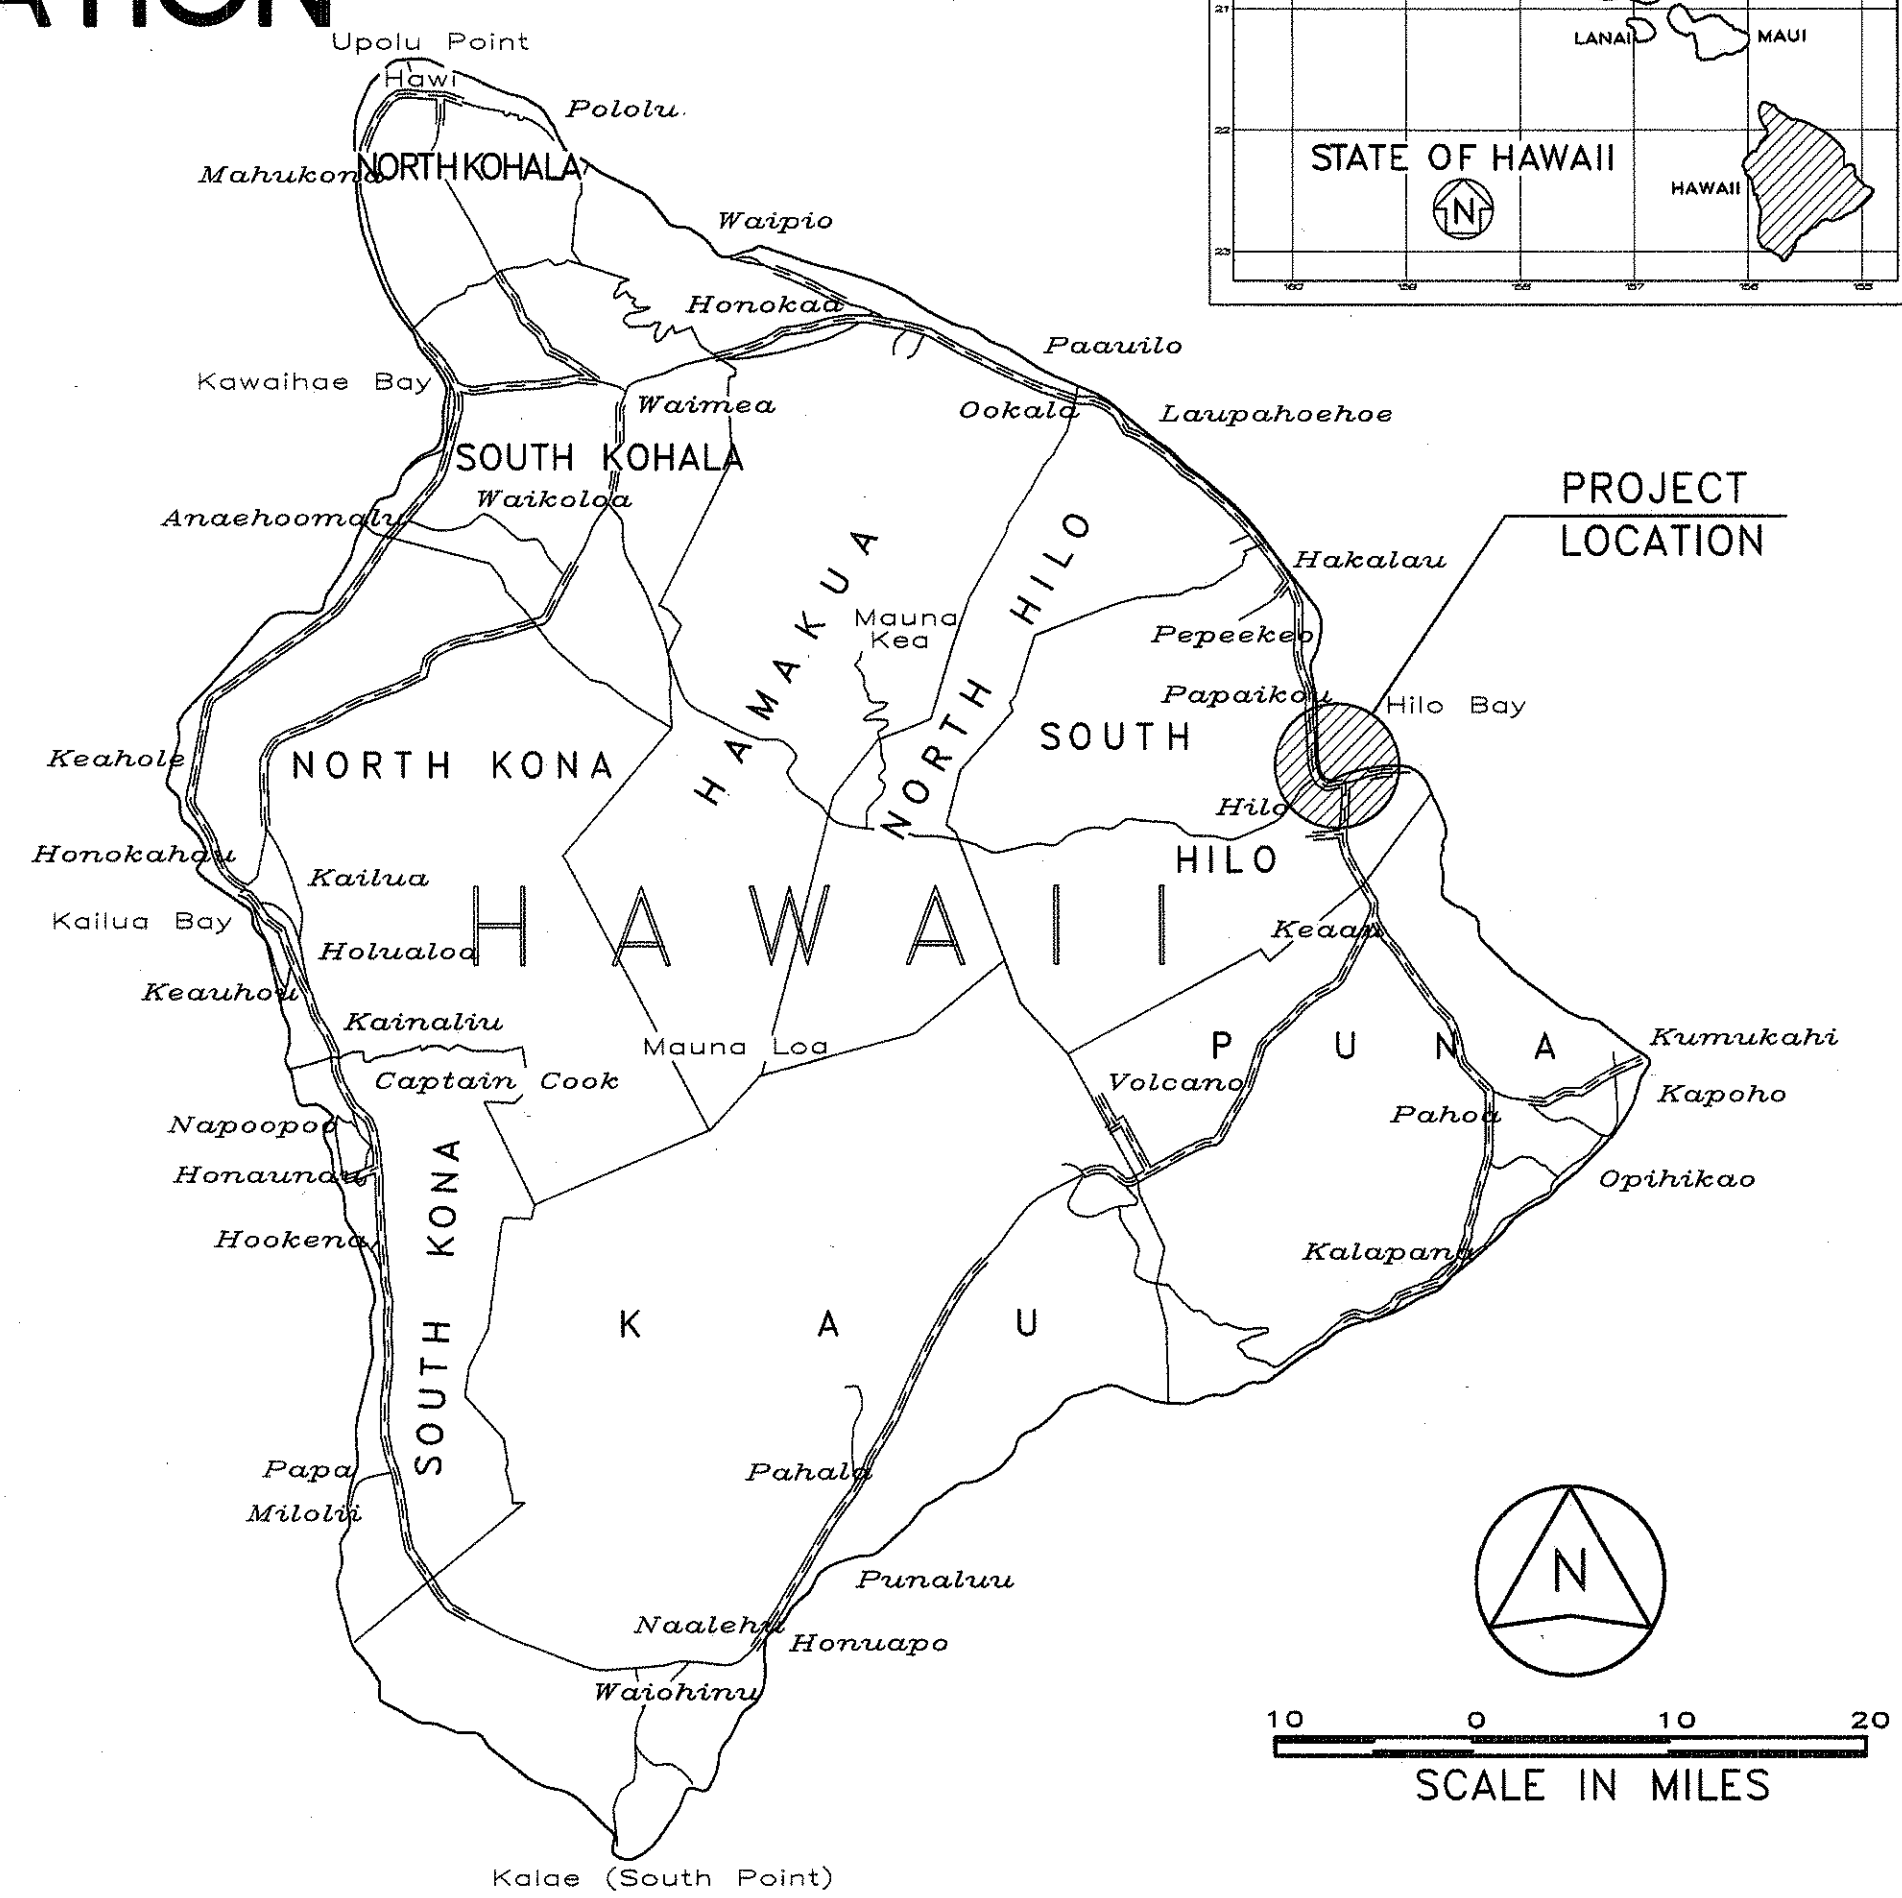


INDEX TO DRAWINGS	
SHEET NO.	DESCRIPTION
1	TITLE SHEET
2	SITE PLAN
3	GEN. NOTES, BLDG. "D" - EXIST./DEMO PLAN
4	BLDG. "D" - TOILET FLOOR PLAN NEW WORK
5	BLDG. "D" - TOILET INTERIOR ELEVATIONS
6	BLDG. "D" - HANDRAIL ELEVATIONS
7	MVSO - DEMOLITION PLAN
8	MVSO - NEW RAMP PLAN
9	MVSO - NEW RAMP FOUNDATION/FRAMING PLAN
10	MVSO - RAMP SECTIONS
11	MVSO - RAMP SECTIONS
12	MVSO - STAIR DETAILS
13	MISCELLANEOUS DETAILS
14	FINISH SCHEDULE, PAINTING SPECIFICATIONS
15	GENERAL NOTES & LEGEND
16	PLUMBING DEMO. & NEW WORK PLANS & KEY NOTES
17	PLUMBING FIXTURE SCHEDULE & DIAGRAMS

STATE OF HAWAII
DEPARTMENT OF TRANSPORTATION
HIGHWAYS DIVISION
HONOLULU, HAWAII
"AS-BUILT"
PLANS FOR
HILO BASEYARD
ADA IMPROVEMENTS
T.M.K. 2-2-50 : 75
PROJECT NO. HWY-H-05-05M
DISTRICT OF SOUTH HILO
ISLAND OF HAWAII

FED. ROAD DIST. NO.	STATE	PROJECT NO.	FISCAL YEAR	SHEET NO.	TOTAL SHEETS
HAWAII	HAWAII	HWY-H-05-05M	2005	1	17

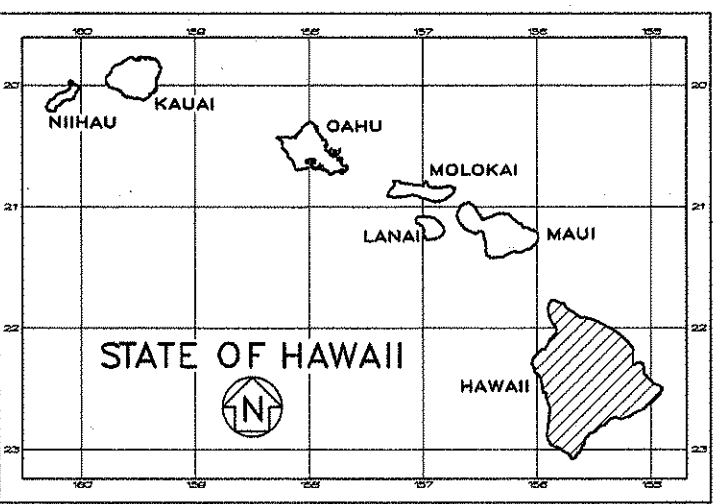

TAX MAP KEY: 2-2-50: 75

LOCATION MAP
(NOT TO SCALE)

LICENSE EXPIRATION DATE: 04/30/06



THIS WORK WAS PREPARED BY
ME OR UNDER MY SUPERVISION

SIGNATURE

CHANGES MADE DURING CONSTRUCTION HAVE BEEN
INCORPORATED ON THESE PLANS AND...
IN THE ORIGINAL THEORETICAL QUANTITIES...
FOR ACTUAL QUANTITIES, REFER TO PROJECT LEDGER
AND/OR CONSTRUCTION BOOK.
3/13/06
DATE

DEPARTMENT OF TRANSPORTATION
STATE OF HAWAII
APPROVED:
3.29.05
DATE

ORIGINAL PLAN
DATE
NO. 1

INK ARCHITECTS, INC.
DESIGNED BY
MANAGED BY
PHONE
JAN. 2005
DATE