

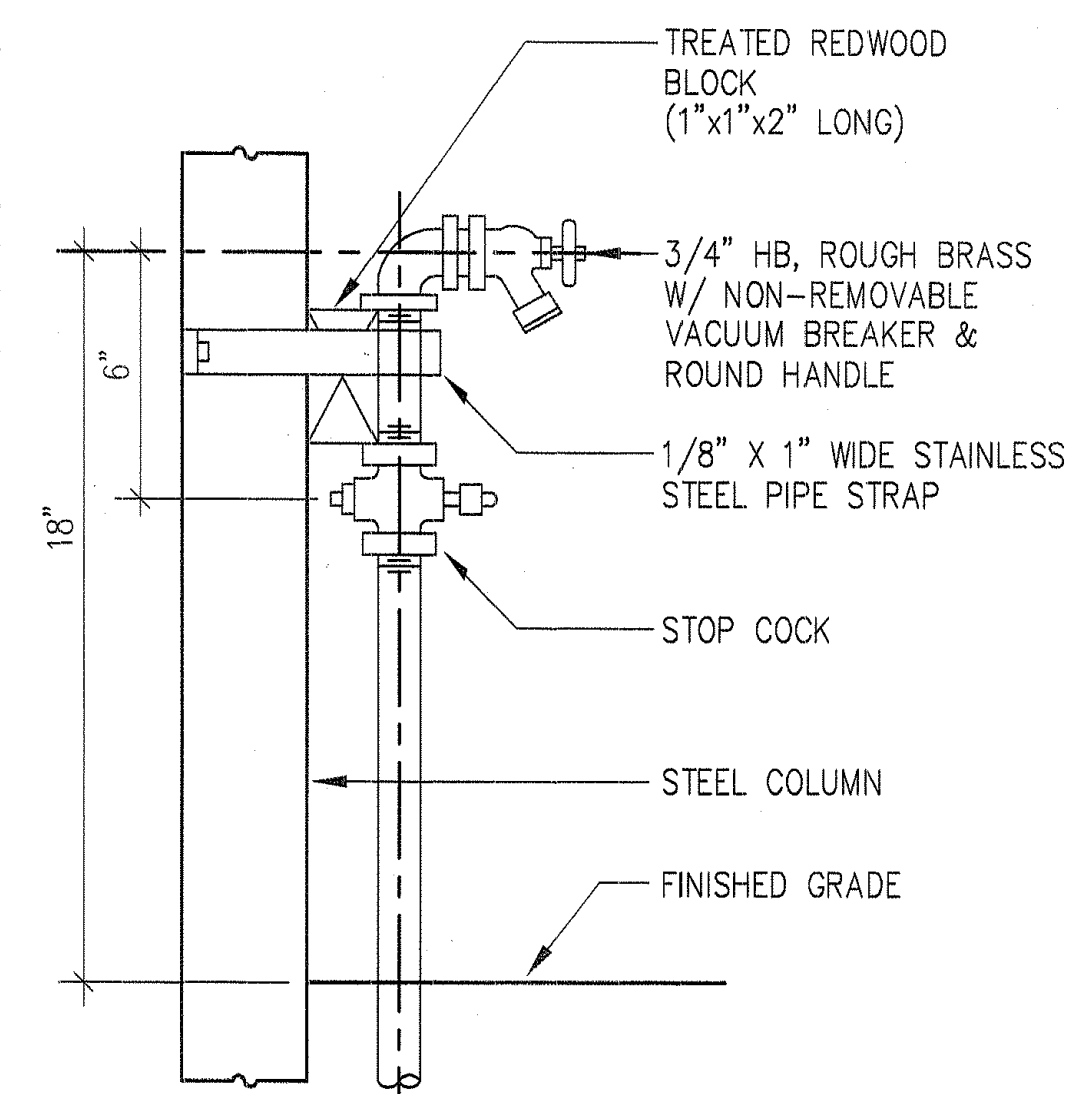


FED. ROAD DIST. NO.	STATE	PROJ. NO.	FISCAL YEAR	SHEET NO.	TOTAL SHEETS
HAWAII	HAW.	HWY-H-03-04M	2005	ADD 25	32

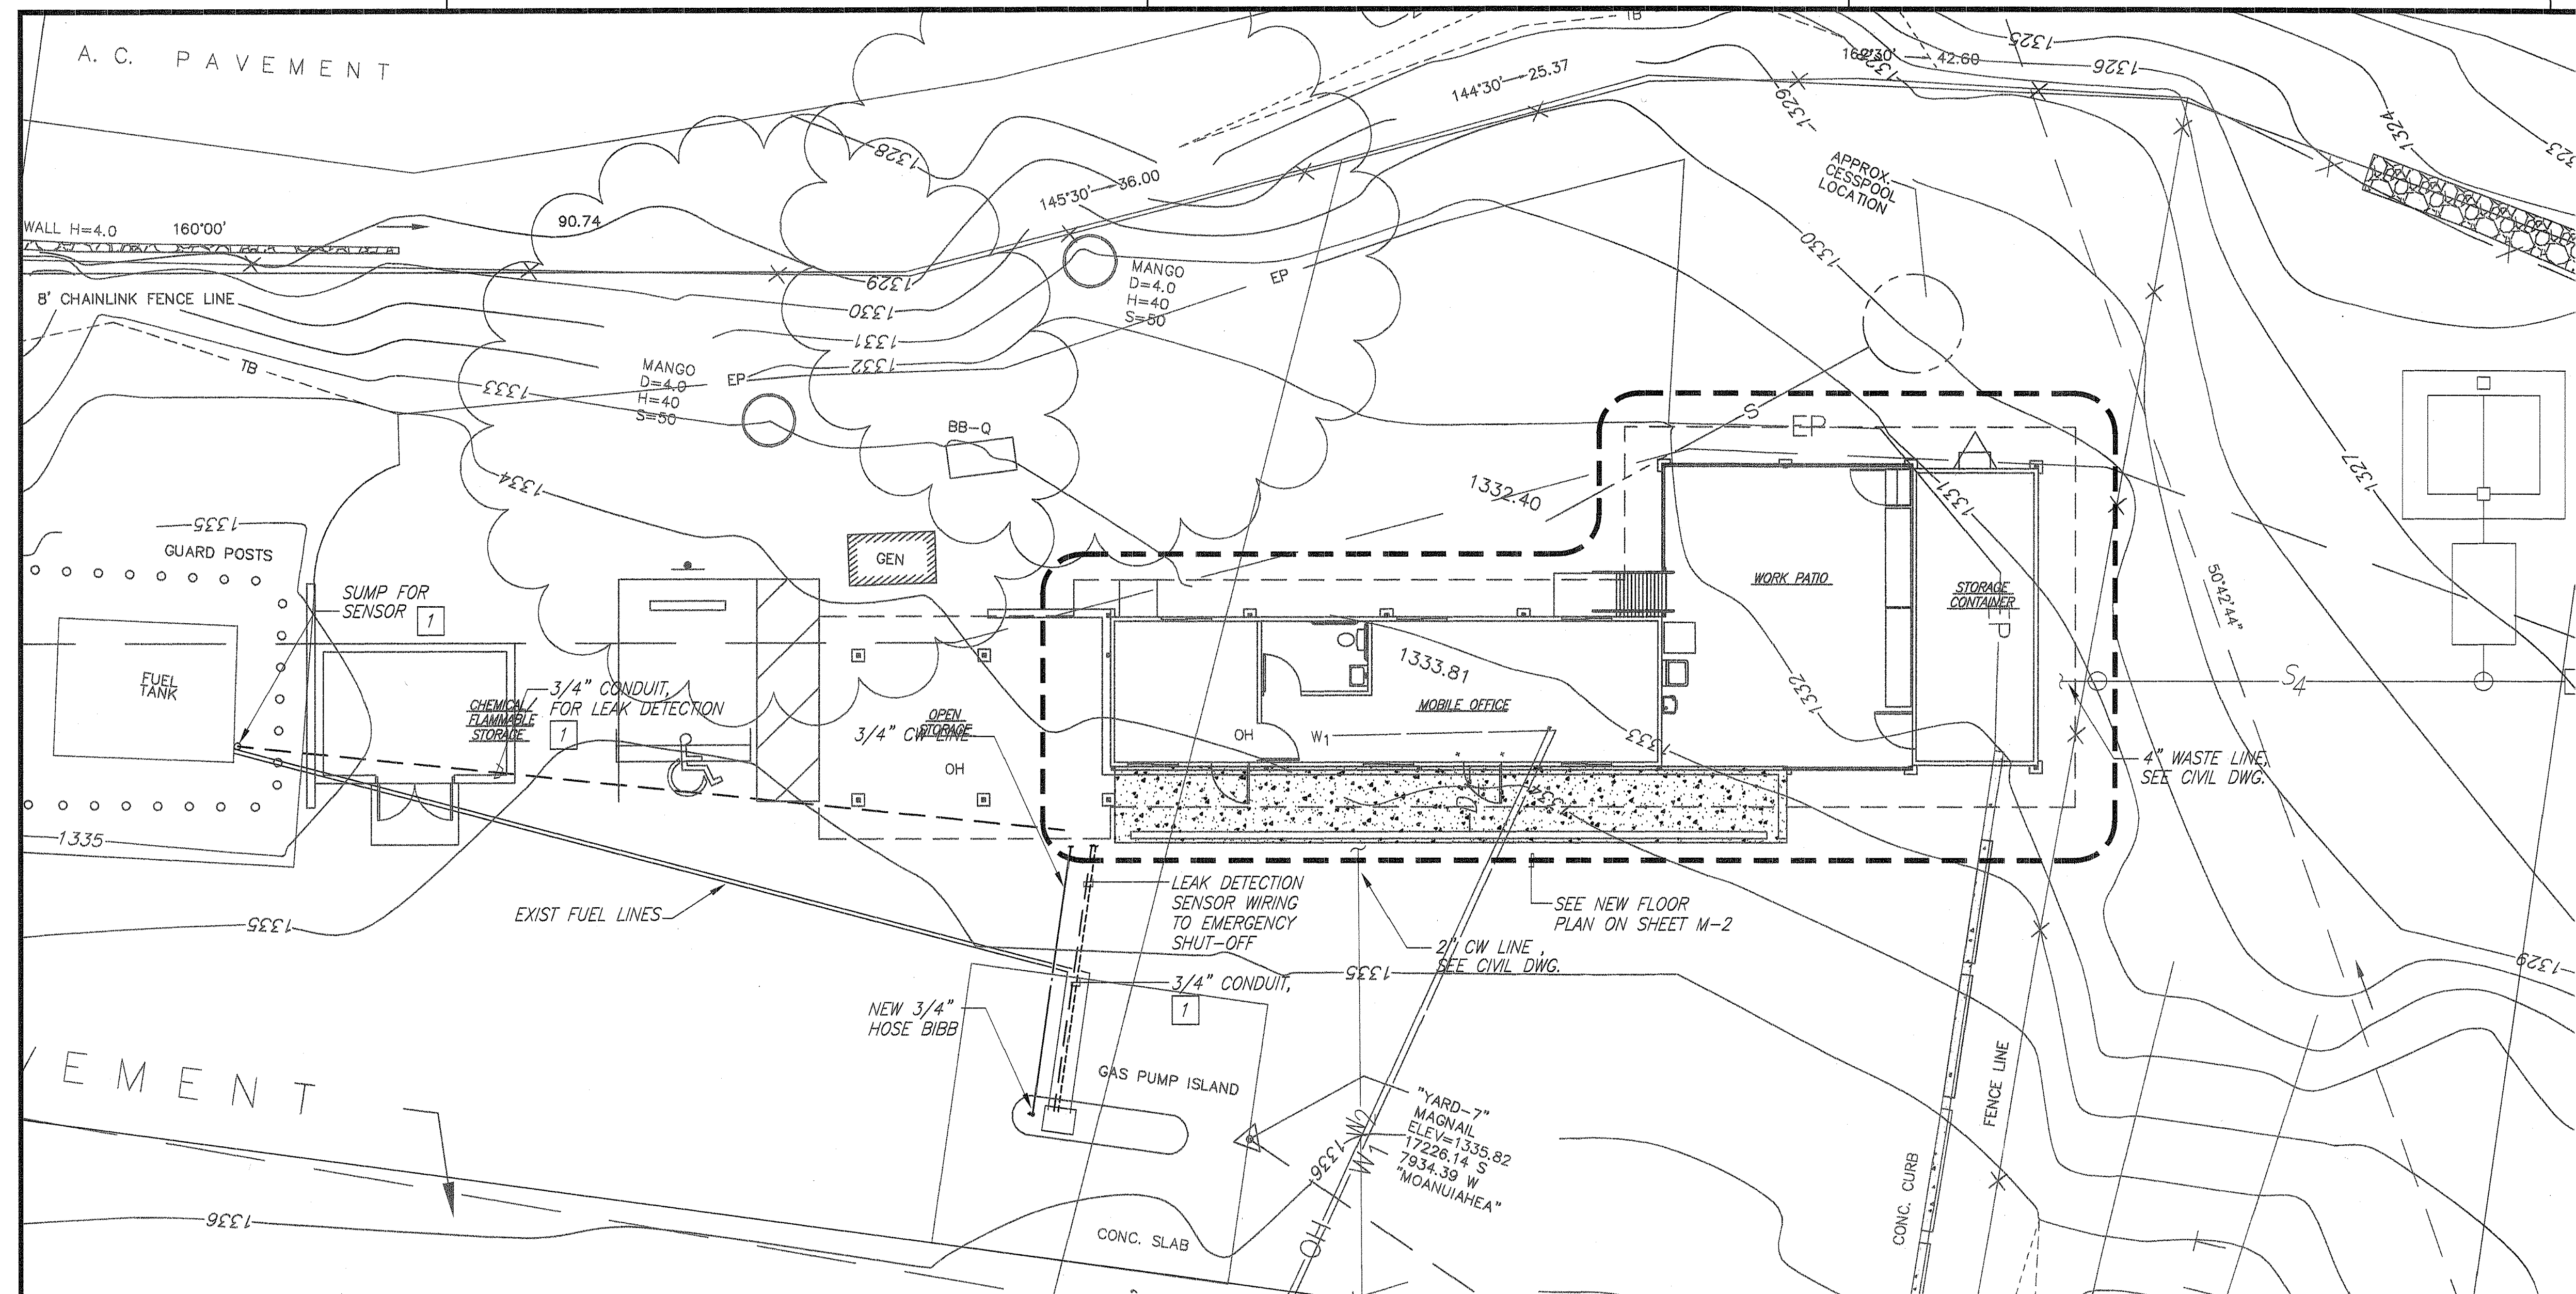


HOSE BIBB-INTERIOR
NOT TO SCALE

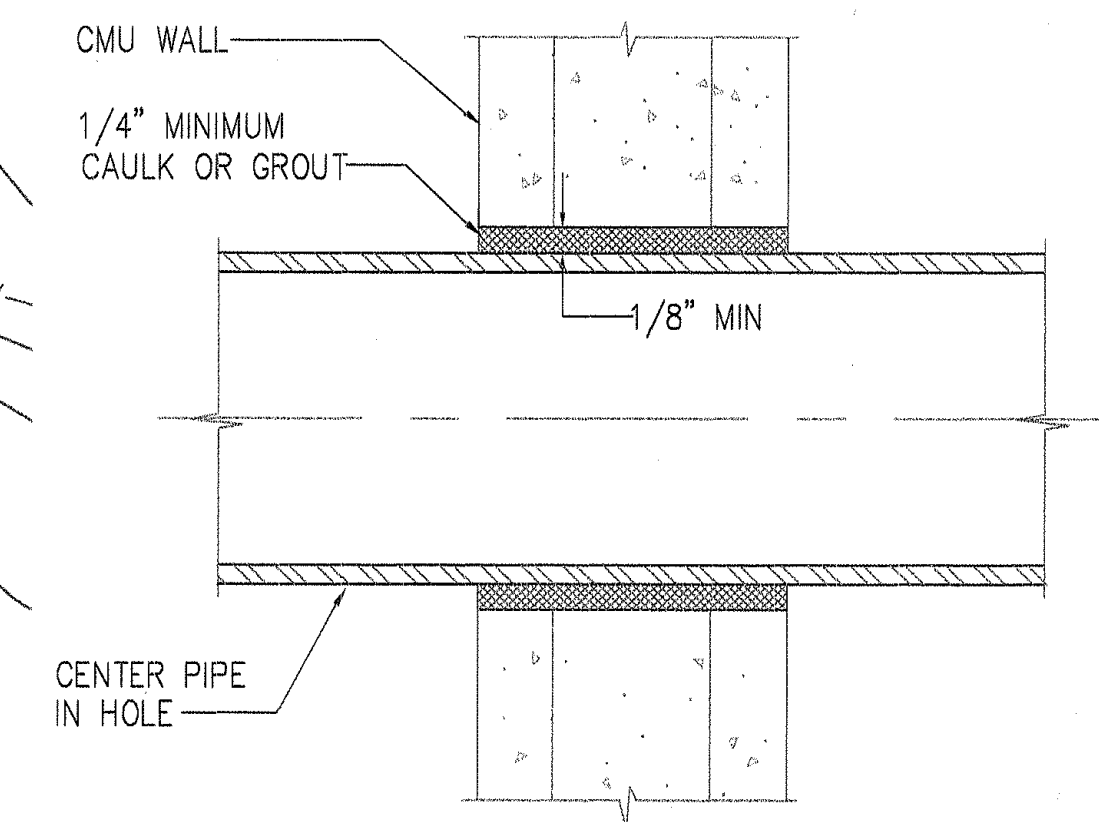

PIPE THRU INTERIOR CMU WALL DETAIL
NOT TO SCALE

NOTE:
PROVIDE LEAK DETECTOR SENSOR AT EXISTING FUEL DISPENSER SUMP. ROUTE SENSOR WIRE BACK TO LEAK DETECTOR MONITOR AT BUILDING. SEE SHEET M-2 FOR LOCATION.

- 1 SCOPE OF WORK FOR LEAK DETECTION SYSTEM:
CONTRACTOR TO PROVIDE DETECTION SUMP AT EXISTING FUEL TANK FOR EXISTING DOUBLE WALL FUEL LINE FOR BOTH GASOLINE AND DIESEL LINES. ROUTE SENSOR WIRE BACK TO LEAK DETECTOR MONITOR AT BUILDING.

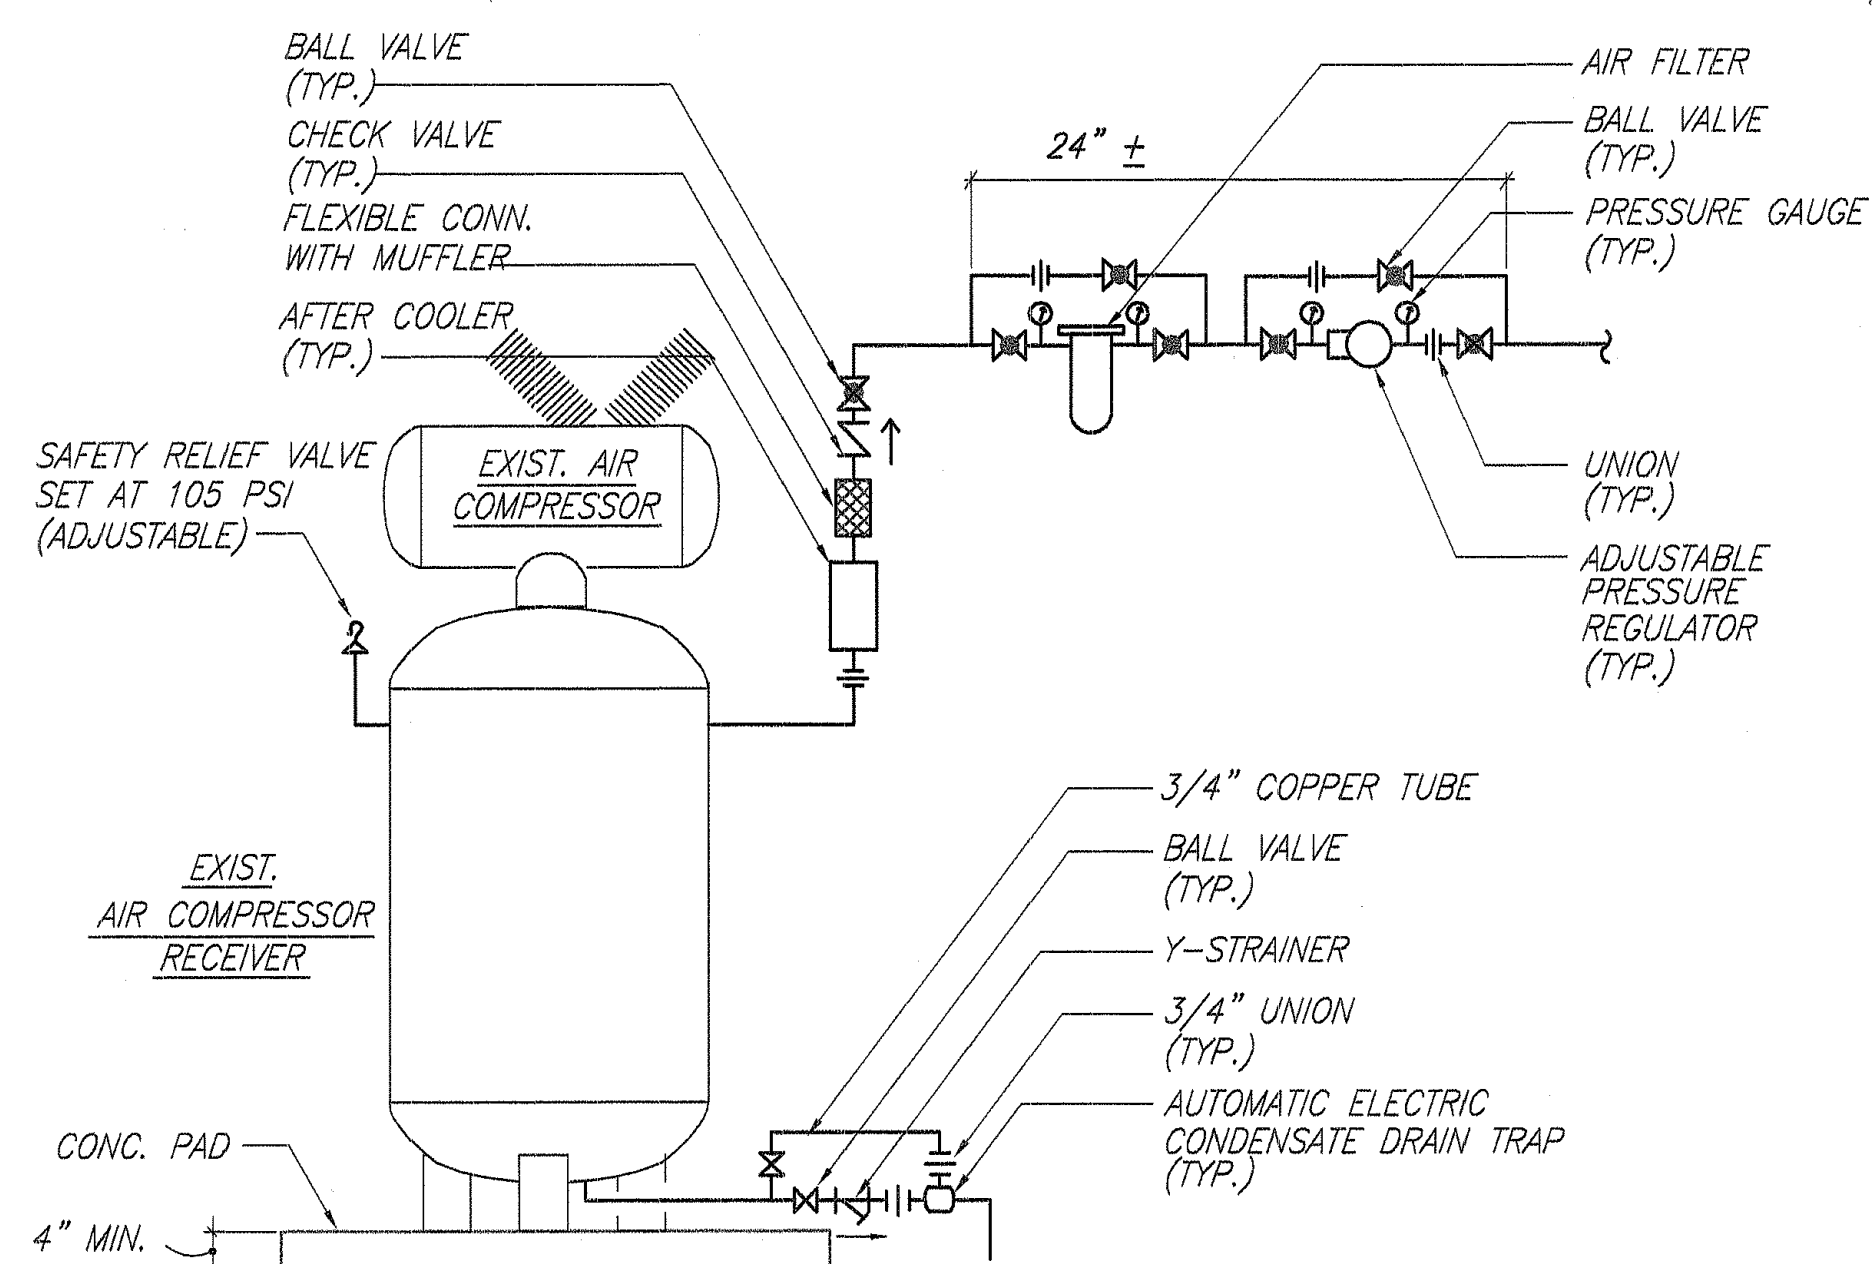

AIR COMPRESSOR PIPING SCHEMATIC
NOT TO SCALE

SURVEY PLOTTED BY	DATE
DRAWN BY	
DESIGNED BY	
CHECKED BY	
ORIGINAL PLAN	
NOTE BOOK	
NO.	

STATE OF HAWAII
DEPARTMENT OF TRANSPORTATION
HIGHWAYS DIVISION
MECHANICAL SITE PLAN
NORTH KONA BASEYARD RENOVATIONS
REMOVE LEAD PAINT AND
UPGRADE ELECTRICAL
Project No. HWY-H-03-04M
Scale: As Noted Date: 6/9/05
SHEET No. M-1 OF M-2 SHEETS

