


FED. ROAD DIST. NO.	STATE	PROJ. NO.	FISCAL YEAR	SHEET NO.	TOTAL SHEETS
HAWAII	HAW.	HWY-H-03-04M	2005	ADD. 1	32

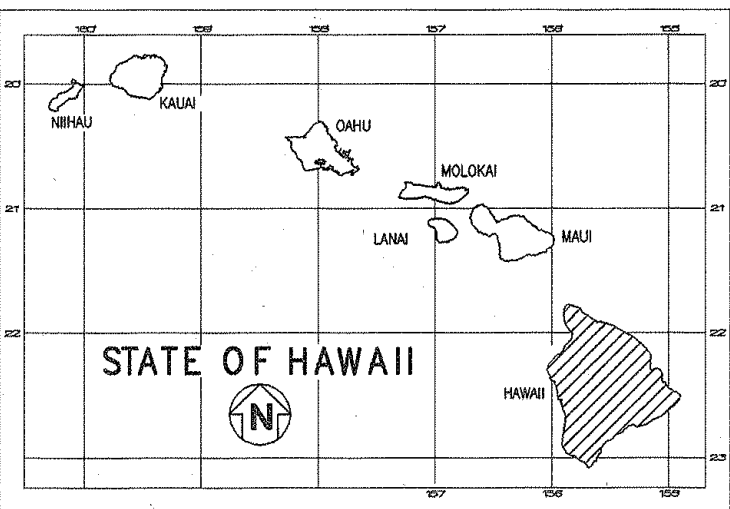

STATE OF HAWAII
DEPARTMENT OF TRANSPORTATION
HIGHWAYS DIVISION
HONOLULU, HAWAII

PLANS FOR
NORTH KONA BASEYARD RENOVATIONS
REMOVE LEAD PAINT and UPGRADE ELECTRICAL
PROJECT NO. HWY-H-03-04M
DISTRICT OF NORTH KONA
ISLAND OF HAWAII


1

OVERALL SHT NO.	SHEET NO. BY DISCIPLINE	INDEX TO DRAWINGS
		DESCRIPTION
1	T-1	TITLE SHEET
2	T-2	GENERAL NOTES
3	C-1	WATER POLLUTION AND EROSION CONTROL NOTES
4	C-2	GENERAL SITE PLAN
5	C-3	DEMOLITION PLAN
6	C-4	SITE AND UTILITY PLAN
7	C-5	GRADING PLAN
8	C-6	PROFILES AND CROSS SECTIONS
9	C-7	SEWERAGE DETAILS
10	C-8	MISCELLANEOUS DETAILS - 1
11	C-9	MISCELLANEOUS DETAILS - 2
12	A-1	BUILDING FLOOR PLAN
13	A-2	EXTERIOR ELEVATIONS
14	A-3	BUILDING SECTIONS
15	A-4	ROOF PLANS
16	A-5	ROOF AND WORK BENCH DETAILS
17	A-6	MISCELLANEOUS DETAILS
18	S-1	GENERAL NOTES
19	S-2	GENERAL NOTES
20	S-3	FOUNDATION PLAN
21	S-4	FLOOR FRAMING PLAN
22	S-5	ROOF FRAMING PLAN
23	S-6	SLAB-ON-GRADE and FOUNDATION DETAILS
24	S-7	ROOF and FLOOR FRAMING DETAILS
25	M-1	MECHANICAL SITE PLAN
26	M-2	NEW FLOOR PLAN
27	E-1	ELECTRICAL SYMBOL LIST & LUMINAIRE SCHEDULE
28	E-2	ELECTRICAL DEMOLITION PLAN
29	E-3	ELECTRICAL SITE PLAN
30	E-4	ELECTRICAL PLAN - NEW WORK
31	E-5	FUEL DISPENSER ELECTRICAL PLANS
32	E-6	MISCELLANEOUS DETAILS


933-8866 APR. 2005
PHONE DATE

HWY-H
DESIGNED BY P. S. & E. BY



MITSUNAGA & ASSOCIATES

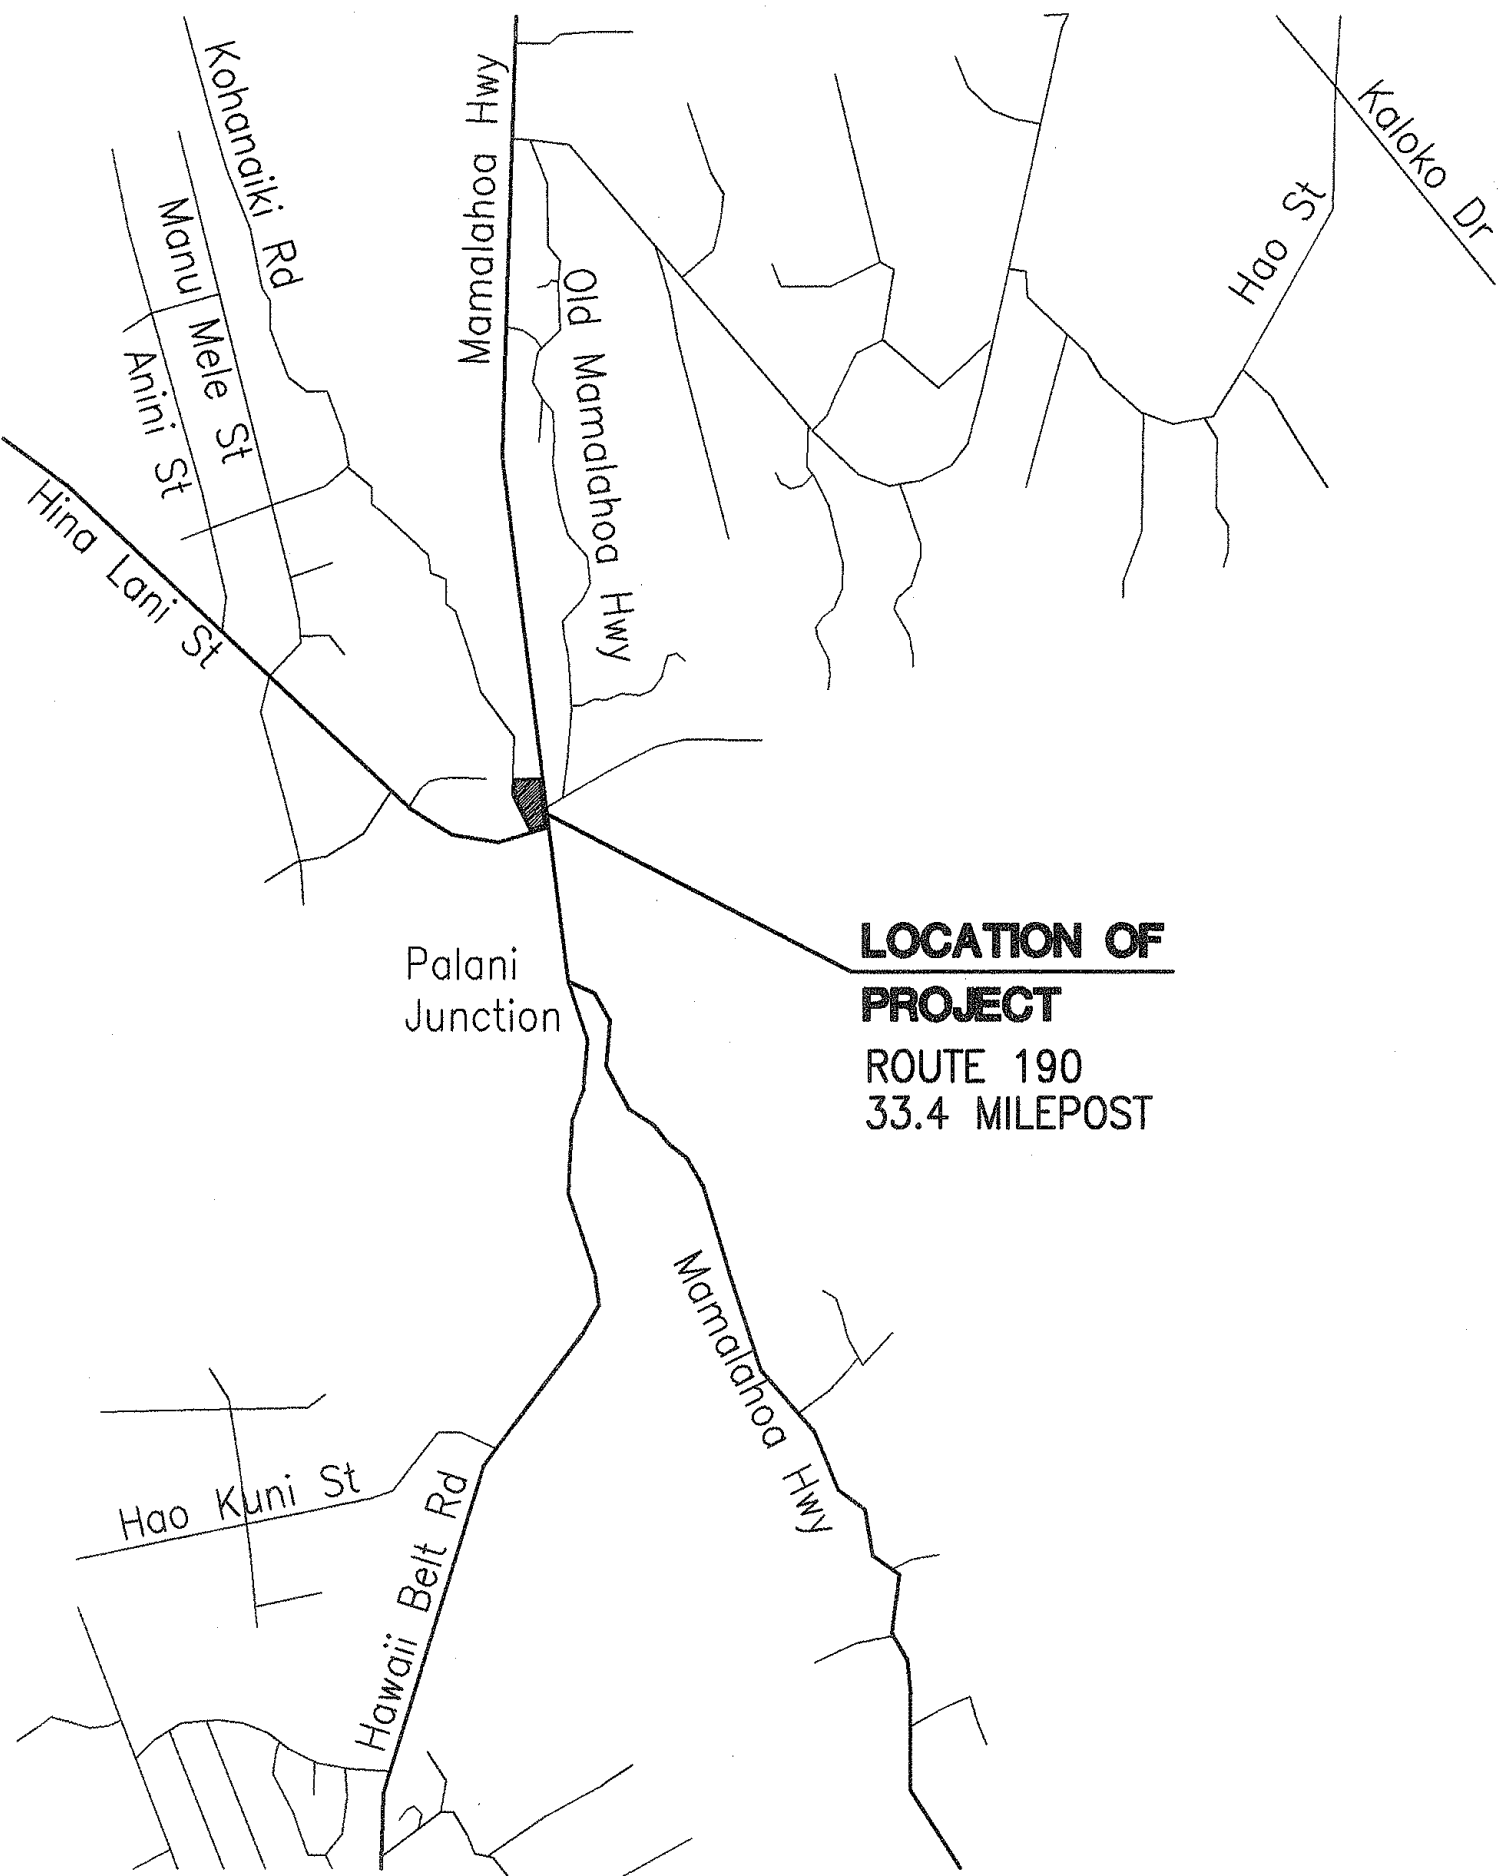


LOCATION MAP
NOT TO SCALE

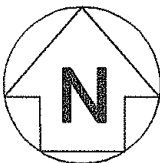

PROJECT LOCATION
NORTH KONA BASEYARD

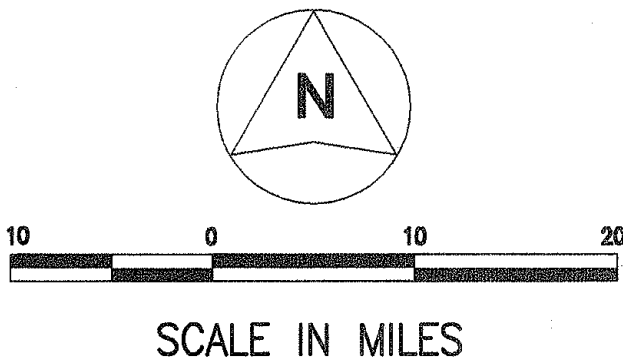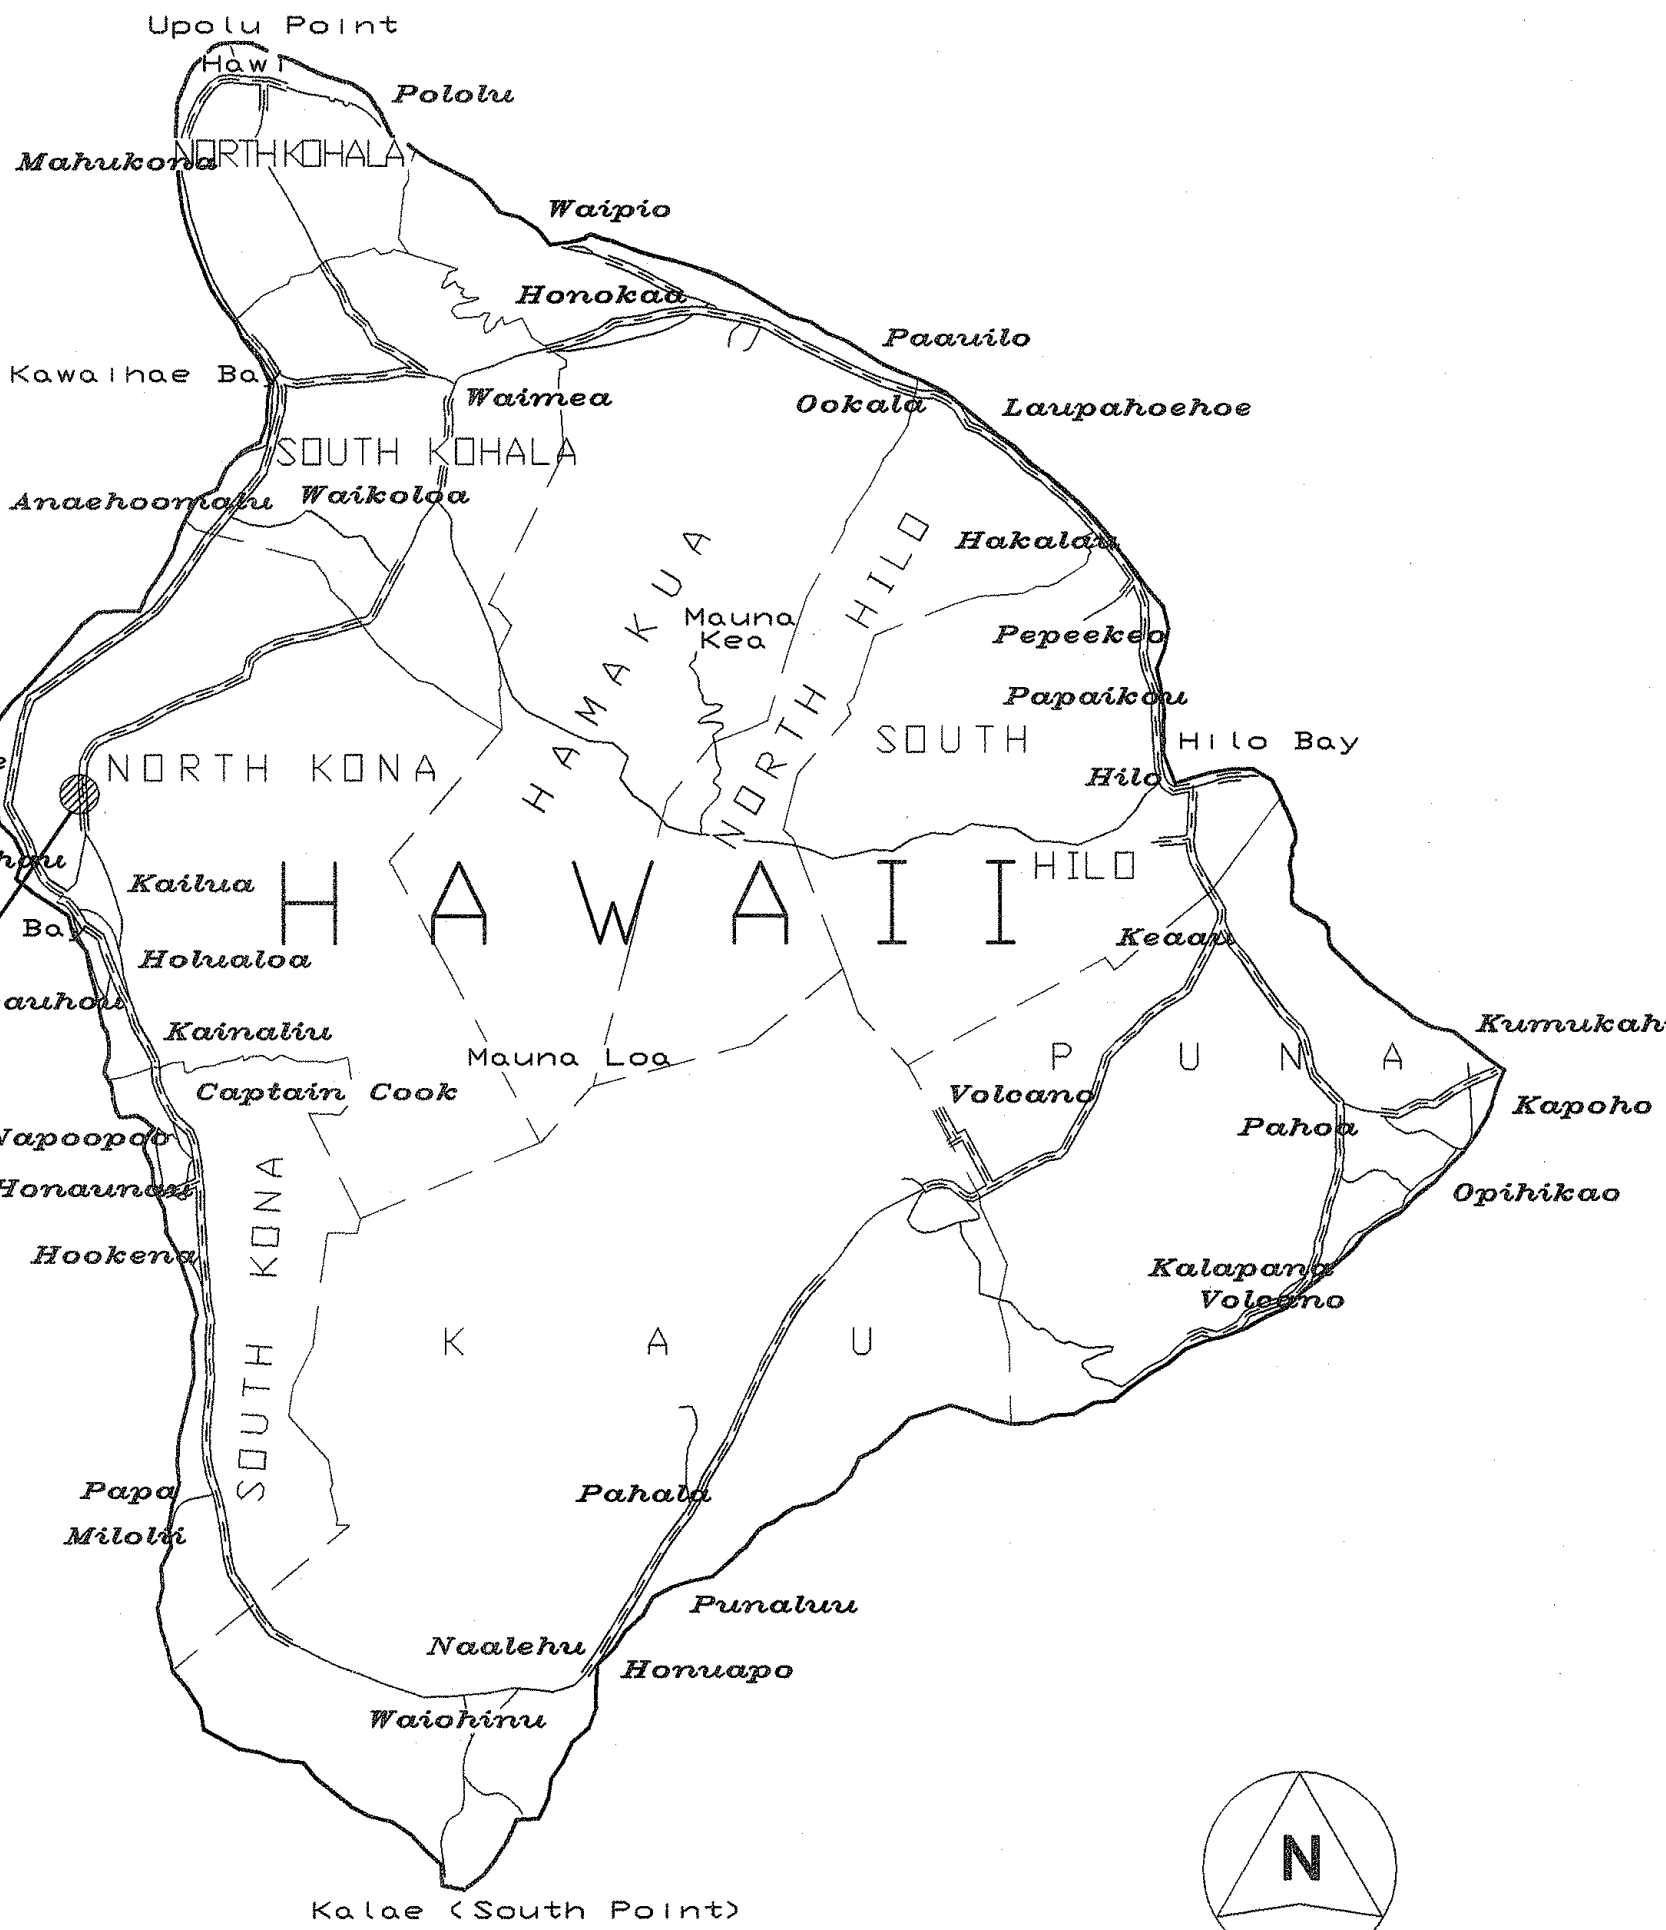

FEDERAL AID PROJECTS PREVIOUSLY CONSTRUCTED
OR UNDER CONSTRUCTION

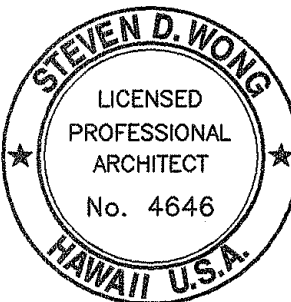

EXPIRES 04-30-06
THIS WORK WAS PREPARED BY ME
OR UNDER MY SUPERVISION AND
CONSTRUCTION OF THIS PROJECT
WILL BE UNDER MY OBSERVATION.

DEPARTMENT OF TRANSPORTATION
STATE OF HAWAII

APPROVED:

DIR. OF TRANSPORTATION DATE

SHEET No. T-1 OF T-2 SHEETS

06/07/05	1	NOTE REVISED OR ADDED, ADDED DETAIL
DATE		REVISION

MITSUNAGA & ASSOCIATES

ADD.1