


FED. ROAD DIST. NO.	STATE	PROJ. NO.	FISCAL YEAR	SHEET NO.	TOTAL SHEETS
HAWAII	HAW.	HNT-H-02-92M	1992	8	11

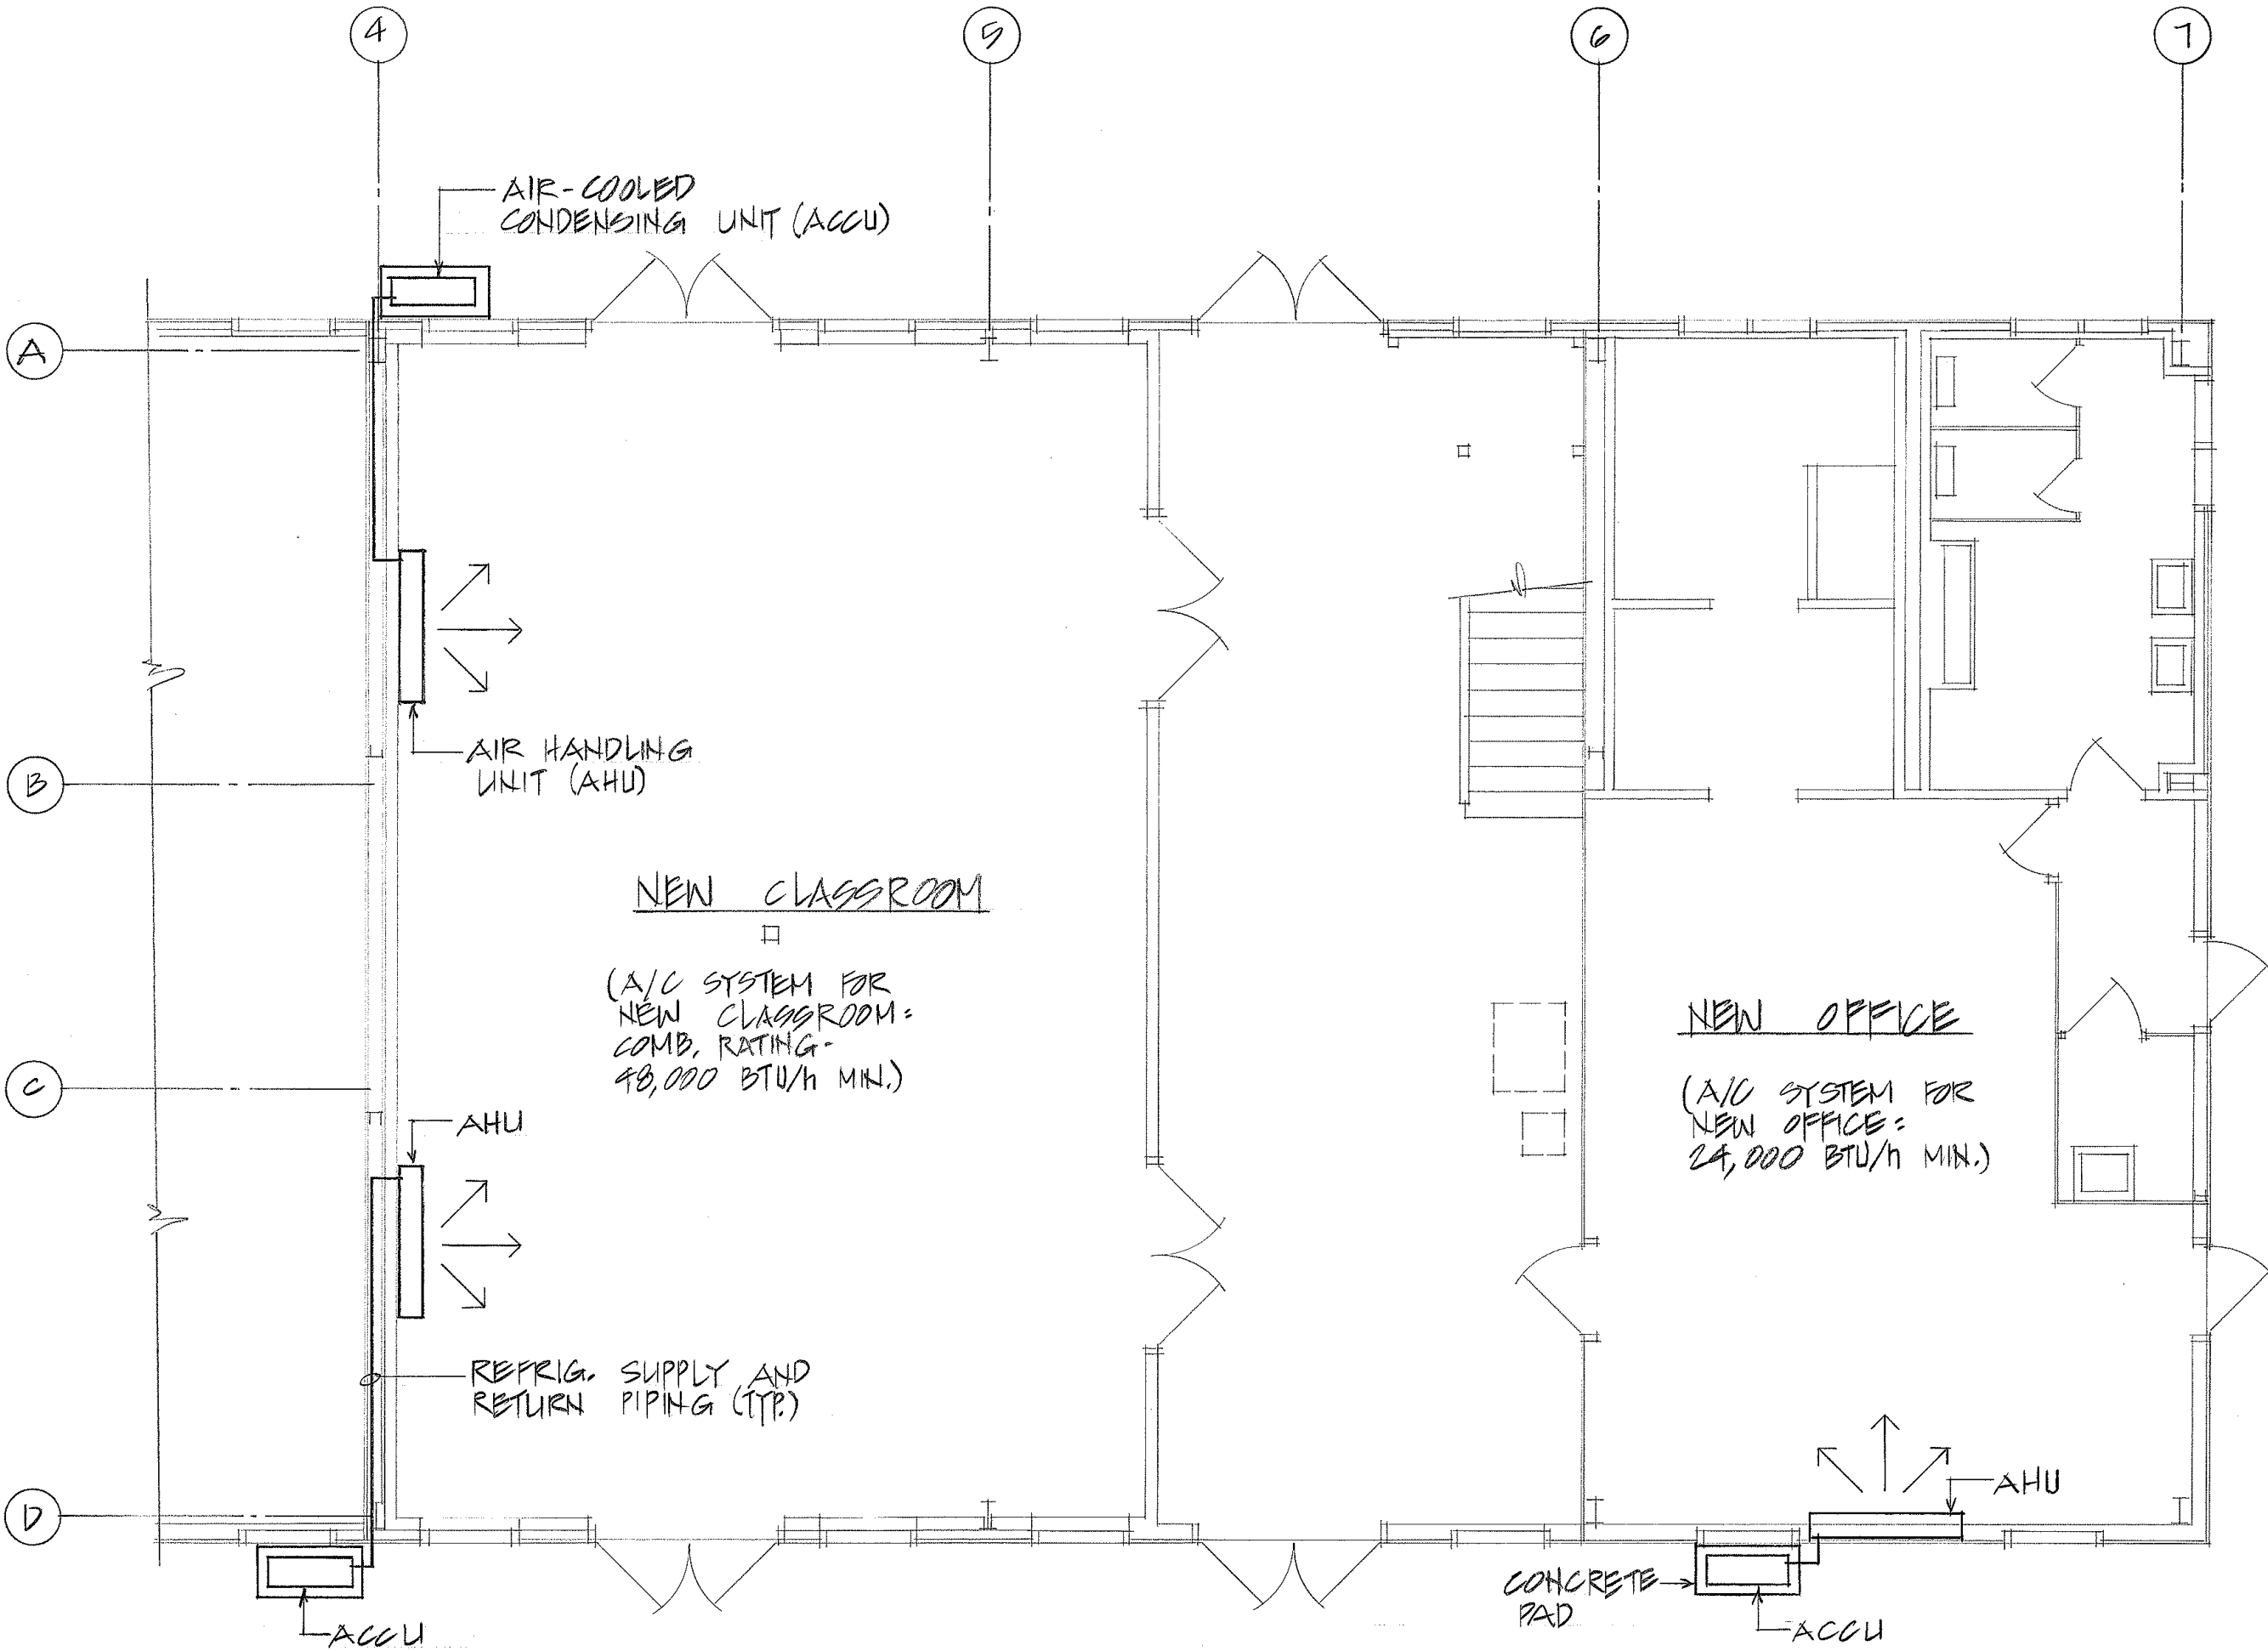


A/C FLOOR PLAN - BUILDING 'D'

SCALE: 3/16" = 1'-0"

NOTES


1. CONTRACTOR SHALL VERIFY EXISTING CONDITIONS PRIOR TO START OF WORK.
2. ENTIRE INSTALLATION SHALL COMPLY WITH ALL APPLICABLE REQUIREMENTS OF THE BUILDING CODE OF THE COUNTY OF HAWAII, THE HEALTH DEPARTMENT REGULATIONS, NFPA STANDARDS 90A, ASHRAE AND SMACNA GUIDES.
3. CONTRACTOR SHALL COORDINATE ALL INSTALLATION OF MECHANICAL WORK WITH OTHER TRADES INVOLVED.
4. LOCATION OF ACCU'S AND AHU'S AS SHOWN ABOVE ARE APPROXIMATE. EXACT LOCATIONS SHALL BE DETERMINED IN THE FIELD BY THE ENGINEER.
5. ALL UNITS TO BE SPLIT-TYPE AIR CONDITIONING SYSTEM. AIR CONDITIONING SYSTEMS PACKAGED BY THE MANUFACTURER INTO TWO SEPARATE UNITS, AN OUTSIDE UNIT AND AN INSIDE UNIT, CONNECTED BY REFRIGERANT PIPING AND ELECTRICAL CIRCUITS.
6. COMPLETE INSTALLATION SHALL BE GUARANTEED AGAINST DEFECTIVE WORKMANSHIP AND MATERIALS FOR ONE YEAR AFTER DATE OF FINAL ACCEPTANCE BY THE STATE.

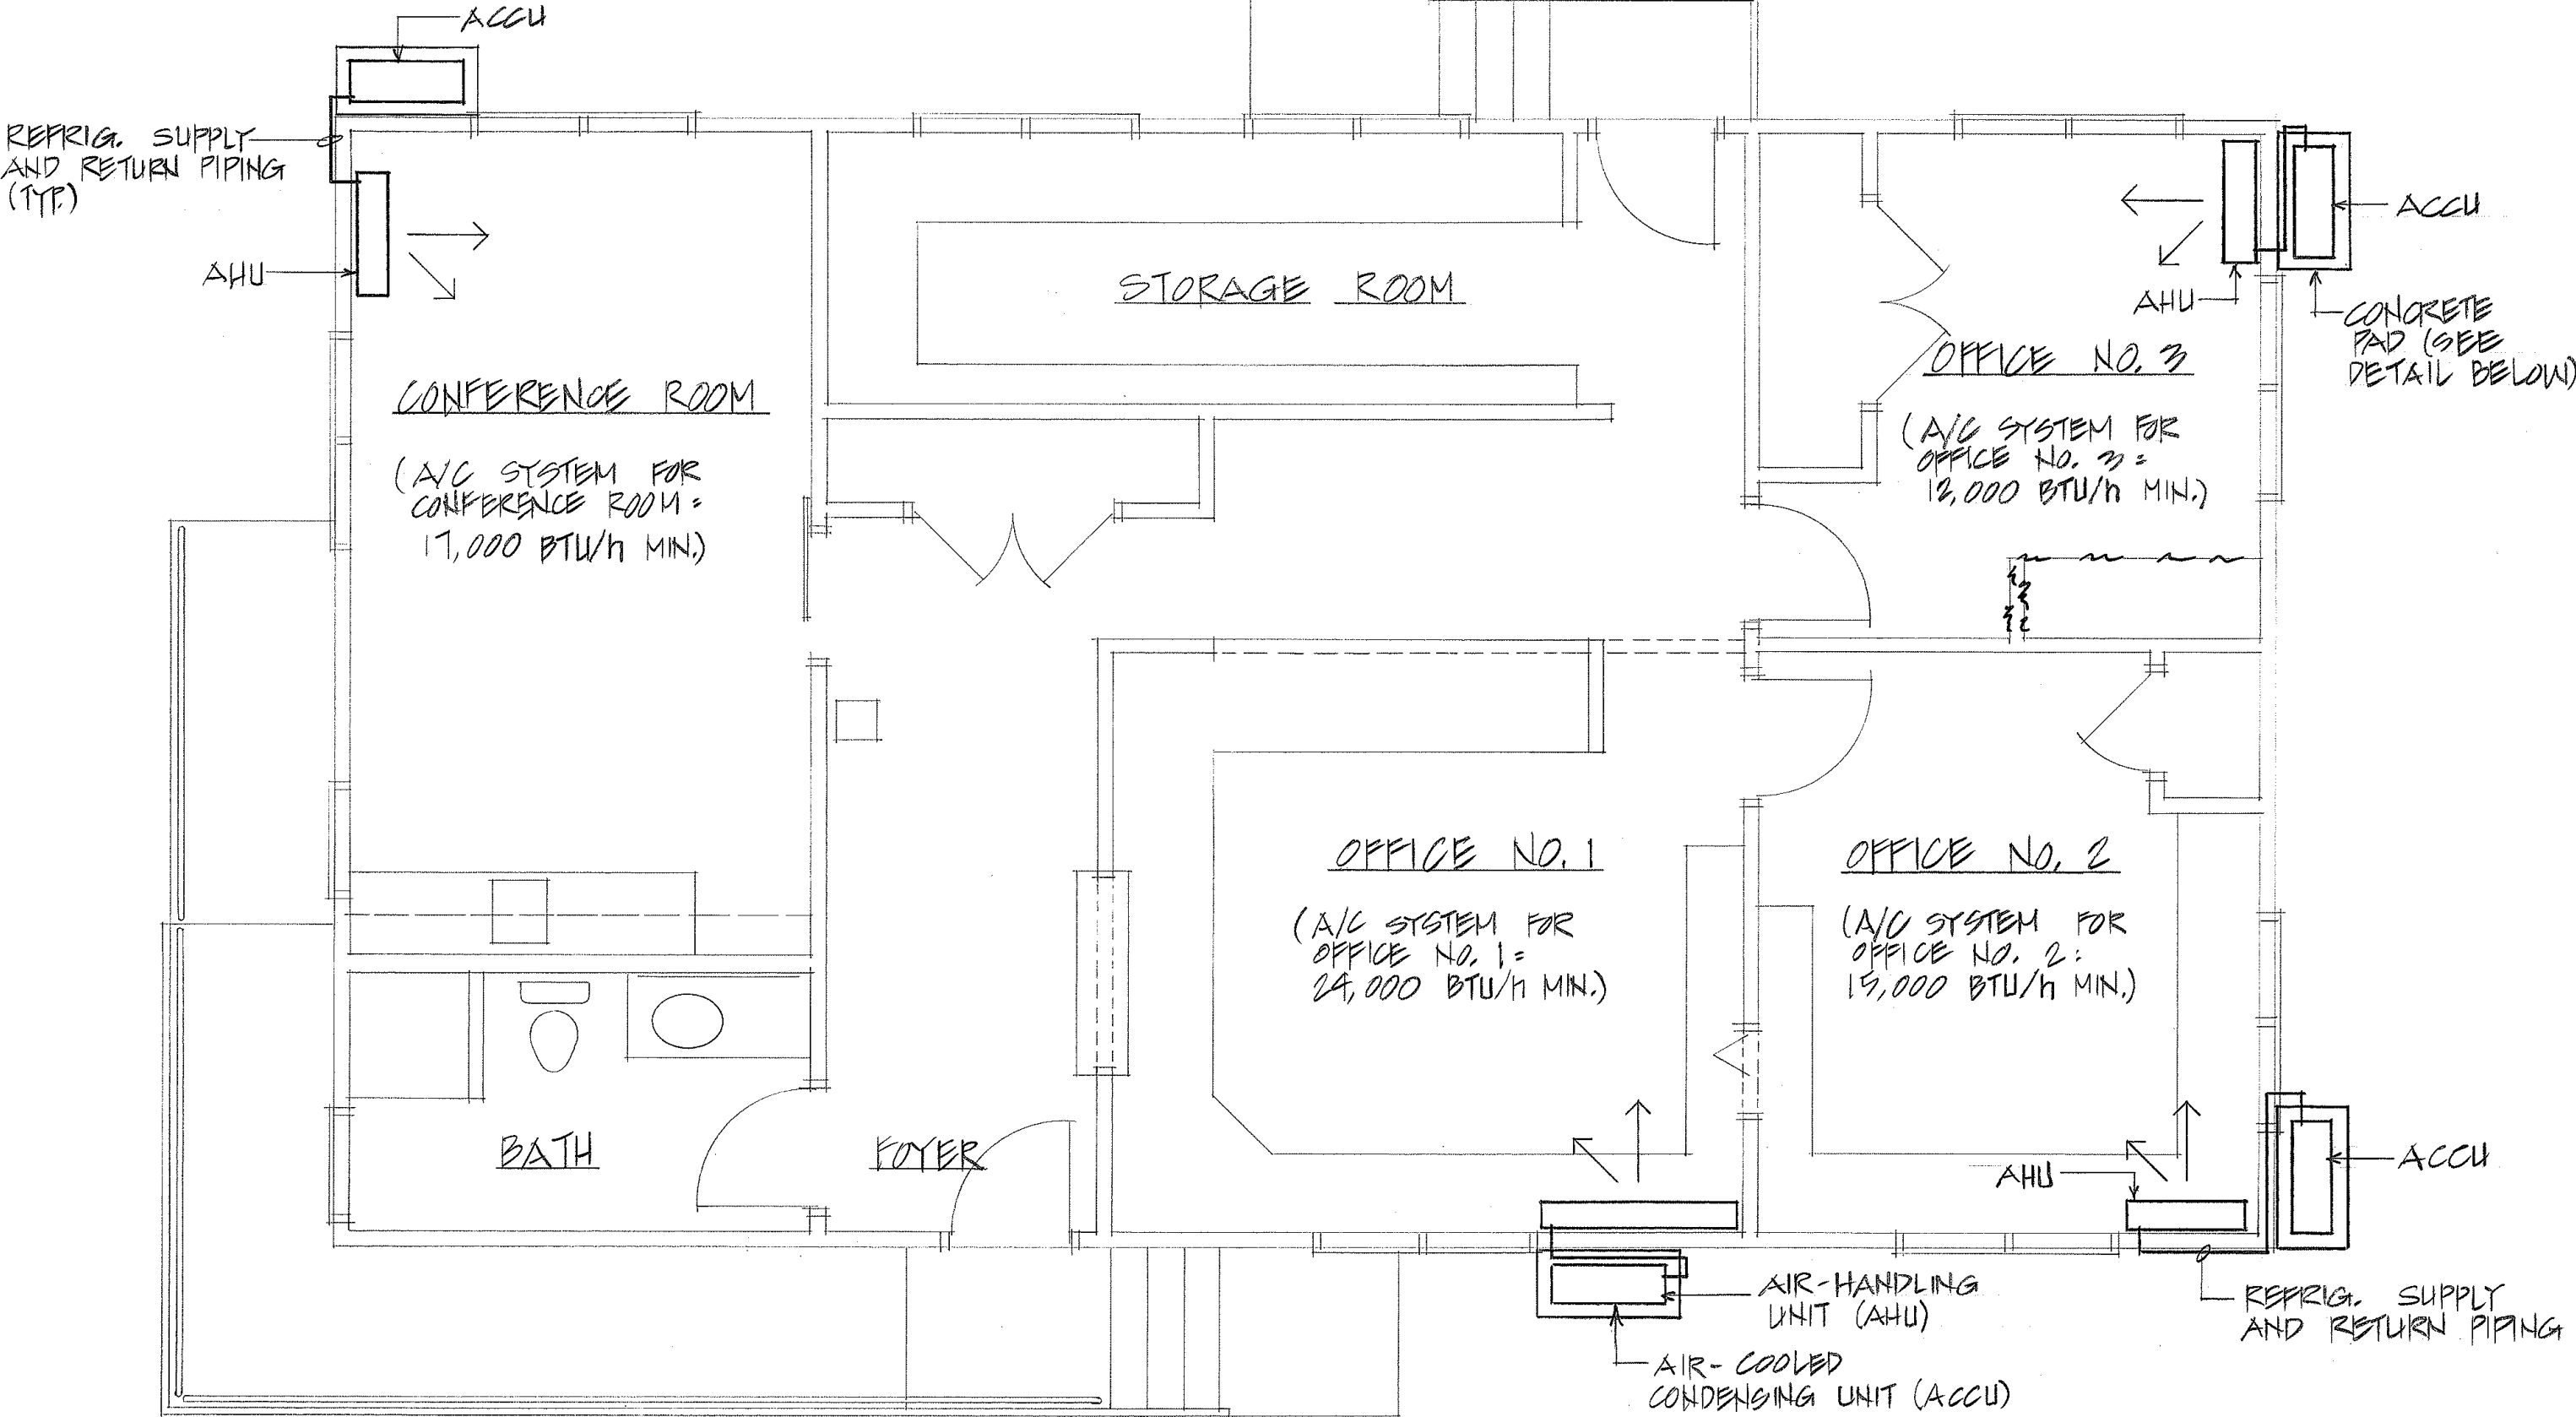

A/C FLOOR PLAN - NEW OFFICE BUILDING

SCALE: 1/4" = 1'-0"

Note:
Refer to Floor Plan Sheet No.4
for Revised Layout

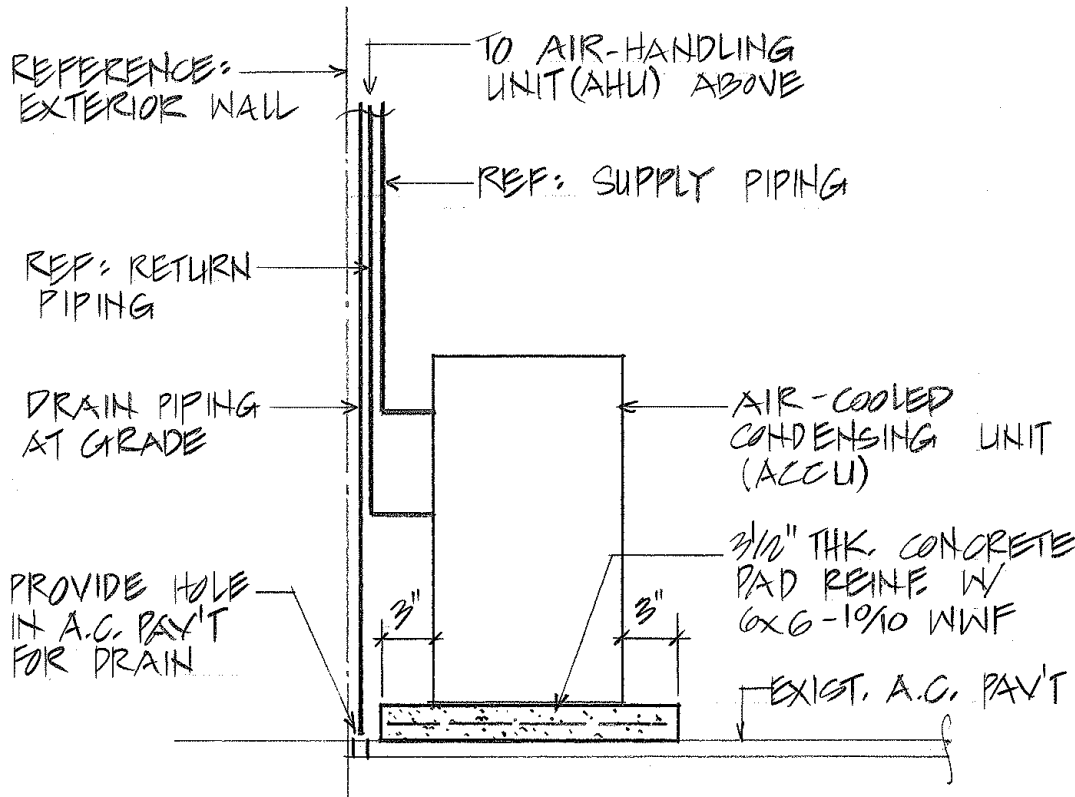

STATE OF HAWAII
DEPARTMENT OF TRANSPORTATION
HIGHWAYS DIVISION

BUILDING 'D' & NEW OFFICE BLD'G
A/C LAYOUT & DETAILS
HILO BASEYARD BUILDING 'D'
OFFICE RENOVATION
PROJ. NO. HNT-H-02-92M
SCALE: AS NOTED
DATE: APRIL 1992

SHEET No. 1 OF 1 SHEETS

ORIGINAL PLAN	SURVEY PLOTTED BY	DATE
NOTE BOOK	DRAWN BY	
	DESIGNED BY	
	CHECKED BY	