
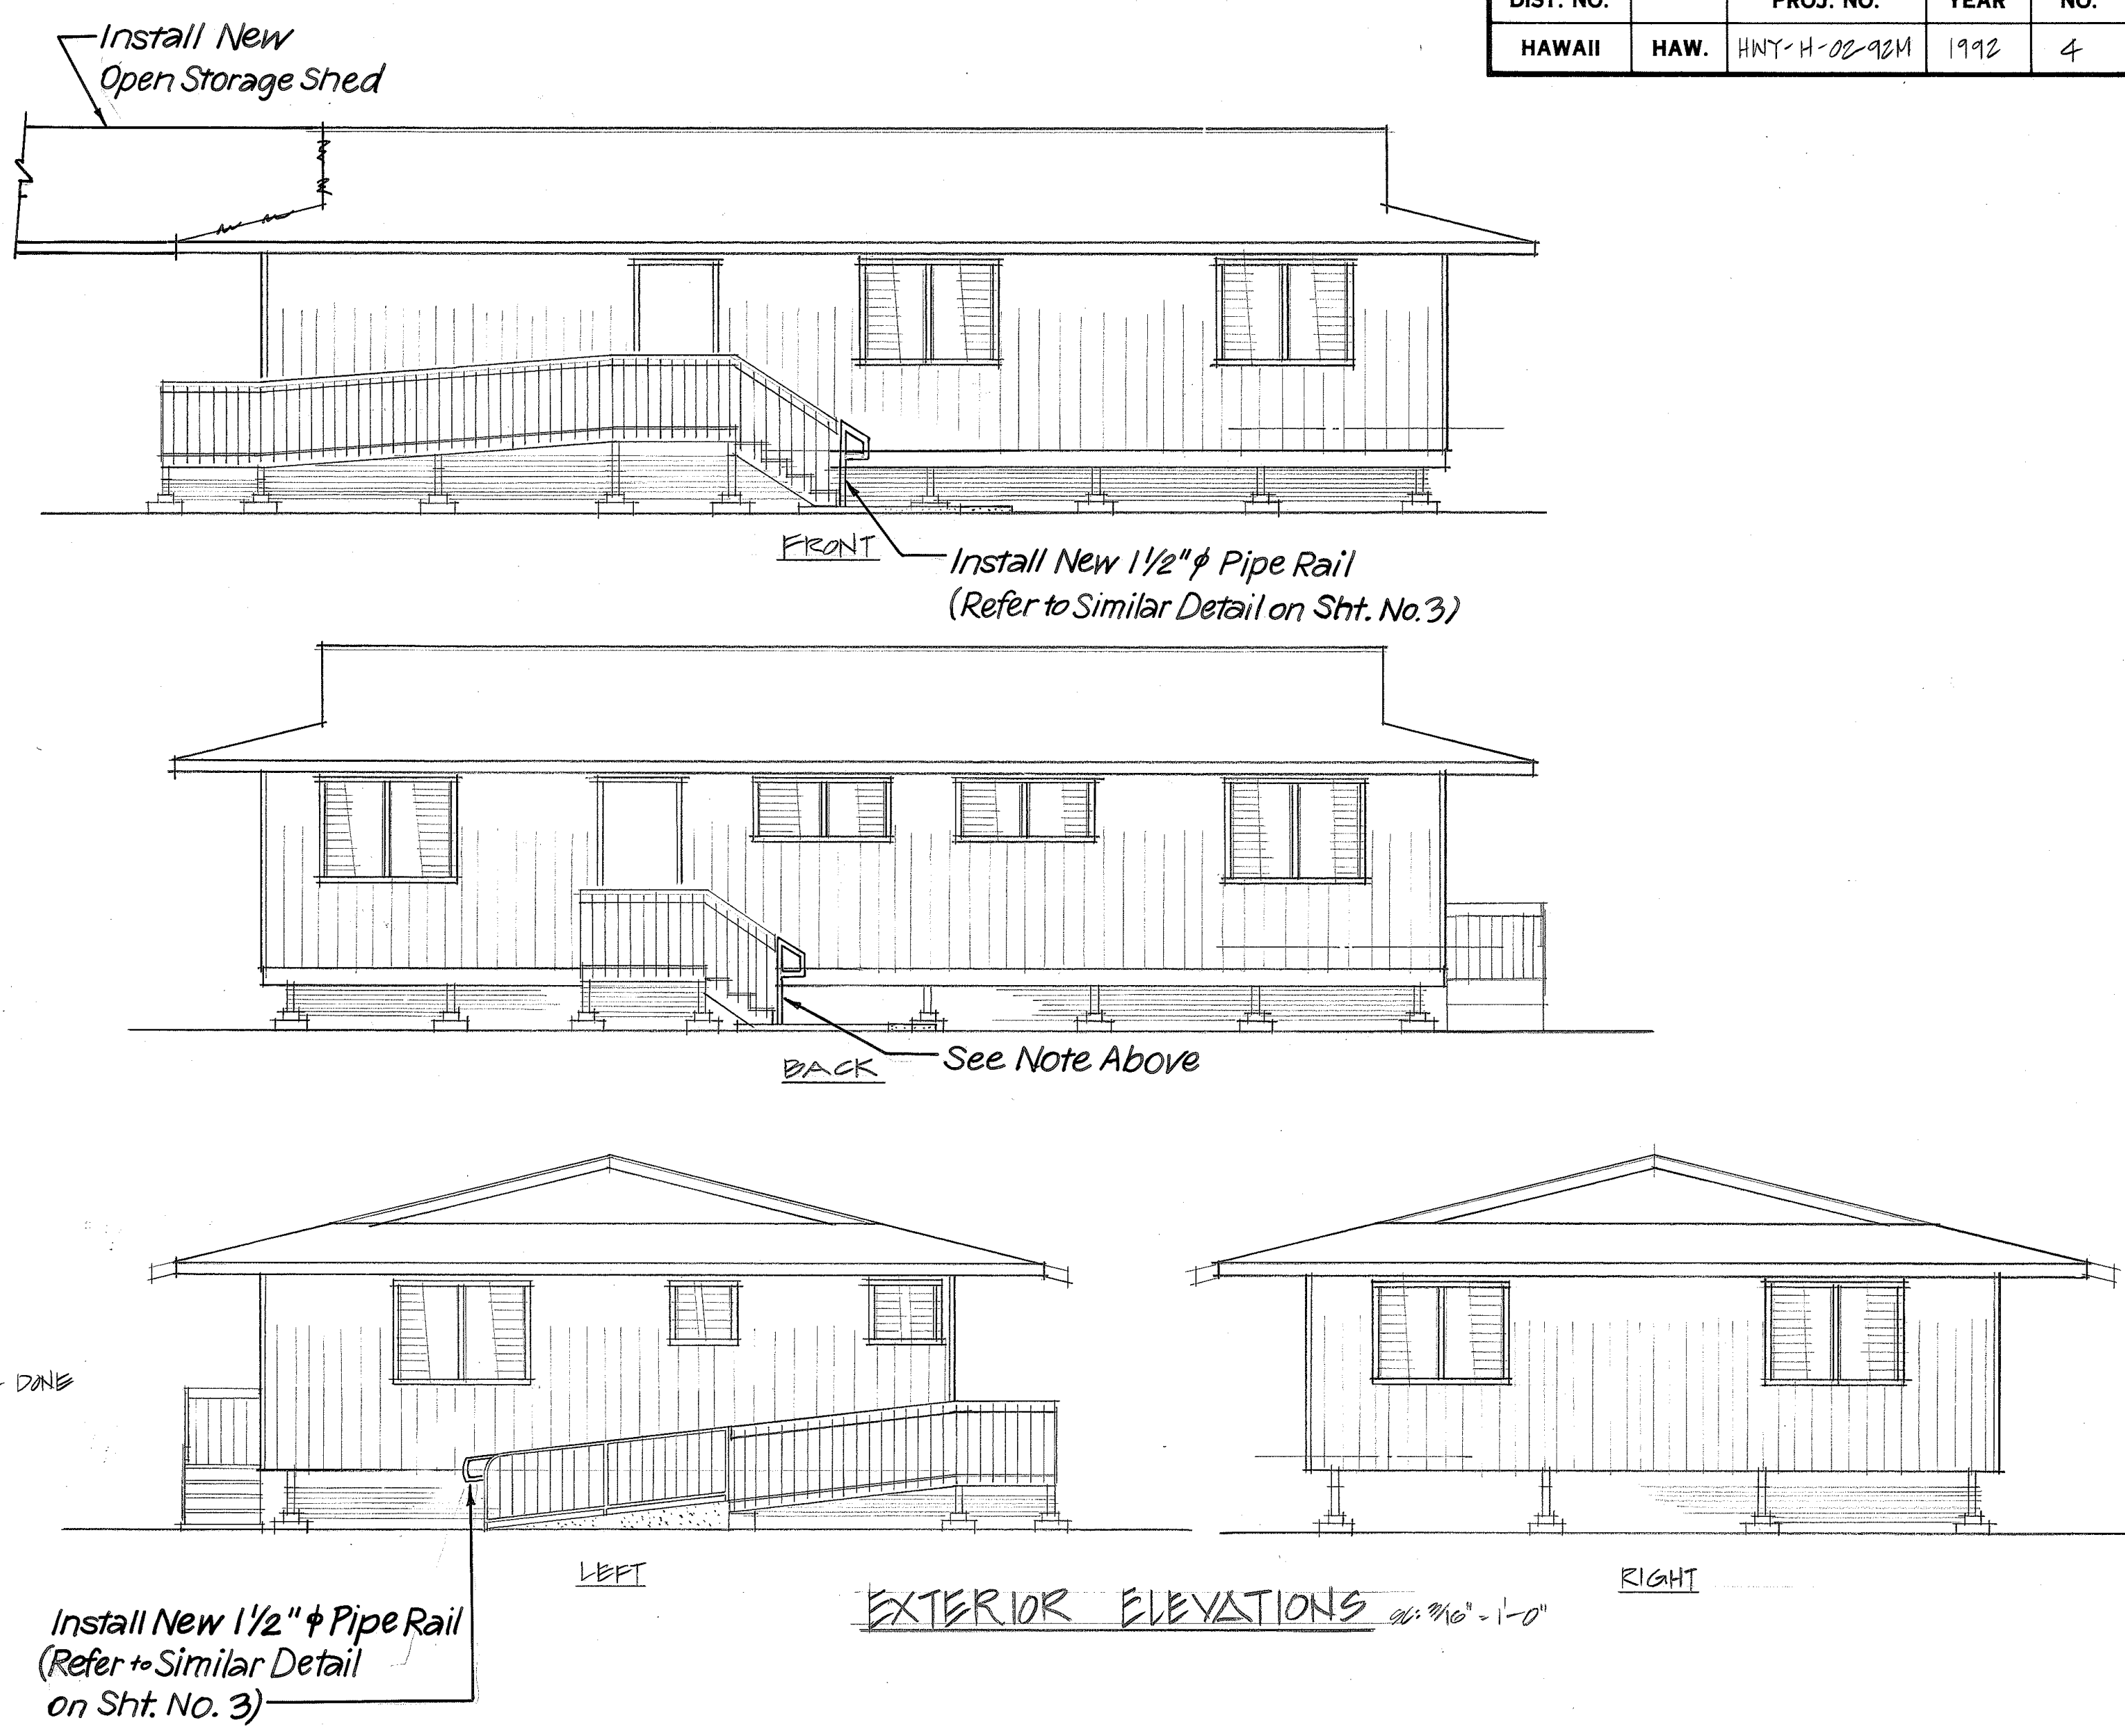
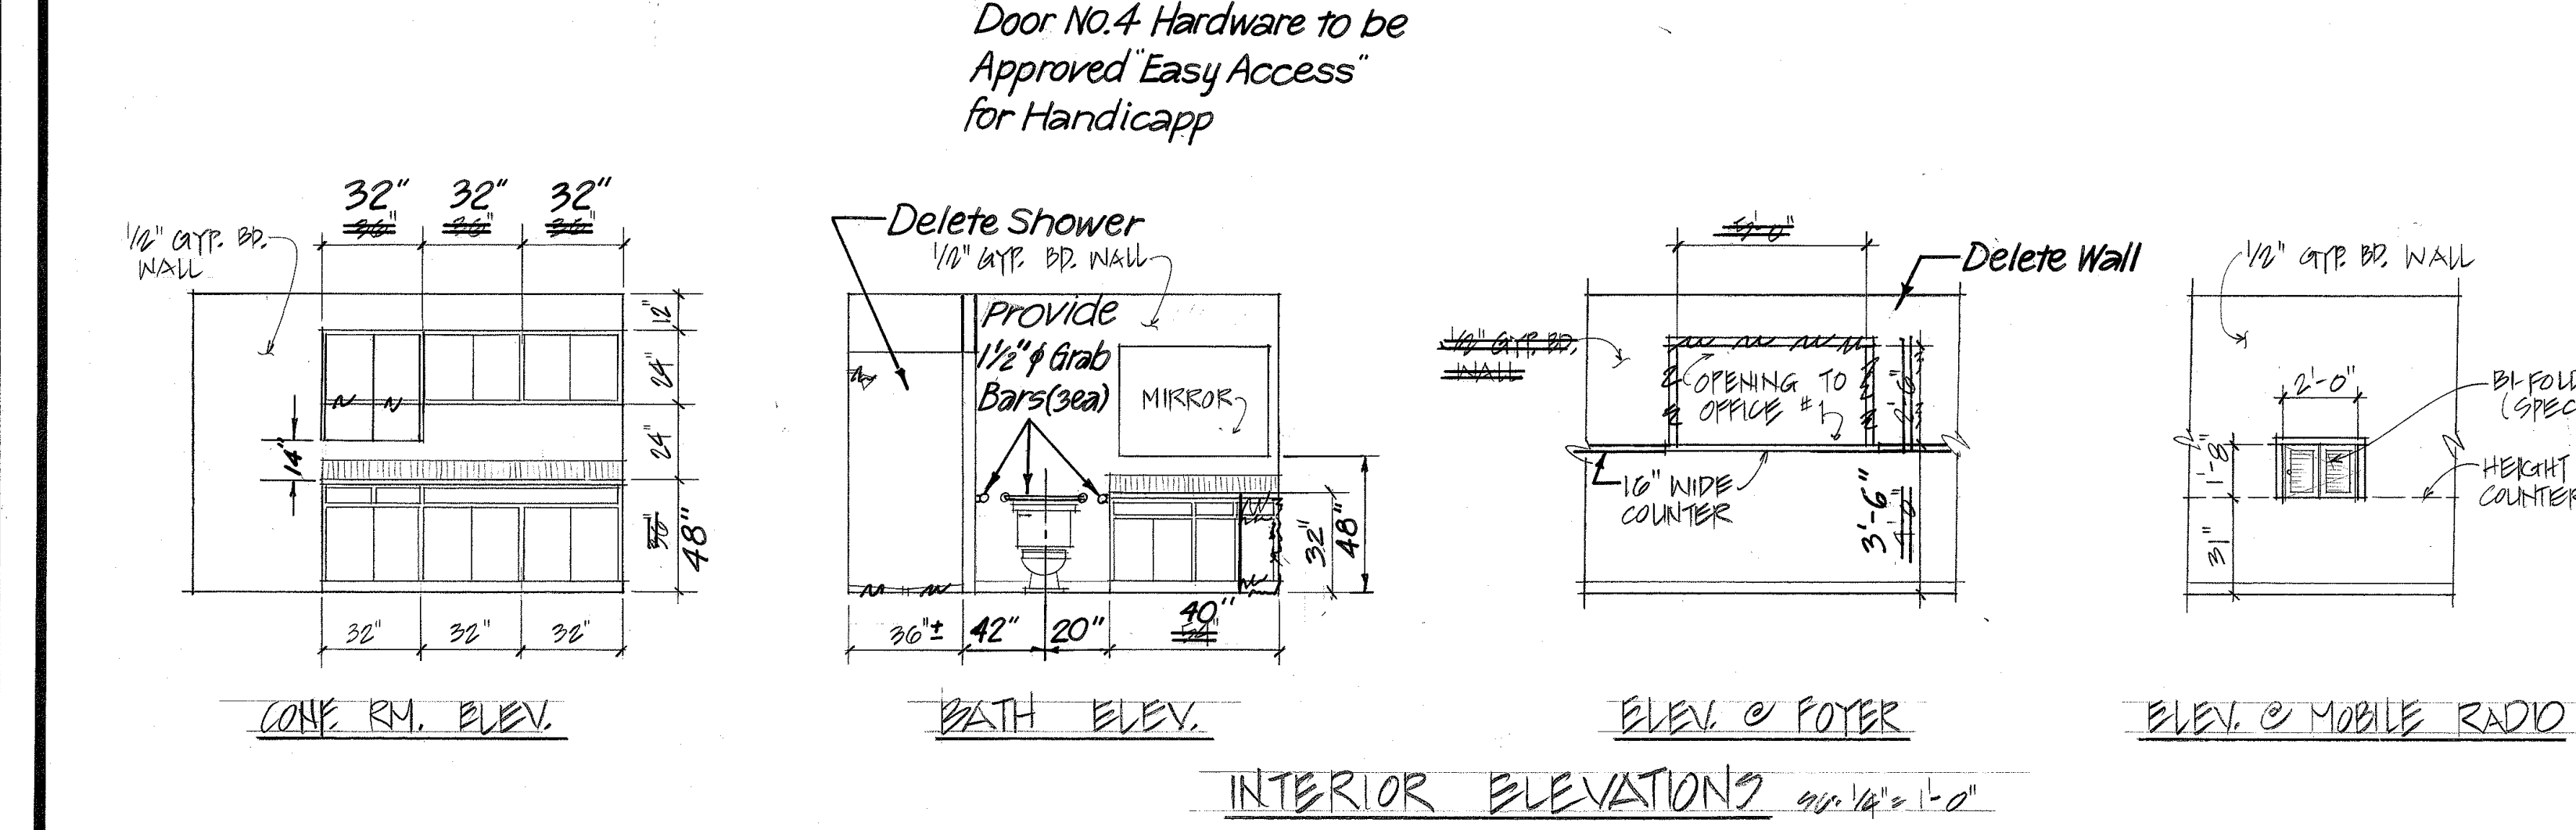
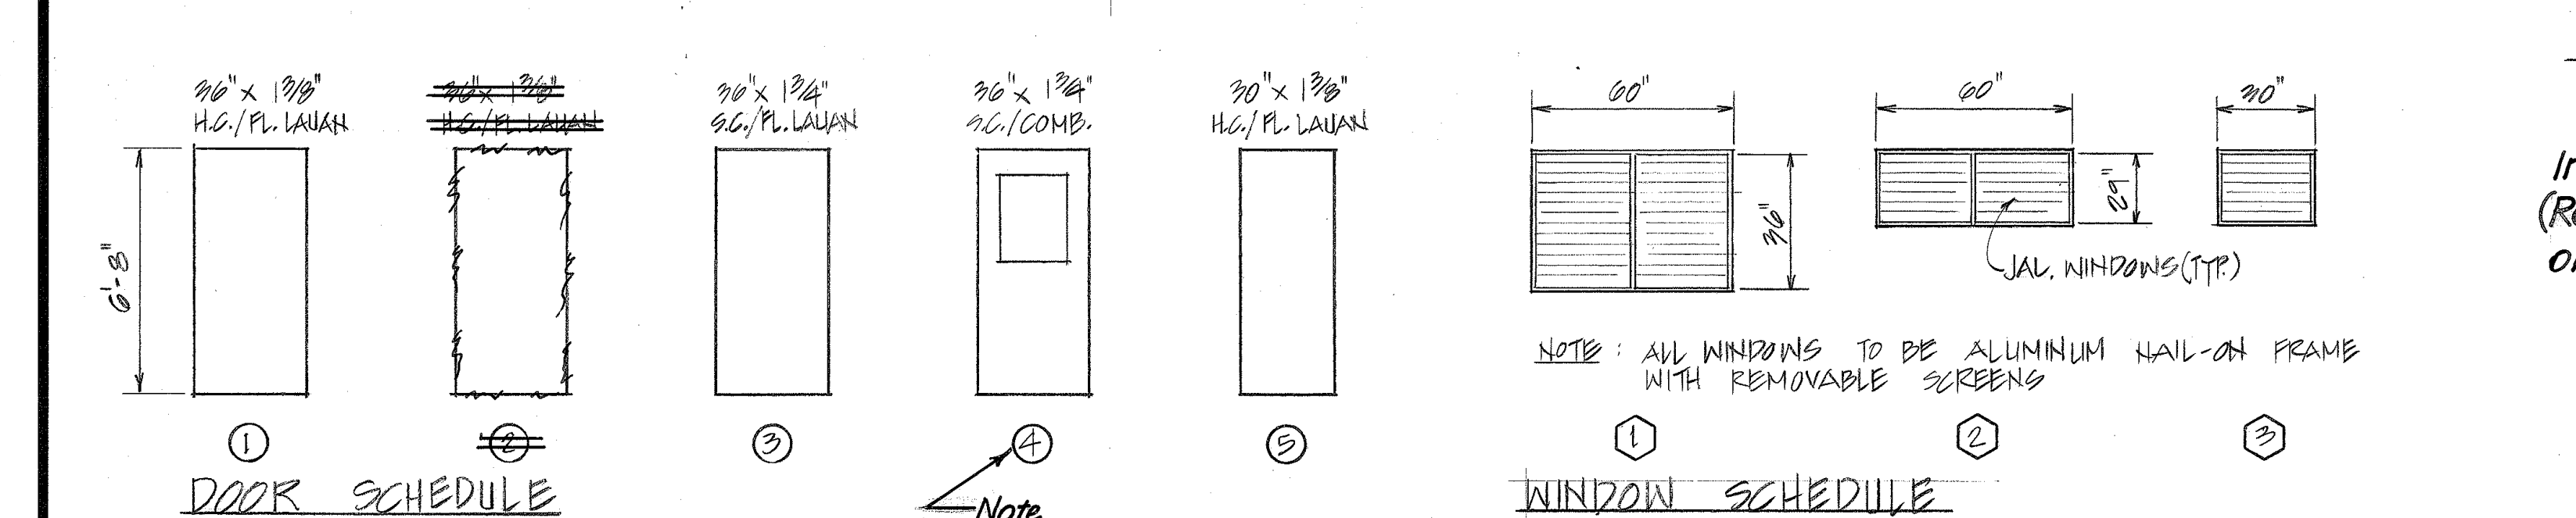


FED. ROAD DIST. NO.	STATE	PROJ. NO.	FISCAL YEAR	SHEET NO.	TOTAL SHEETS
HAWAII	HAW.	HNT-H-02-92M	1992	4	11

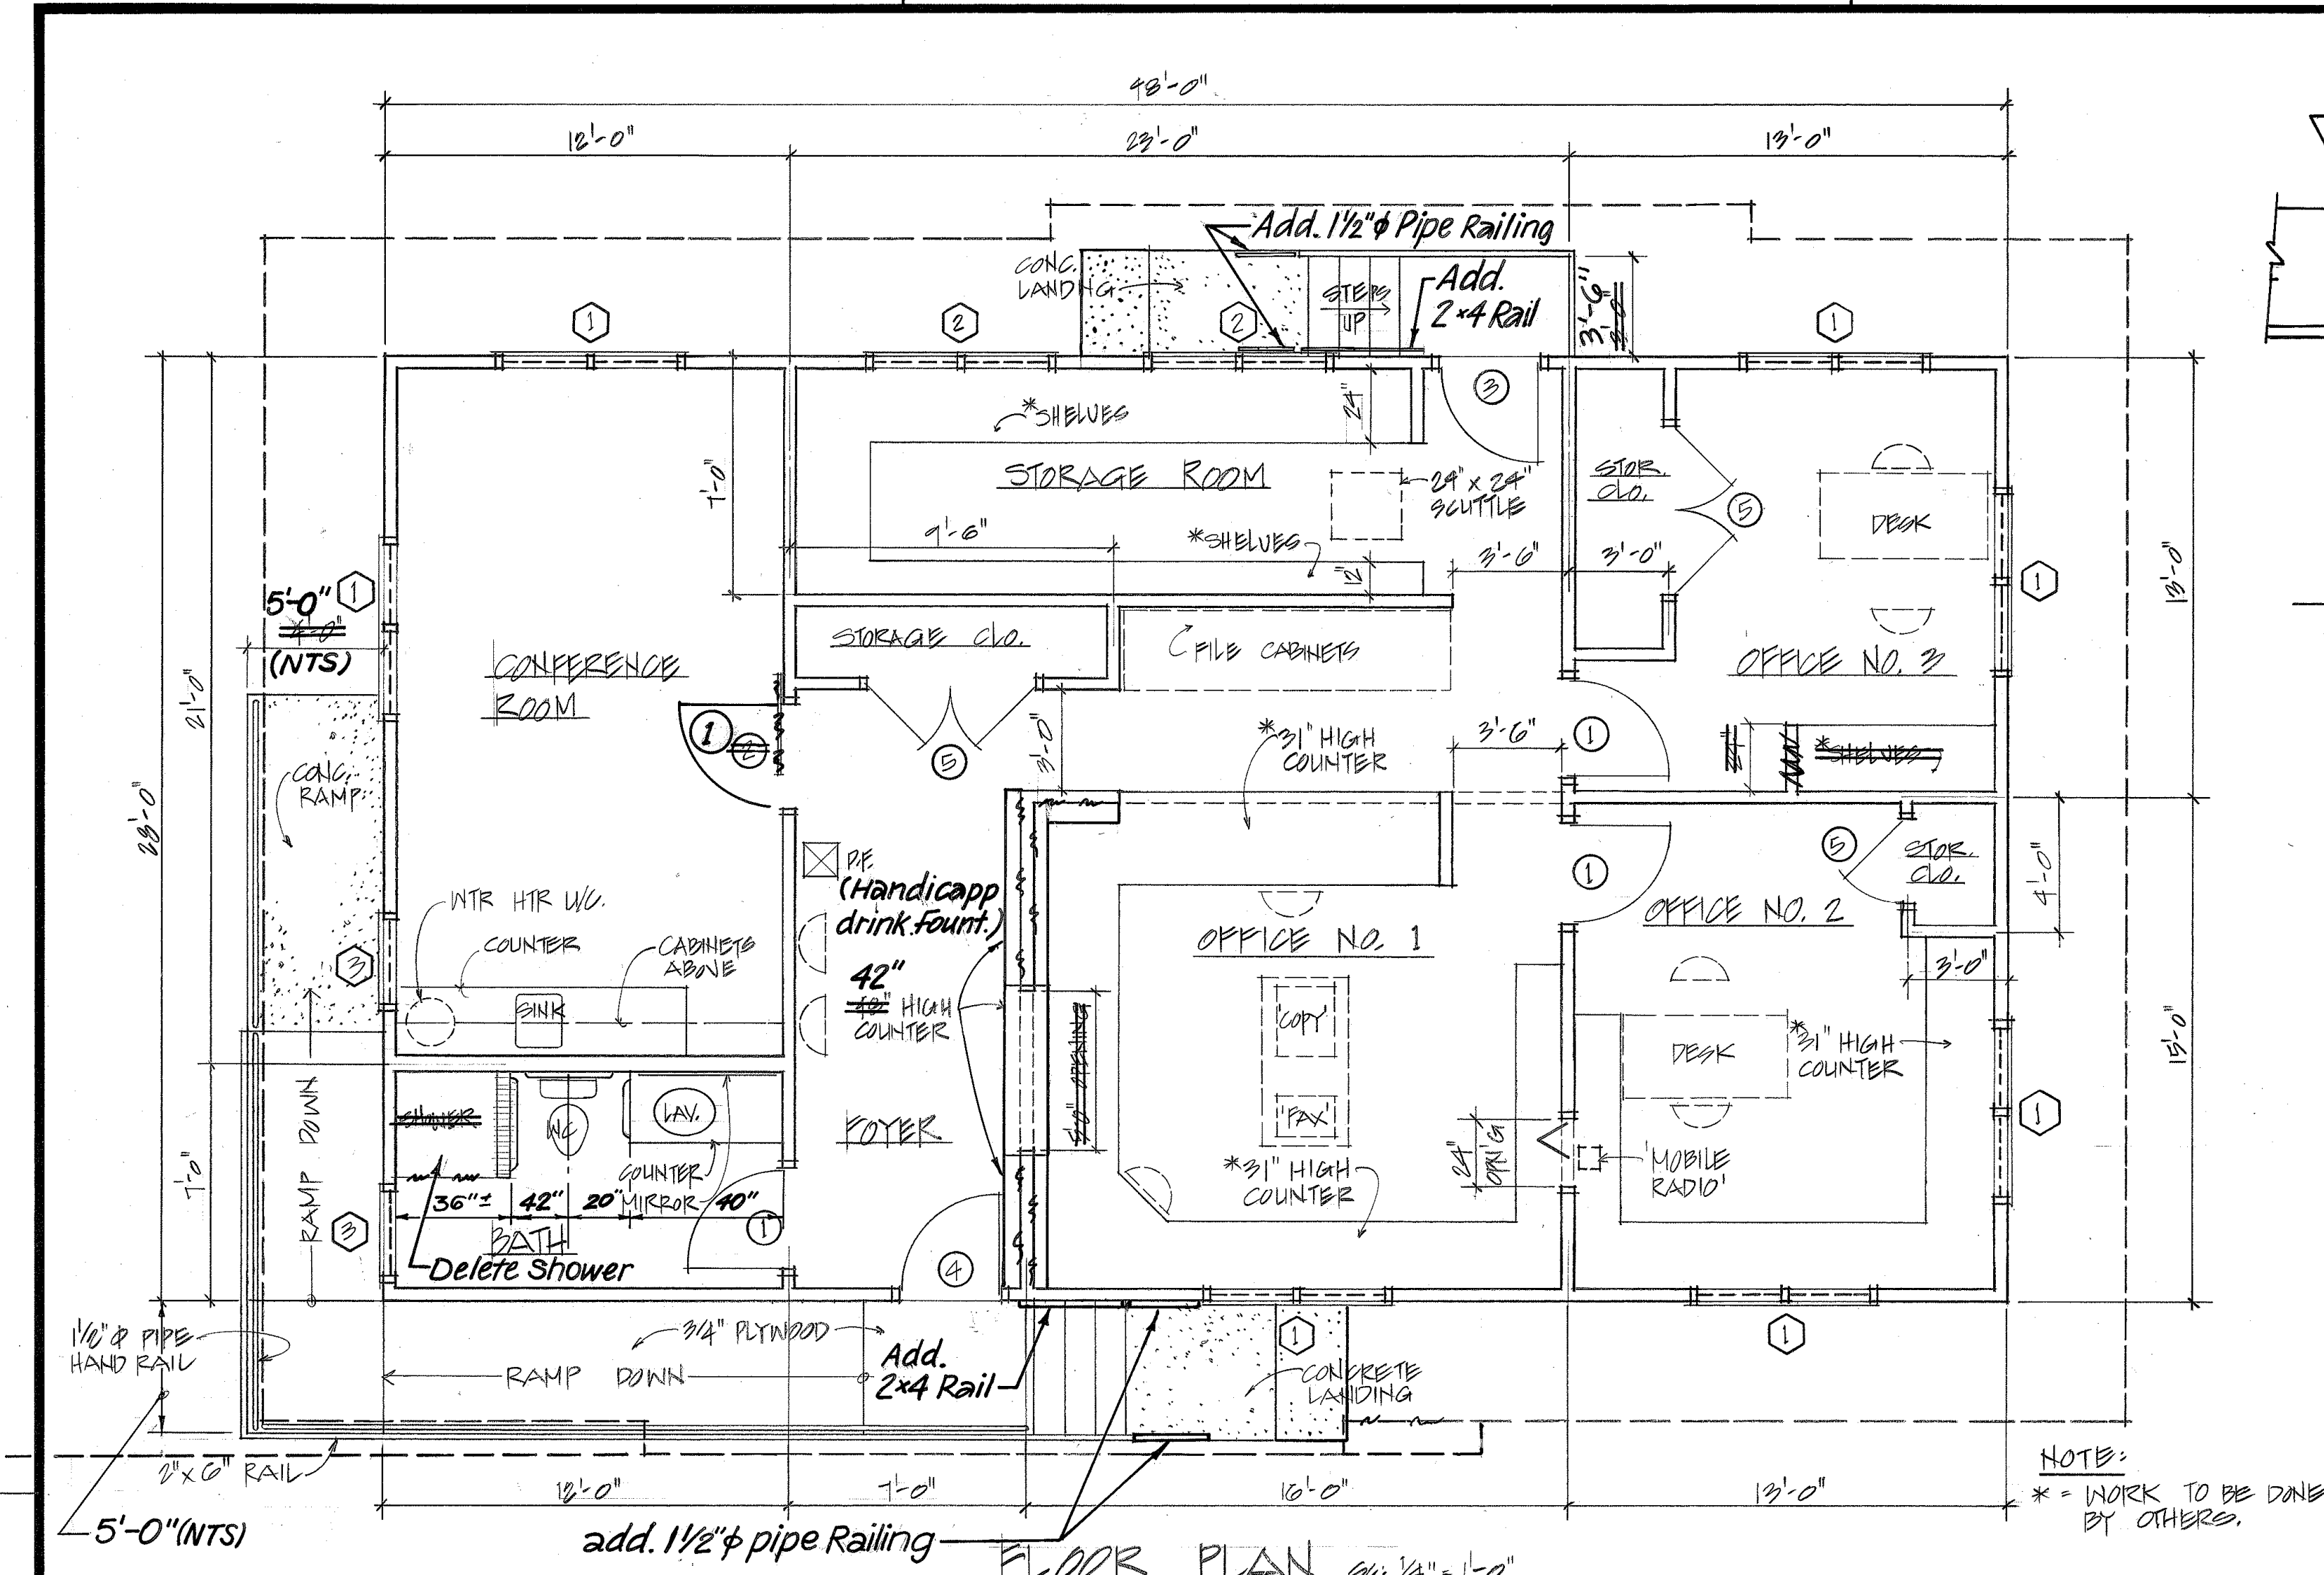

ORIGINAL PLAN	DATE
DRAWN BY	
DESIGNED BY	
CHECKED BY	
NO.	

STATE OF HAWAII
DEPARTMENT OF TRANSPORTATION
HIGHWAYS DIVISION






NEW OFFICE BUILDING
FLOOR PLAN & EXT. ELEVATIONS

HILLO BASEYARD, BUILDING 'D'
OFFICE RENOVATION
PROJ. NO. HNT-H-02-92M

SCALE: AS NOTED DATE: APRIL 1992

SHEET No. 1 OF 3 SHEETS

FED. ROAD DIST. NO.	STATE	PROJ. NO.	FISCAL YEAR	SHEET NO.	TOTAL SHEETS
HAWAII	HAW.	HNY-H-02-92M	1992	5	11

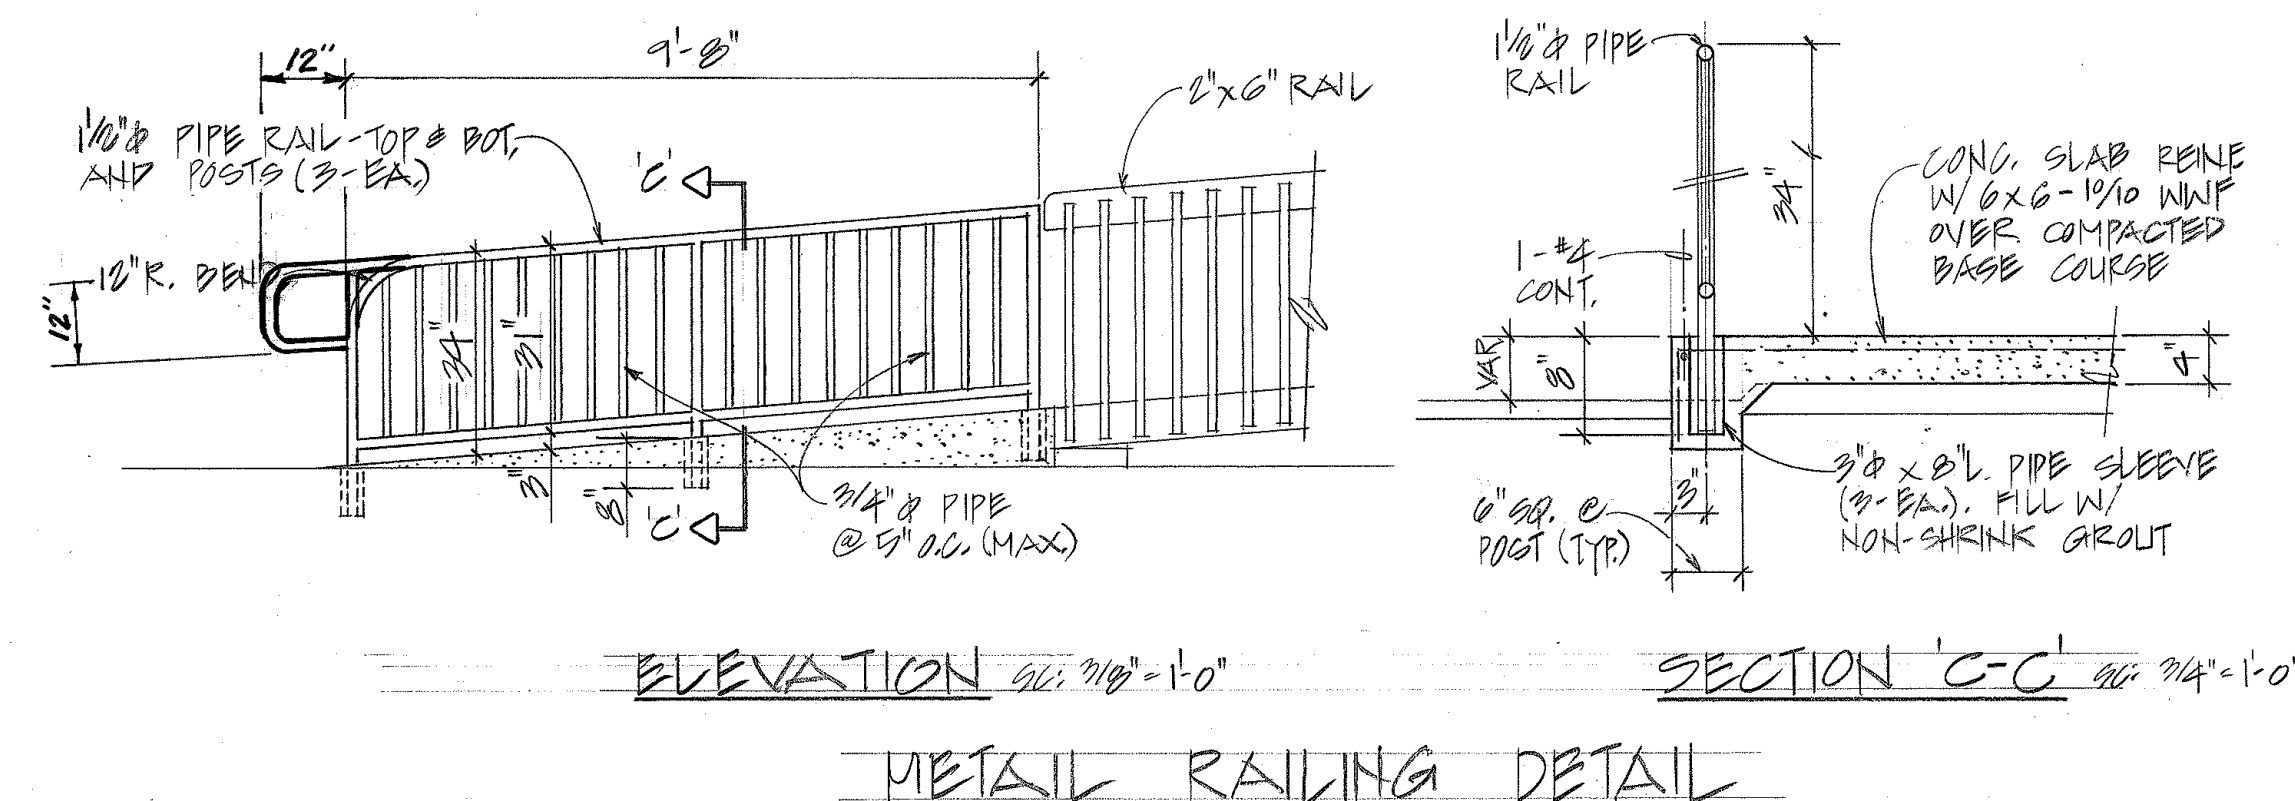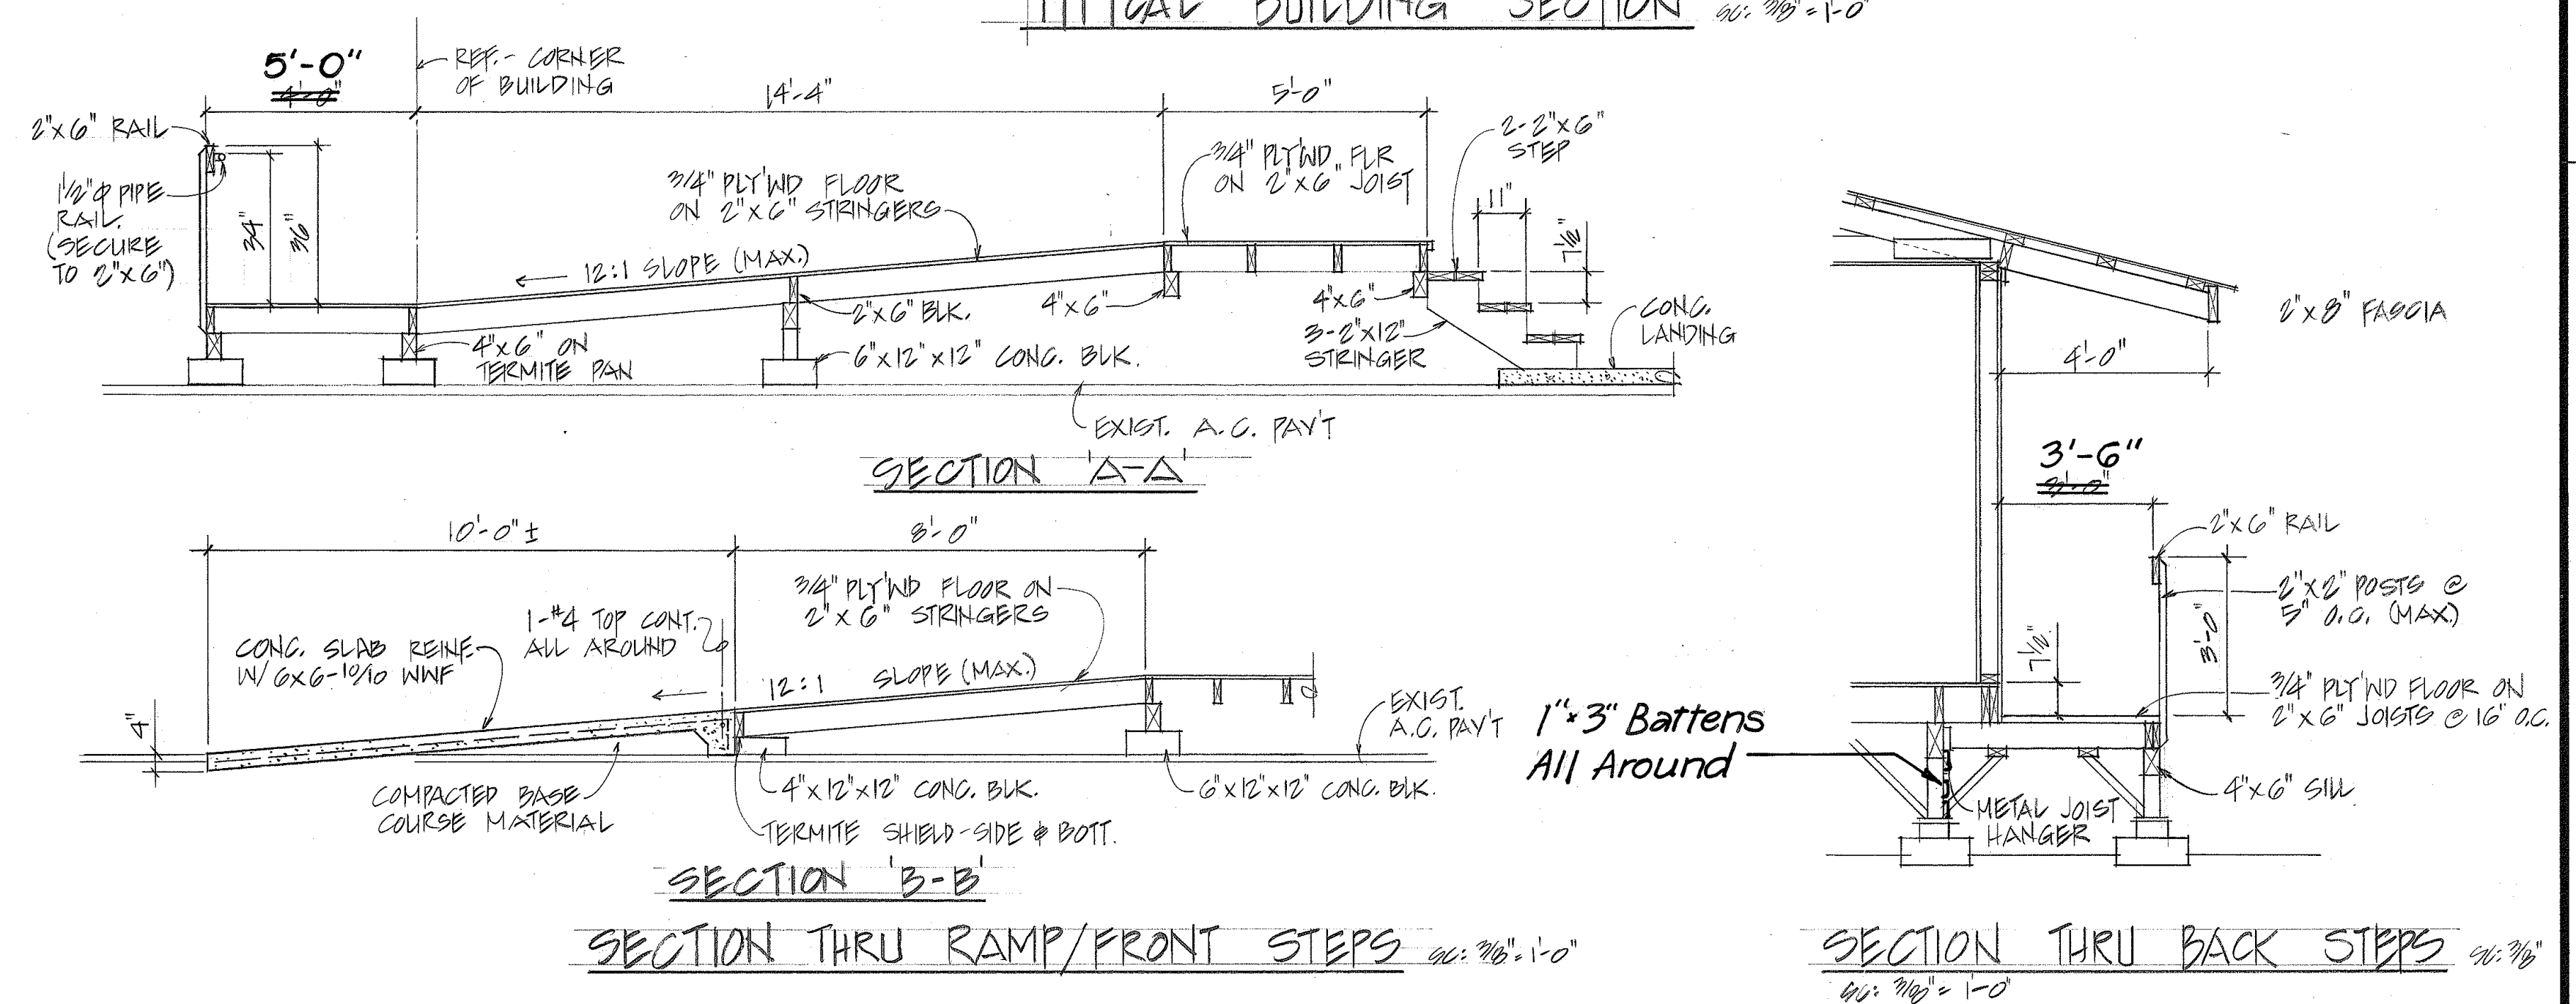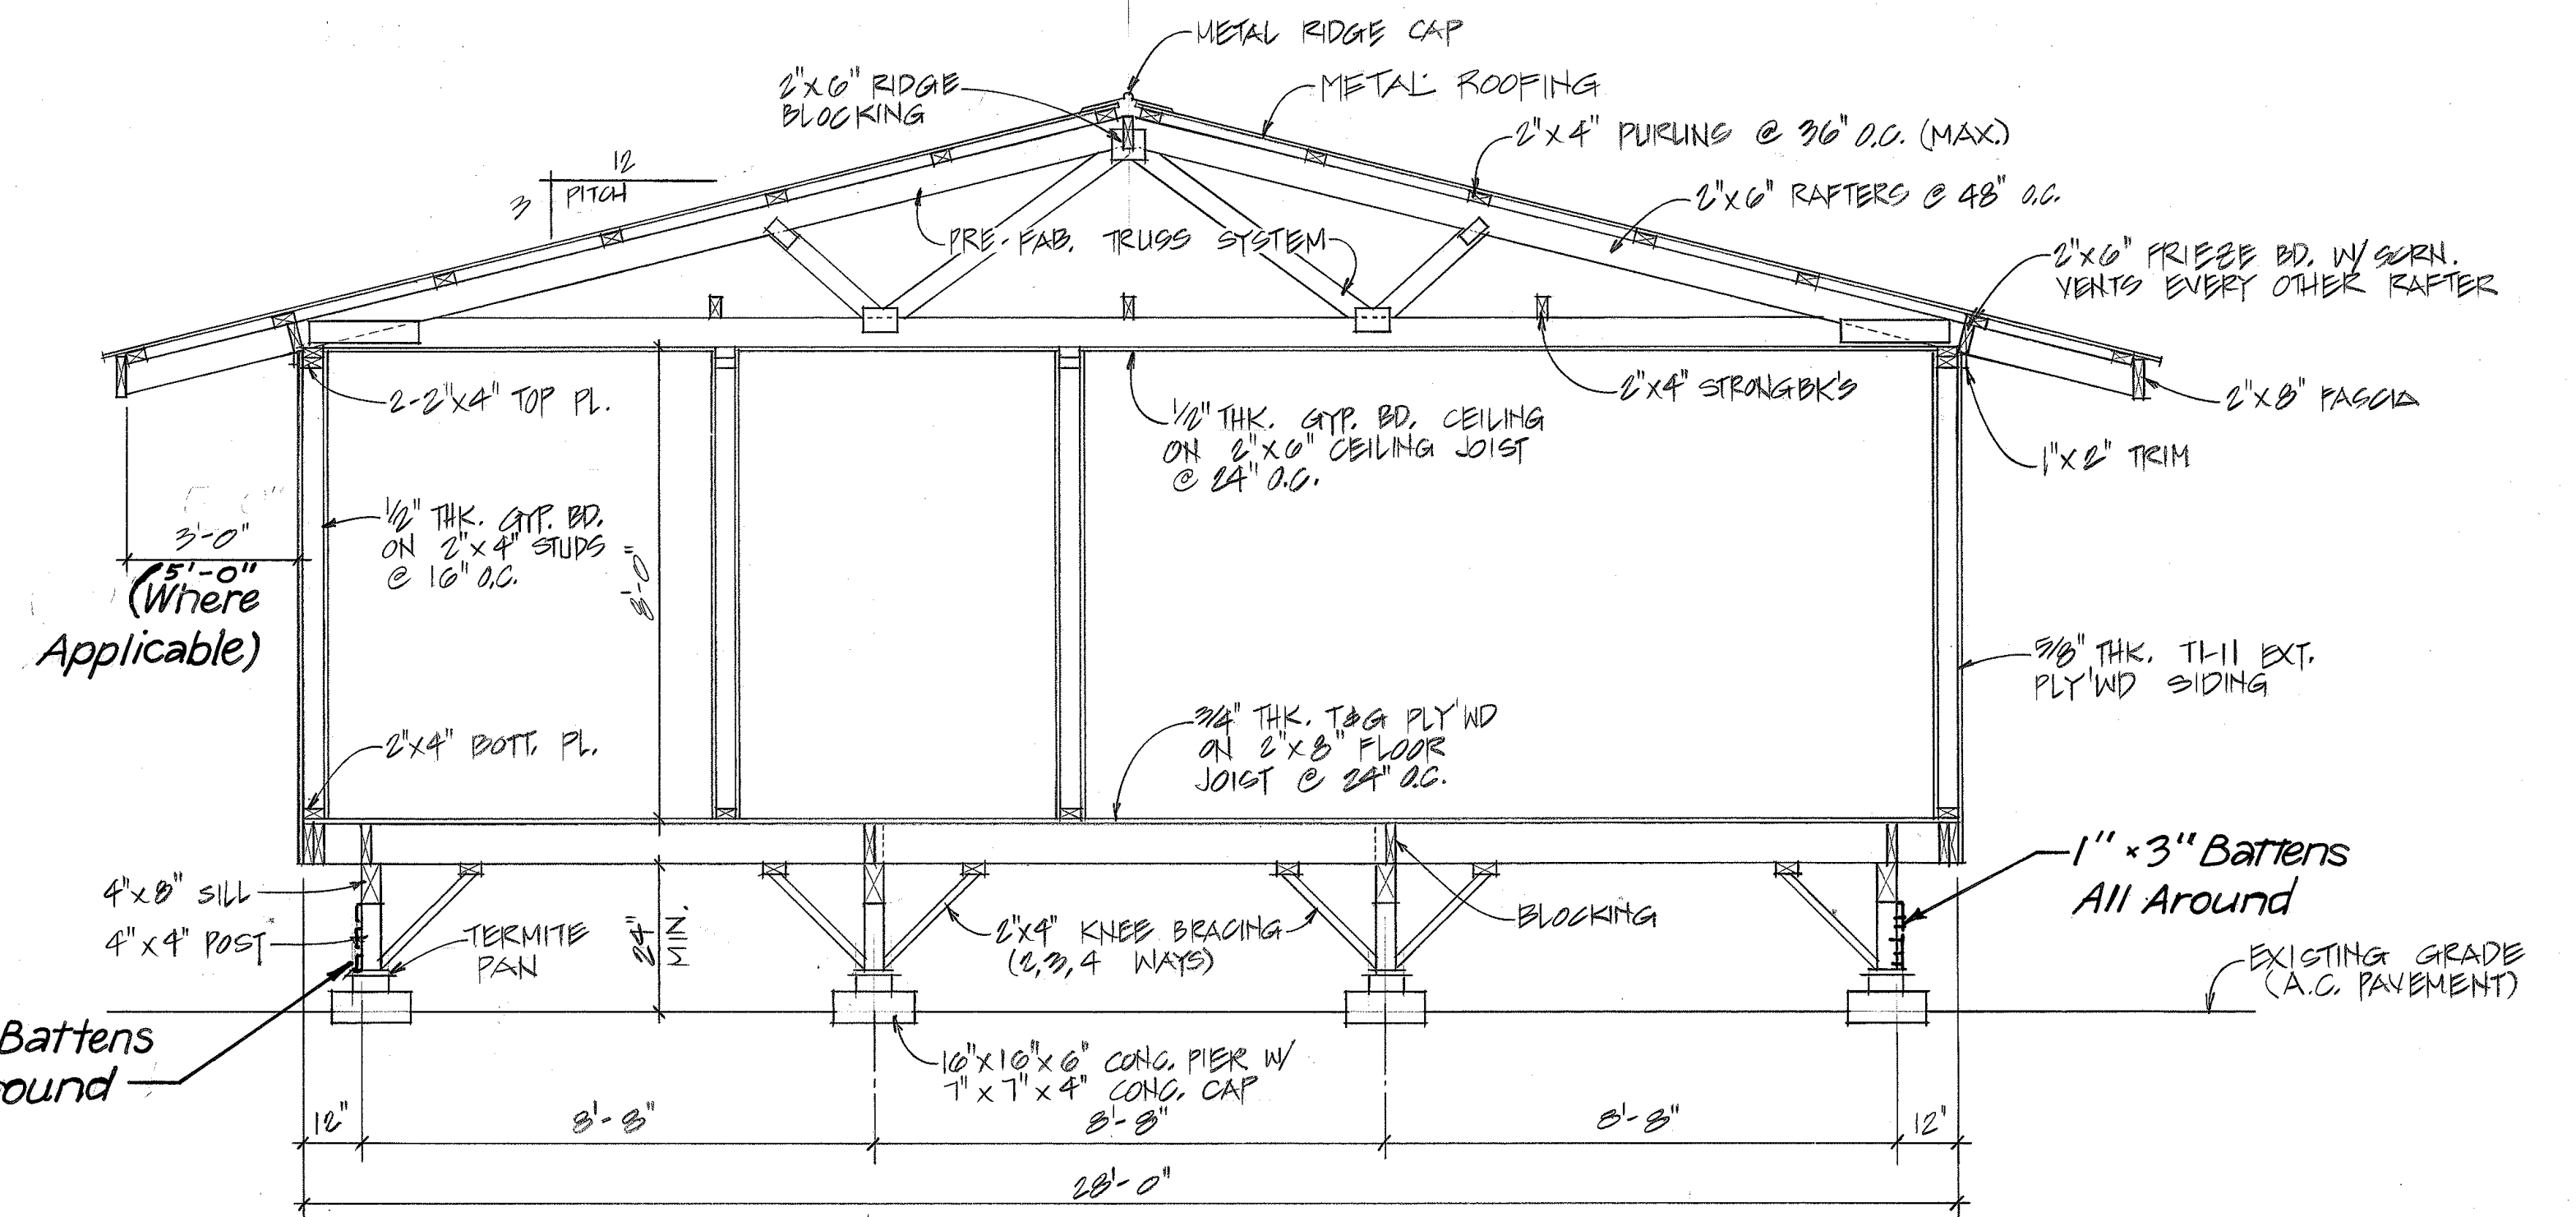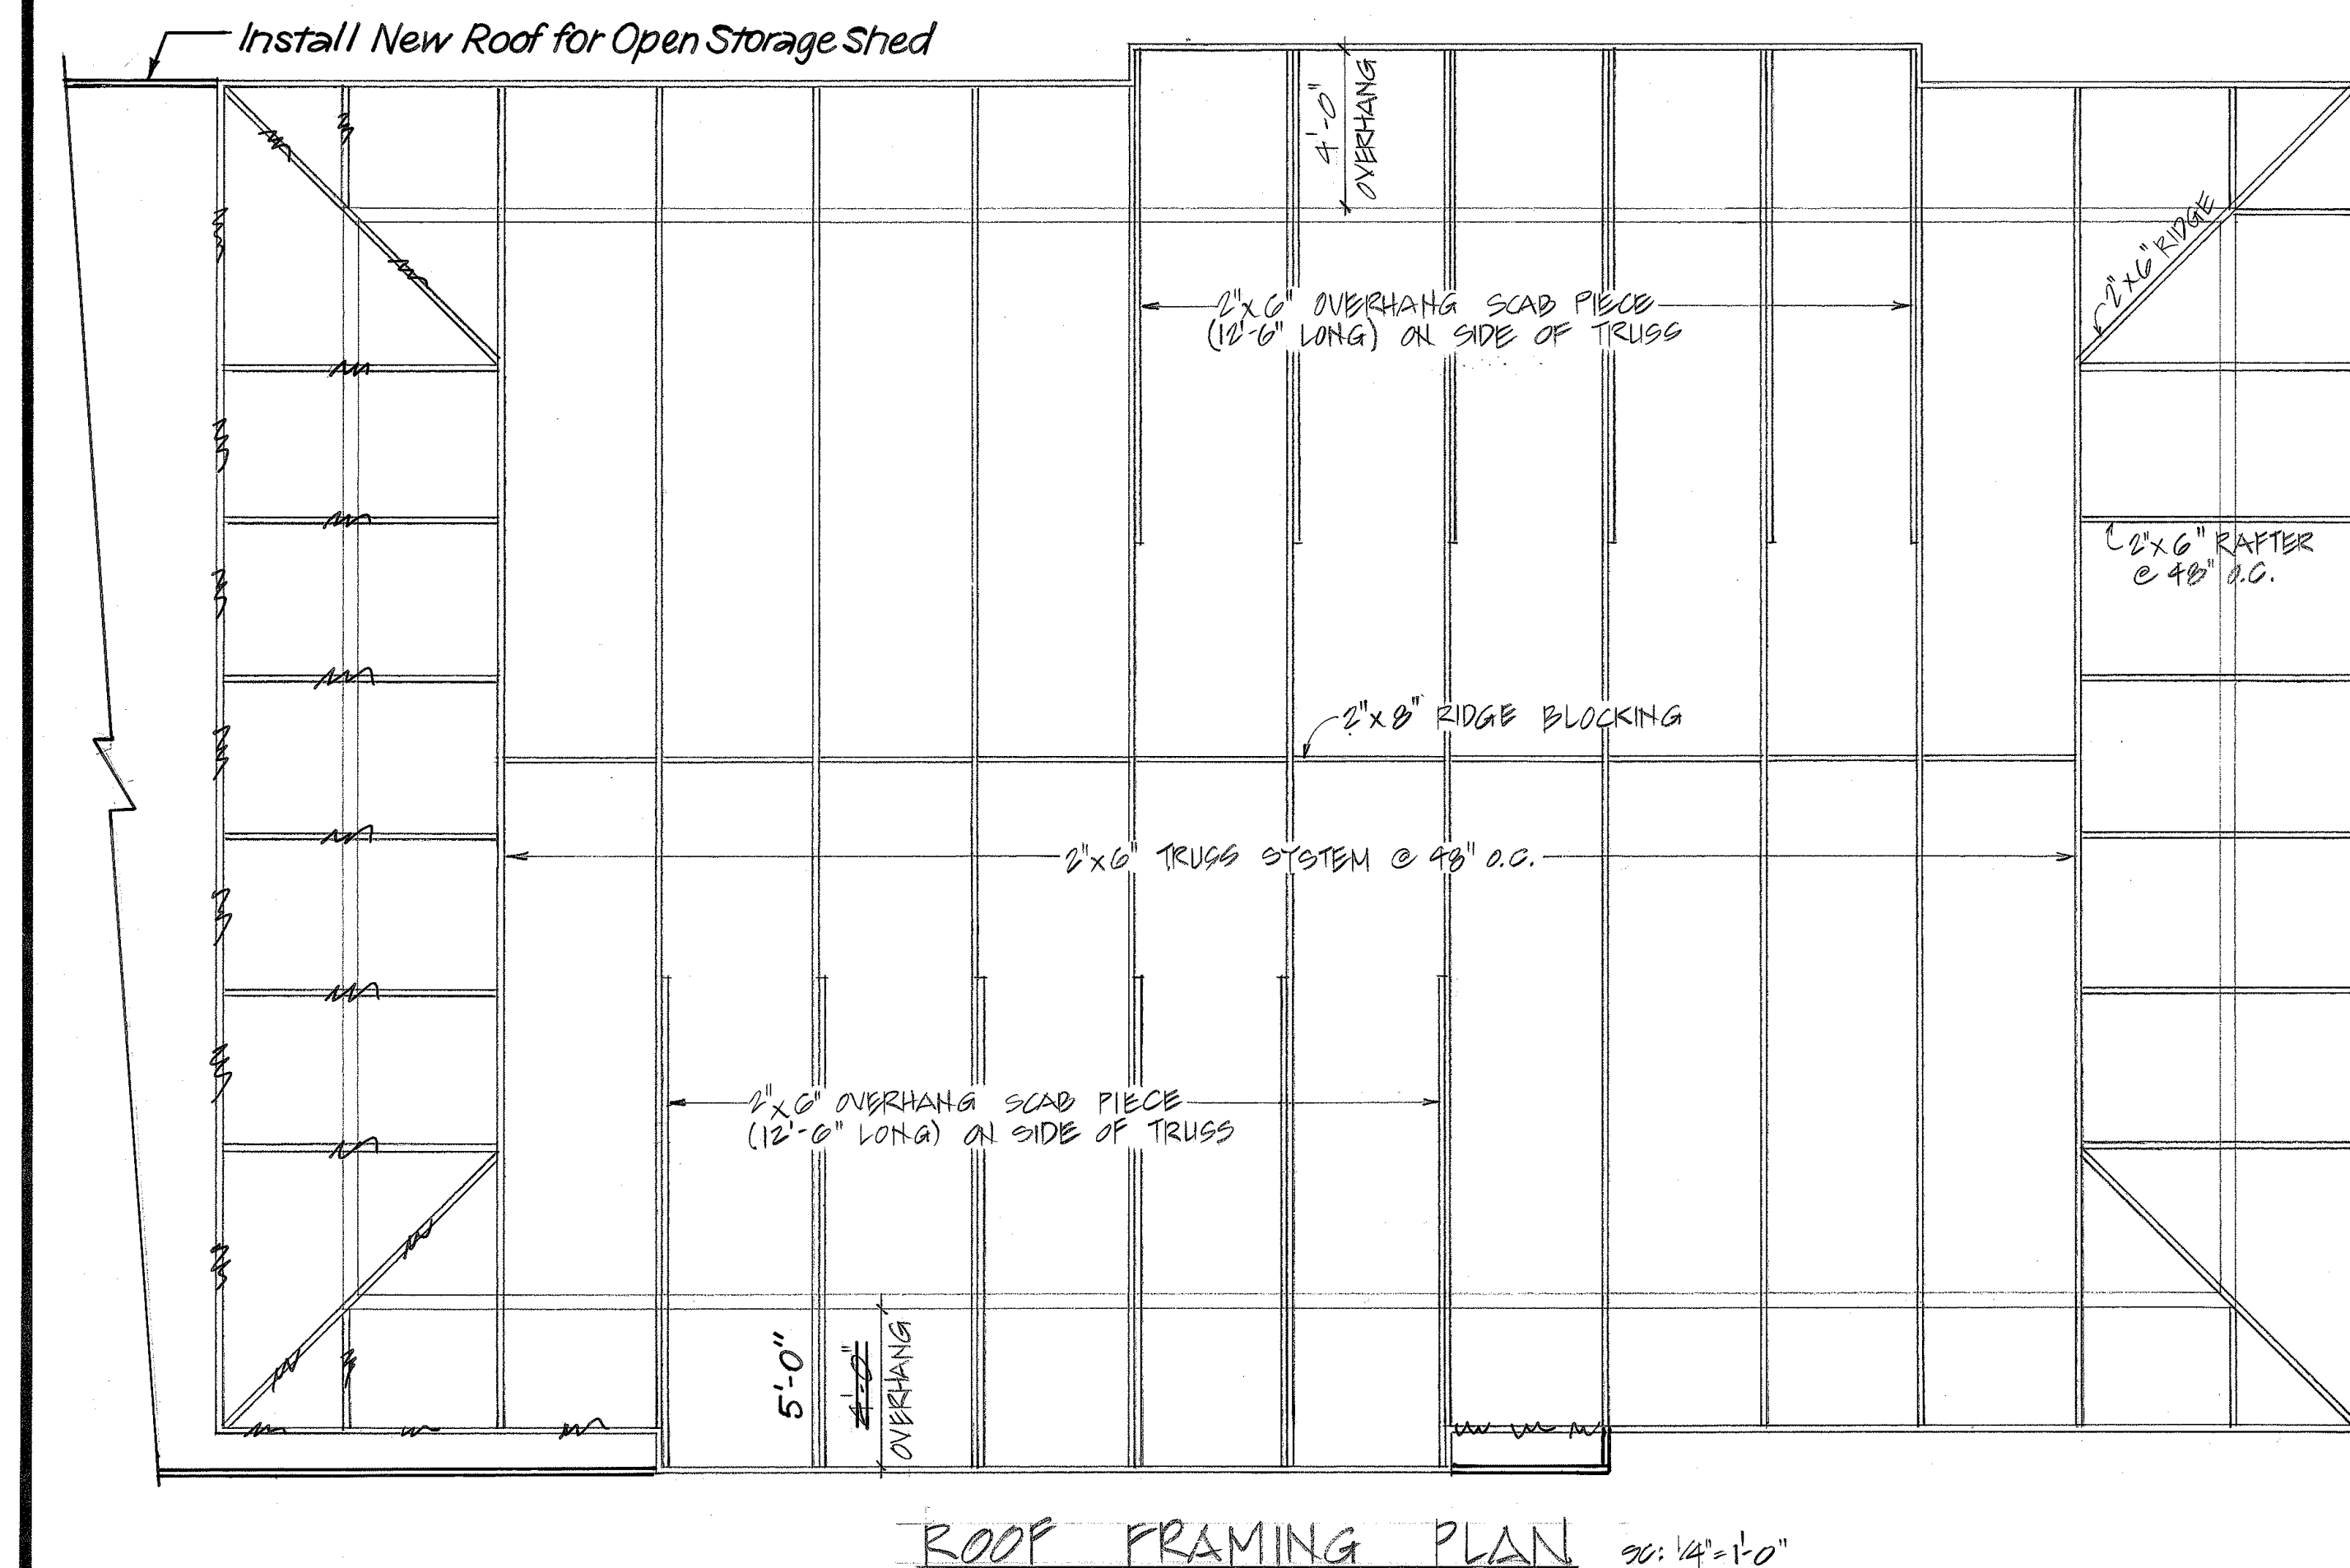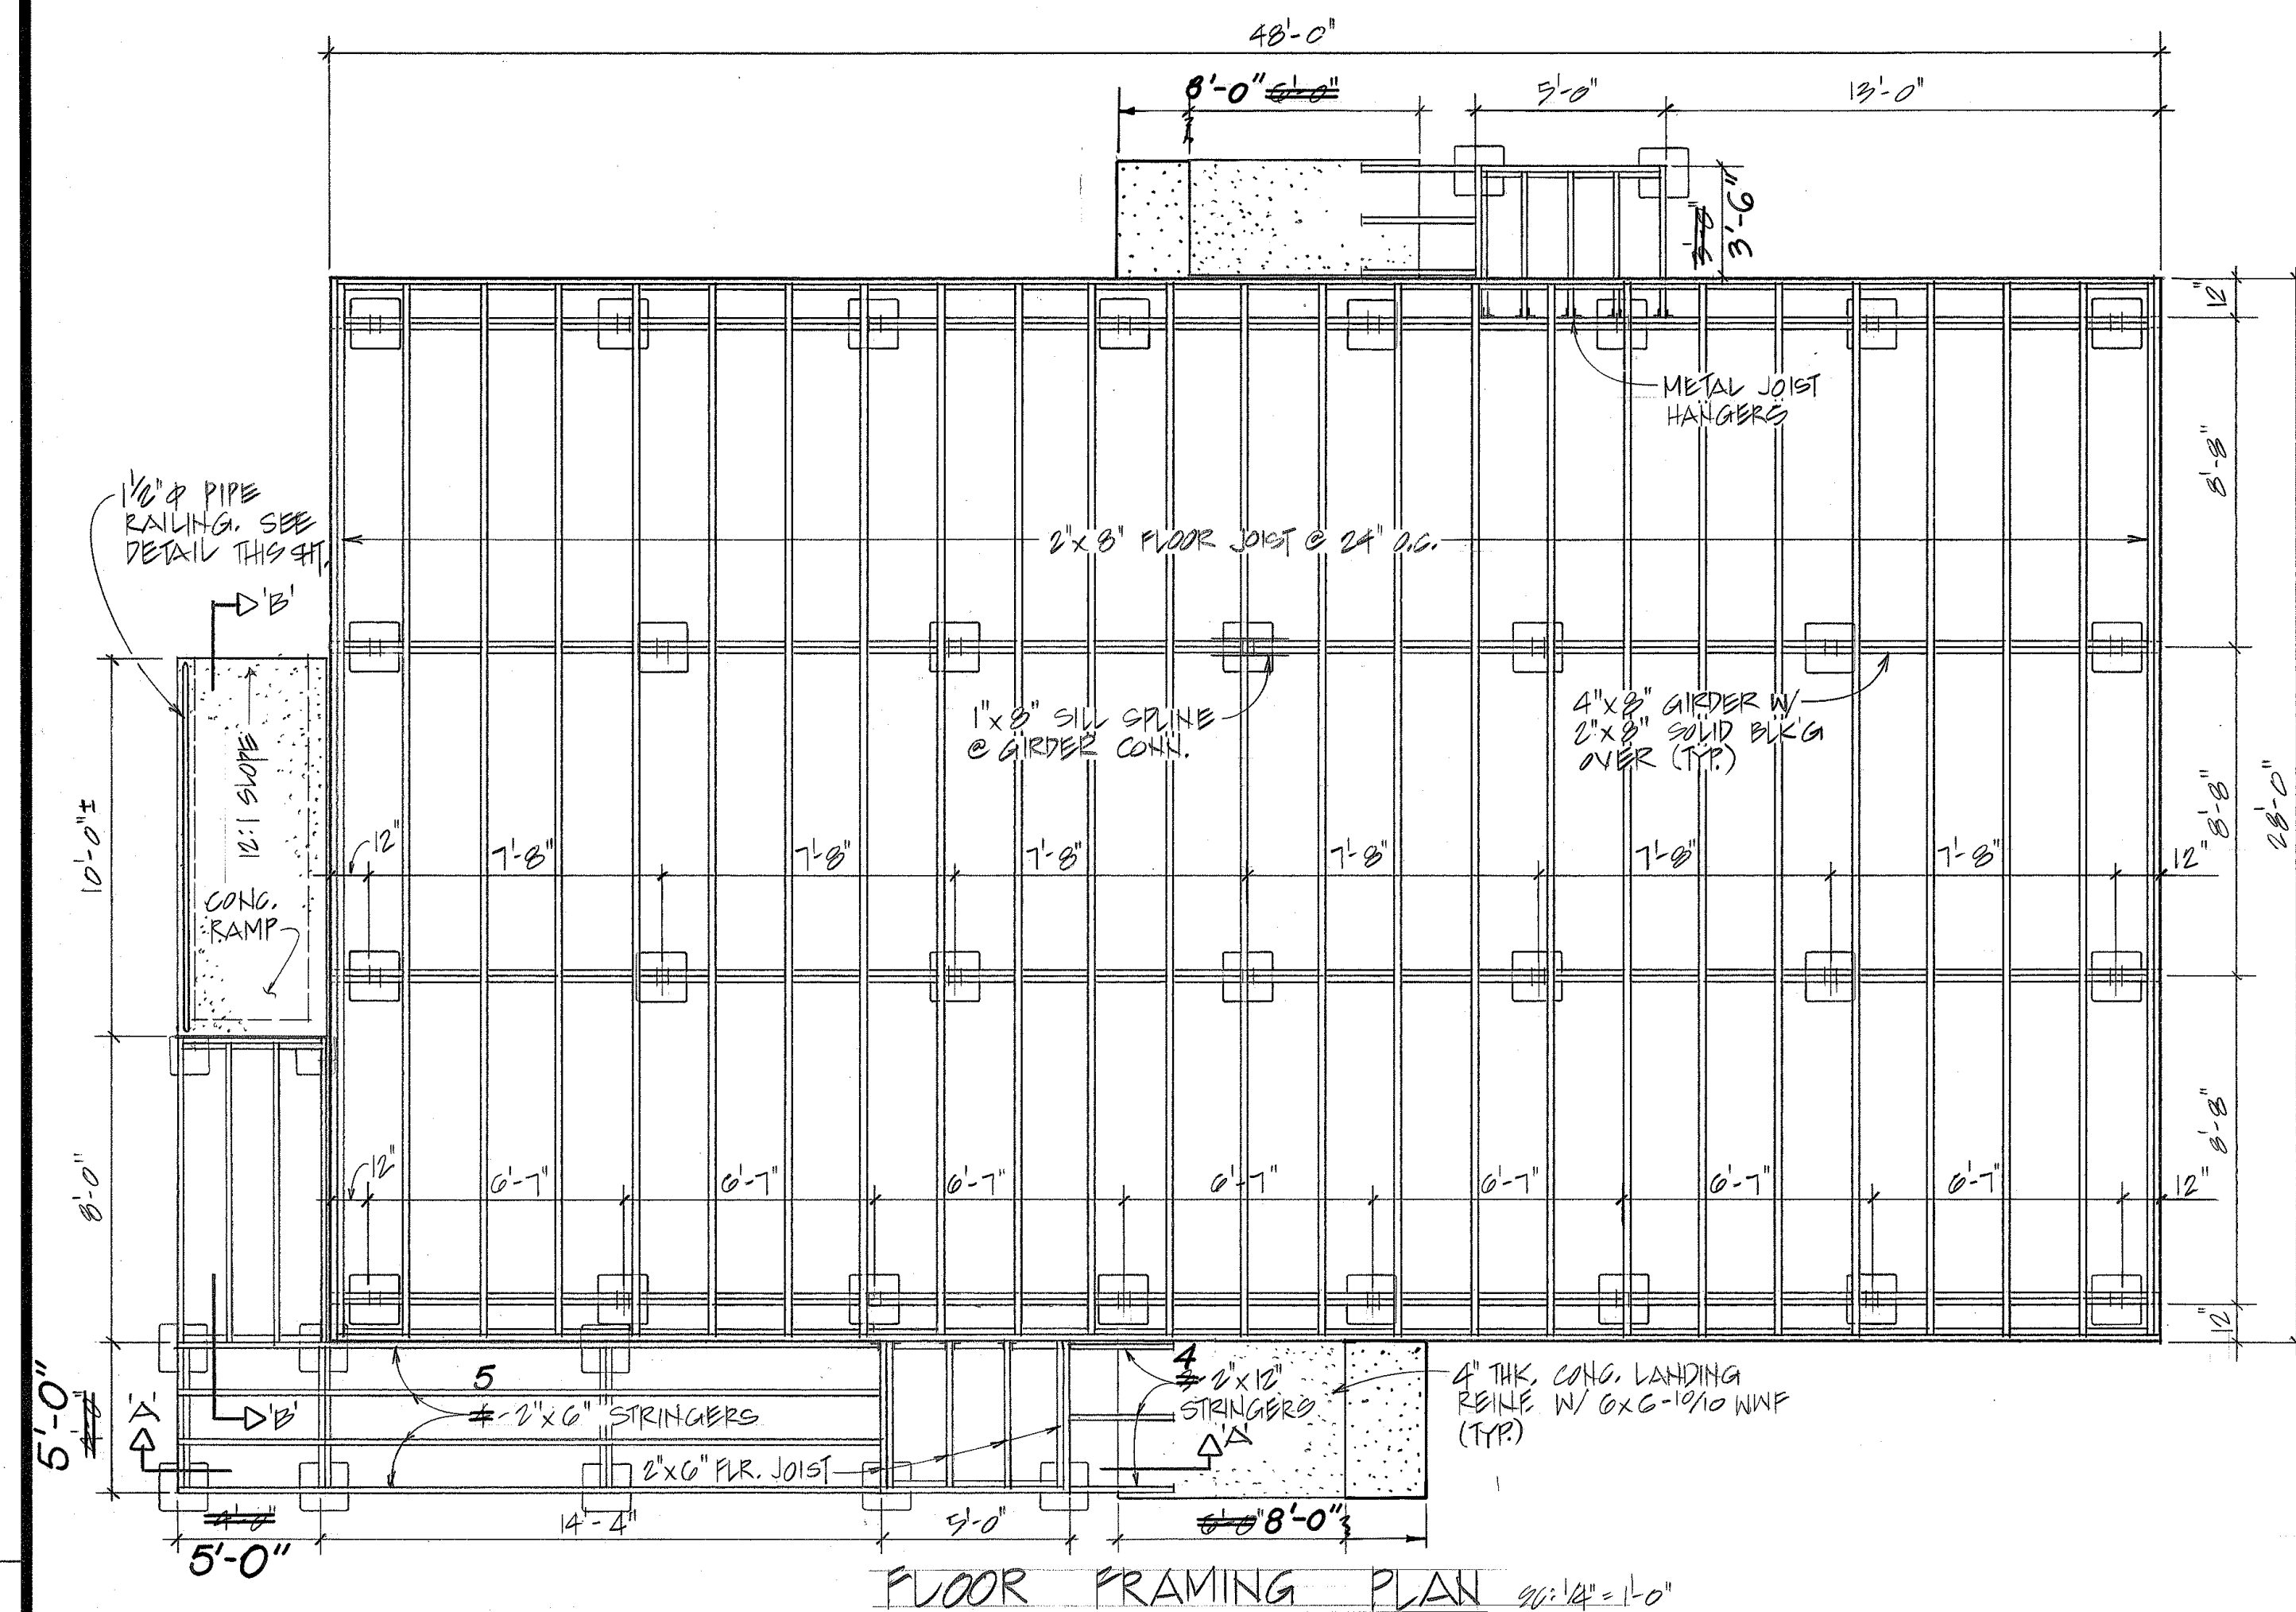

STATE OF HAWAII
DEPARTMENT OF TRANSPORTATION
HIGHWAYS DIVISION

NEW OFFICE BUILDING
FRAMING PLAN, DETAILS
& TYPICAL SECTIONS


HILO BASECAMP BUILDING 'D'
OFFICE RENOVATION
PROJ. NO. HNY-H-02-92M

SCALE: AS NOTED DATE: APRIL 1992

SHEET NO. 2 OF 3 SHEETS


"AS-BUILT"

FED. ROAD DIST. NO.	STATE	PROJ. NO.	FISCAL YEAR	SHEET NO.	TOTAL SHEETS
HAWAII	HAW.	HNY-H-02-92M	1992	6	11

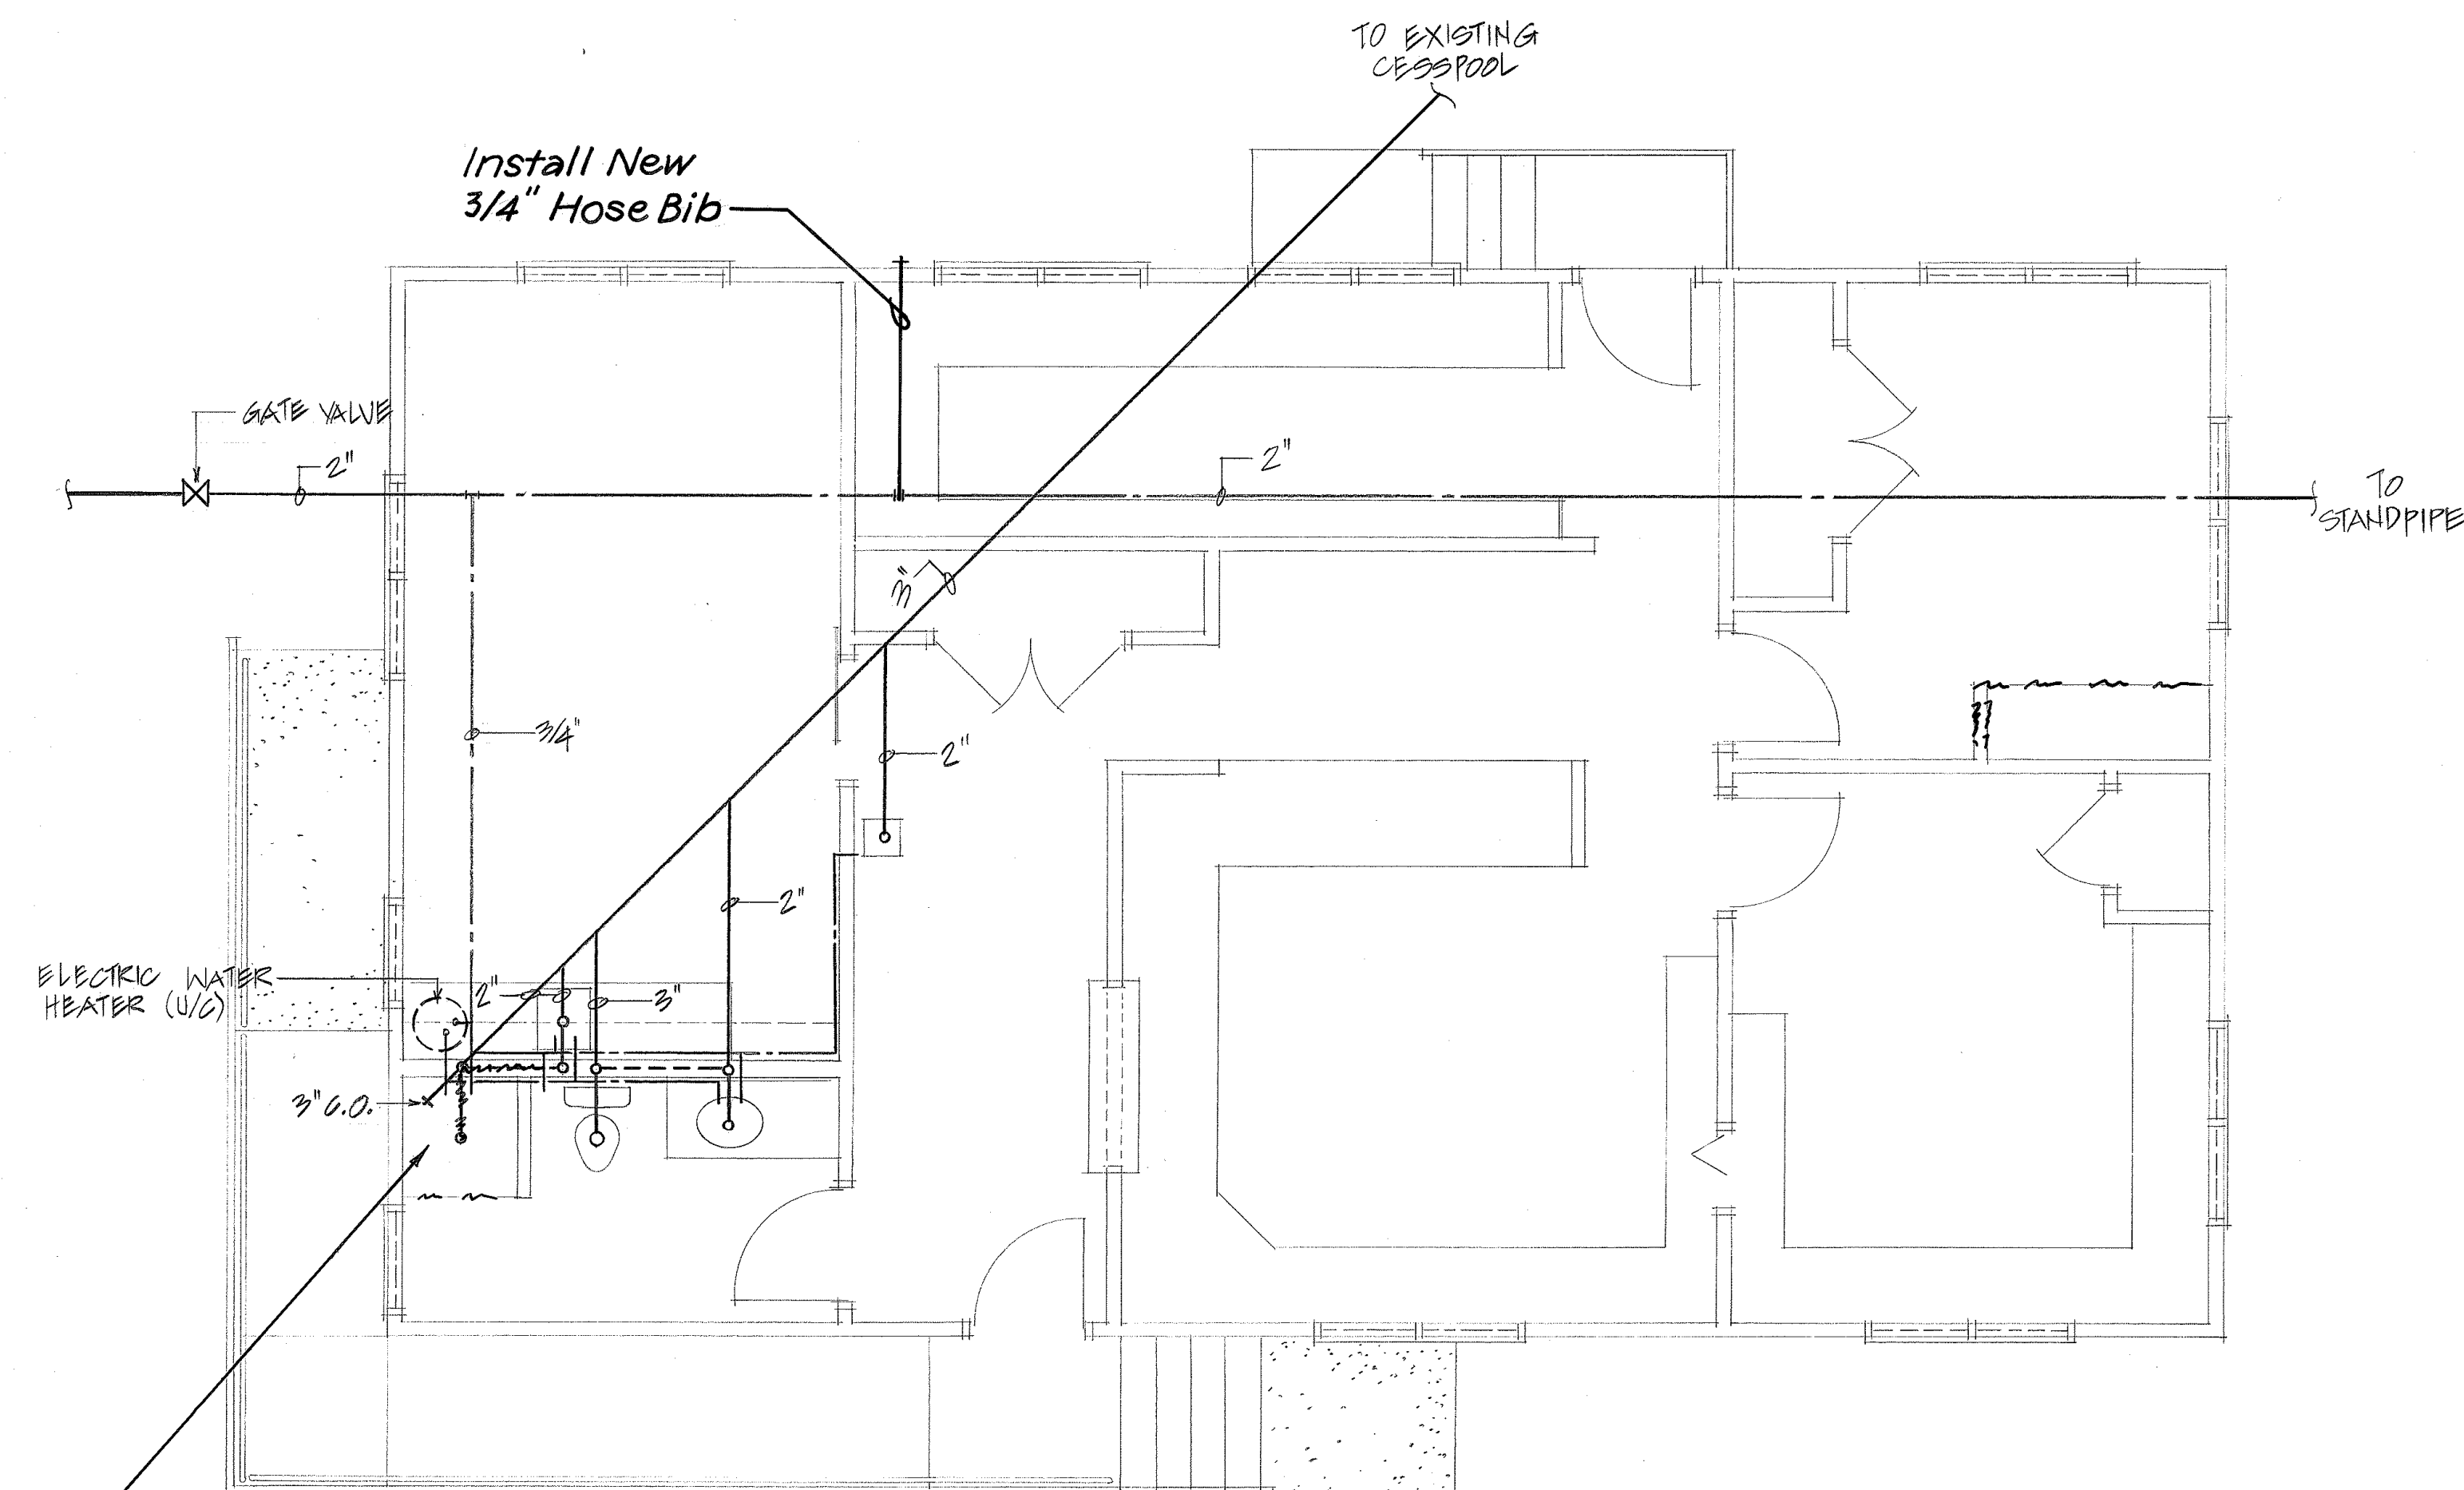


Note:
Refer to Floor Plan Sheet No. 4
for Revised Bathroom Layout

PLUMBING FLOOR PLAN 1/4"

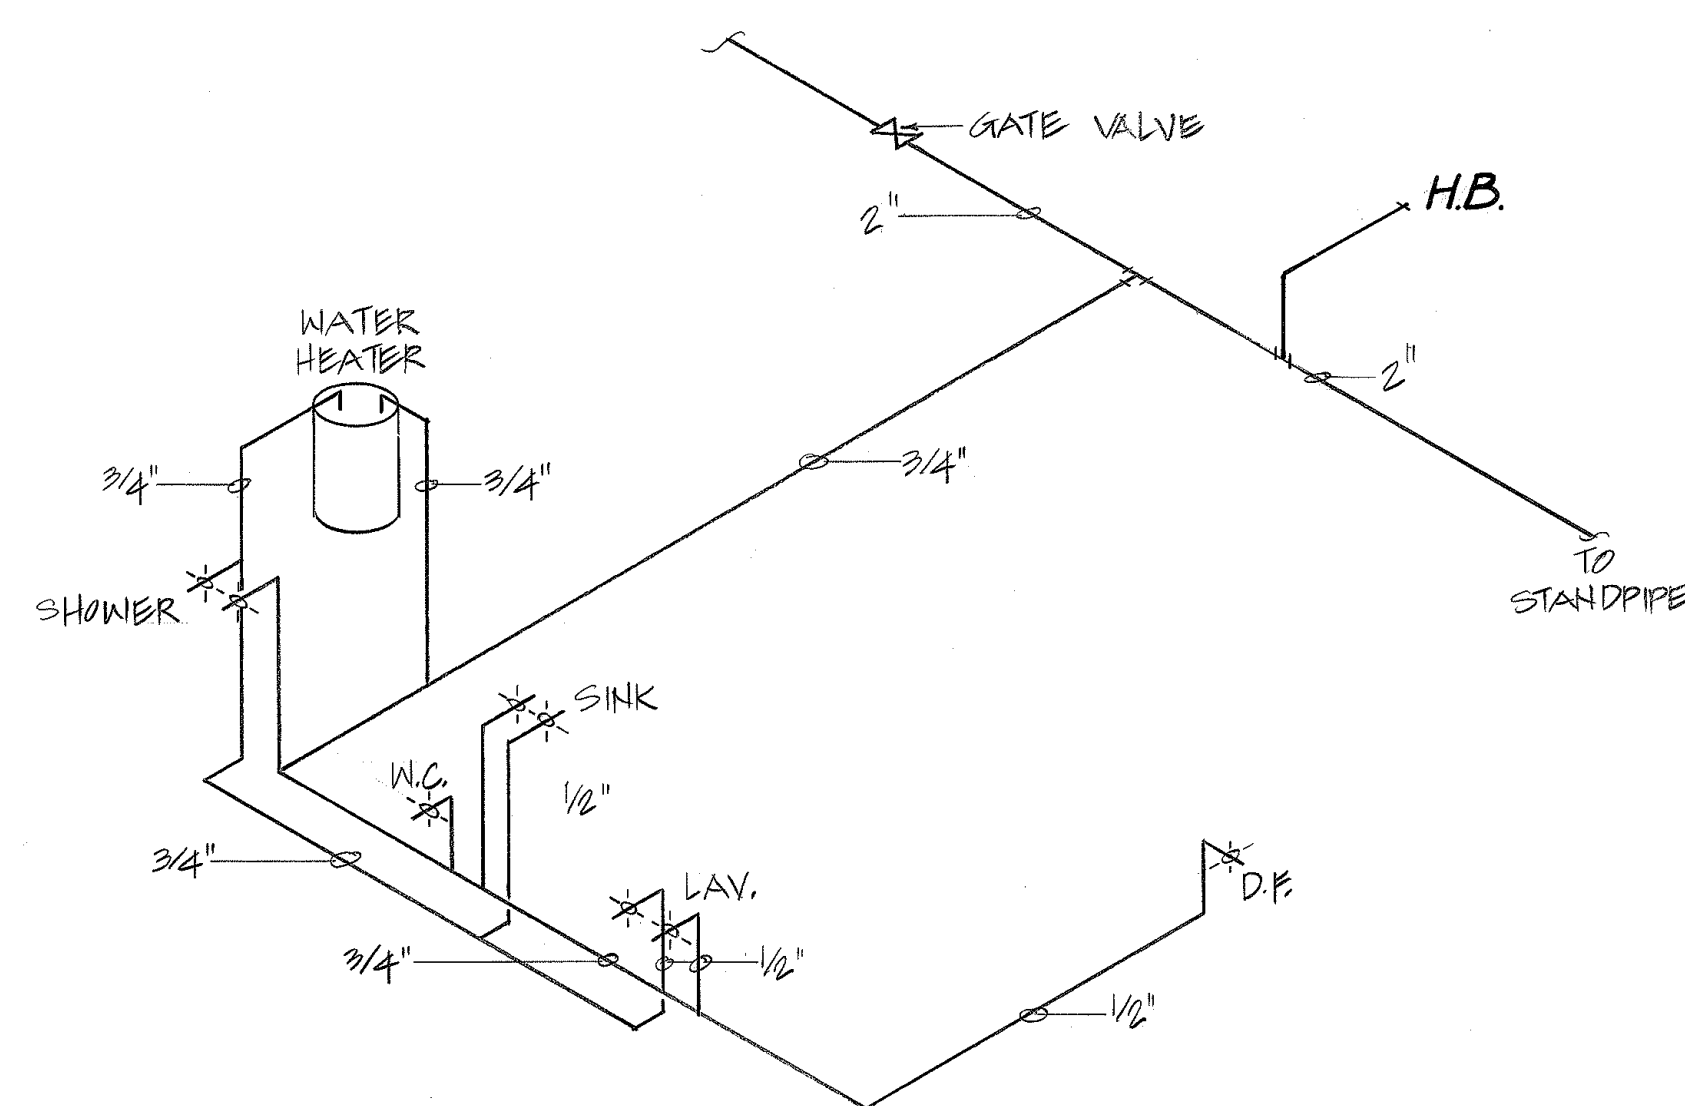

HOT & COLD WATER DIAGRAM
NOT TO SCALE

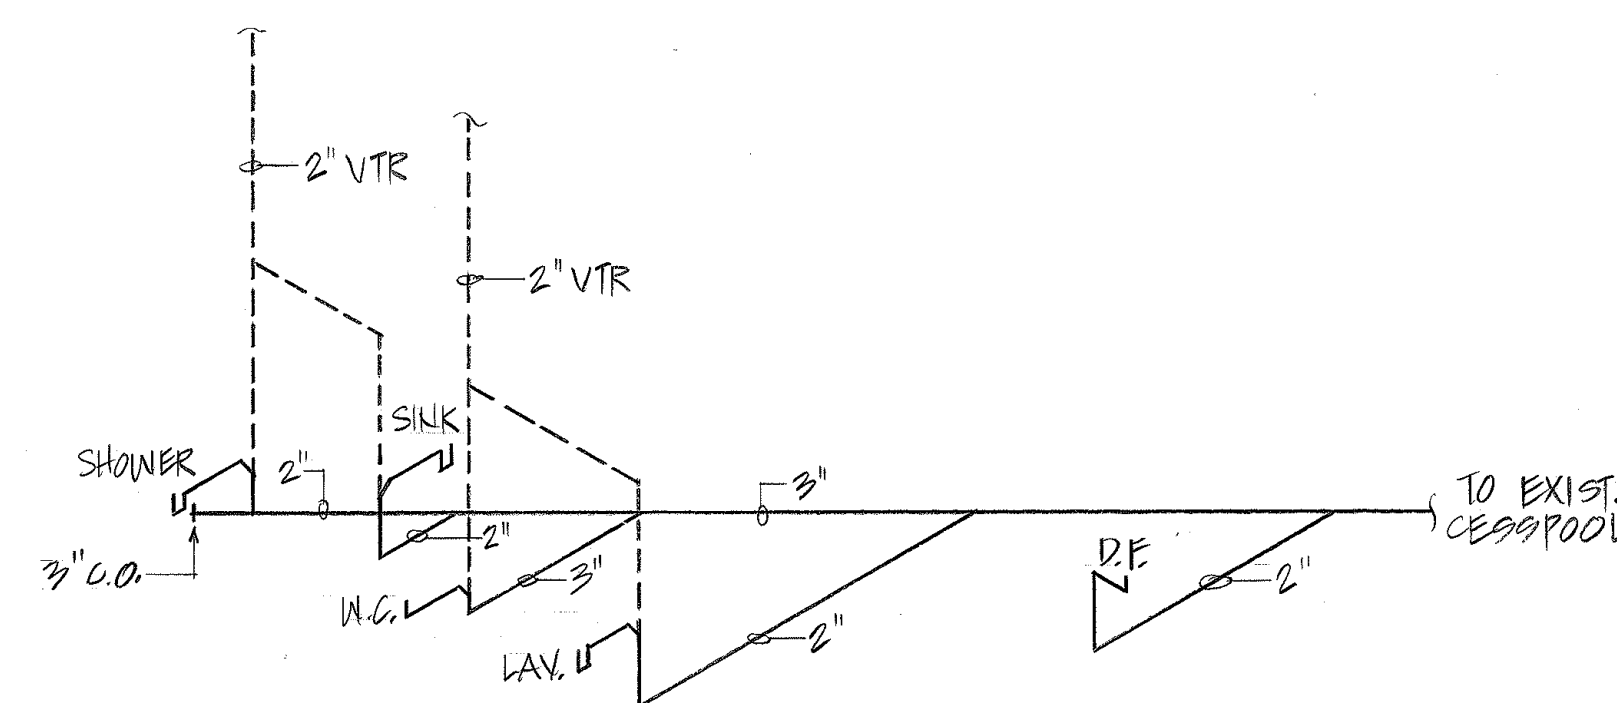

SANITARY PIPING DIAGRAM
NOT TO SCALE

SURVEY PLOTTED BY	DATE
DRAWN BY	
DESIGNED BY	
CHECKED BY	
ORIGINAL PLAN	
NOTE BOOK	
No.	

STATE OF HAWAII DEPARTMENT OF TRANSPORTATION HIGHWAYS DIVISION	
NEW OFFICE BUILDING	
PLUMBING PLAN & DIAGRAMS	
HILLO BAYVIEW BUILDING 'D' OFFICE RENOVATION PROJ. NO. HNY-H-02-92M	
SCALE: AS NOTED	DATE: APRIL 1992
SHEET NO. 3 OF 3 SHEETS	

"AS-BUILT"