



1
OVERALL ELECTRICAL SITE PLAN
E-2
SCALE: 1" = 20'-0"

NOTE:


- 1 PROVIDE PULL STRING IN TELECOM CONDUIT
- 2 REMOVE STUBUPS AT EXISTING GUARD SHACK TO 12" BELOW GRADE

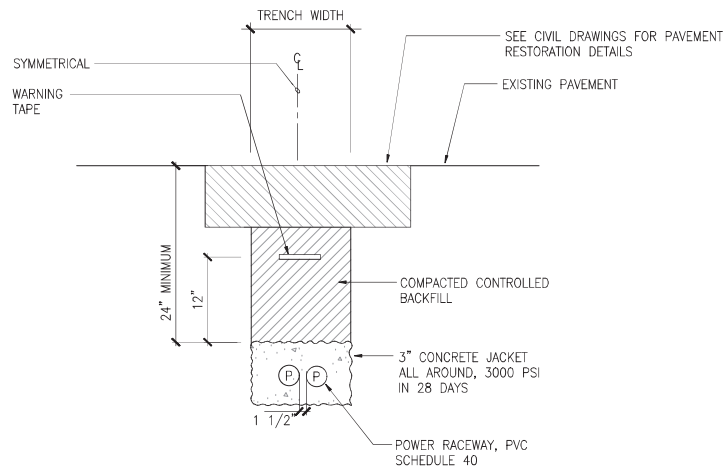

3
TYPICAL POWER CONCRETE ENCASED DUCT SECTION
E-2
NOT TO SCALE

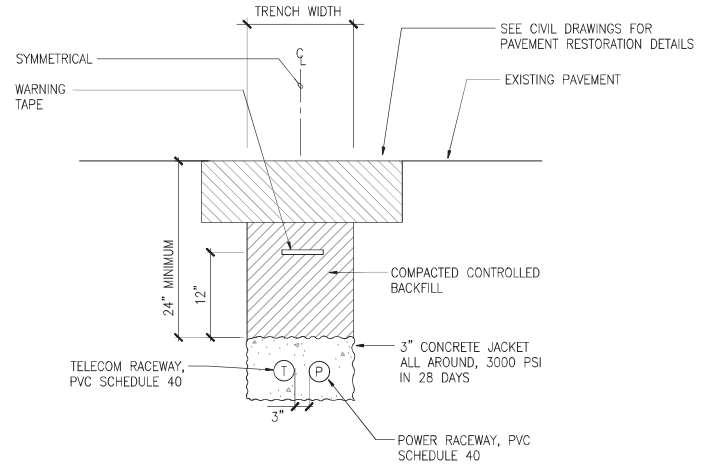

2
TYPICAL TELECOM AND POWER CONCRETE ENCASED DUCT SECTION
E-2
NOT TO SCALE

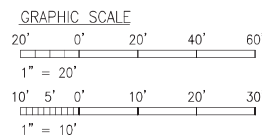

		STATE OF HAWAII DEPARTMENT OF TRANSPORTATION HARBORS DIVISION	
JOB TITLE REPAIR GUARD SHACK HILO HARBOR, HAWAII		SHEET TITLE OVERALL ELECTRICAL SITE PLAN, ENLARGED BUILDING PLAN	
DESIGNED BY AM	CHECKED BY IP	DATE FEB, 2023	SCALE AS NOTED
EXPIRATION DATE OF LICENSE APRIL 30, 2024		JOB NUMBER H.C. 50173	SHEET E-2 21 of 22 SHEETS