
 
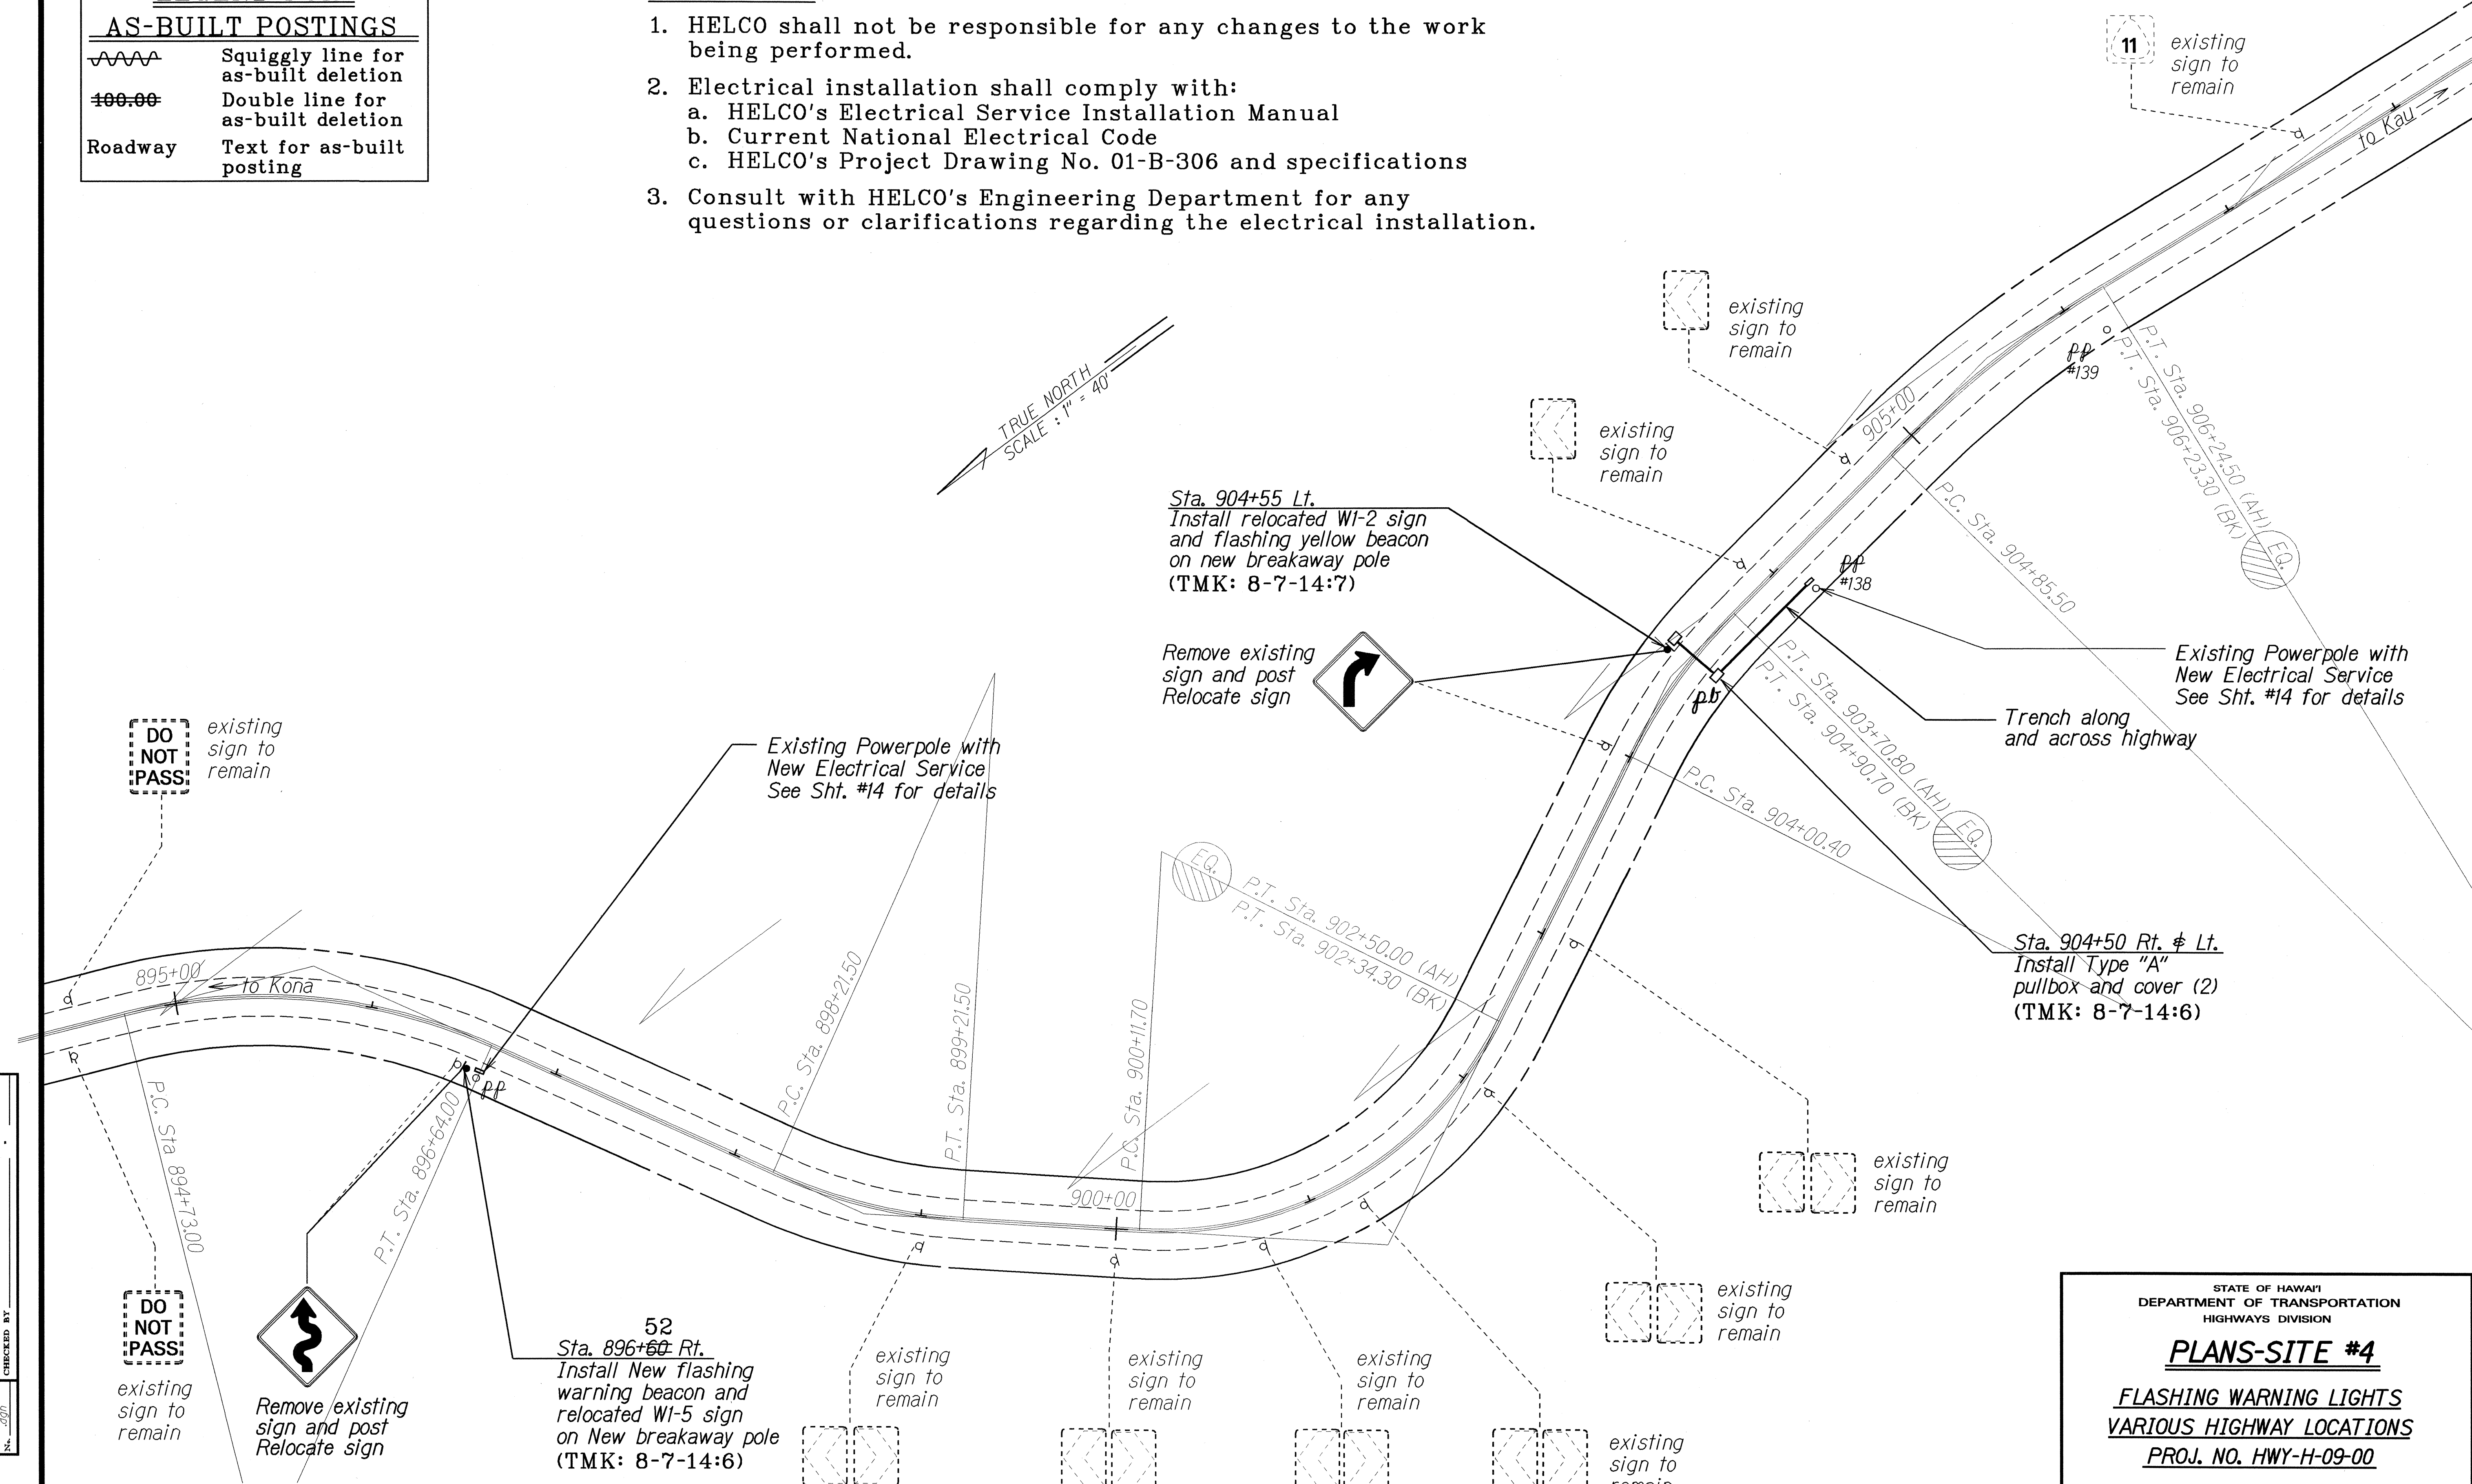


FED. ROAD DIST. NO.	STATE	PROJ. NO.	FISCAL YEAR	SHEET NO.	TOTAL SHEETS
HAWAII	HAW.	HWY-H-09-00	2000	8	15

LEGEND FOR AS-BUILT POSTINGS	
	Squiggly line for as-built deletion
	Double line for as-built deletion
Roadway	Text for as-built posting

HELCO NOTES

- HELCO shall not be responsible for any changes to the work being performed.
- Electrical installation shall comply with:
 - HELCO's Electrical Service Installation Manual
 - Current National Electrical Code
 - HELCO's Project Drawing No. 01-B-306 and specifications
- Consult with HELCO's Engineering Department for any questions or clarifications regarding the electrical installation.




SURVEY PLOTTED BY	DATE
DRAWN BY	
DESIGNED BY	
NOTED BY	
CHECKED BY	

STATE OF HAWAII
 DEPARTMENT OF TRANSPORTATION
 HIGHWAYS DIVISION


PLANS-SITE #4
FLASHING WARNING LIGHTS
VARIOUS HIGHWAY LOCATIONS
 PROJ. NO. HWY-H-09-00
 Scale: Noted Date: April, 2000
 SHEET No. 1 OF 1 SHEETS

FED. ROAD DIST. NO.	STATE	PROJ. NO.	FISCAL YEAR	SHEET NO.	TOTAL SHEETS
HAWAII	HAW.	HWY-H-09-00	2000	9	15

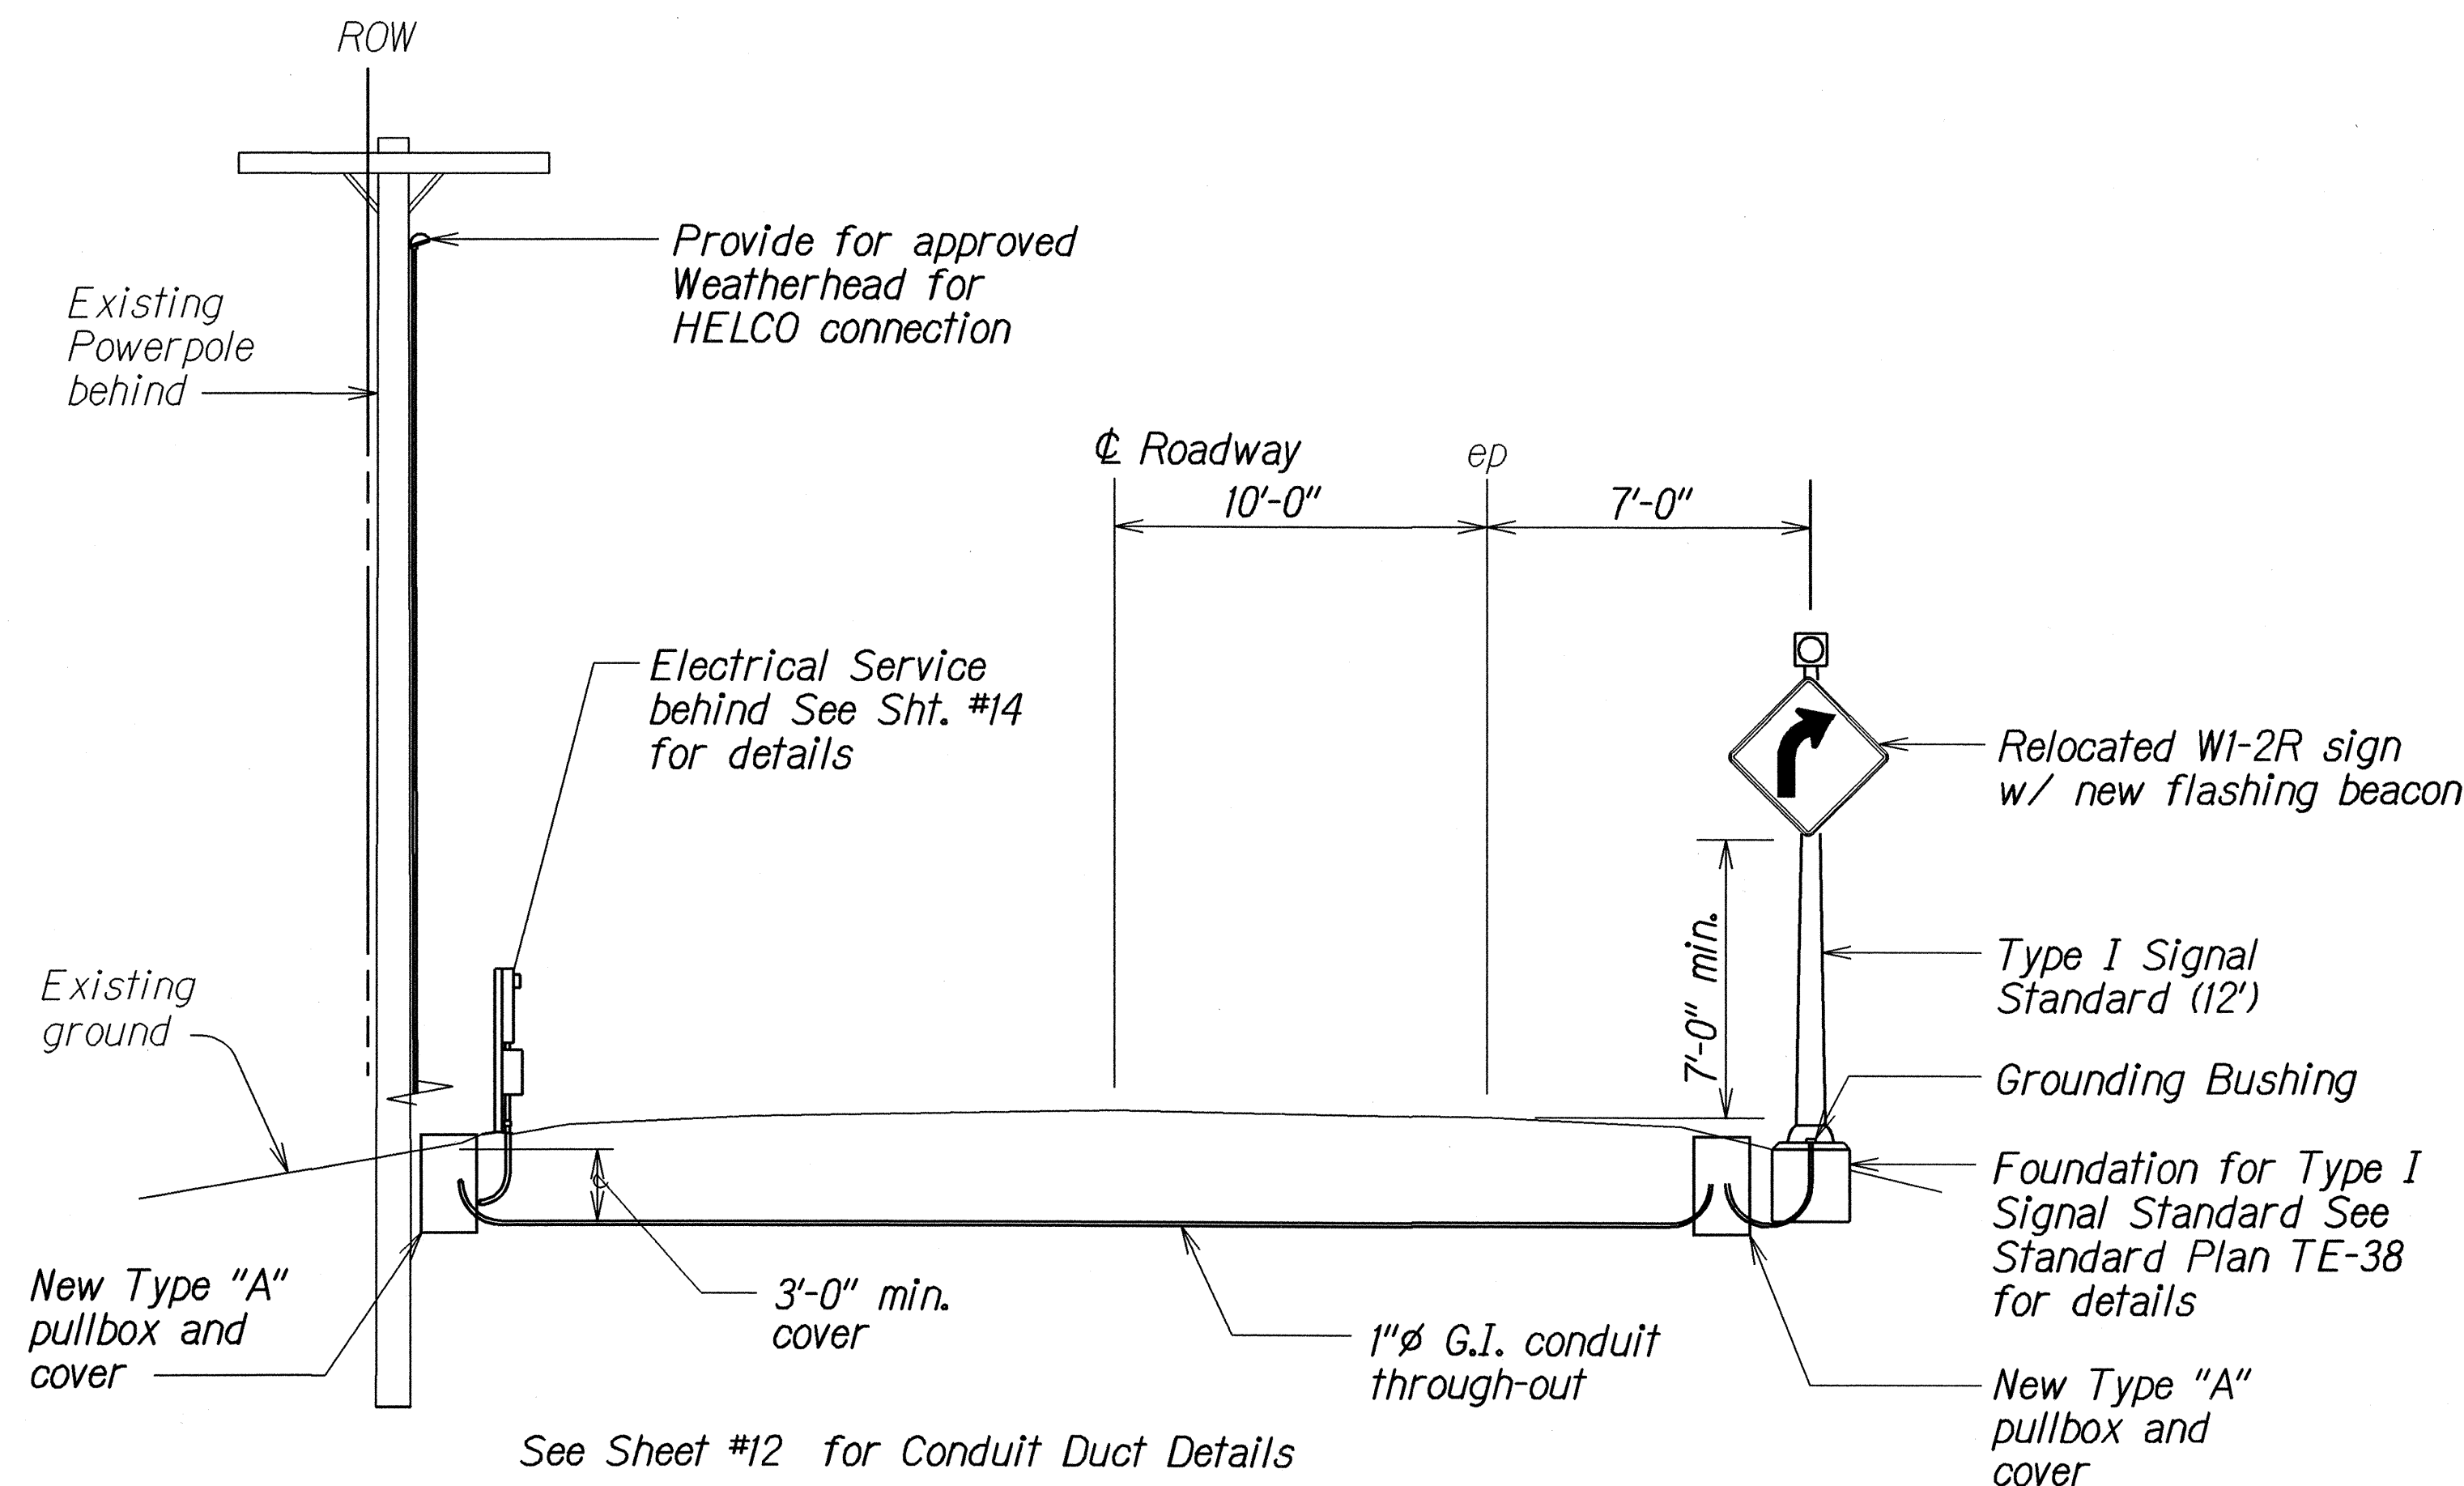


SECTION AT STA. 904+55
Scale: None

Note:
Section looking North

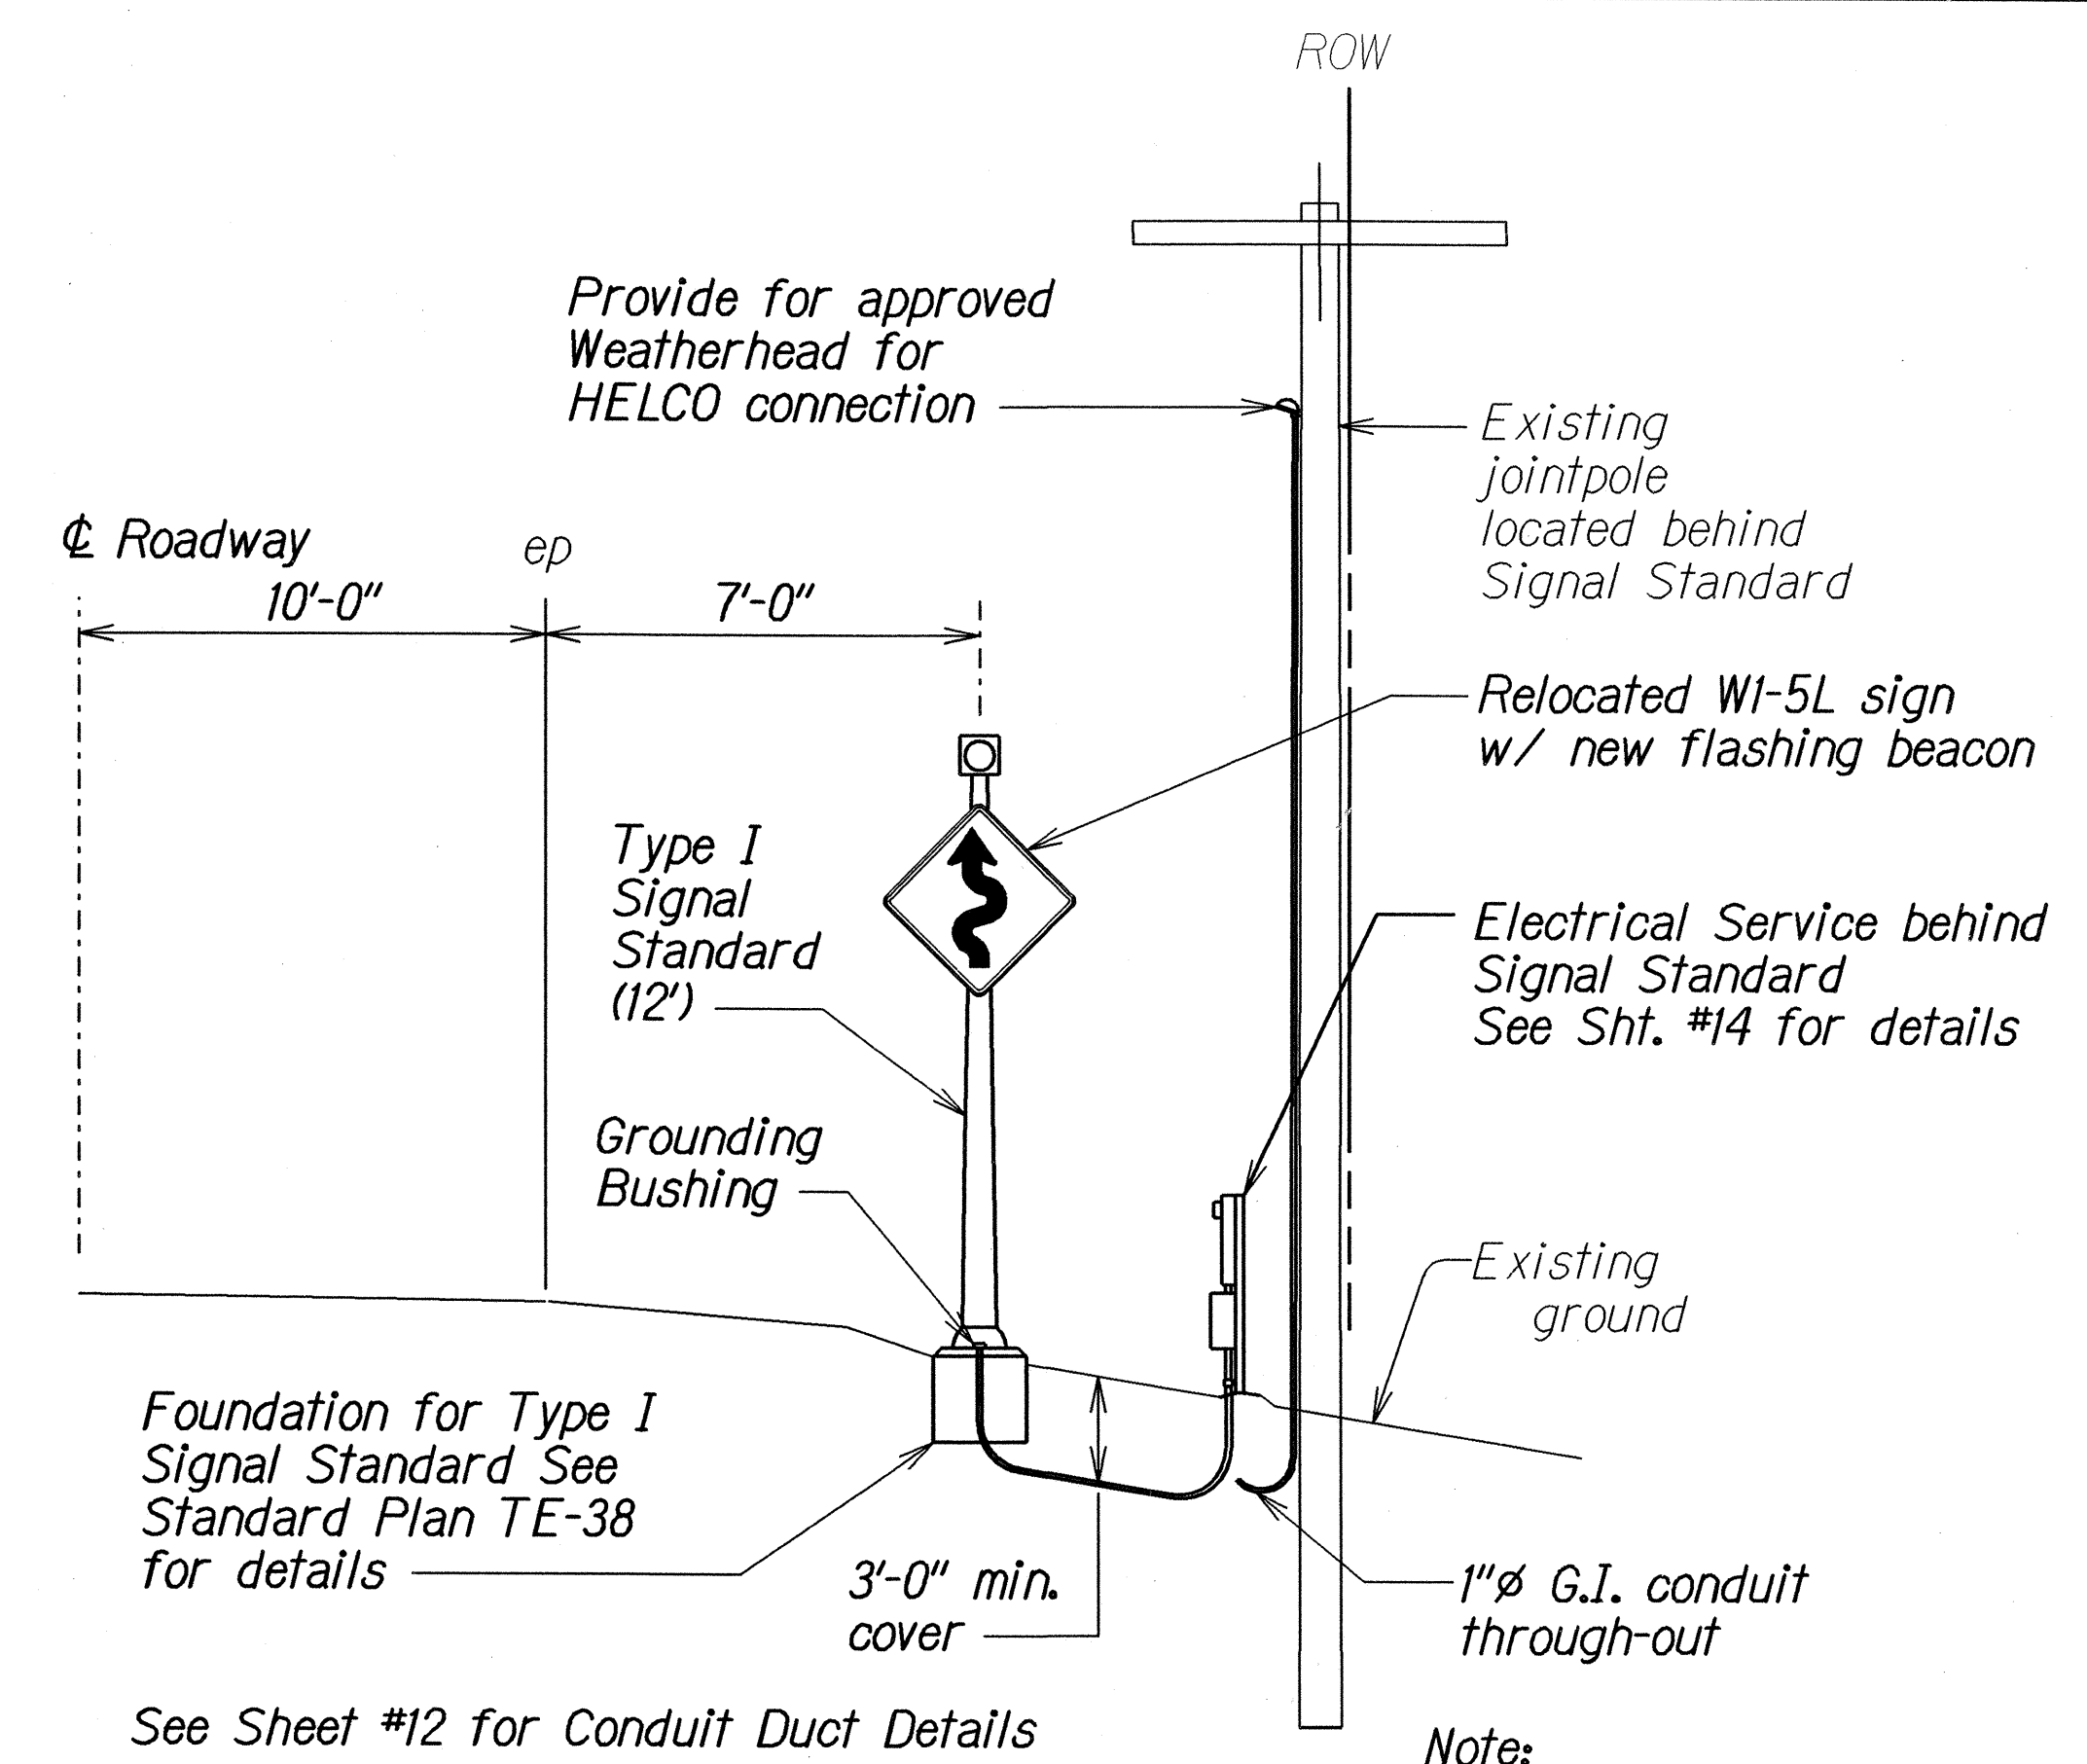

SECTION AT STA. 896+60
Scale: None

Note:
Section looking South

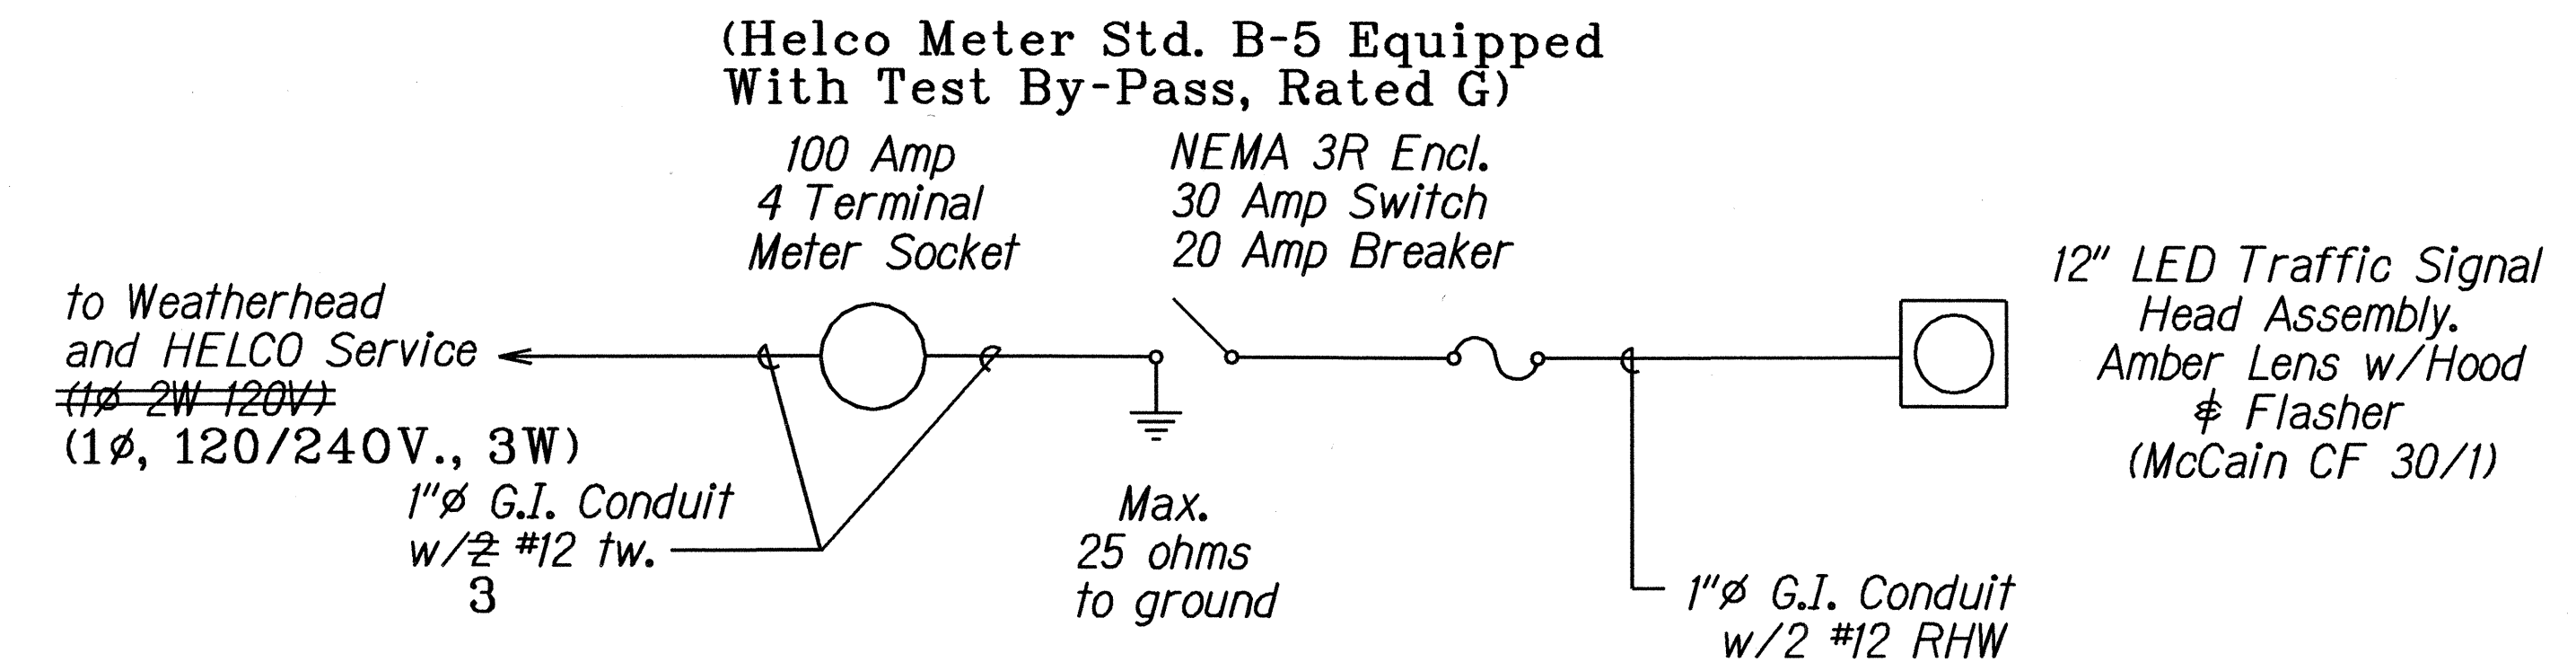

ONE LINE DIAGRAM
Scale: None

HELCO NOTES

- HELCO shall not be responsible for any changes to the work being performed.
- Electrical installation shall comply with:
 - HELCO's Electrical Service Installation Manual
 - Current National Electrical Code
 - HELCO's Project Drawing No. 01-B-306 and specifications
- Consult with HELCO's Engineering Department for any questions or clarifications regarding the electrical installation.

LEGEND FOR AS-BUILT POSTINGS	
	Squiggly line for as-built deletion
	Double line for as-built deletion
Roadway	Text for as-built posting

STATE OF HAWAII
DEPARTMENT OF TRANSPORTATION
HIGHWAYS DIVISION

DETAILS-SITE #4
FLASHING WARNING LIGHTS
VARIOUS HIGHWAY LOCATIONS
PROJ. NO. HWY-H-09-00
Scale: Noted
Date: April, 2000