

FED. ROAD DIST. NO.	STATE	FED. AID PROJ. NO.	FISCAL YEAR	SHEET NO.	TOTAL SHEETS
HAWAII	HAW.	CMAQ-0100(62)	2004	53	86

Note:
For All Meter Boxes That Shall Be Relocated/Adjusted, The Contractor Shall Verify The Meter Box Type And Replace Any That is Not a Type "X" To a Type "X" Meter Box, See DWS Det. M3.


Adjust Water Meter Box, Frame and Cover to be Flush with New Finish Grade (Typ.), See Det.

Conc. Curb Ramp See Det.

T.M.K.: 3RD DIV.
5-3-10:56
NEW HALAULA SCHOOL

I:\2000\2000-070\000 PROJECT POINT - PEDESTRIAN ACCESSIBILITY\DRAWINGS\PLAN\G-SP0021_KAPAAU.DWG 05/13/02 16:04 MTM



ORIGINAL PLAN	DATE
DESIGNED BY	9/2004
DRAWN BY	9/2004
CHECKED BY	9/2004
NOTED BY	9/2004
DATE	9/2004

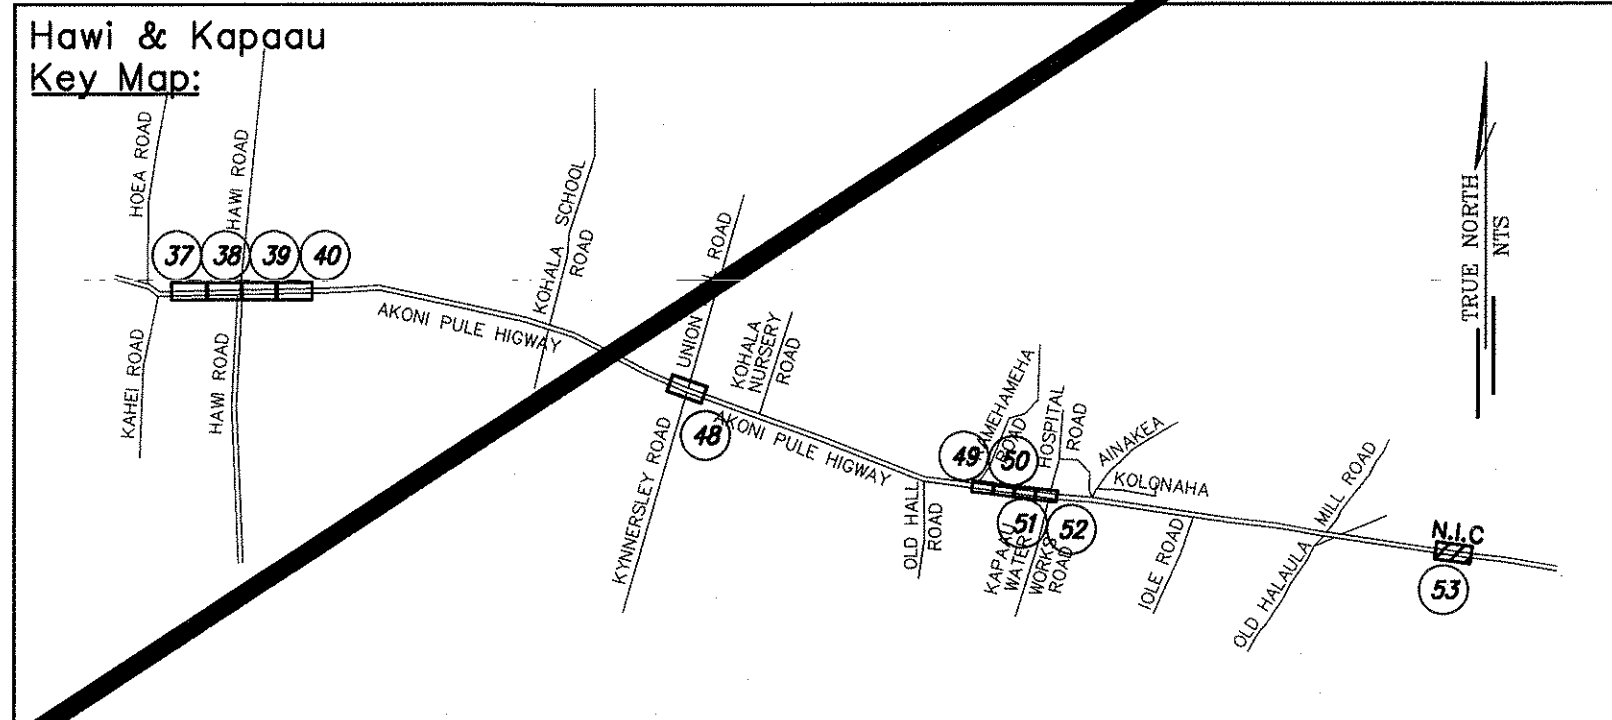

- Legend:
- AC Pavement & AC Driveway Repair
 - Concrete Sidewalk & Concrete Driveway Repair

SITE PLAN - KAPAAU

SCALE: 1" = 10'

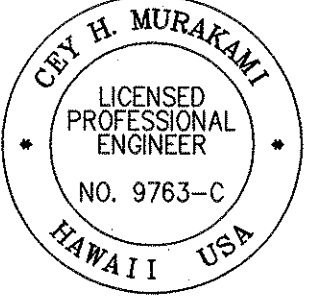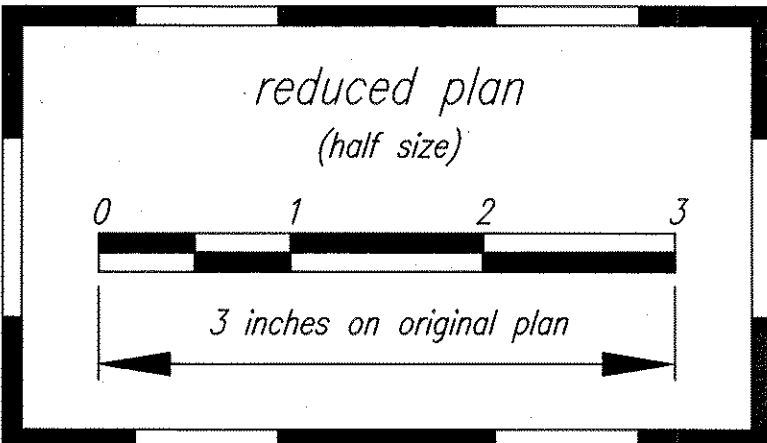

THIS WORK WAS PREPARED BY ME OR UNDER MY SUPERVISION

Cey H. Murakami 04/30/06
SIGNATURE EXPIRATION DATE OF THE LICENSE

STATE OF HAWAII
DEPARTMENT OF TRANSPORTATION
HIGHWAYS DIVISION
SITE PLAN - KAPAAU
AKONI PULE HIGHWAY
PEDESTRIAN ACCESSIBILITY ROUTE
IMPROVEMENTS - HONOKAA, HAWAII, AND KAPAAU
Federal Aid Project No. CMAQ-0100(62)
Scale: AS NOTED Date: SEPT. 2004