


FED. ROAD DIST. NO.	STATE	PROJ. NO.	FISCAL YEAR	SHEET NO.	TOTAL SHEETS
HAWAII	HAW.	11BC-02-01	2003	7	13

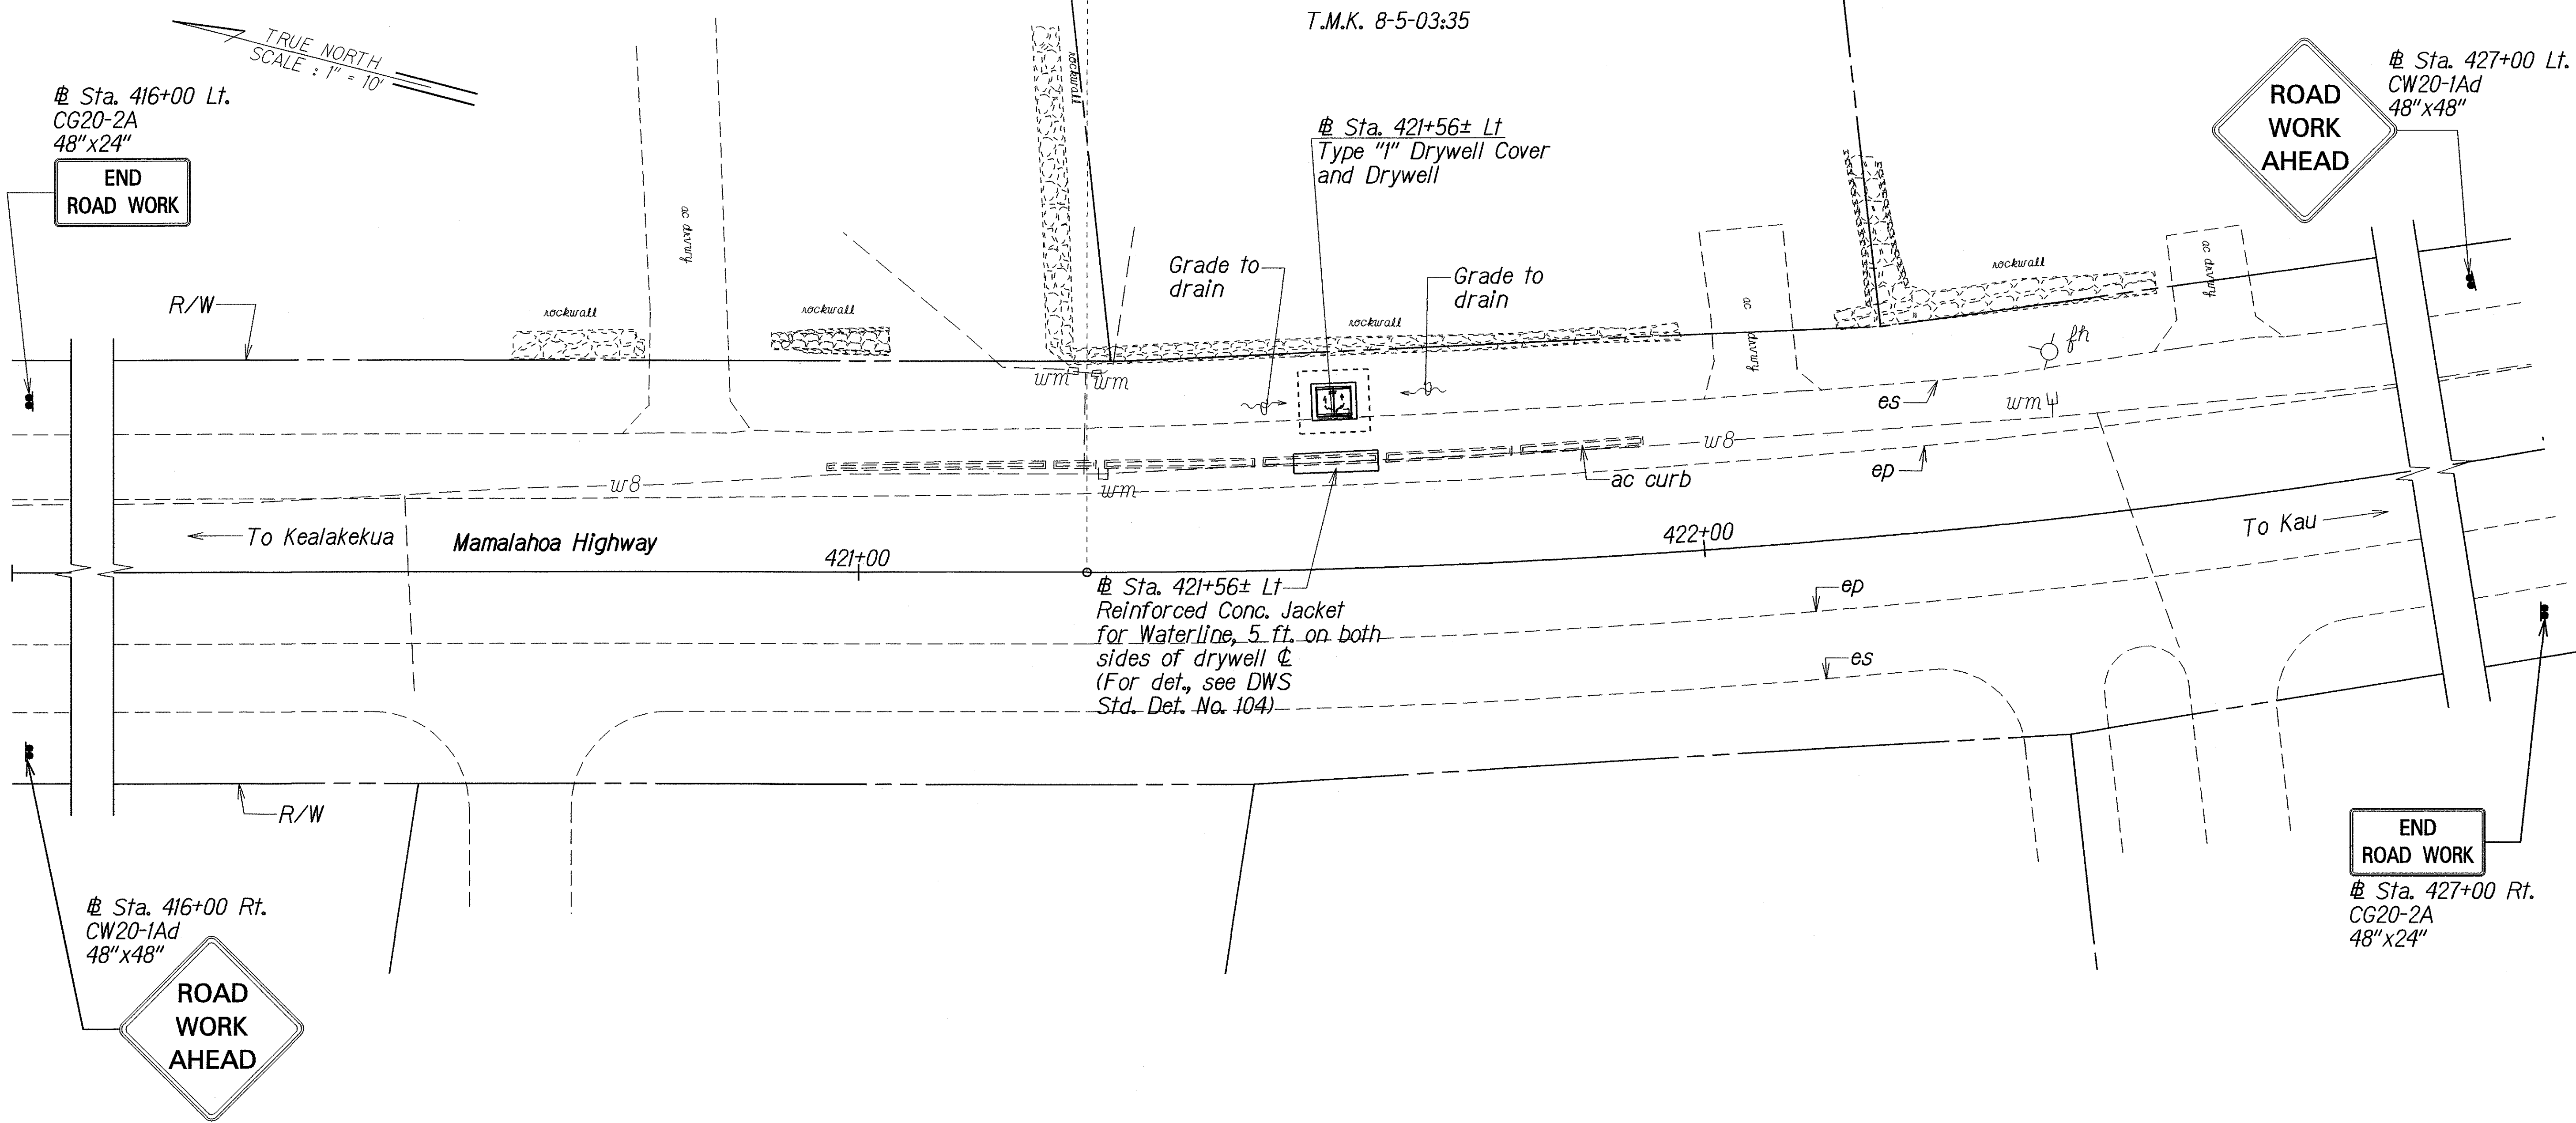

Sta. 421+56± Lt.
 Install: Type "I" Drywell Cover and Drywell
 (For det. see sht. H3)

Estimated Quantities
 Type "I" Drywell Cover (2-2.99 feet) = 1 EA.
 Excavation for Type "I" Drywell = 25 L.F.
 Reinforced Conc. Jacket for Waterline = 10 L.F.
 Structure Exc. for Reinf. Conc. Jacket = 8 C.Y.
 for Waterline

STATE OF HAWAII
 DEPARTMENT OF TRANSPORTATION
 HIGHWAYS DIVISION

DRAINAGE PLAN
 MAMALAHOA HIGHWAY
 Miscellaneous Drainage Improvements
 Vicinity of Hokena
 Project No.: 11BC-02-01
 Scale: 1" = 10'-0" Date: Feb. 2002

SHEET No. **HI** OF **7** SHEETS

DESIGNED BY	DATE
DRAWN BY	
CHECKED BY	
IN CHARGE	
NOTE BOOK	
QUANTITIES BY	
CHECKED BY	

