



| FED. ROAD DIST. NO. | STATE | PROJ. NO.    | FISCAL YEAR | SHEET NO. | TOTAL SHEETS |
|---------------------|-------|--------------|-------------|-----------|--------------|
| HAWAII              | HAW.  | HWY-H-01-92M | 1992        | 3         | 4            |

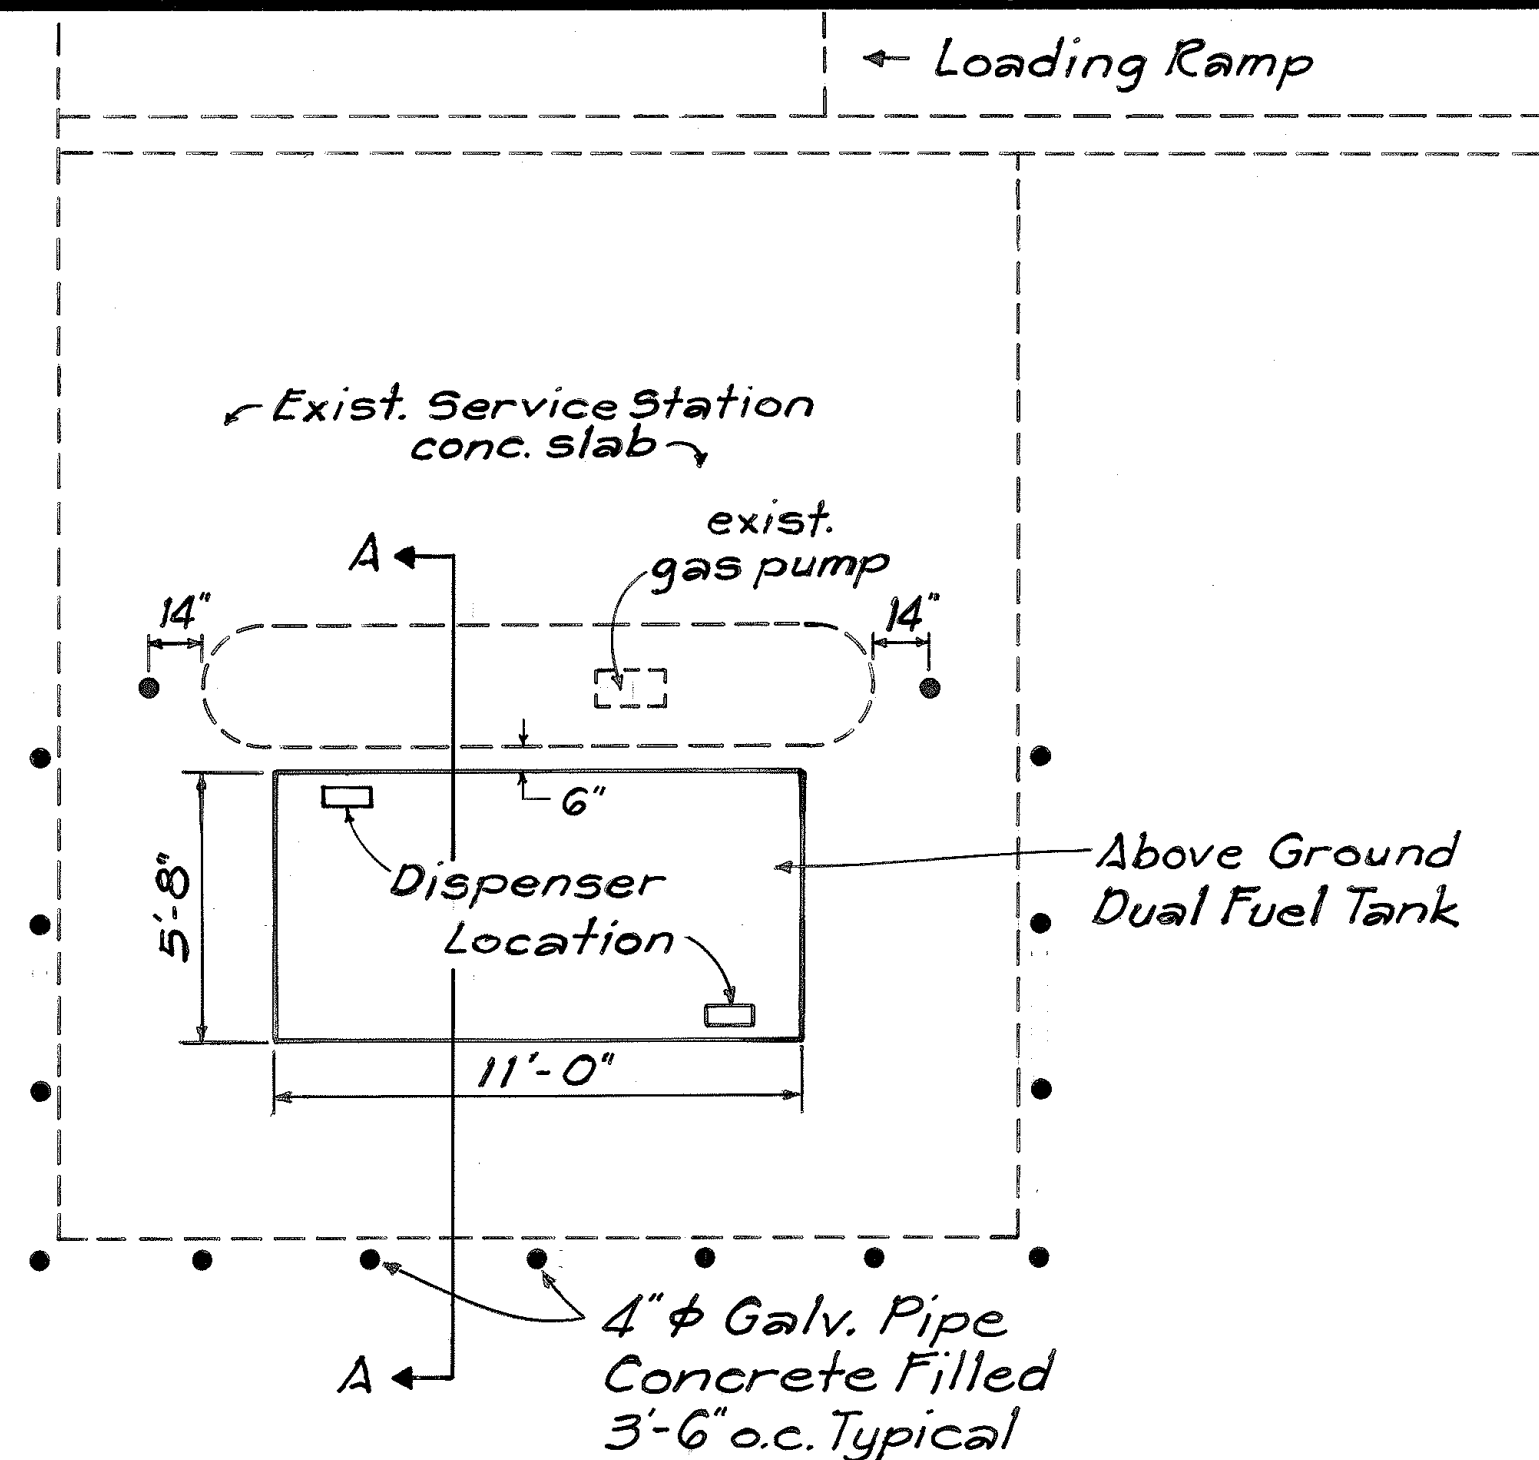


**FLOOR PLAN**  
Scale: 1/4" = 1'-0"

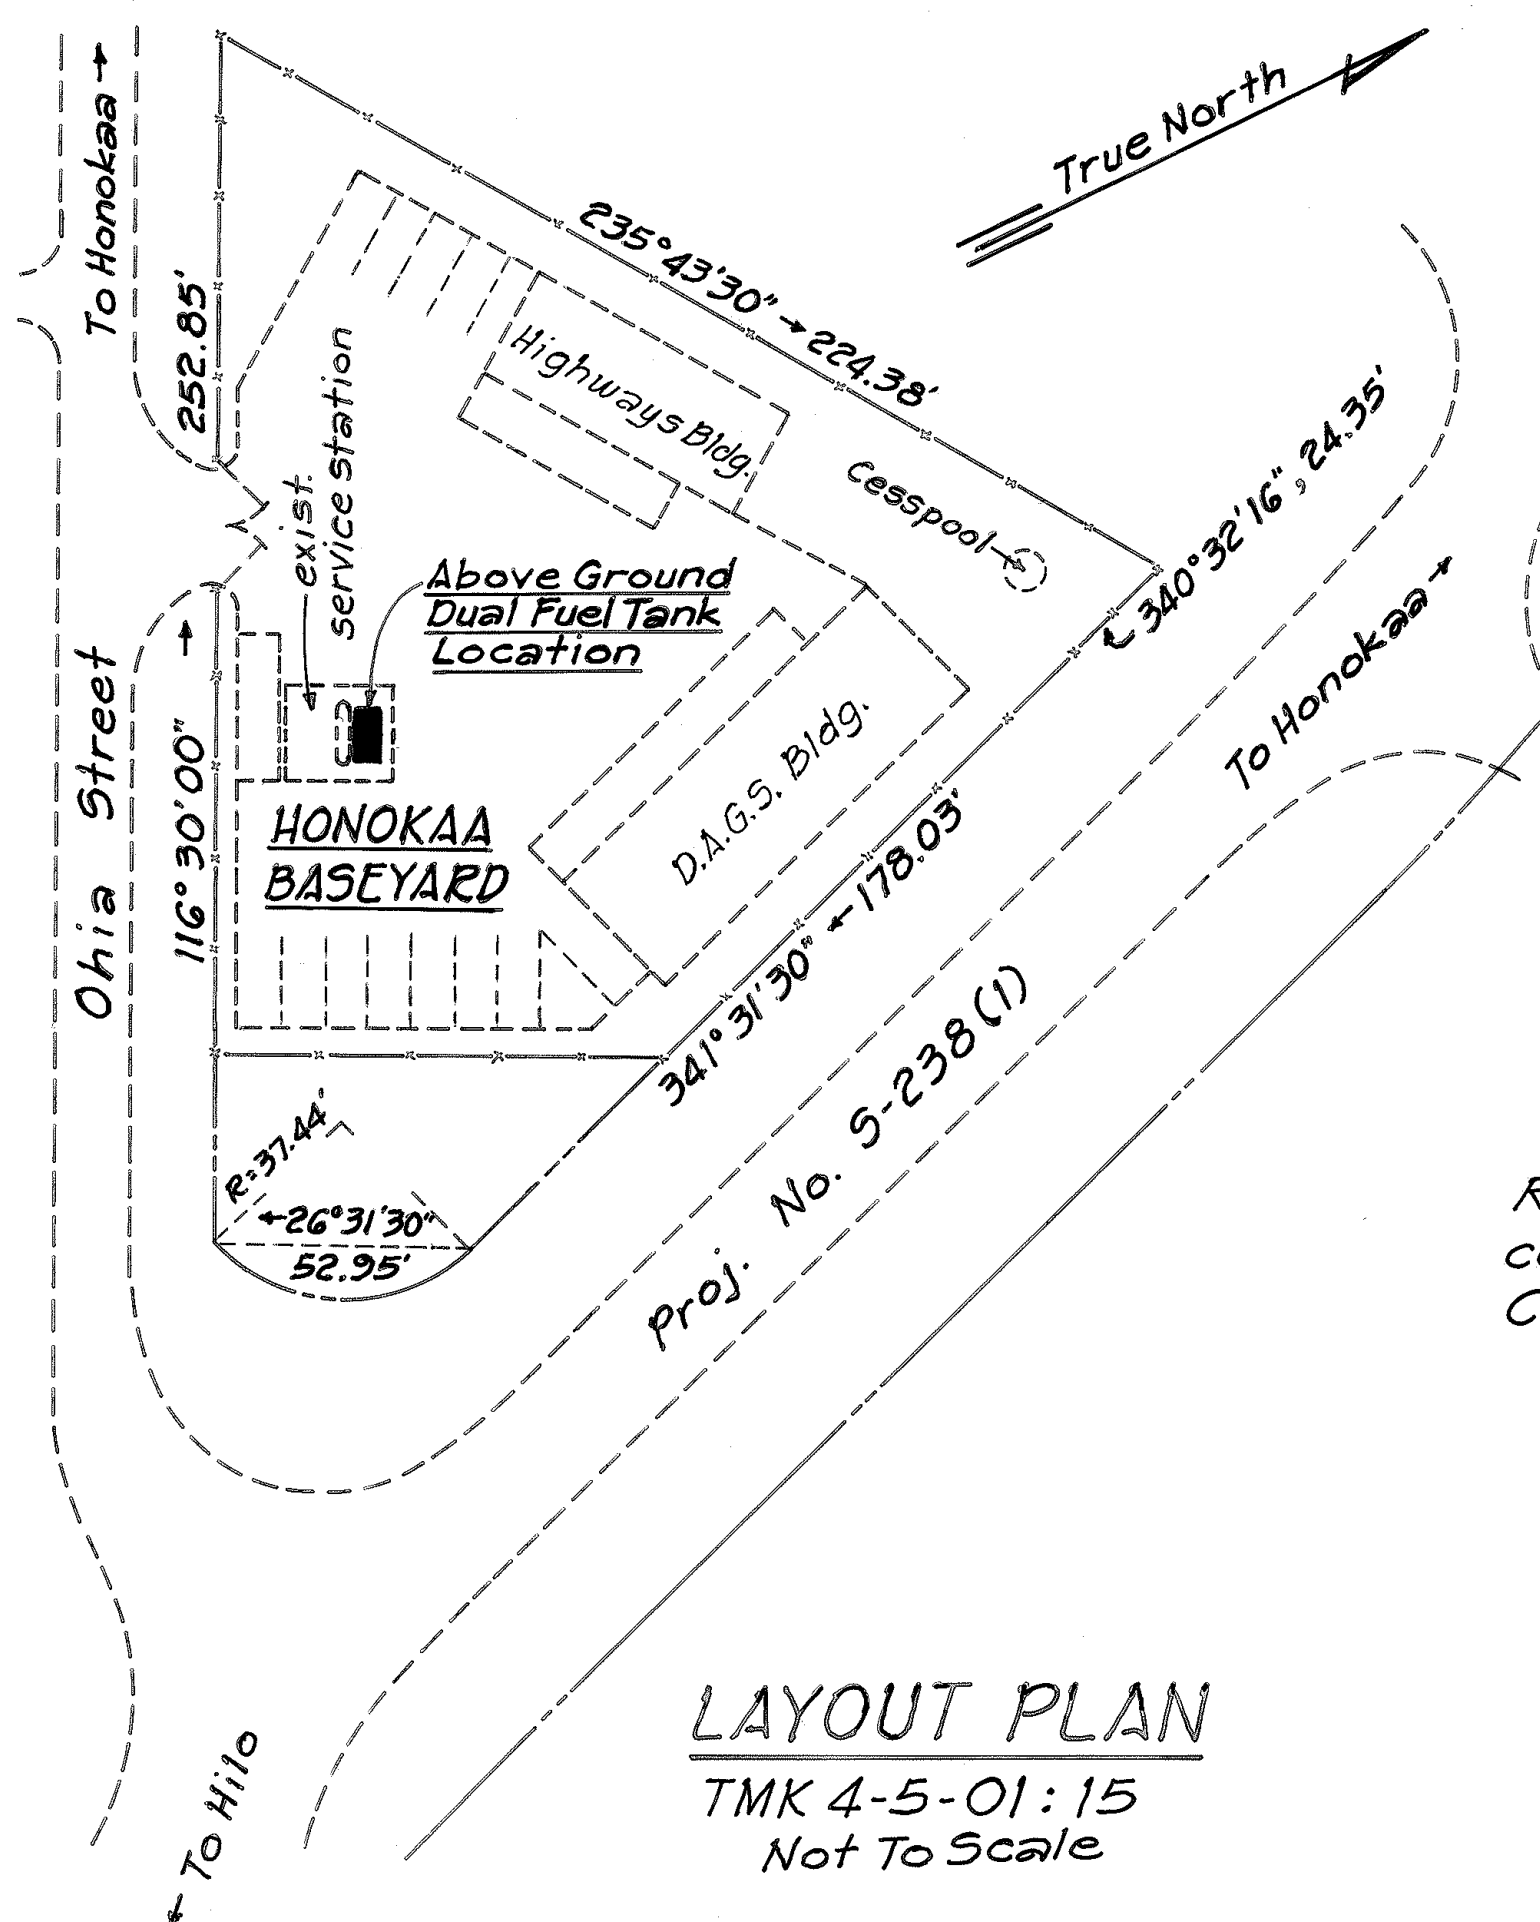


**LAYOUT PLAN**  
TMK 4-5-01:15  
Not To Scale

### NOTES:


- General Notes on Sheet 4.
- Tank and dispensing system to be installed on existing concrete slab. Concrete Slab shall be prepared for Tank footings with 4" Pedestals of Class 'A' Concrete extending 4" beyond Tank footing in all directions. All edges to be chamfered 1/2".
- Concrete filled Steel Pipes to be placed in the positions shown. Pipes are to be embedded 3'-6" in 15" diameter base.

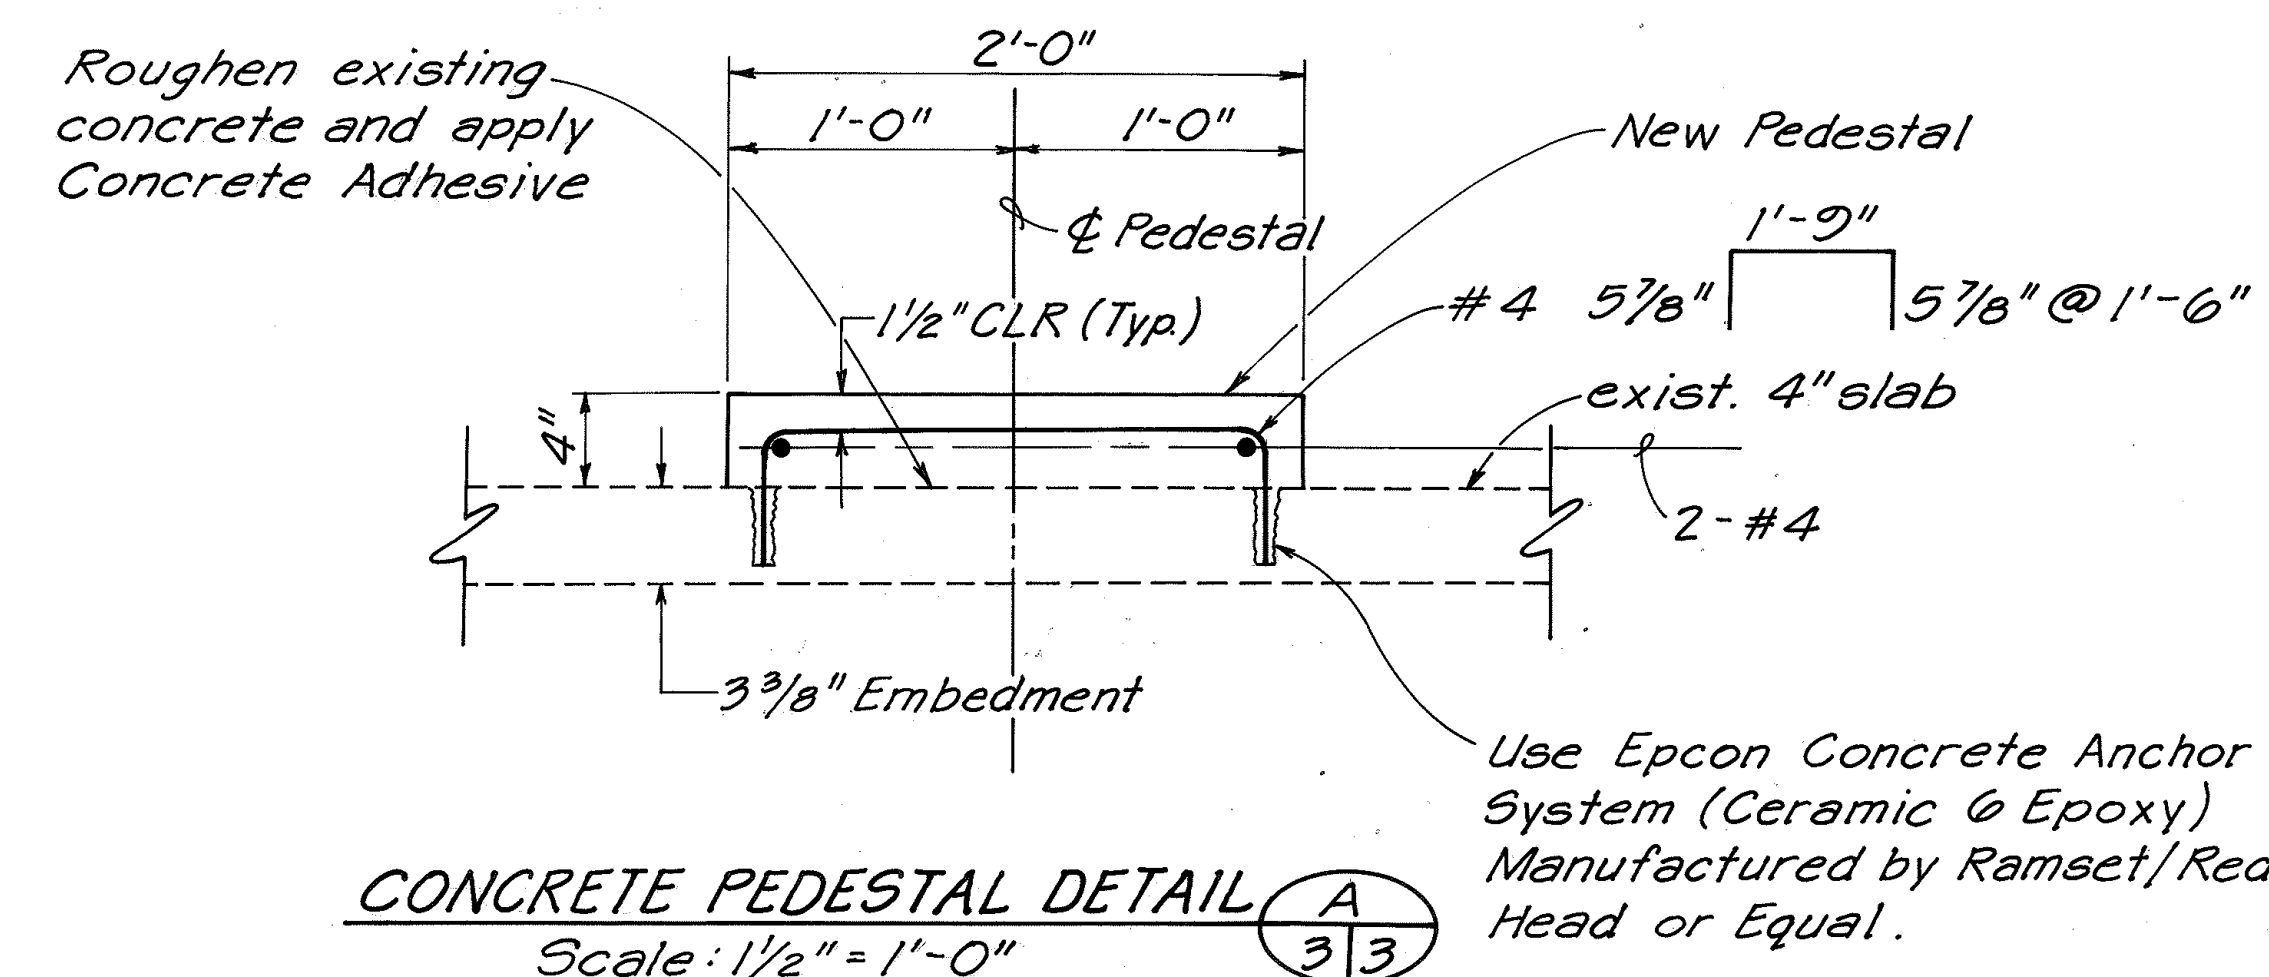

**CONCRETE PEDESTAL DETAIL A**  
Scale: 1 1/2" = 1'-0"

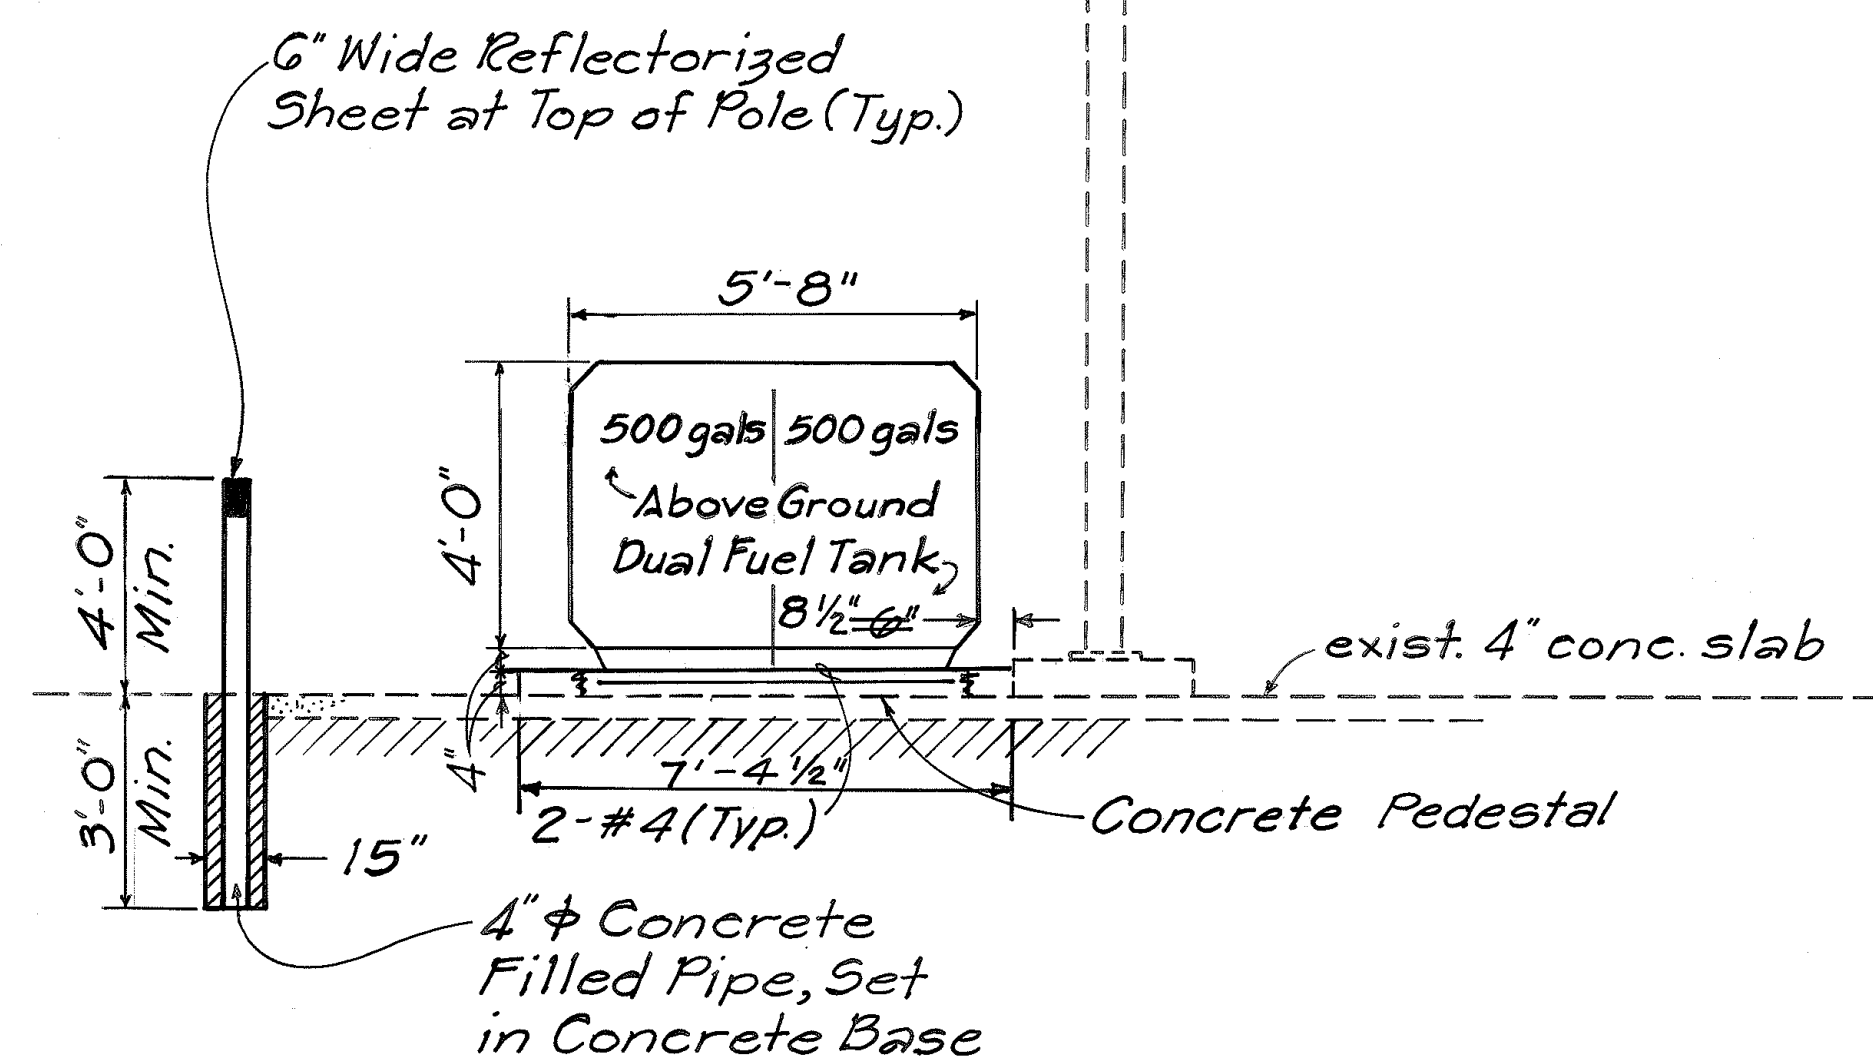

**SECTION A-A**  
Scale: 3/8" = 1'-0"

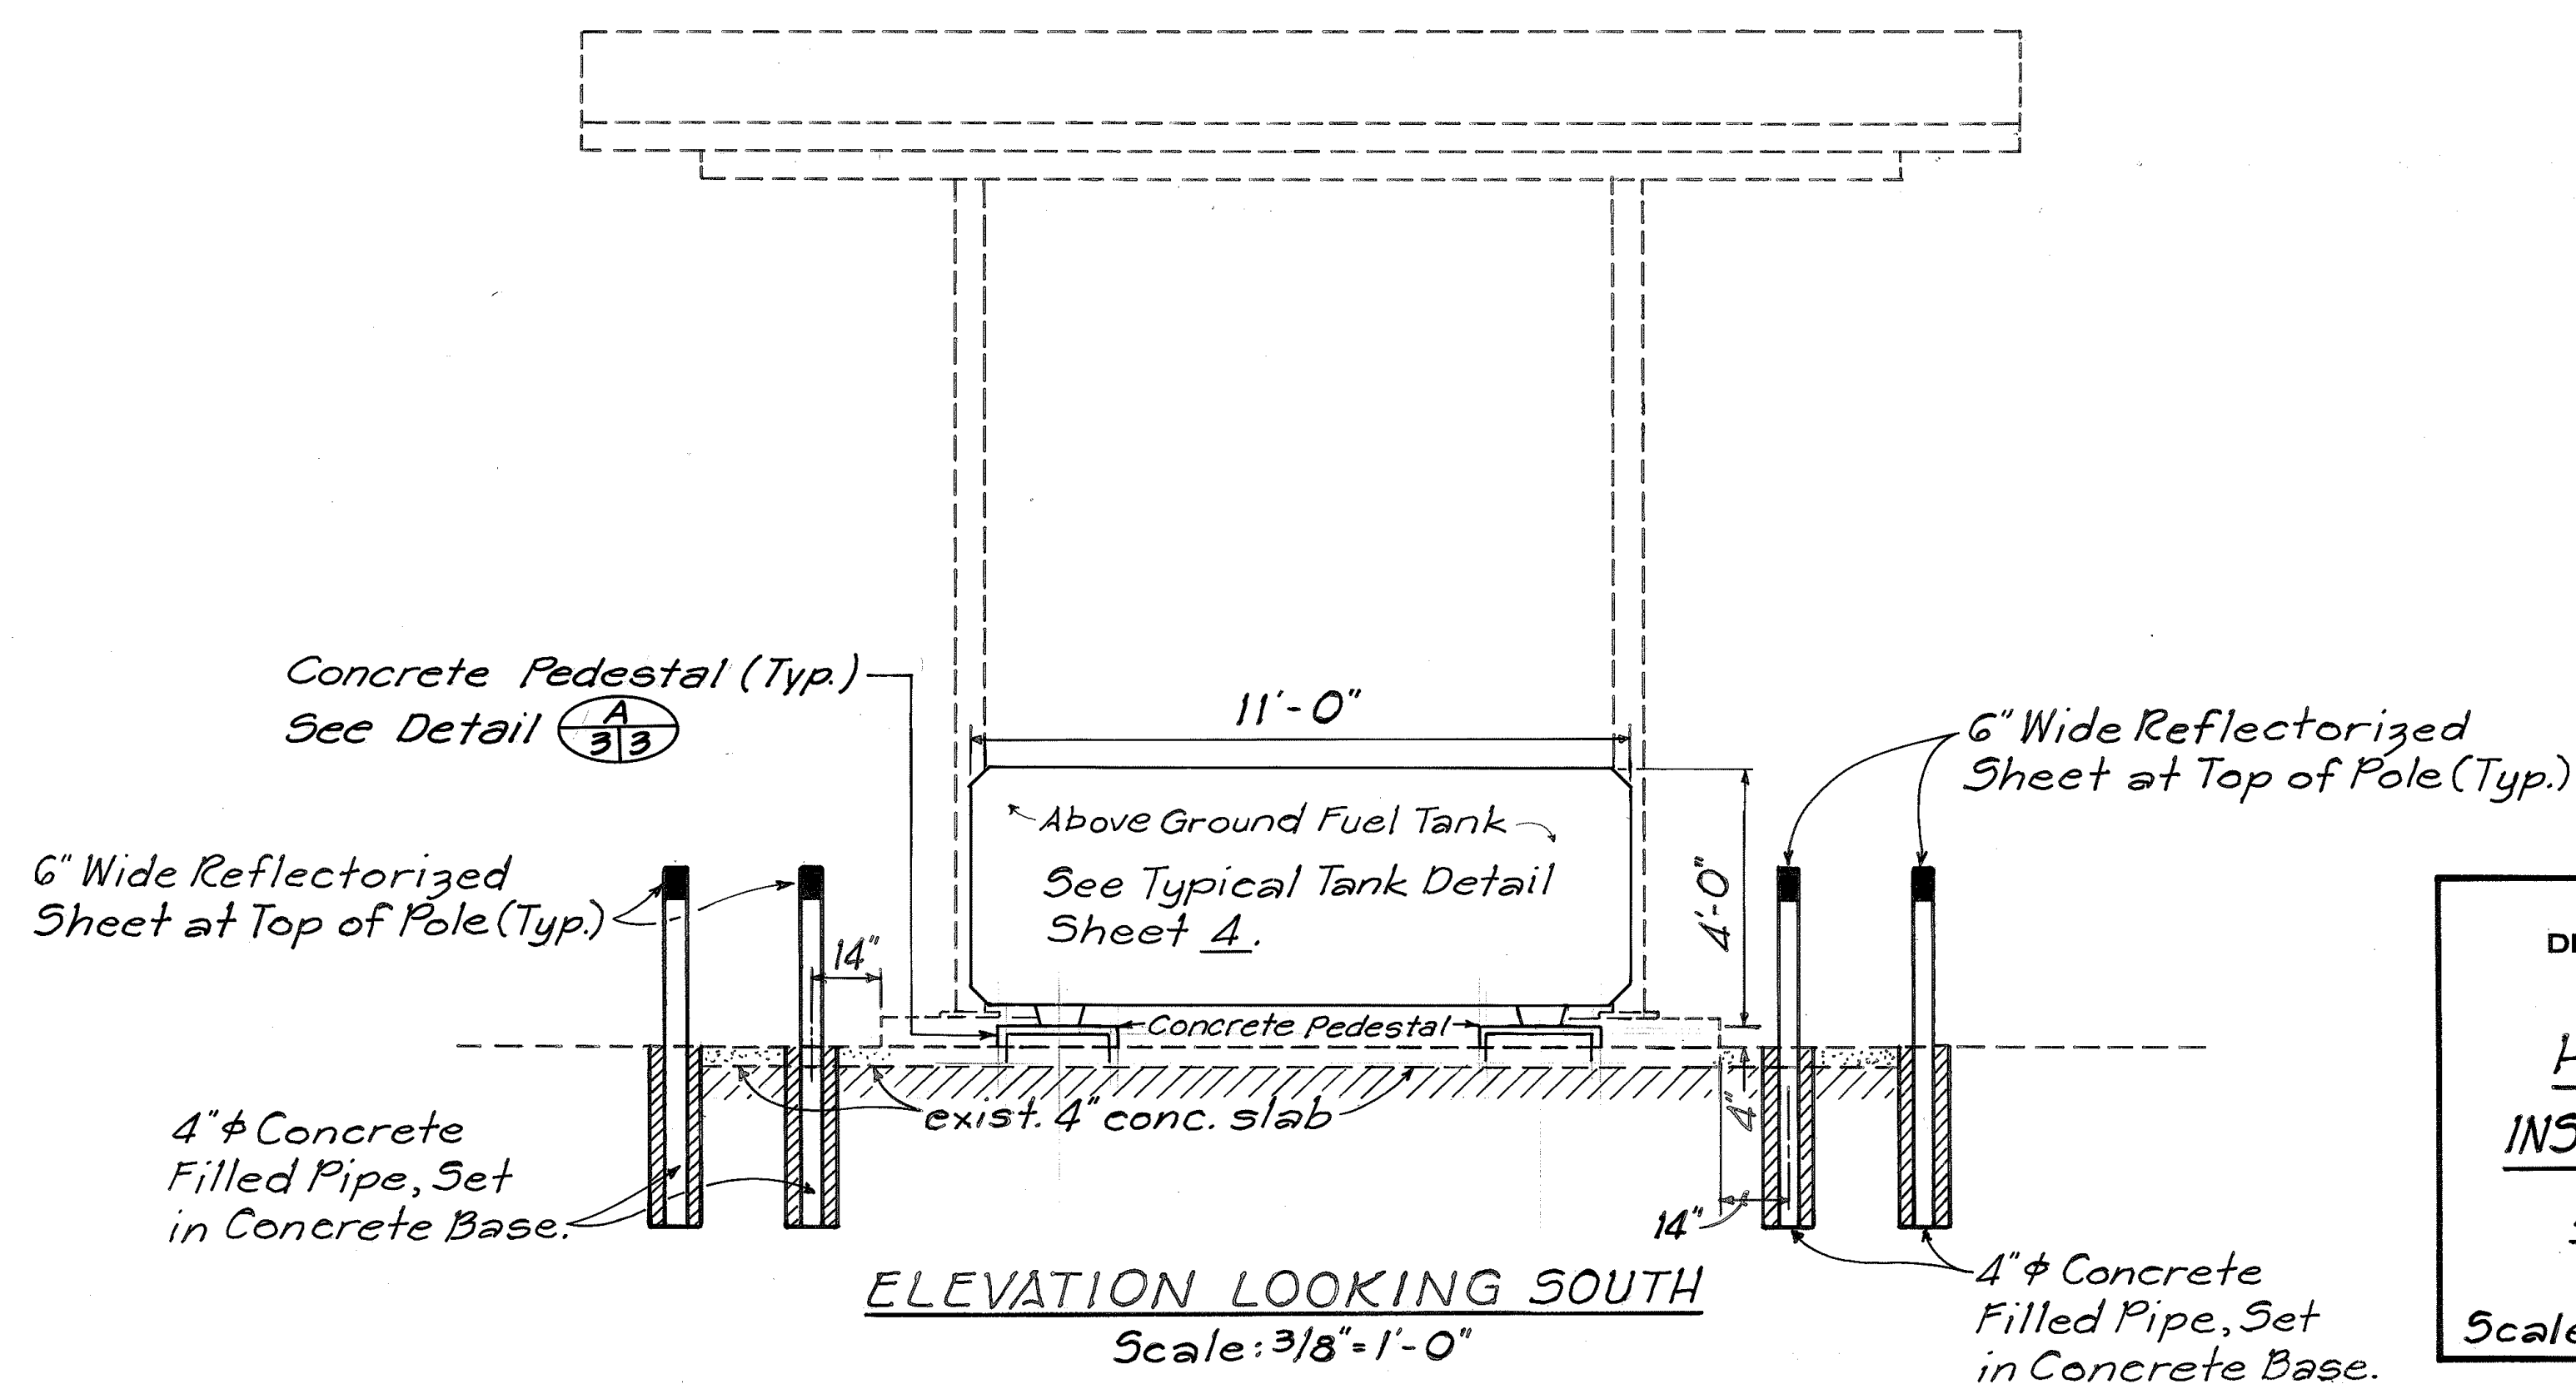

**ELEVATION LOOKING SOUTH**  
Scale: 3/8" = 1'-0"

STATE OF HAWAII  
DEPARTMENT OF TRANSPORTATION  
HIGHWAYS DIVISION

**HONOKAA BASEYARD**  
**INSTALL NEW DUAL FUEL TANK**  
**AND LEAK DETECTION**

Scale: As Noted Date: Mar. 1992  
SHEET NO. 1 OF 1 SHEETS

|                   |      |
|-------------------|------|
| SURVEY PLOTTED BY | DATE |
| DRAWN BY          |      |
| TRACED BY         |      |
| QUANTITIES BY     |      |
| CHECKED BY        |      |
| ORIGINAL PLAN     |      |
| NOTE BOOK         |      |
| No.               |      |