



FED. ROAD DIST. NO.	STATE	PROJ. NO.	FISCAL YEAR	SHEET NO.	TOTAL SHEETS
HAWAII	HAW.	HNY-H-01-92M	1992	2	4

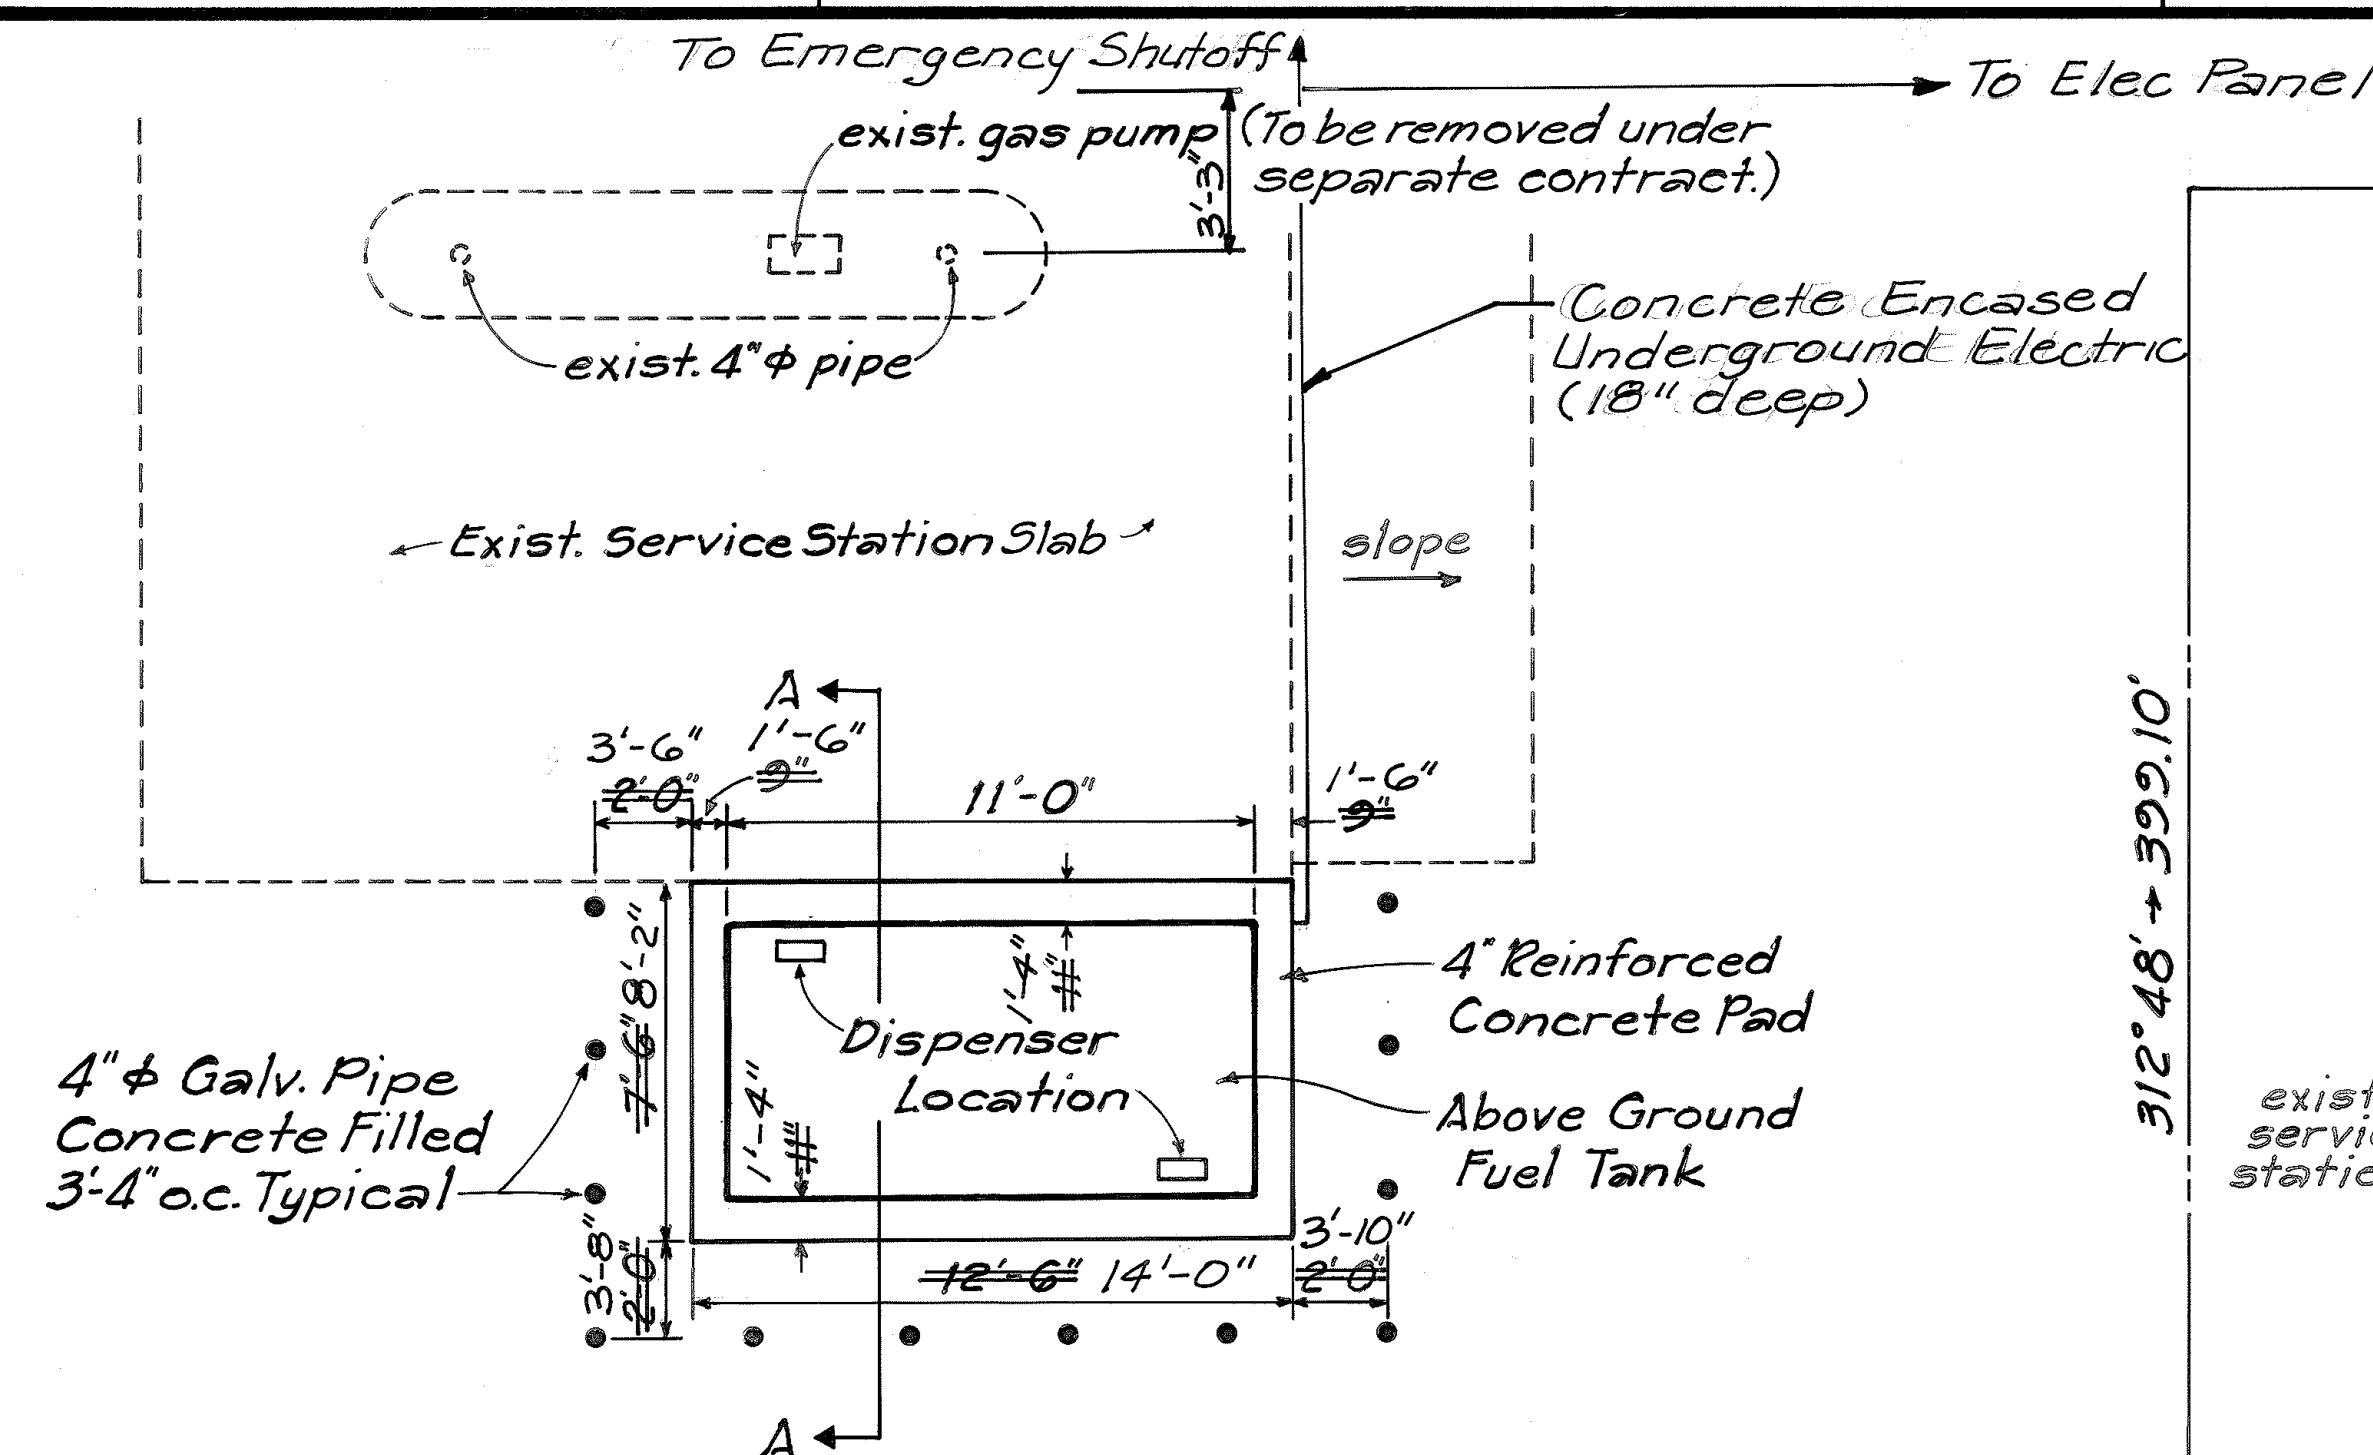


LAYOUT PLAN
Scale: 1/4" = 1'-0"

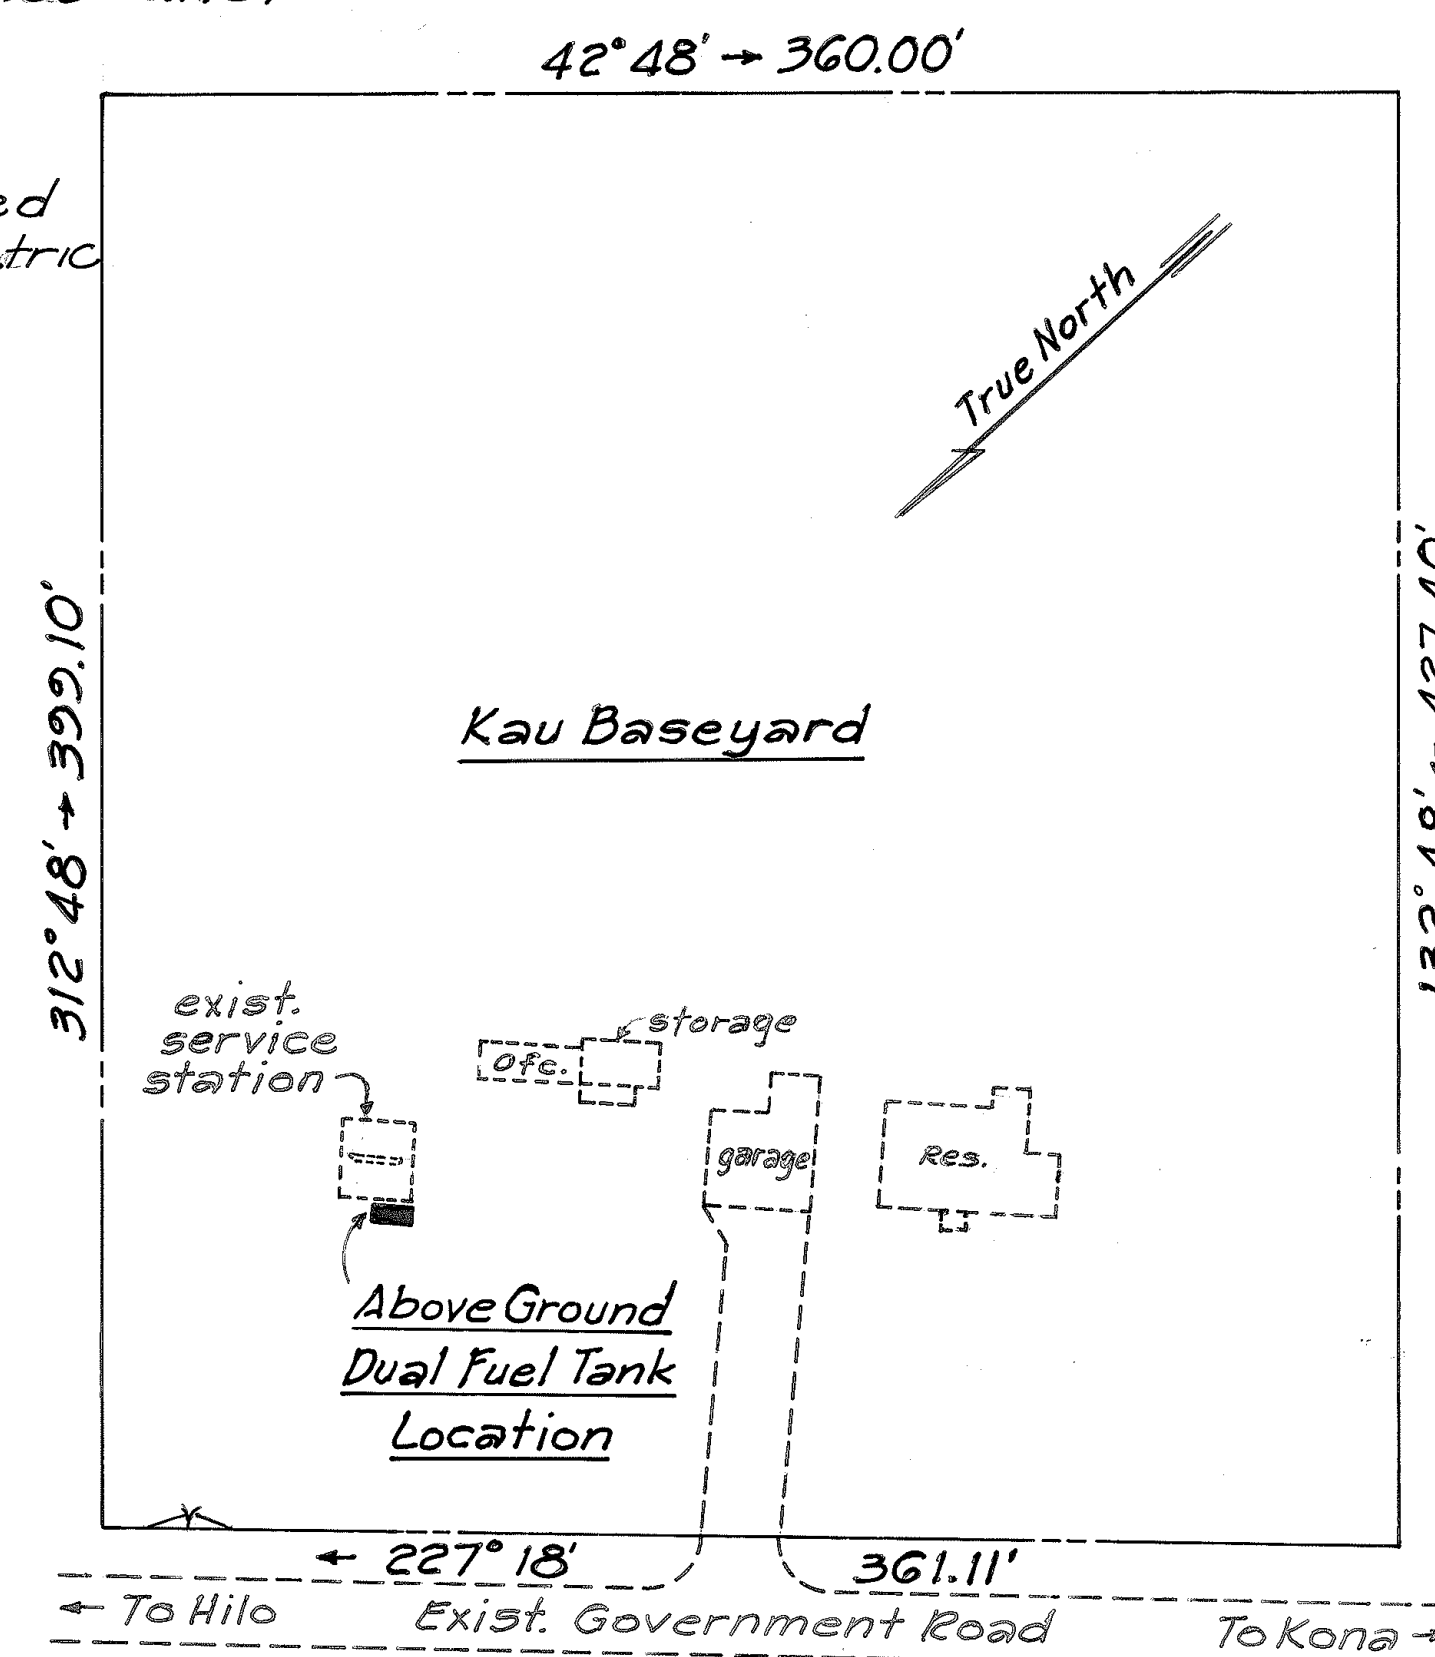


SITE PLAN
TMK 9-5-12:30
Not To Scale

NOTES:


1. See General Notes Sheet 4.
2. Tank and dispensing system to sit on New Class "A" Concrete Slab and 4" Pedestal as shown. Pedestal edges to be chamfered 1/2".
3. Concrete filled Steel Pipes to be placed in the positions shown. Pipes to be embedded 3' in 15" diameter concrete base and spaced 3'-4" o.c.

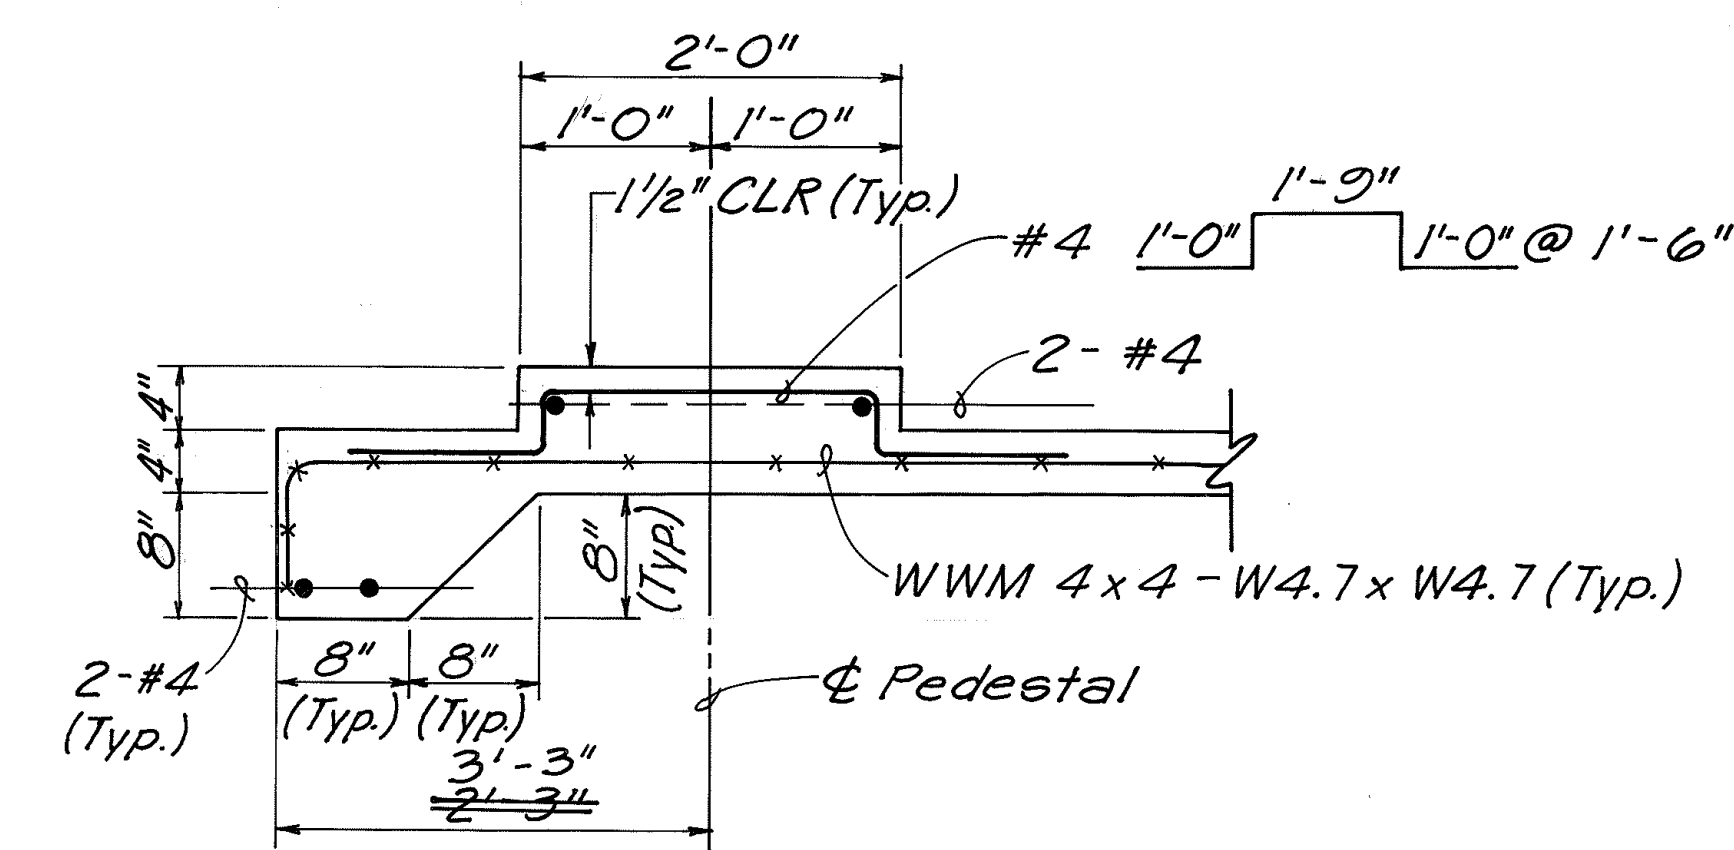

DETAIL A
Scale: 1" = 1'-0"

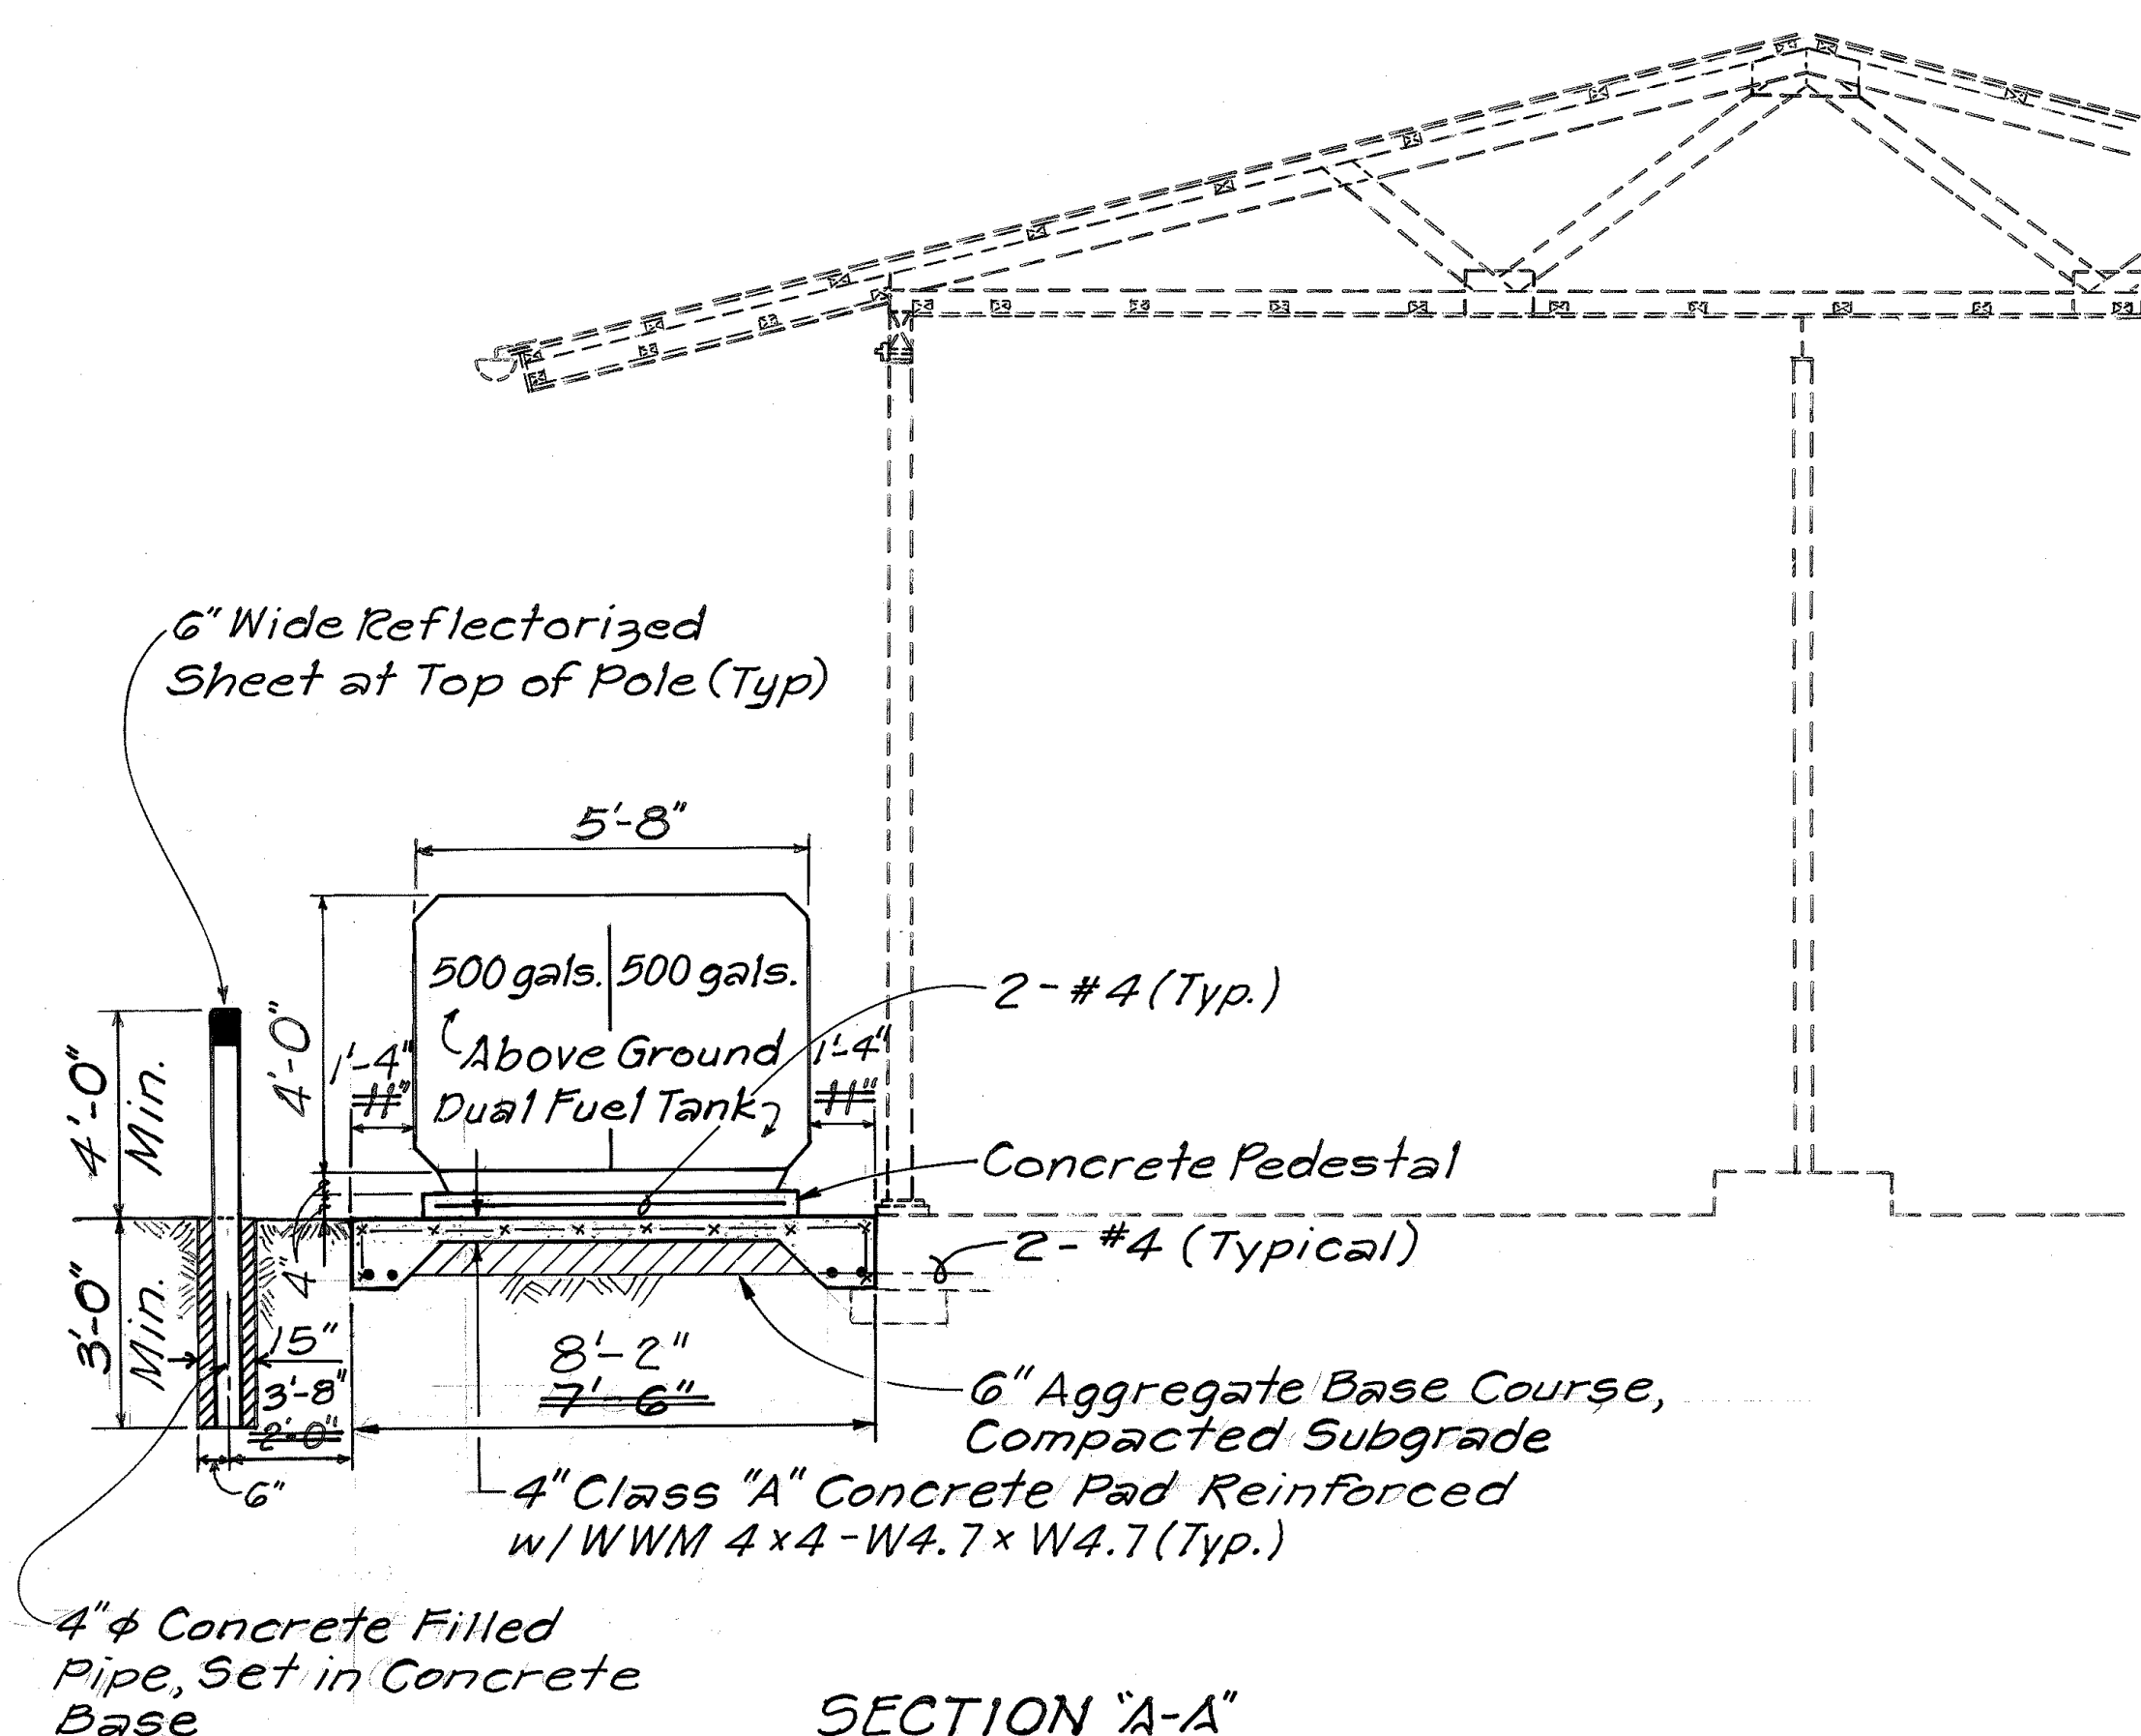

SECTION A-A
Scale: 3/8" = 1'-0"

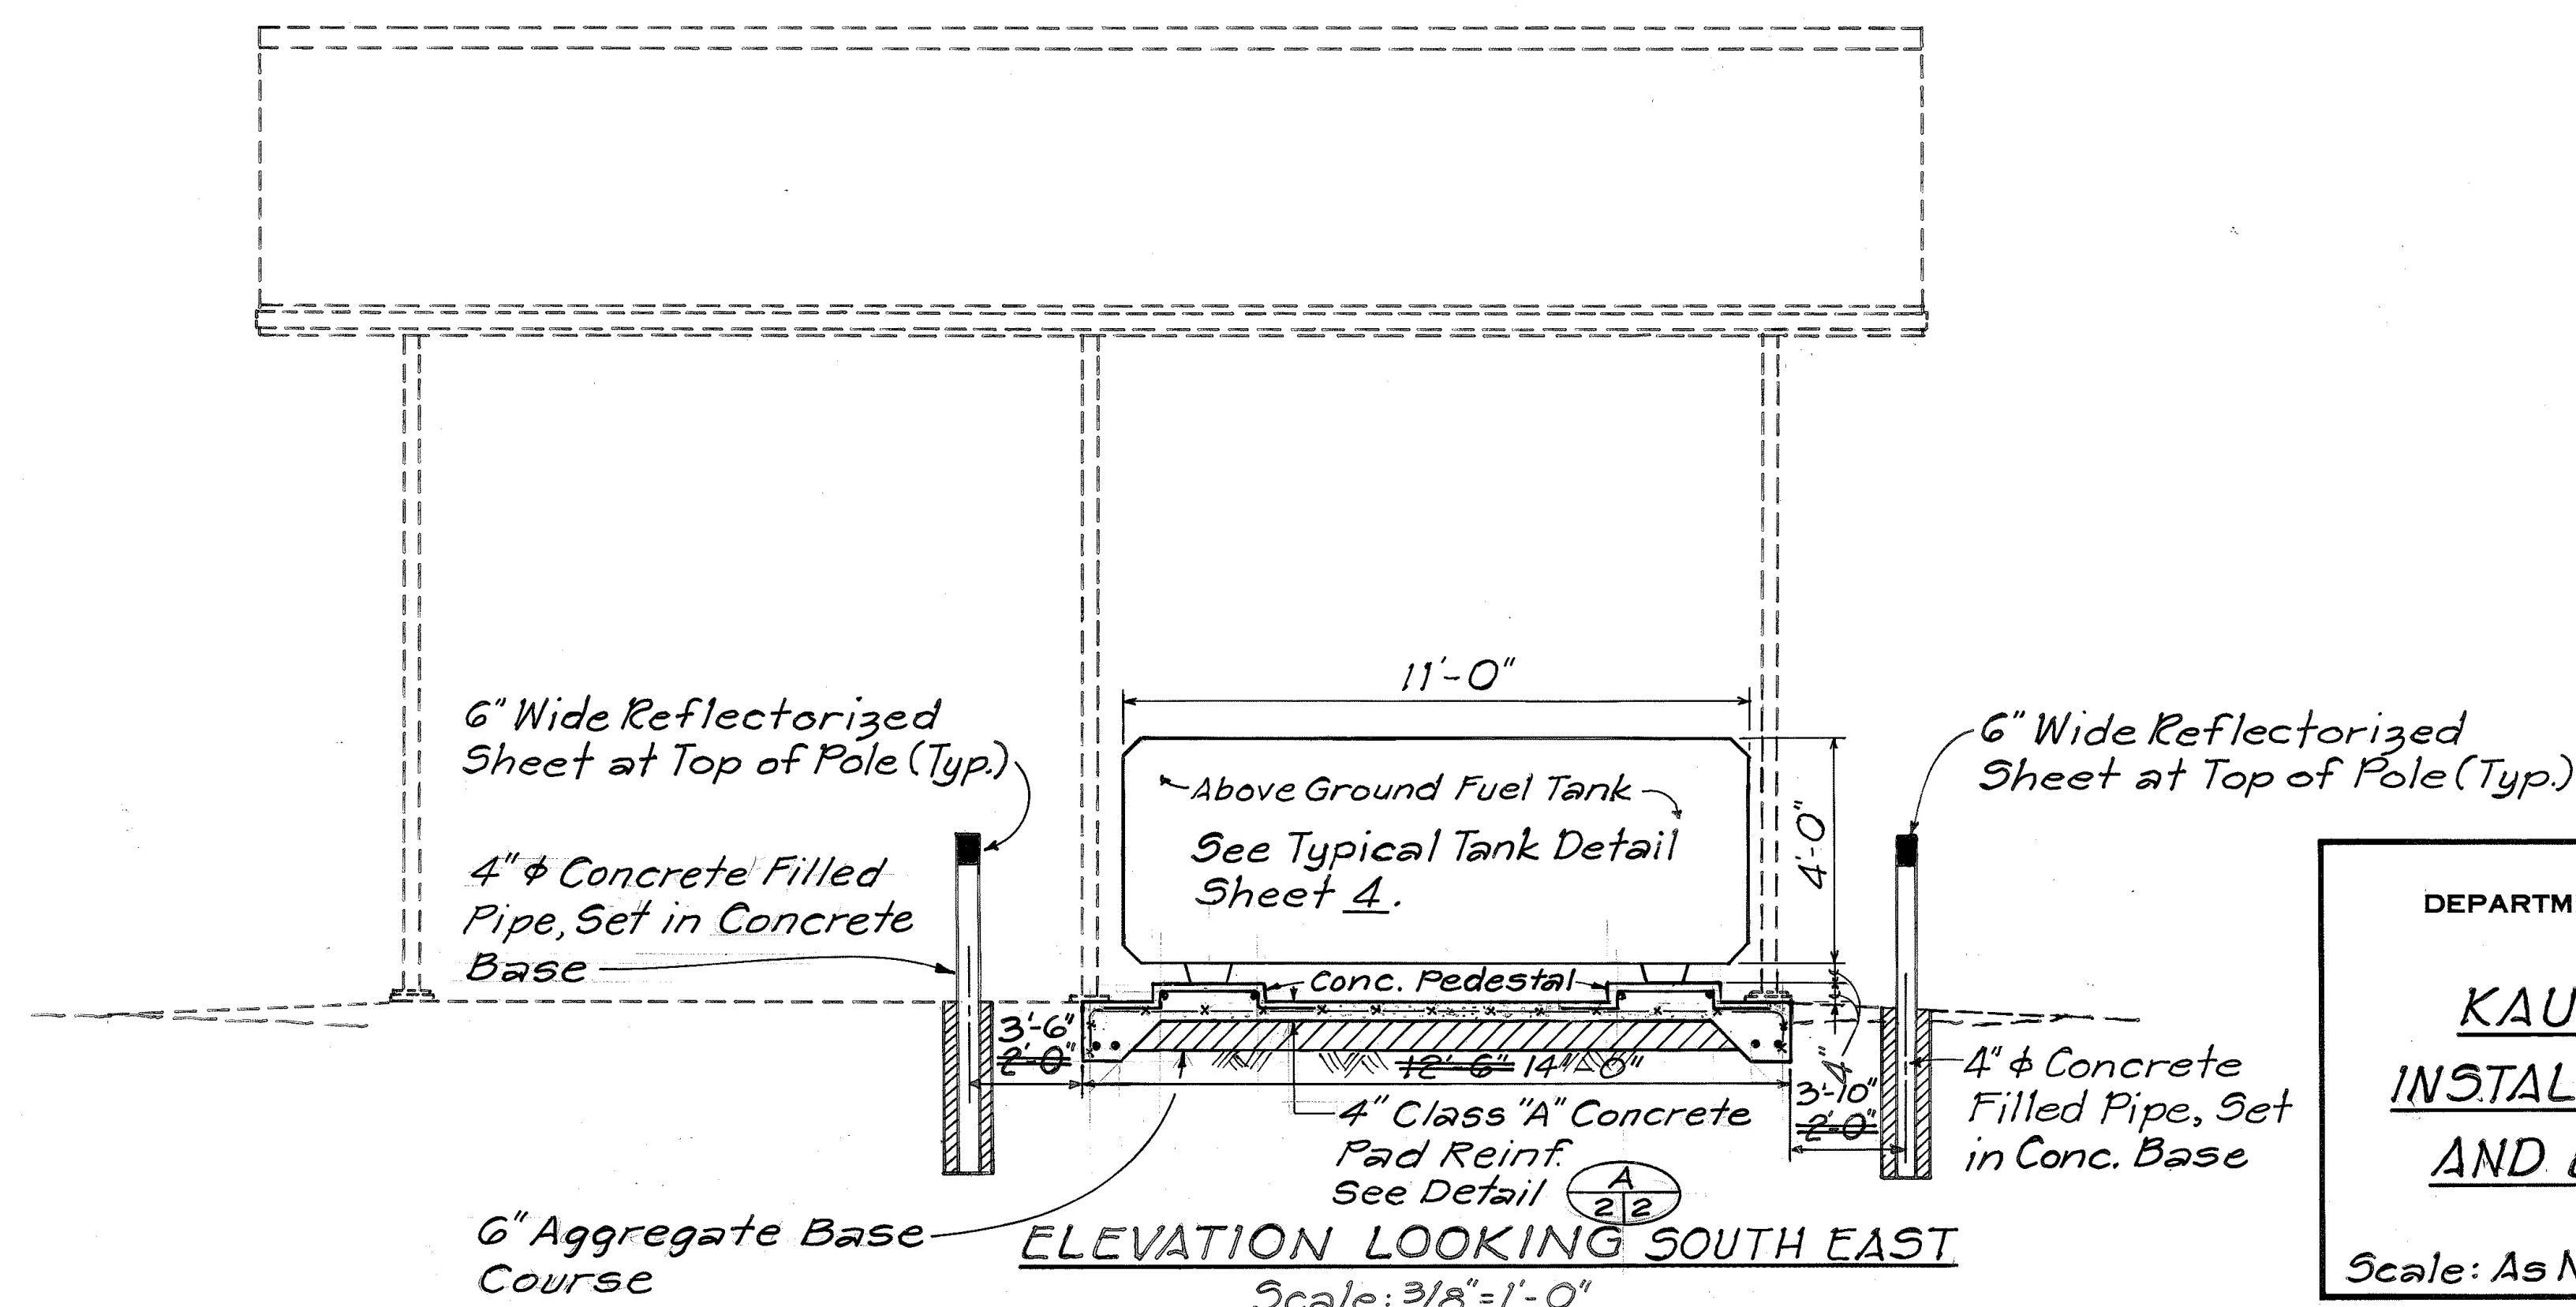

ELEVATION LOOKING SOUTH EAST
Scale: 3/8" = 1'-0"

STATE OF HAWAII
DEPARTMENT OF TRANSPORTATION
HIGHWAYS DIVISION

KAU BASEYARD
INSTALL NEW FUEL TANK
AND LEAK DETECTION

Scale: As Noted Date: Mar. 1992
SHEET NO. 1 OF 1 SHEETS

SURVEY PLOTTED BY	DATE
DRAWN BY	
TRACED BY	
QUANTITIES BY	
CHECKED BY	
ORIGINAL PLAN	
NOTE BOOK	
No.	