
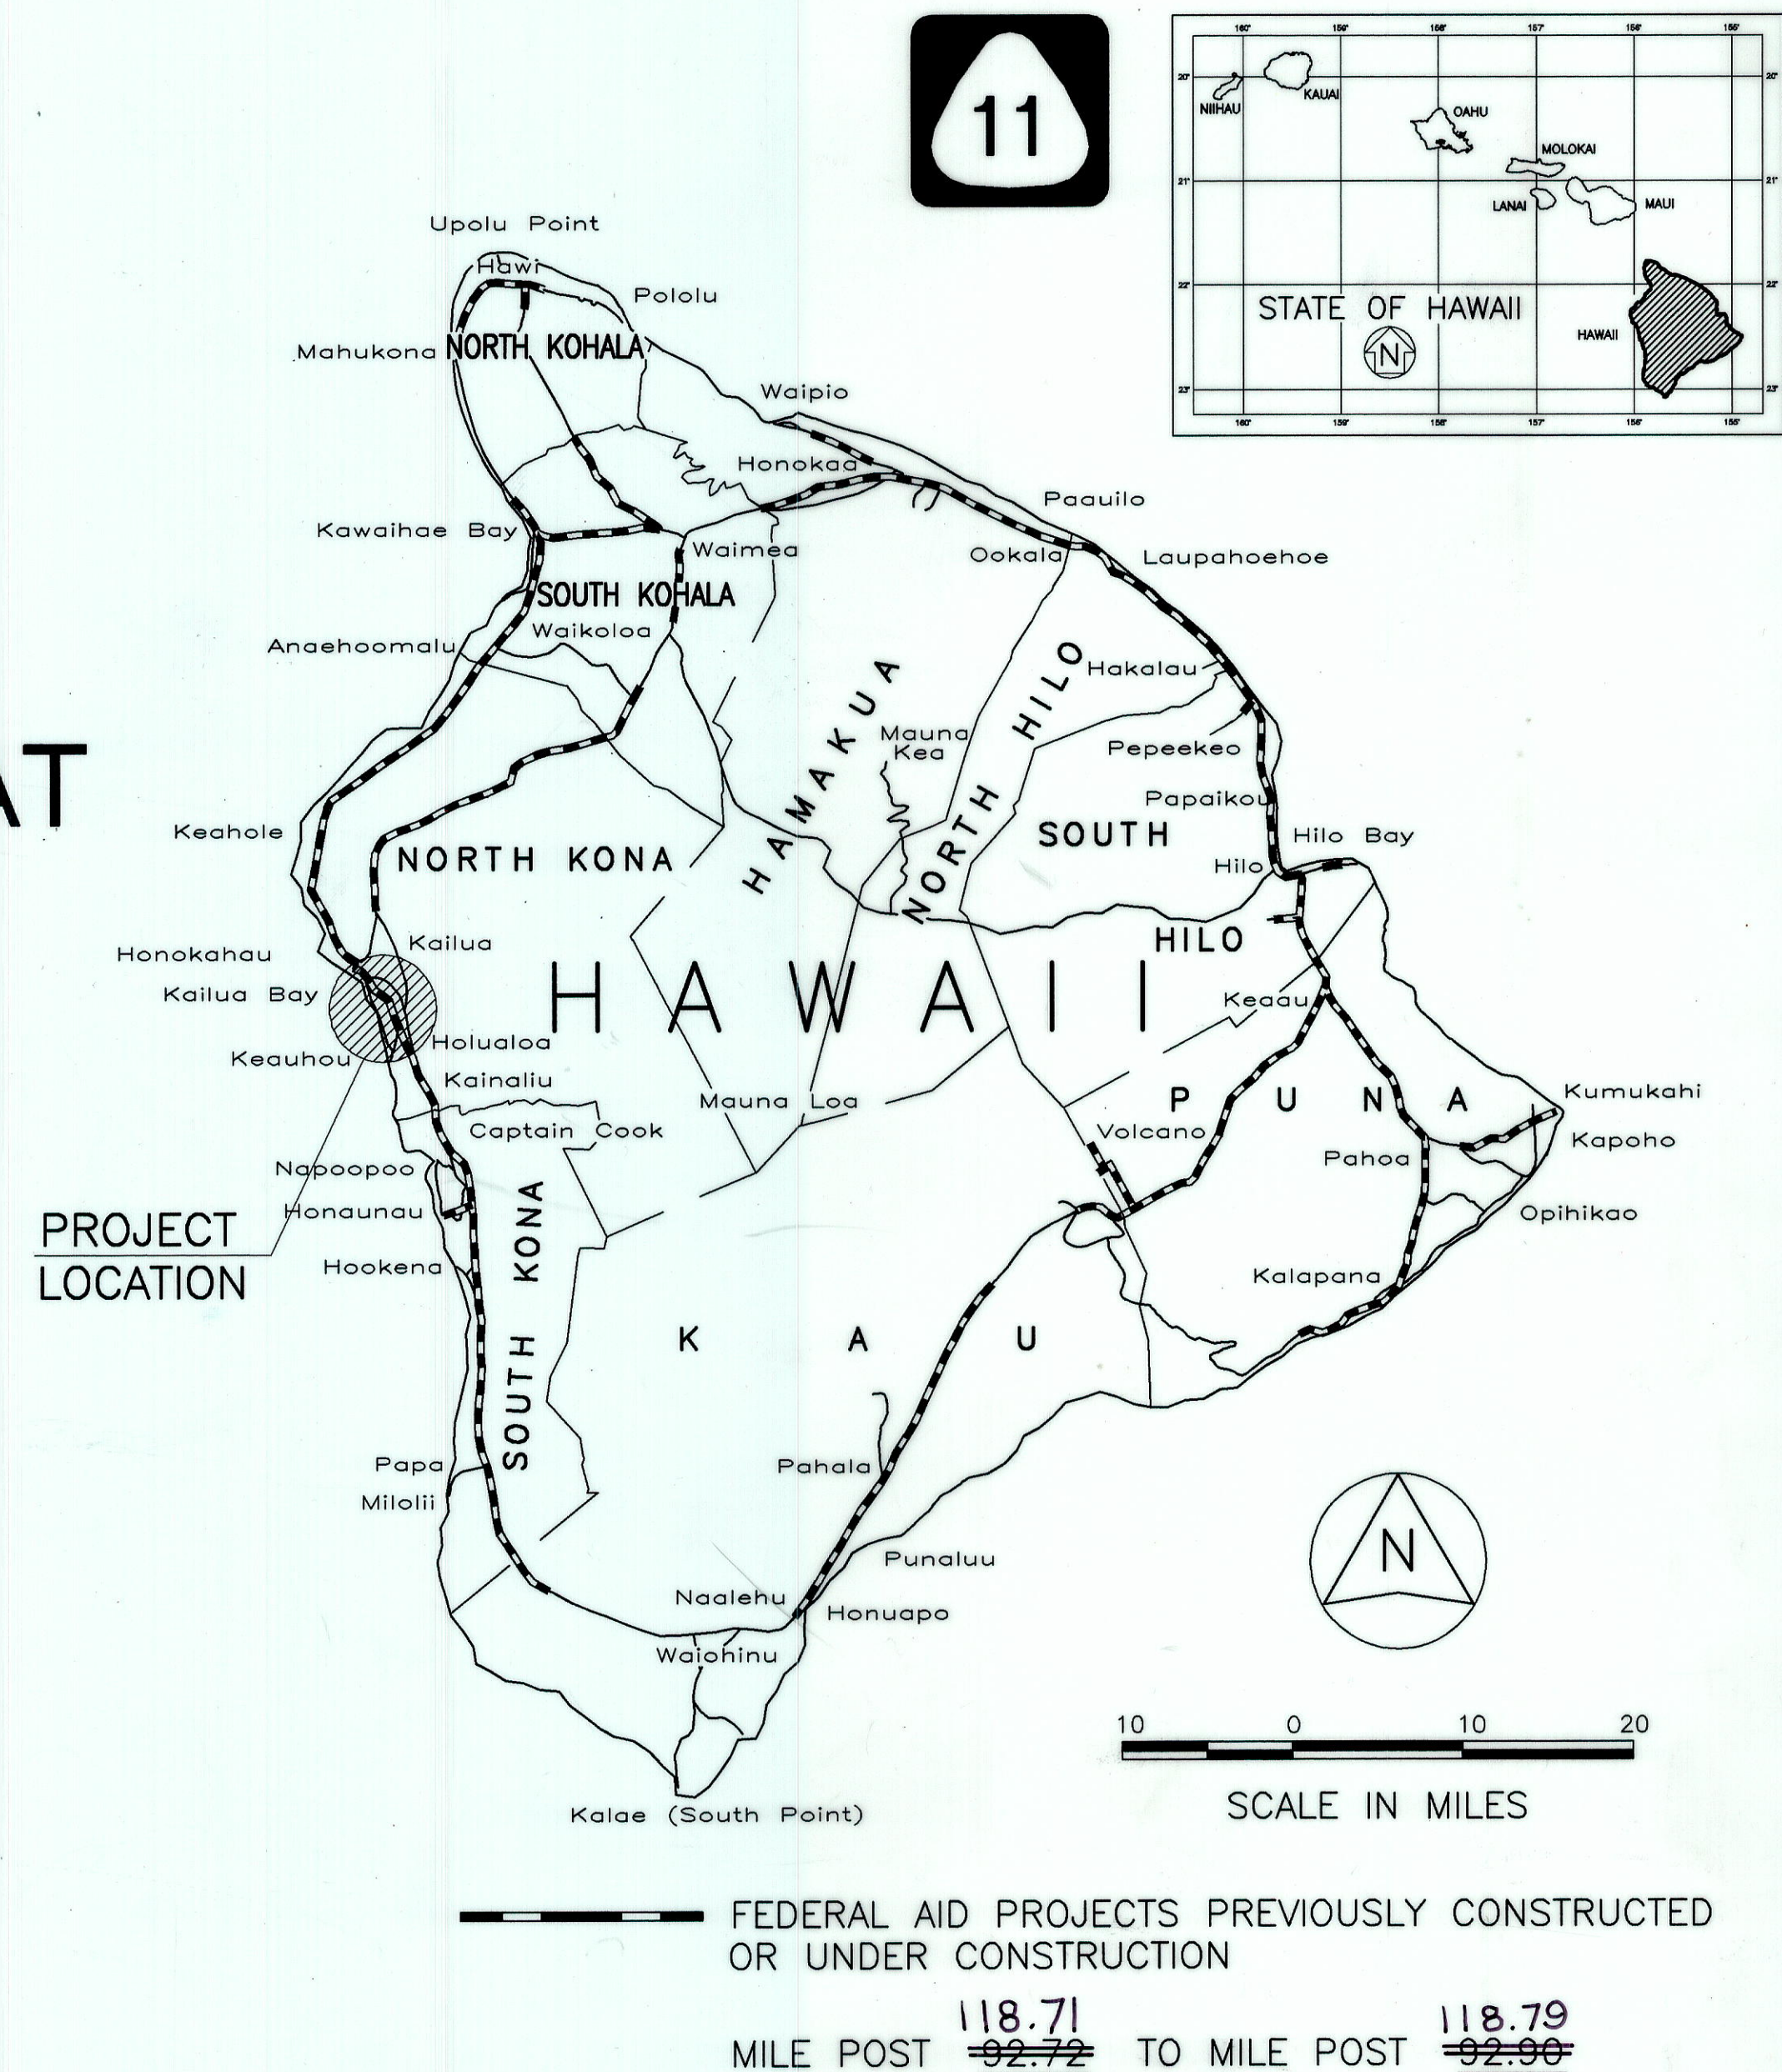


INDEX TO DRAWINGS	
SHEET NO.	DESCRIPTION
1	TITLE SHEET
2	STANDARD PLANS SUMMARY
3	NOTES AND LEGEND
4	SIGNING AND STRIPING PLAN
5	TRAFFIC SIGNAL PLAN
6	TRAFFIC SIGNAL DETAILS
7	SIGN MOUNTING DETAILS
8	TRAFFIC SIGNAL DETAILS
9	LOOP DETECTOR DETAILS
10	MISCELLANEOUS DETAILS
11-14	ELECTRICAL PLANS

STATE OF HAWAII  
DEPARTMENT OF TRANSPORTATION  
HIGHWAYS DIVISION  
HONOLULU, HAWAII  
**"AS-BUILT"**  
PLANS FOR  
**KUAKINI HIGHWAY**  
**INSTALLATION OF TRAFFIC SIGNALS AT**  
**SEA VIEW CIRCLE**  
FEDERAL AID PROJECT NO. STP-011-1(22)  
DISTRICT OF NORTH KONA  
ISLAND OF HAWAII

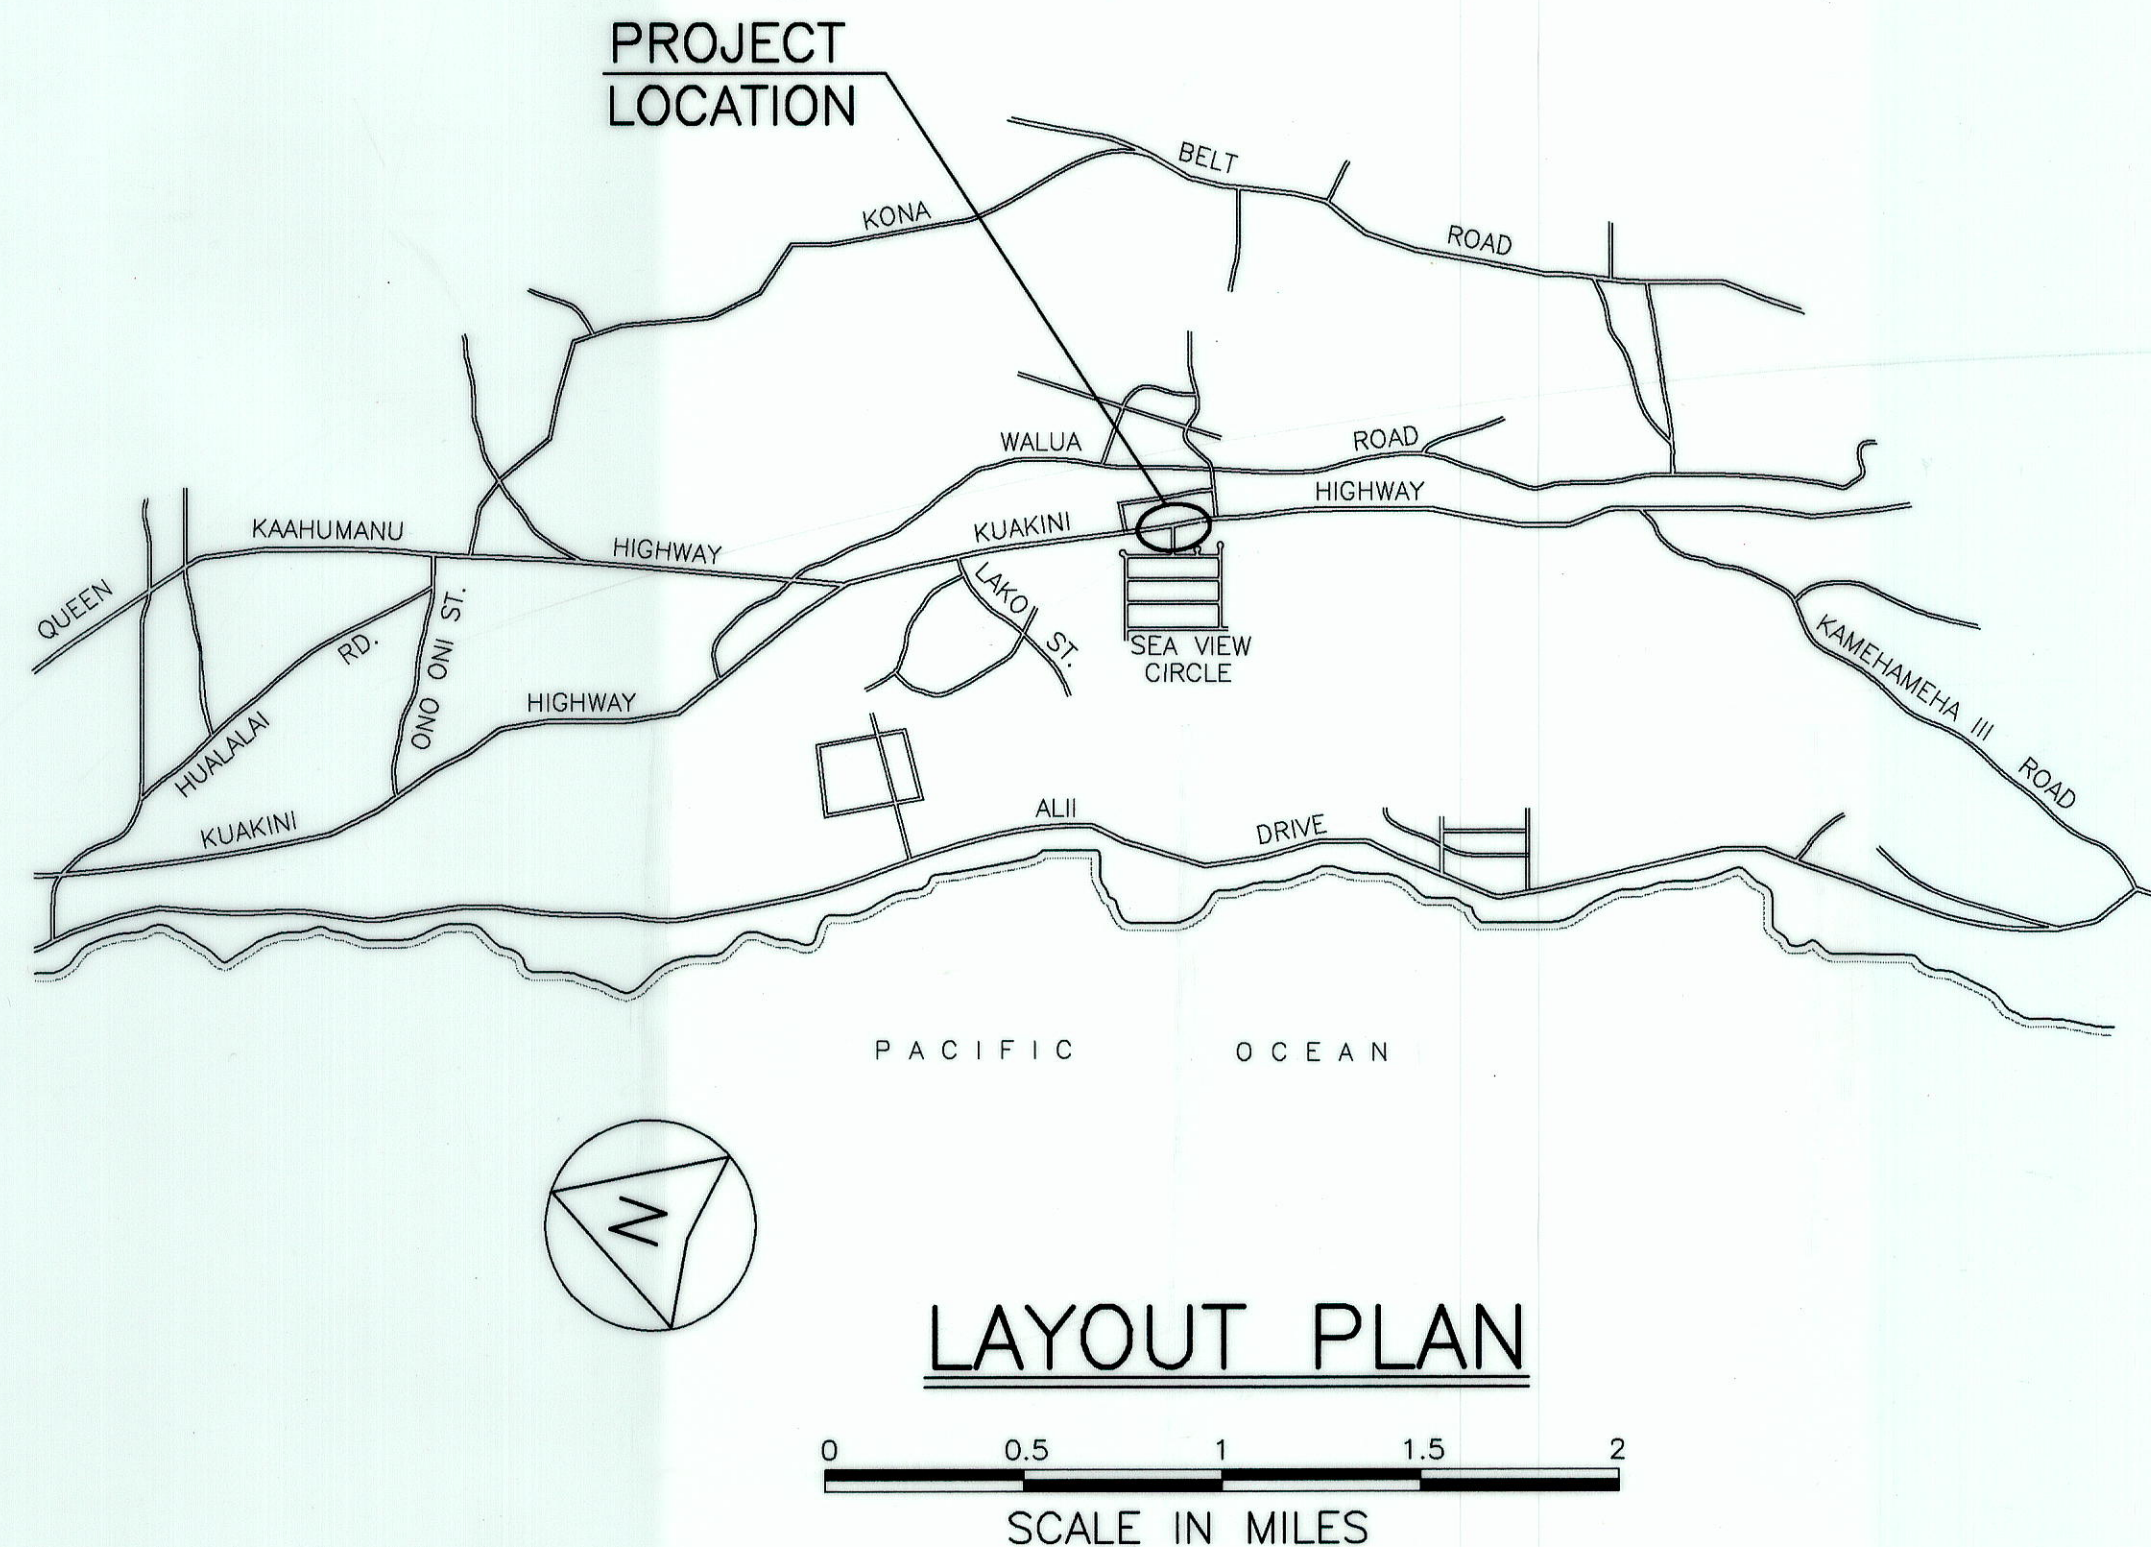

CHANGES MADE DURING CONSTRUCTION HAVE BEEN INCORPORATED ON THESE PLANS EXCEPT CHANGES IN THE ORIGINAL THEORETICAL QUANTITIES. FOR ACTUAL QUANTITIES, REFER TO PROJECT LEDGER AND/OR COMPUTATION BOOK.

RESIDENT ENGINEER  
DATE

DEPARTMENT OF TRANSPORTATION  
STATE OF HAWAII  
APPROVED:  
DIR. OF TRANSPORTATION  
DATE

ATA  
DESIGNED BY  
KARL KUNISHIGE  
P. S. & E. BY  
587-2173  
PHONE  
MARCH 1998  
DATE