
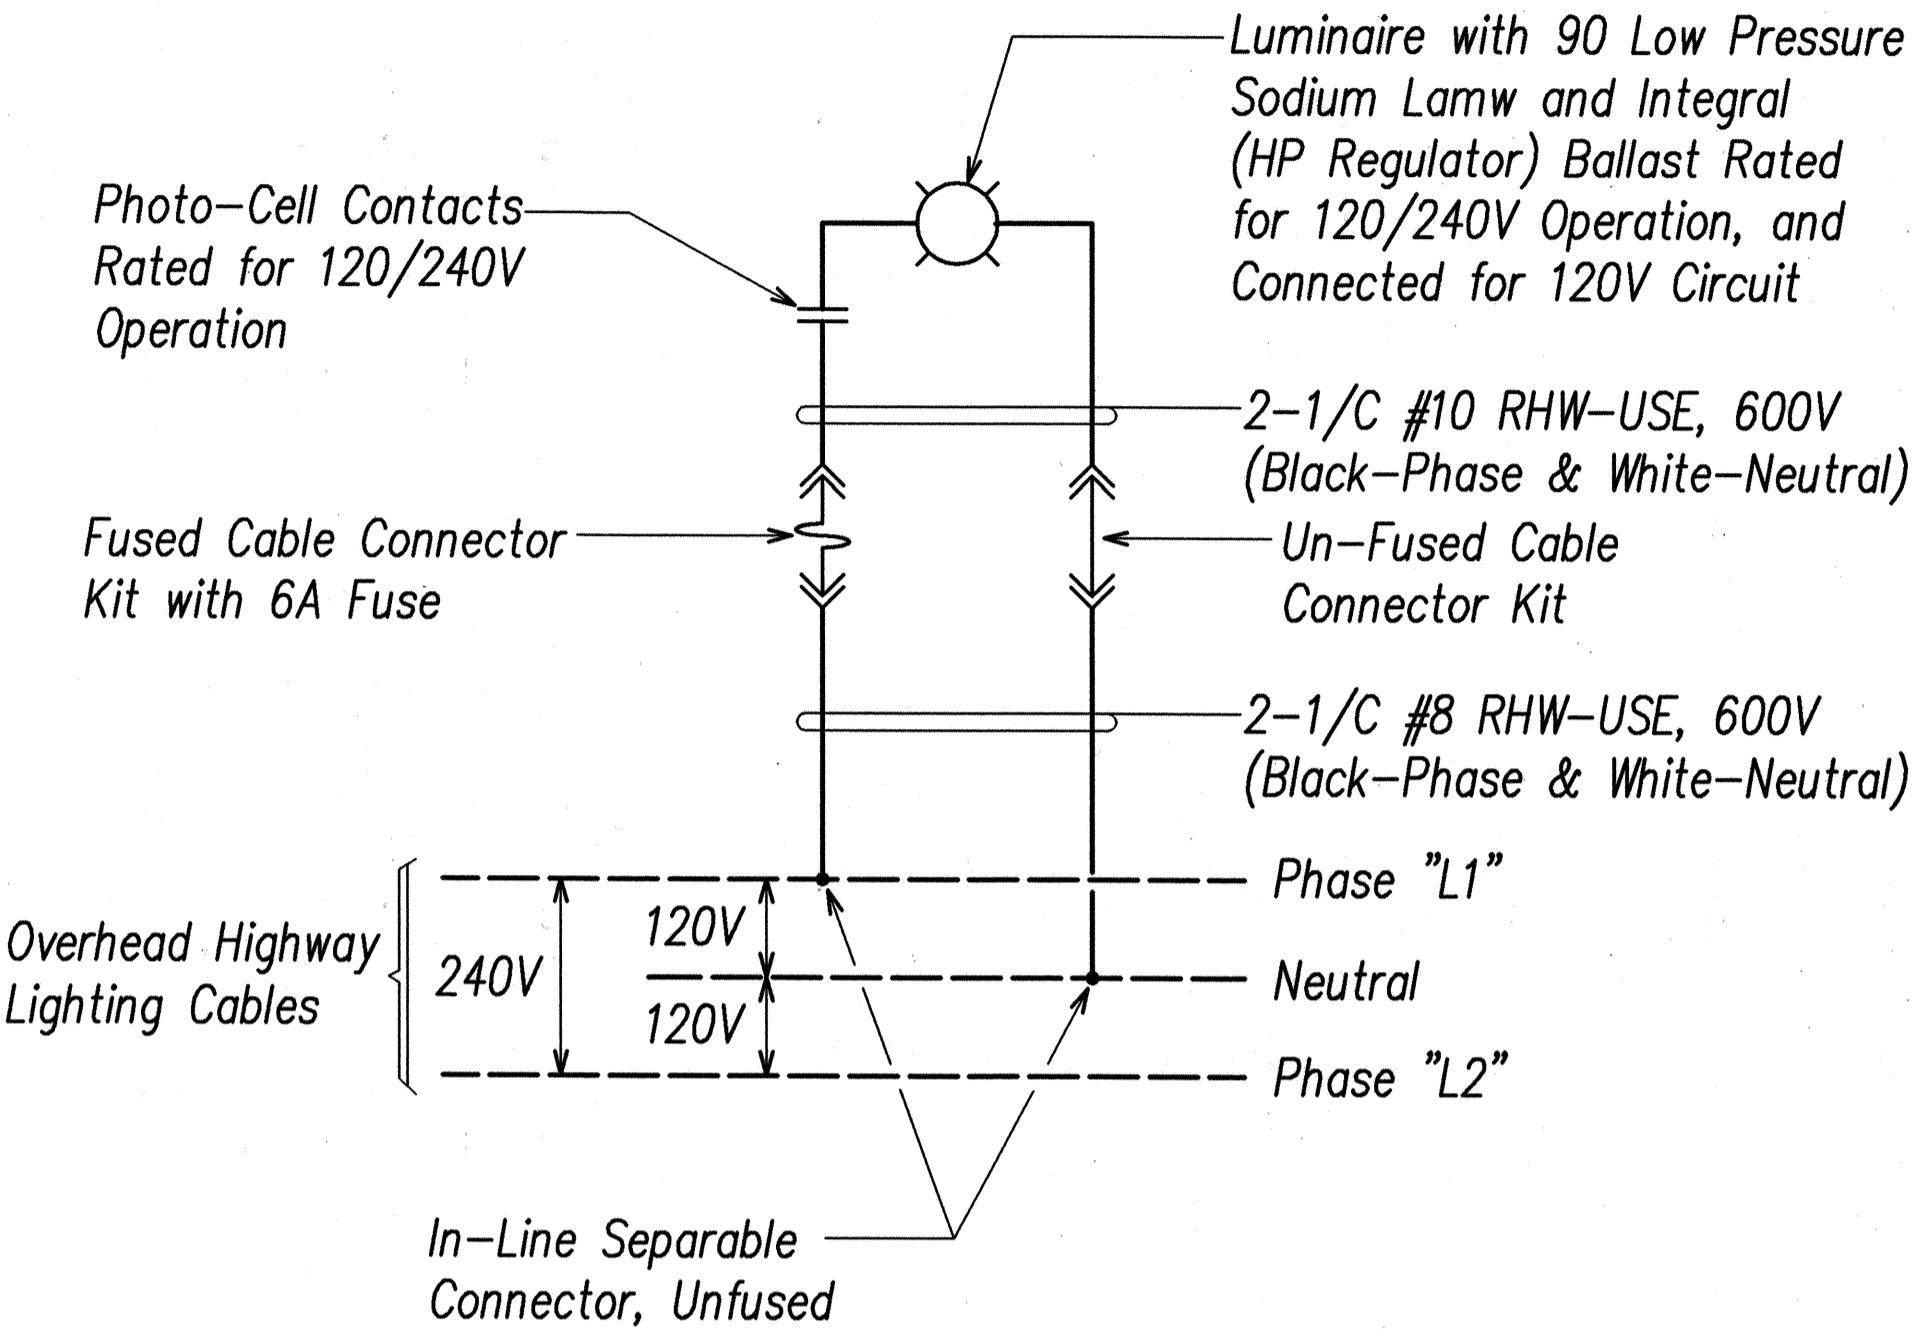


FED. ROAD DIST. NO.	STATE	PROJ. NO.	FISCAL YEAR	SHEET NO.	TOTAL SHEETS
HAWAII	HAW.	11M-01-00	2002	61	65

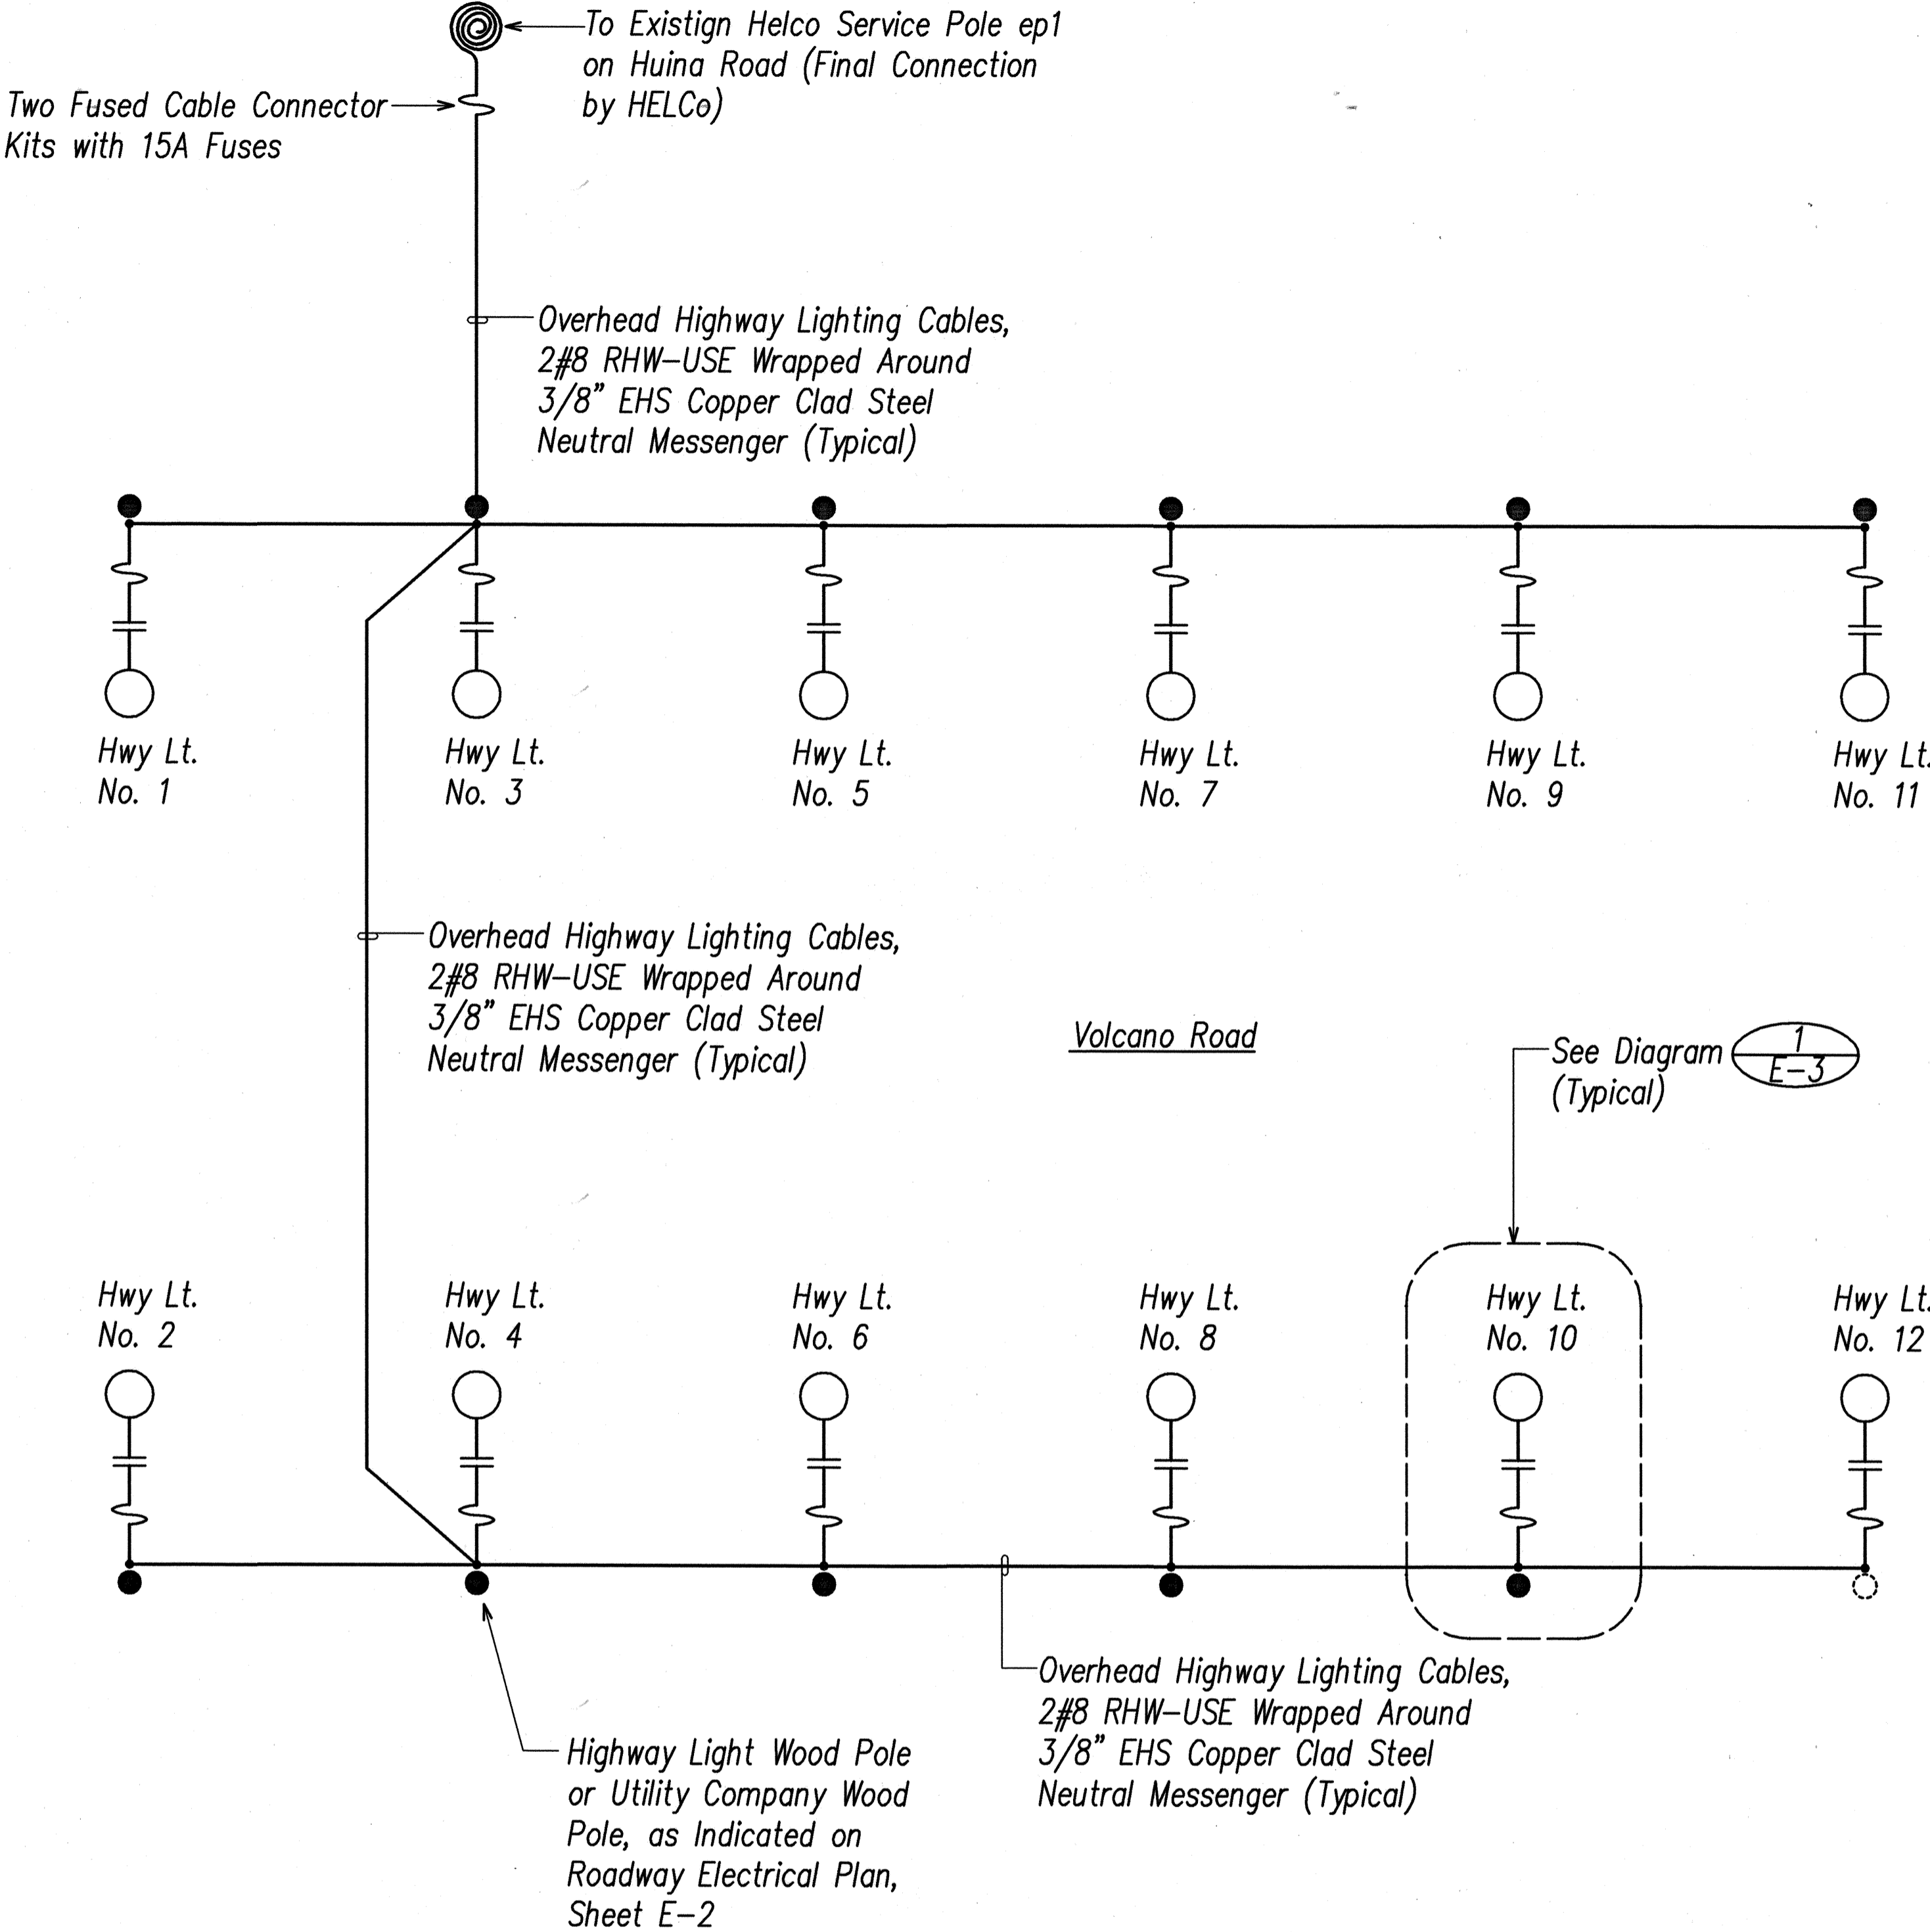


1 E-3 TYPICAL HIGHWAY LIGHT LUMINAIRE CONNECTION DIAGRAM

HIGHWAY LIGHTING SYSTEM ONE-LINE DIAGRAM

ORIGINAL PLAN	SURVEY PLOTTED BY	DATE
DRAWN BY		
DESIGNED BY		
CHECKED BY		
NOTED BY		
DATE		

LAST SAVE: 08/13/01 10:28:24 BY: JAM/PLT/S2: 1-7-01
Z:\ACAD\PROJECTS\2000A\2000A.ECS\HWL1DAS

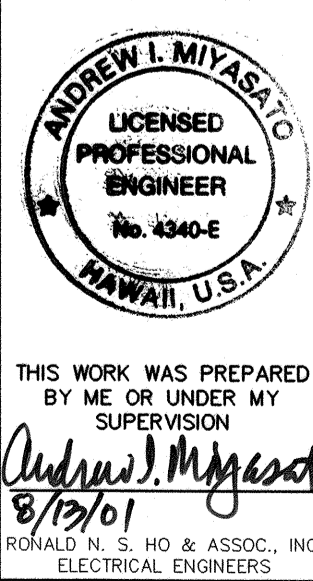

DATE	REVISION
STATE OF HAWAII DEPARTMENT OF TRANSPORTATION HIGHWAYS DIVISION	
HIGHWAY LIGHTING SYSTEM ONE-LINE DIAGRAM	
VOLCANO ROAD INTERSECTION IMPROVEMENTS AT HUINA ROAD	
State Project No. 11M-01-00	
SCALE: AS NOTED	DATE: AUGUST, 2001
SHEET No. E-3 OF 7 SHEETS	