


| INDEX TO DRAWINGS |                                            |
|-------------------|--------------------------------------------|
| SHEET NO.         | DESCRIPTION                                |
| 1                 | TITLE SHEET                                |
| 2                 | STANDARD PLANS SUMMARY                     |
| 3-6               | NOTES                                      |
| 7                 | GENERAL PLAN                               |
| 8-10              | TYPICAL ROADWAY SECTIONS                   |
| 11-12             | GEOMETRIC LAYOUTS                          |
| 13-17             | ROADWAY PLANS - VOLCANO ROAD               |
| 18                | PLAN AND PROFILE - HUINA ROAD              |
| 19-23             | GRADING PLANS                              |
| 24                | PAVEMENT MARKING LEGEND, DETAILS AND NOTES |
| 25-28             | PAVEMENT MARKING AND TRAFFIC SIGNING PLANS |
| 29                | TRAFFIC DETAILS AND SUMMARIES              |
| 30-33             | DETAILS                                    |
| 34                | DRAIN PROFILES                             |
| 35-37             | GUARDRAIL DETAILS                          |
| 38-42             | CROSS SECTIONS                             |
| 43                | DRAINAGE RUNOFF MAP                        |
| 44-50             | TRAFFIC CONTROL PLANS                      |
| 51-54             | CONSTRUCTION PHASING PLANS                 |
| 55-58             | STRUCTURAL DETAILS                         |
| 59                | LOCATION MAP, ELECTRICAL SYMBOLS, INDEX OF |
|                   | ELECTRICAL DRAWINGS                        |
| 60                | ROADWAY ELECTRICAL PLANS                   |
| 61                | HIGHWAY LIGHTING SYSTEM ONE-LINE DIAGRAM   |
| 62                | HIGHWAY LIGHTING INSTALLATION DETAILS      |
| 63                | HIGHWAY LIGHTING WOOD POLE AND GUYING      |
|                   | INSTALLATION DETAILS                       |
| 64                | TELEPHONE POLE LINE RELOCATION ELECTRICAL  |
|                   | PLANS                                      |
| 65                | TRENCH RESTORATION AND DUCT ENCASEMENT     |
|                   | DETAILS                                    |

STATE OF HAWAII  
DEPARTMENT OF TRANSPORTATION  
HIGHWAYS DIVISION  
HONOLULU, HAWAII  
**"AS-BUILT"**  
PLANS FOR  
CONSTRUCTION OF  
VOLCANO ROAD INTERSECTION  
IMPROVEMENTS AT HUINA ROAD  
PROJECT NO. 11M-01-00  
DISTRICT OF PUNA  
ISLAND OF HAWAII

## LOCATION PLAN

GROSS LENGTH OF PROJECT ..... 0.33 MILES  
NET LENGTH OF ROADWAY ..... 0.33 MILES

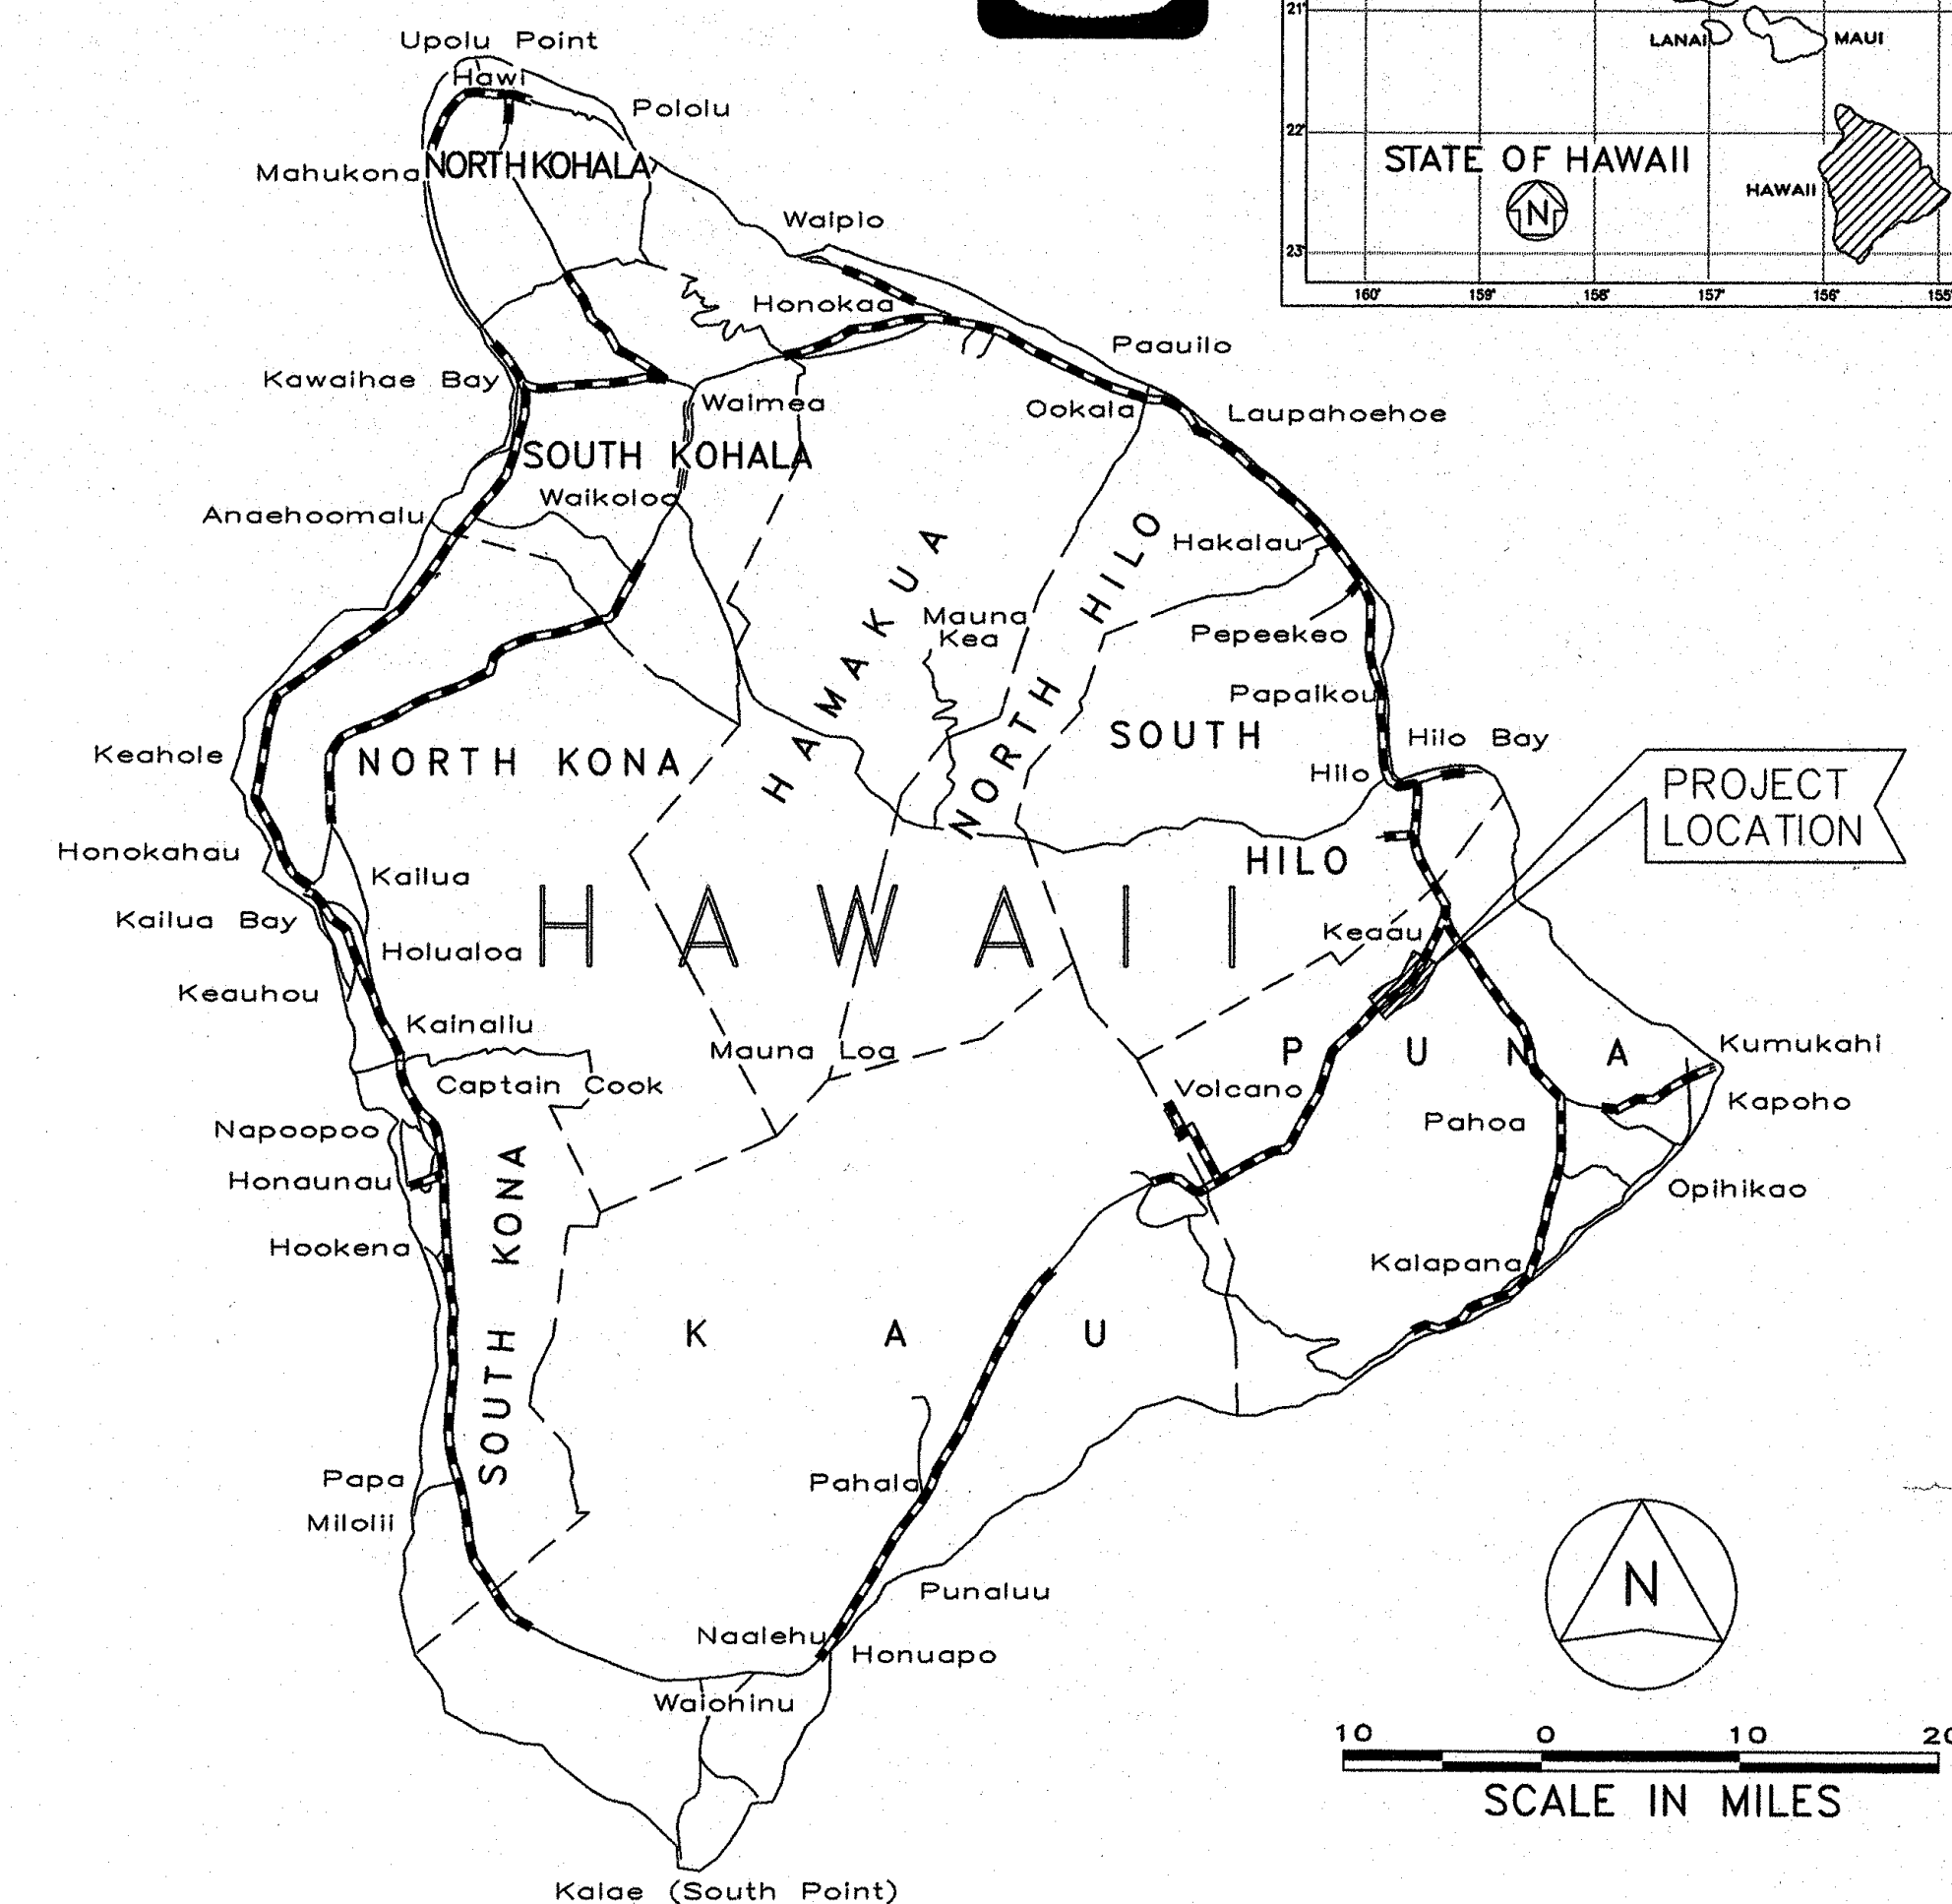

DEPARTMENT OF WATER SUPPLY