


FED. ROAD DIST. NO.	STATE	FED. AID PROJ. NO.	FISCAL YEAR	SHEET NO.	TOTAL SHEETS
HAWAII	HAW.	STP-011-2(32)	1999	34	34

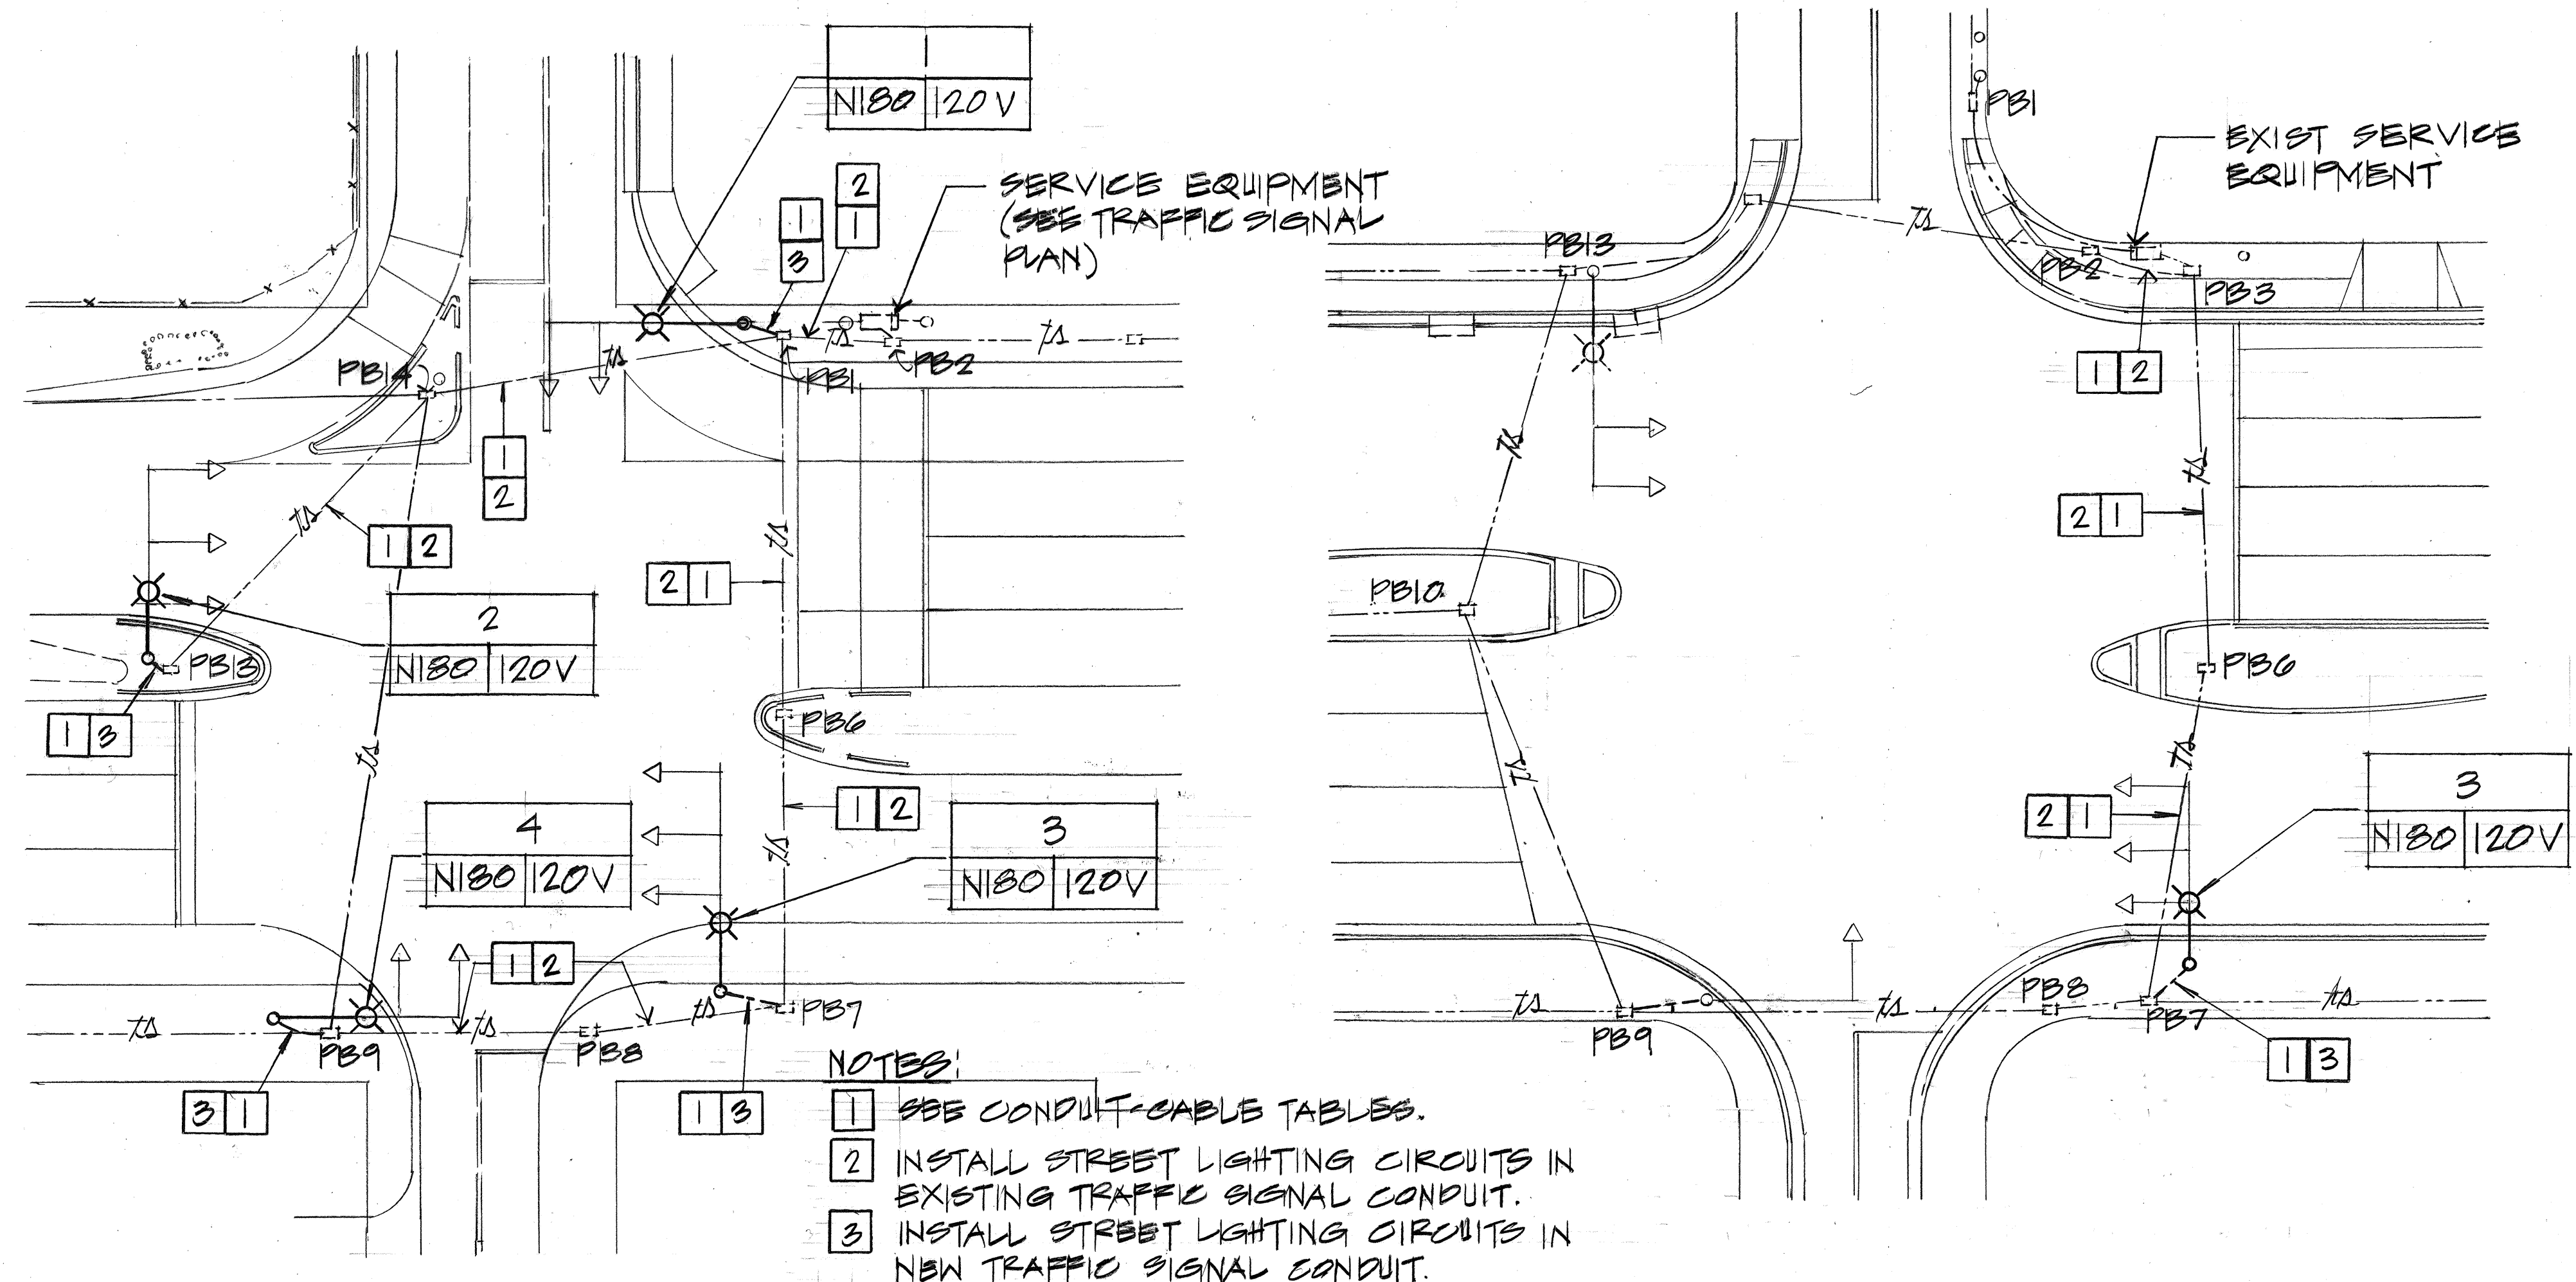

ELECTRICAL SYMBOLS

EXIST

NEW

STREET LIGHT, 180 WATTS LOW PRESSURE SODIUM ON TYPE III TRAFFIC SIGNAL STANDARD

STREET LIGHT IDENTIFICATION TAG

A : STREET LIGHT POLE NUMBER


B : LAMP TYPE/WATTAGE

C : VOLTAGE RATING

TRAFFIC SIGNAL PULLBOX

UNDERGROUND DICTIONLINE


NOTE DESIGNATION

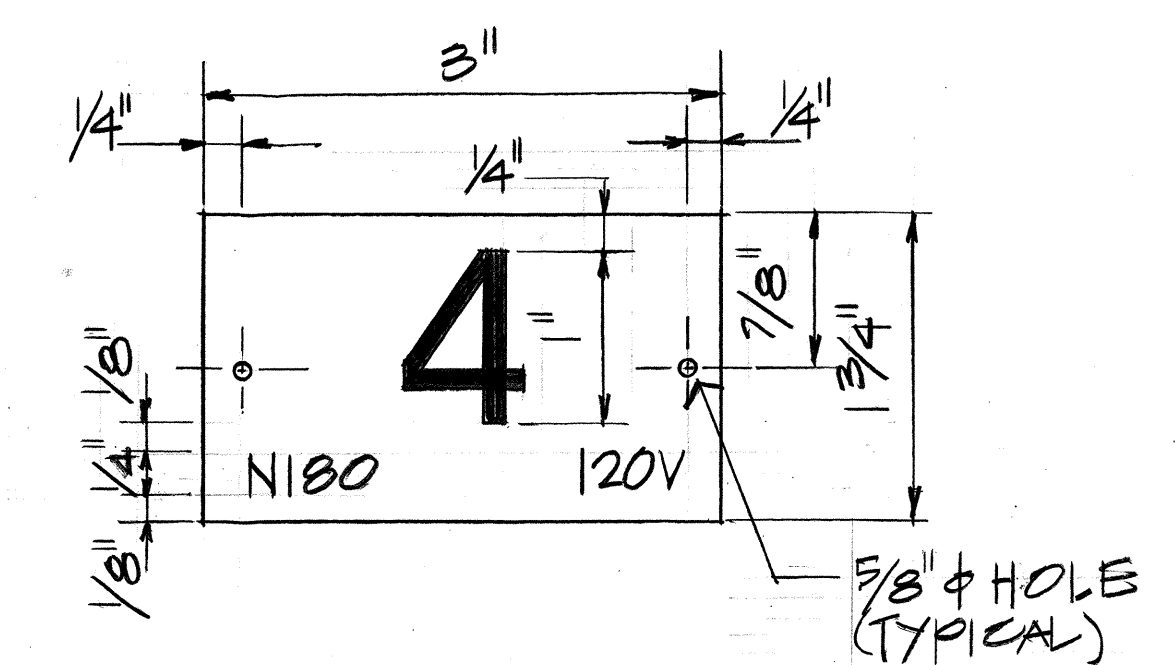

(KANOELEHUA AVE/E. KAHAOPEA ST. INTERSECTION) (KANOELEHUA AVE/LEILANI ST. INTERSECTION)

STREET LIGHTING PLANS

SCALE: 1" = 20'

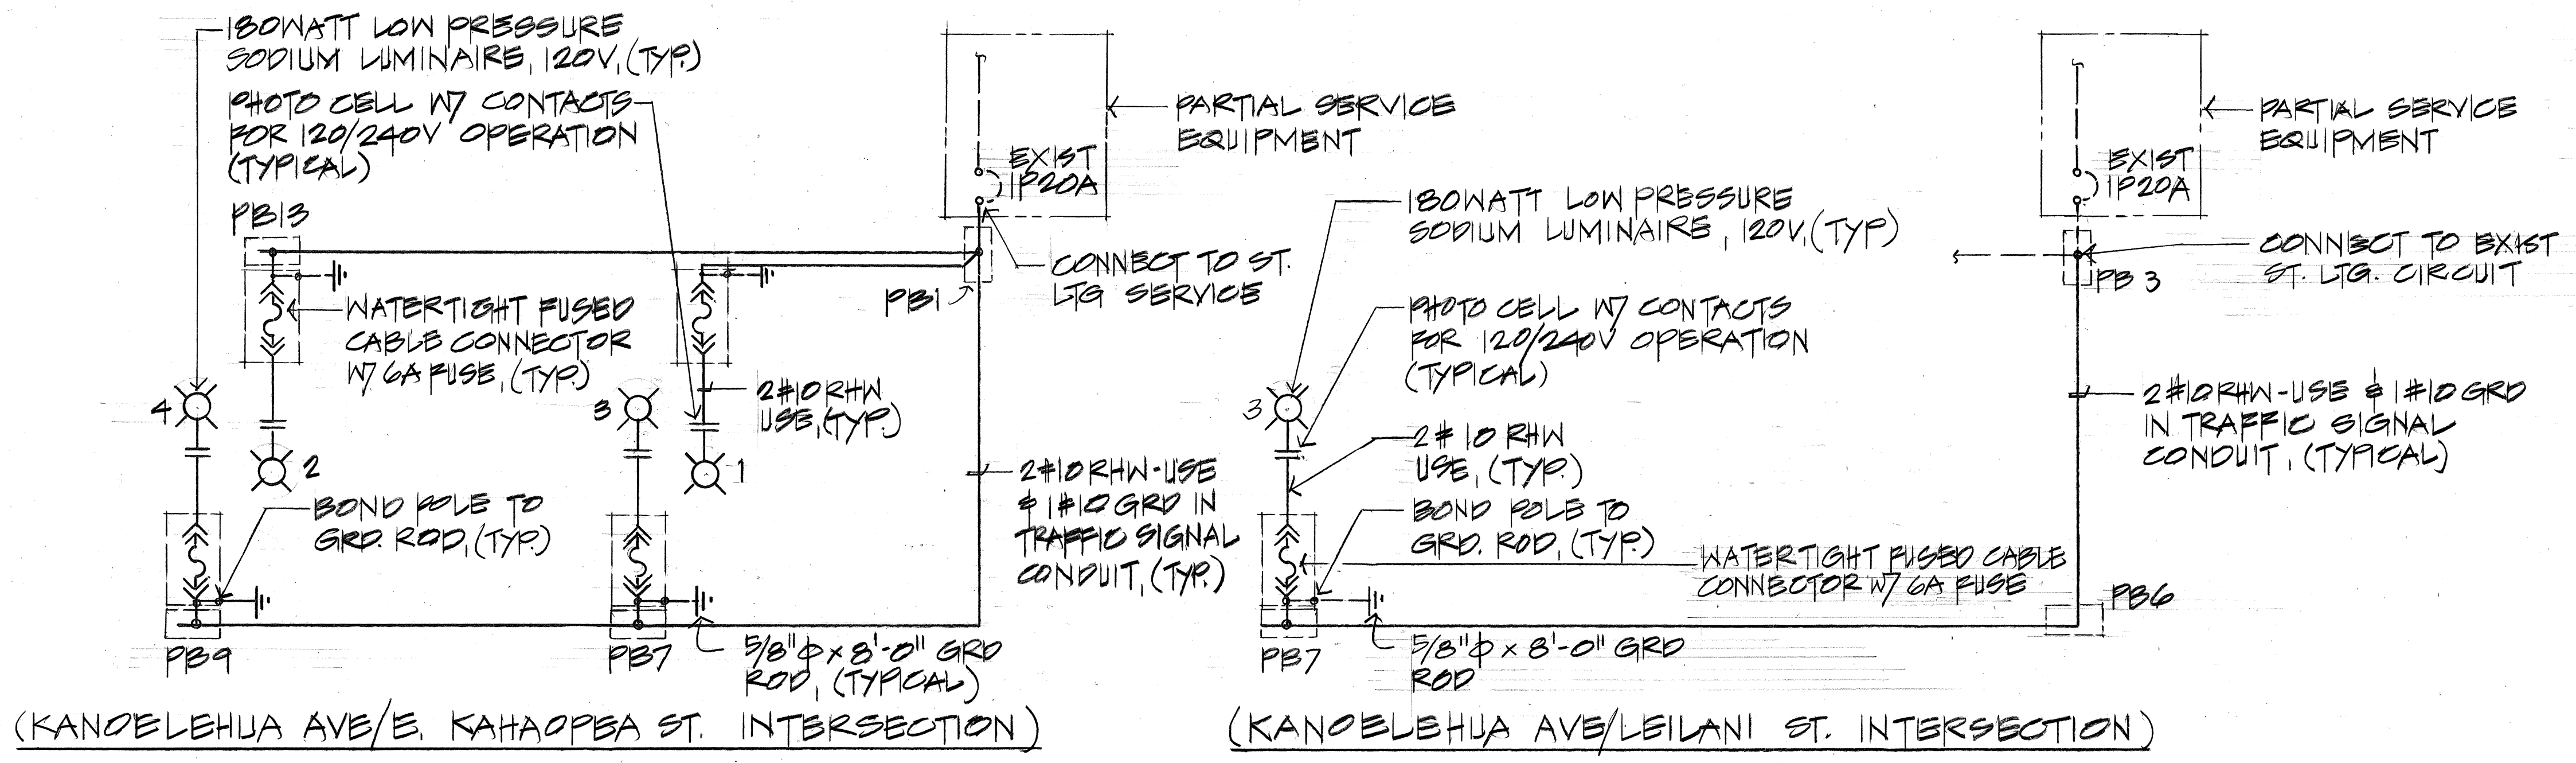

(KANOELEHUA AVE/E. KAHAOPEA ST. INTERSECTION) (KANOELEHUA AVE/LEILANI ST. INTERSECTION)

SINGLE LINE DIAGRAMS


NO SCALE

- NOTES:**
- USE 2 PLY PLASTIC BLACK WHITE.
 - NUMBER SIZE SHALL BE 1" HIGH AND ENGRAVED 1/8" WIDE, WHITE COLOR. (NUMBER AS REQUIRED)
 - NOMENCLATURE SHALL BE 1/4" HIGH AND ENGRAVED 1/32" WIDE, WHITE IN COLOR. (WATTAGE AND VOLTAGE AS REQUIRED)
 - ATTACHED TO STEEL POLES WITH #7 DRIVE SCREWS.
 - USE "N" FOR LOW PRESSURE SODIUM LAMPS.

POLE IDENTIFICATION TAG DETAIL

NOT TO SCALE

SURVEY PLOTTED BY	DATE
DESIGNED BY	
TRACED BY	
QUANTITIES BY	
CHECKED BY	
NOTE BOOK	
No.	

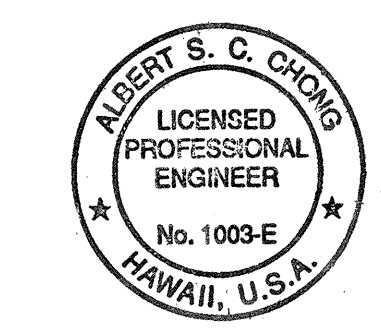

THIS WORK WAS PREPARED BY ME
OR UNDER MY SUPERVISION
Albert S. C. Chong

STATE OF HAWAII
DEPARTMENT OF TRANSPORTATION
HIGHWAYS DIVISION

STREET LIGHTING PLAN

KANOELEHUA AVENUE
TRAFFIC SIGNAL MODERNIZATION
F.A. PROJ. NO. STP-011-2(32)

SCALE: AS SHOWN DATE: OCT. 1998

SHEET NO. 1 OF 1 SHEETS