



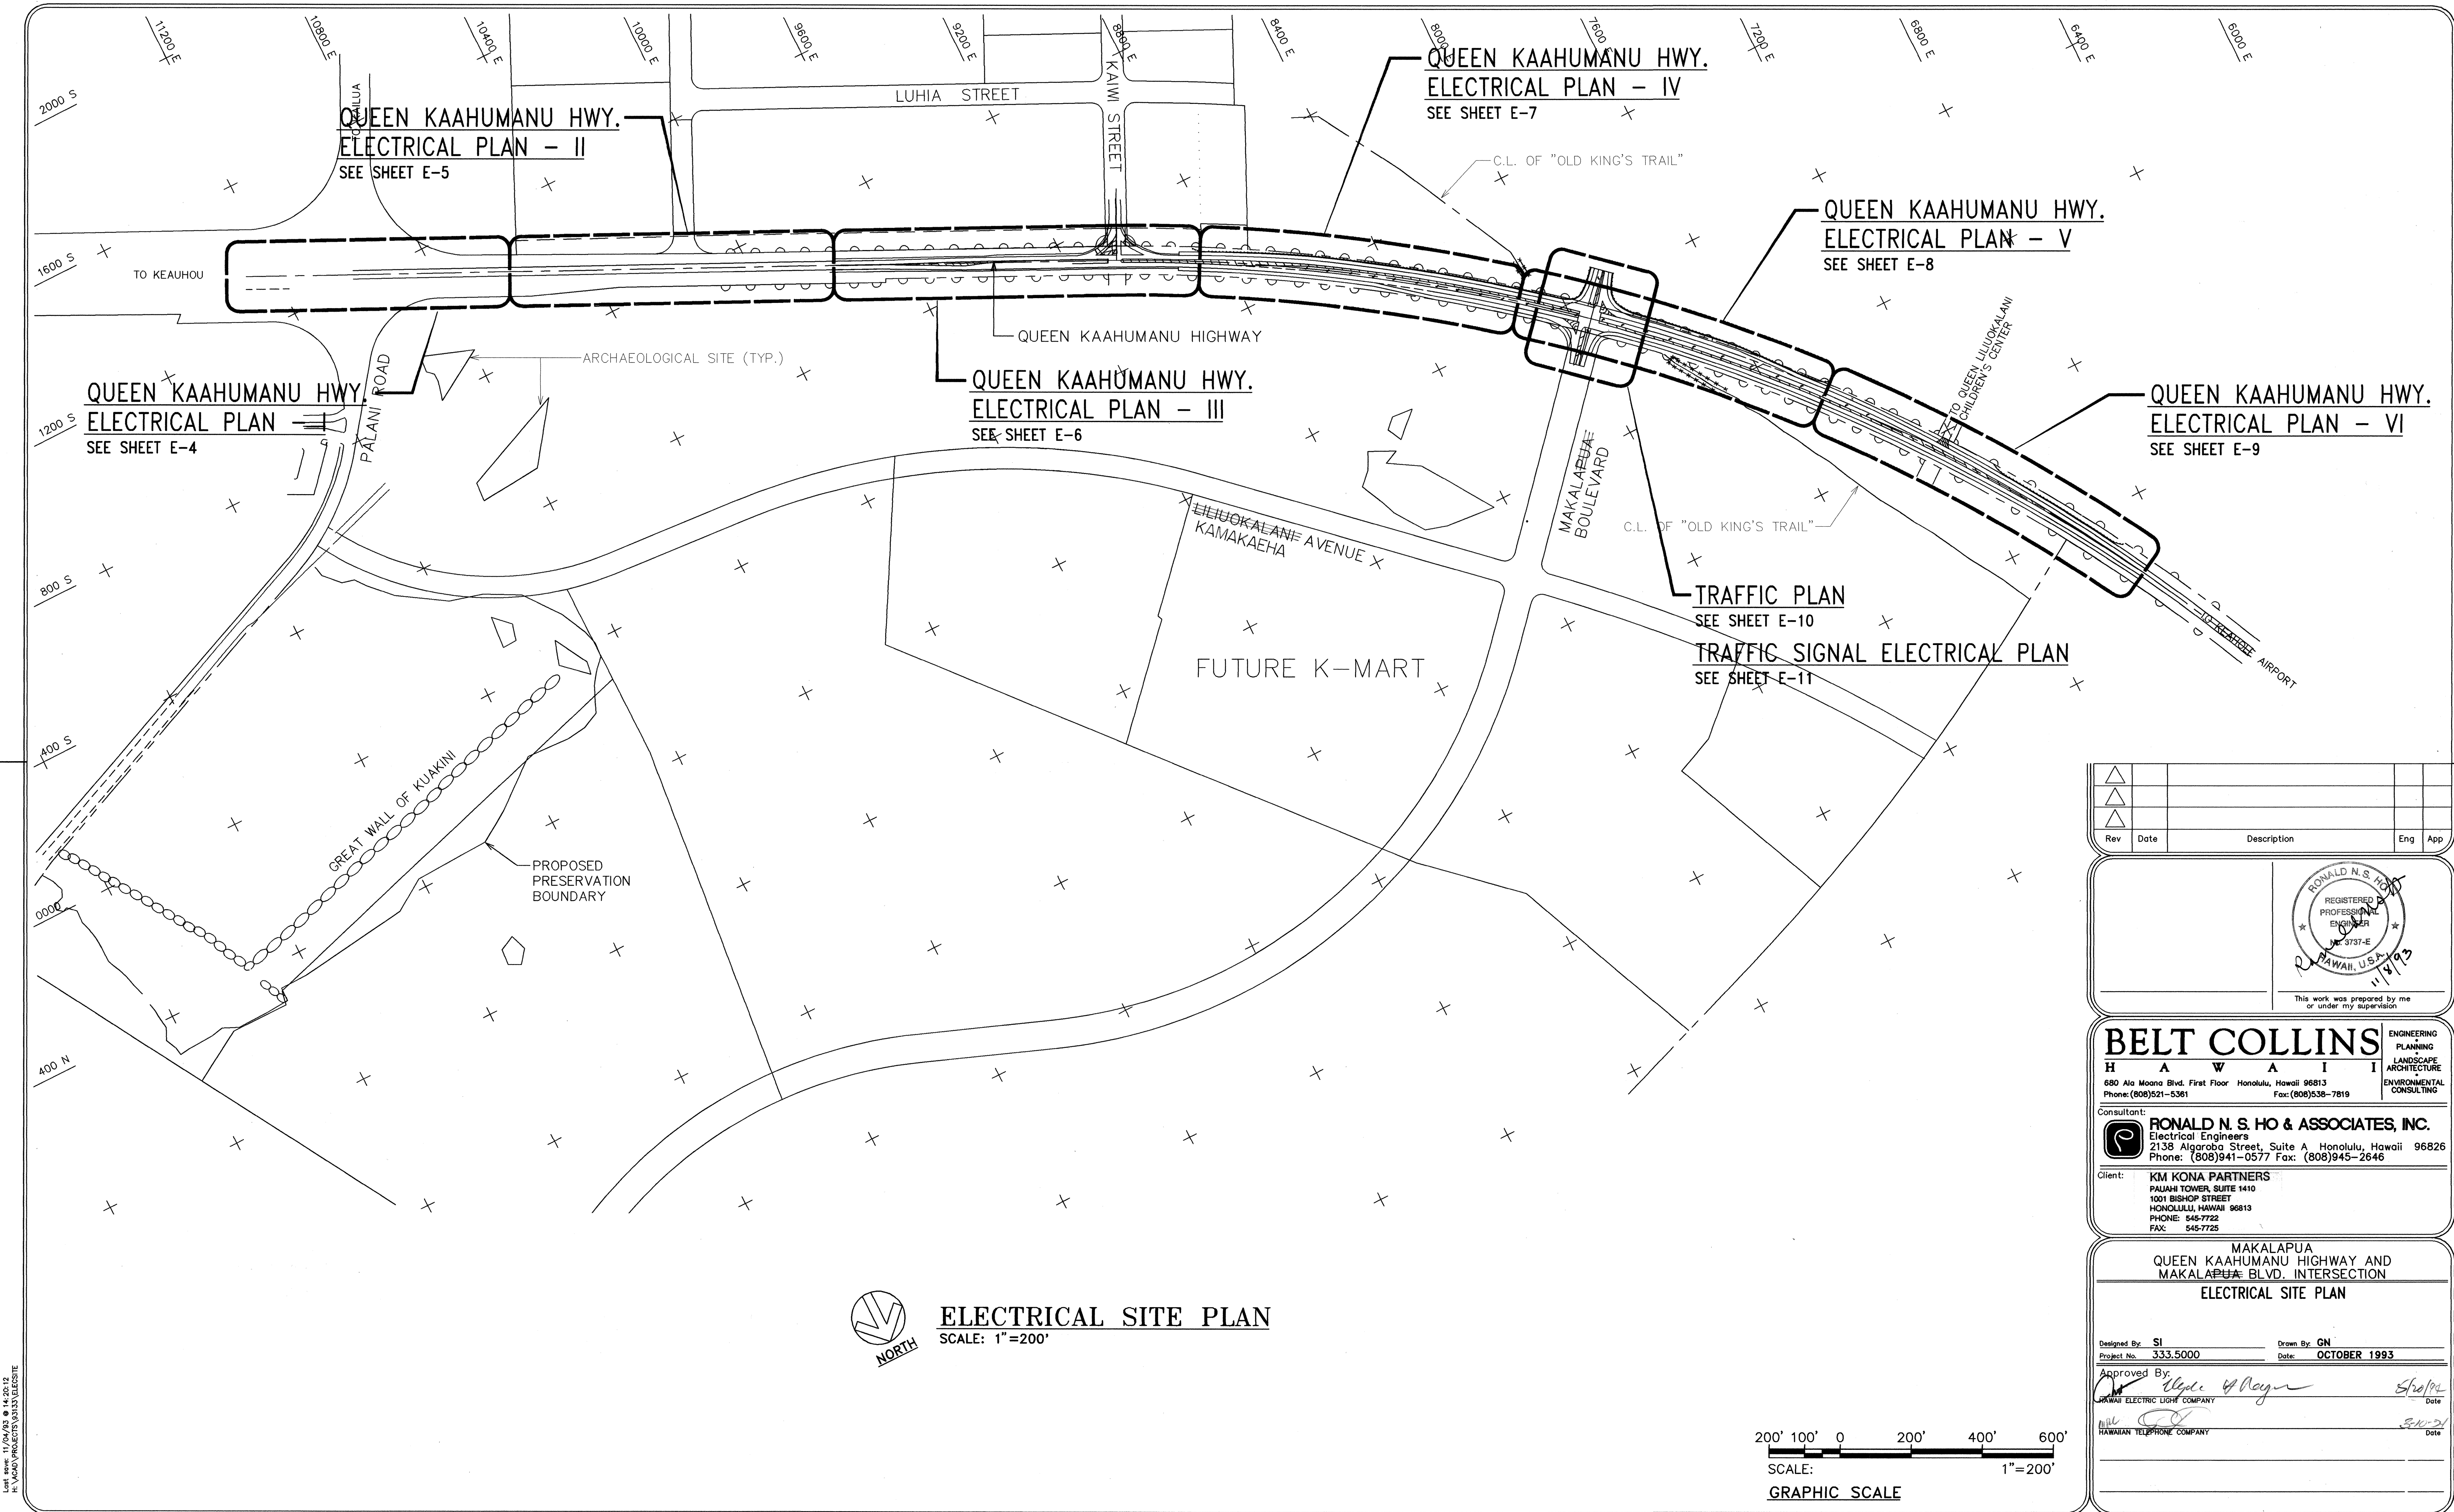

Rev	Date	Description	Eng	App

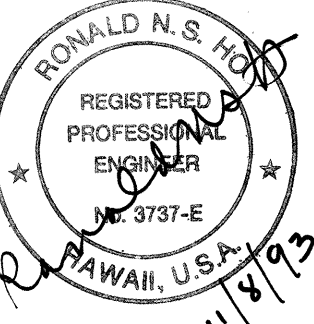

This work was prepared by me or under my supervision

BELT COLLINS
HAWAII
680 Ala Moana Blvd. First Floor Honolulu, Hawaii 96813
Phone: (808)521-5361 Fax: (808)538-7819

ENGINEERING
PLANNING
LANDSCAPE
ARCHITECTURE
ENVIRONMENTAL
CONSULTING

Consultant:
**RONALD N. S. HO & ASSOCIATES, INC.**
Electrical Engineers
2138 Algoroba Street, Suite A Honolulu, Hawaii 96826
Phone: (808)941-0577 Fax: (808)945-2646

Client:
KIM KONA PARTNERS
PALUHI TOWER, SUITE 1410
1001 BISHOP STREET
HONOLULU, HAWAII 96813
PHONE: 545-7722
FAX: 545-7725

MAKALAPUA
QUEEN KAAHUMANU HIGHWAY AND
MAKALAPUA BLVD. INTERSECTION
ELECTRICAL SITE PLAN

Designed By: **SI** Drawn By: **GN**
Project No. **333.5000** Date: **OCTOBER 1993**

Approved By:  Date: 
HAWAII ELECTRIC LIGHT COMPANY
HAWAIIAN TELEPHONE COMPANY

FILE	POCKET	FOLDER	NO.

East arrow 1/10/93 11:00 AM
11/10/93 11:00 AM

Trim: 22"x36"