
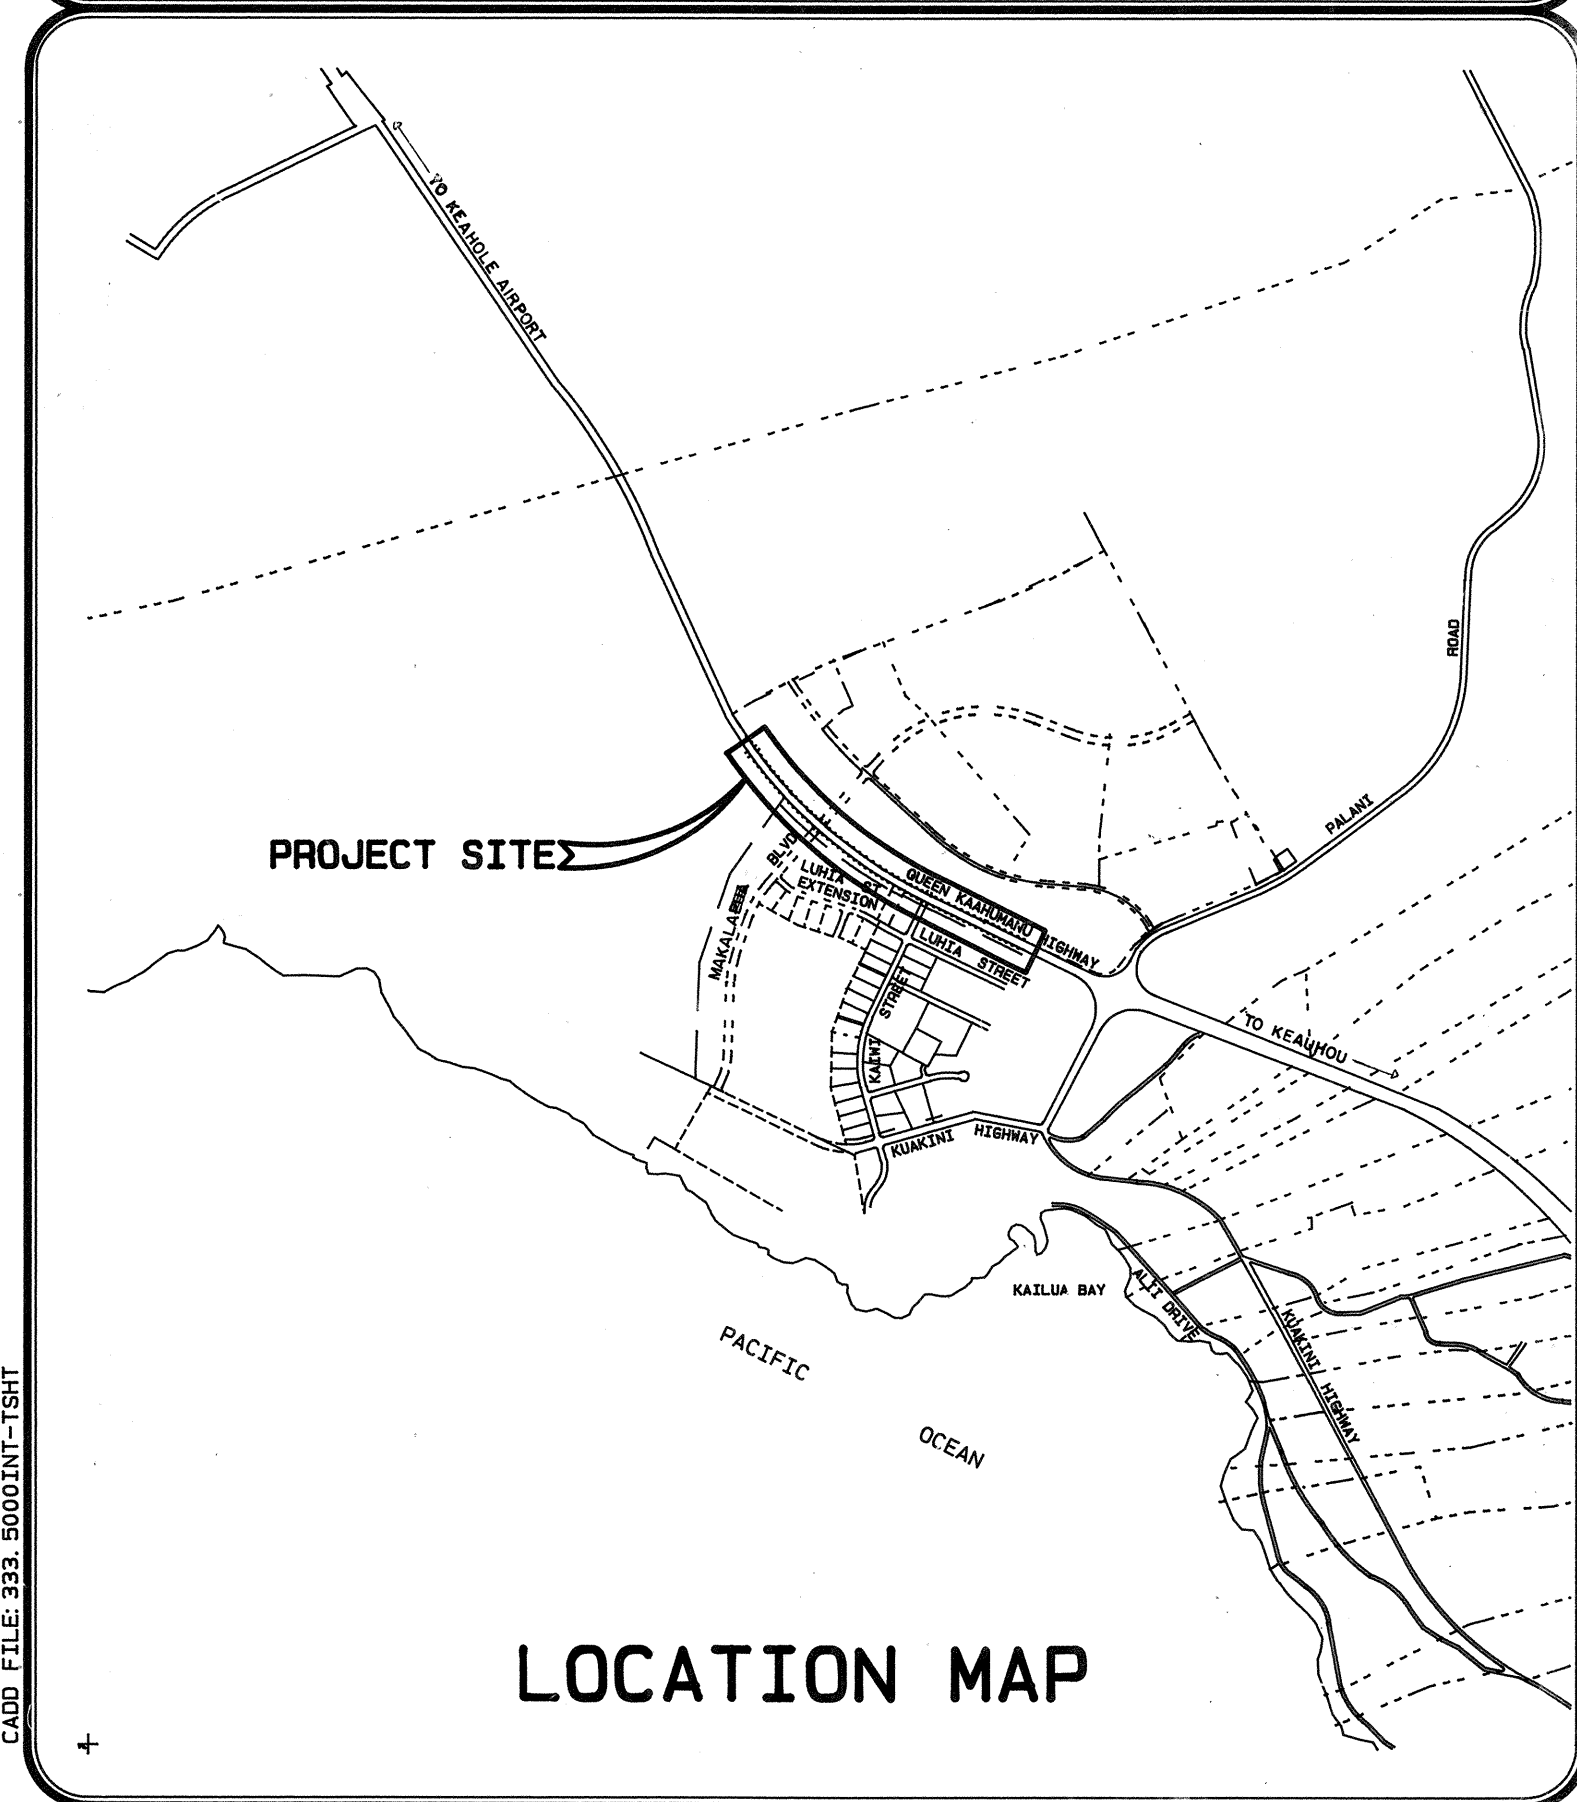
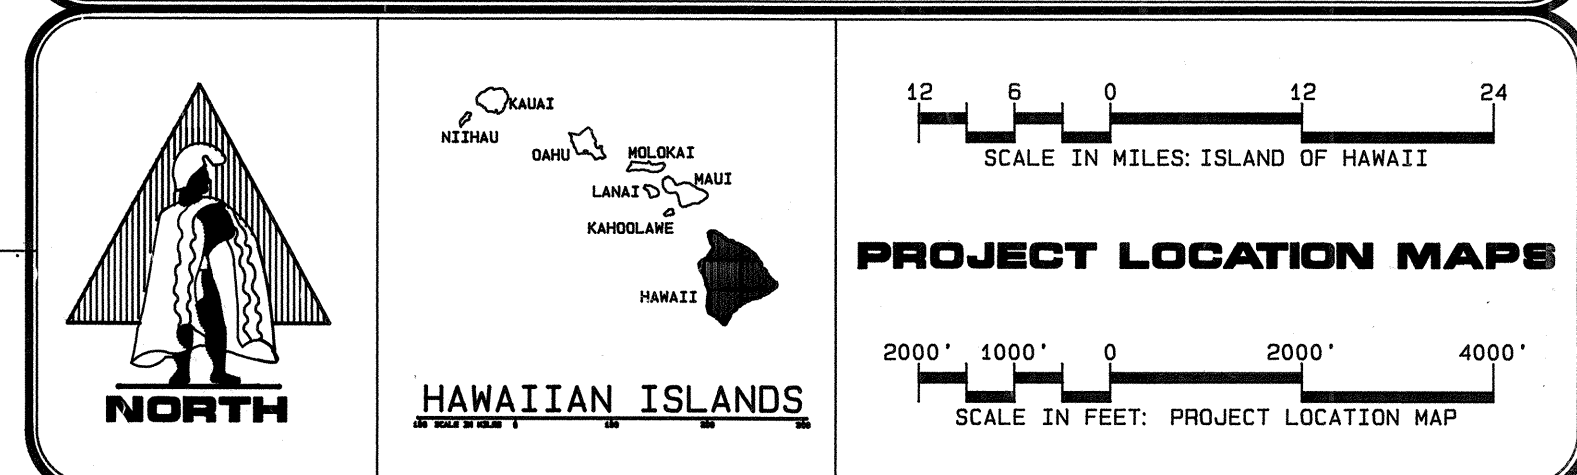


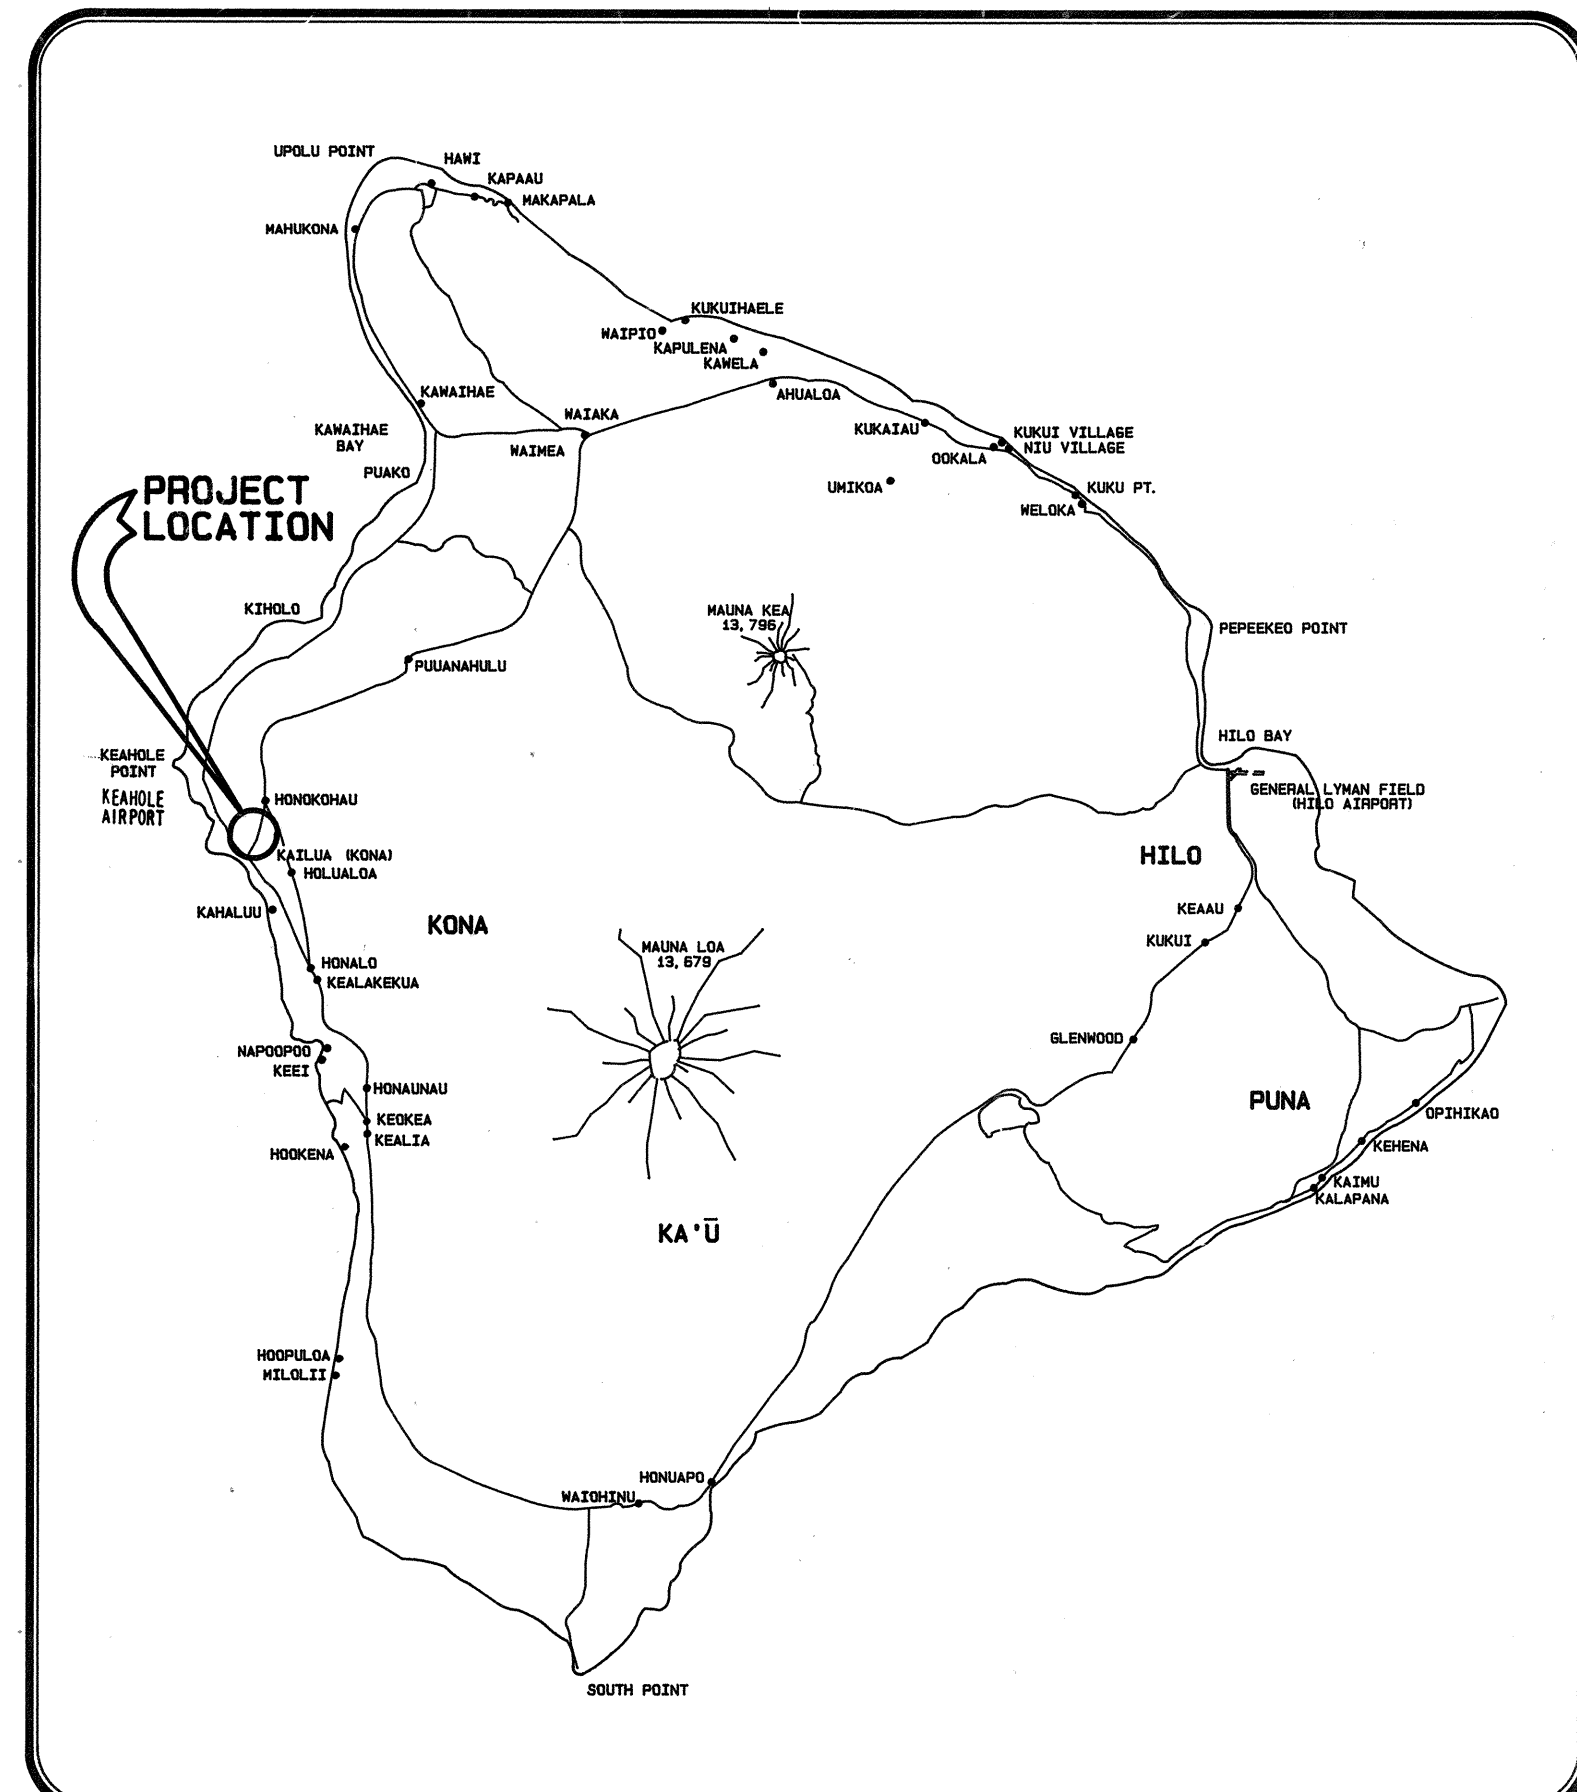

Trim:22"x36"

CONSTRUCTION PLANS FOR:

MAKALAPUA

SIGNALIZED INTERSECTION AT QUEEN KAAHUMANU HIGHWAY AND MAKALAPUA BOULEVARD

LOCATION: KEAHUOLU NORTH KONA, HAWAII
TMK: 7-04-08

PREPARED FOR:
KM KONA PARTNERS
PAUAAH Tower, Suite 1410
1001 BISHOP STREET
HONOLULU, HAWAII, 96813
PHONE: 545-7722
FAX: 545-7725

PLANS FOR:
QUEEN KAAHUMANU HIGHWAY
SIGNALIZED INTERSECTION AT
QUEEN KAAHUMANU HIGHWAY
AND MAKALAPUA BOULEVARD
PROJECT NO. **19A-02-94**
DISTRICT OF NORTH KONA
ISLAND OF HAWAII

PREPARED BY:
BELT COLLINS
HAWAII
ENGINEERING
PLANNING
LANDSCAPE ARCHITECTURE
ENVIRONMENTAL CONSULTING
680 ALA MOANA BOULEVARD, FIRST FLOOR
HONOLULU, HAWAII 96813
PHONE (808) 521-5361 • FAX (808) 538-7819

INDEX OF DRAWINGS		
SHEET NO.	SHEET	DESCRIPTION
CIVIL DRAWINGS		
1	C-1	TITLE SHEET
2	C-2	STANDARD PLANS SUMMARY
3	C-3	GENERAL SITE PLAN
4-5	C-4	CONSTRUCTION NOTES - 1
	C-5	CONSTRUCTION NOTES - 2
6-9	C-6	PLAN AND PROFILE - 1 QUEEN KAAHUMANU HIGHWAY
	C-7	PLAN AND PROFILE - 2 QUEEN KAAHUMANU HIGHWAY
	C-8	PLAN AND PROFILE - 3 QUEEN KAAHUMANU HIGHWAY
	C-9	PLAN AND PROFILE - 4 QUEEN KAAHUMANU HIGHWAY
10	C-10	TYPICAL SECTIONS
11	C-11	ROADWAY DETAILS
12	C-12	INTERSECTION DETAIL
13	C-13	SEWER AND WATER DETAILS
13-14	C-14	MISCELLANEOUS DETAILS
	C-15	MISCELLANEOUS PROFILE
15-16	C-16	SIGNING AND STRIPING PLAN
	C-17	INTERSECTION STRIPING DETAIL
17-20	C-18	TRAFFIC CONTROL NOTES AND DETAILS MISC. DETAILS
	C-19	TRAFFIC CONTROL PLAN - MAUKA WIDENING
	C-20	TRAFFIC CONTROL PLAN - MAKAI WIDENING
	C-21	TRAFFIC CONTROL PLAN - UTILITY CROSSING
21-29	C-22	CROSS SECTIONS STA. 23+00 TO STA. 26+50
	C-23	CROSS SECTIONS STA. 27+00 TO STA. 30+50
	C-24	CROSS SECTIONS STA. 31+00 TO STA. 33+50
	C-25	CROSS SECTIONS STA. 34+00 TO STA. 35+50
	C-26	CROSS SECTIONS STA. 36+00 TO STA. 38+50
	C-27	CROSS SECTIONS STA. 39+00 TO STA. 42+50
	C-28	CROSS SECTIONS STA. 43+00 TO STA. 46+50
	C-29	CROSS SECTIONS STA. 47+00 TO STA. 52+50
	C-30	SEWER DETAILS
ELECTRICAL DRAWINGS		
30	E-1	VICINITY MAP, LOCATION MAP, EQUIPMENT SCHEDULE, ELECTRICAL SYMBOLS
31	E-2	NOTES
32	E-3	ELECTRICAL SITE PLAN
33-38	E-4	QUEEN KAAHUMANU HIGHWAY ELECTRICAL PLAN - I
	E-5	QUEEN KAAHUMANU HIGHWAY ELECTRICAL PLAN - II
	E-6	QUEEN KAAHUMANU HIGHWAY ELECTRICAL PLAN - III
	E-7	QUEEN KAAHUMANU HIGHWAY ELECTRICAL PLAN - IV
	E-8	QUEEN KAAHUMANU HIGHWAY ELECTRICAL PLAN - V
	E-9	QUEEN KAAHUMANU HIGHWAY ELECTRICAL PLAN - VI
39-40	E-10	TRAFFIC PLAN
41	E-11	TRAFFIC SIGNAL ELECTRICAL PLAN
42	E-12	TYPICAL DUCT SECTIONS
43	E-13	LOOP DETECTOR & TRAFFIC SIGNAL CONTROLLER DETAILS
44	E-14	TRAFFIC SIGNAL DETAILS
45	E-15	TRAFFIC SIGNAL DETAILS
46	E-16	STREET LIGHT DETAILS
47	E-17	SINGLE-LINE DIAGRAM, MISCELLANEOUS DETAILS

DESIGN INFORMATION
DESIGN SPEED = 50 MPH
POSTED SPEED = 45 MPH
PROJECT LOCATED BETWEEN MILE POST 98.06 AND MILE POST 99.43

APPROVED BY:

Stefan H. Menden 18 Oct 94
CHIEF, HIGHWAYS DIVISION, DEPARTMENT OF TRANSPORTATION, STATE OF HAWAII
(APPROVAL GRANTED FOR WORK WITHIN STATE RIGHT-OF-WAY ONLY)
APPROVAL LETTER HIGHWAY HWY-CM 2.2733 DATED 08/09/1994
ID NO. H-93-8
William S. Smith 10/20/94
MANAGER, DEPARTMENT OF WATER SUPPLY, (M. 9.0)
COUNTY OF HAWAII
David P. Smith 10/20/94
CHIEF, ENVIRONMENTAL MANAGEMENT DIVISION, DEPARTMENT OF HEALTH,
STATE OF HAWAII

RECORD DRAWINGS
These Record Drawings have been prepared based on information provided by others. The Design Professional has not verified the accuracy and/or completeness of this information and shall not be responsible for any errors or omissions which may be incorporated herein as a result.
Date: 12/22/94 By: *David P. Smith*
BELT COLLINS HAWAII LTD.