


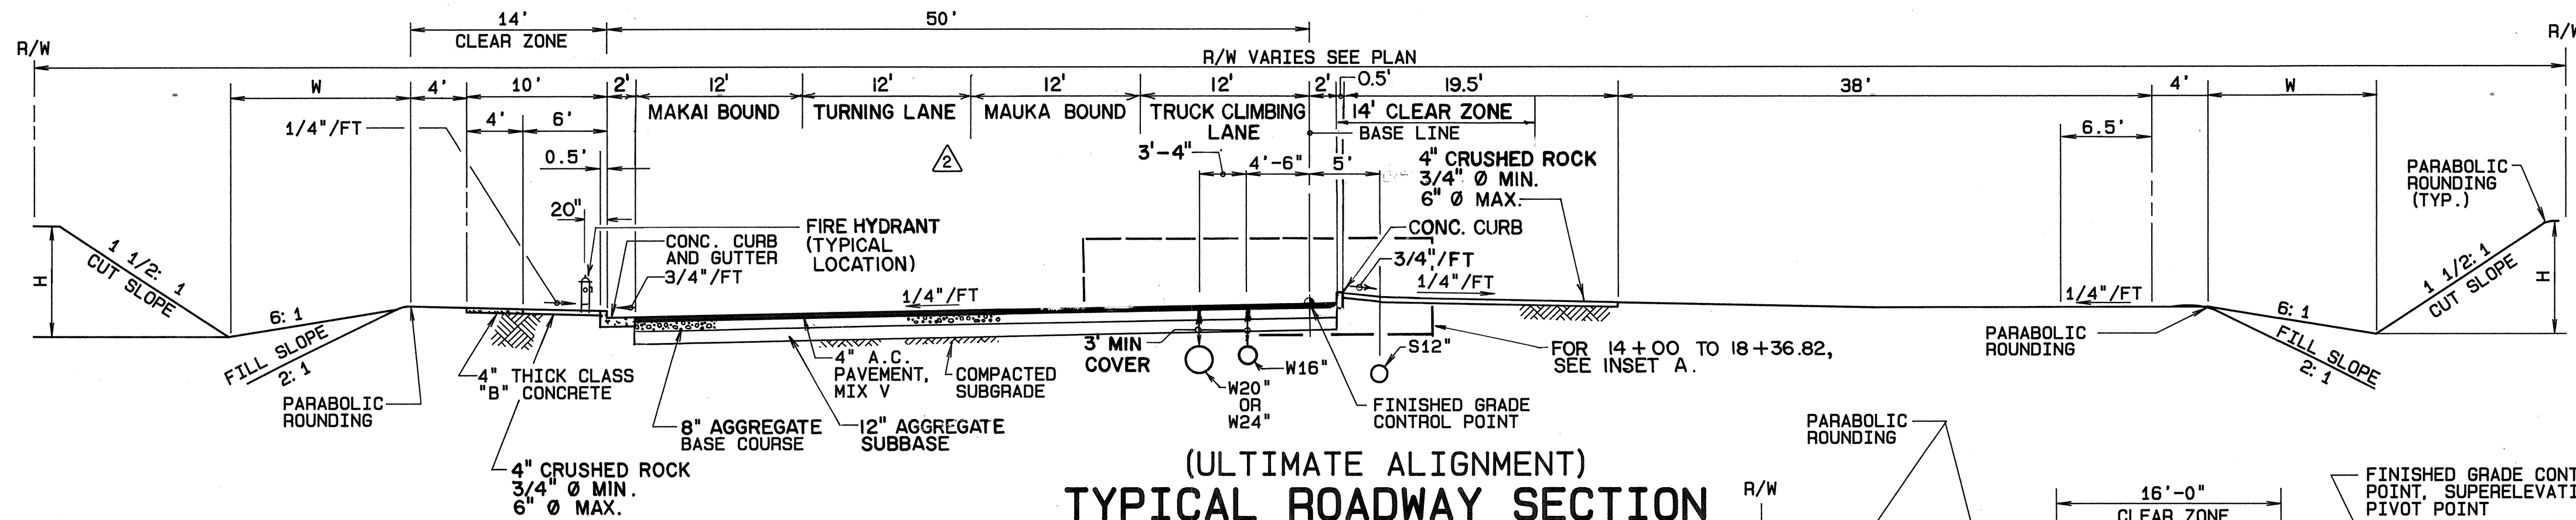

H	W
0' < H ≤ 6'	0'
6' < H ≤ 15'	6'

GENERAL NOTES:


- FOR SIZE AND LOCATION OF ALL ELECTRICAL LINES, SEE ELECTRICAL PLANS.
- CLEAR AND GRUB CLEAR ZONE AREA.
- FOR ASPHALT SURFACE TREATMENT AT DRYWELLS SEE DETAIL SHEET C-18.
- THE PAVEMENT SECTION SHALL BE FIELD VERIFIED BY THE GEOTECHNICAL ENGINEER DURING CONSTRUCTION IN LOCATIONS WHERE THE EXISTING SUBGRADE IS DETERMINED TO BE ROCK FORMATION OR DENSE CLINKER, THE SUBBASE MAY BE ELIMINATED.

NOTE:
RIGHT-OF-WAY LOCATION VARIES. SEE PLANS FOR EXACT LOCATION.

(ULTIMATE ALIGNMENT) TYPICAL ROADWAY SECTION

KEALAKEHE PARKWAY
14+00 TO 44+63.10

SCALE: 1/8"=1'-0"

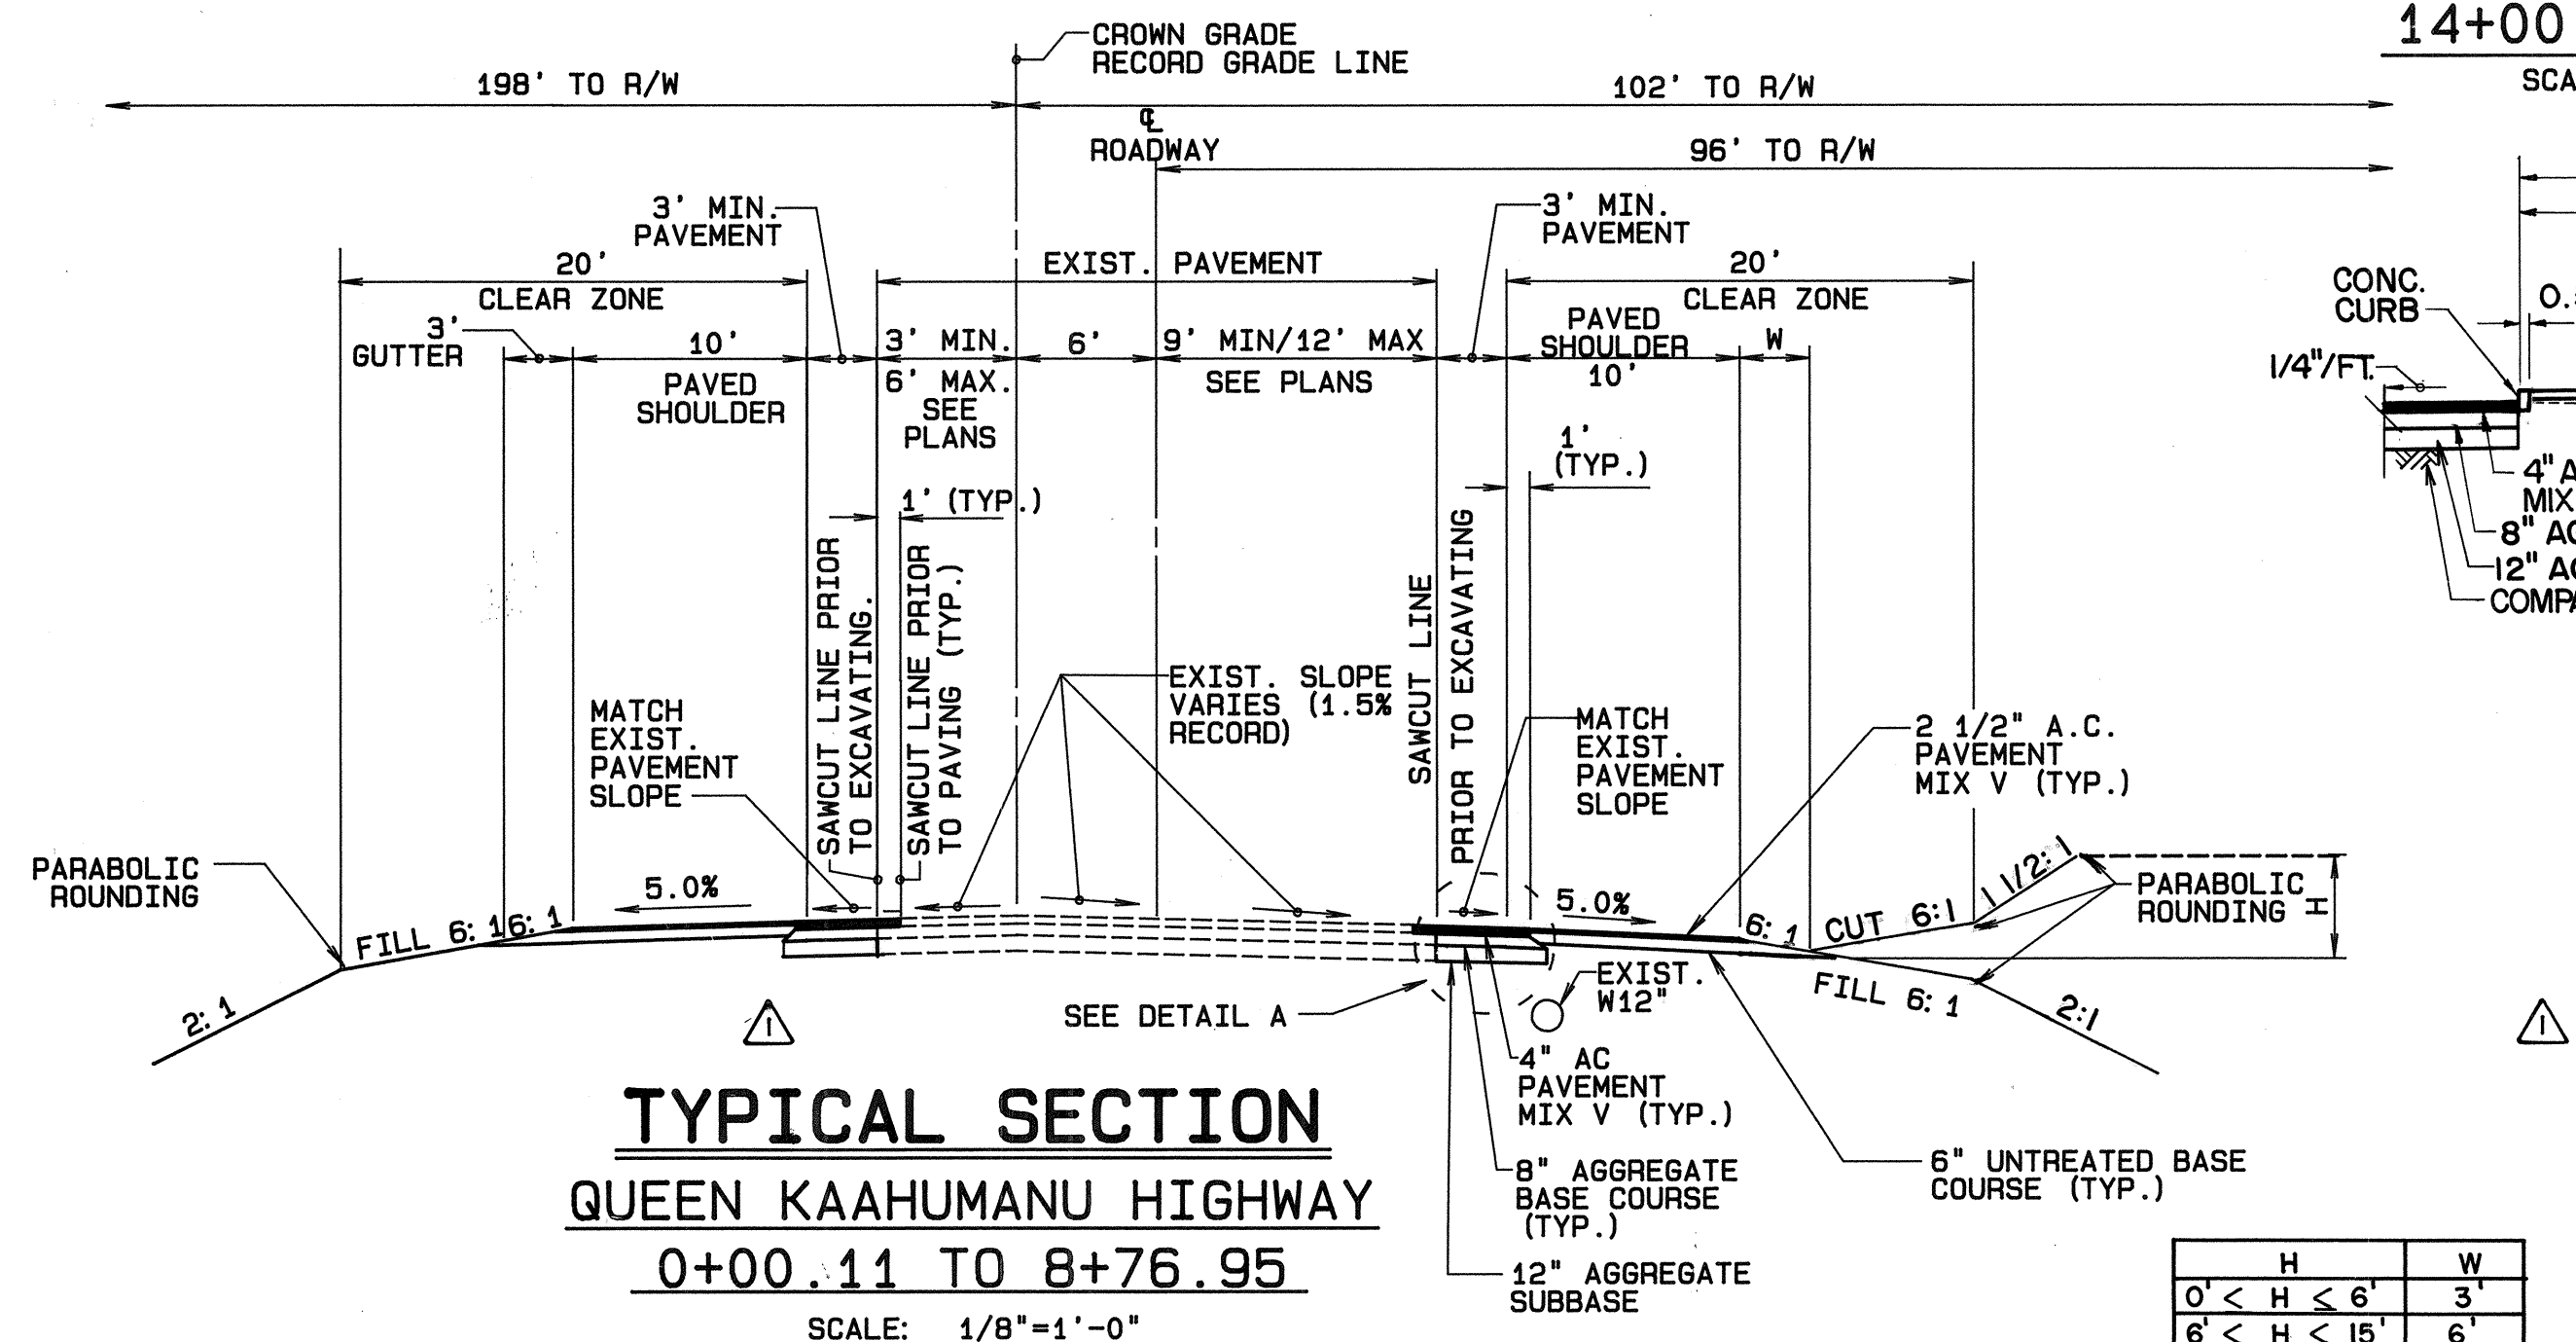


TYPICAL SECTION QUEEN KAAHUMANU HIGHWAY

0+00.11 TO 8+76.95

SCALE: 1/8"=1'-0"

INSET A


SCALE: 1/8"=1'-0"

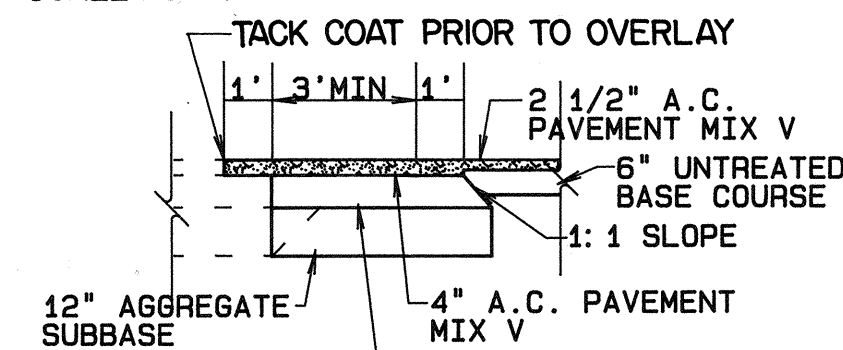

DETAIL A

SCALE: 1/4"=1'-0"

H	W
0' < H ≤ 6'	3'
6' < H ≤ 15'	6'

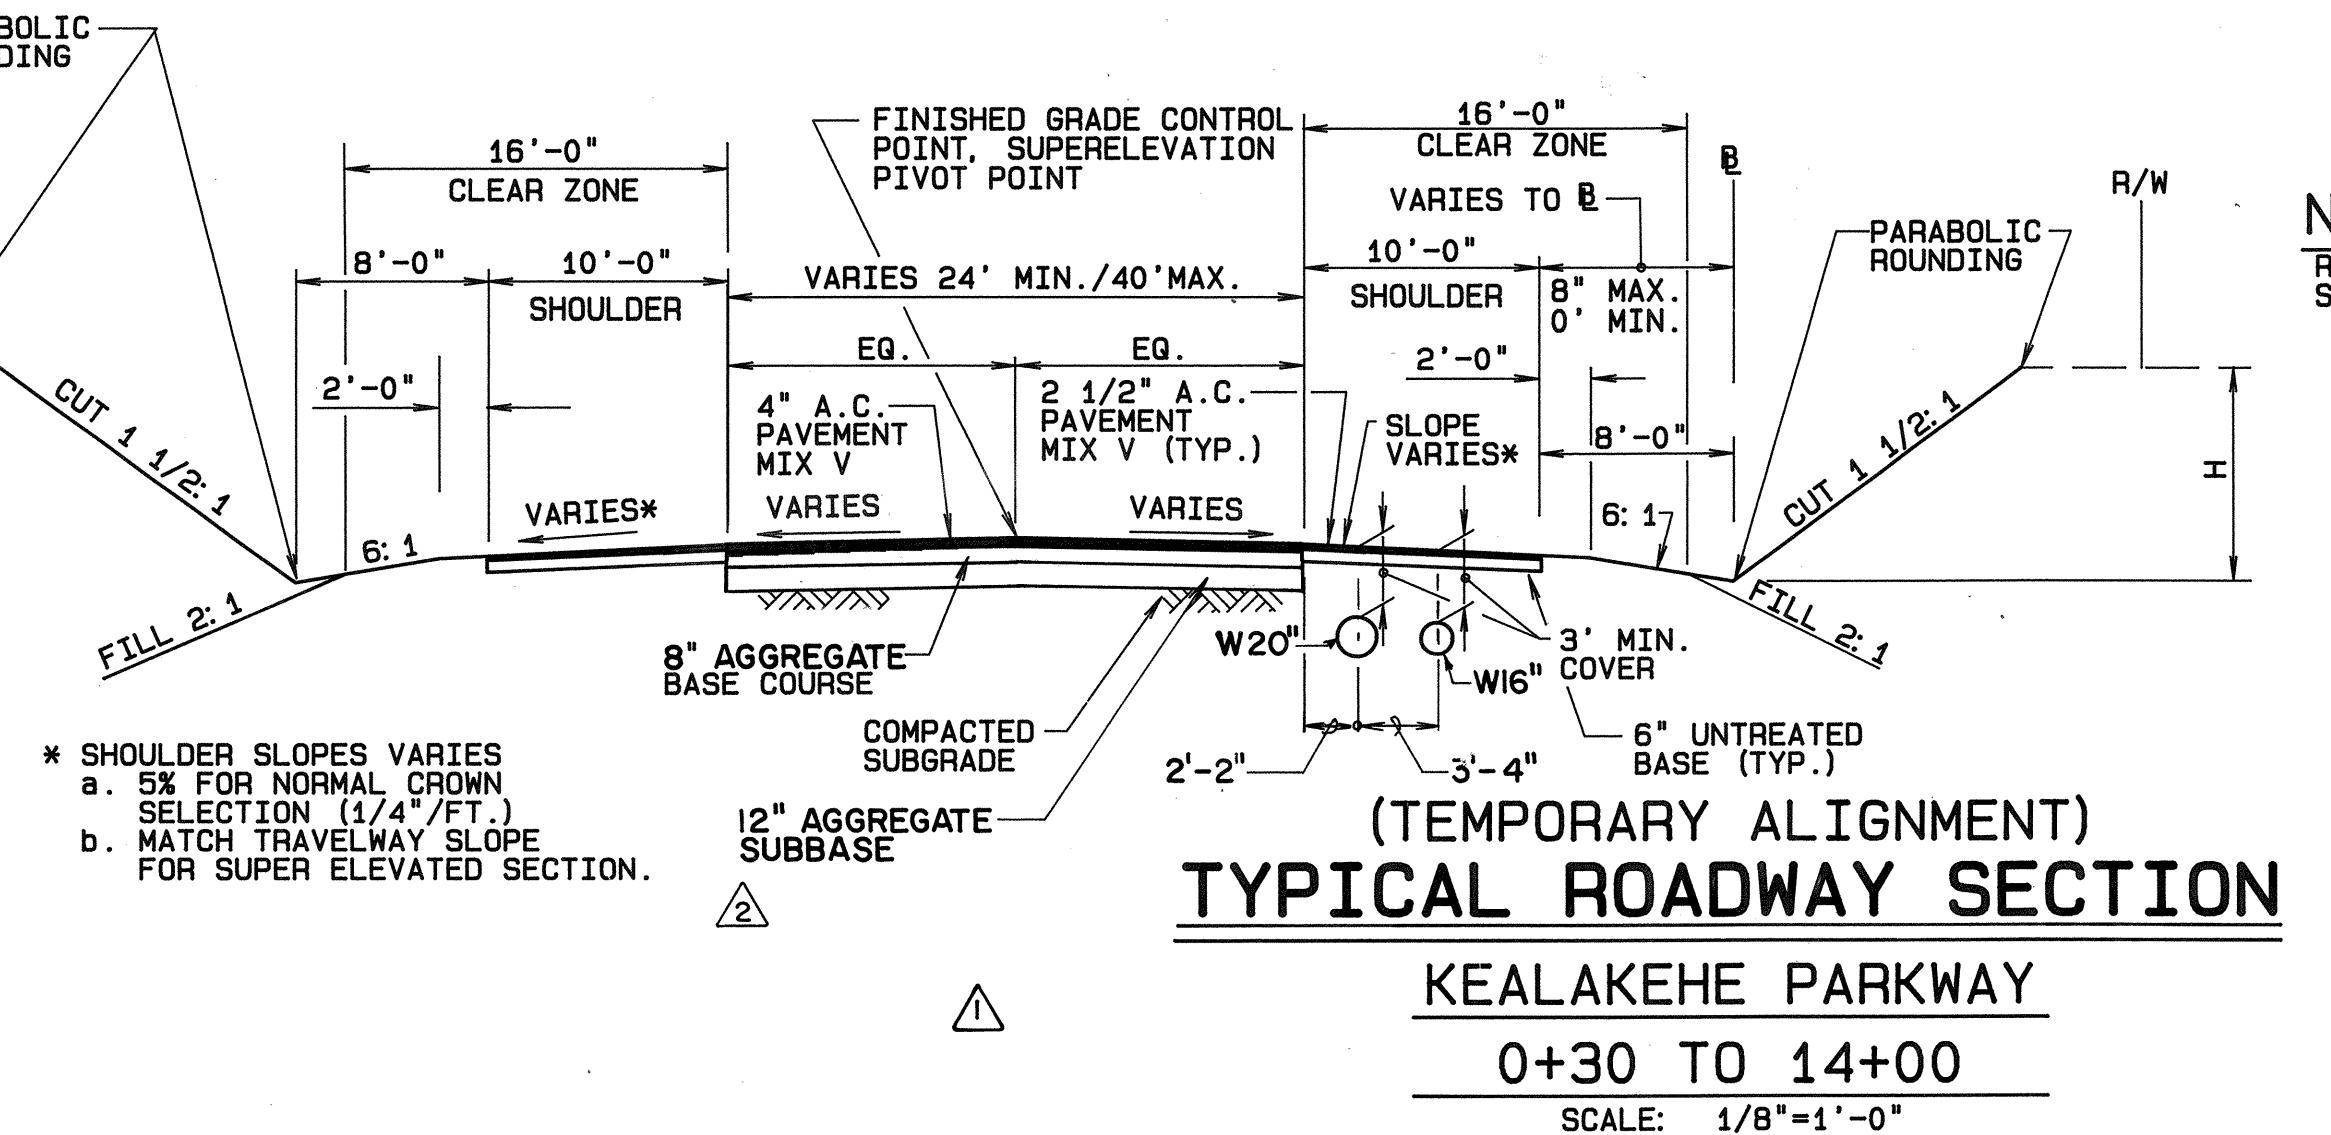


(TEMPORARY ALIGNMENT) TYPICAL ROADWAY SECTION

KEALAKEHE PARKWAY

0+30 TO 14+00

SCALE: 1/8"=1'-0"

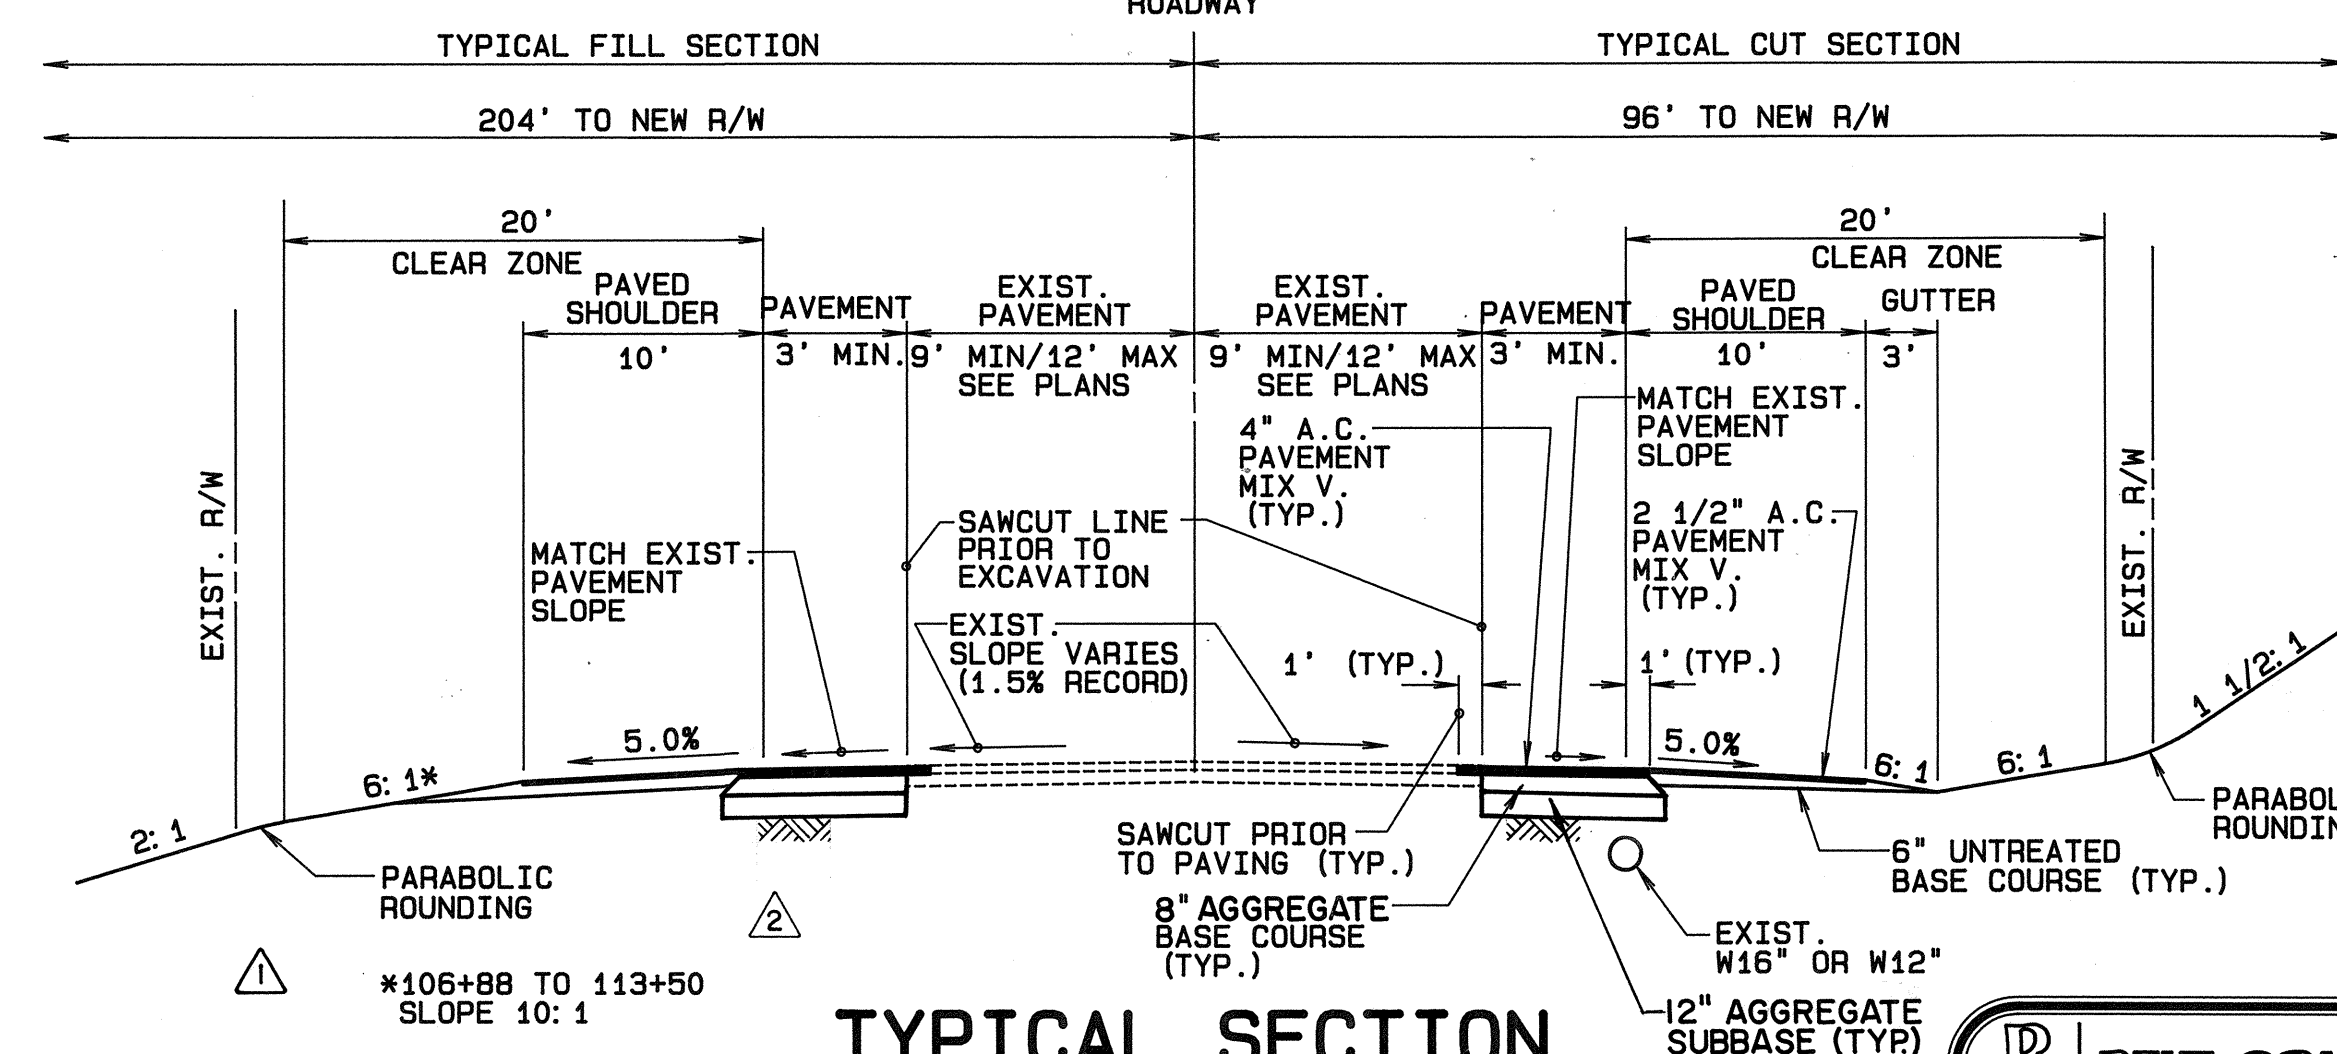


TYPICAL SECTION QUEEN KAAHUMANU HIGHWAY

106+88 TO 126+05.57

SCALE: 1/8"=1'-0"

H	W
0' < H ≤ 6'	3'
6' < H ≤ 15'	7'

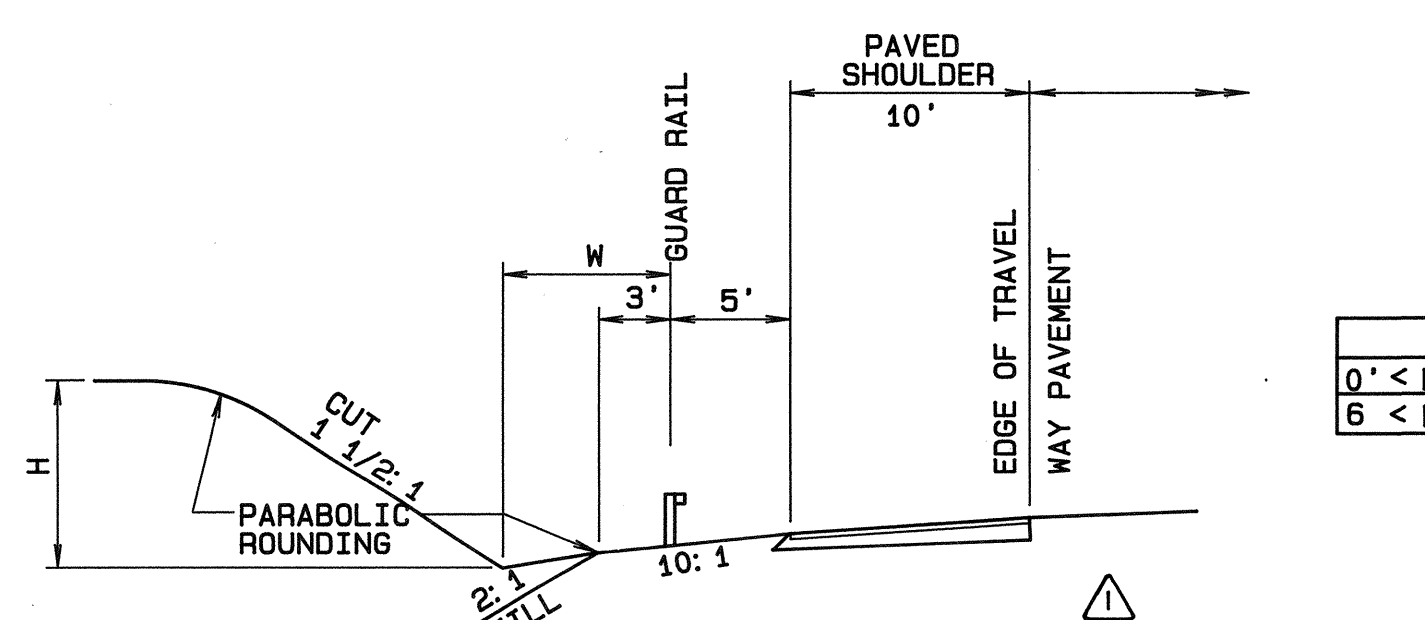

TYPICAL SHOULDER SECTION AT GUARD RAIL QUEEN KAAHUMANU HIGHWAY

SCALE: 1/8"=1'-0"

BELT COLLINS & ASSOCIATES
Engineering • Planning • Landscape Architecture
880 Ala Moana Boulevard Suite 200 Honolulu, Hawaii 96813
Phone: (808) 521-5361 Telex: BELTH 7430474 Fax: (808) 538-7819

Client:
HOUSING FINANCE AND DEVELOPMENT CORPORATION
STATE OF HAWAII

VILLAGES OF LA 'I' OPUA
MAUKA-MAKAI ROADWAY IMPROVEMENTS
PHASE-1

TYPICAL SECTION

Designed by: CP Date: JULY 30, 1990
Drawn by: KO, AJP Proj. no.: (BCA) 841.0104
Approved:

Rev	Date	Description	Eng	App
7-14-92		REVISE SECTION	CP	
12-4-91		REVISE SECTIONS	CP	

THIS WORK WAS PREPARED BY ME OR UNDER MY SUPERVISION AND CONSTRUCTION OF THIS PROJECT WILL BE UNDER MY OBSERVATION.

Cheryl M. Sells
PROFESSIONAL ENGINEER
No. 5952-C
HAWAII, U.S.A.

Date: _____
Date: _____