

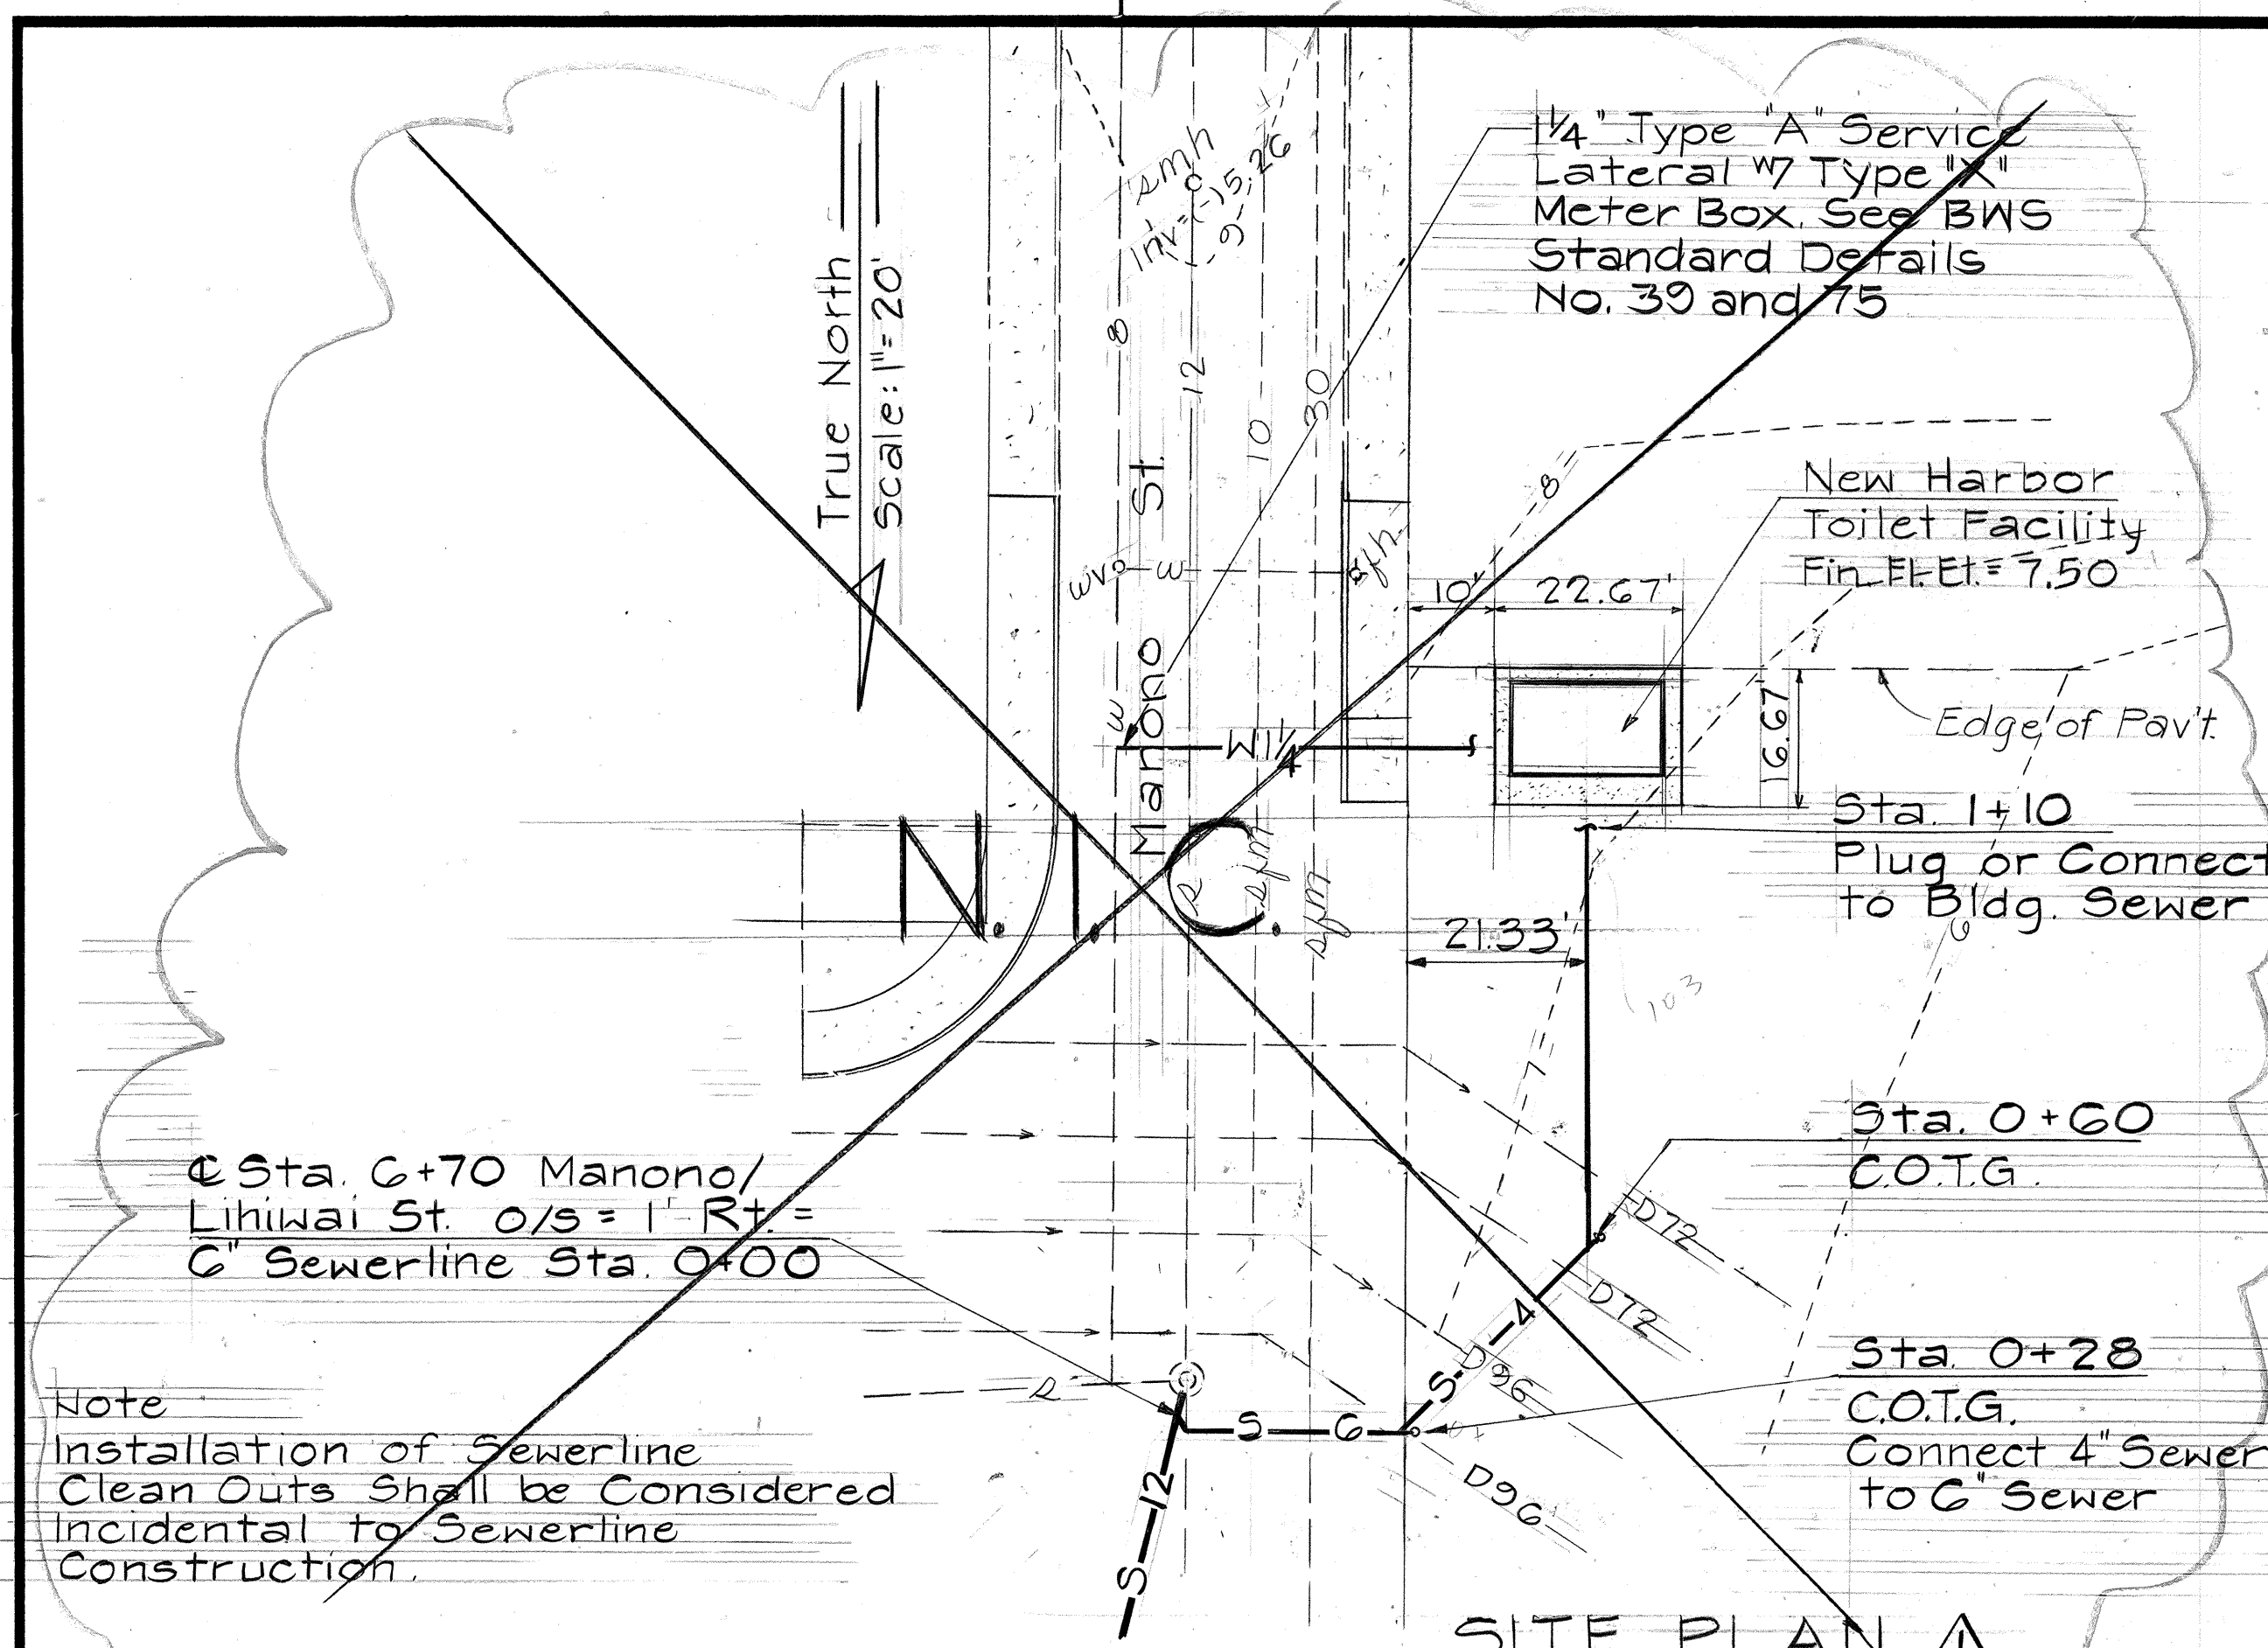
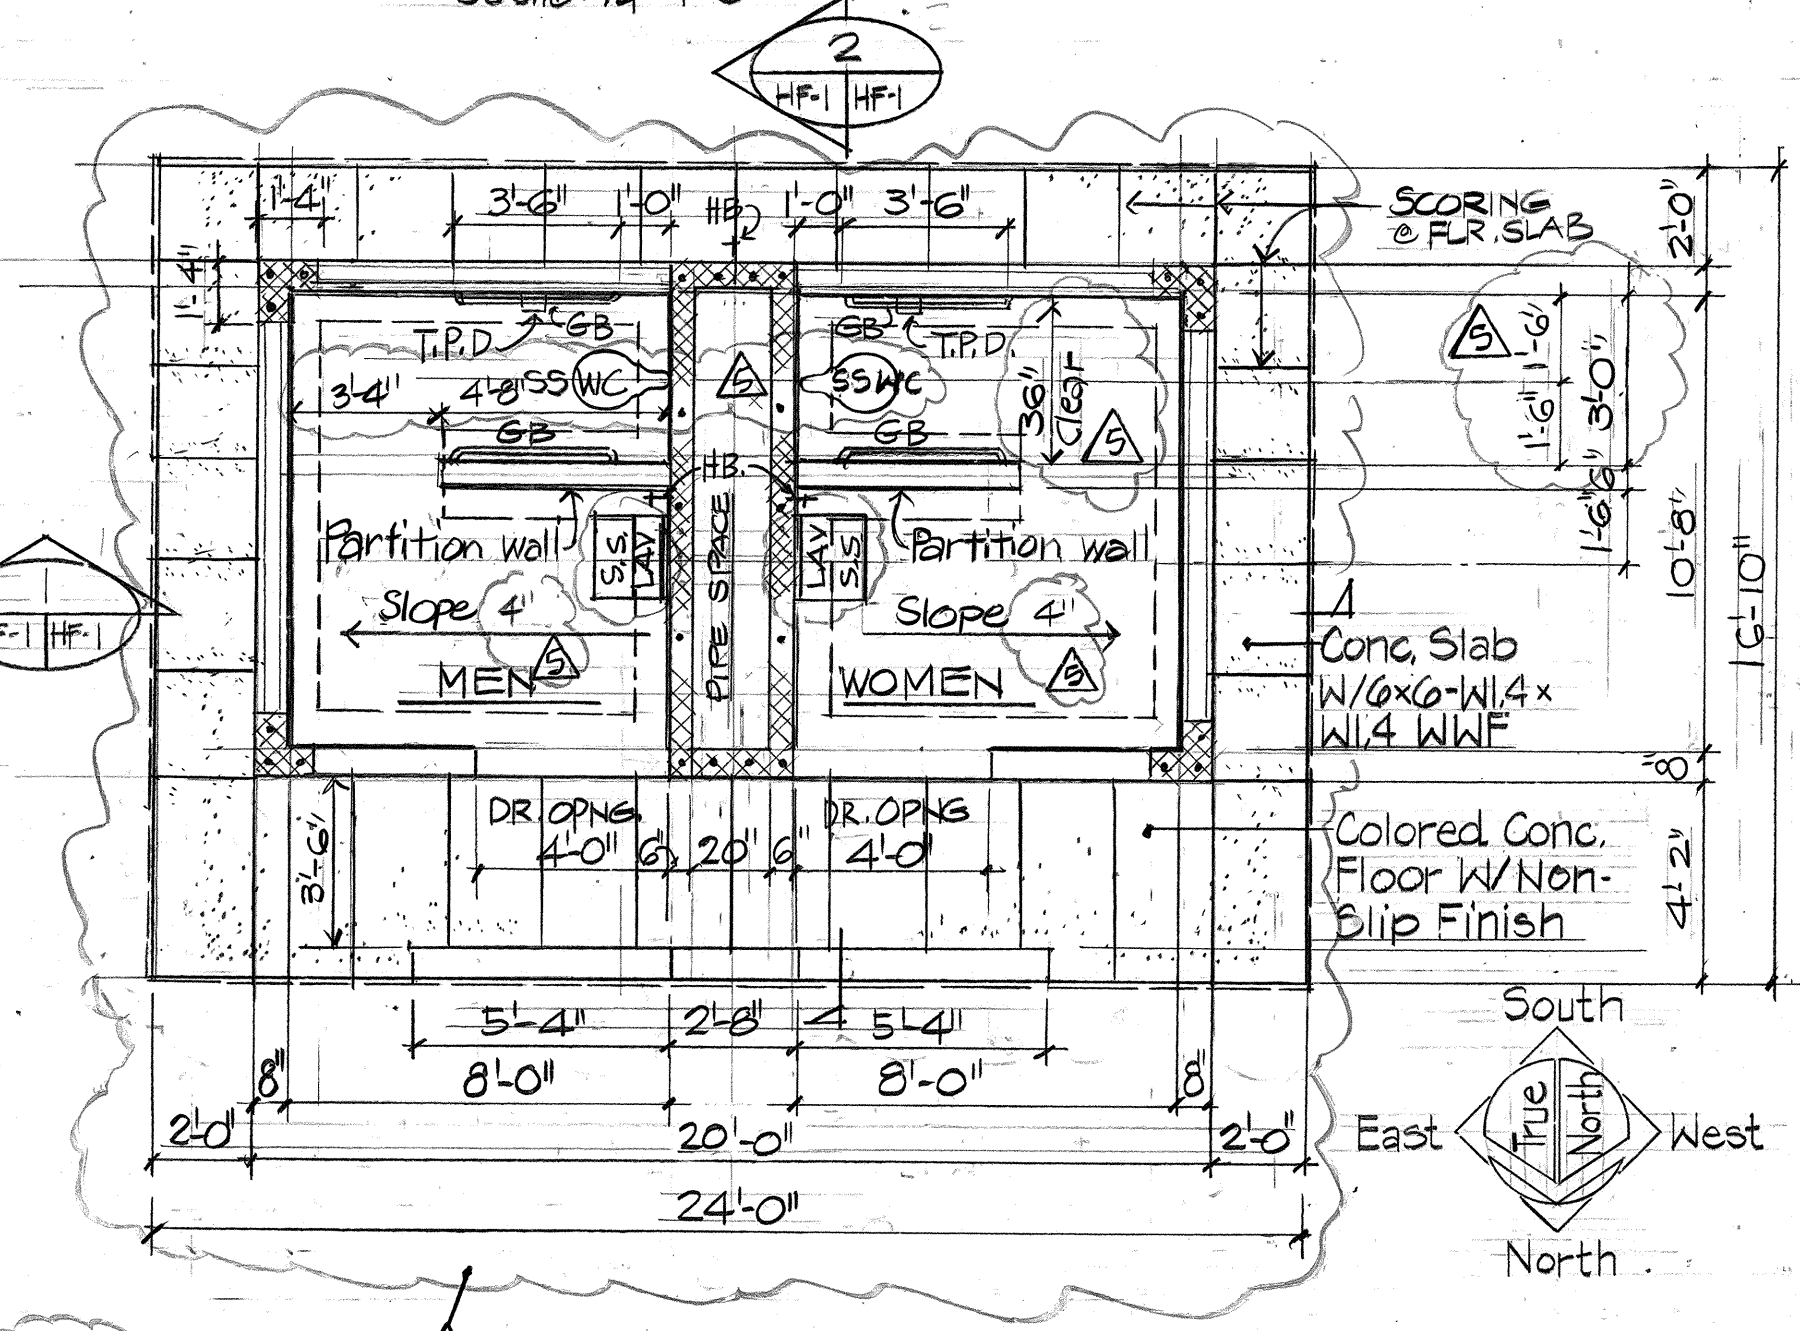
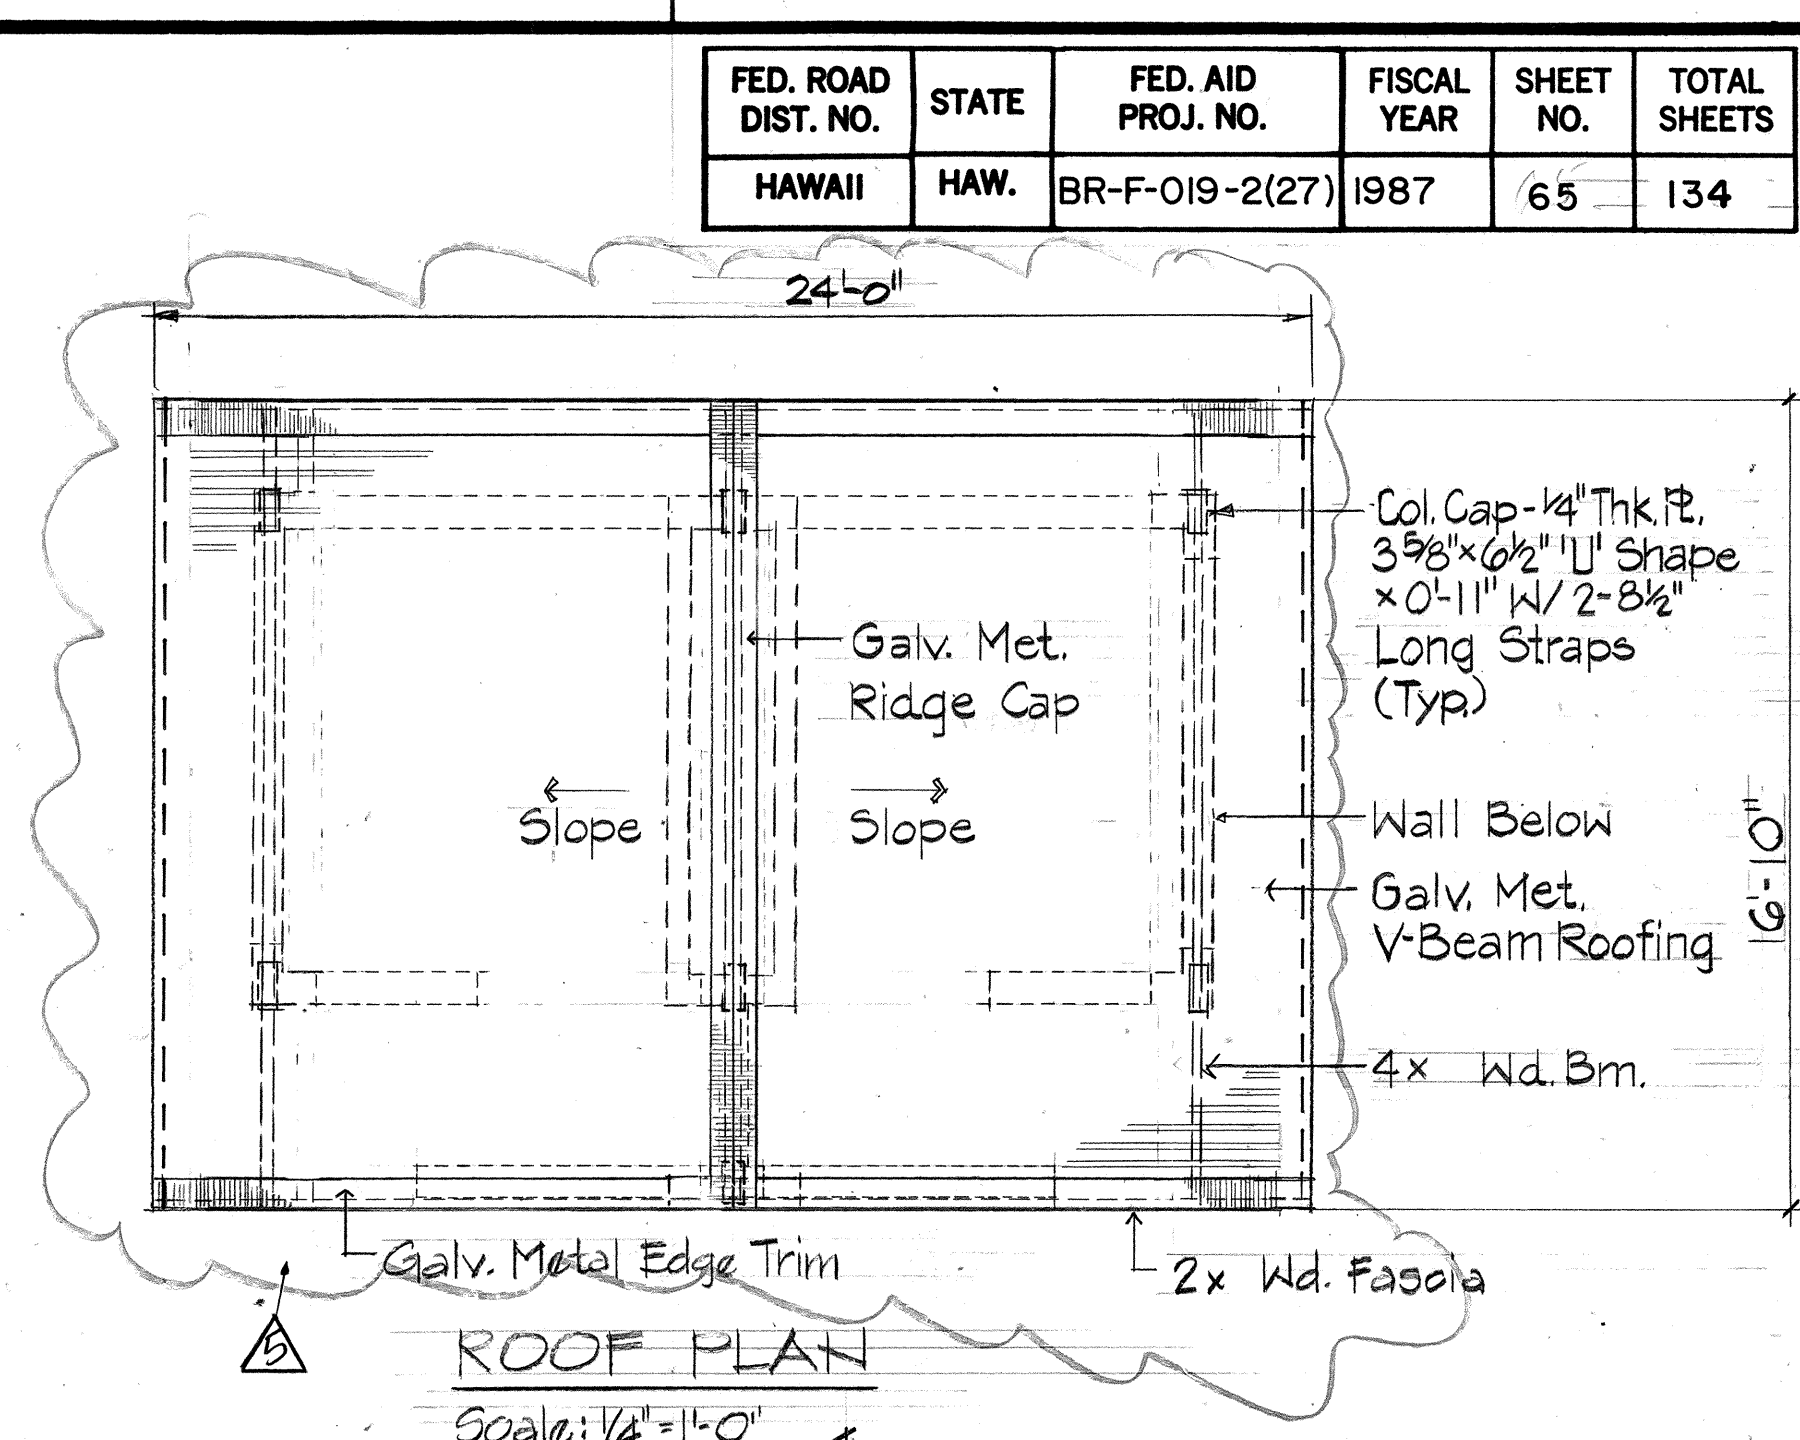
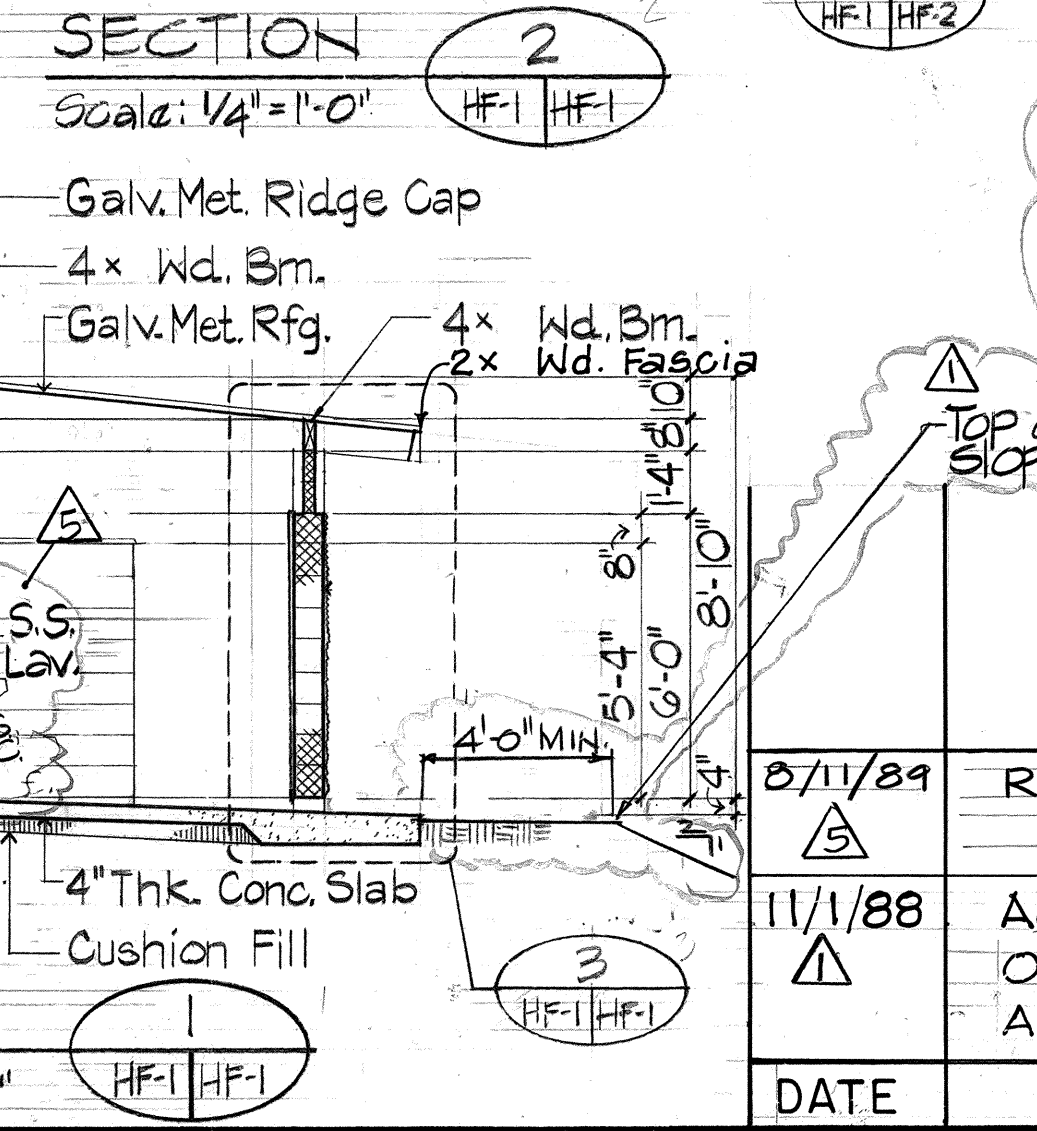
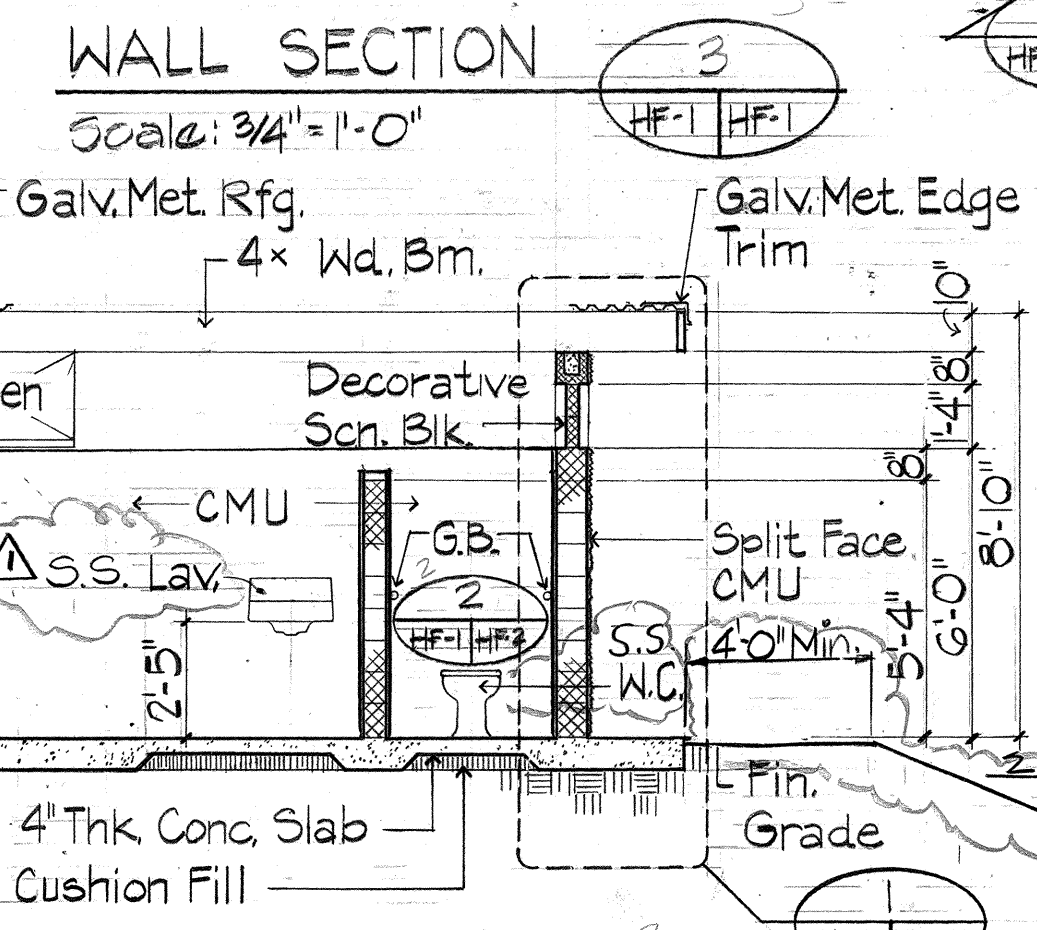


FED. ROAD DIST. NO.	STATE	FED. AID PROJ. NO.	FISCAL YEAR	SHEET NO.	TOTAL SHEETS
HAWAII	HAW.	BR-F-019-2(27)	1987	65	134

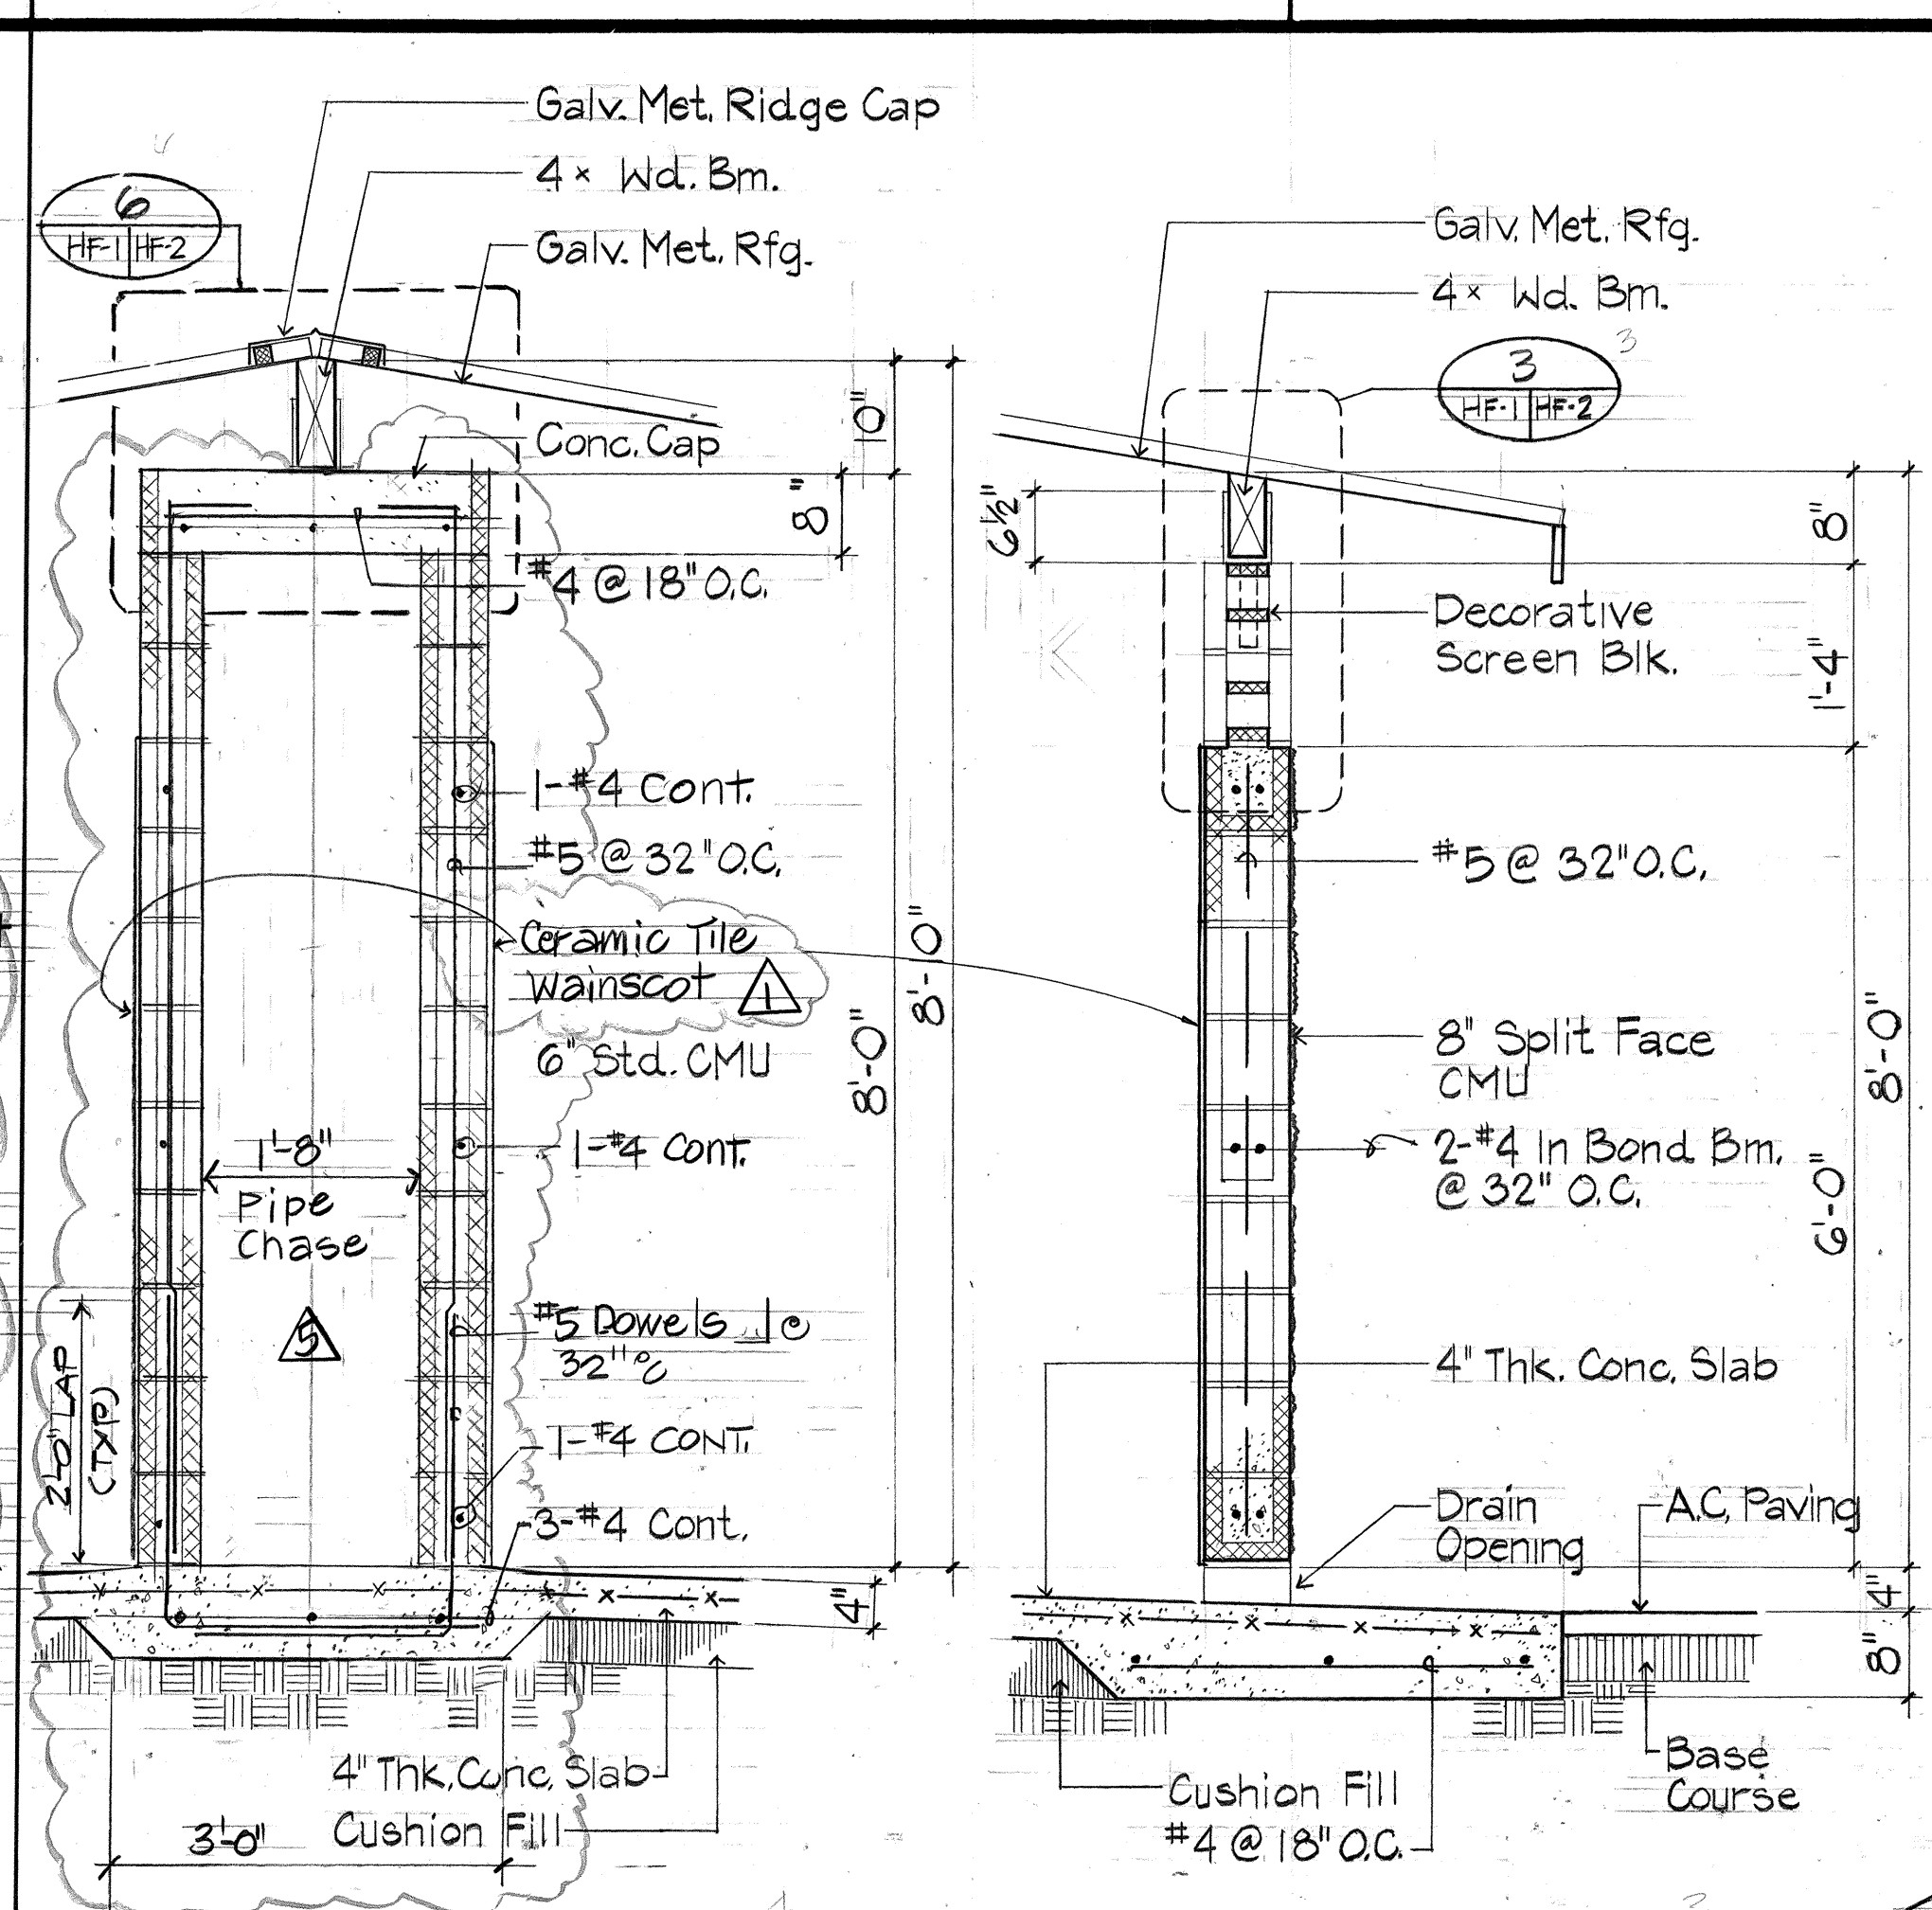

SITE PLAN

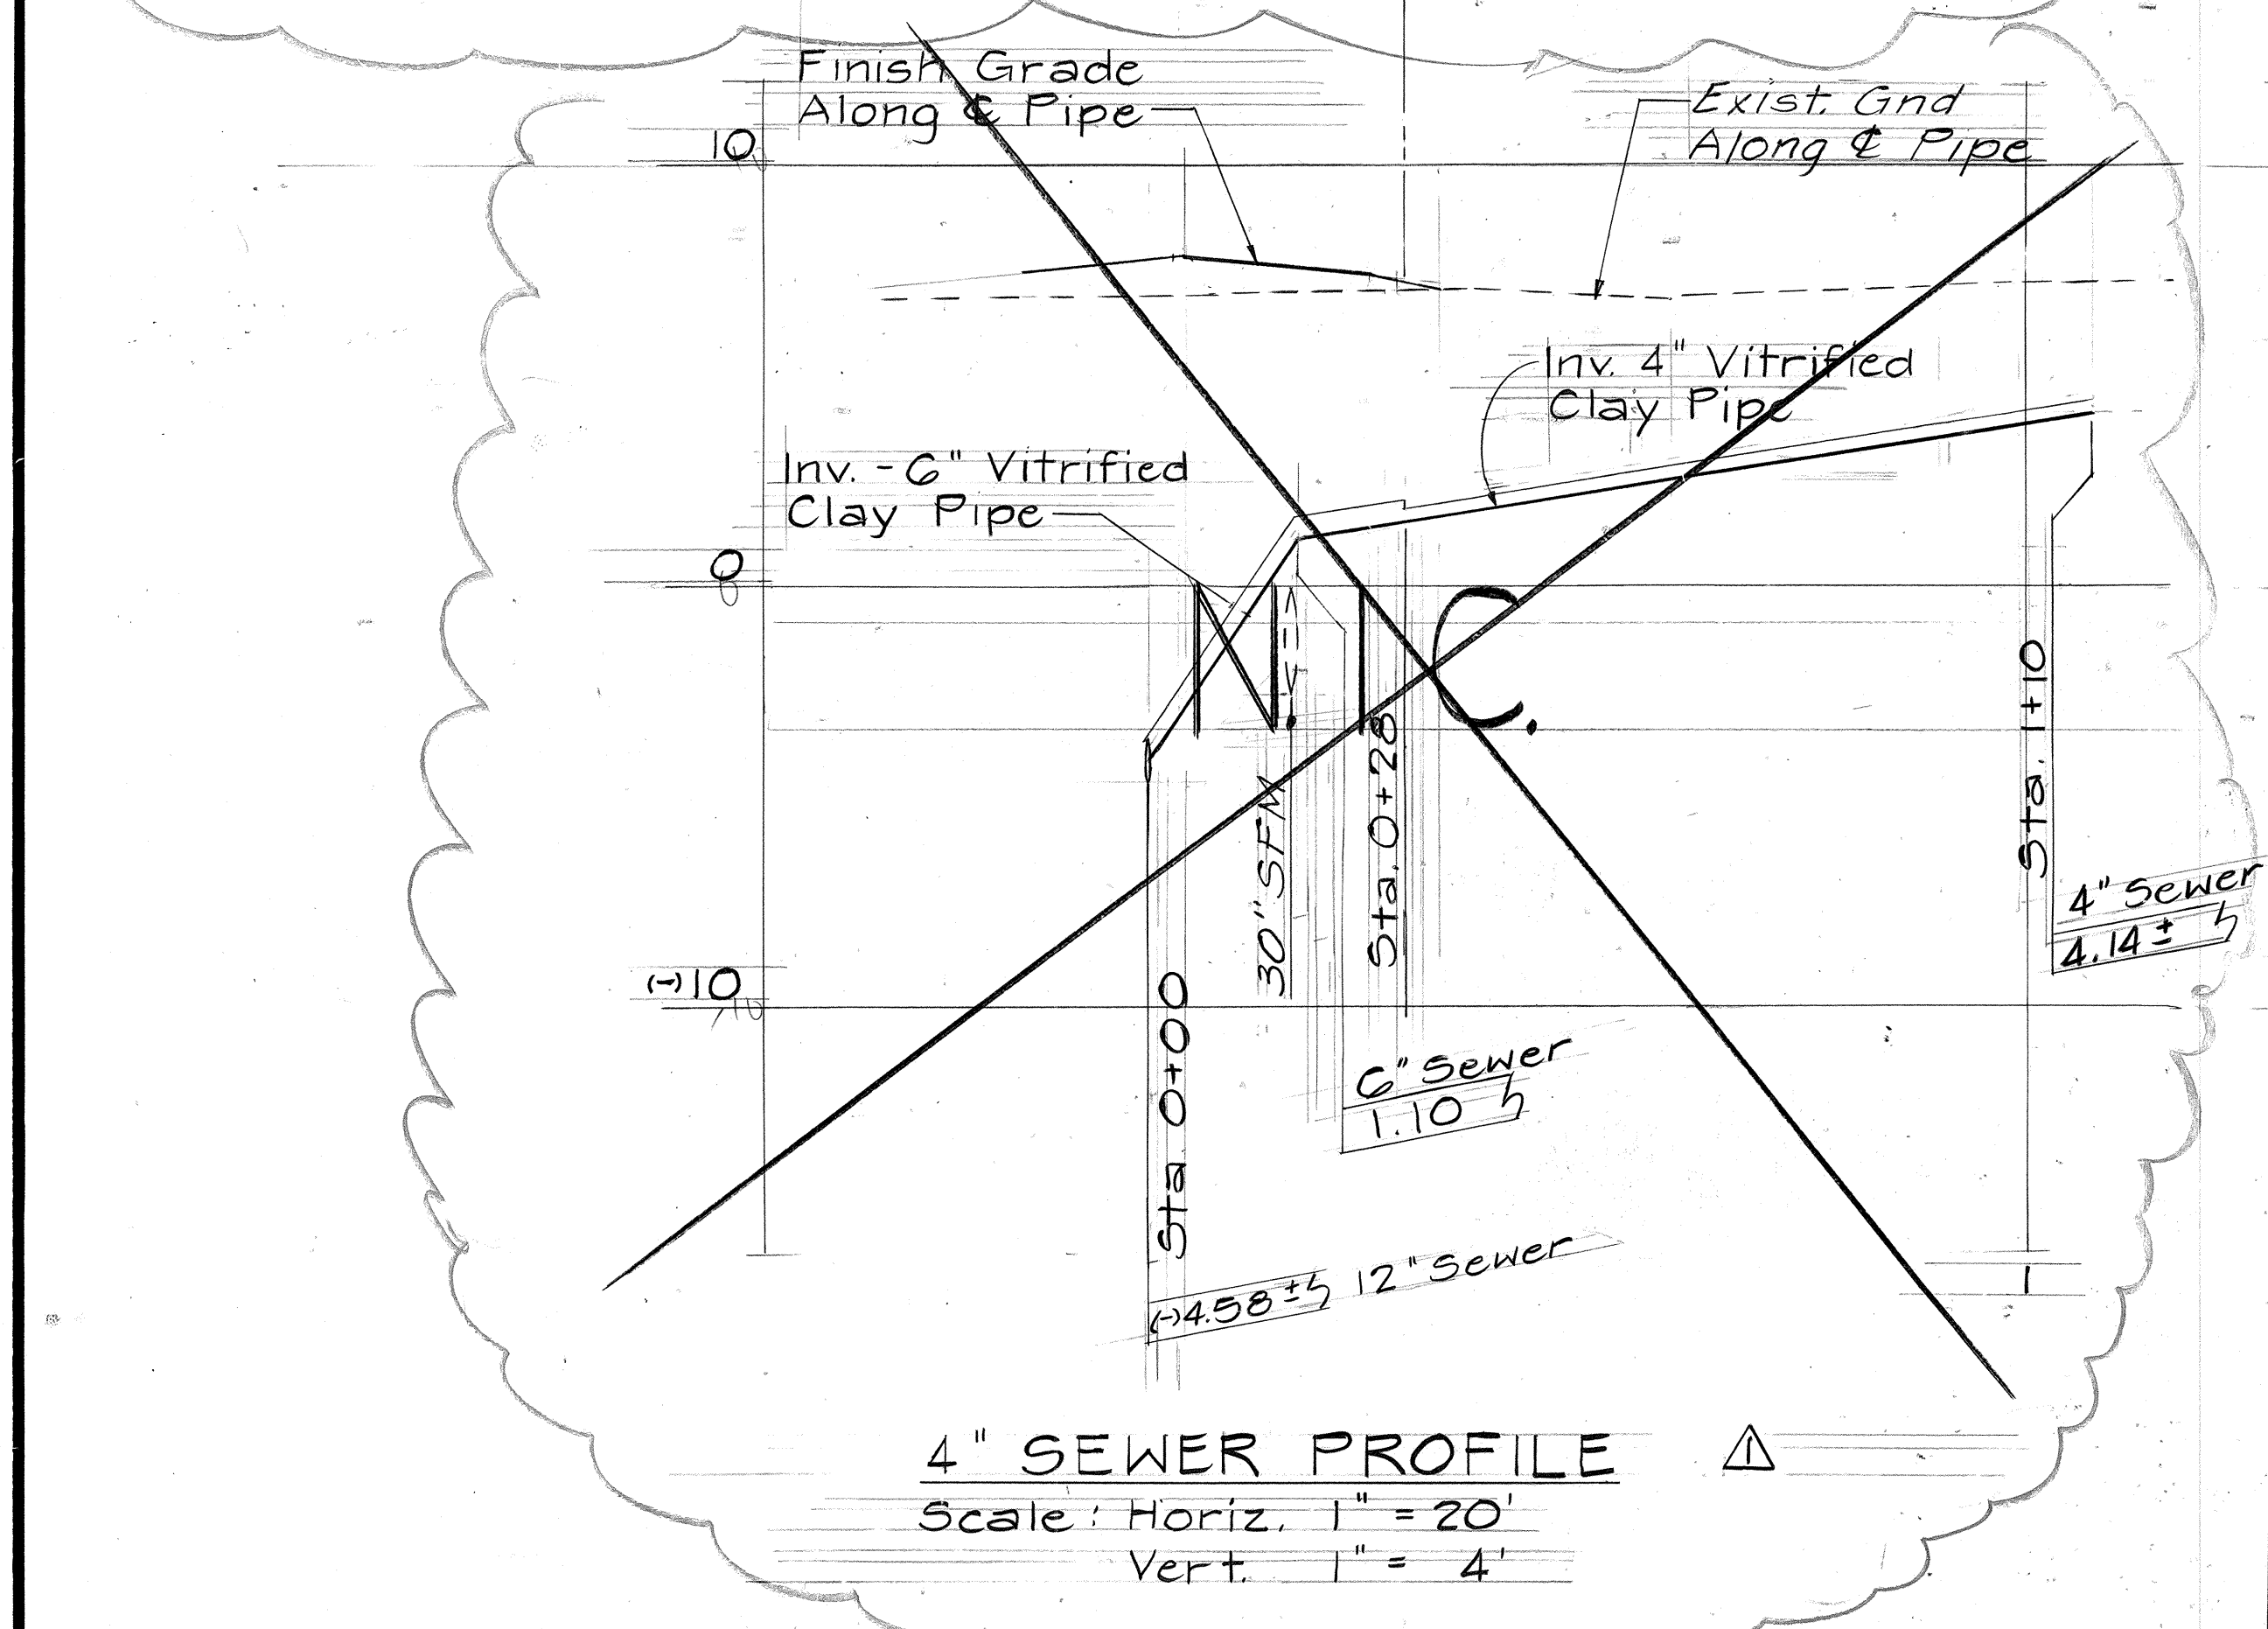

Note: For Ceramic Tile use Dry-Set Mortar Installation as per Ceramic Tile Installation Handbook 1989" By The Tile Council of America, Inc., Design W202 Handicap Requirements are per ANSI code (Not UFAS)

WALTER LEU REGISTERED PROFESSIONAL ARCHITECT No. 2709 HAWAII, U.S.A.

THIS WORK WAS PREPARED BY ME OR UNDER MY SUPERVISION

DATE	REVISION
8/1/89	Revised.
11/1/88	Added Ceramic Tile Wainscot Omit Site Plan And a Sewer Profile.

STATE OF HAWAII DEPARTMENT OF TRANSPORTATION HIGHWAYS DIVISION

HARBOR FACILITIES COMFORT STATION DETAILS

HAWAII BELT ROAD/KAMEHAMEHA AVENUE

Wailoa Bridge Replacement And Approaches











FEDERAL AID PROJECT NO. BR-F-019-2(27)

SCALE: AS NOTED DATE: SEPT. 1986

SHEET NO. HF1 OF 2 SHEETS

ORIGINAL PLAN	DATE
SURVEY PLOTTED BY	
DRAWN BY	
DESIGNED BY	
QUANTITIES BY	
CHECKED BY	

FED. ROAD DIST. NO.	STATE	FED. AID PROJ. NO.	FISCAL YEAR	SHEET NO.	TOTAL SHEETS
HAWAII	HAW.	BR-F-019-2(27)	1987	66	134

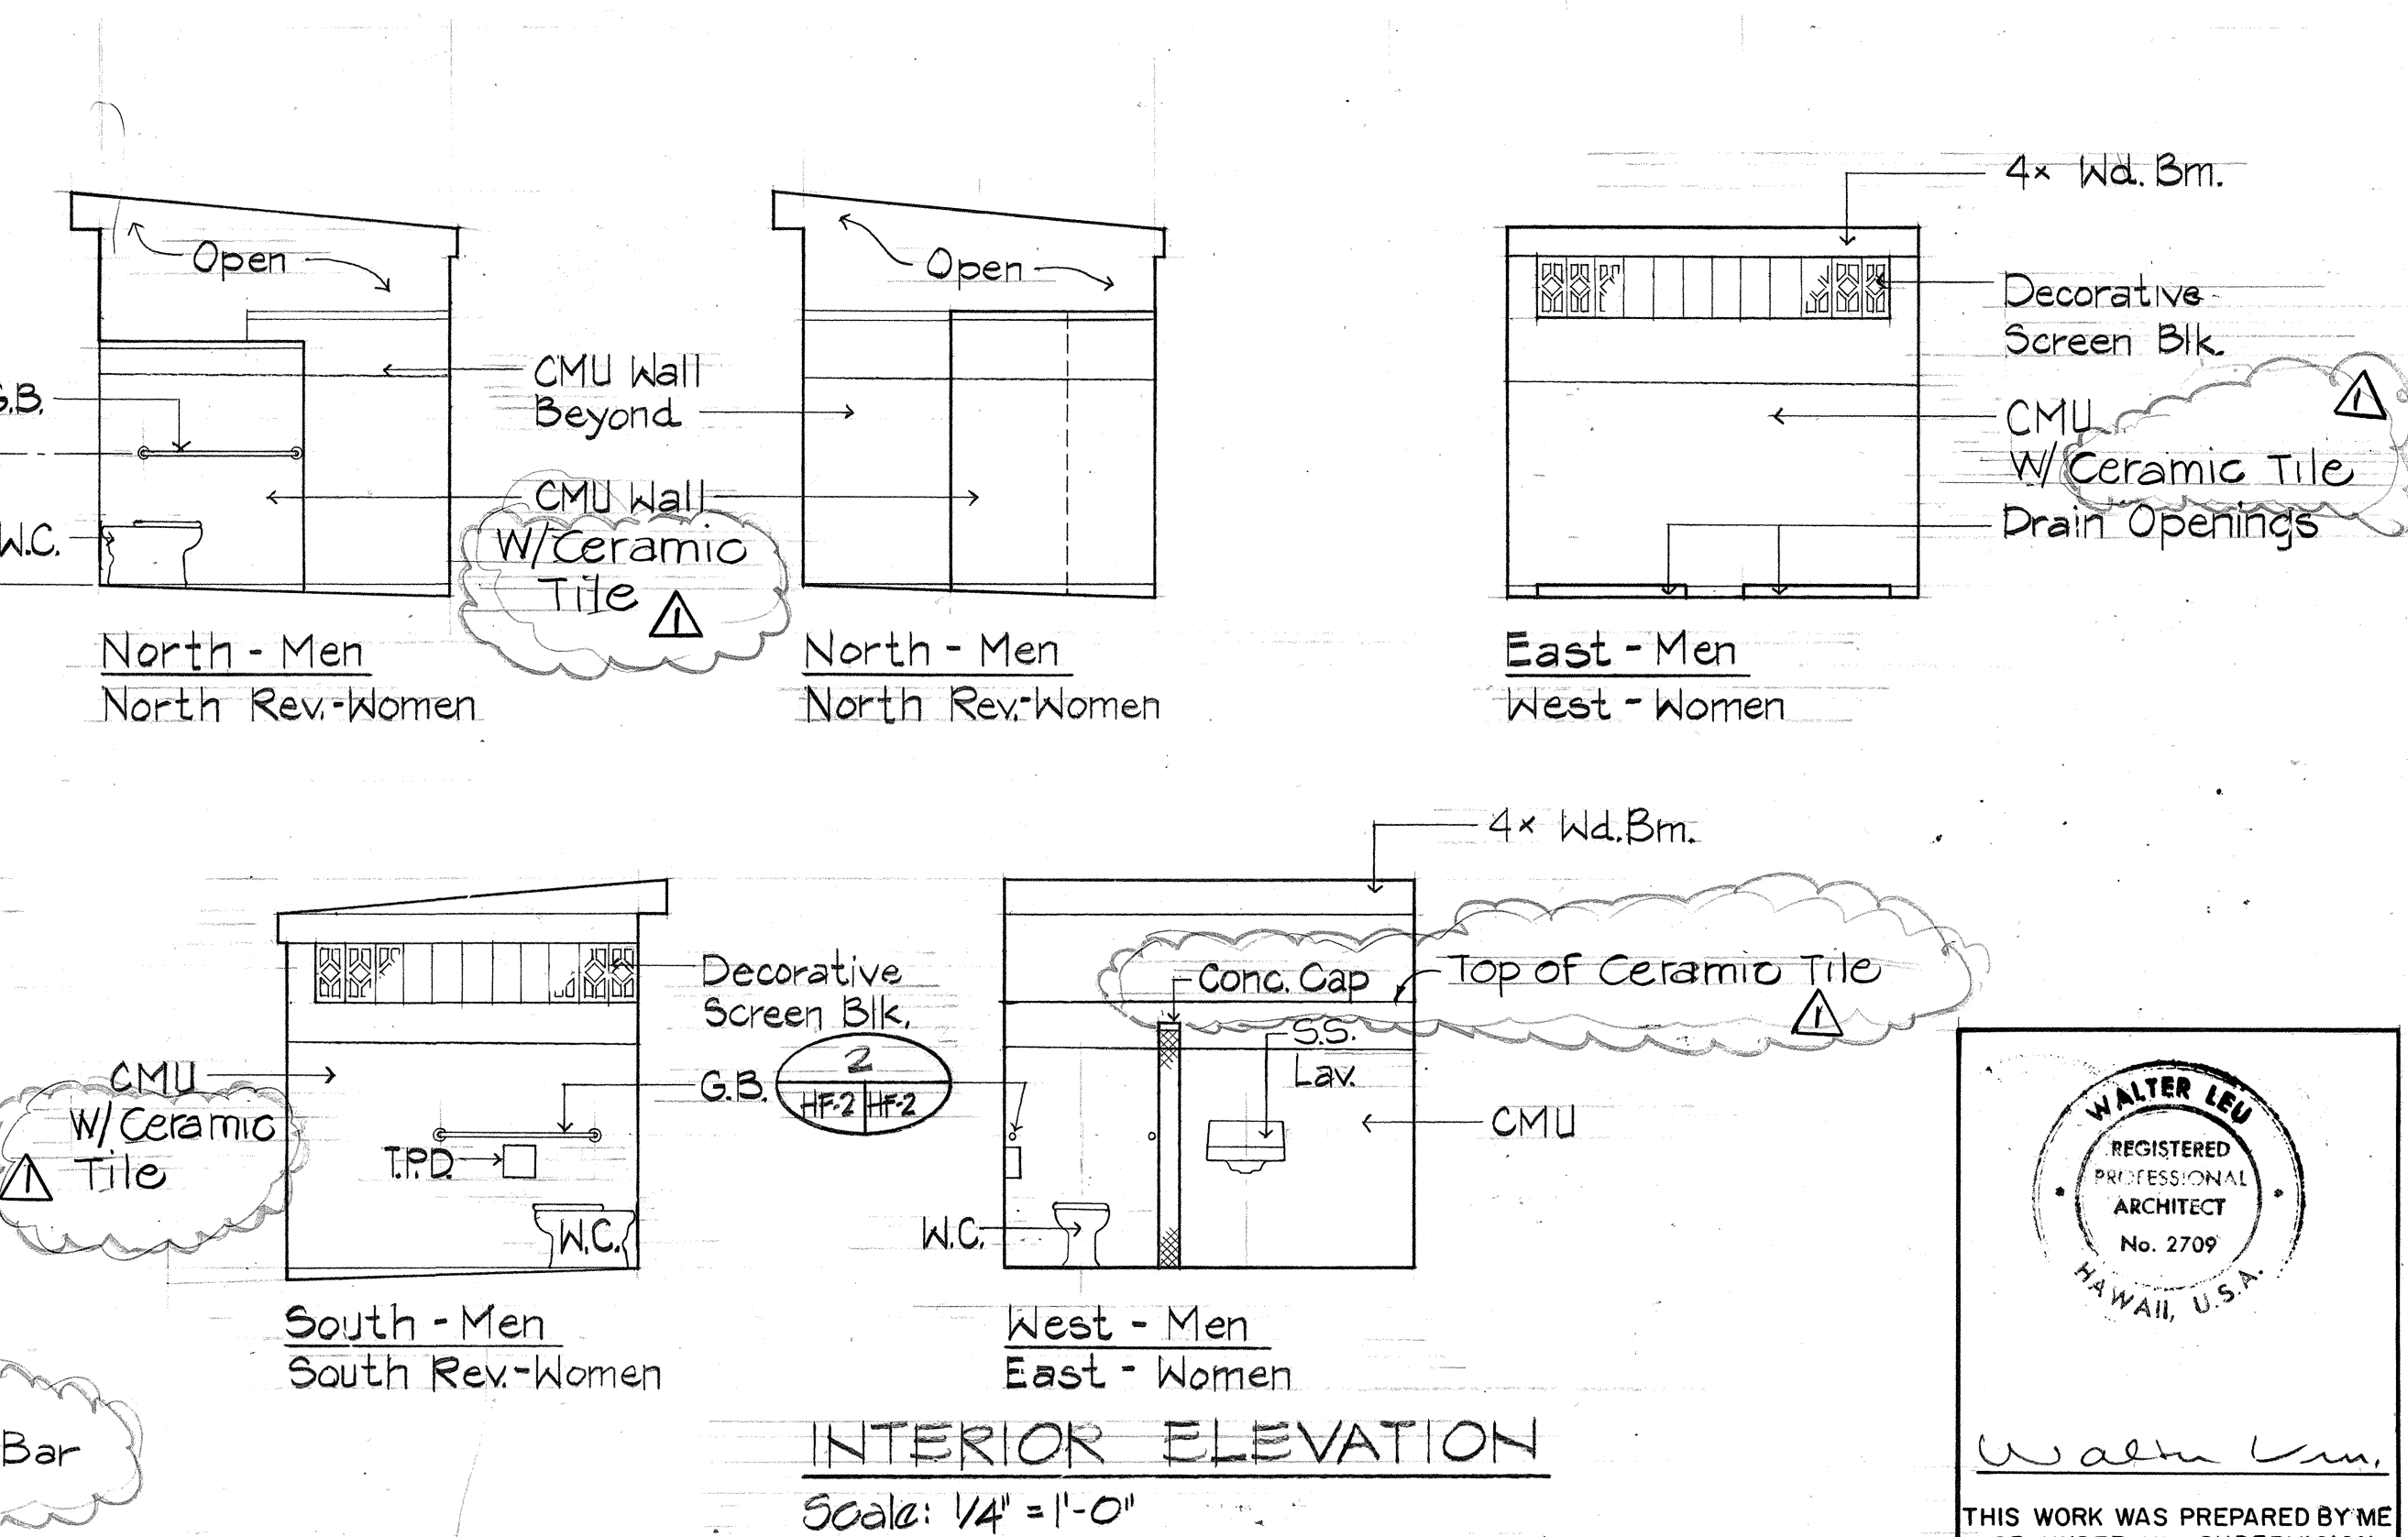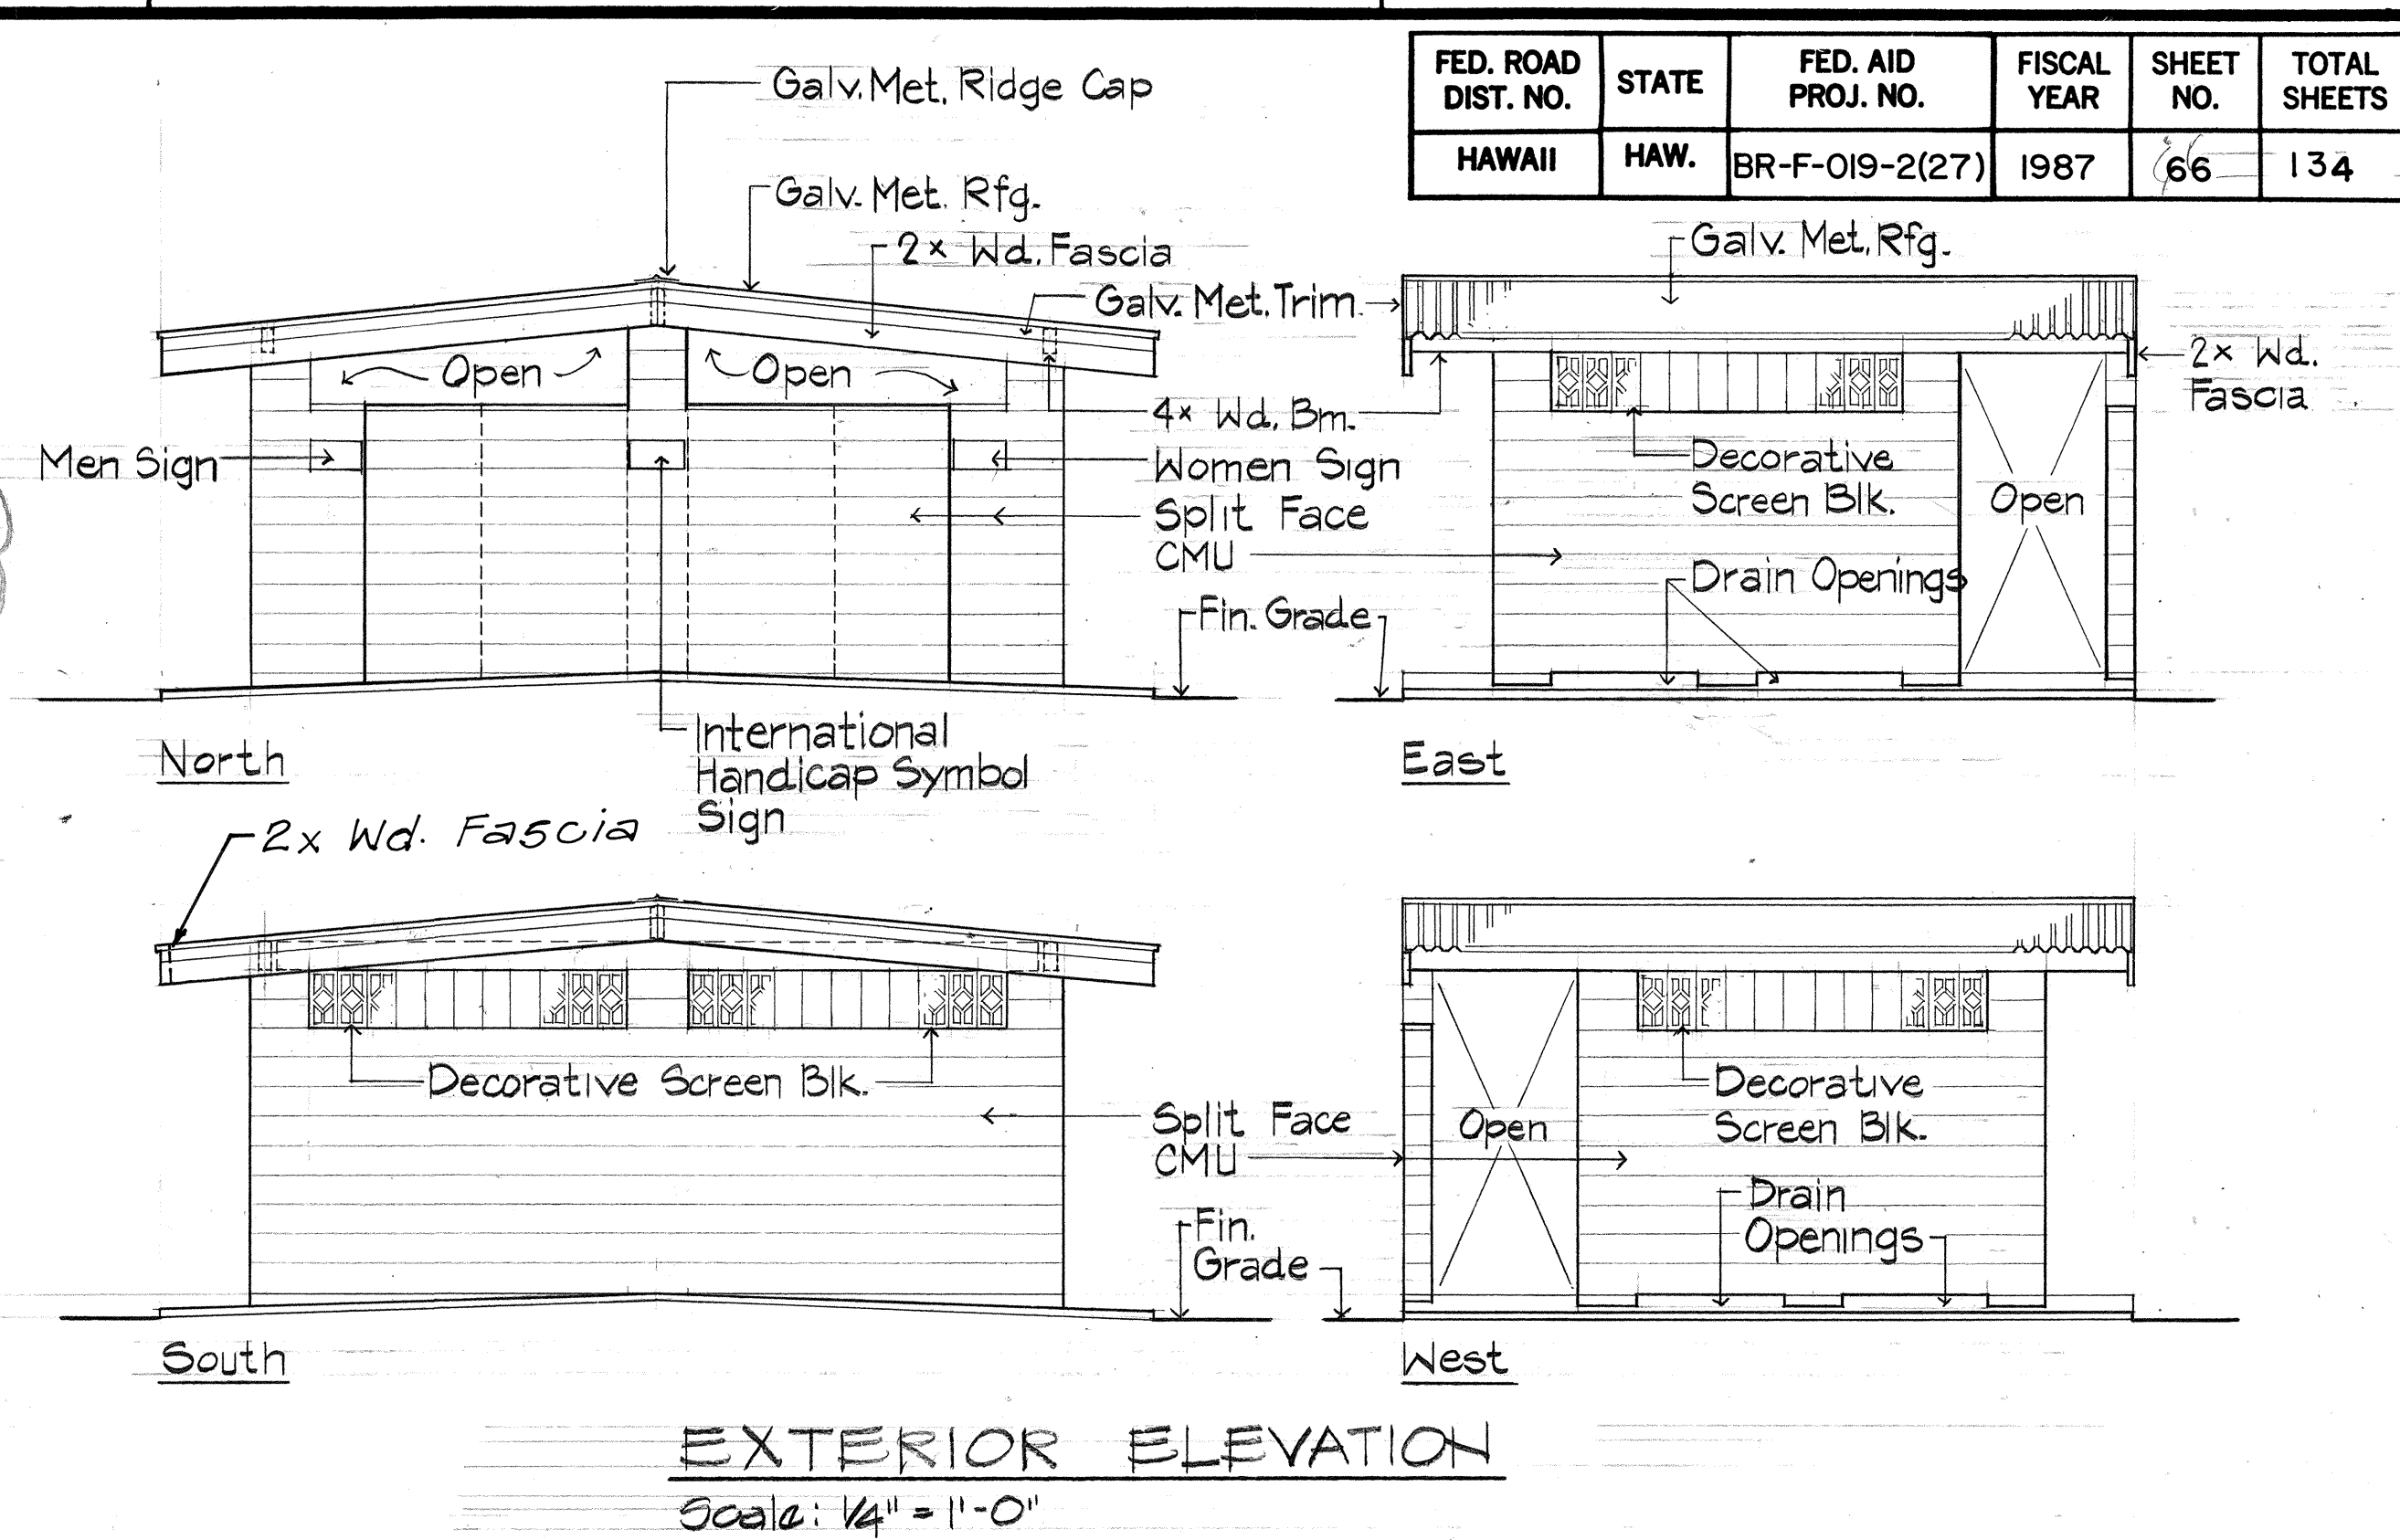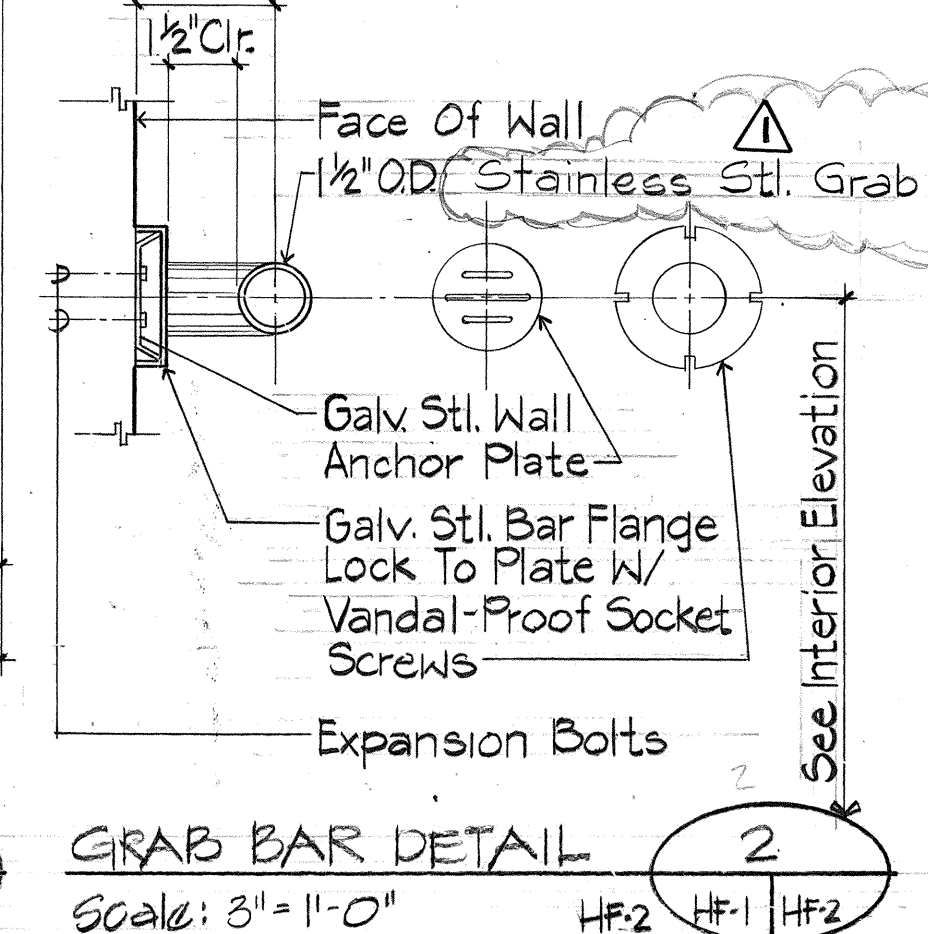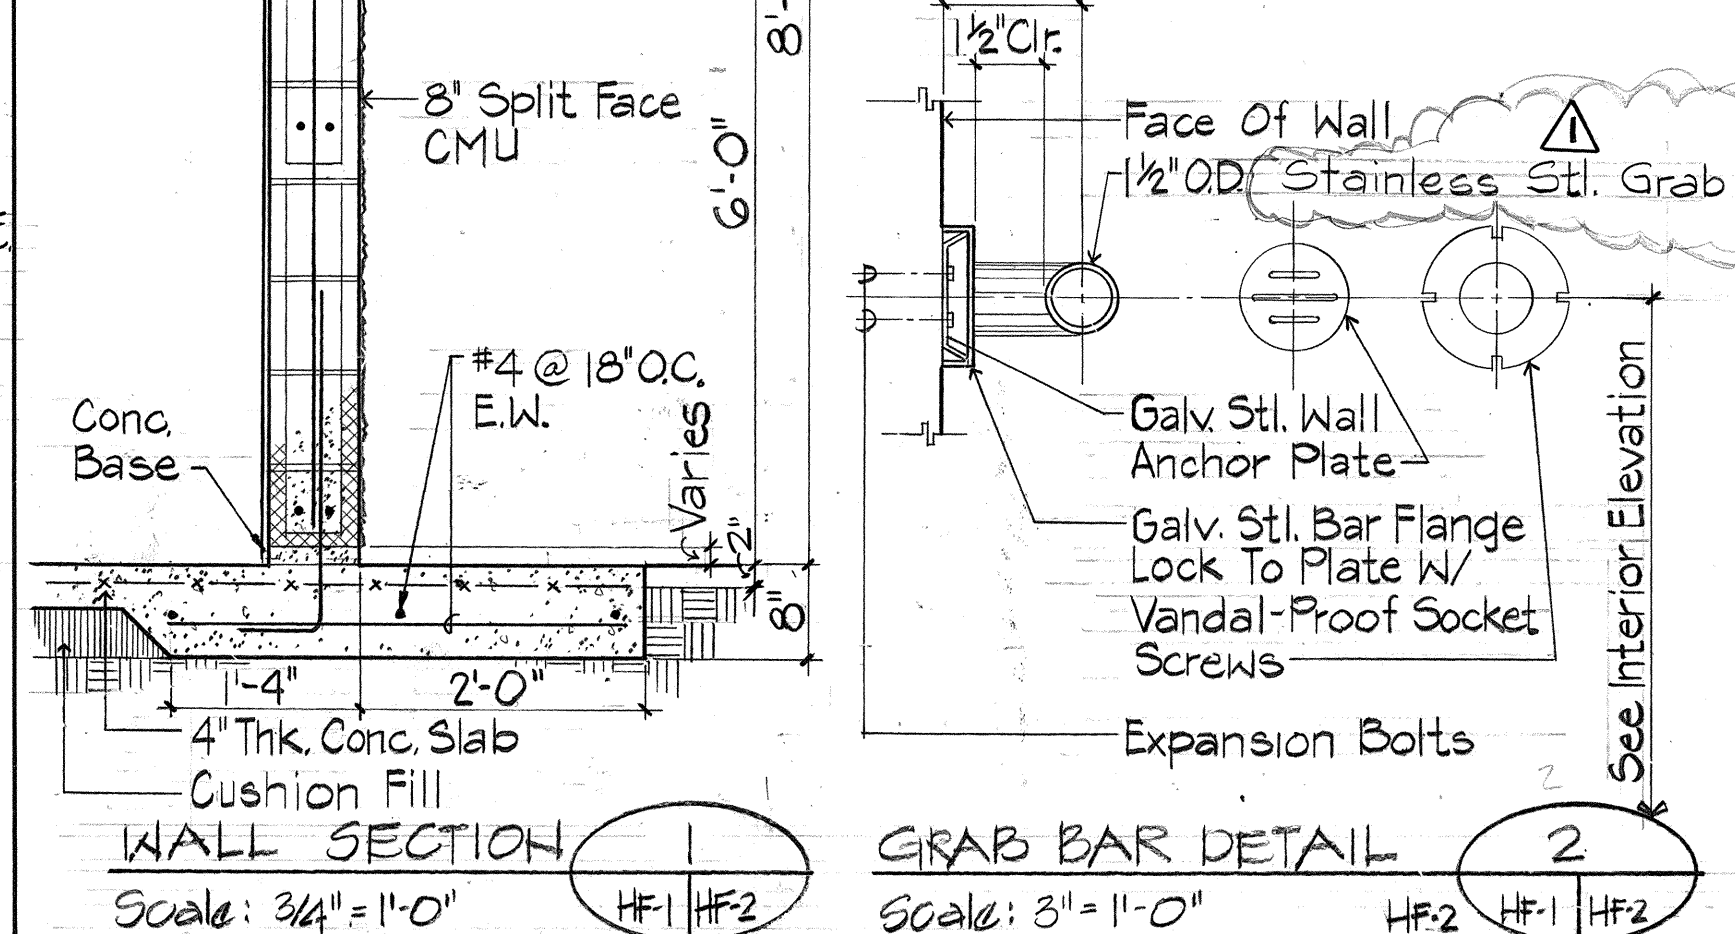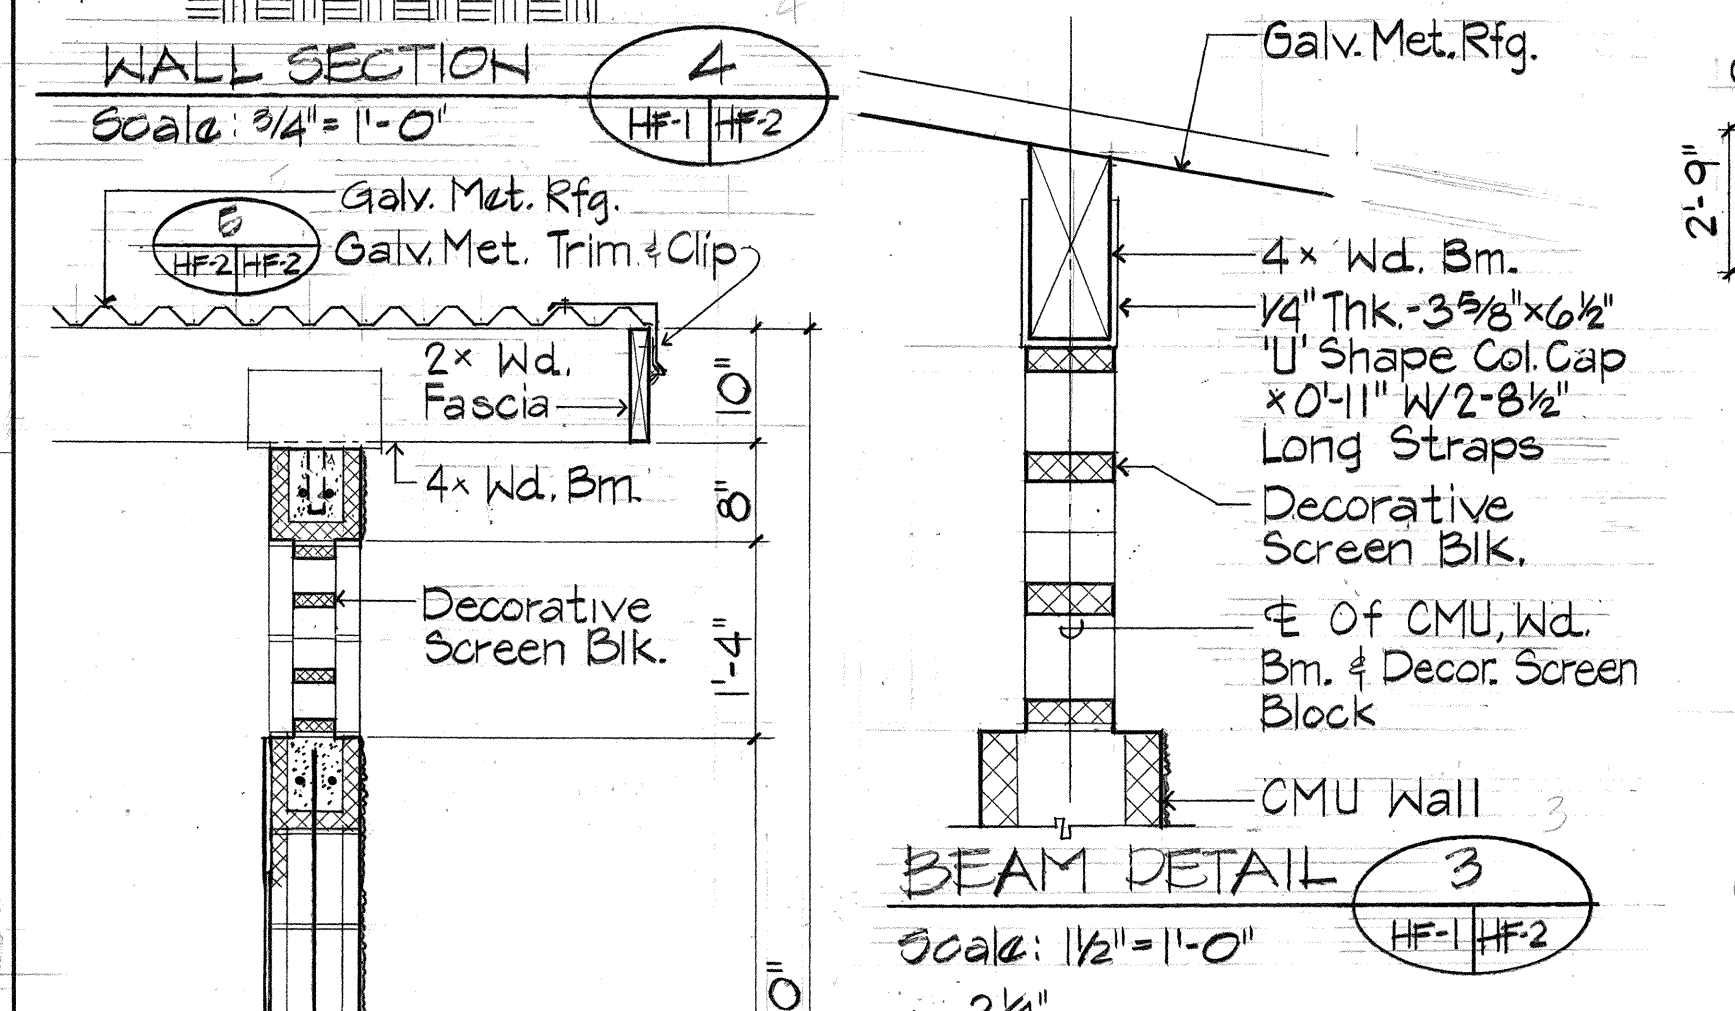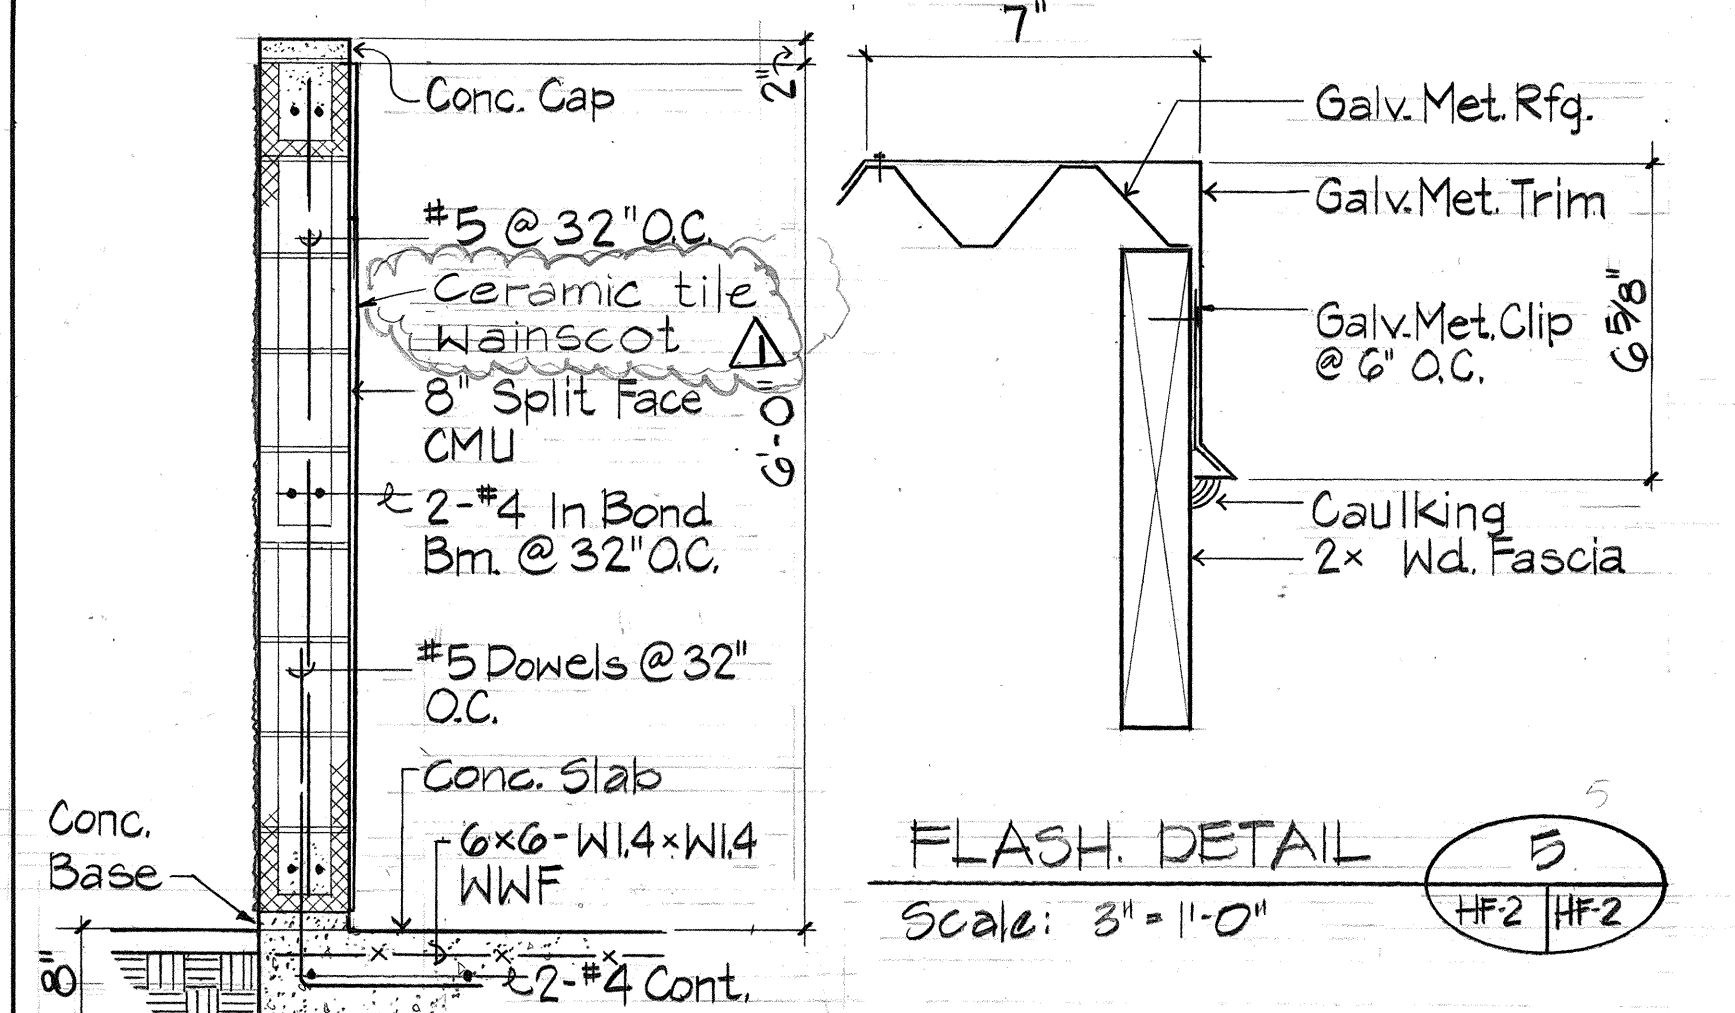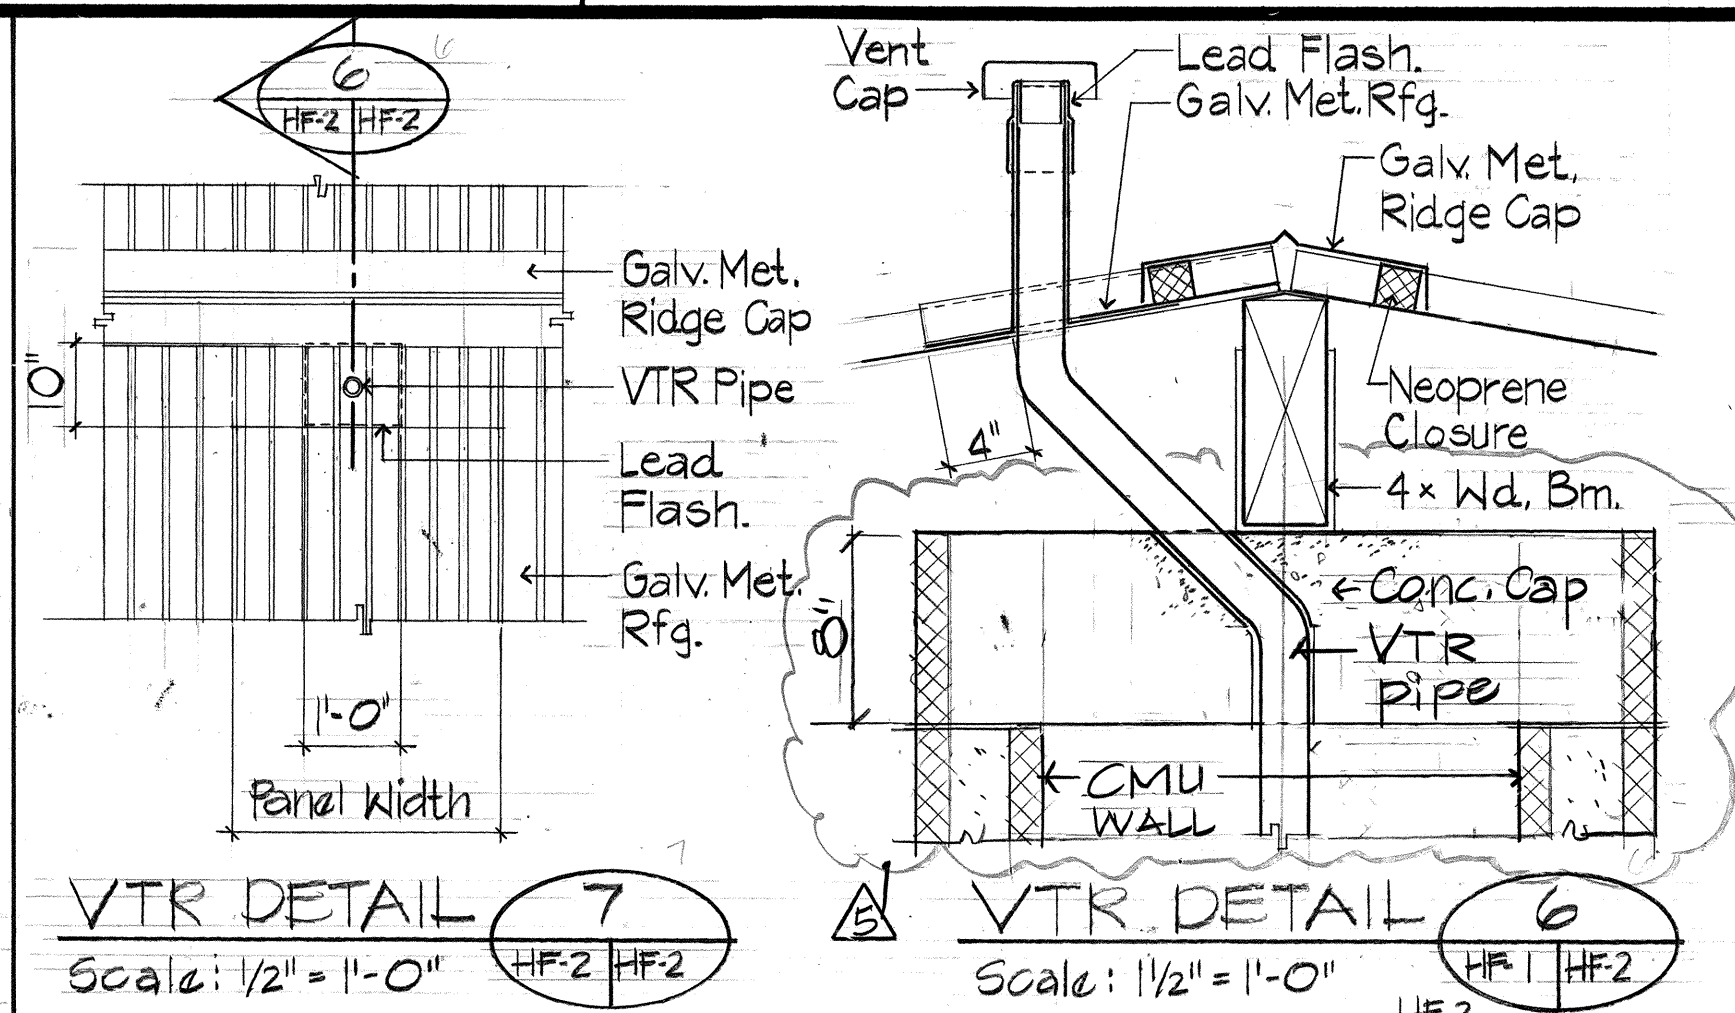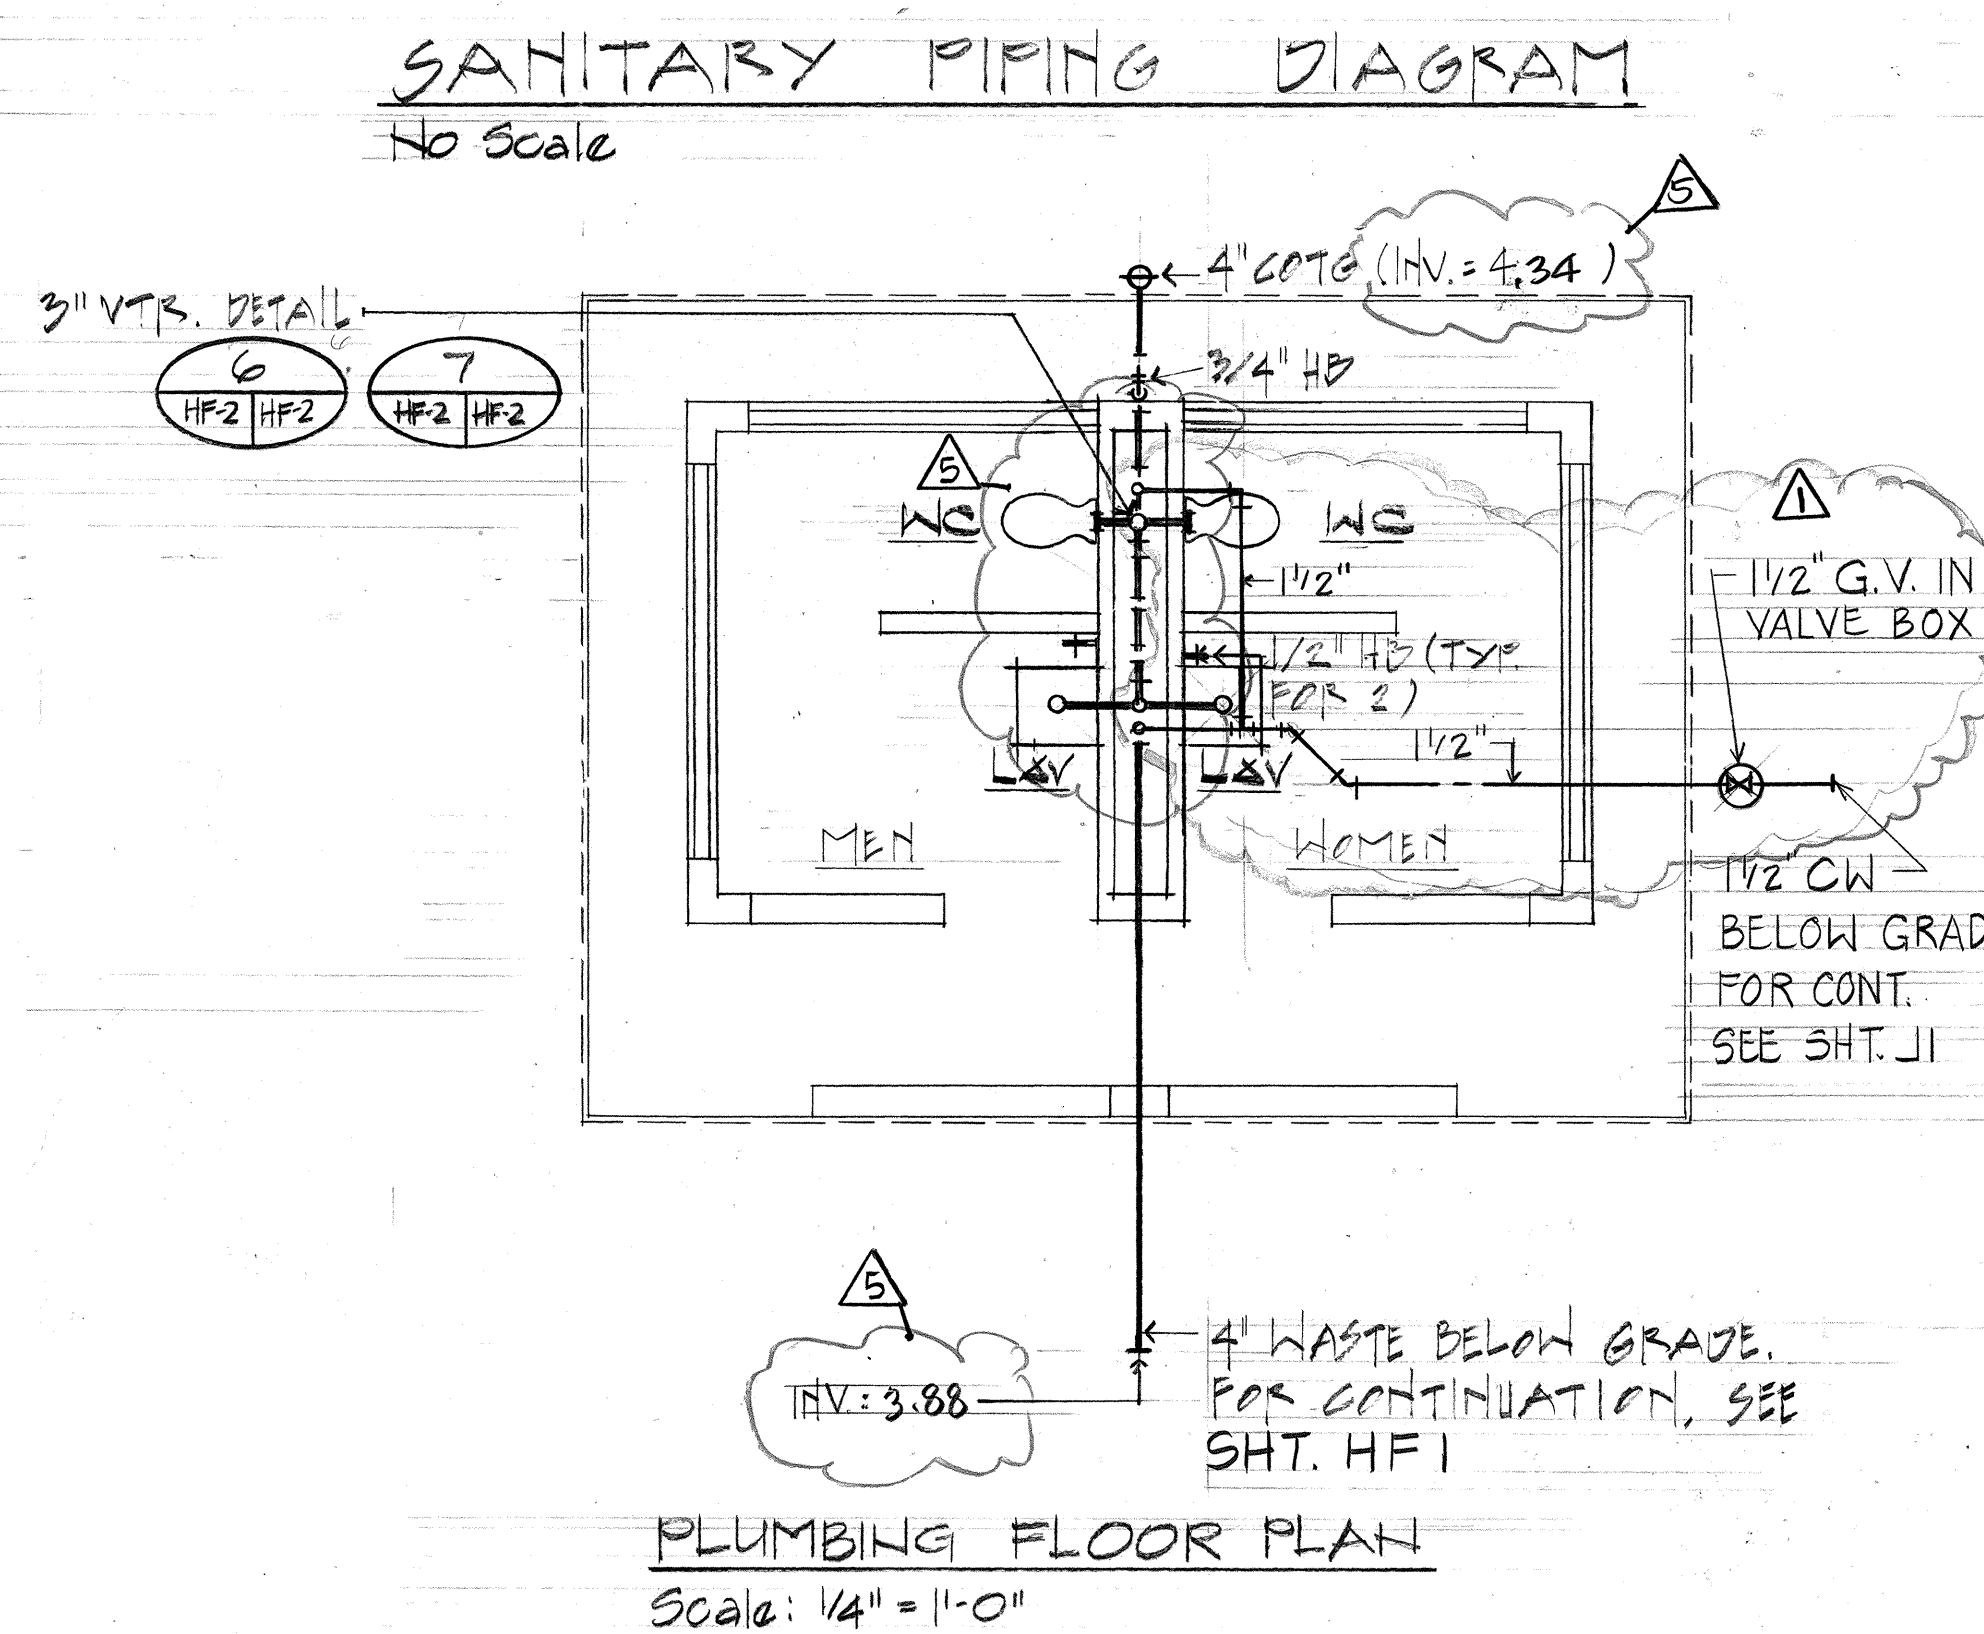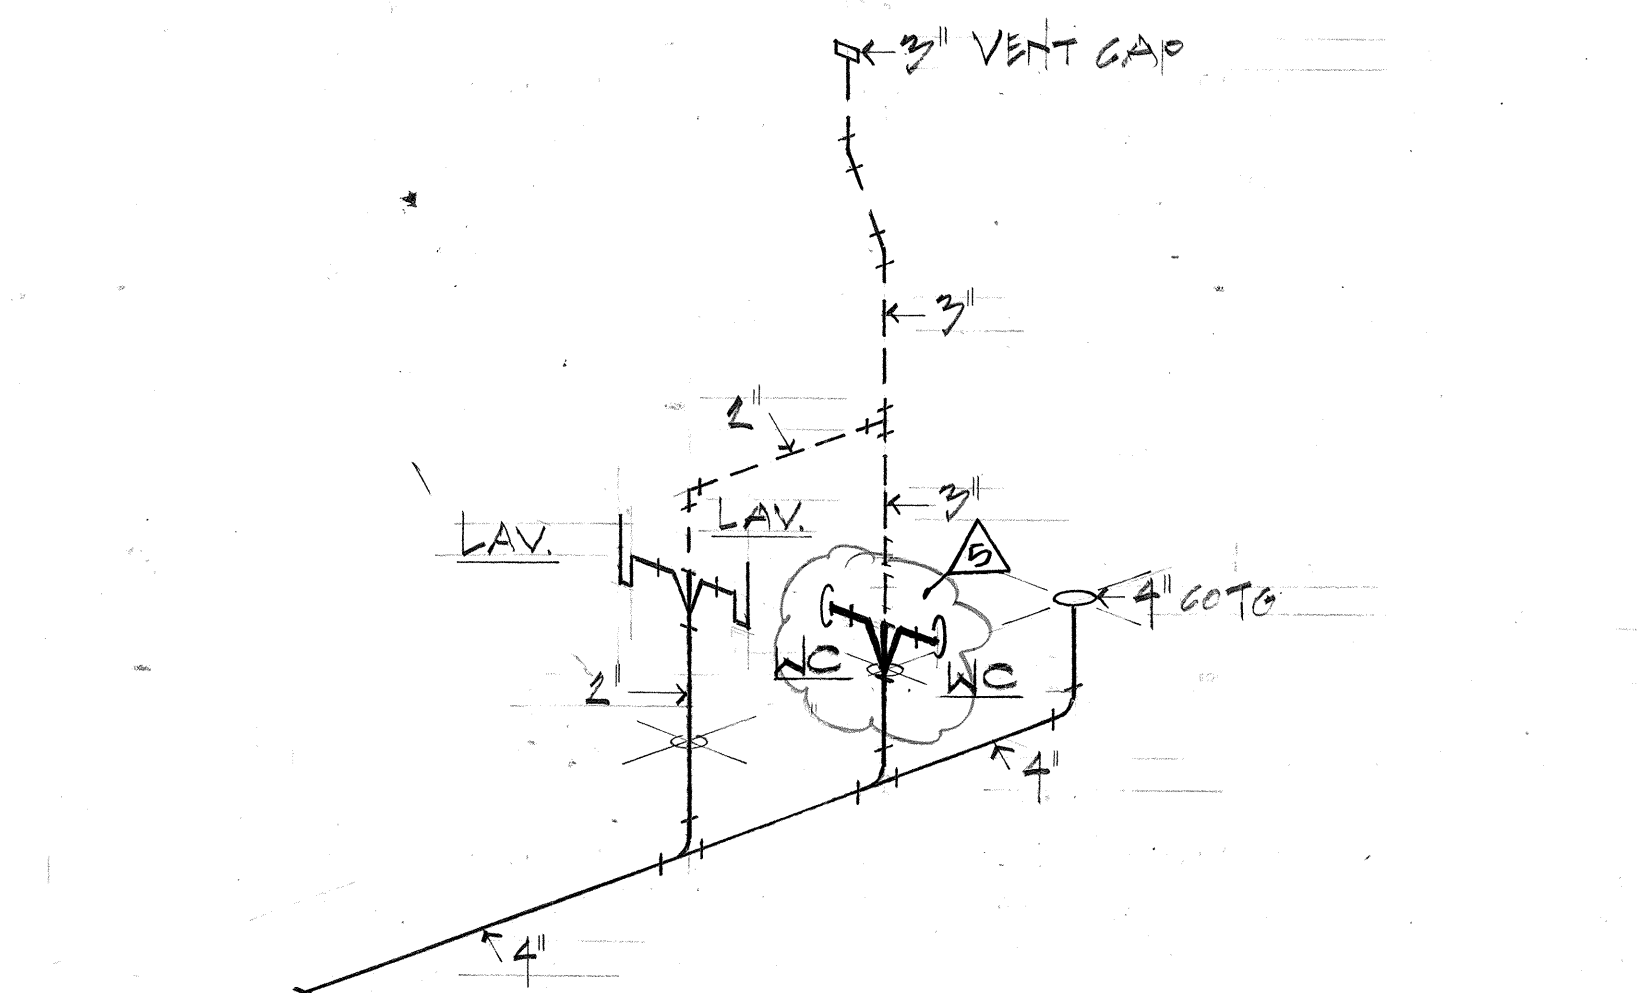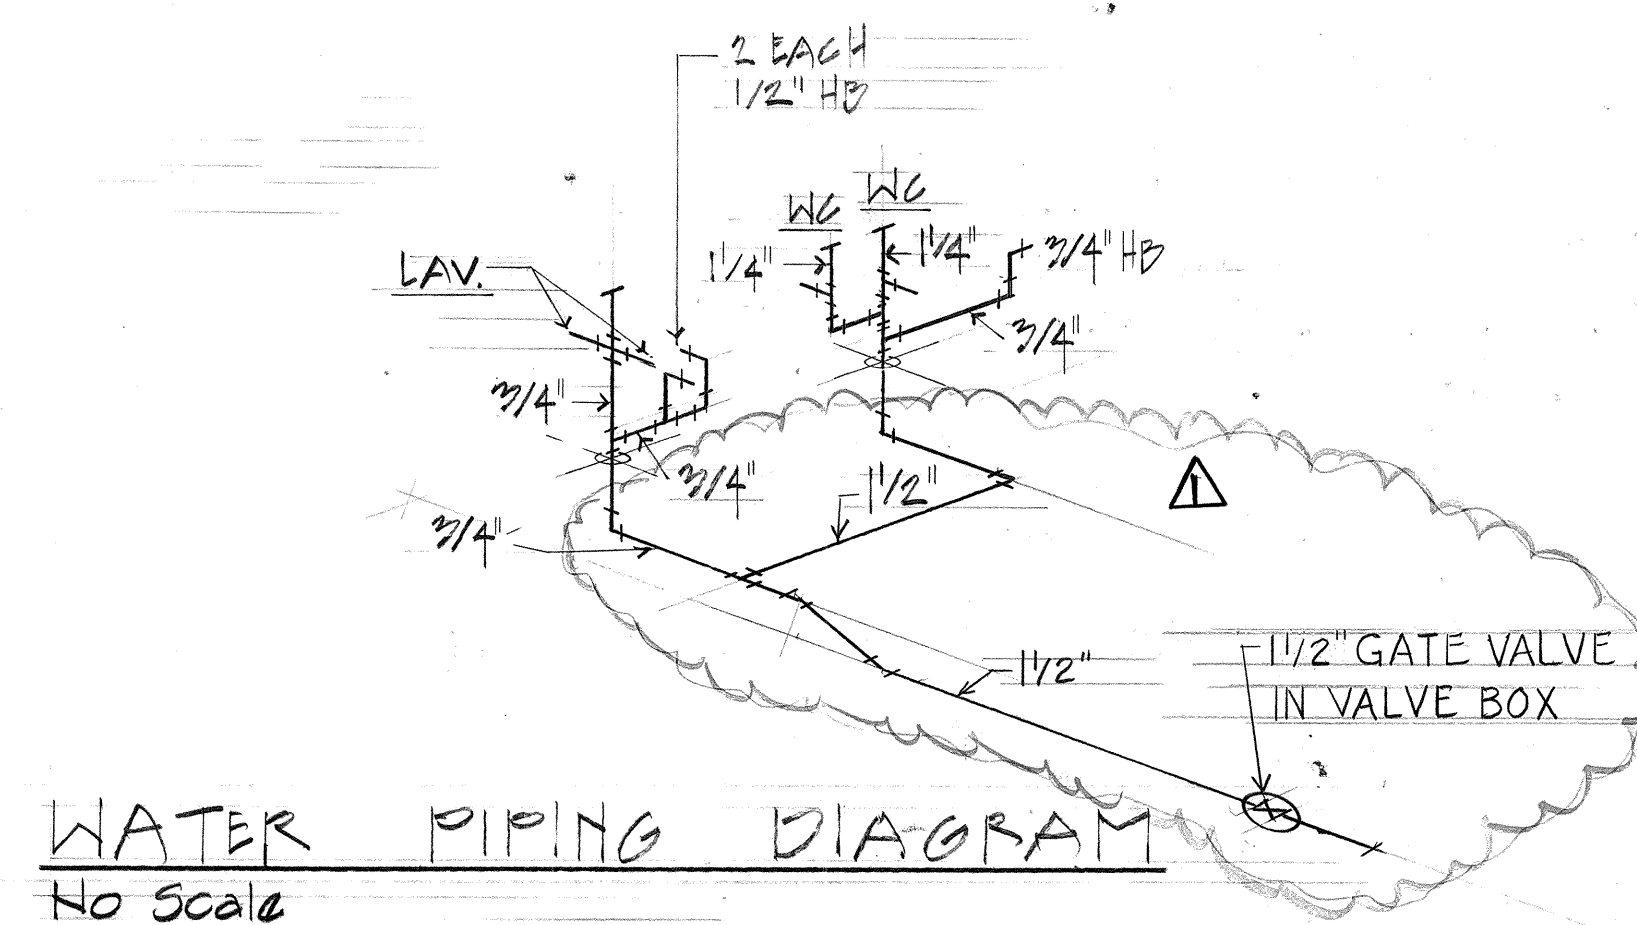

DATE	REVISION
8/11/89	Revised
11/1/88	Change Grab Bar to Stainless Steel. Revised Water Piping Diagram And Plumbing Floor Plan.

STATE OF HAWAII DEPARTMENT OF TRANSPORTATION HIGHWAYS DIVISION
HARBOR FACILITIES
COMFORT STATION DETAILS
HAWAII BELT ROAD/KAMEHAMEHA AVENUE
Wailoa Bridge Replacement And Approaches
FEDERAL AID PROJECT NO. BR-F-019-2(27)
SCALE: AS NOTED DATE: SEPT, 1986
SHEET No. HF2 OF 2 SHEETS

