

INDEX TO DRAWINGS	
SHEET NO.	DESCRIPTION
1	TITLE SHEET
2	STANDARD PLANS SUMMARY
3	GENERAL NOTES
4	GENERAL NOTES AND LEGEND
5 - 6	WATER POLLUTION & EROSION CONTROL NOTES
7 - 9	DEMOLITION PLAN
10	TYPICAL SECTION
11 - 13	ROADWAY PLAN
14	CURVE RETURN
15	DRAINAGE SUMMARY
16 - 18	DRAINAGE PLANS
19 - 24	DRAINAGE DETAILS
25 - 28	GUARDRAIL DETAILS
29	FLEAT-350, FLARED ENERGY ABSORBING TERMINAL
30	PAVEMENT MARKING LEGEND AND NOTES
31 - 33	PAVEMENT MARKING AND SIGNING PLAN
34	CONSTRUCTION SIGN PLAN
35	CONSTRUCTION SIGN DETAILS
36	CONCRETE WALL PLAN AND ELEVATION
37	CONCRETE WALL TYPICAL SECTION AND ELEVATION
38 - 40	ELECTRICAL PLAN

STATE OF HAWAII

DEPARTMENT OF TRANSPORTATION

HIGHWAYS DIVISION

HONOLULU, HAWAII

"AS-BUILT"

PLANS FOR


HAWAII BELT ROAD

TRAFFIC OPERATIONAL IMPROVEMENTS

AT KULAIMANO ROAD


Project No. 19J-01-02

DISTRICT OF SOUTH HILO
ISLAND OF HAWAII


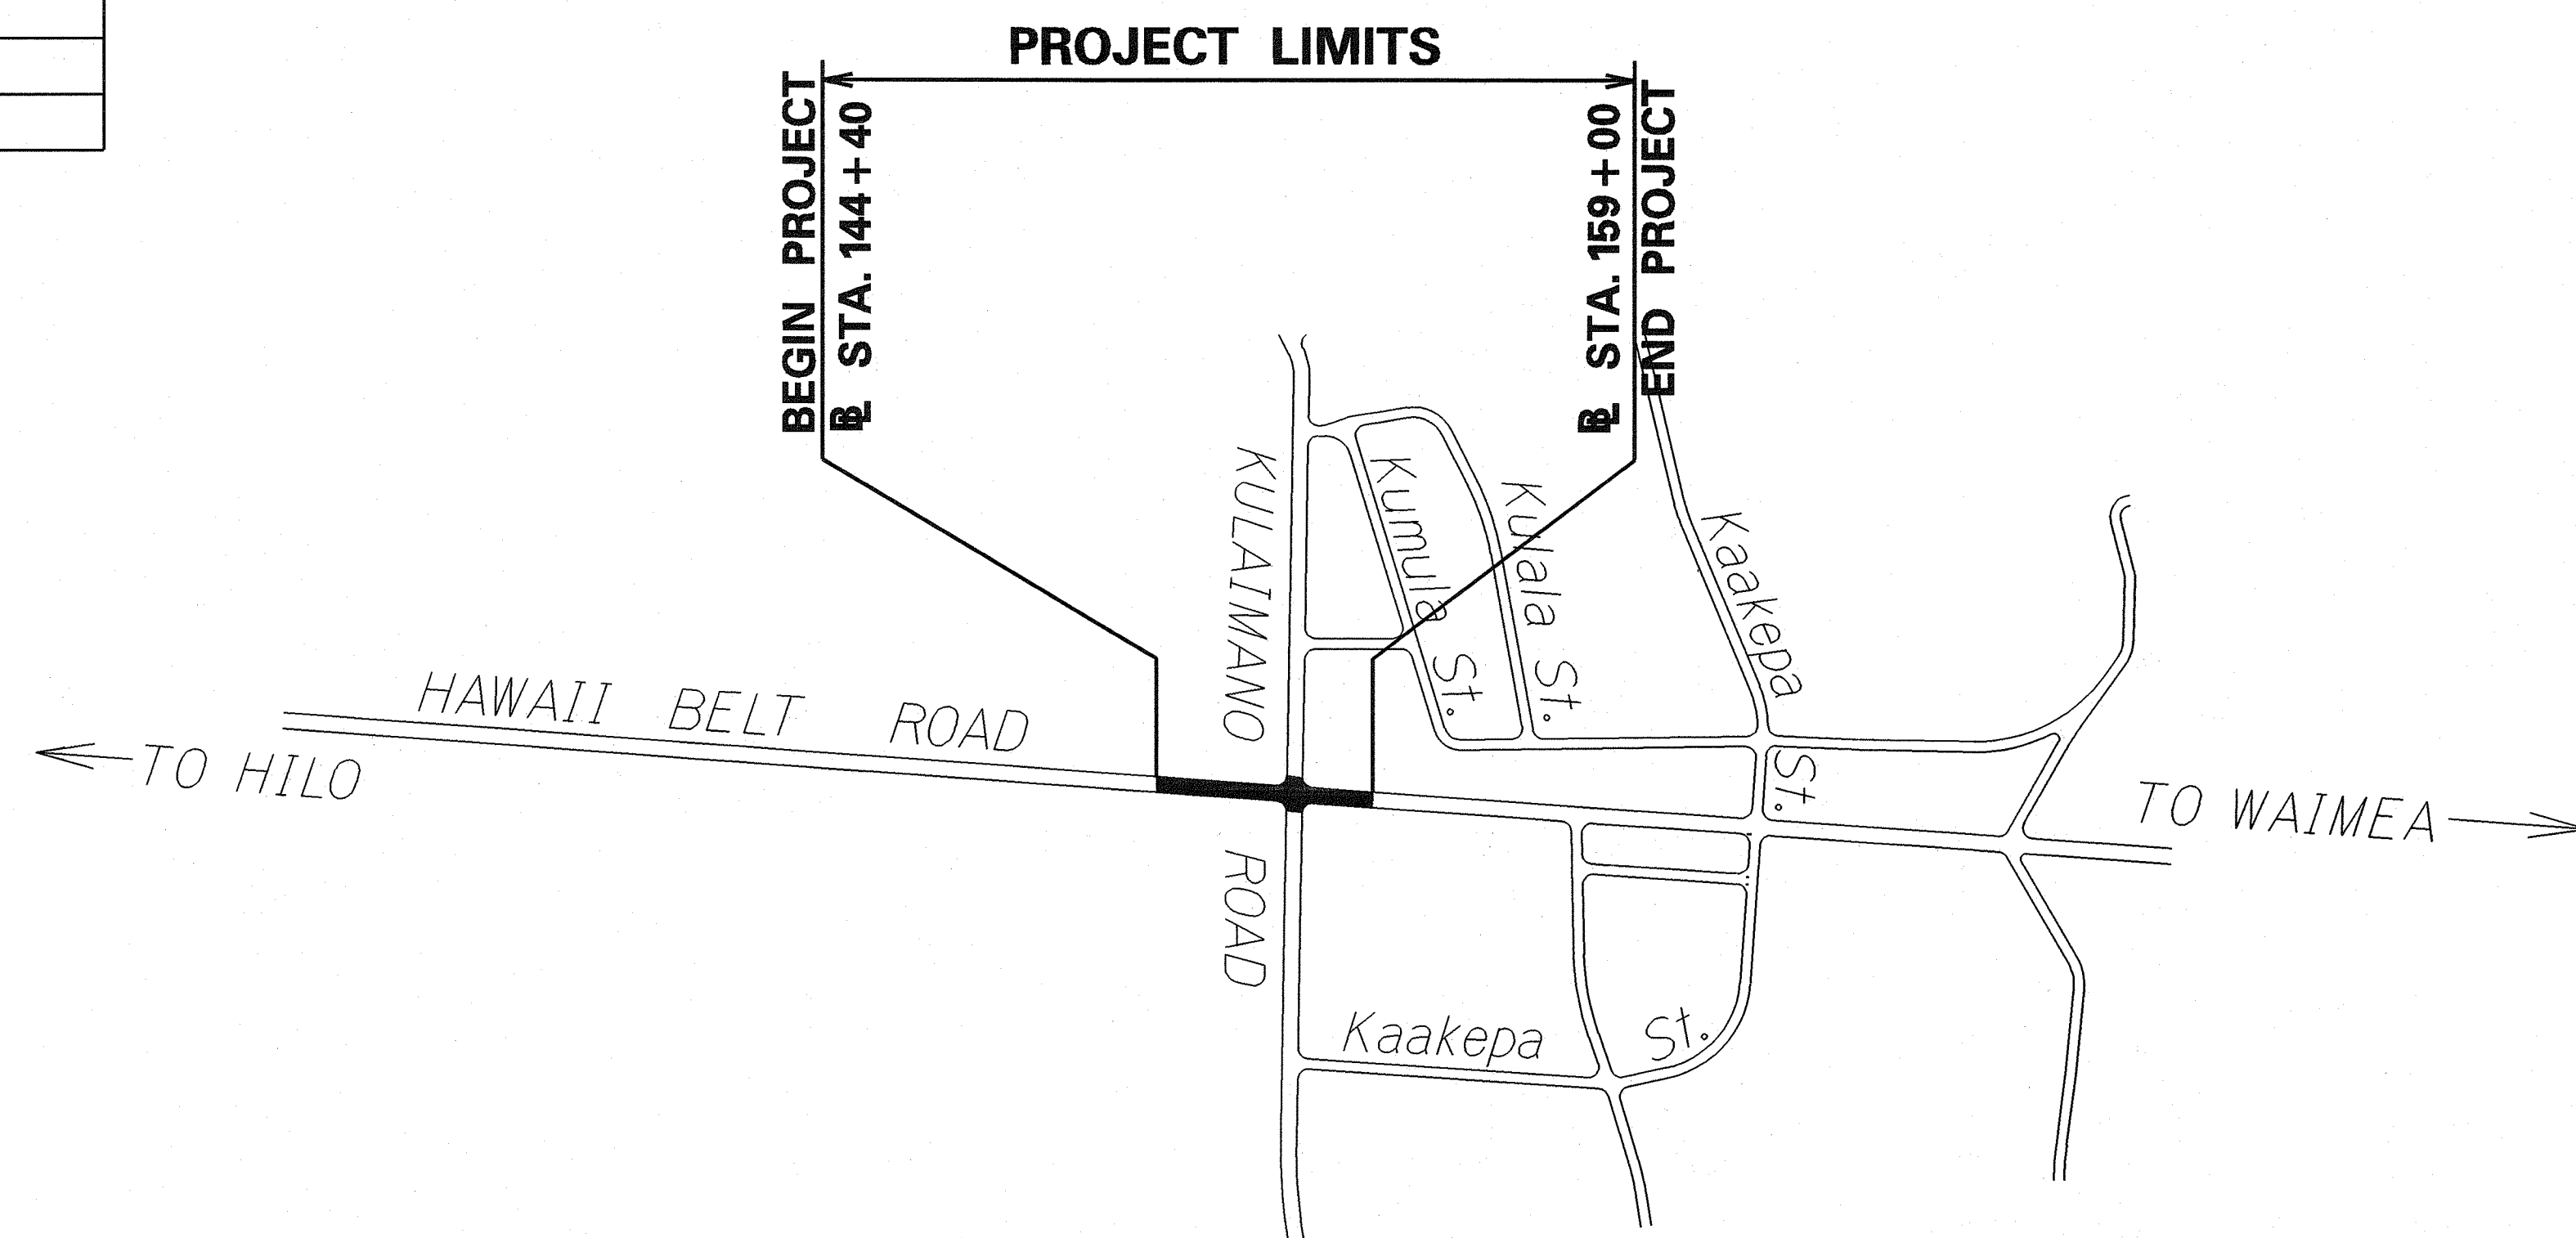


LAYOUT PLAN


GROSS LENGTH OF PROJECT..... 0.28 MILES
NET LENGTH OF PROJECT..... 0.28 MILES

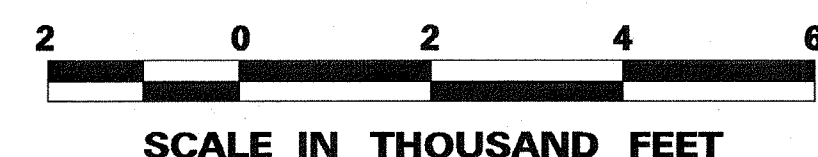

FED. ROAD DIST. NO.	STATE	FED. AID PROJ. NO.	FISCAL YEAR	SHEET NO.	TOTAL SHEETS
HAWAII	HAW.	19J-01-02	2004	1	40

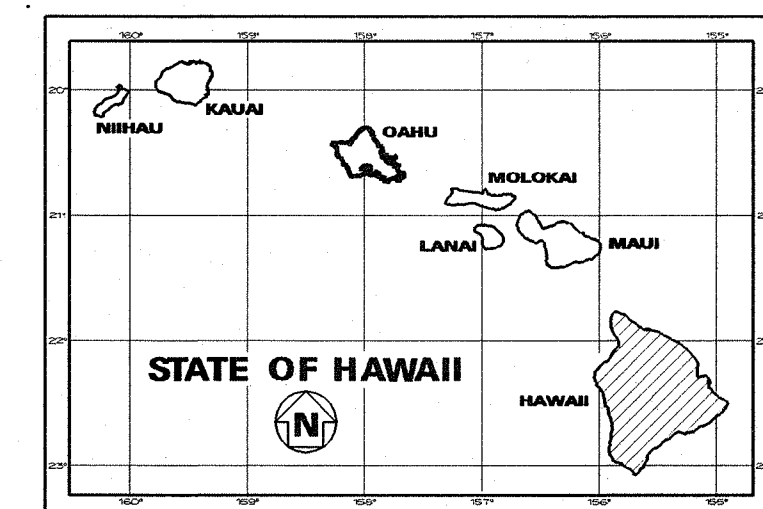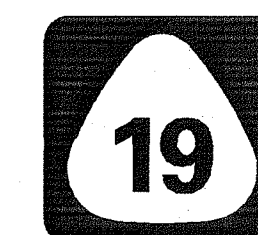

PROJECT LOCATION

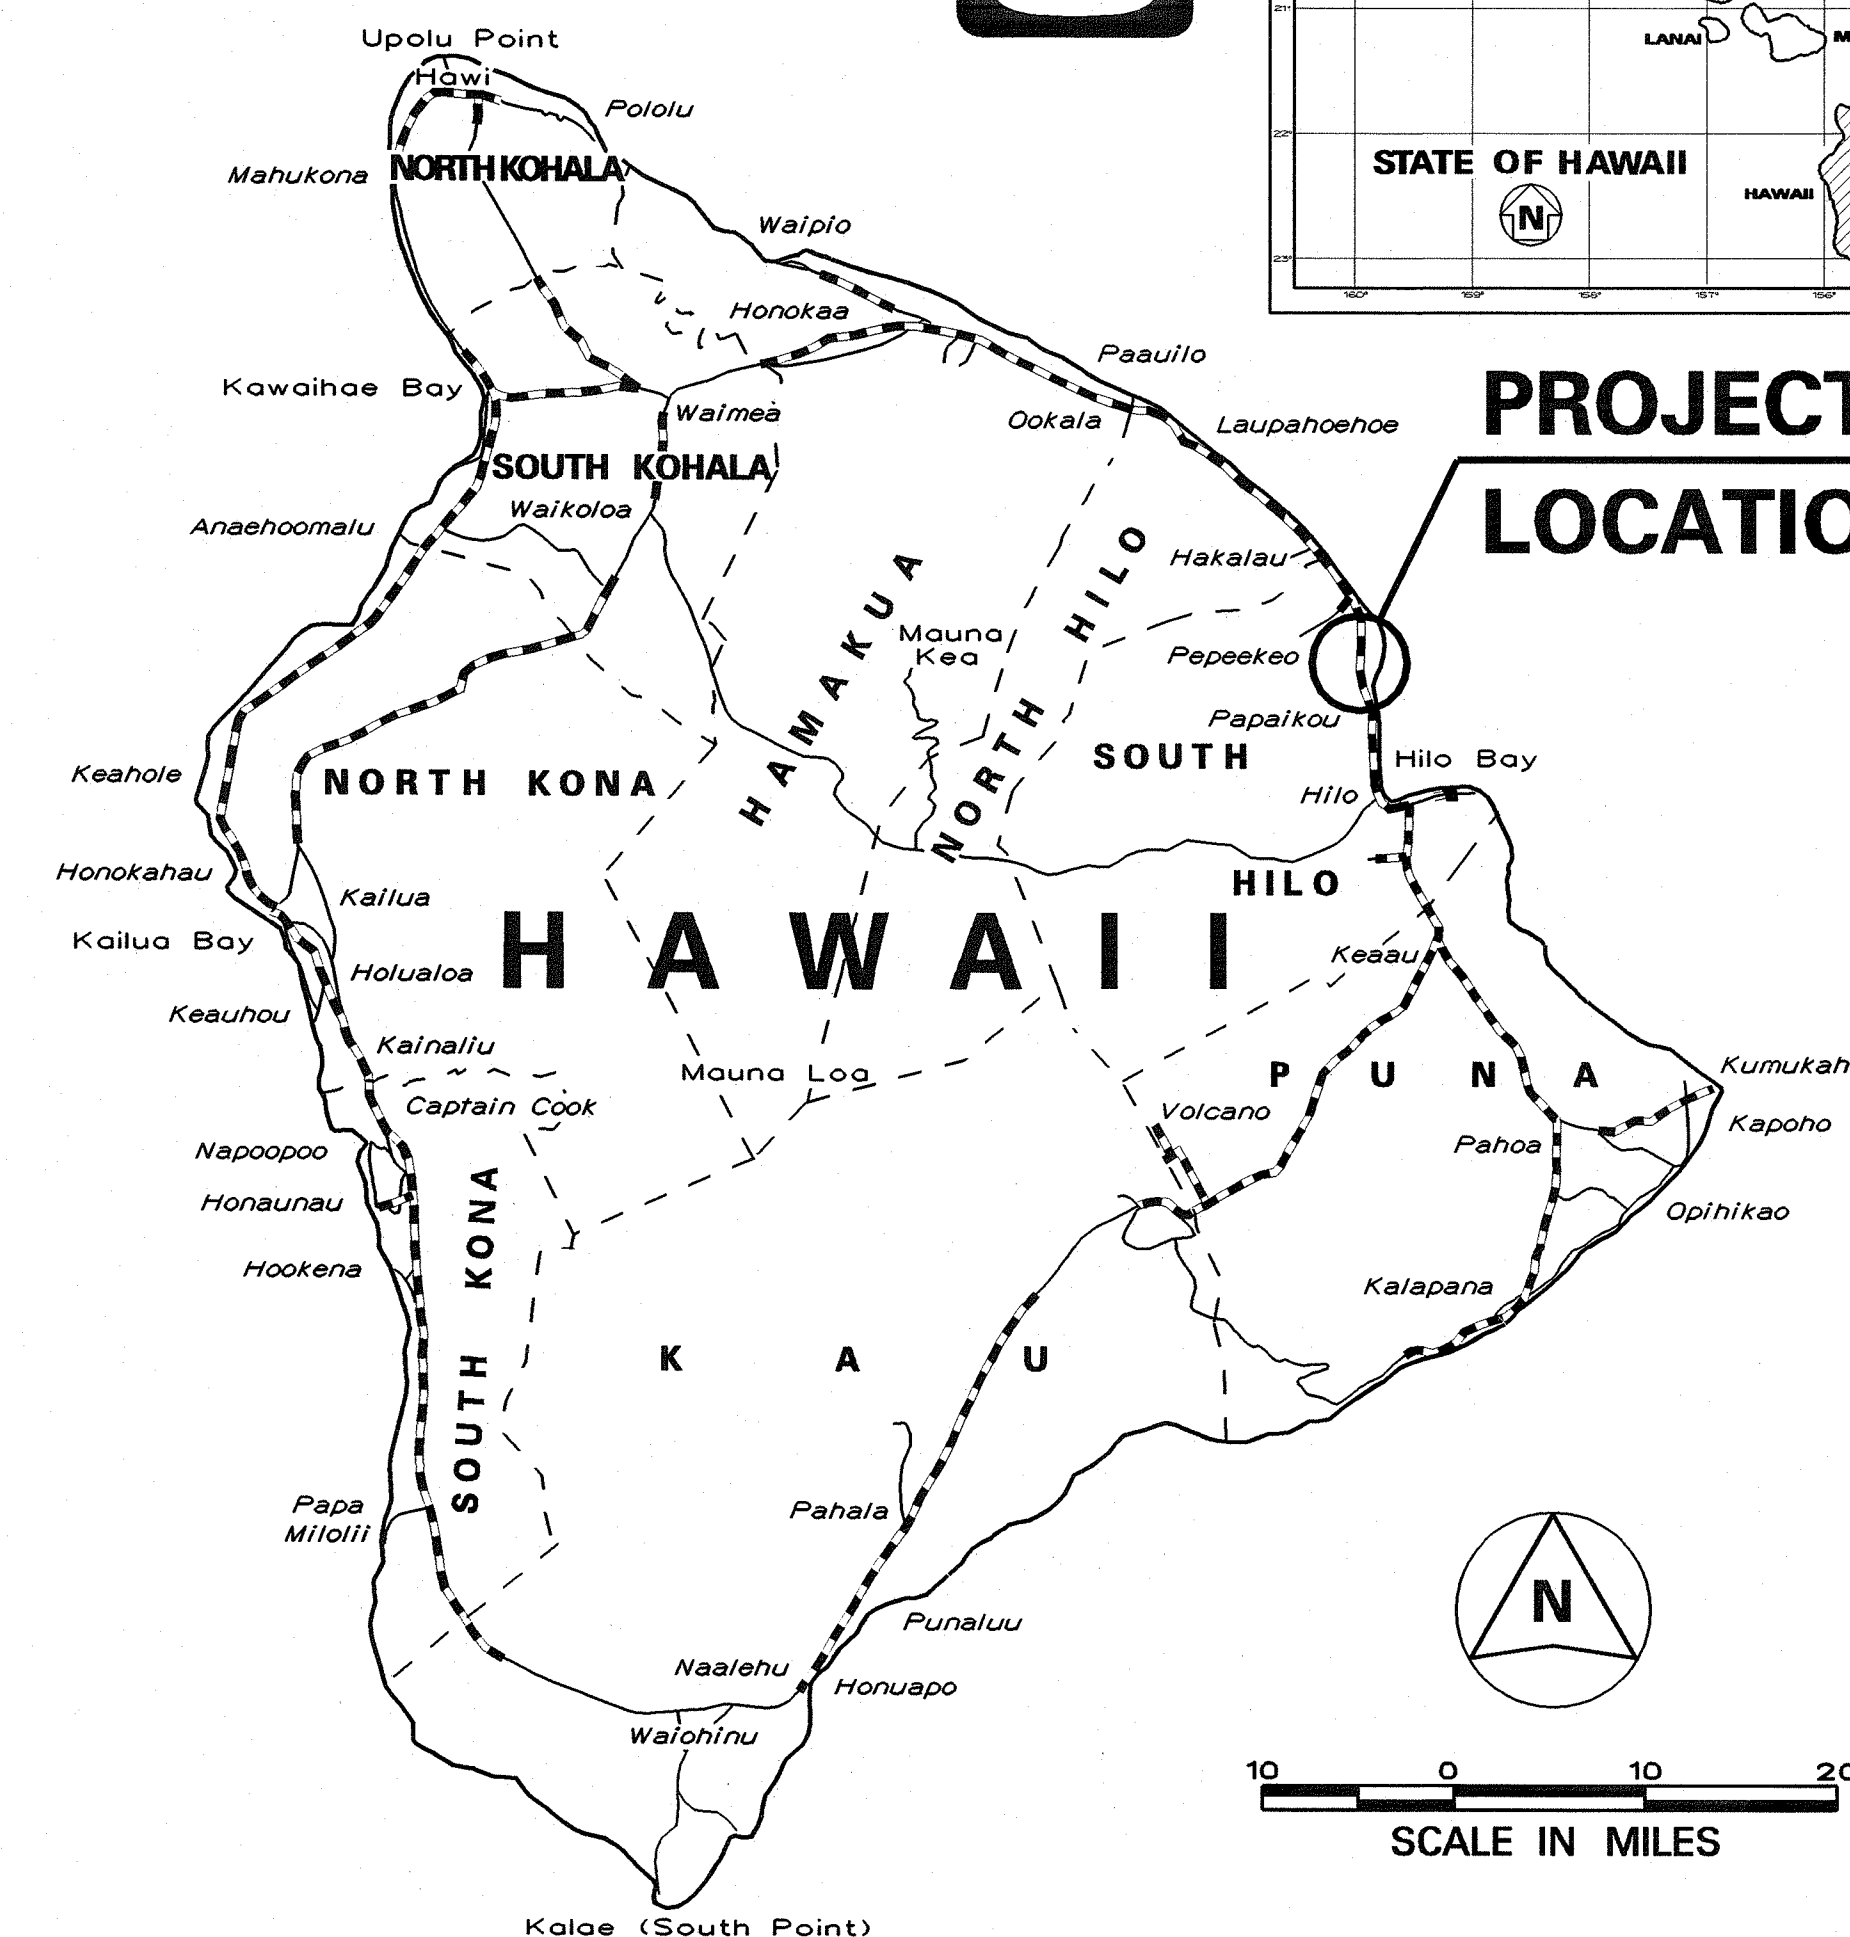

----- FEDERAL AID PROJECTS PREVIOUSLY CONSTRUCTED OR UNDER CONSTRUCTION

MILE POST 9.96 TO MILE POST 10.24

CHANGES MADE DURING CONSTRUCTION HAVE BEEN INCORPORATED ON THESE PLANS EXCEPT CHANGES IN THE ORIGINAL THEORETICAL QUANTITIES. FOR ACTUAL QUANTITIES, REFER TO PROJECT LEDGER AND/OR COMPUTATION BOOK.

[Signature] 5-2-11
for RESIDENT ENGINEER DATE

DEPARTMENT OF TRANSPORTATION
STATE OF HAWAII

APPROVED:
[Signature] 2.6.04
for DIR. OF TRANSPORTATION DATE

DESIGNED BY
HWY-D
MANAGED BY
HWY-DD
692-7570
PHONE
February, 2004
DATE