

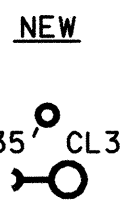
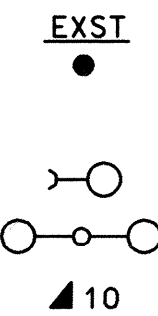


FED. ROAD DIST. NO.	STATE	PROJ. NO.	FISCAL YEAR	SHEET NO.	TOTAL SHEETS
HAWAII	HAW.	130B-02-94	1994	2	12

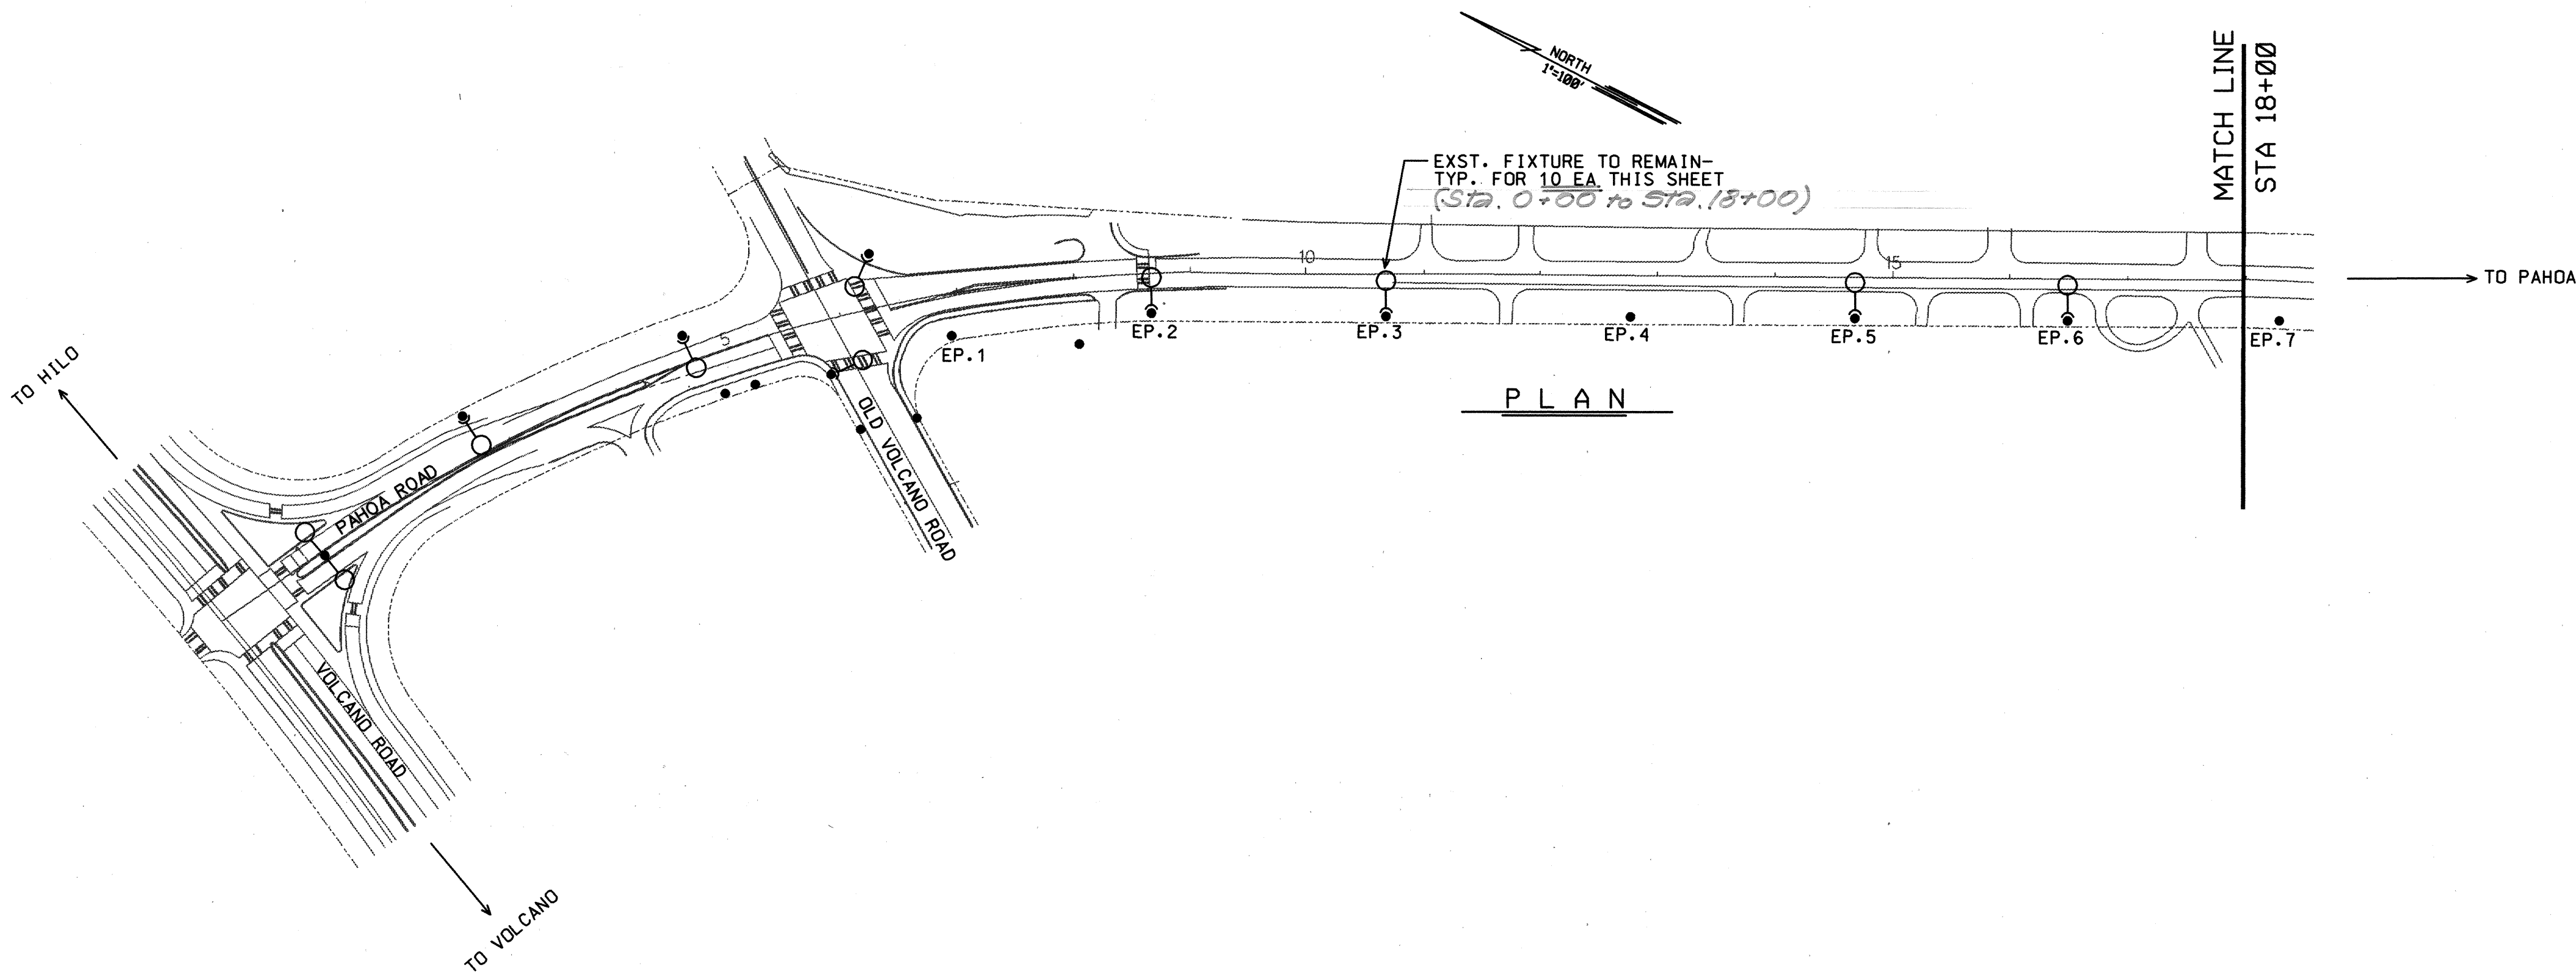


SYMBOL LIST

- WOOD POLE
- WOOD POLE, 35' = HEIGHT, CL3= CLASS 3, 1'-6" FROM RIGHT OF WAY
- POLE MOUNTED LIGHT FIXTURE
- STEEL POLE & LIGHT FIXTURES
- HELCO TRANSFORMER, 10=10KVA

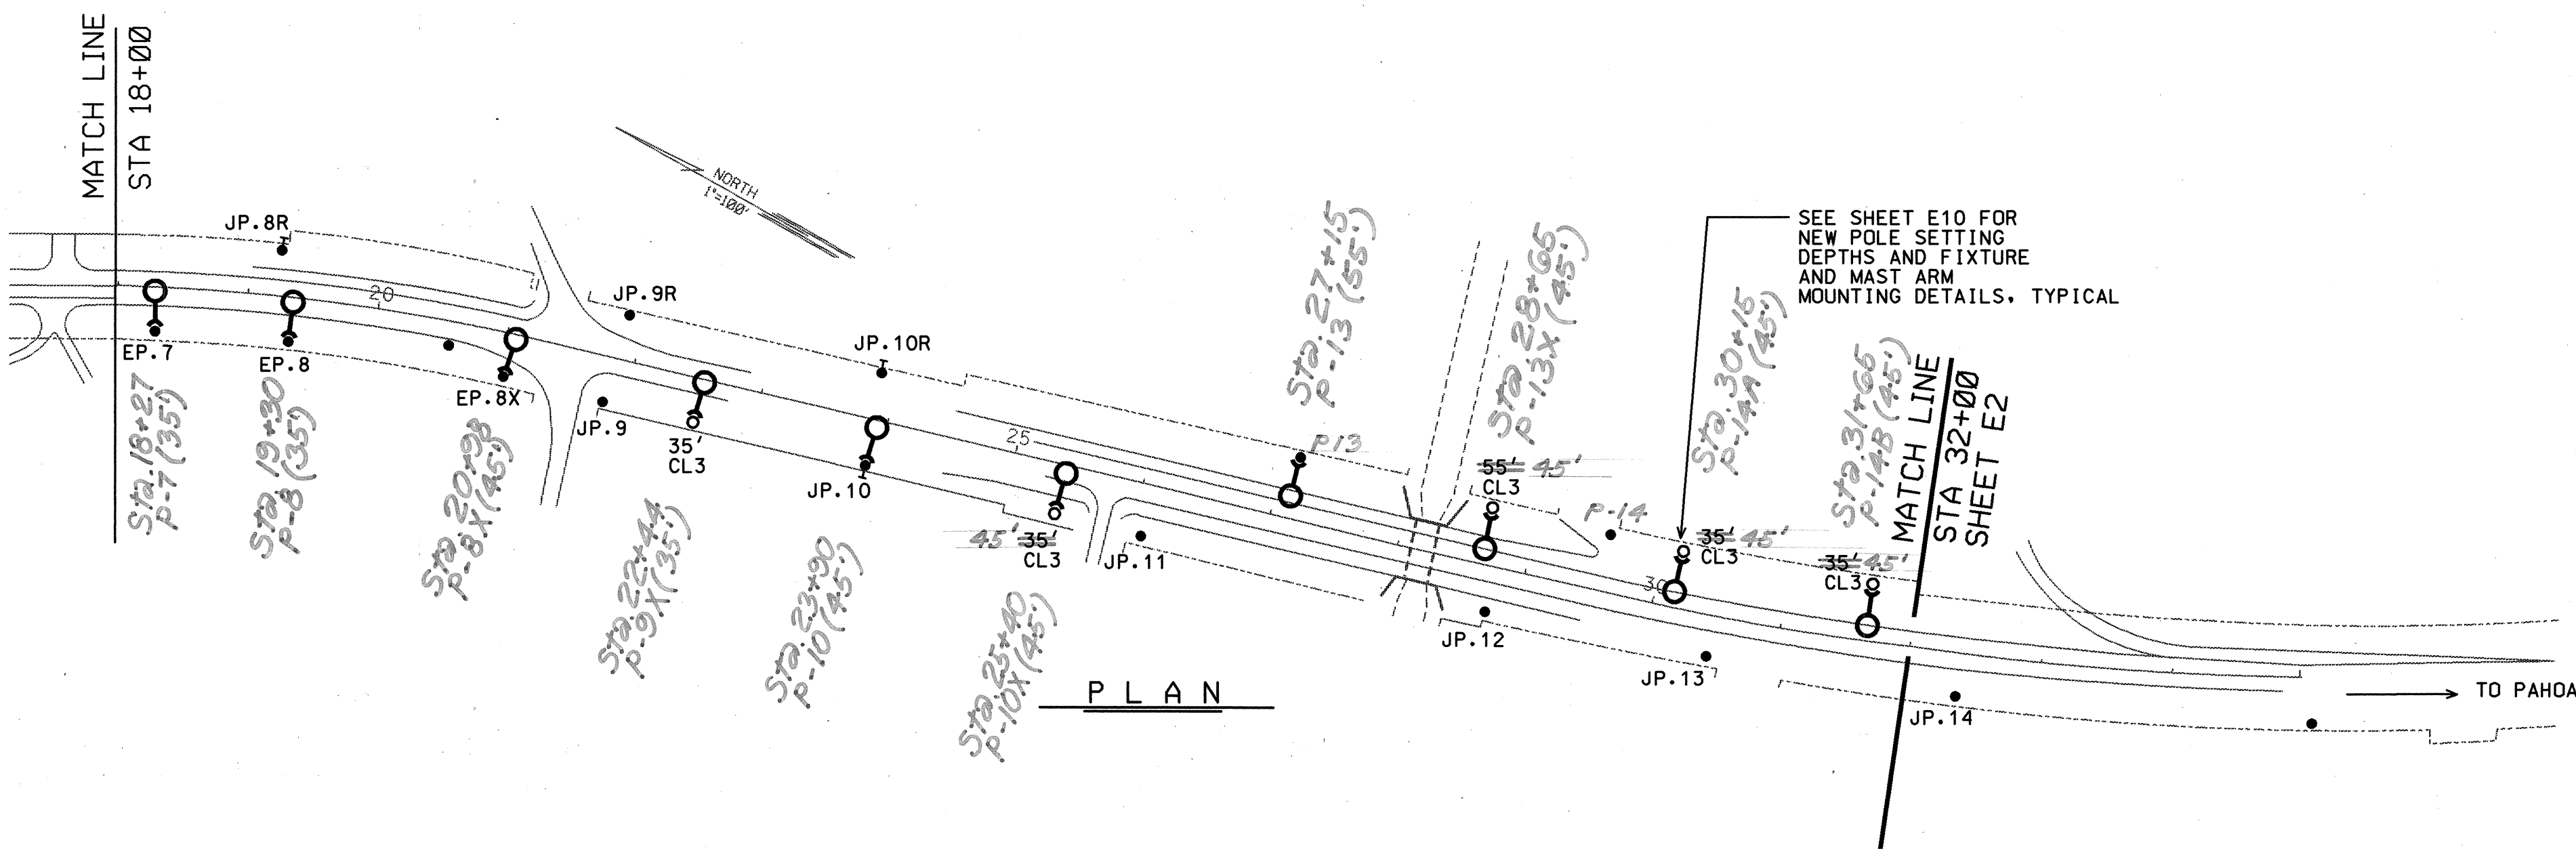

NOTE:

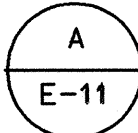SEE DETAIL  FOR TYPICAL STREET LIGHT WIRING DIAGRAM

SERVICE DATA

- SERVICE VOLTAGE: 1PH, 120/240V, 3W
- LOAD DATA: METER CONNECTED KVA DEMAND KVA
NONE 11.4 11.4
- SERVICE ENTRANCE CONDUCTORS: NONE
- METERING: UNMETERED
- TYPE: OVERHEAD
- BILLING ADDRESS: STATE OF HAWAII
DEPT. OF TRANSPORTATION
HIGHWAYS DIVISION
727 KAKOI ST.
HONOLULU, HI 96819



THIS WORK WAS PREPARED BY ME
OR UNDER MY SUPERVISION.
B. Okano
MK ENGINEERS, LTD.

DATE	DESCRIPTION
6/16/94	DELETED ONE-LINE DIAGRAMS & O/H CONDUCTORS, REVISED SYMBOL LIST
STATE OF HAWAII DEPARTMENT OF TRANSPORTATION HIGHWAYS DIVISION SITE PLAN, SYMBOLS LIST & SVC DATA KEAAU-PAHOA ROAD HIGHWAY LIGHTING, BETWEEN HAWAII BELT ROAD AND PAHOA TOWN F&P NO. 130B-02-94	
SCALE: AS NOTED	DATE: JUNE 1994
SHEET No. E1 OF 11 SHEETS	

"AS-BUILT"