



FED. ROAD DIST. NO.	STATE	PROJ. NO.	FISCAL YEAR	SHEET NO.	TOTAL SHEETS
HAWAII	HAW.	130B-02-94	1994	3	12

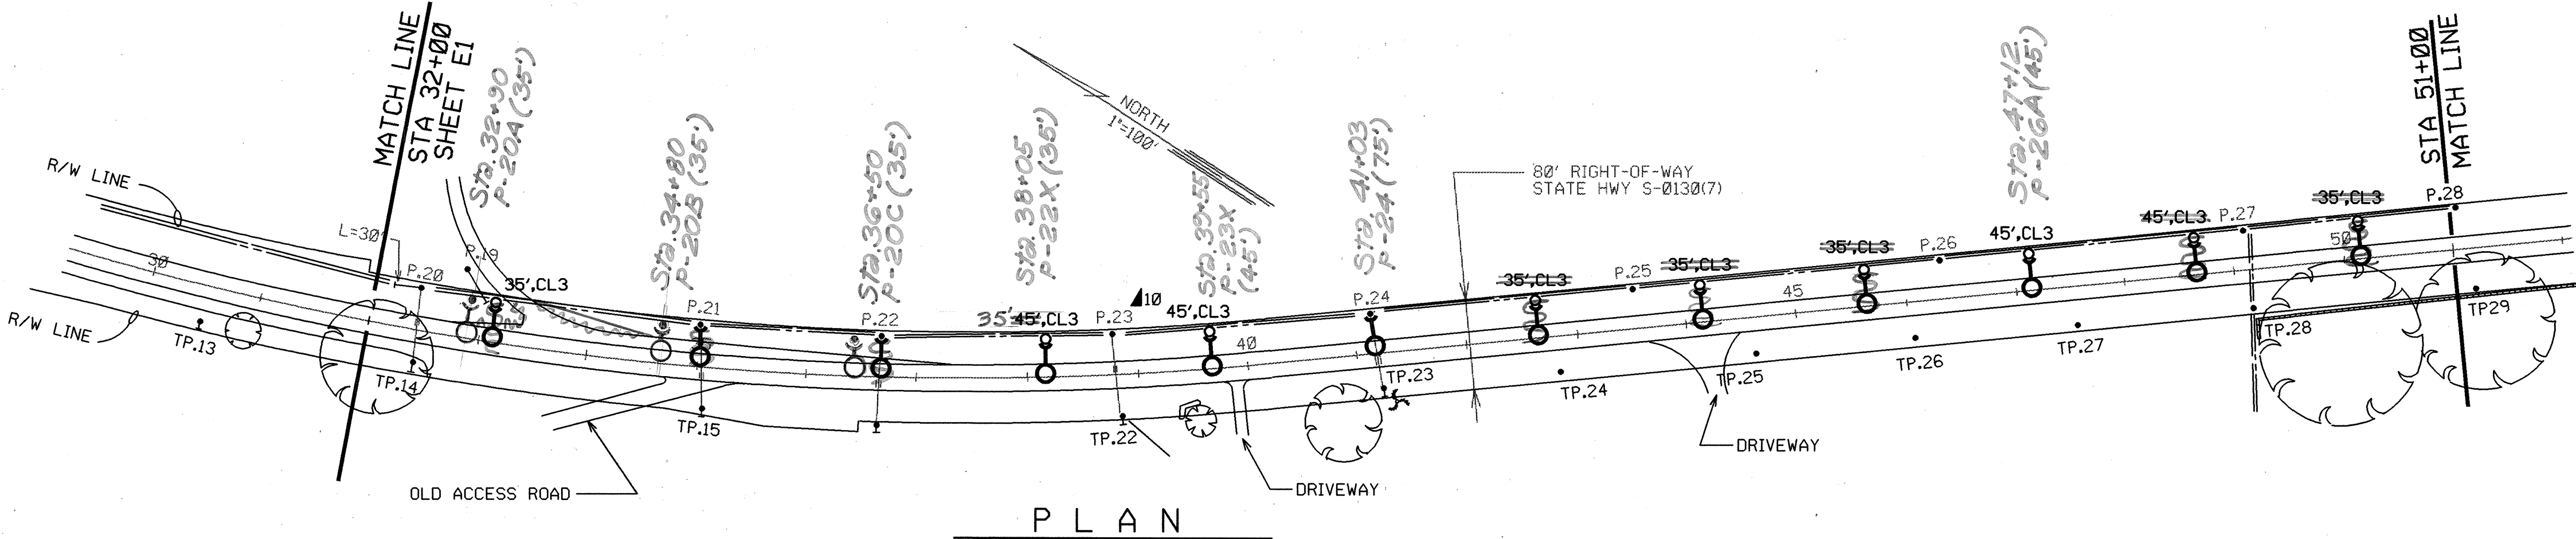

PLAN

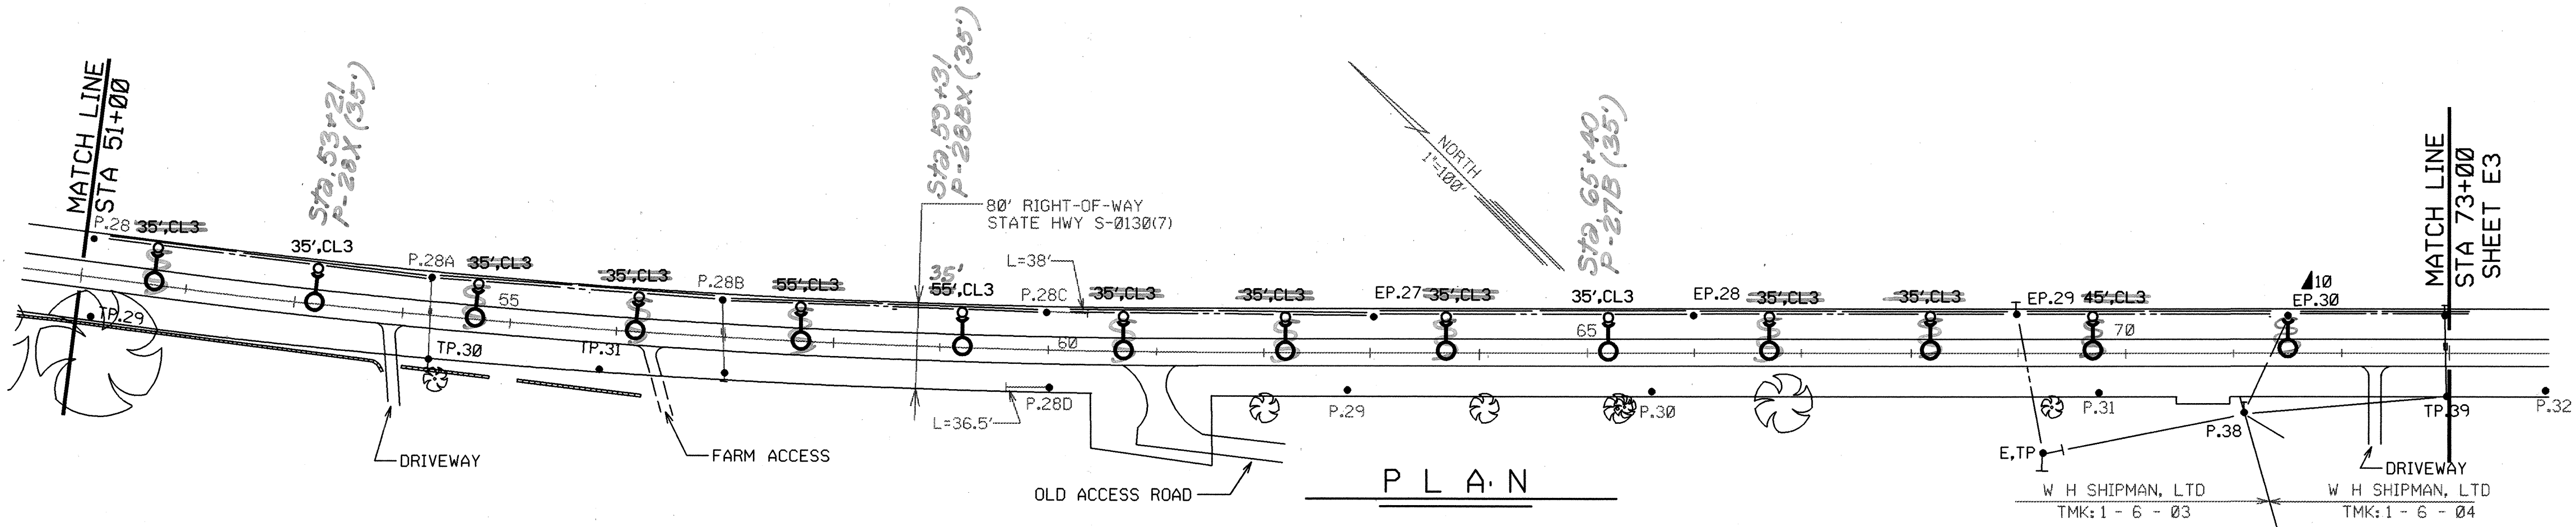

PLAN




THIS WORK WAS PREPARED BY ME
OR UNDER MY SUPERVISION.
B. K. OKANO
MK ENGINEERS, LTD.

6/16/94	DELETED ONE-LINE DIAGRAMS & O/H CONDUCTORS
DATE	DESCRIPTION
STATE OF HAWAII DEPARTMENT OF TRANSPORTATION HIGHWAYS DIVISION	
SITE PLAN	
KEAAU-PAHOA ROAD HIGHWAY LIGHTING, BETWEEN HAWAII BELT ROAD AND PAHOA TOWN PROJECT NO. 130B-02-94	
SCALE: AS NOTED	DATE: JUNE 1994
SHEET No. E2 OF 11 SHEETS	


"AS-BUILT"

ADD 3

FED. ROAD DIST. NO.	STATE	PROJ. NO.	FISCAL YEAR	SHEET NO.	TOTAL SHEETS
HAWAII	HAW.	130B-02-94	1994	4	12

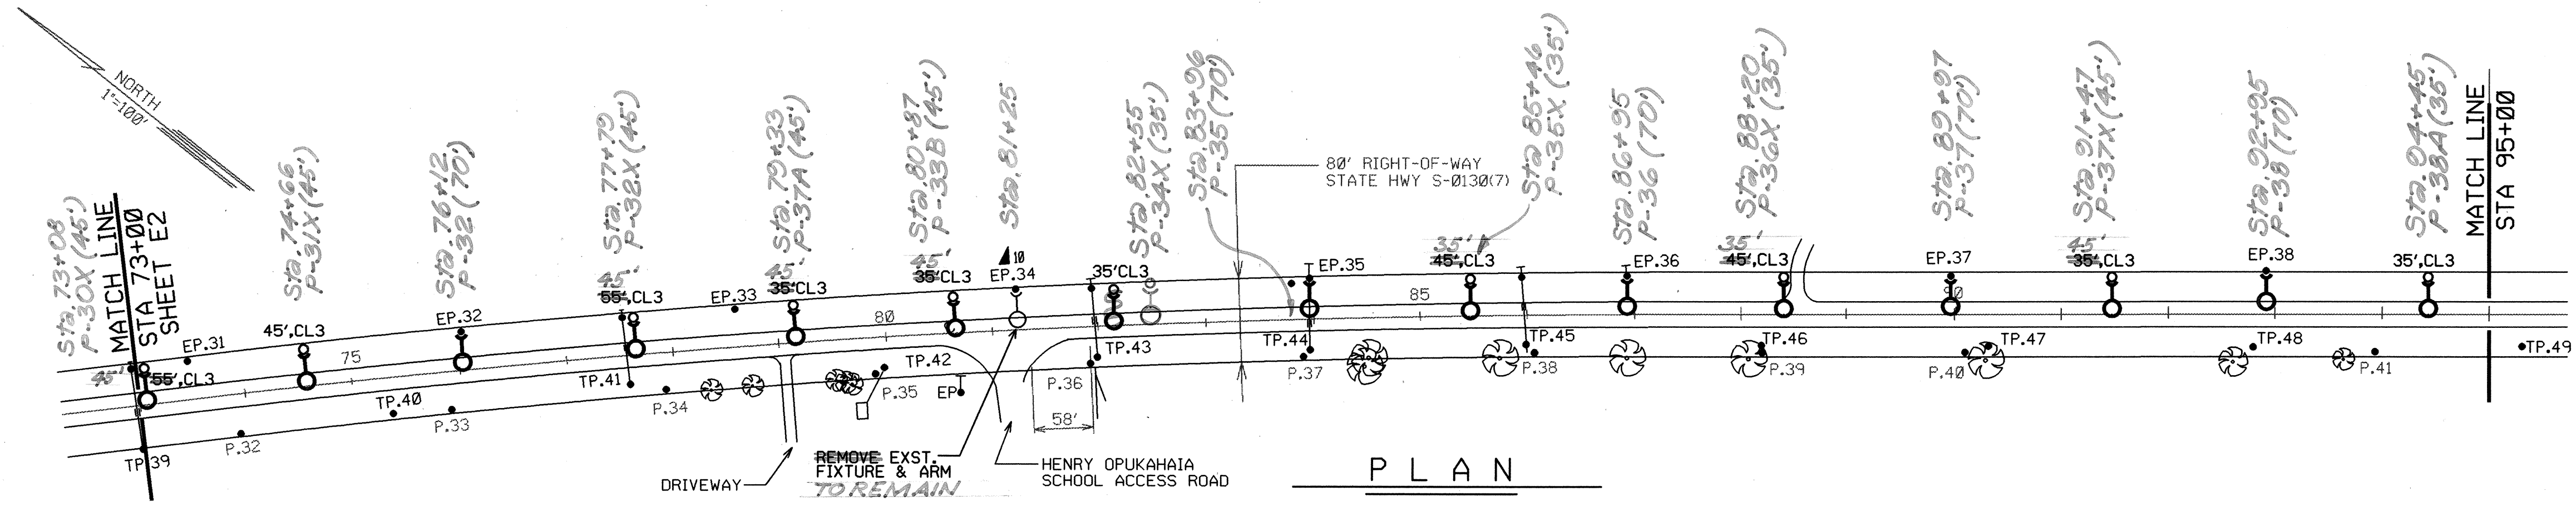

PLAN

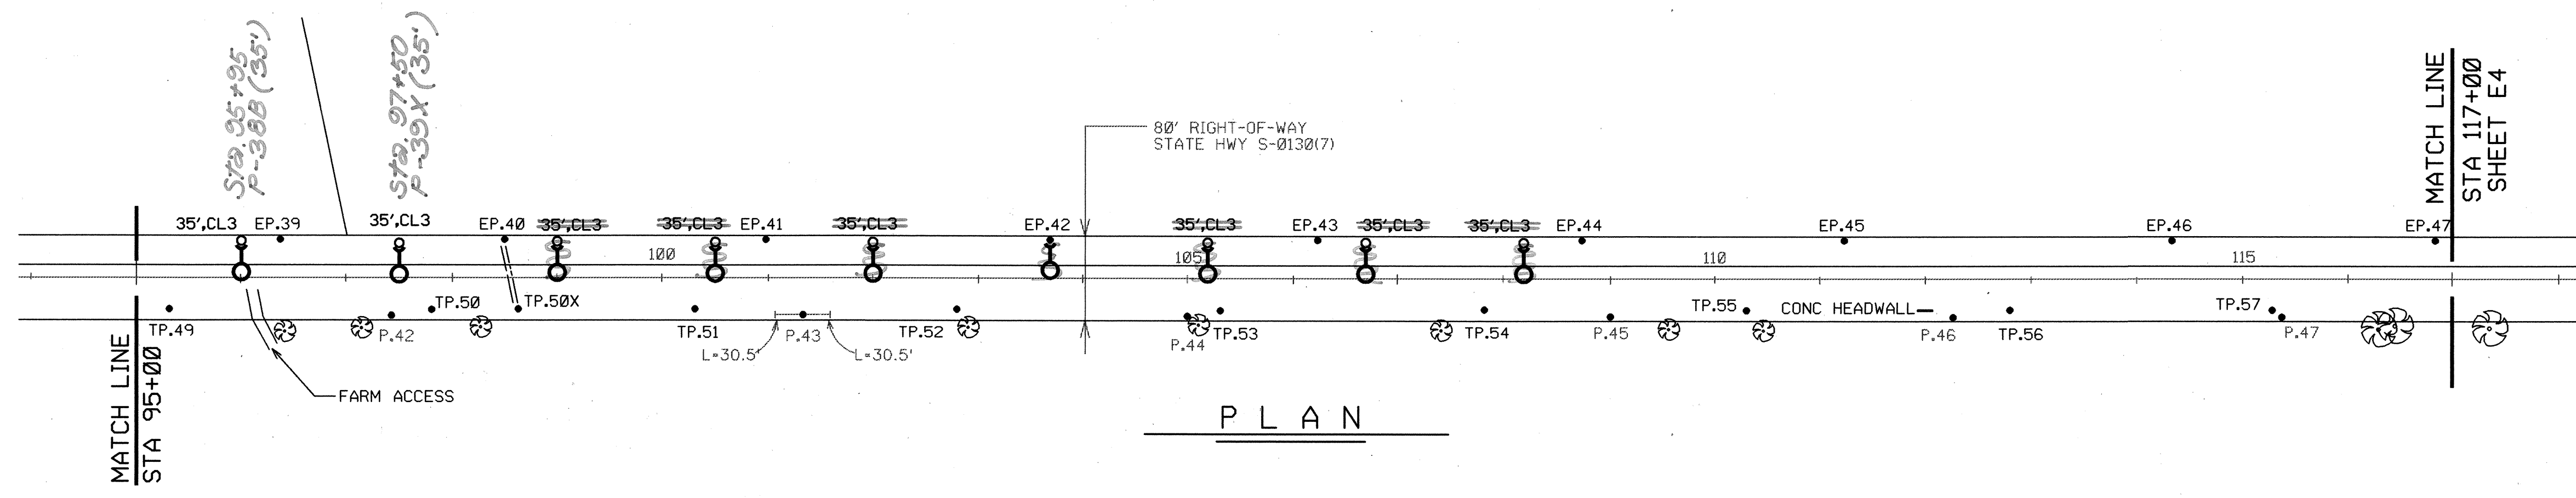

PLAN




THIS WORK WAS PREPARED BY ME
OR UNDER MY SUPERVISION.
[Signature]
MK ENGINEERS, LTD.

6/16/94	DELETED ONE-LINE DIAGRAMS & O/H CONDUCTORS
DATE	DESCRIPTION
STATE OF HAWAII DEPARTMENT OF TRANSPORTATION HIGHWAYS DIVISION	
SITE PLAN	
KEAAU-PAHOA ROAD HIGHWAY LIGHTING, BETWEEN HAWAII BELT ROAD AND PAHOA TOWN PROJECT NO. 130B-02-94	
SCALE: AS NOTED	DATE: JUNE 1994
SHEET No. E3 OF 11 SHEETS	


"AS-BUILT"

ADD 4


FED. ROAD DIST. NO.	STATE	PROJ. NO.	FISCAL YEAR	SHEET NO.	TOTAL SHEETS
HAWAII	HAW.	130B-02-94	1994	5	12

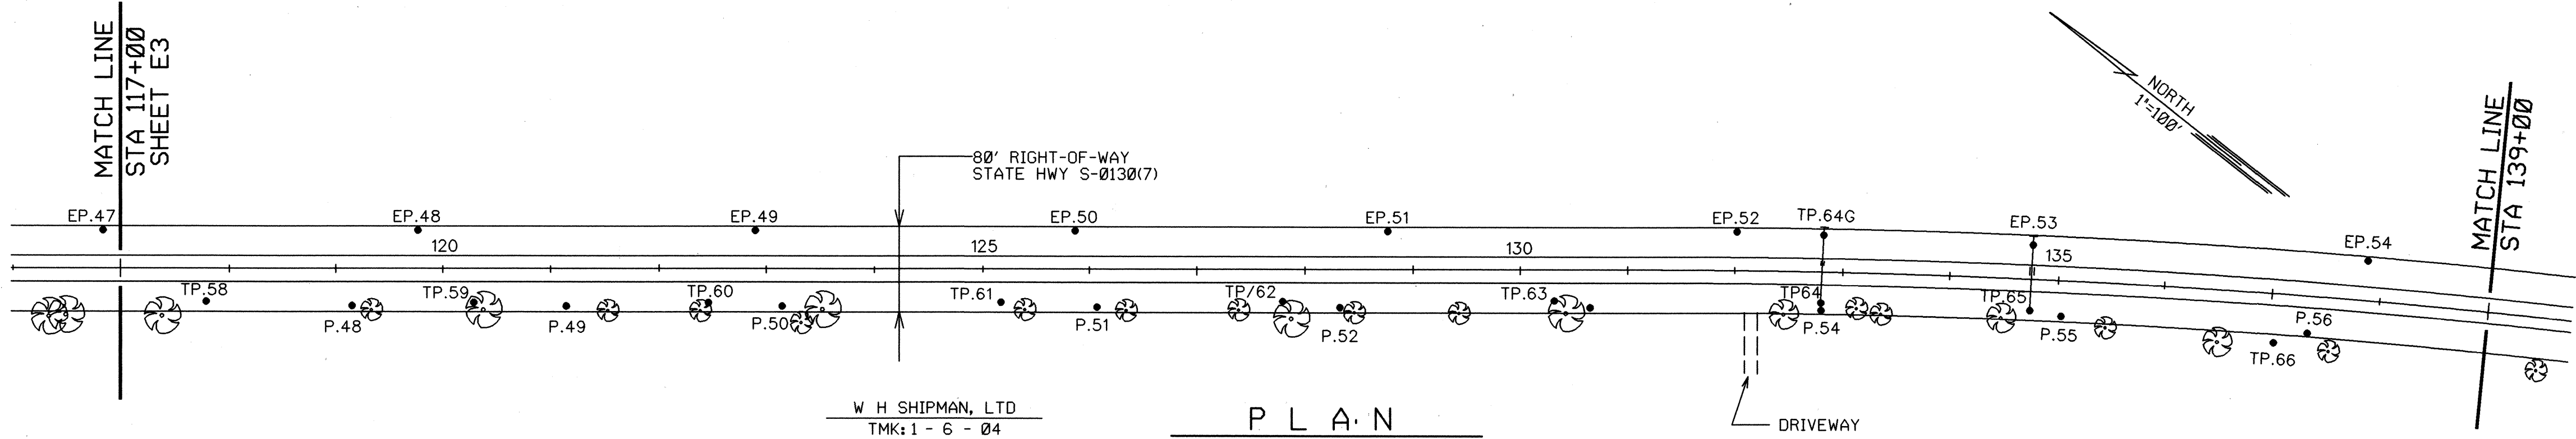

P L A N

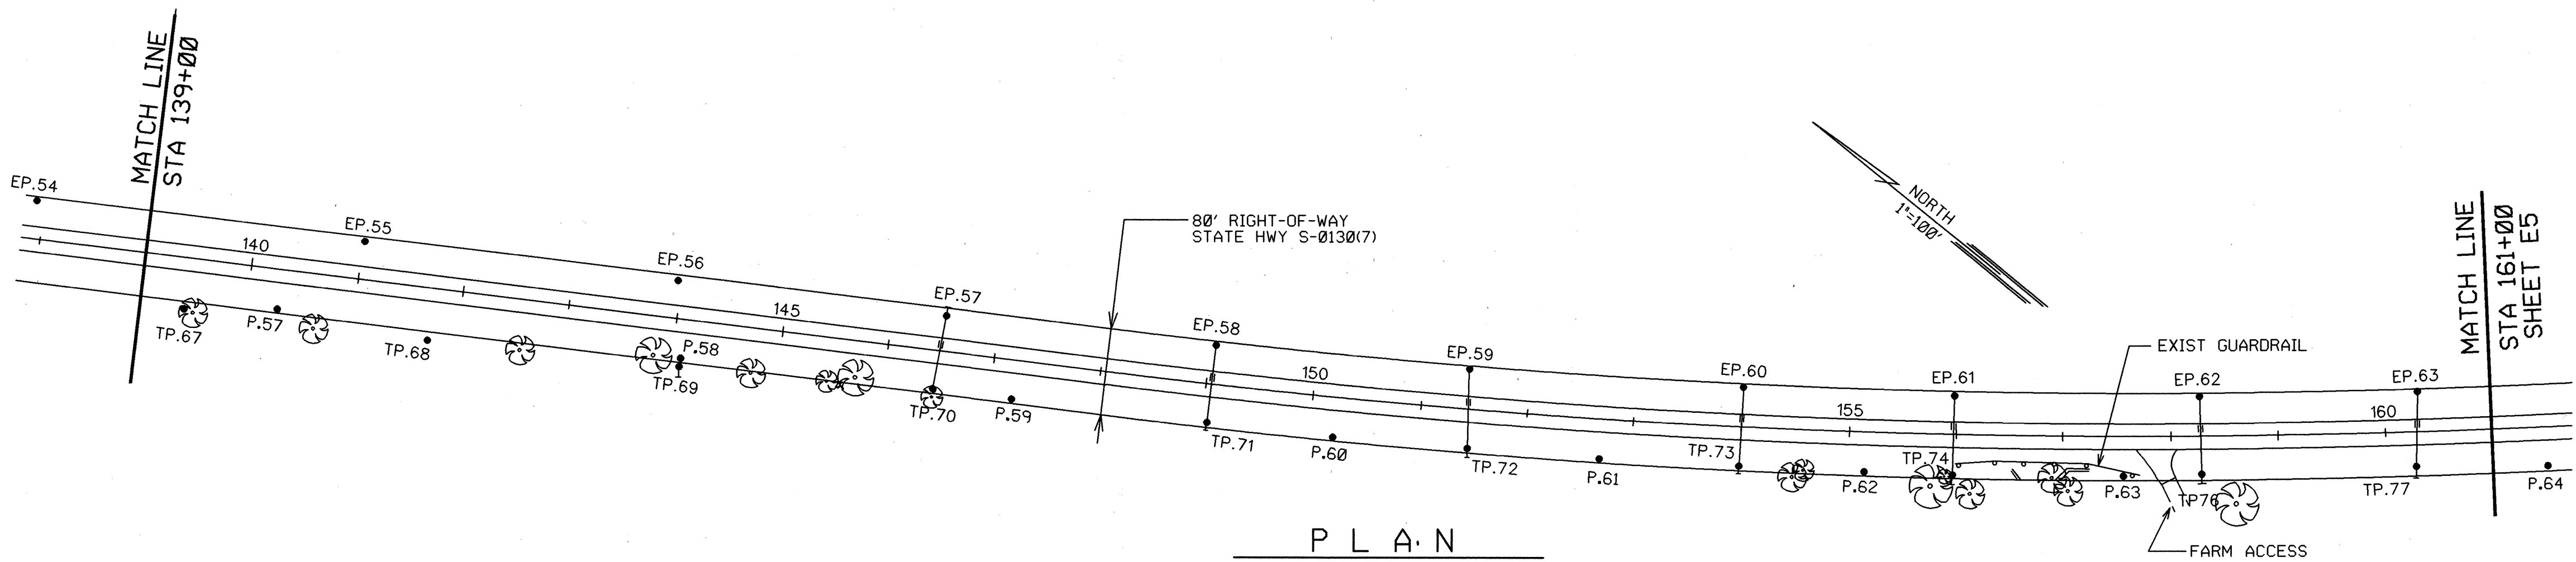

P L A N

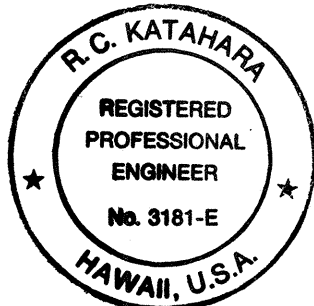

THIS WORK WAS PREPARED BY ME
OR UNDER MY SUPERVISION.
R.C. KATAHARA 5/19/94
MK ENGINEERS, LTD.



STATE OF HAWAII
DEPARTMENT OF TRANSPORTATION
HIGHWAYS DIVISION

SITE PLAN

KEAAU-PAHOA ROAD HIGHWAY LIGHTING,
BETWEEN HAWAII BELT ROAD AND PAHOA TOWN
PROJECT NO. 130B-02-94

SCALE: AS NOTED DATE: APRIL 1994
SHEET No. E4 OF 11 SHEETS

FED. ROAD DIST. NO.	STATE	PROJ. NO.	FISCAL YEAR	SHEET NO.	TOTAL SHEETS
HAWAII	HAW.	130B-02-94	1994	6	12

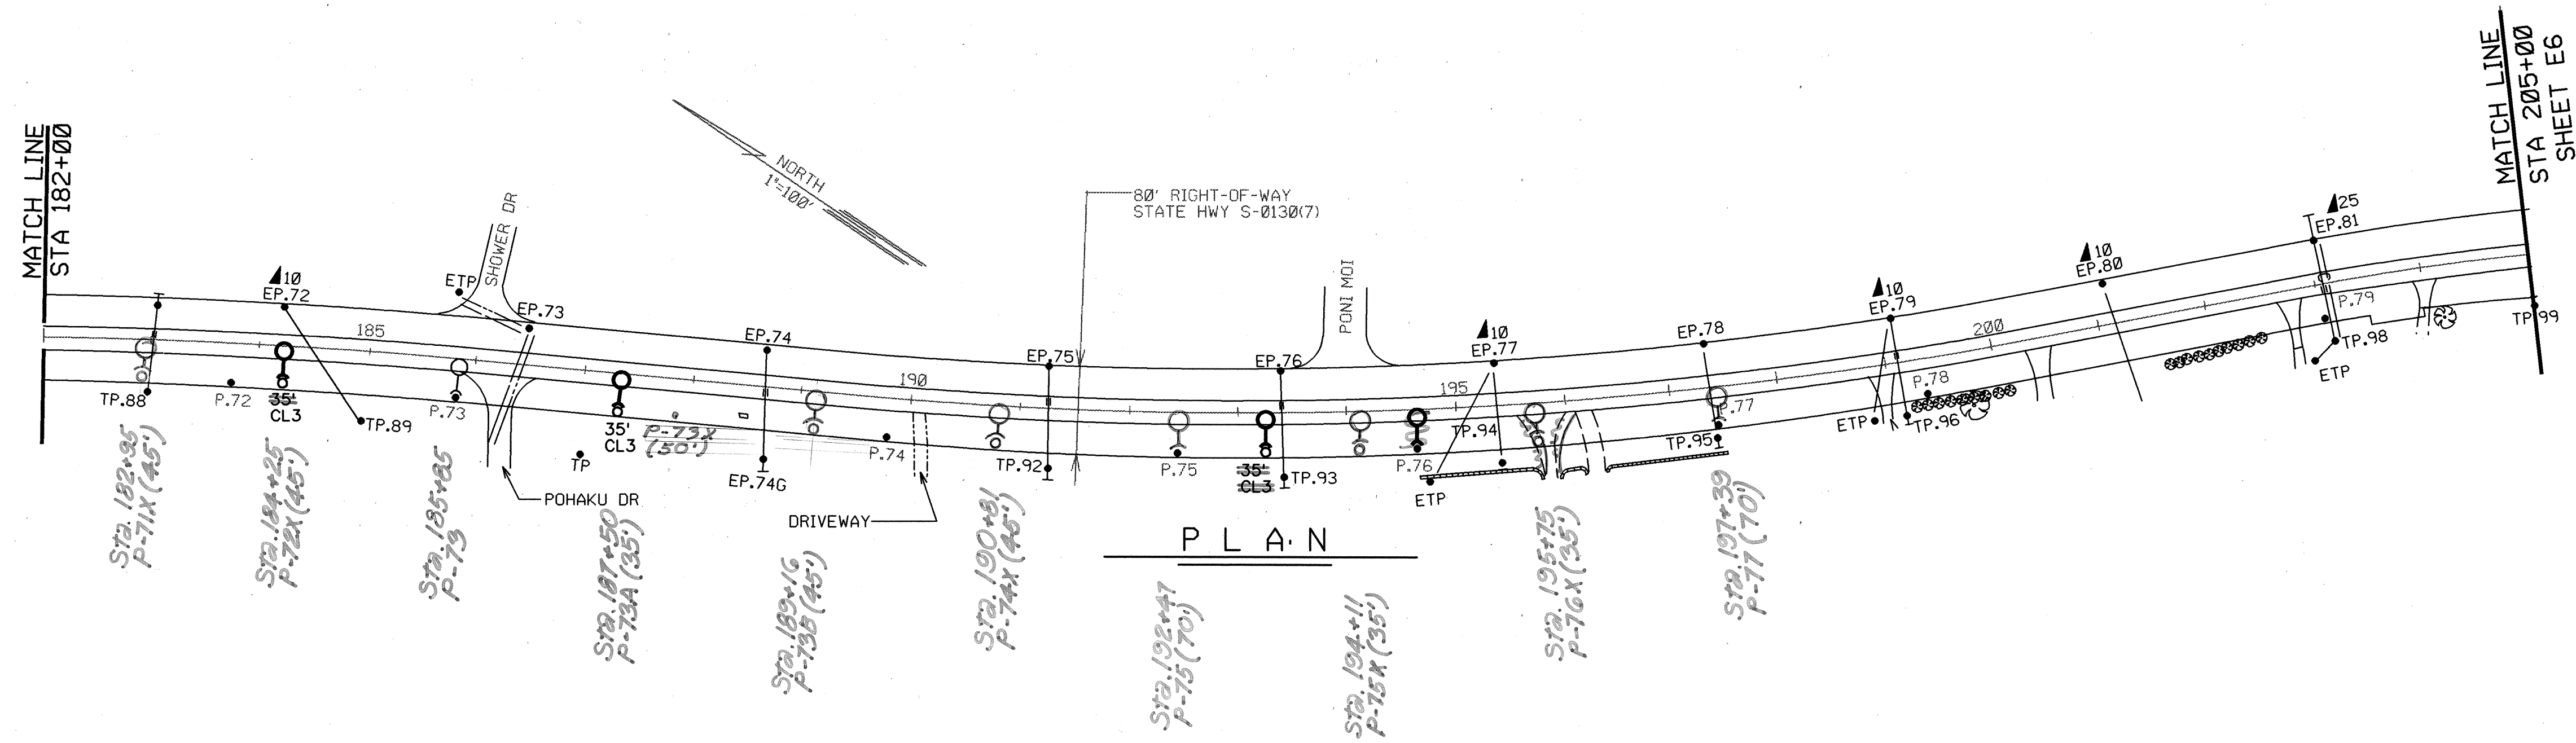
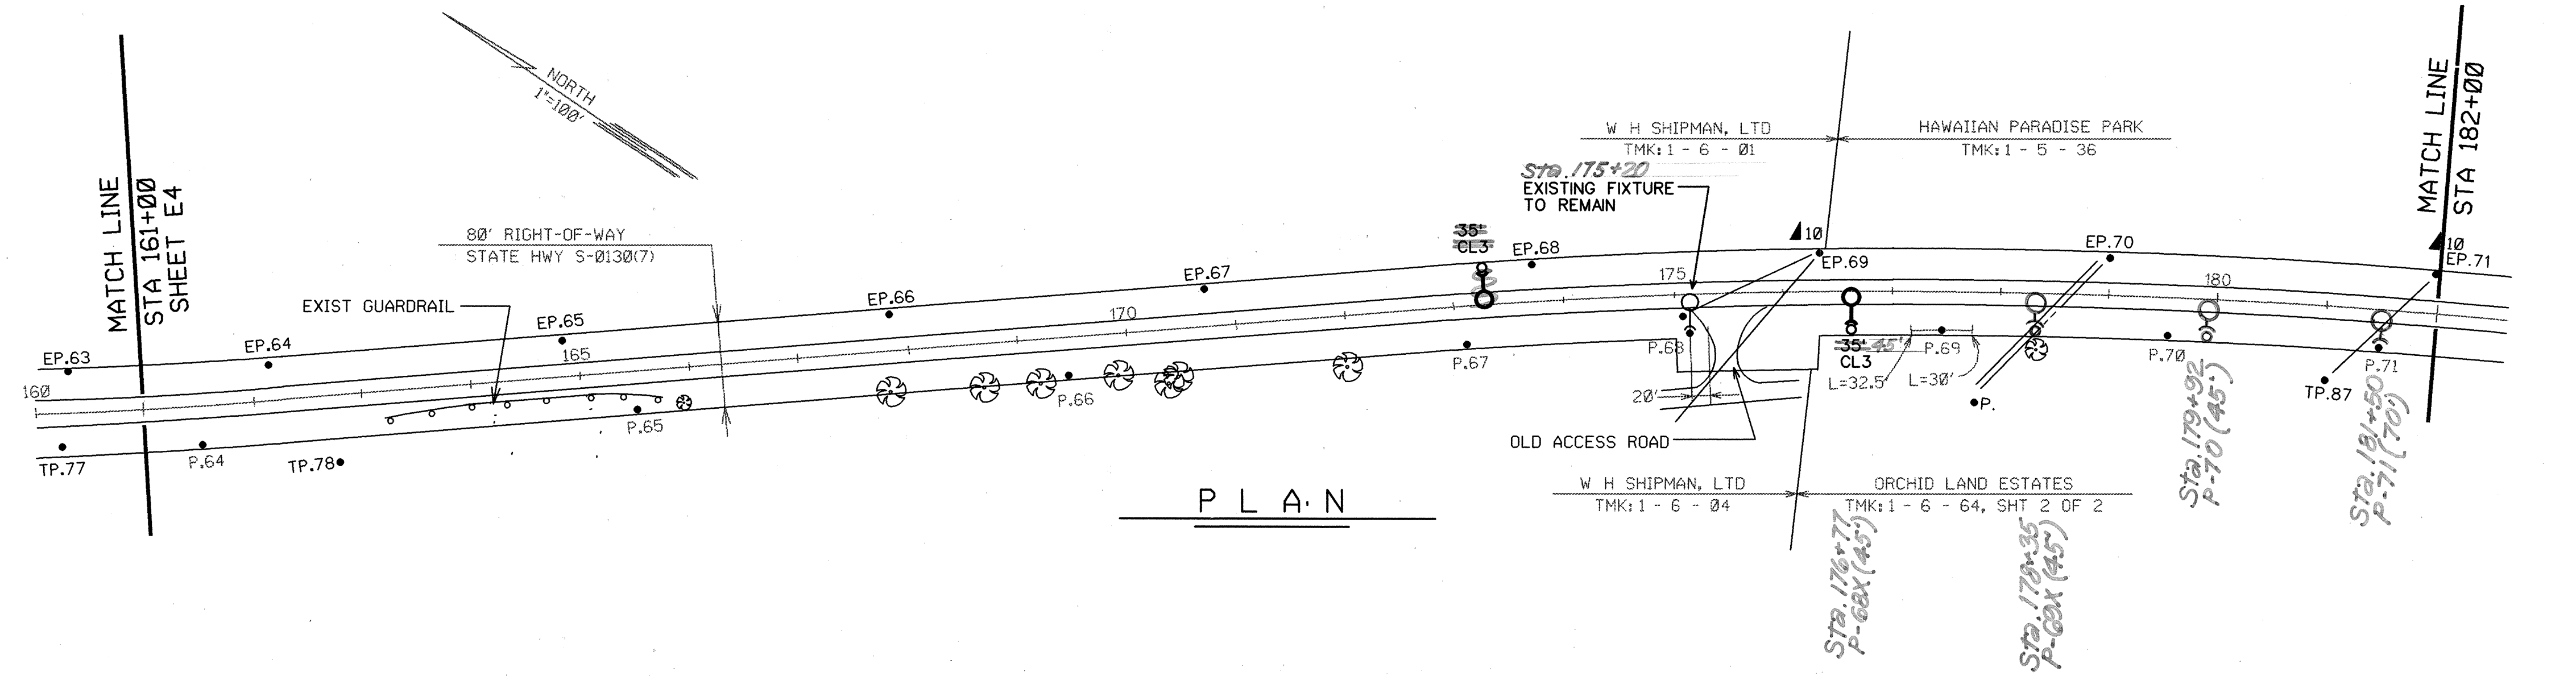


THIS WORK WAS PREPARED BY ME
OR UNDER MY SUPERVISION.
Ben K. Okano
MK ENGINEERS, LTD.

DATE	DESCRIPTION
6/16/94	DELETED ONE-LINE DIAGRAMS & O/H CONDUCTORS
DATE	DESCRIPTION
STATE OF HAWAII DEPARTMENT OF TRANSPORTATION HIGHWAYS DIVISION	
SITE PLAN	
KEAAU-PAHOA ROAD HIGHWAY LIGHTING, BETWEEN HAWAII BELT ROAD AND PAHOA TOWN PROJECT NO. 130B-02-94	
SCALE: AS NOTED	DATE: JUNE 1994
SHEET No. E5 OF 11 SHEETS	

"AS-BUILT"

FED. ROAD DIST. NO.	STATE	PROJ. NO.	FISCAL YEAR	SHEET NO.	TOTAL SHEETS
HAWAII	HAW.	130B-02-94	1994	7	12

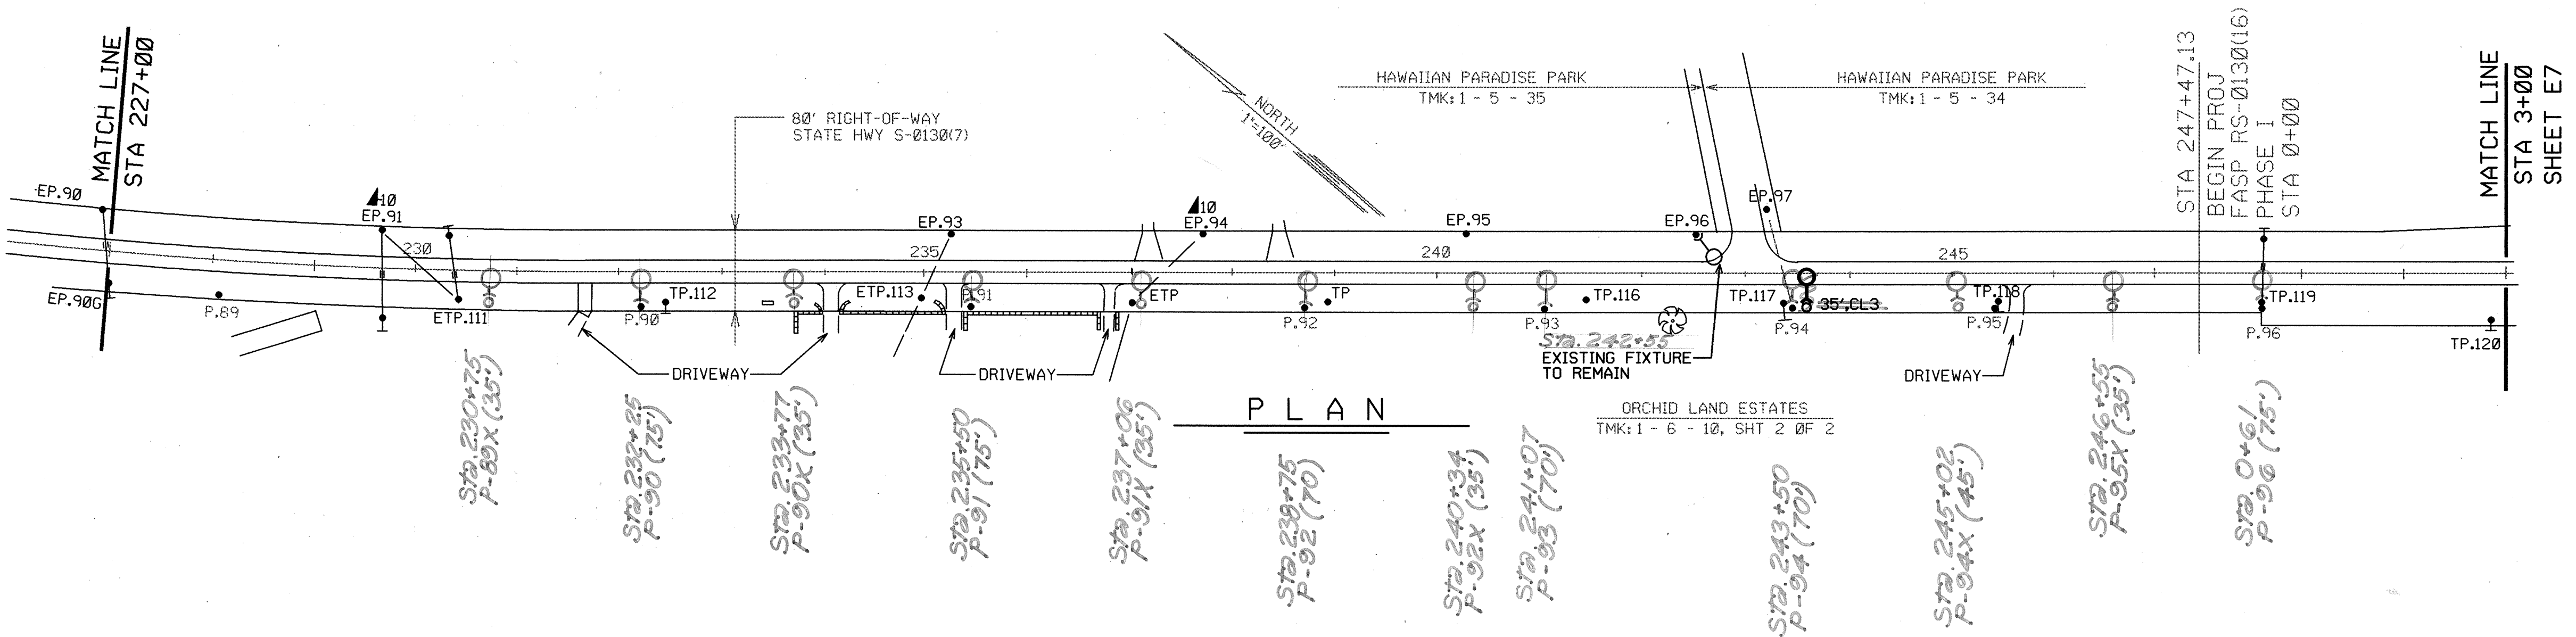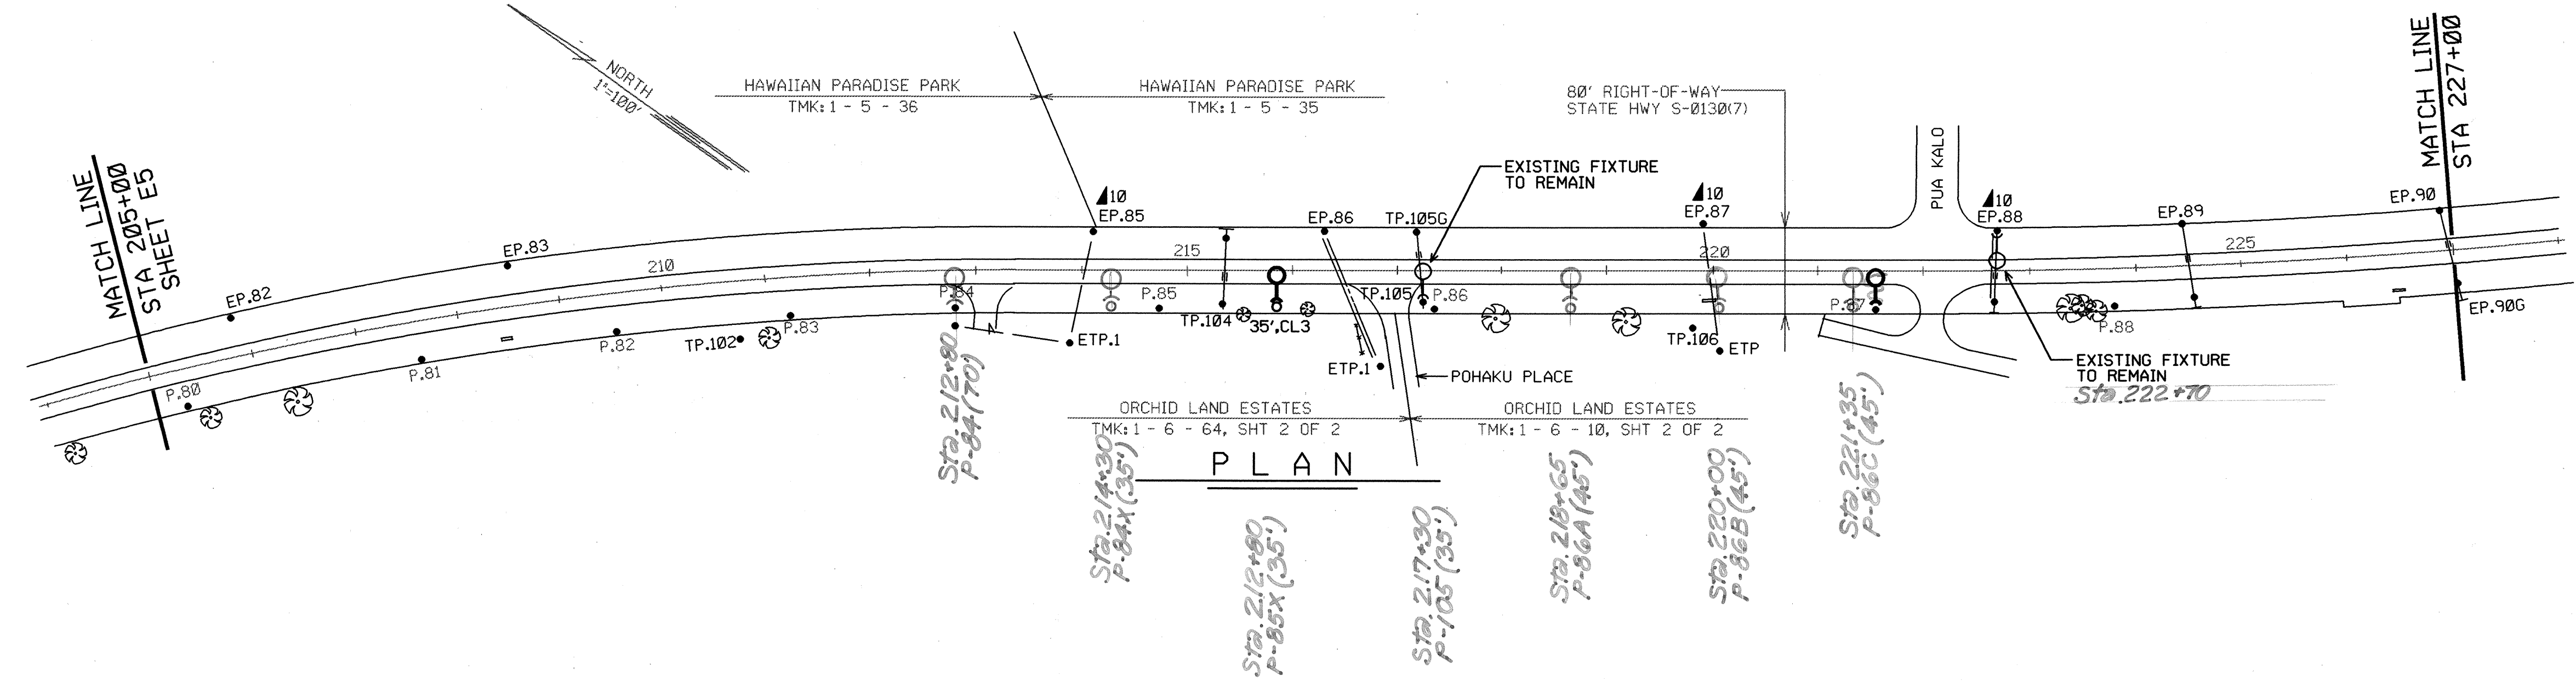



THIS WORK WAS PREPARED BY ME
OR UNDER MY SUPERVISION.
MK ENGINEERS, LTD.

6/16/94	DELETED ONE-LINE DIAGRAMS & O/H CONDUCTORS
DATE	DESCRIPTION
STATE OF HAWAII DEPARTMENT OF TRANSPORTATION HIGHWAYS DIVISION	
SITE PLAN	
KEAAU-PAHOA ROAD HIGHWAY LIGHTING, BETWEEN HAWAII BELT ROAD AND PAHOA TOWN PROJECT NO. 130B-02-94	
SCALE: AS NOTED	DATE: JUNE 1994
SHEET No. E6 OF 11 SHEETS	

"AS-BUILT"

ADD 7

FED. ROAD DIST. NO.	STATE	PROJ. NO.	FISCAL YEAR	SHEET NO.	TOTAL SHEETS
HAWAII	HAW.	130B-02-94	1994	8	12

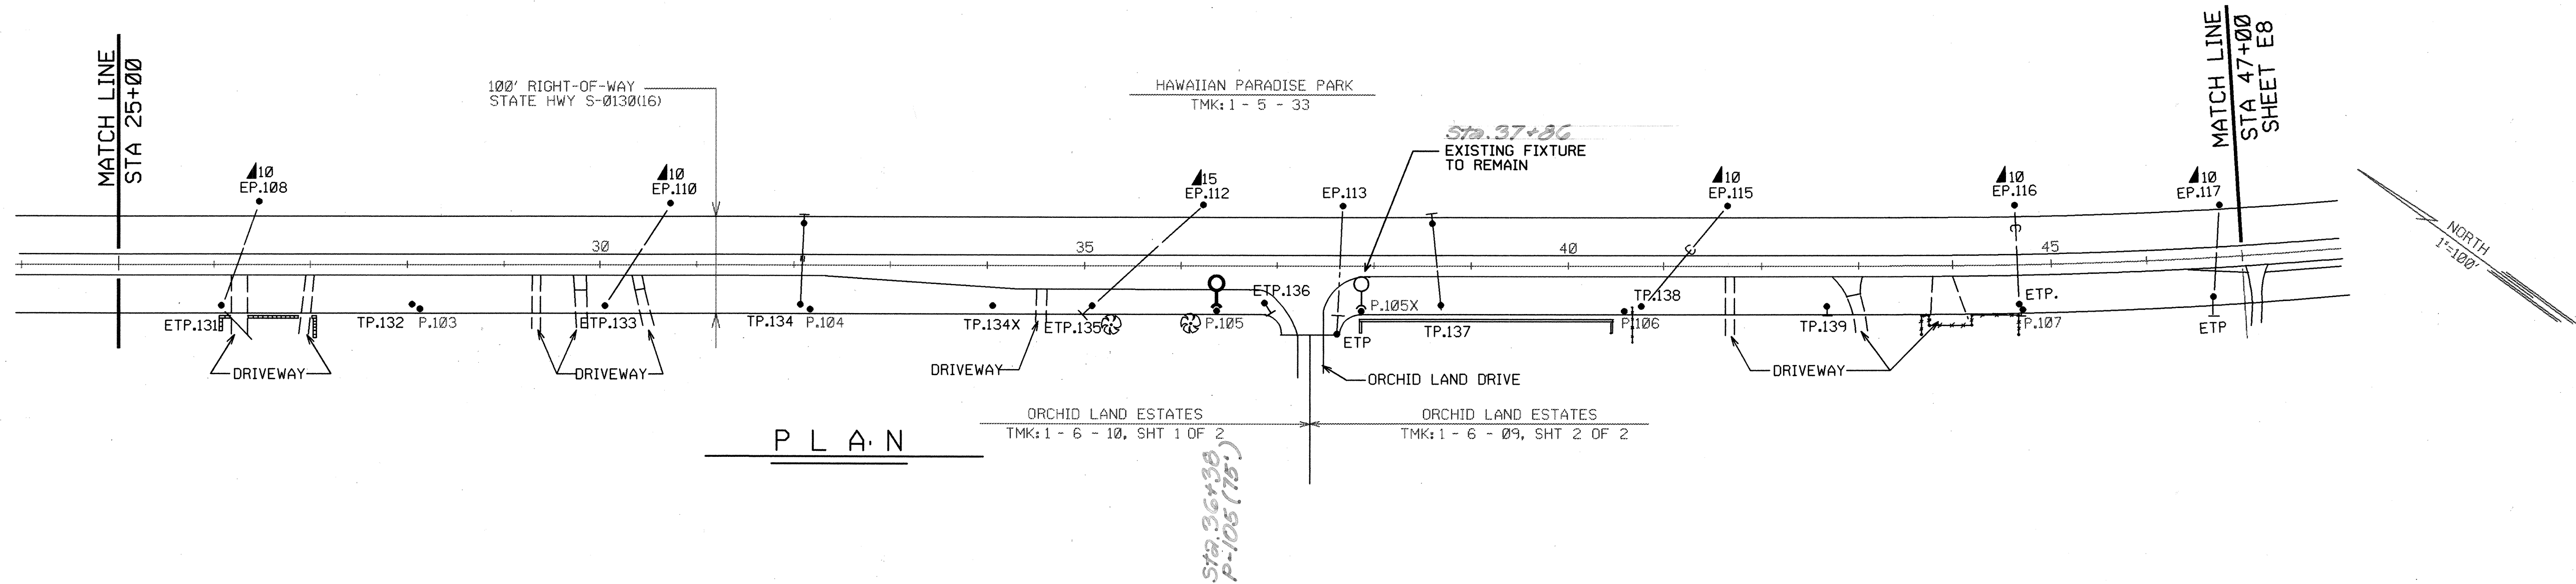
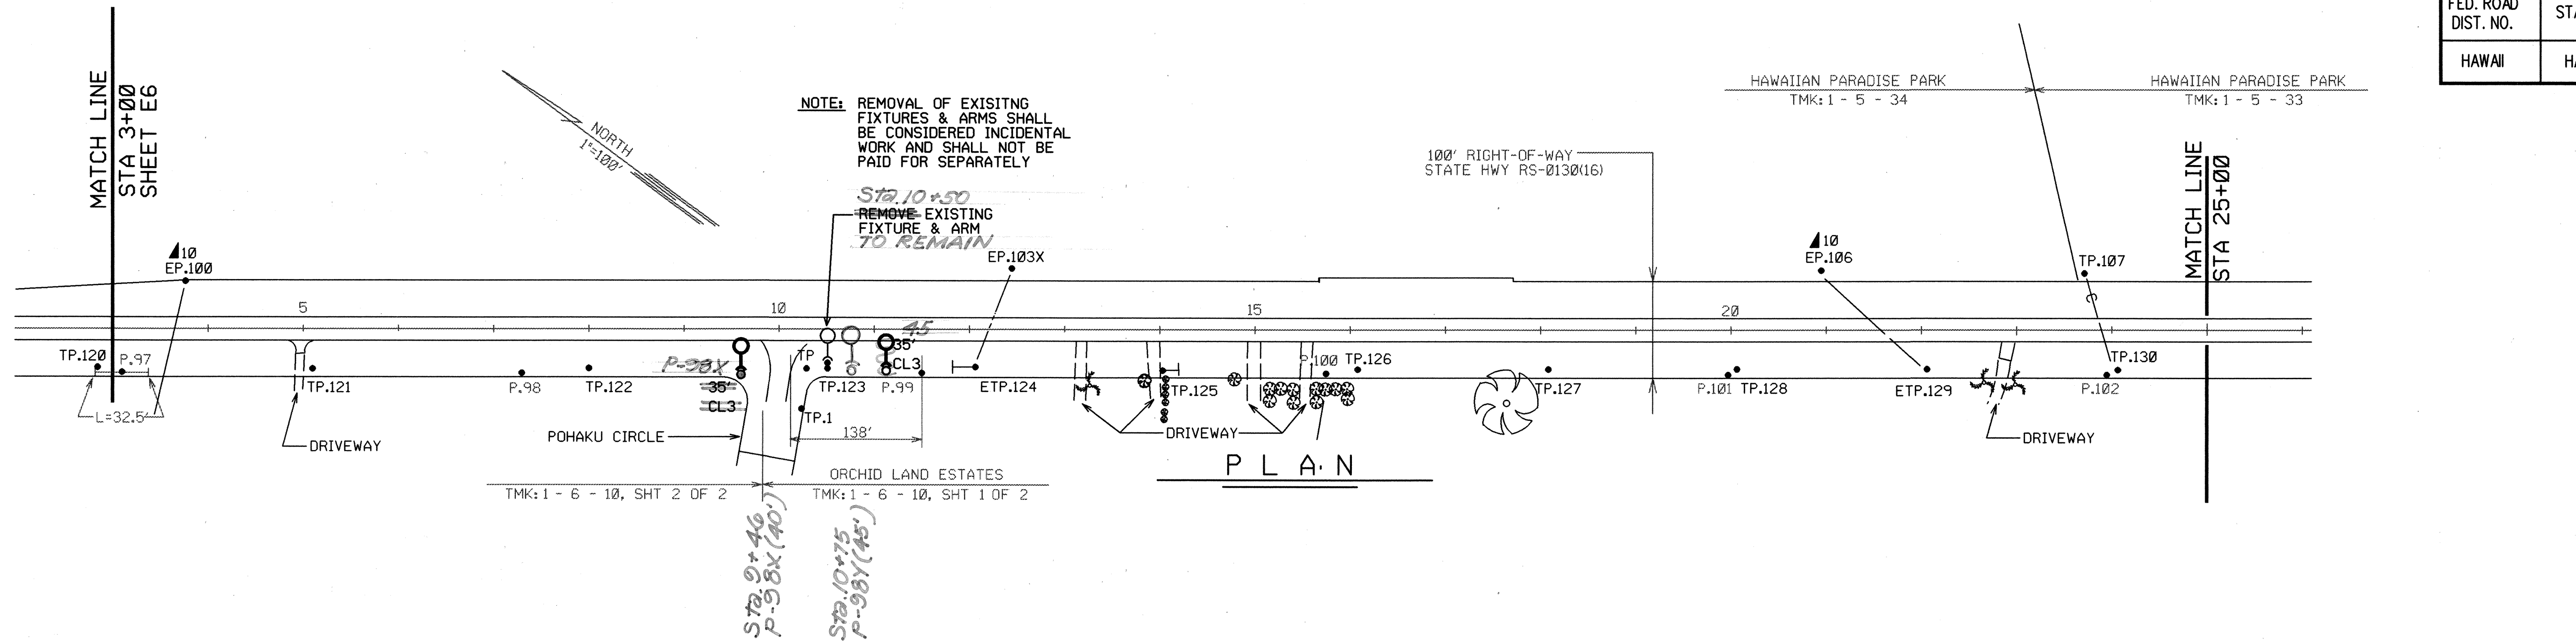


THIS WORK WAS PREPARED BY ME
OR UNDER MY SUPERVISION.
Ben K. Okano
MK ENGINEERS, LTD.

6/16/94	DELETED ONE-LINE DIAGRAMS & O/H CONDUCTORS
DATE	DESCRIPTION
STATE OF HAWAII DEPARTMENT OF TRANSPORTATION HIGHWAYS DIVISION SITE PLAN KEAAU-PAHOA ROAD HIGHWAY LIGHTING, BETWEEN HAWAII BELT ROAD AND PAHOA TOWN PROJECT NO. 130B-02-94	
SCALE: AS NOTED	DATE: JUNE 1994
SHEET No. E7 OF 11 SHEETS	

"AS-BUILT"

FED. ROAD DIST. NO.	STATE	PROJ. NO.	FISCAL YEAR	SHEET NO.	TOTAL SHEETS
HAWAII	HAW.	130B-02-94	1994	9	12


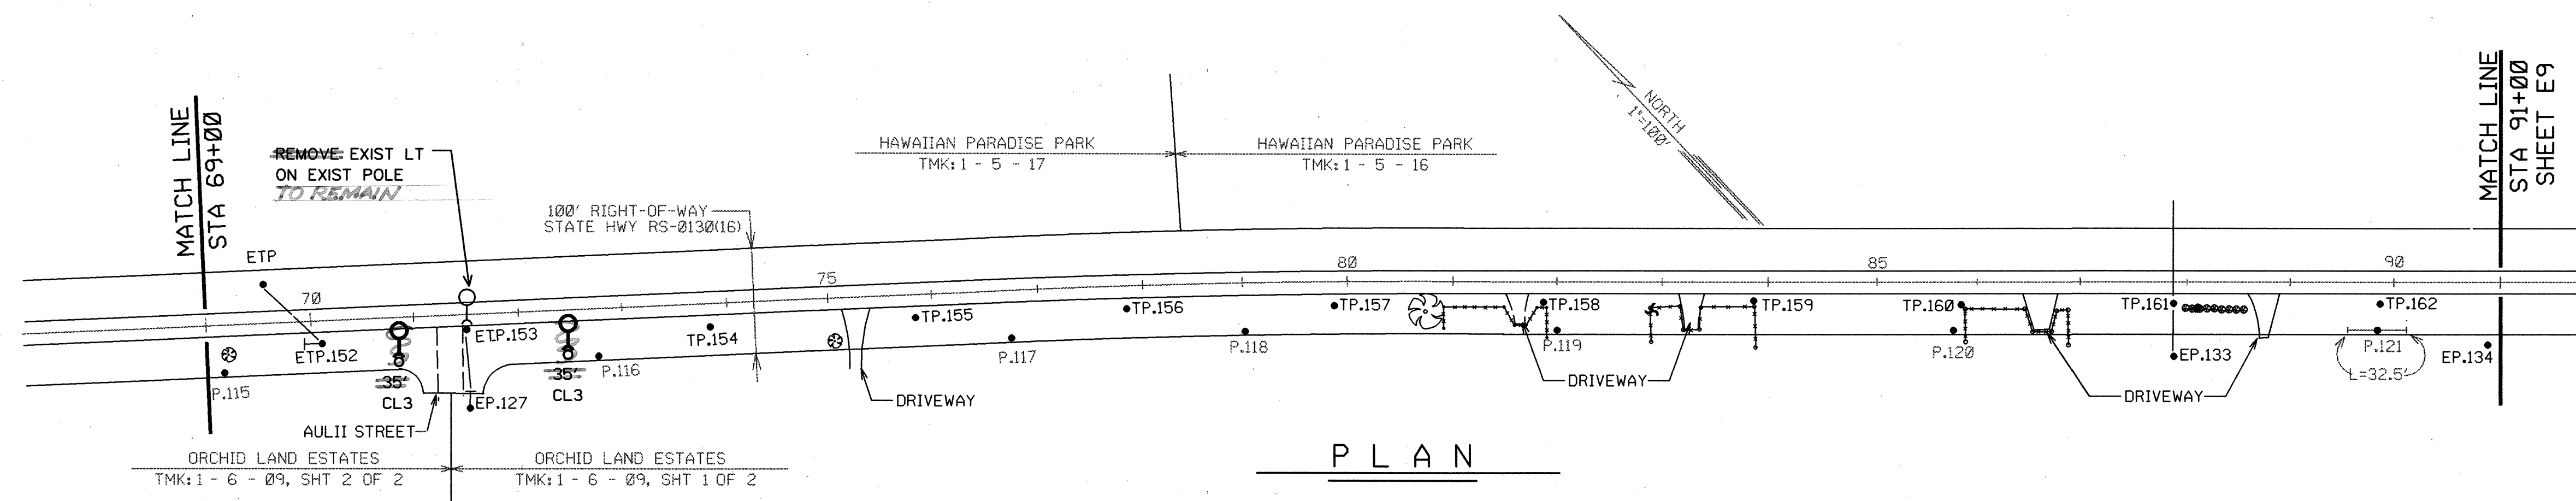
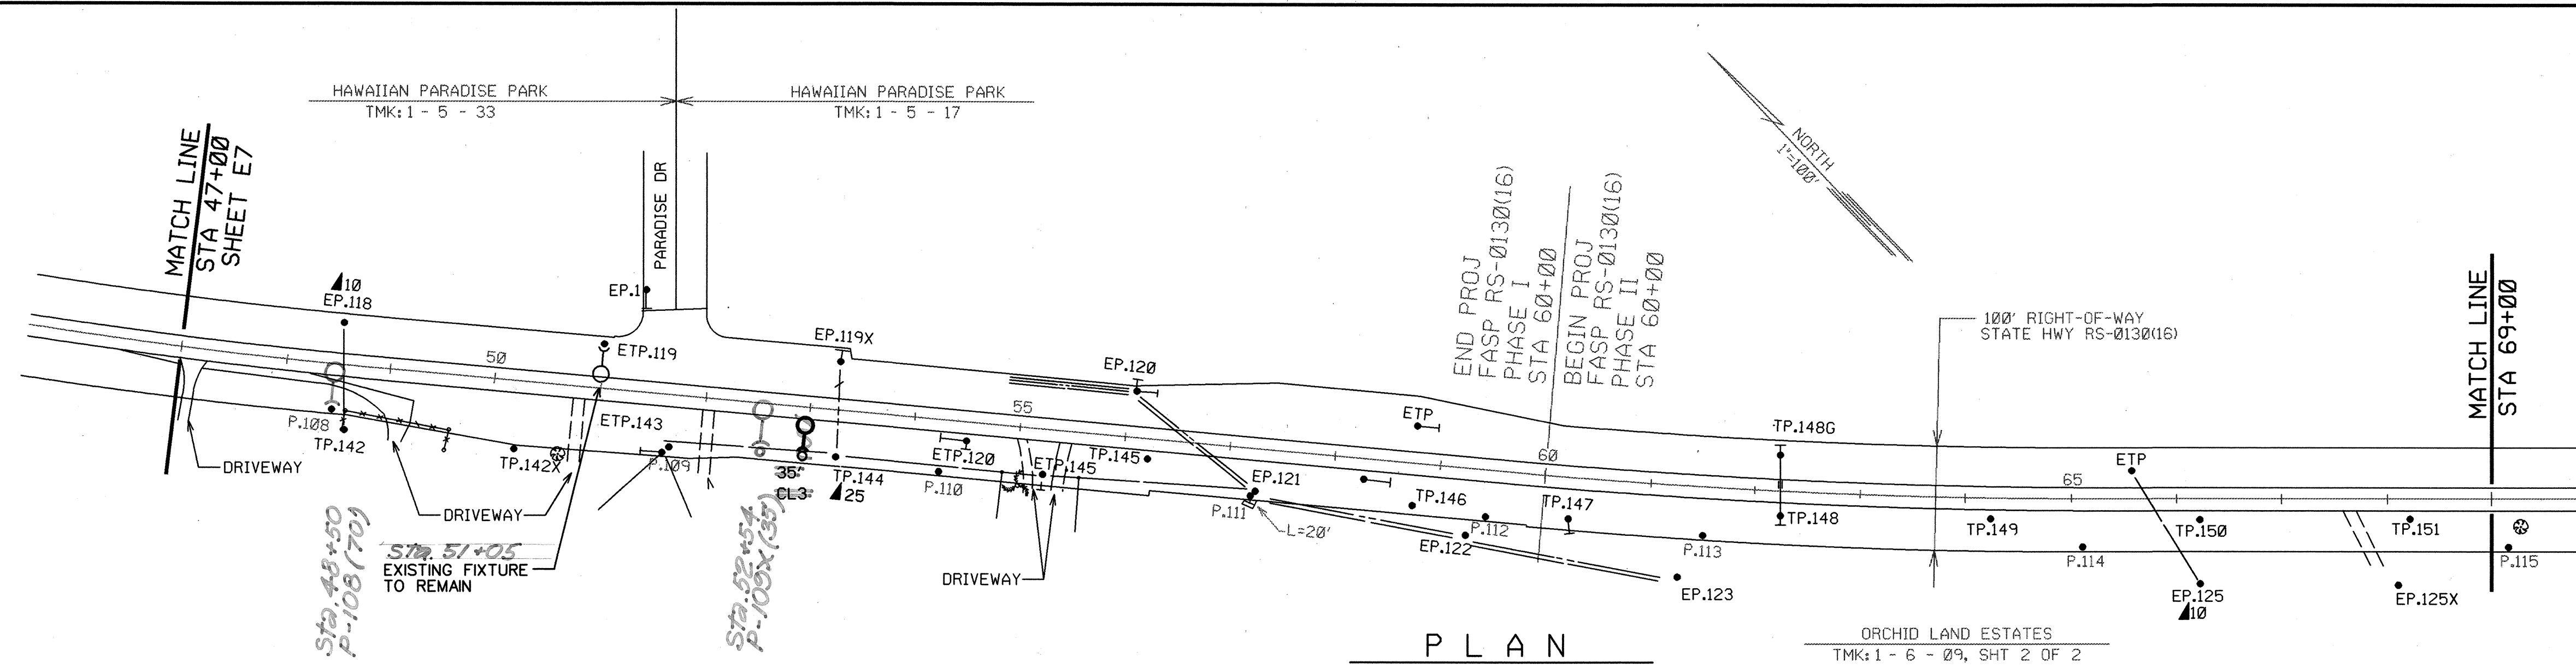


THIS WORK WAS PREPARED BY ME
OR UNDER MY SUPERVISION.
Ben K. Okano
MK ENGINEERS, LTD.

6/16/94	DELETED ONE-LINE DIAGRAMS & O/H CONDUCTORS
DATE	DESCRIPTION
STATE OF HAWAII DEPARTMENT OF TRANSPORTATION HIGHWAYS DIVISION <u>SITE PLAN</u> KEAAU-PAHOA ROAD HIGHWAY LIGHTING, BETWEEN HAWAII BELT ROAD AND PAHOA TOWN PROJECT NO. 130B-02-94	
SCALE: AS NOTED	DATE: JUNE 1994
SHEET No. E8 OF 11 SHEETS	

"AS-BUILT"

FED. ROAD DIST. NO.	STATE	PROJ. NO.	FISCAL YEAR	SHEET NO.	TOTAL SHEETS
HAWAII	HAW.	130B-02-94	1994	10	12

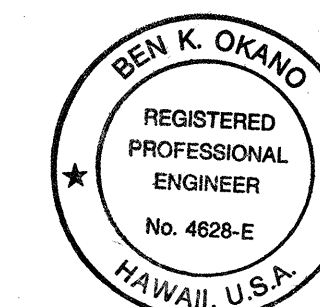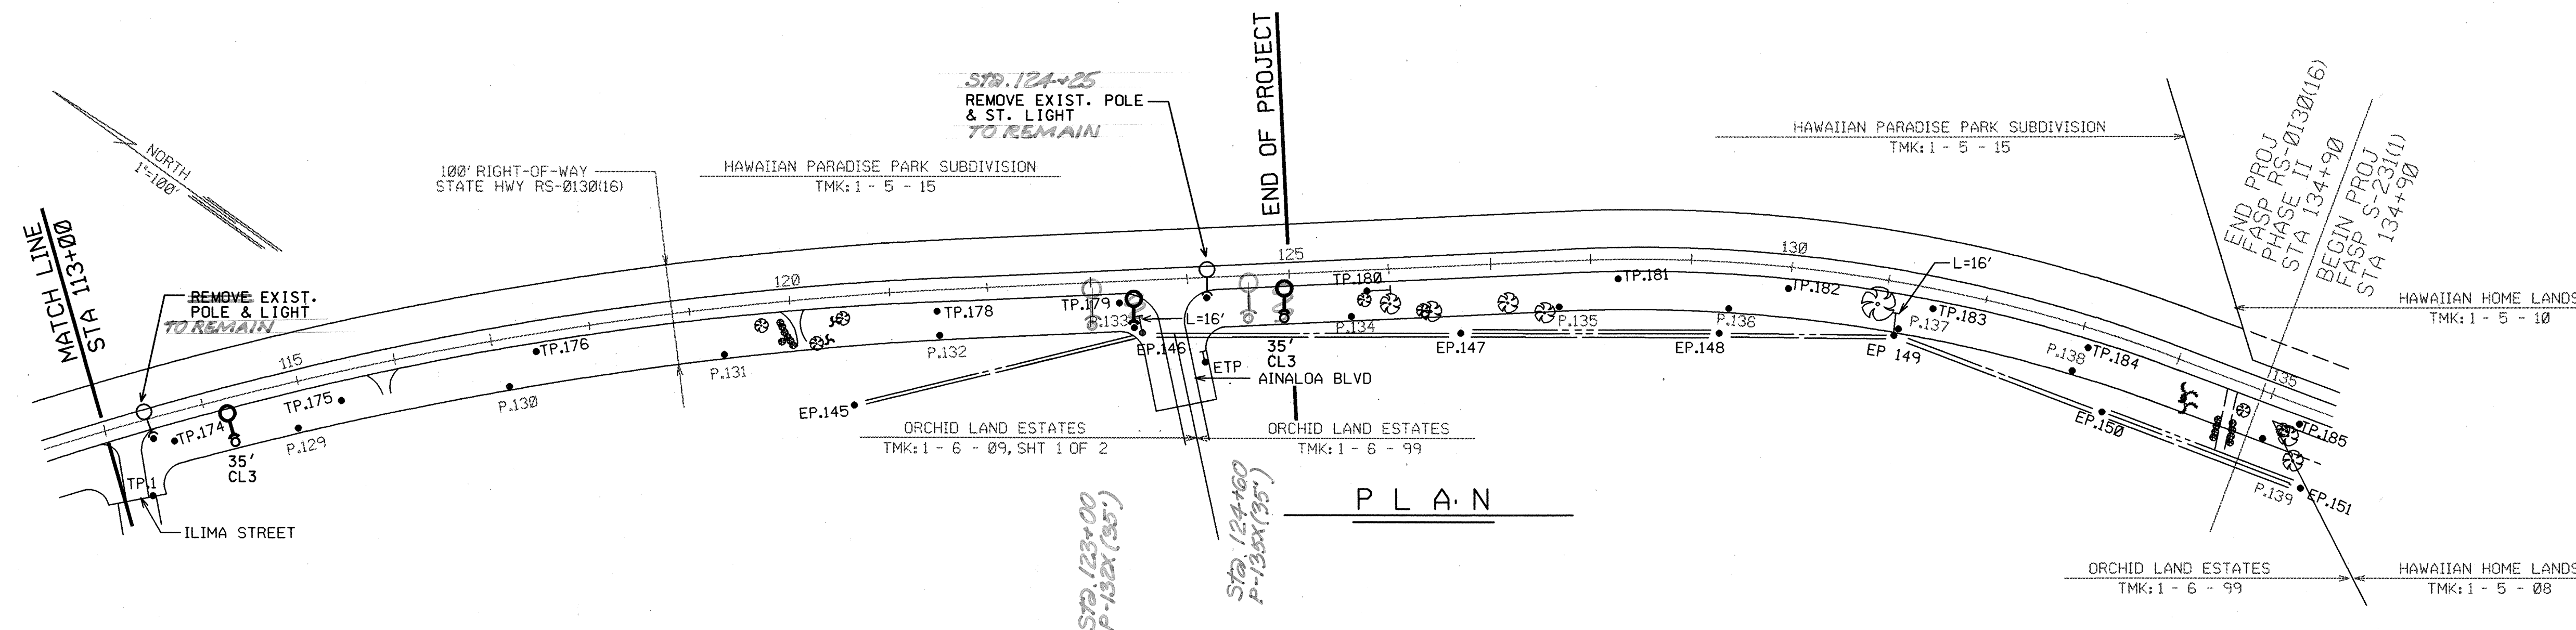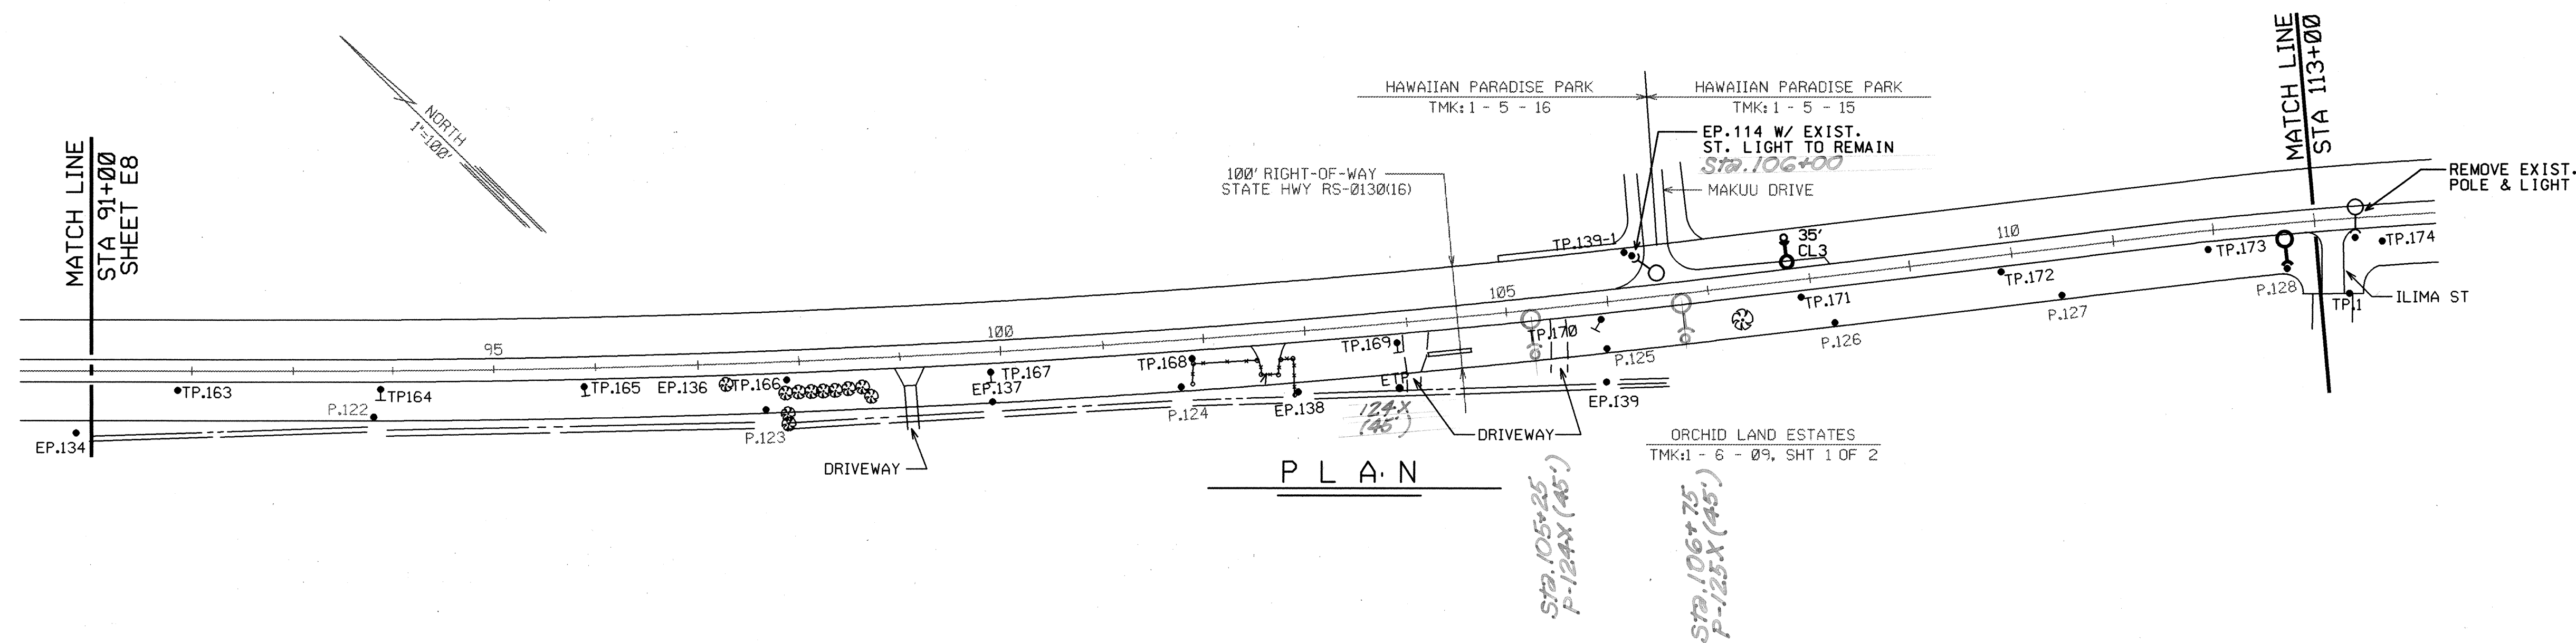

THIS WORK WAS PREPARED BY ME
OR UNDER MY SUPERVISION.
[Signature]
MK ENGINEERS, LTD.

DATE	DESCRIPTION
6/16/94	DELETED ONE-LINE DIAGRAMS & O/H CONDUCTORS
STATE OF HAWAII DEPARTMENT OF TRANSPORTATION HIGHWAYS DIVISION SITE PLAN KEAAU-PAHOA ROAD HIGHWAY LIGHTING, BETWEEN HAWAII BELT ROAD AND PAHOA TOWN PROJECT NO. 130B-02-94 SCALE: AS NOTED DATE: JUNE 1994 SHEET No. E9 OF 11 SHEETS	

"AS-BUILT"

ADD 10