


INDEX TO DRAWINGS	
SHEET NO.	DESCRIPTION
1	TITLE SHEET
2	KEY MAP
3	STANDARD PLAN SUMMARY
4-5	GEN. NOTES & LEGEND, NPDES, & GRADING NOTES
6-13	TYPICAL SECTIONS & DETAILS
14-18	TREE REMOVAL BYPASS ROAD
19-21	ROUTE 11 DEMOLITION PLAN
22-25	ROUTE 11 PAVEMENT WIDENING PLAN
26	ROUTE 11 SUPERELEVATION DIAGRAM
27	ROUTE 11 INTERSECTION PAVEMENT GRADE PLAN
28-30	RAMP PLAN/PRO., SUP'ELEV. DIAG., PAV'T GRADE PLAN
31-38	BYPASS ROAD PLAN & PRO., SUPERELEV. DIAGRAM
39-40	ROAD "C" PLAN & PROFILE, PAV'T. GRADE PLAN
41-48	MILO ST. CONSTRUCTION PLANS
49-51	ROAD "D" CONSTRUCTION PLANS
52-54	VICINITY OF ROAD "E" CONSTRUCTION PLANS
55-60	DRAINAGE SUMMARY
61-73	RTE. 11 DRAINAGE & WALL PLANS, SECT. & DETAILS
74	COUNTY OF HAWAII R-40 DRYWELL DETAILS
75	TYPE A-9B GRATED DROP INLET DETAILS
76-79	LONGITUDINAL SECTIONS OF CULVERTS
80	RIPRAP & GRP APRON DETAILS
81	TYPE 61614 DRYWELL DETAILS
82	BERM AT 8 1/2 MILE CAMP
83-86	GUARDRAIL SCHEDULE & DETAILS
87	PAVEMENT MARKINGS LEGENDS & NOTES
88-91	ROUTE 11 SIGNING & STRIPING
92	RAMP SIGNING & STRIPING
93-98	BYPASS ROAD SIGNING & STRIPING
99	ROAD "C" & MILO ST. SIGNING & STRIPING
100	ROAD "D" SIGNING & STRIPING
101	VICINITY OF ROAD "E" SIGNING & STRIPING
102	ADJACENT ROADWAY IMPROVEMENTS KEY SHEET
103-111	TEMPORARY SIGN/STRIPING REMOVAL SHEETS
112-114	KEA'AU KULA RD. SIGNING/STRIPING & MISC. DETAILS
115	EXIST. RTE. 130 SIGN/STRIPING & MISC. DETAILS
116	ROAD "B" SIGNING & STRIPING
117-118	ROAD "A" STRIPING PLAN
119-123	SIGN DETAILS AND NOTES
124-126	SIGN SCHEDULE
127-129	REFLECTOR & OBJECT MARKER SCHEDULE
130-131	MISCELLANEOUS SCHEDULE
132-142	DETOUR TRAFFIC CONT'L & CONSTRUCTION SIGN PLAN
143	CONSTRUCTION SIGN PLAN SCHEDULE
144-154	I.B.L. 11 & O.B.L. 11. CROSS SECTIONS
155	RAMP CROSS SECTIONS
156-169	BYPASS ROAD CROSS SECTIONS
170	ROAD "C" CROSS SECTIONS
171	MILO STREET CROSS SECTIONS
172-173	ROAD "D" CROSS SECTIONS
174	ROAD "E" CROSS SECTIONS
175-176	RTE. 11 I.B.L. STA. 1080+00 TO 1081+50 CROSS SECTIONS
* 177-189	PEDESTRIAN OVERPASS PLANS
190-210	ELECTRICAL PLANS

STATE OF HAWAII
DEPARTMENT OF TRANSPORTATION
HIGHWAYS DIVISION
HONOLULU, HAWAII

PLANS FOR
KEA'AU - PĀHOA ROAD
KEA'AU TOWN SECTION (KEA'AU BYPASS ROAD), PH. 2
PROJECT NO. 130B-01-98

DISTRICT OF PUNA
ISLAND OF HAWAII



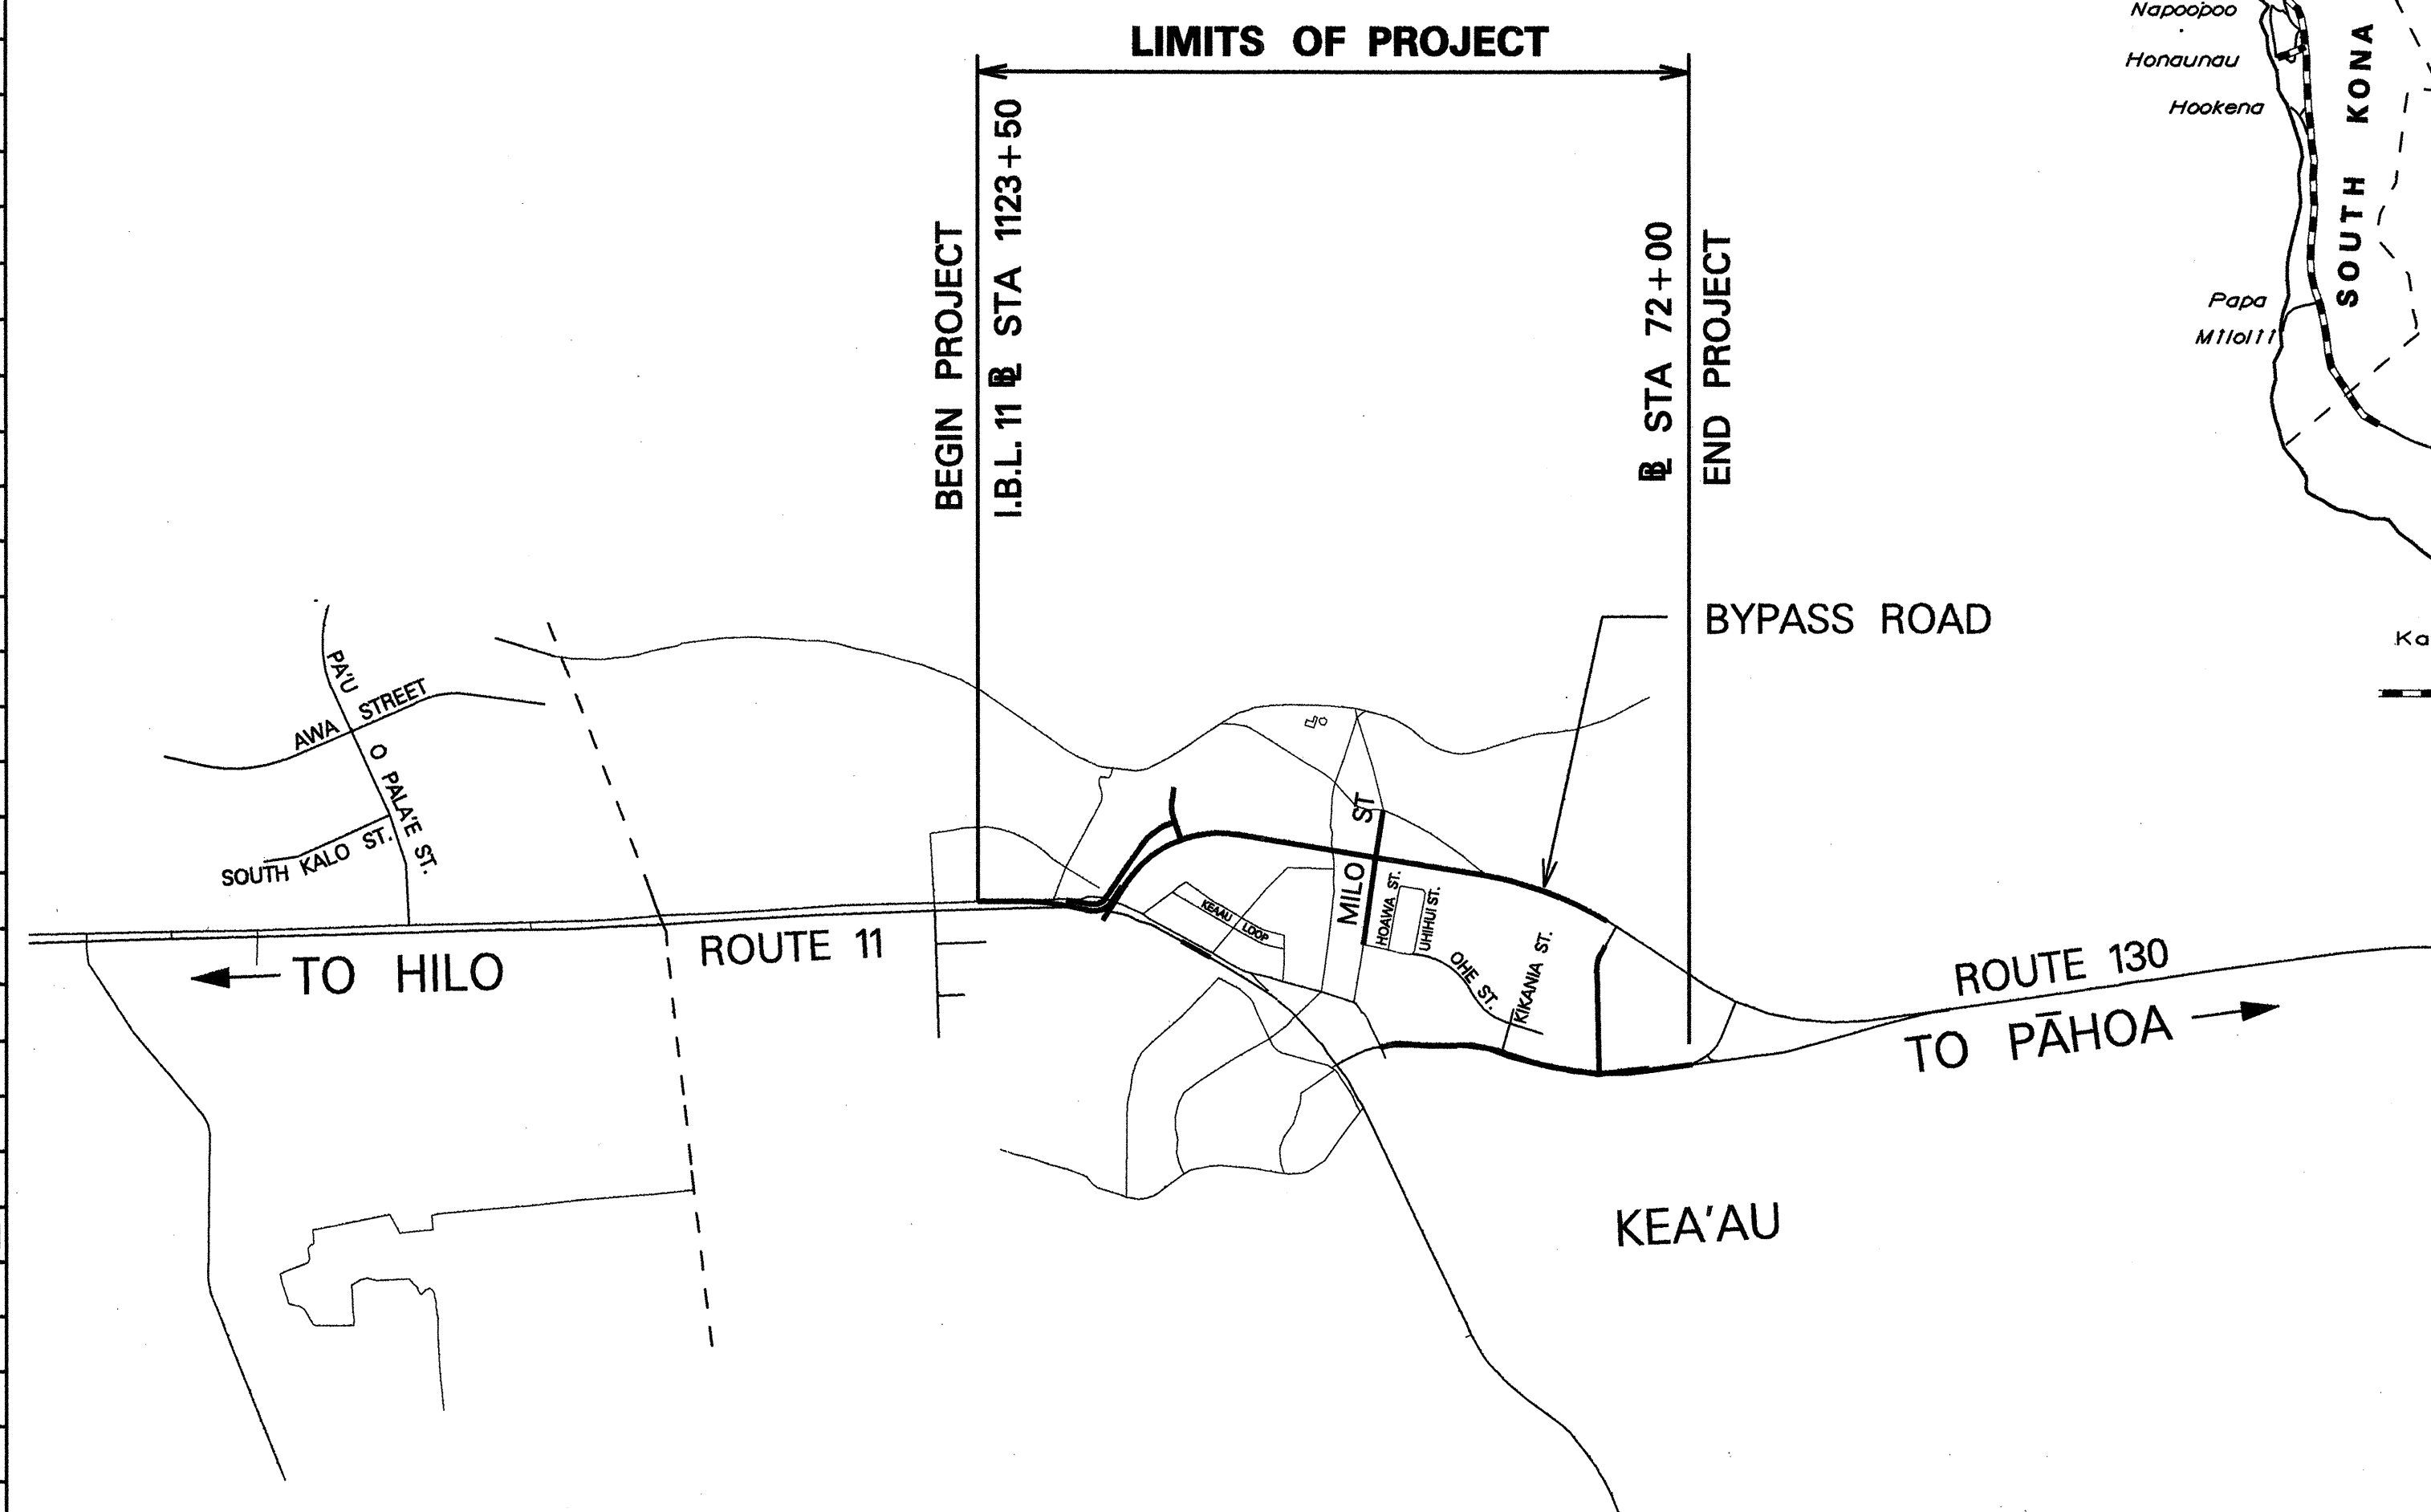


*NOT IN CONTRACT

LAYOUT PLAN

NET LENGTH OF PROJECT.....2.3 MILES

FED. ROAD DIST. NO.	STATE	PROJ. NO.	FISCAL YEAR	SHEET NO.	TOTAL SHEETS
HAWAII	HAW.	130B-01-98	1999	1	210

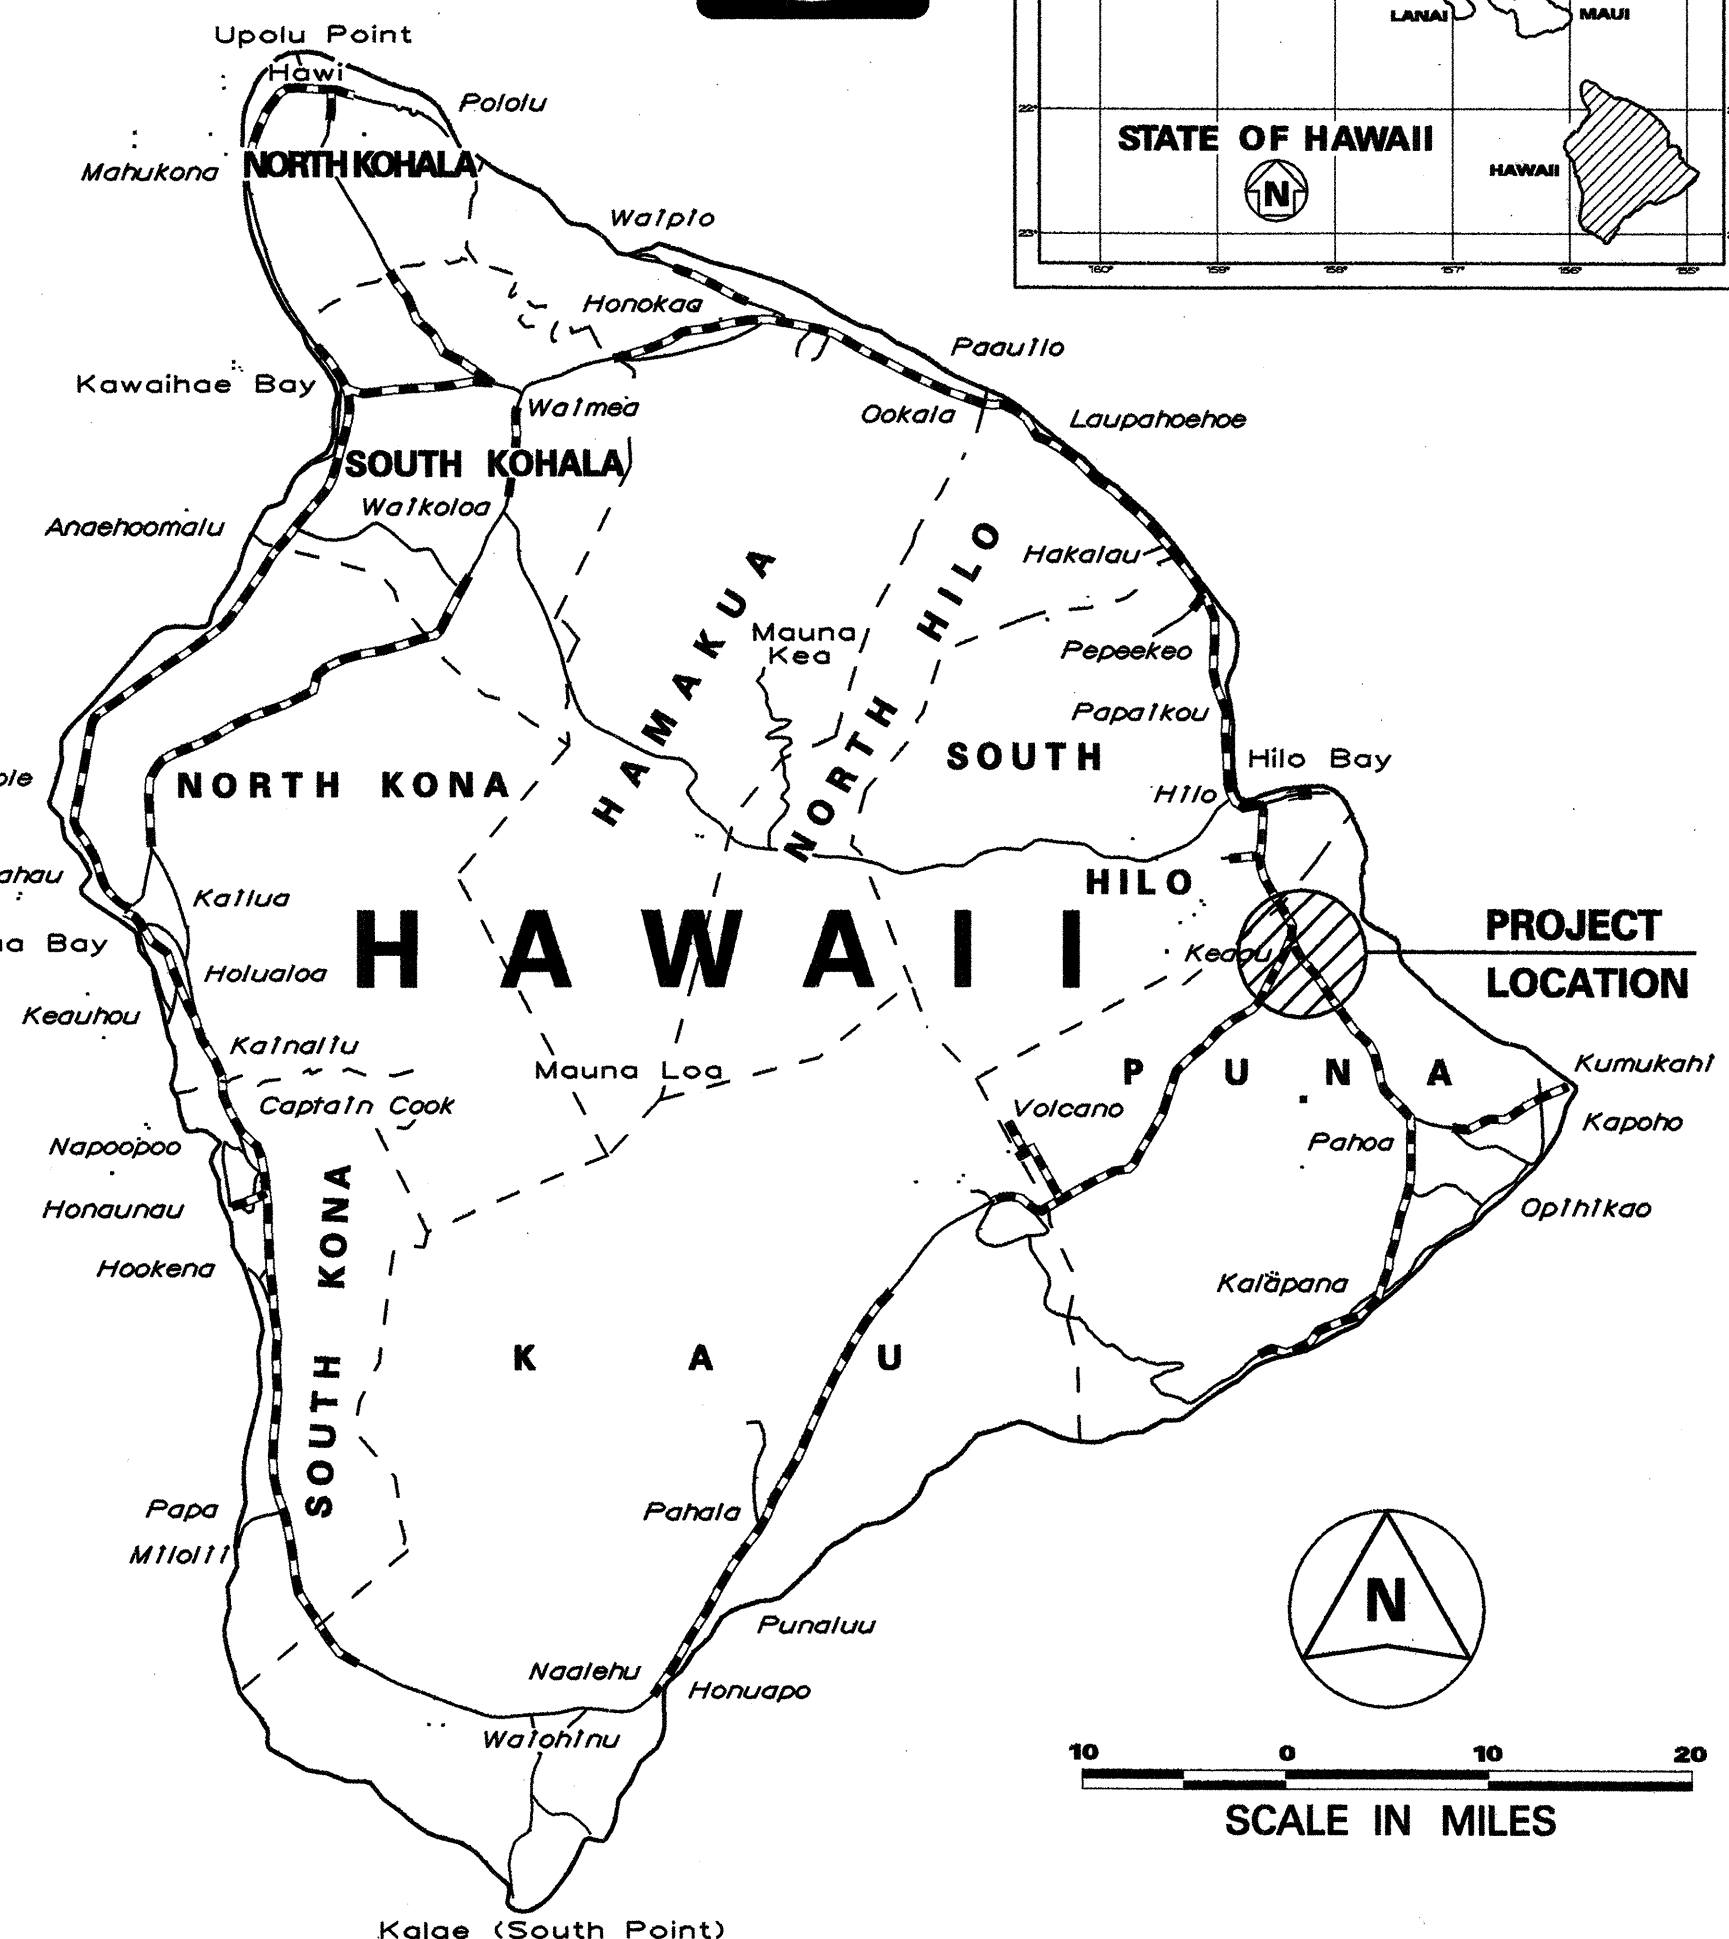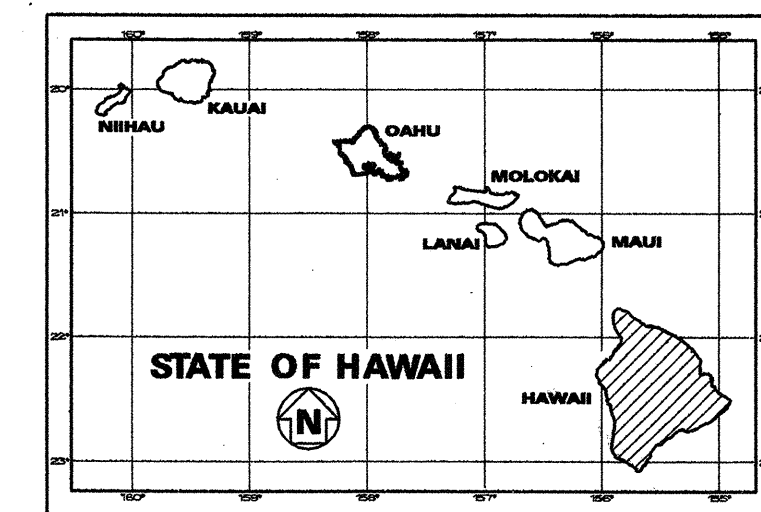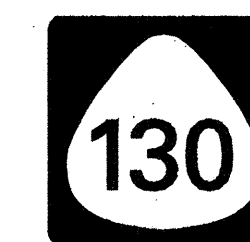

FEDERAL AID PROJECTS PREVIOUSLY CONSTRUCTED OR UNDER CONSTRUCTION

ROUTE 11 (VOLCANO ROAD) MILE POST 6.23
TO ROUTE 130 (BYPASS ROAD) MILE POST 2.33

DEPARTMENT OF TRANSPORTATION STATE OF HAWAII	
APPROVED:	
<i>[Signature]</i>	8/25/98
DIR. OF TRANSPORTATION	DATE

DMT / R. TAIRA
DESIGNED BY

R. HIRONAKA
P.S. & E. BY

587-2250
PHONE

AUGUST, 1998
DATE