

INDEX TO DRAWINGS	
SHEET NO.	DESCRIPTION
1	TITLE SHEET
2	DETAILED INDEX
3	STANDARD PLANS SUMMARY
4 - 9	NOTES
10 - 228	CIVIL PLANS
229 - 246	GEOTECHNICAL PLANS
247 - 263	STRUCTURAL PLANS
264 - 288	ELECTRICAL PLANS

STATE OF HAWAII

DEPARTMENT OF TRANSPORTATION

HIGHWAYS DIVISION

HONOLULU, HAWAII

"AS-BUILT"

PLANS FOR

KEAAU-PAHOA ROAD

SHOULDER LANE CONVERSION, PHASE 1



KEAAU BYPASS ROAD TO SHOWER DRIVE

FEDERAL-AID PROJECT NO. STP-0130(28), PHASE 1

DISTRICT OF PUNA

ISLAND OF HAWAII


FED. ROAD DIST. NO.	STATE	FED. AID PROJ. NO.	FISCAL YEAR	SHEET NO.	TOTAL SHEETS
HAWAII	HAW.	STP-0130(28)PH.1	2012	1	288

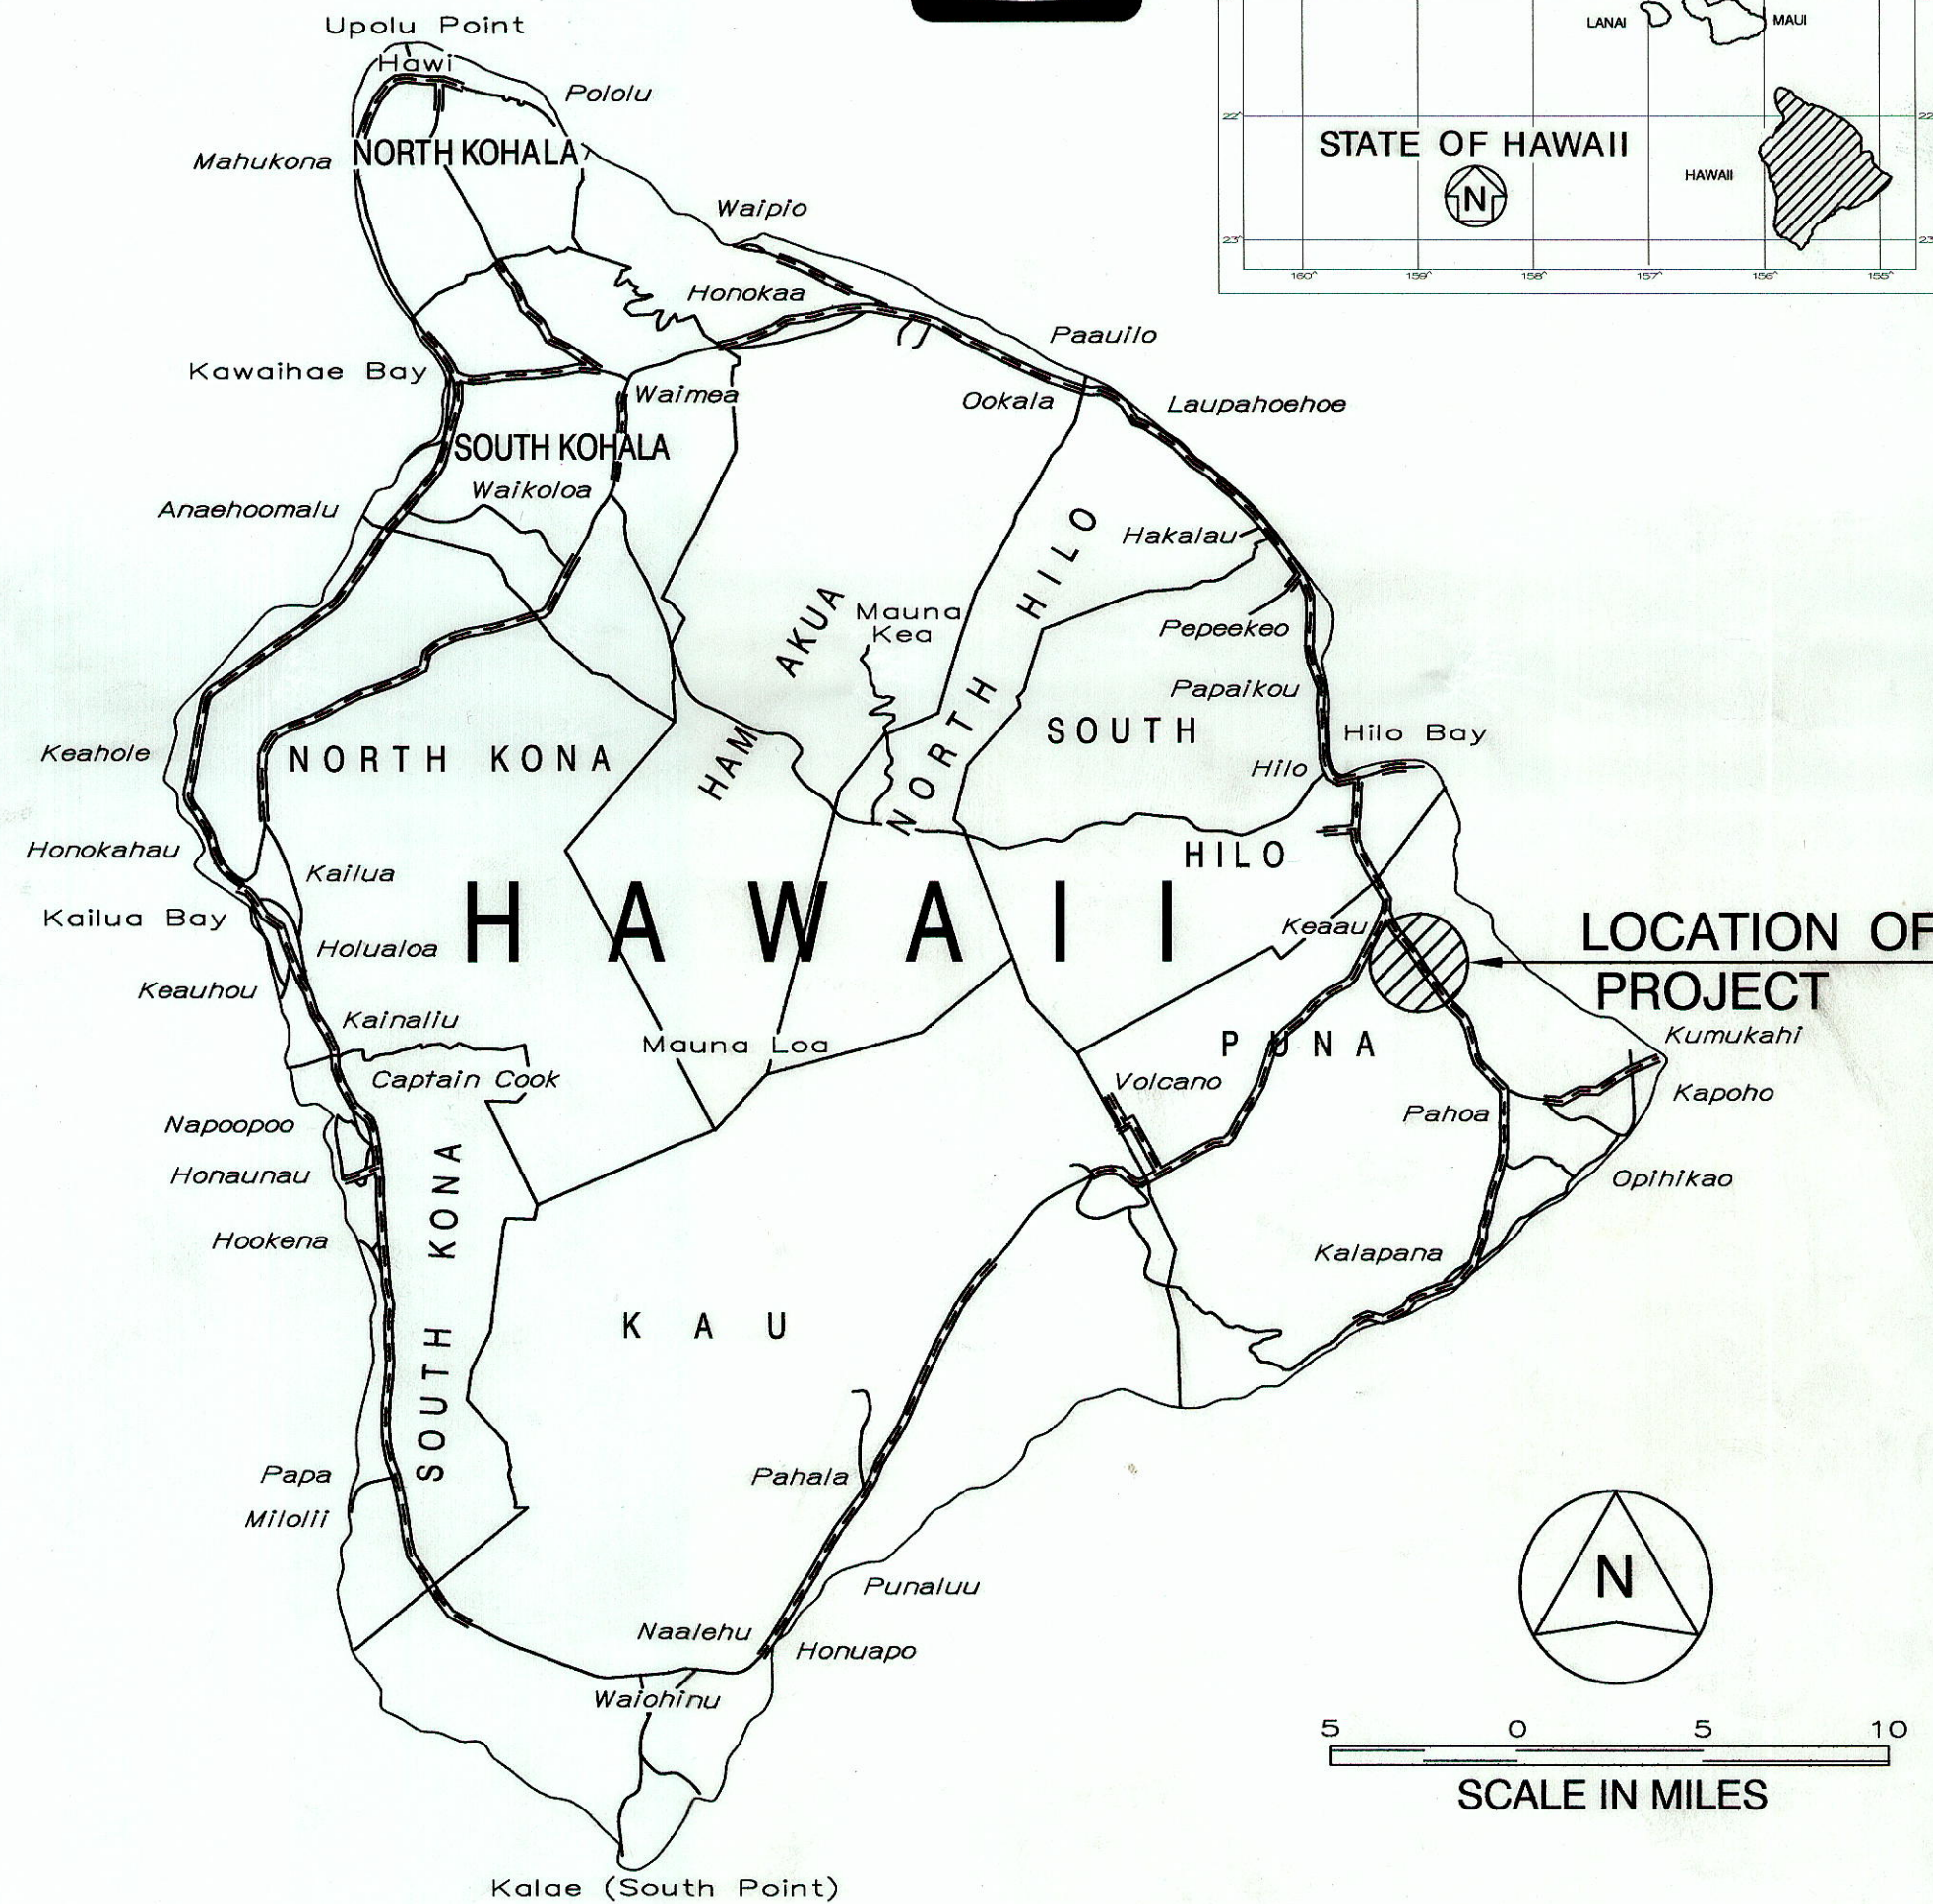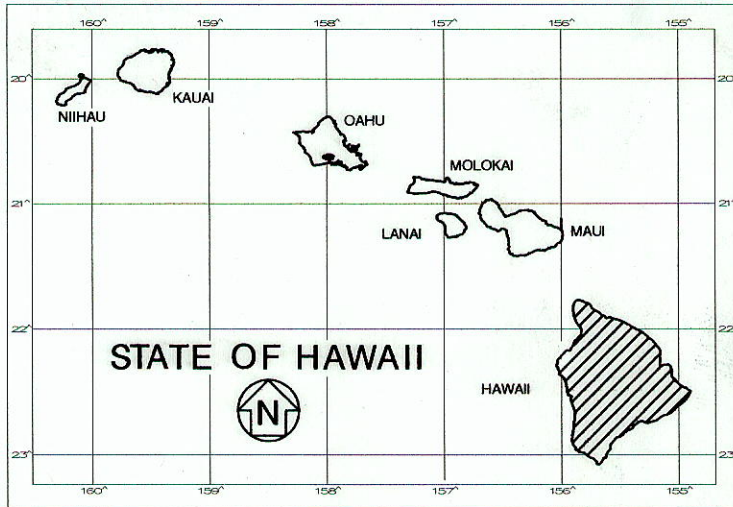

5 0 5 10
SCALE IN MILES

FEDERAL AID PROJECTS PREVIOUSLY CONSTRUCTED OR UNDER CONSTRUCTION

MILE POST 2.02 TO MILE POST 4.12

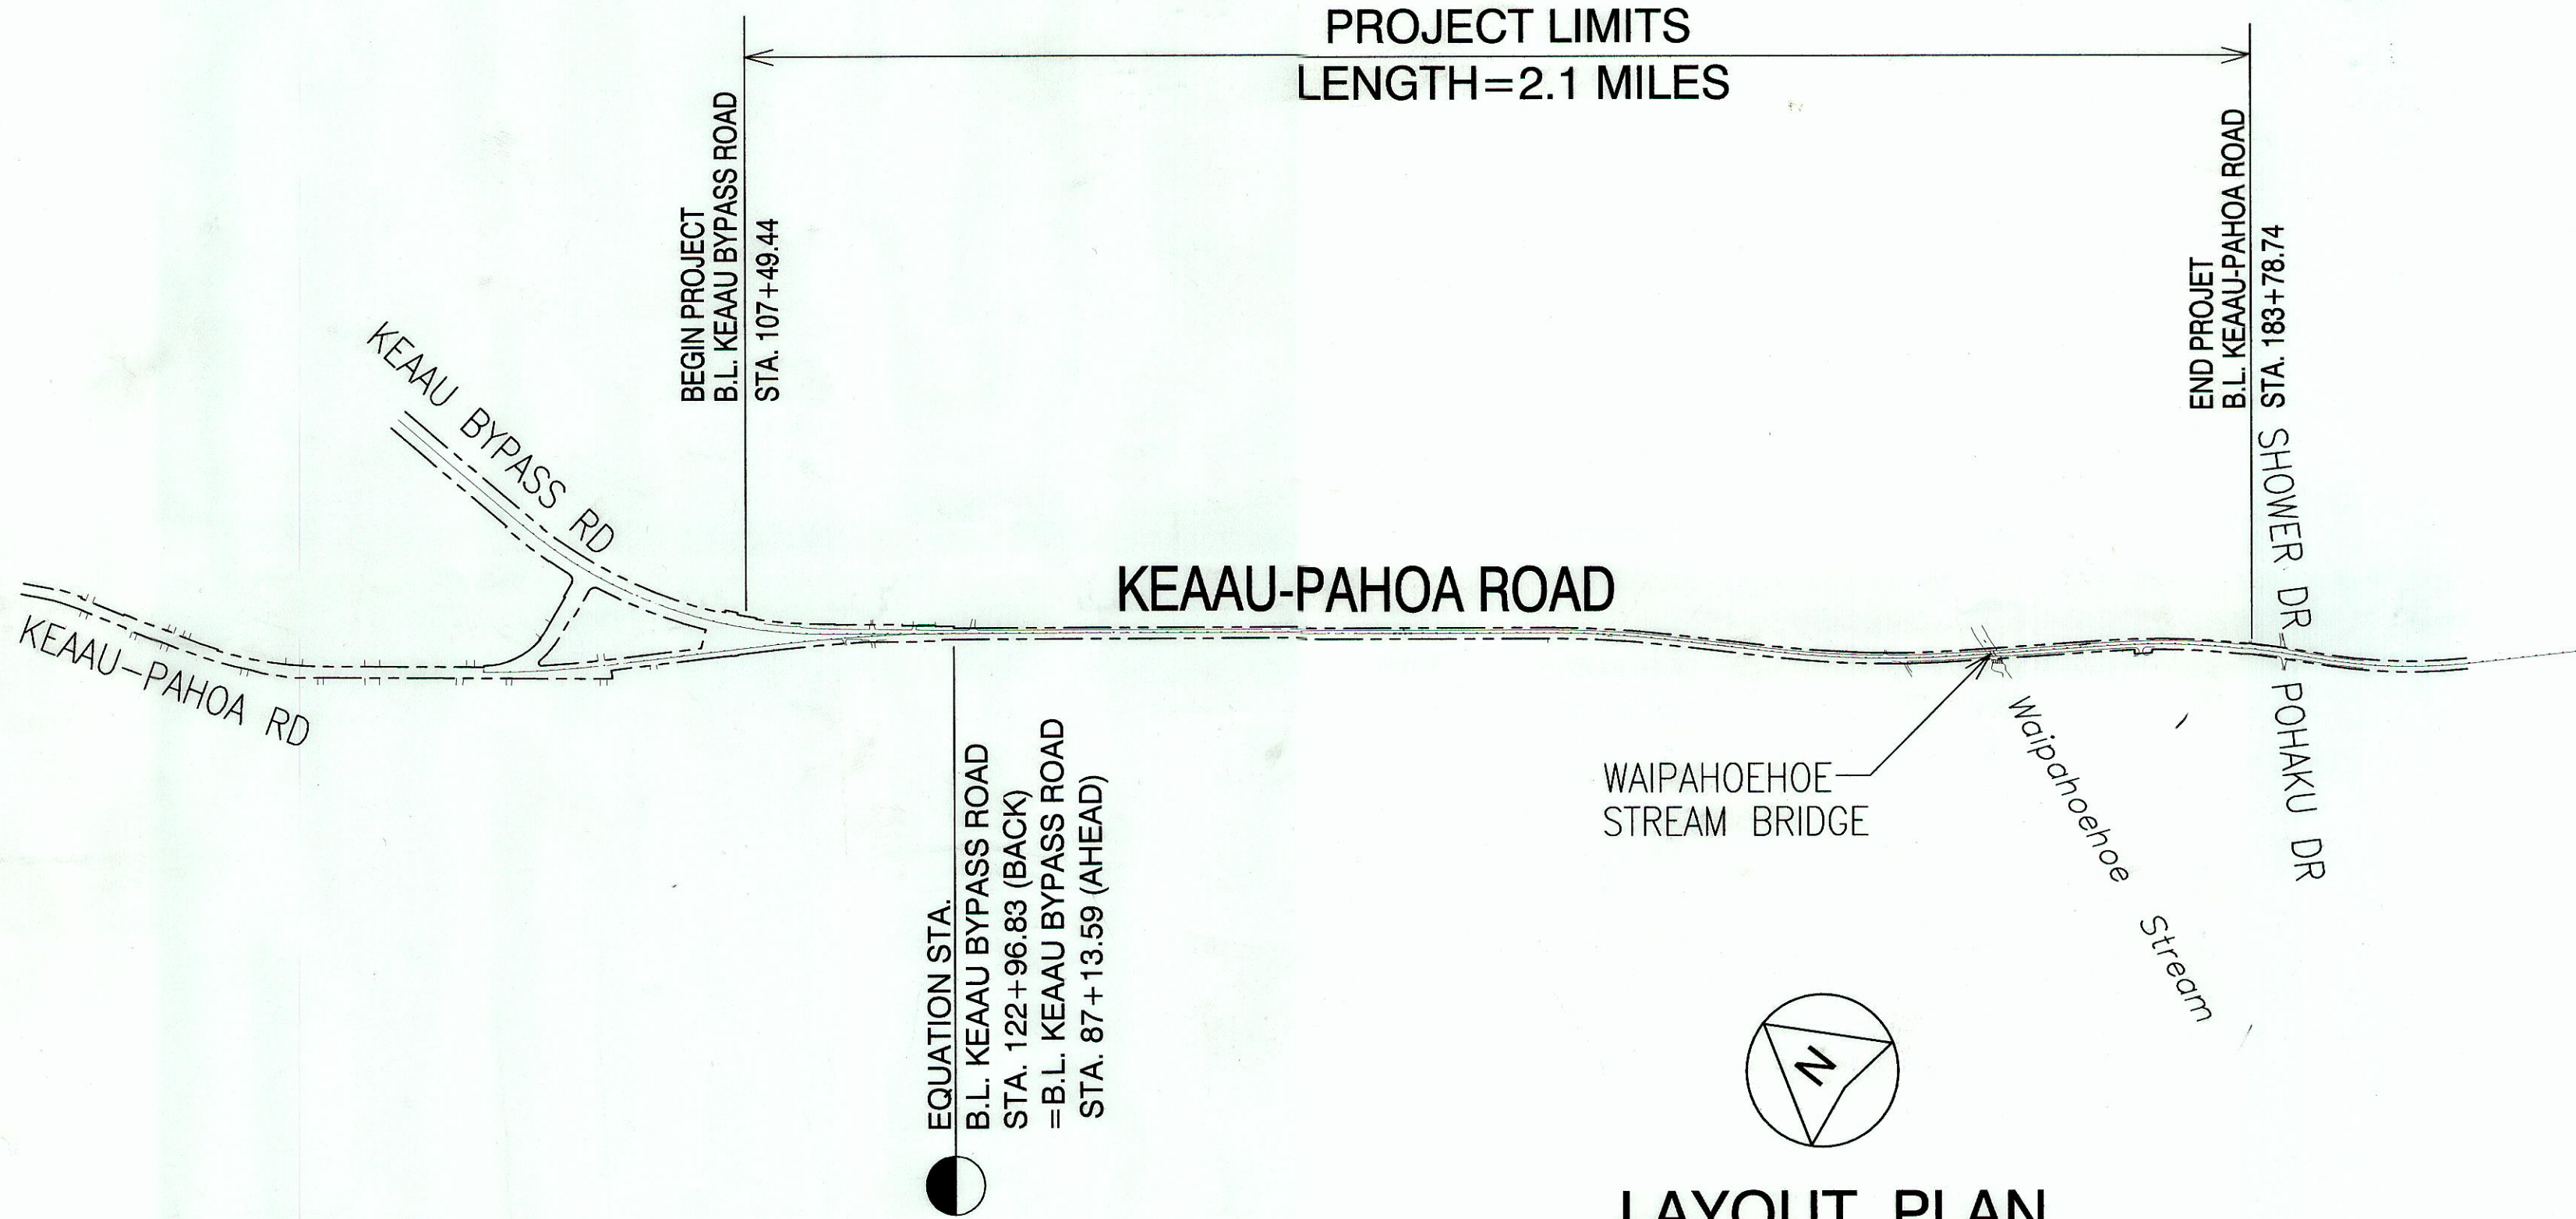

LAYOUT PLAN
NOT TO SCALE

GROSS LENGTH OF PROJECT 2.1 MILES
NET LENGTH OF PROJECT 2.1 MILES

DESIGN DESIGNATION

KEAAU-PAHOA ROAD

CURRENT ADT (2007) ...	25,200
DESIGN ADT (2028)	34,800
DHV	2,960
D	80/20
T	3.0
T ₂₄	2.5
K	8.5%
V	65

CHANGES MADE DURING CONSTRUCTION HAVE BEEN INCORPORATED ON THESE PLANS EXCEPT CHANGES IN THE ORIGINAL THEORETICAL QUANTITIES. FOR ACTUAL QUANTITIES, REFER TO PROJECT LEDGER AND/OR COMPUTATION BOOK.

6/29/12
DATE

DEPARTMENT OF TRANSPORTATION
STATE OF HAWAII
APPROVED:
7/06/12
DATE

WILSON OKAMOTO CORPORATION
DESIGNED BY
HWY - DS
MANAGED BY
692-7544
PHONE
JULY 2012
DATE