



FED. ROAD DIST. NO.	STATE	FED. AID PROJ. NO.	FISCAL YEAR	SHEET NO.	TOTAL SHEETS
HAWAII	HAW.	STP-0130(33)	2016	30	99

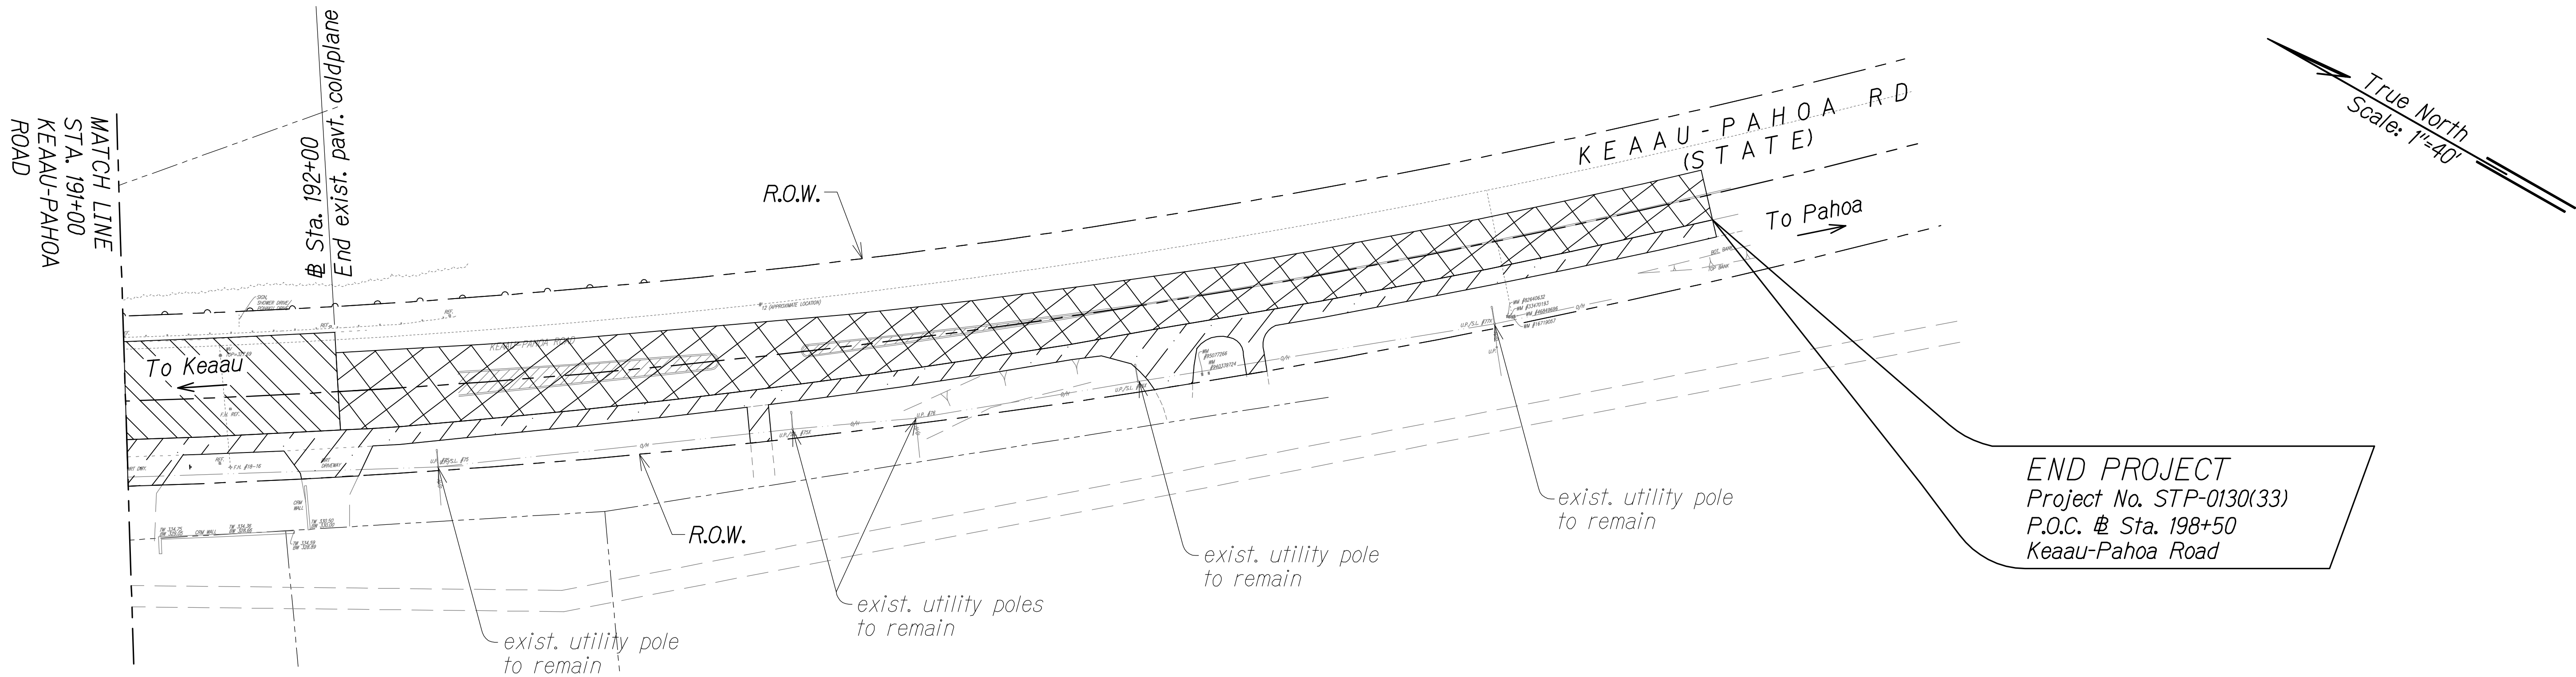

 
- Notes:
1. See "Electrical Plans" for relocation of utility poles.
 2. See "Pavement Marking and Signing Plans" for sign removal and relocation.
 3. See "Utility Plans" for relocations and removal water system.

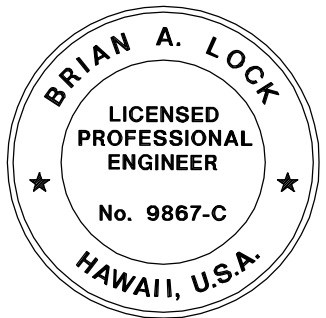


THIS WORK WAS PREPARED BY ME
OR UNDER MY SUPERVISION.

APRIL 30, 2018
WILSON OKAMOTO CORPORATION LIC. EXP. DATE


Legend:



 Remove exist. a.c. pavement
including asphalt base and
aggregate subbase




Approx. Bulk Sample Location

 

Coldplane existing a.c.
pavement 2"



 Approx. Boring Location



Remove exist. pavt. marking

LEGEND FOR
AS-BUILT POSTINGS



Squiggly line for
as-built deletion



Double line for
as-built deletion



Text for as-built
posting

STATE OF HAWAII
DEPARTMENT OF TRANSPORTATION
HIGHWAYS DIVISION

DEMOLITION PLAN

KEAAU-PAHOA ROAD, SHOULDER
LANE CONVERSION, PHASE 2
Show Drive Intersection Improvements
Fed. Aid Proj. No. STP-0130(33)
Scale: 1" = 40' Date: March 2016

SHEET No. DP-2 OF 2 SHEETS

"AS-BUILT"

30

ORIGINAL PLAN	SURVEY PLOTTED BY	DATE
	DRAWN BY	
NOTE BOOK	TRACED BY	
	QUANTITIES BY	
No.	CHECKED BY	