

FED. ROAD DIST. NO.	STATE	FED. AID PROJ. NO.	FISCAL YEAR	SHEET NO.	TOTAL SHEETS
HAWAII	HAW.	STP-0130(28)	2010	25	317

BEGIN PROJECT
Project No. STP-0130(28)
B.L. P.O.C. Sta. 107+94.44
Keaau Bypass Road

True North
Scale: 1"=40'

exist. litter control sign
to remain

Provide Smooth and Flush
Connection to exist.
pav't, typ.

Remove exist.
a.c. pav't.

Remove exist.
a.c. pav't.

exist. r.o.w.

Sta. 113+43.56
Keaau Bypass Rd.

B-1

Remove exist.
stop bar and
striping

Adjust WV Box Frame and
Cover to New Finish Grade,
Typ.

Remove exist.
stop bar and
striping

exist. r.o.w.
exist. utility pole
to remain

exist. utility pole and guy wires
See Elec. Plans, Typ.

Remove
exist.
tree

Remove exist.
a.c. pav't.


See Utility Plans, Typ.

exist. utility pole/street
light. See elec. plans,
typ.

exist. utility pole/street
light
Proposed R.O.W.

exist. r.o.w.

- Notes:
1. See "Electrical Plans" for relocation of utility poles.
 2. See "Pavement Marking and Signing Plans" for sign removal and relocation.
 3. See "Utility Plans" for relocations and removal water system.

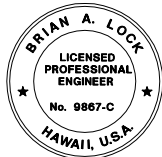

THIS WORK WAS PREPARED BY ME
OR UNDER MY SUPERVISION.

APRIL 30, 2012
WILSON OKAMOTO CORPORATION LIC. EXP. DATE

STATE OF HAWAII
DEPARTMENT OF TRANSPORTATION
HIGHWAYS DIVISION

DEMOLITION PLAN - 1

Keaau-Pahoa Road, Shoulder Lane Conversion
Keaau Bypass Road to Shower Drive
Fed. Aid Proj. No. STP-0130(28)

Scale: As Noted Date: December 2010

SHEET No. DP1 OF 7 SHEETS

FINAL DESIGN 25

SURVEY PLOTTED BY	DATE
DRAWN BY	
CHECKED BY	
DESIGNED BY	
QUANTITIES BY	
CHECKED BY	
ORIGINAL PLAN	No.
NOTE BOOK	

GRAPHIC SCALE:
40' 20' 0 40' 80'
SCALE: 1" = 40'

DEMOLITION PLAN - 1
Scale: 1" = 40'

Legend:



Remove exist. a.c. pavement
including asphalt base and
aggregate subbase





Approx. Bulk Sample Location



Approx. Boring Location

FED. ROAD DIST. NO.	STATE	FED. AID PROJ. NO.	FISCAL YEAR	SHEET NO.	TOTAL SHEETS
HAWAII	HAW.	STP-0130(28)	2010	26	317

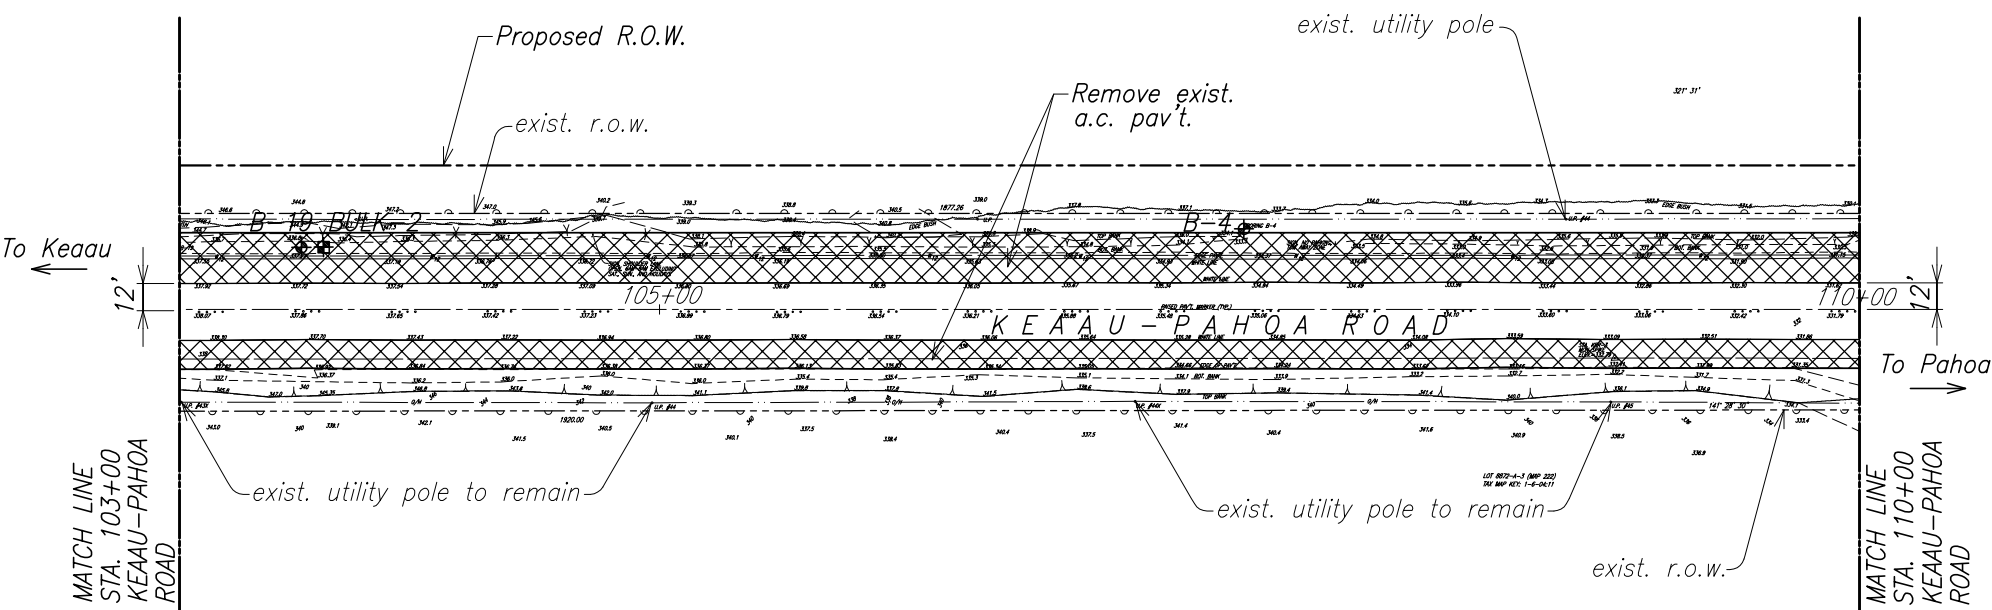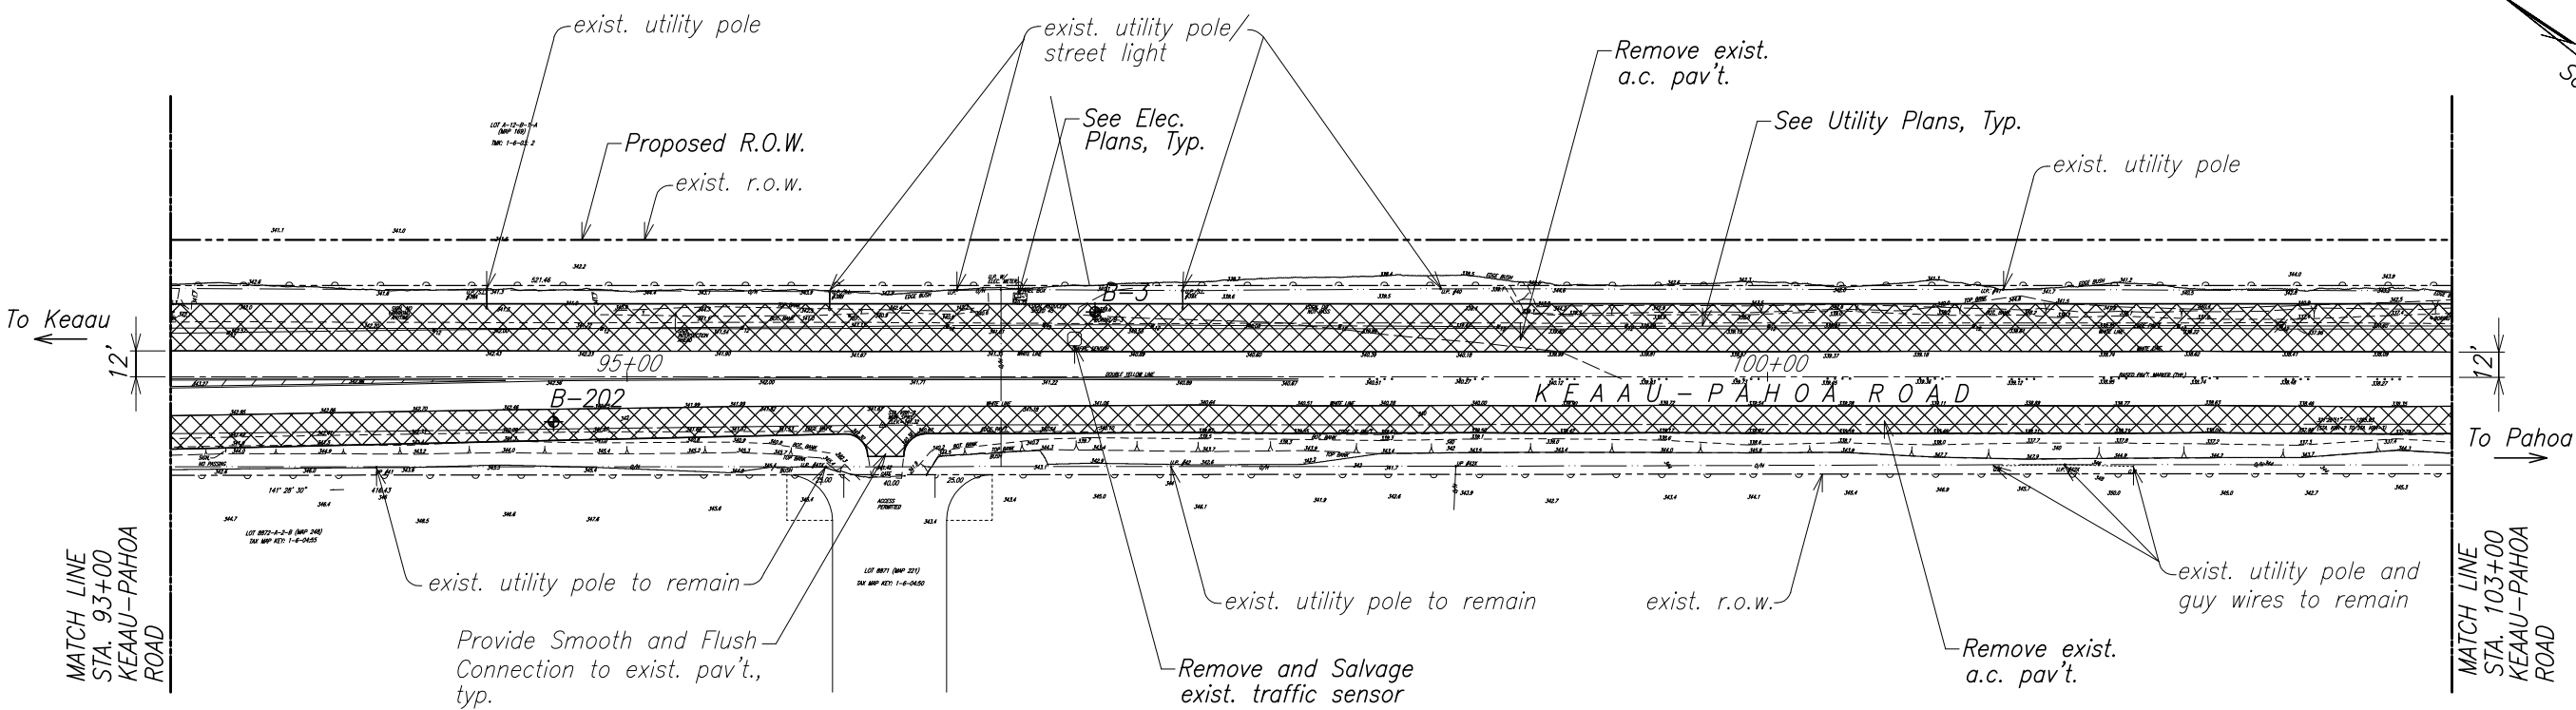

Legend:



Remove exist. a.c. pavement including asphalt base and aggregate subbase



Approx. Bulk Sample Location



Approx. Boring Location

Notes:

1. See "Electrical Plans" for relocation of utility poles.
2. See "Pavement Marking and Signing Plans" for sign removal and relocation.
3. See "Utility Plans" for relocations and removal water system.





THIS WORK WAS PREPARED BY ME OR UNDER MY SUPERVISION.

APRIL 30, 2012
WILSON OKAMOTO CORPORATION LIC. EXP. DATE

STATE OF HAWAII
DEPARTMENT OF TRANSPORTATION
HIGHWAYS DIVISION
DEMOLITION PLAN - 2
Keaau-Pahoa Road, Shoulder Lane Conversion
Keaau Bypass Road to Shower Drive
Fed. Aid Proj. No. STP-0130(28)
Scale: As Noted Date: December 2010
SHEET No. DP2 OF 7 SHEETS

FED. ROAD DIST. NO.	STATE	FED. AID PROJ. NO.	FISCAL YEAR	SHEET NO.	TOTAL SHEETS
HAWAII	HAW.	STP-0130(28)	2010	27	317

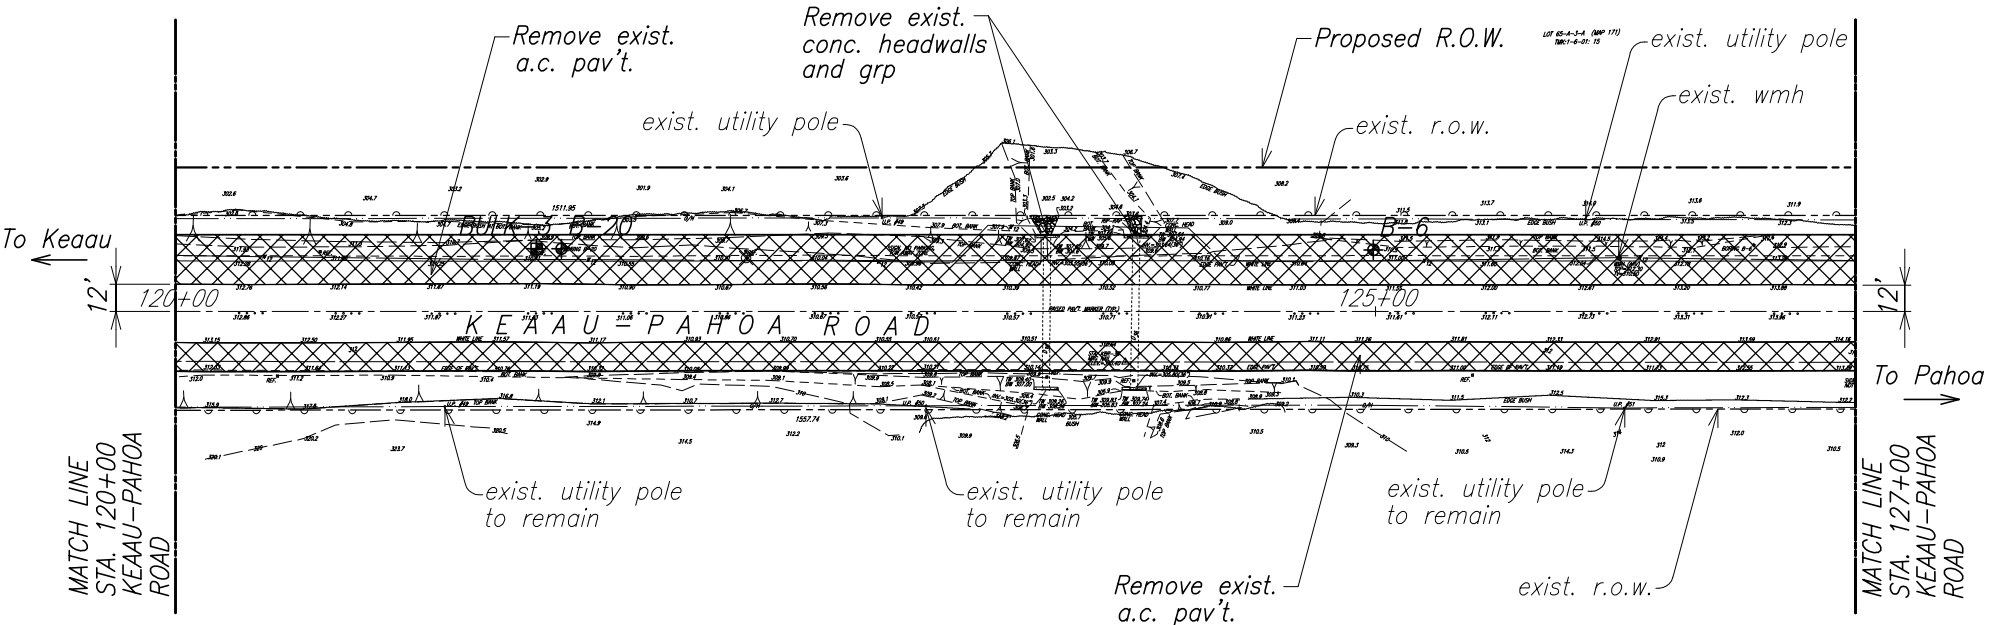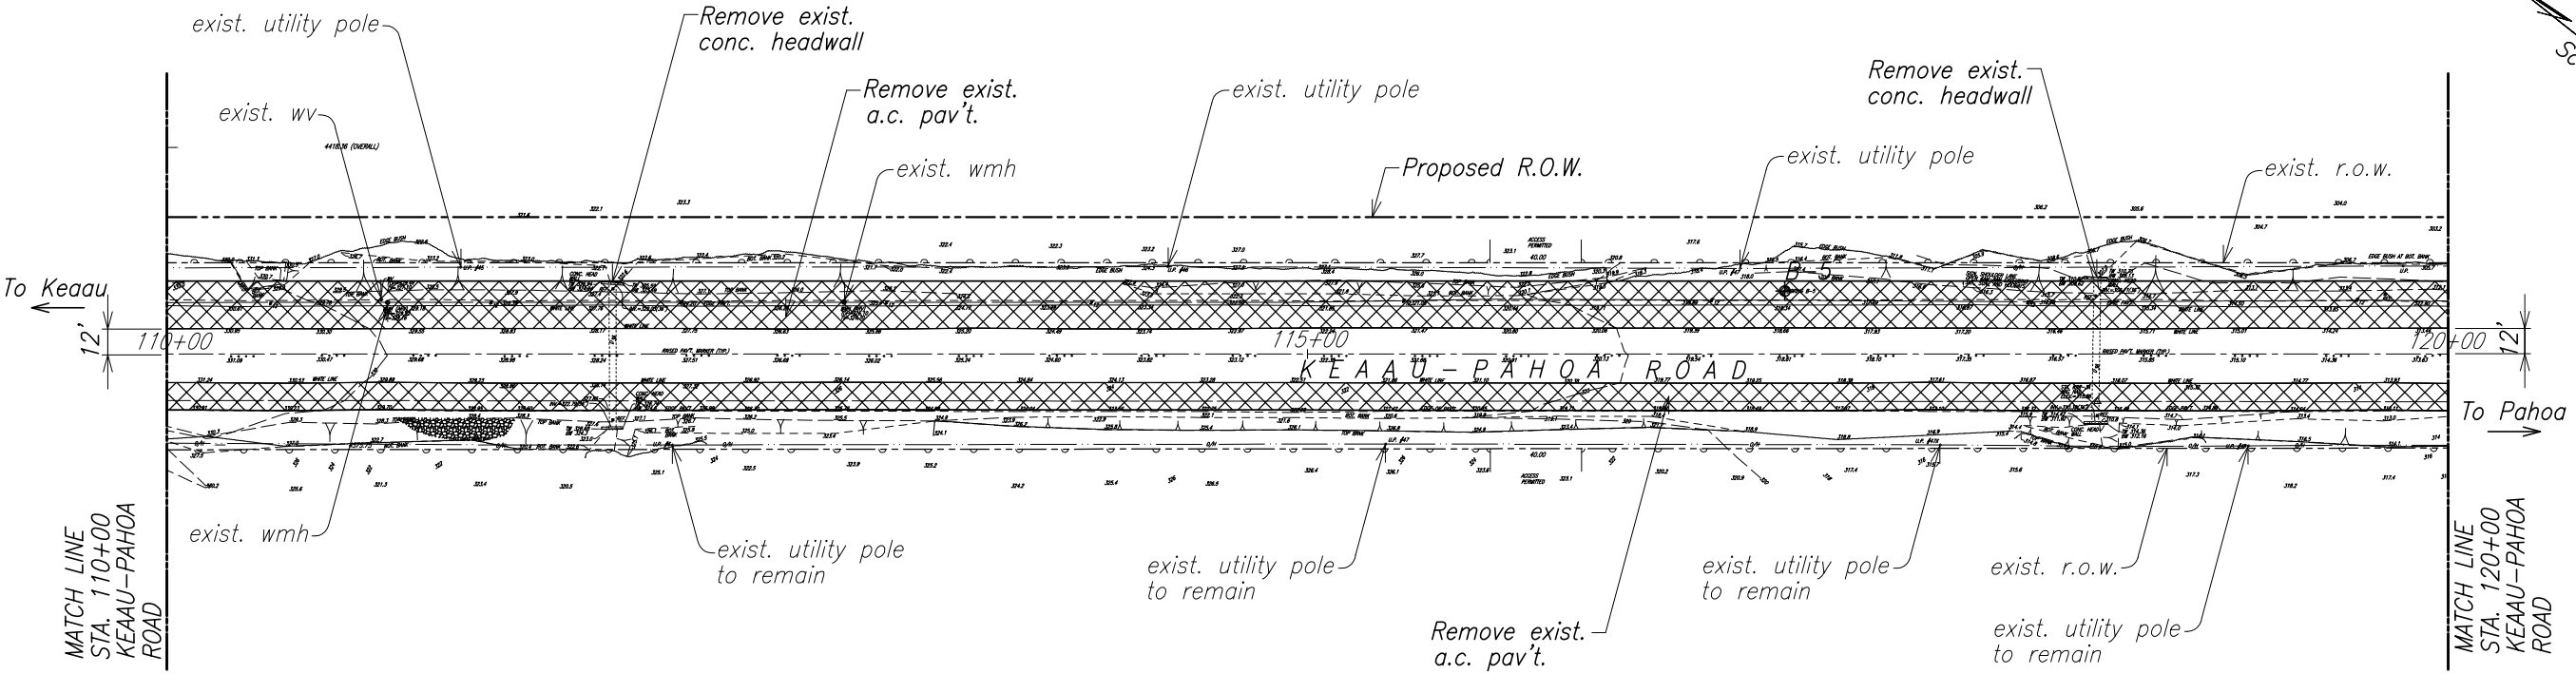

- Legend:**
- Remove exist. a.c. pavement including asphalt base and aggregate subbase
 - Approx. Bulk Sample Location
 - Approx. Boring Location
- Notes:**
- See "Electrical Plans" for relocation of utility poles.
 - See "Pavement Marking and Signing Plans" for sign removal and relocation.
 - See "Utility Plans" for relocations and removal water system.



THIS WORK WAS PREPARED BY ME OR UNDER MY SUPERVISION.

APRIL 30, 2012
WILSON OKAMOTO CORPORATION LIC. EXP. DATE

STATE OF HAWAII
DEPARTMENT OF TRANSPORTATION
HIGHWAYS DIVISION



DEMOLITION PLAN - 3

Keaau-Pahoa Road, Shoulder Lane Conversion
Keaau Bypass Road to Shower Drive
Fed. Aid Proj. No. STP-0130(28)

Scale: As Noted Date: December 2010

SHEET No. DP3 OF 7 SHEETS

FED. ROAD DIST. NO.	STATE	FED. AID PROJ. NO.	FISCAL YEAR	SHEET NO.	TOTAL SHEETS
HAWAII	HAW.	STP-0130(28)	2010	28	317

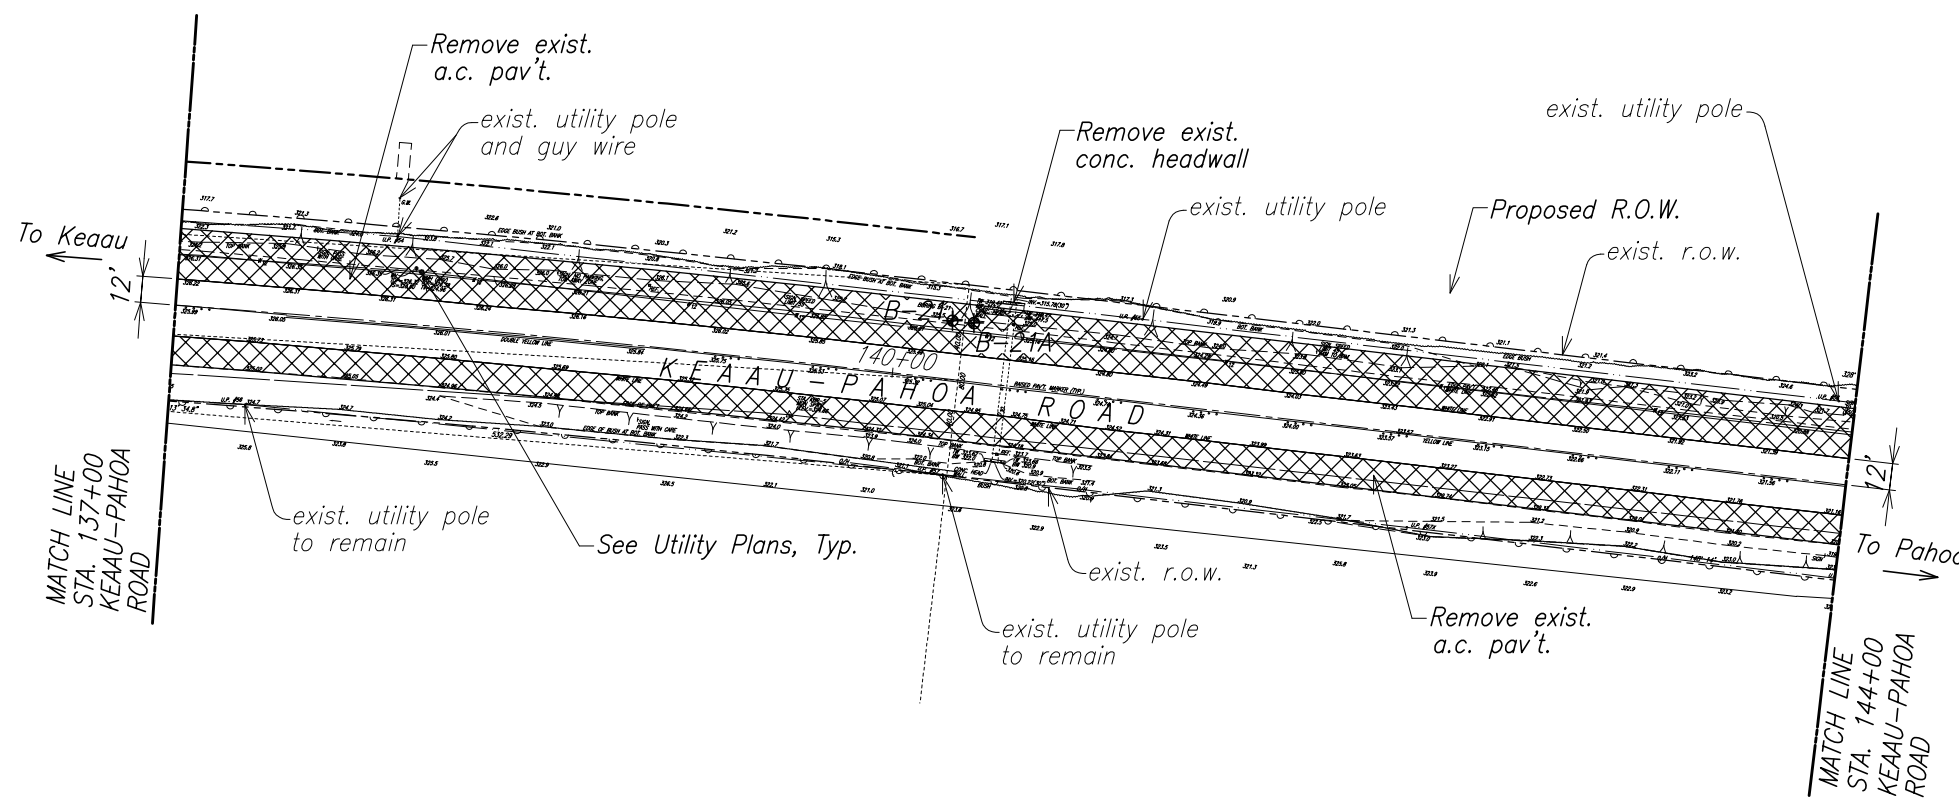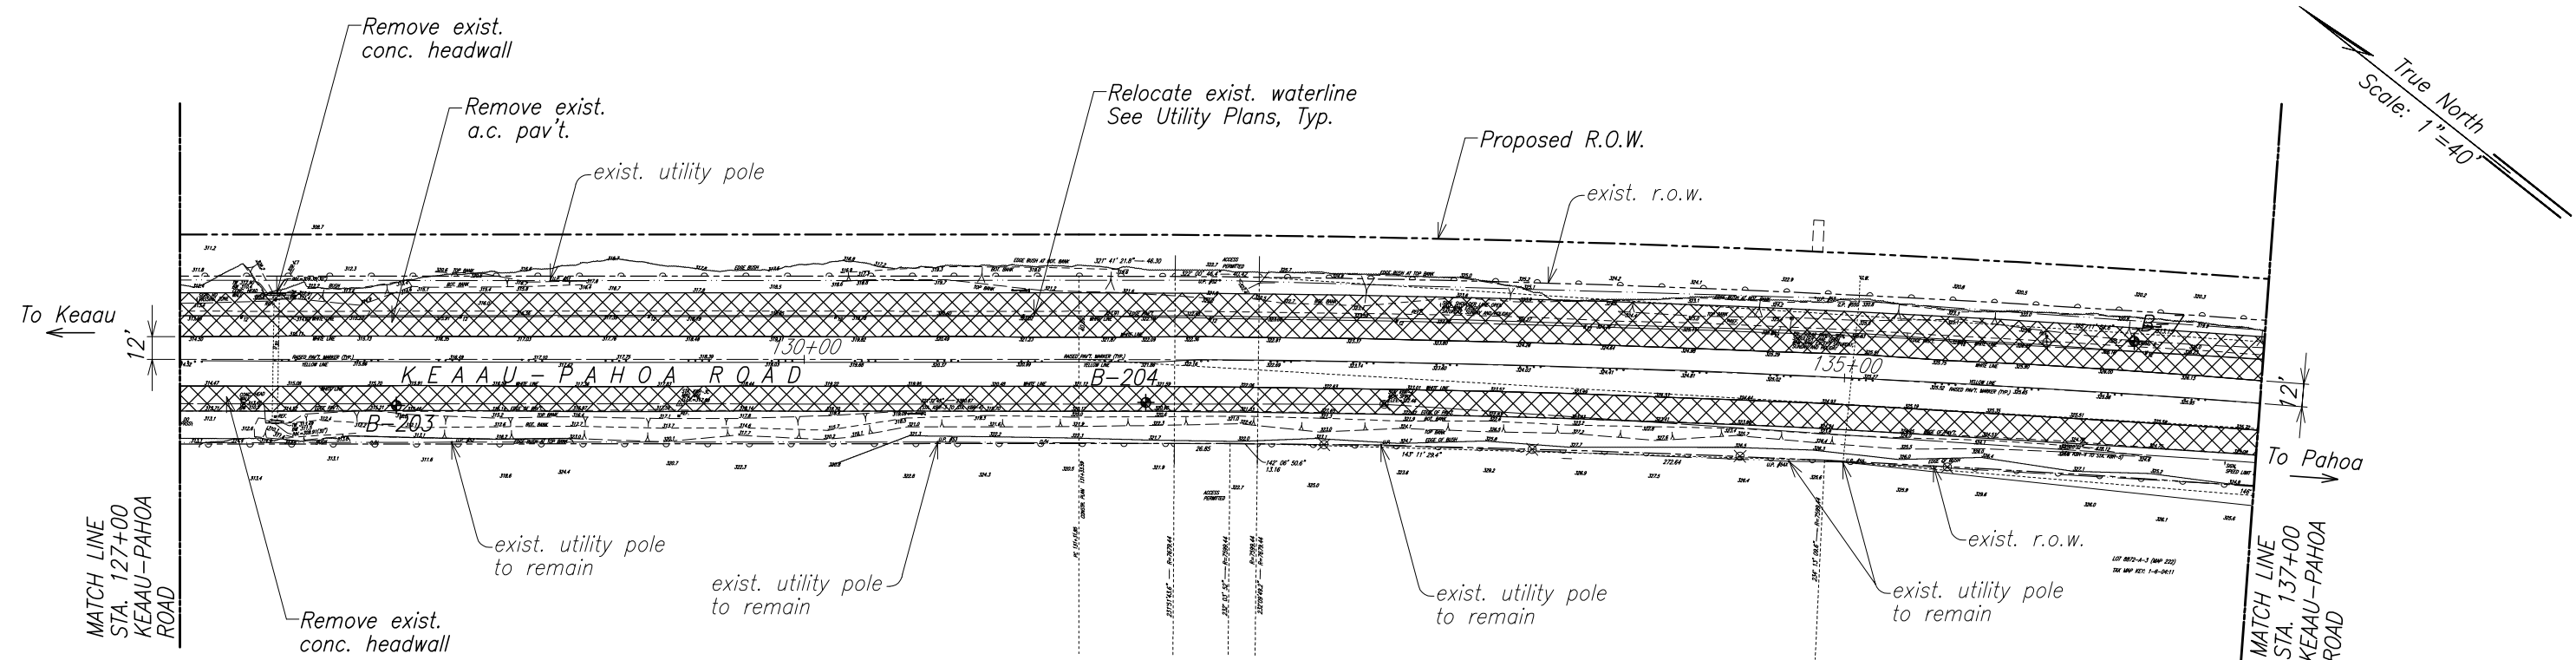


- Legend:**
- Remove exist. a.c. pavement including asphalt base and aggregate subbase
 - Approx. Bulk Sample Location
 - Approx. Boring Location
- Notes:**
- See "Electrical Plans" for relocation of utility poles.
 - See "Pavement Marking and Signing Plans" for sign removal and relocation.
 - See "Utility Plans" for relocations and removal water system.



THIS WORK WAS PREPARED BY ME OR UNDER MY SUPERVISION.

WILSON OKAMOTO CORPORATION APRIL 30, 2012 LIC. EXP. DATE

DATE	_____
SURVEY PLOTTED BY	_____
DRAWN BY	_____
DESIGNED BY	_____
QUANTITIES BY	_____
CHECKED BY	_____

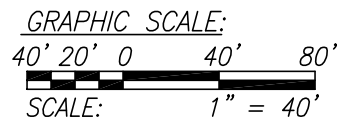

DEMOLITION PLAN - 4
Scale: 1" = 40'

STATE OF HAWAII
DEPARTMENT OF TRANSPORTATION
HIGHWAYS DIVISION


DEMOLITION PLAN - 4

Keaau-Pahoa Road, Shoulder Lane Conversion
Keaau Bypass Road to Shower Drive
Fed. Aid Proj. No. STP-0130(28)

Scale: As Noted Date: December 2010

SHEET No. DP4 OF 7 SHEETS

FED. ROAD DIST. NO.	STATE	FED. AID PROJ. NO.	FISCAL YEAR	SHEET NO.	TOTAL SHEETS
HAWAII	HAW.	STP-0130(28)	2010	30	317

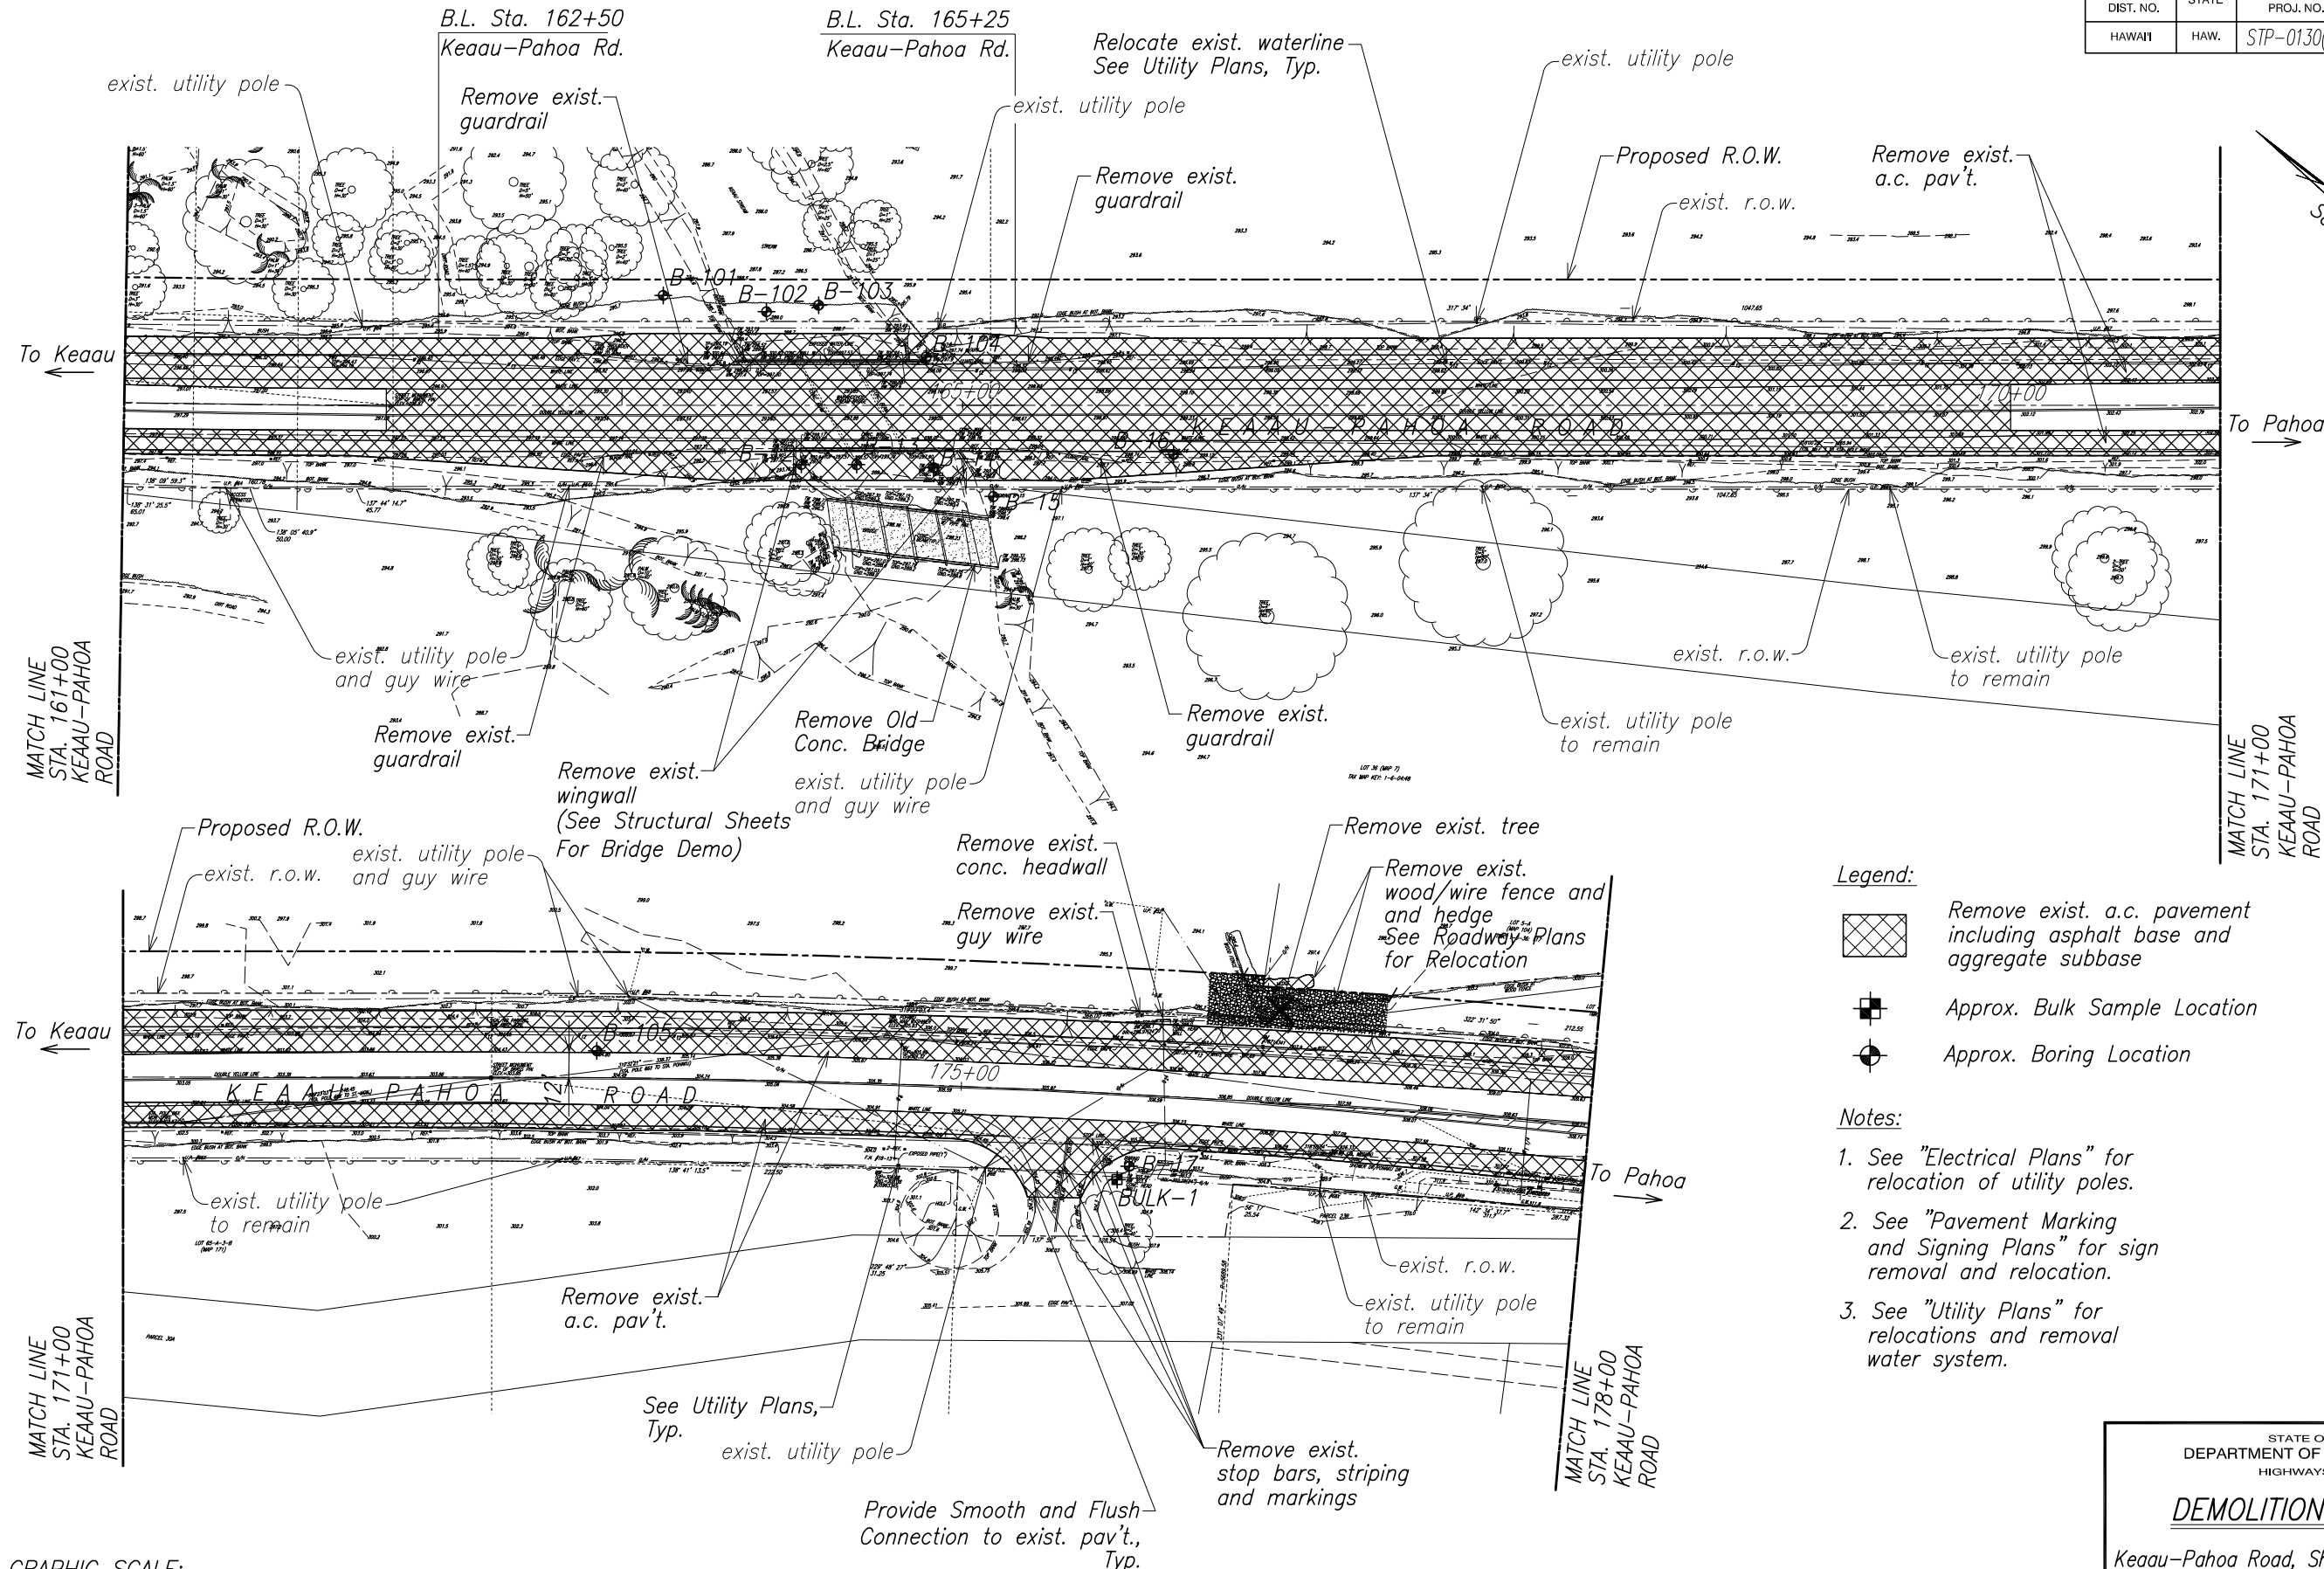

Legend:

- Remove exist. a.c. pavement including asphalt base and aggregate subbase
- Approx. Bulk Sample Location
- Approx. Boring Location

Notes:

- See "Electrical Plans" for relocation of utility poles.
- See "Pavement Marking and Signing Plans" for sign removal and relocation.
- See "Utility Plans" for relocations and removal water system.



THIS WORK WAS PREPARED BY ME OR UNDER MY SUPERVISION.


APRIL 30, 2012
WILSON OKAMOTO CORPORATION LIC. EXP. DATE

DEMOLITION PLAN - 6

Keaau-Pahoa Road, Shoulder Lane Conversion
Keaau Bypass Road to Shower Drive
Fed. Aid Proj. No. STP-0130(28)

Scale: As Noted Date: December 2010

SHEET No. DP6 OF 7 SHEETS

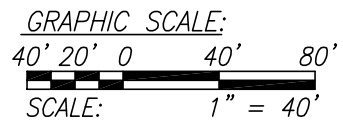

DEMOLITION PLAN - 6
Scale: 1" = 40'

