



FED. ROAD DIST. NO.	STATE	FED. AID PROJ. NO.	FISCAL YEAR	SHEET NO.	TOTAL SHEETS
HAWAII	HAW.	HSIP-0130(031)	2014	37	108

LEGEND FOR AS-BUILT POSTINGS

Squiggly line for as-built deletion

Double line for as-built deletion

Roadway Text for as-built posting

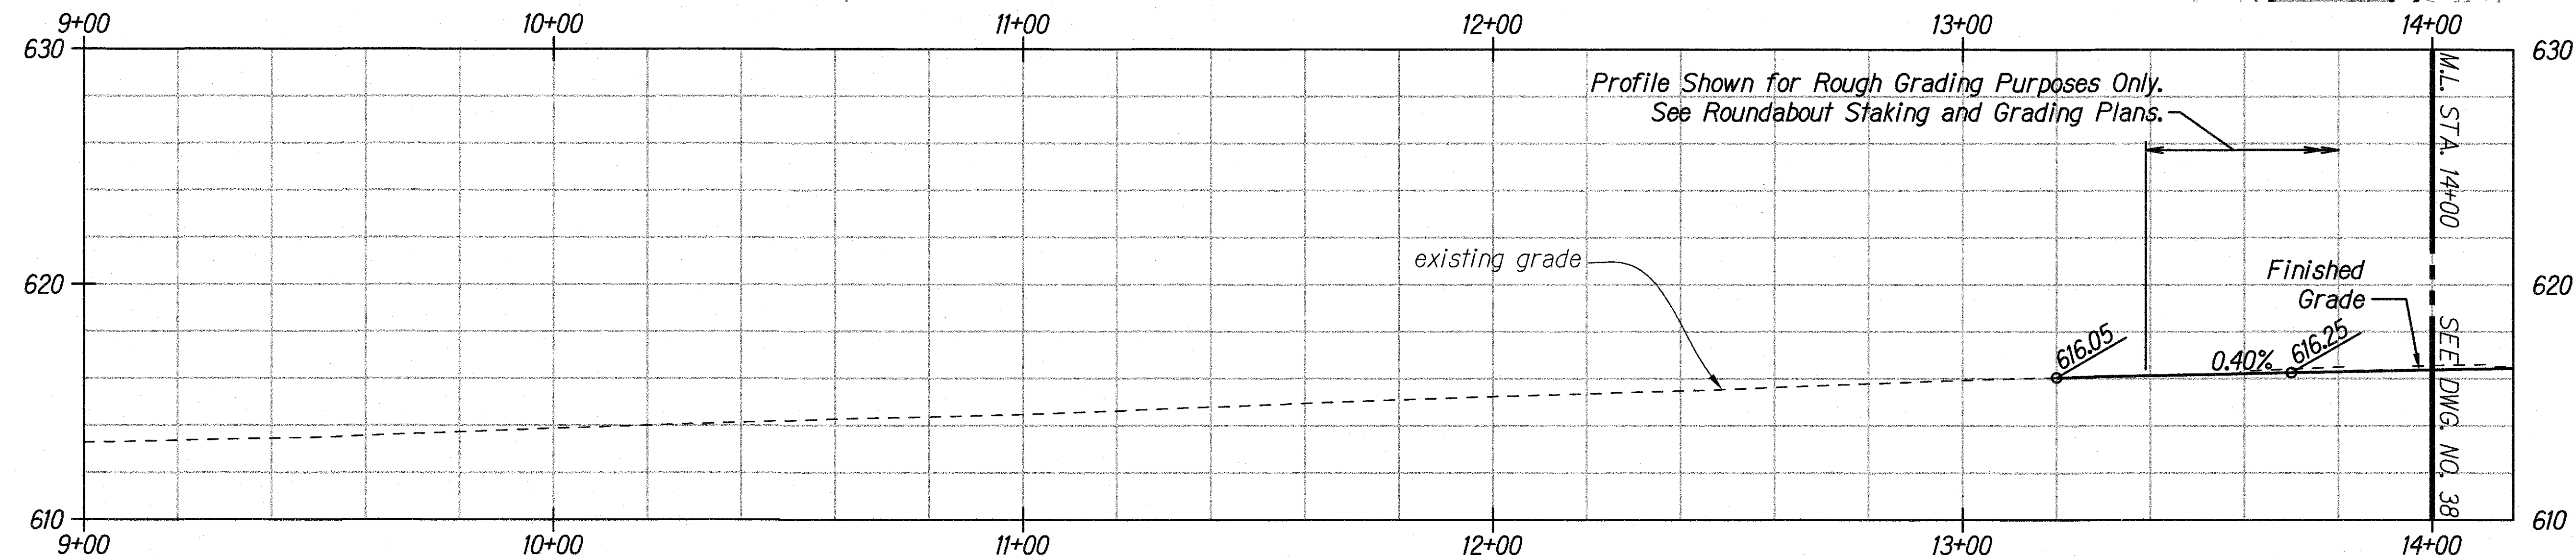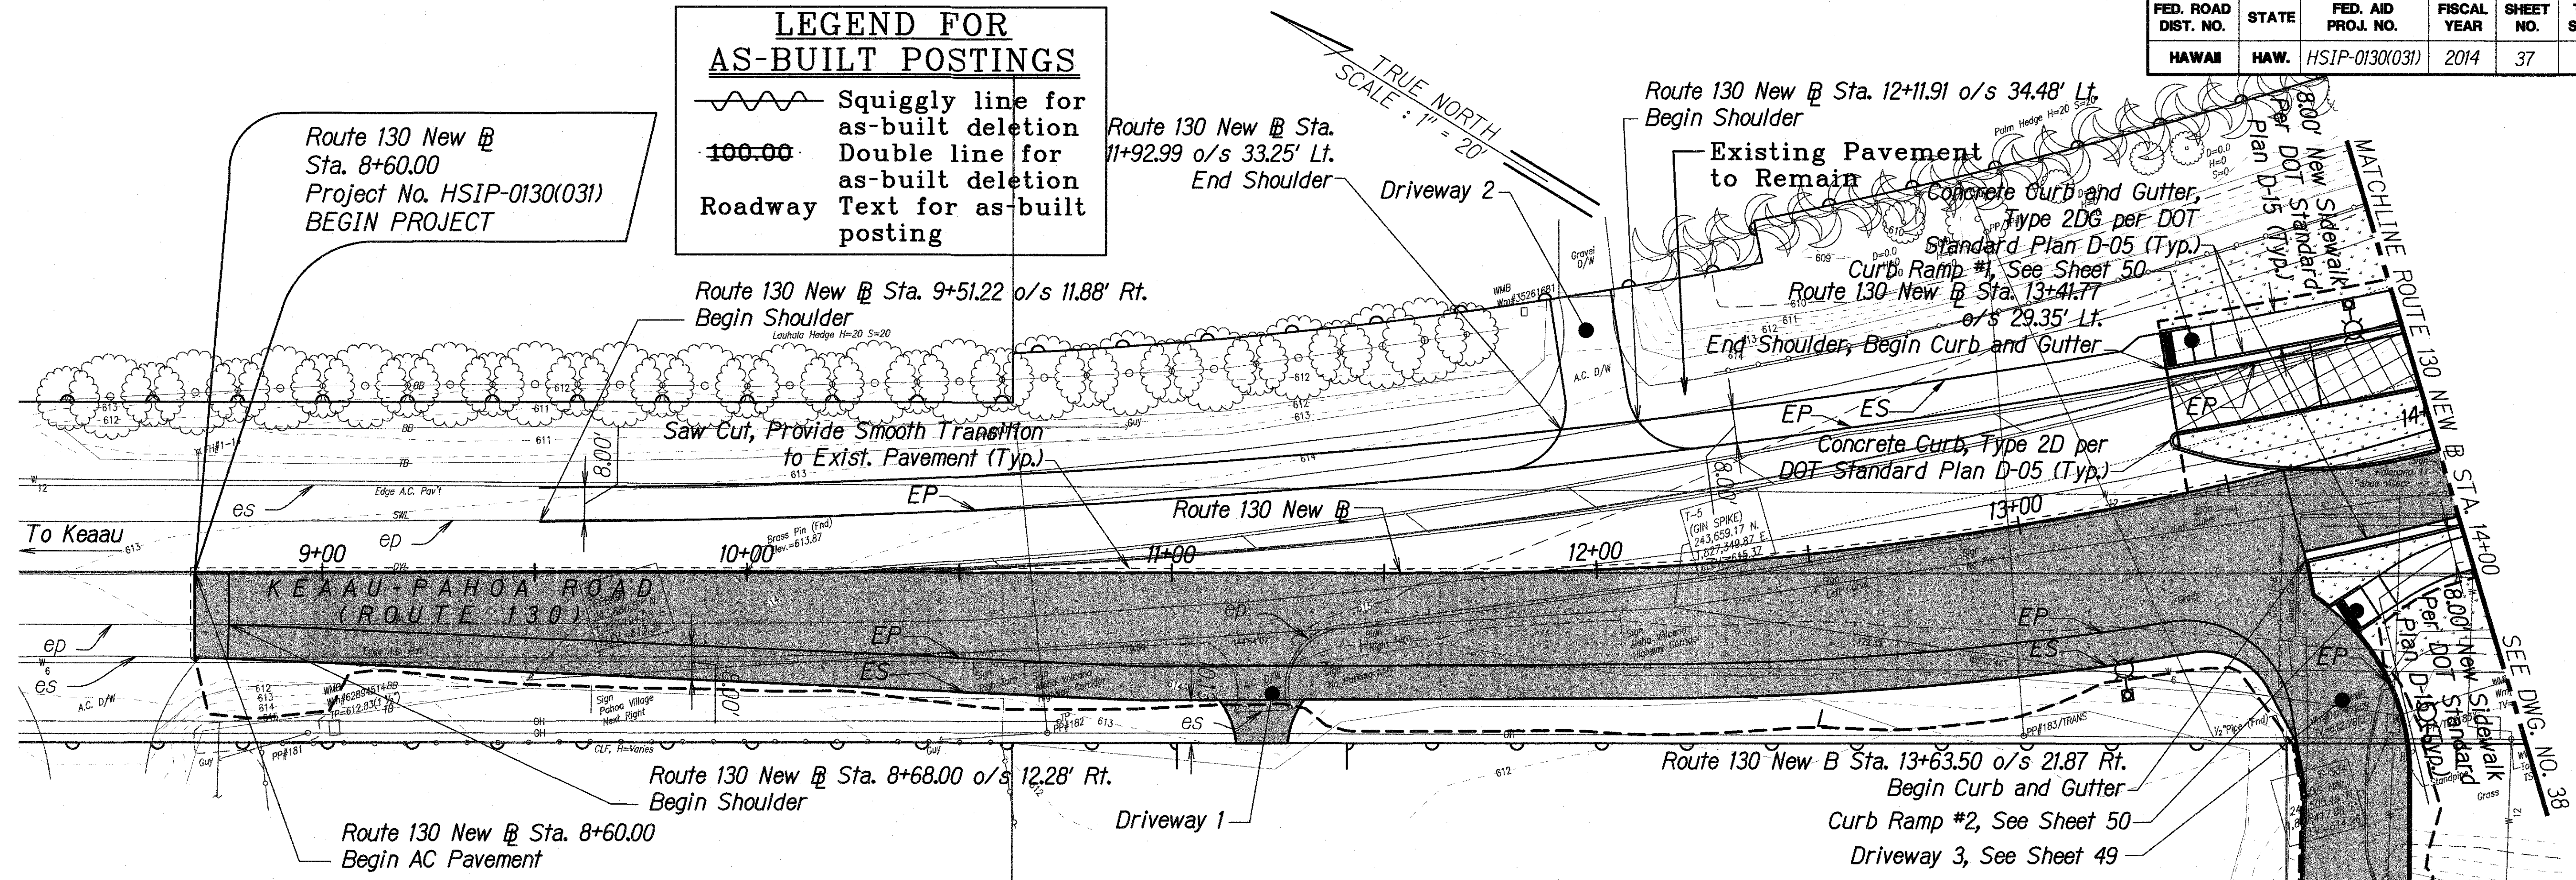

Notes:
1. Spot Elevations on Profile are at 50' Spacing, Typical


LEGEND

- 9.5" Portland Cement Concrete, 6" Untreated Permeable Base, 6" Aggregate Subbase
- 4" Asphaltic Concrete, 7" Asphalt Concrete Base, 6" Aggregate Subbase
- Sidewalk Culvert, See Sheet 77 for Details
- Truck Apron, See Sheet 25 for Details
- Guardrail, See Sheet 74 for Details
- 4" High Chain Link Fence per HDOT Standard Plan D-02 with 5' max post spacing
- Right of Way
- Limits of Grading

**ROADWAY PLAN & PROFILE
ROUTE 130 STA 9+00 TO STA 14+00**

Horizontal Scale: 1" = 20'
Vertical Scale: 1" = 4'

- Cold Plane and Repave
- 2" HMA Pav't, Mix No. IV
- Light Pole, See Electrical Plans
- Landscaping, See Landscape Plans

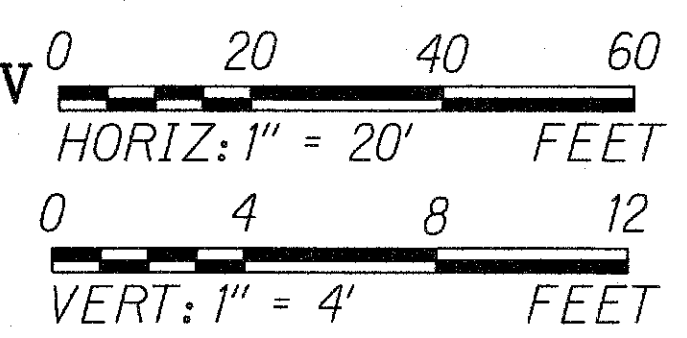

LICENSE EXPIRES 4/30/18
THIS WORK WAS PREPARED BY ME OR UNDER MY SUPERVISION

STATE OF HAWAII
DEPARTMENT OF TRANSPORTATION
HIGHWAYS DIVISION

**ROADWAY PLAN & PROFILE
ROUTE 130 STA 9+00 TO STA 14+00**

**Keau-Pahoa Road Intersection
Improvements at Old Government Road
Federal-Aid Project No. HSIP-0130(031)**



Scale: As Shown Date: August 2013

SHEET No. 1 OF 4 SHEETS

"AS-BUILT"

ADD. 37

FED. ROAD DIST. NO.	STATE	FED. AID PROJ. NO.	FISCAL YEAR	SHEET NO.	TOTAL SHEETS
HAWAII	HAW.	HSIP-0130(031)	2014	39	108

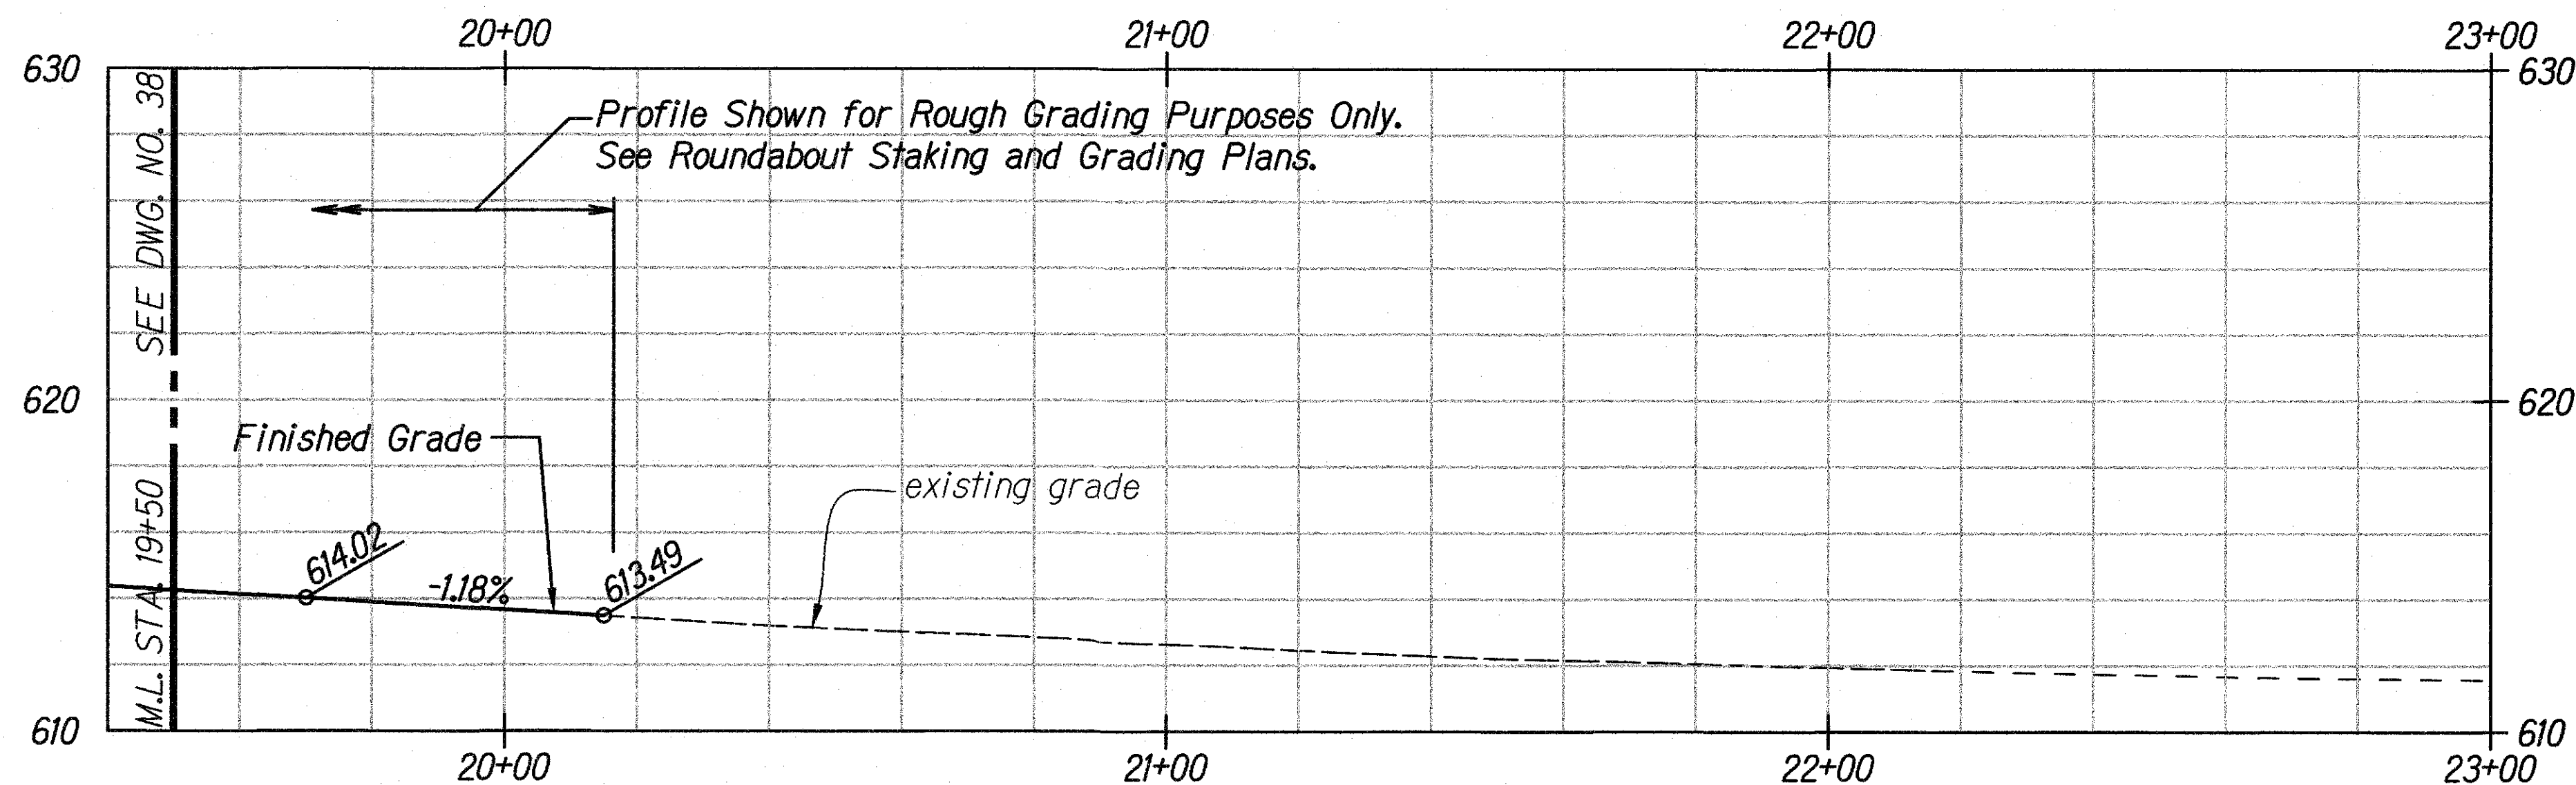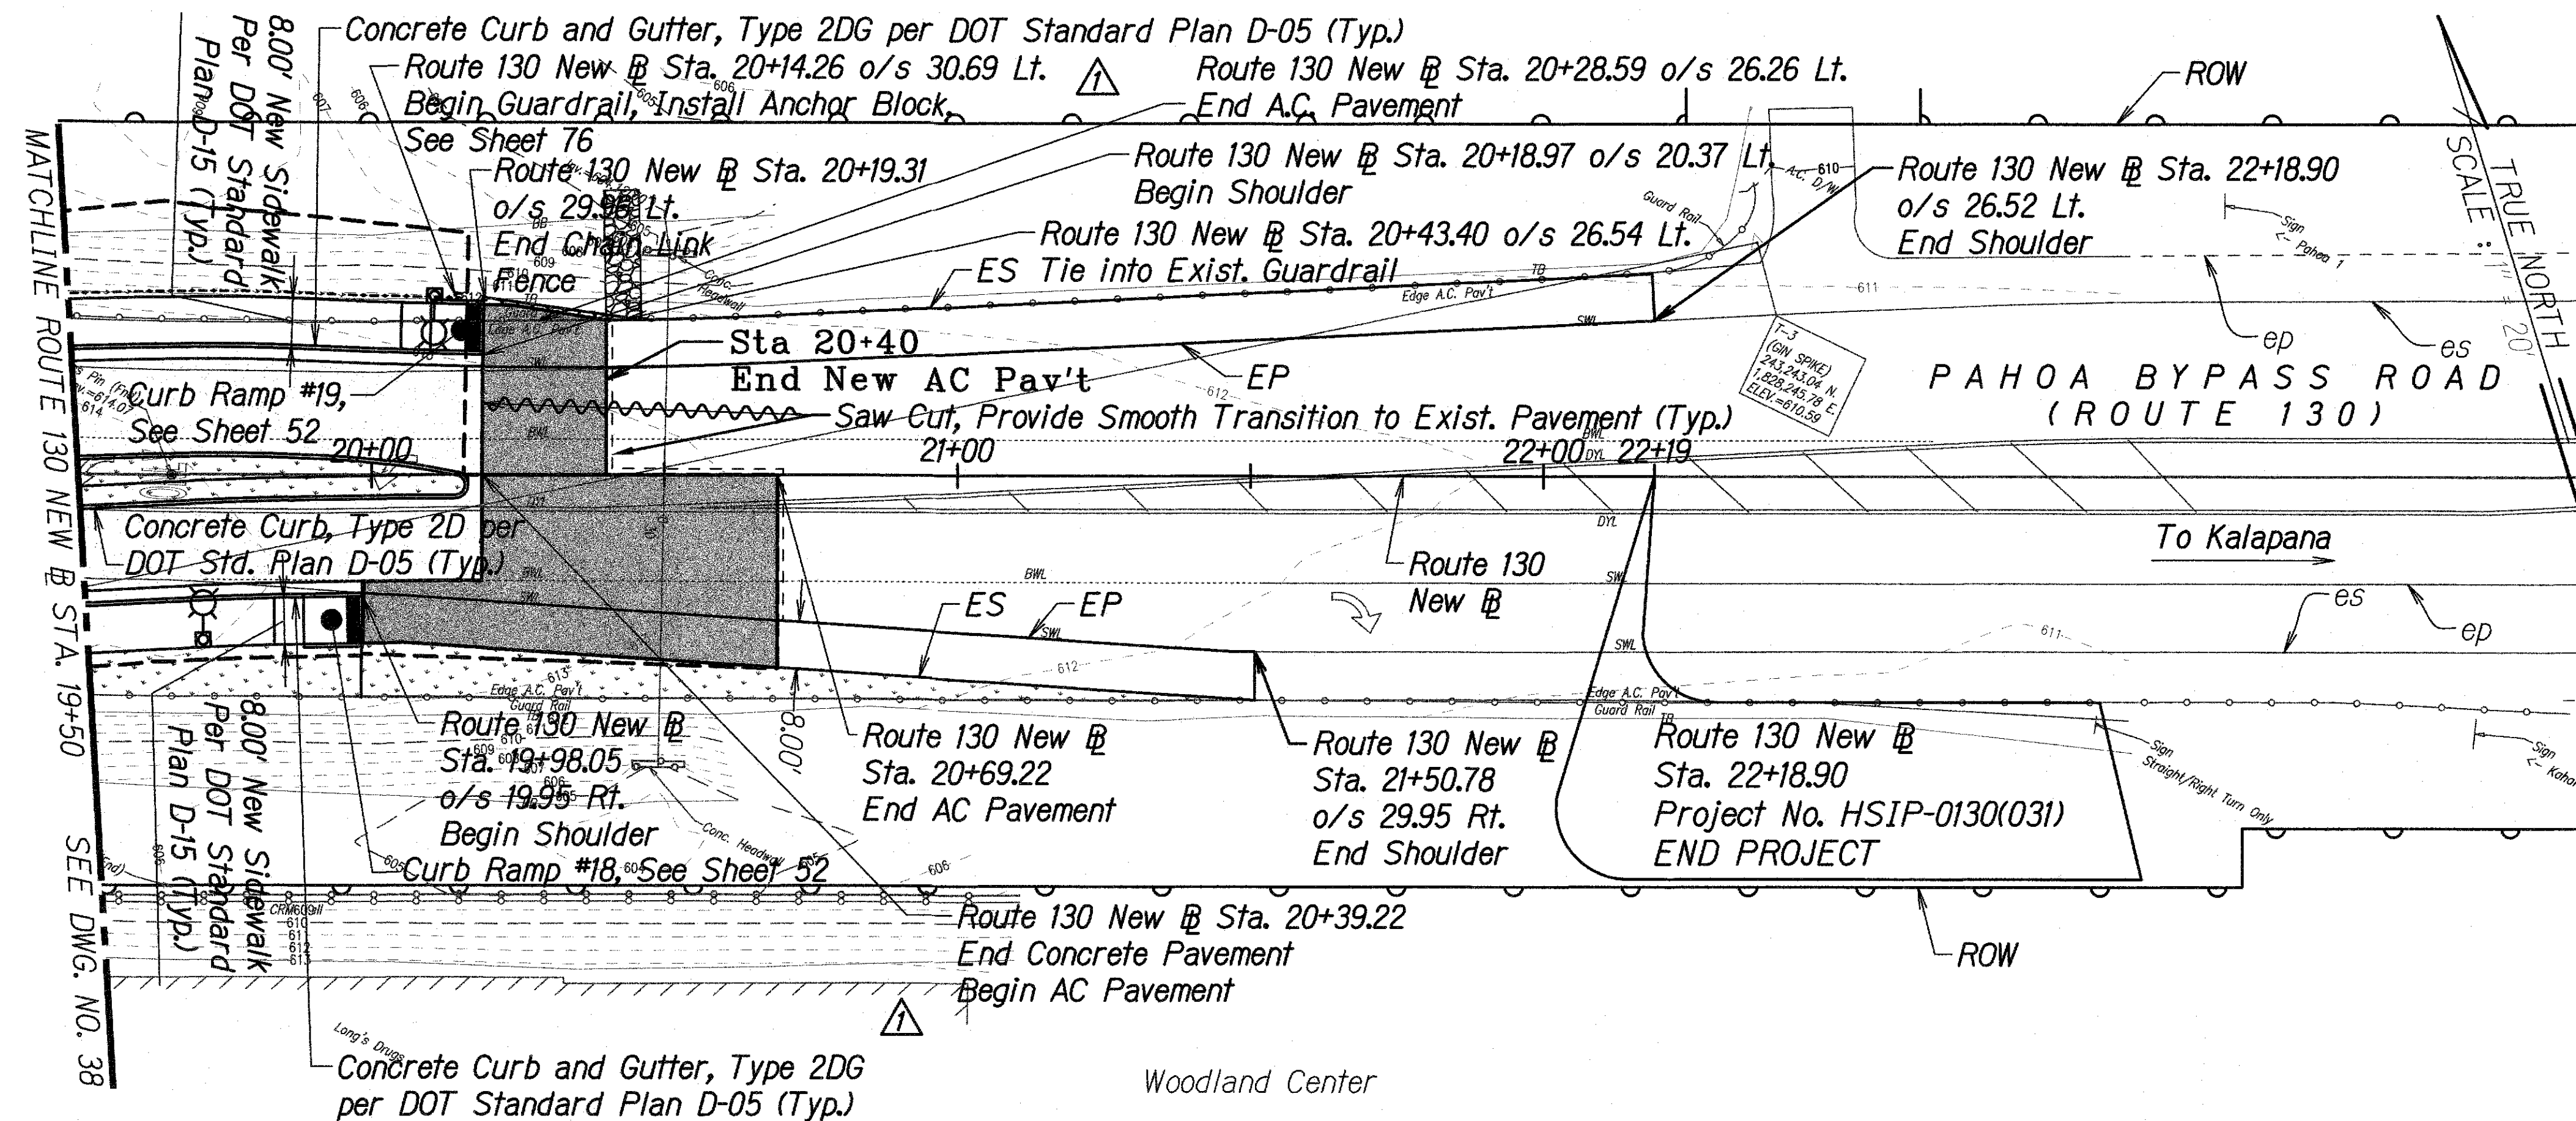

Notes:
1. Spot Elevations on Profile are at 50' Spacing, Typical



LEGEND

- | | | | |
|--|--|--|--|
| | 9.5" Portland Cement Concrete, 6" Untreated Permeable Base, 6" Aggregate Subbase | | Guardrail, See Sheet 74 for Details |
| | 4" Asphaltic Concrete, 7" Asphalt Concrete Base, 6" Aggregate Subbase | | 4'-High Chain Link Fence per HDOT Standard Plan D-02 with 5' max spacing |
| | Sidewalk Culvert, See Sheet 77 for Details | | Right of Way |
| | Truck Apron, See Sheet 25 for Details | | Limits of Grading |

ROADWAY PLAN & PROFILE ROUTE 130 STA 19+50 TO STA 22+00

Horizontal Scale: 1" = 20'
Vertical Scale: 1" = 4'

- | | |
|--|----------------------------------|
| | GRP |
| | Light Pole, See Electrical Plans |
| | Landscaping, See Landscape Plans |

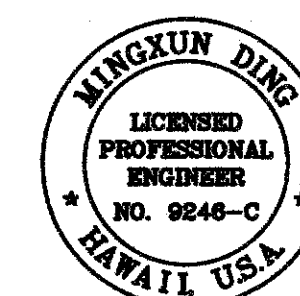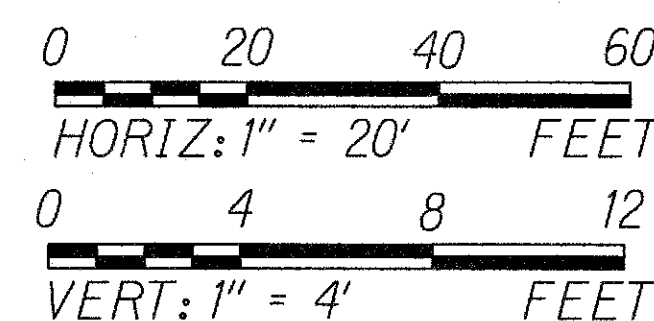

LICENSE EXPIRES 4/30/18
THIS WORK WAS PREPARED BY ME OR UNDER MY SUPERVISION

LEGEND FOR AS-BUILT POSTINGS

- | | |
|--|-------------------------------------|
| | Squiggly line for as-built deletion |
| | Double line for as-built deletion |
| | Roadway Text for as-built posting |

02/07/14		Deleted Callout
02/07/14		Amended Callout to Include Anchor Block Installation

STATE OF HAWAII
DEPARTMENT OF TRANSPORTATION
HIGHWAYS DIVISION
ROADWAY PLAN & PROFILE
ROUTE 130 STA 19+50 TO STA 22+00
Kaaau-Pahoa Road Intersection
Improvements at Old Government Road
Federal-Aid Project No. HSIP-0130(031)


Scale: As Shown Date: August 2013

SHEET No. 3 OF 4 SHEETS

"AS-BUILT"

ADD. 39

FED. ROAD DIST. NO.	STATE	FED. AID PROJ. NO.	FISCAL YEAR	SHEET NO.	TOTAL SHEETS
HAWAII	HAW.	HSIP-0130(031)	2014	40	108

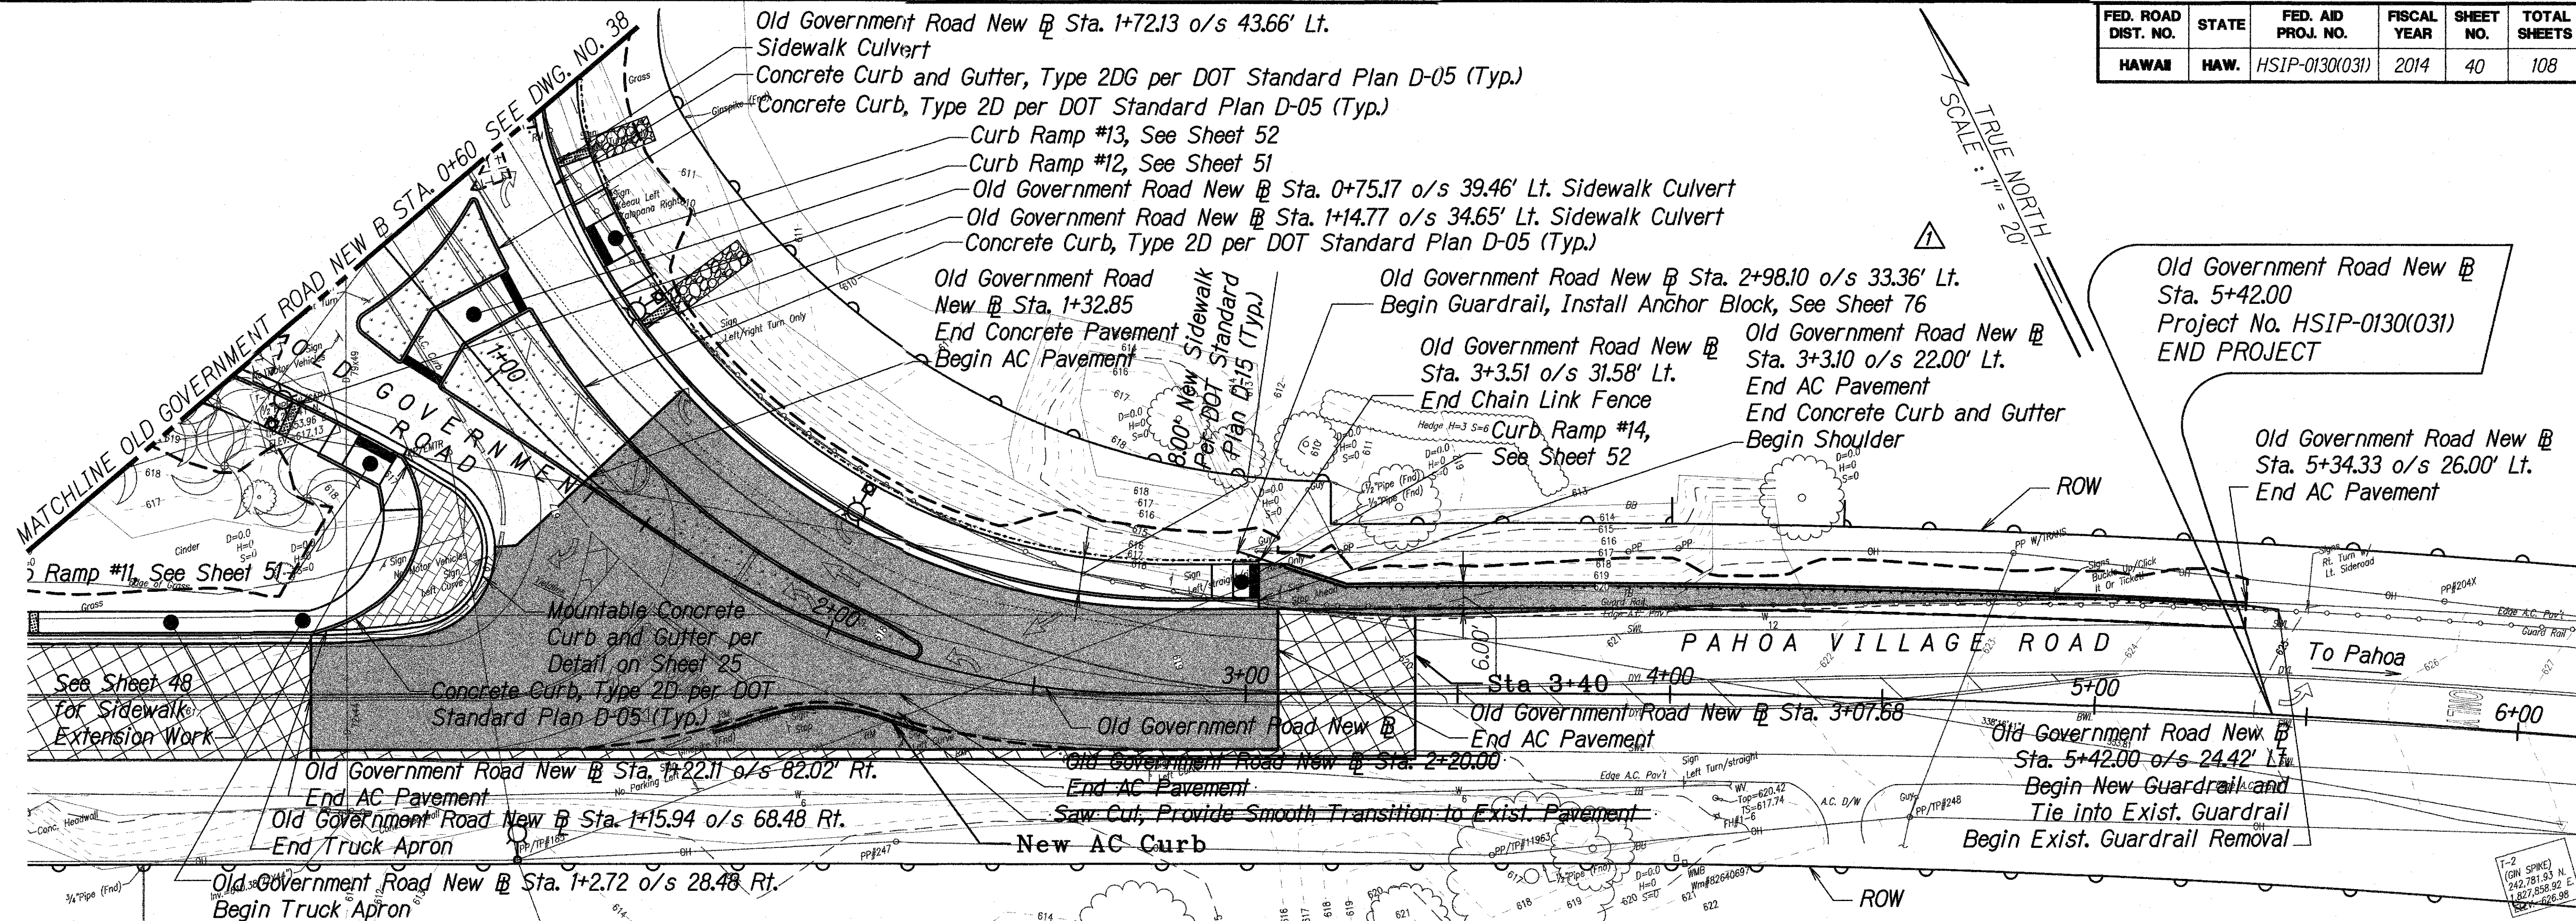

Old Government Road New @ Sta. 5+42.00
Project No. HSIP-0130(031)
END PROJECT

Old Government Road New @ Sta. 5+34.33 o/s 26.00' Lt.
End AC Pavement


Old Government Road New @ Sta. 5+42.00 o/s 24.42' Lt.
Begin New Guardrail and Tie into Exist. Guardrail
Begin Exist. Guardrail Removal

LEGEND FOR AS-BUILT POSTINGS

~~~~~ Squiggly line for as-built deletion

==== Double line for as-built deletion

Roadway Text for as-built posting

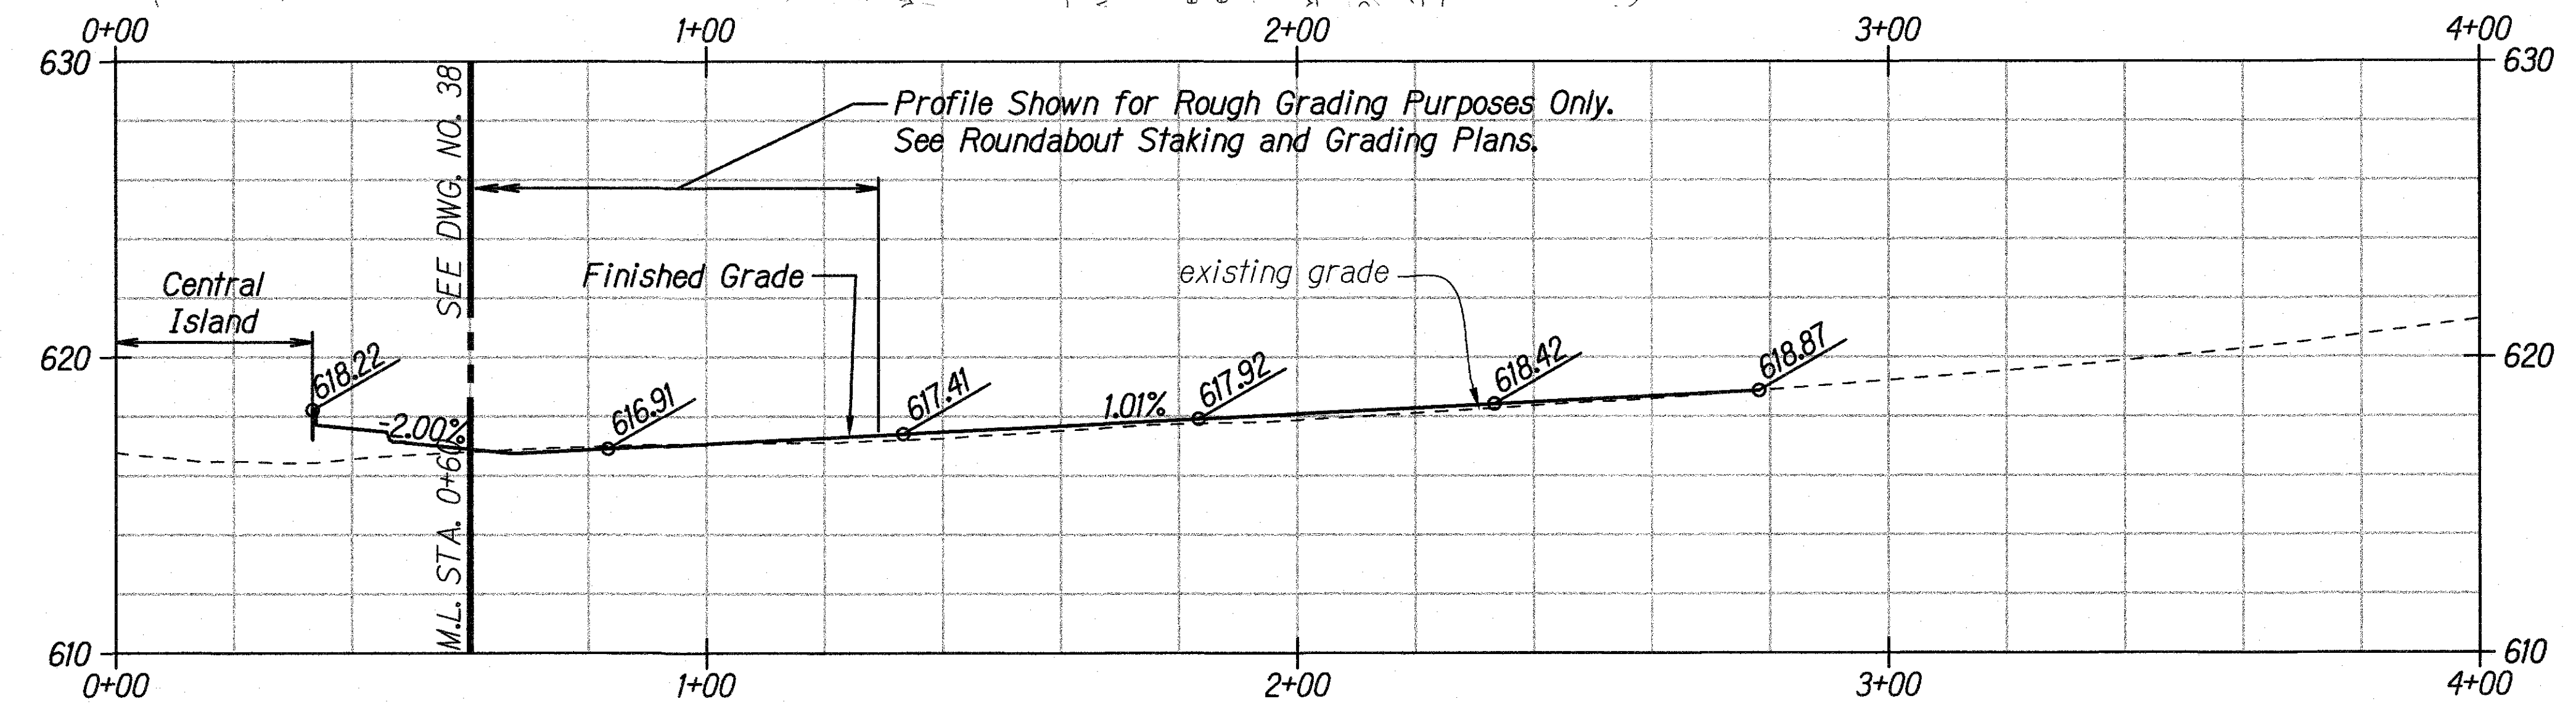

Notes:  
1. Spot Elevations on Profile are at 50' Spacing, Typical

**LEGEND**

|  |                                                                                  |  |                                                                               |
|--|----------------------------------------------------------------------------------|--|-------------------------------------------------------------------------------|
|  | 9.5" Portland Cement Concrete, 6" Untreated Permeable Base, 6" Aggregate Subbase |  | Cold Plane and Repave 2" HMA Pav't, Mix No. IV                                |
|  | 4" Asphaltic Concrete, 7" Asphalt Concrete Base, 6" Aggregate Subbase            |  | Guardrail, See Sheet 74 for Details                                           |
|  | Transition 2" Coldplane, See Sheet 25 for Details                                |  | 4'-High Chain Link Fence per HDOT Standard Plan D-02 with 5' max post spacing |
|  | Sidewalk Culvert, See Sheet 77 for Details                                       |  | Right of Way                                                                  |
|  | Truck Apron, See Sheet 25 for Details                                            |  | Limits of Grading                                                             |



**ROADWAY PLAN & PROFILE**  
**OLD GOV'T ROAD STA 0+60 TO END**

Horizontal Scale: 1" = 20'  
Vertical Scale: 1" = 4'

Riprap

Light Pole, See Electrical Plans

Landscaping, See Landscape Plans

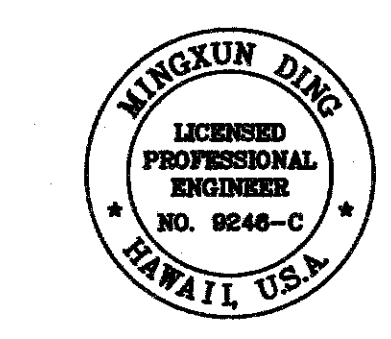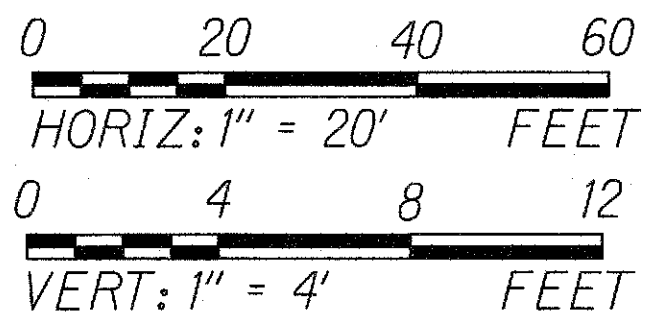

LICENSE EXPIRES 4/30/18  
THIS WORK WAS PREPARED BY ME OR UNDER MY SUPERVISION

02/07/14 Amended Callout to Include Anchor Block Installation

STATE OF HAWAII  
DEPARTMENT OF TRANSPORTATION  
HIGHWAYS DIVISION

**ROADWAY PLAN & PROFILE**  
**OLD GOV'T ROAD STA 0+60 TO END**  
**Keau-Pahoa Road Intersection**  
**Improvements at Old Government Road**  
**Federal-Aid Project No. HSIP-0130(031)**

Scale: As Shown Date: August 2013  
SHEET No. 4 OF 4 SHEETS

"AS-BUILT"

ADD. 40