


DATE  
SURVEY PLOTTED BY  
DRAWN BY  
DESIGNED BY  
NOTED BY  
CHECKED BY  
ORIGINAL  
PLAN  
NOTE BOOK  
No.

INDEX TO DRAWINGS												FED. ROAD DIST. NO.	STATE	PROJ. NO.	FISCAL YEAR	SHEET NO.	TOTAL SHEETS
												HAWAII	HAW.	200A-01-10	2018	2	146
	SHEET NO.	DESCRIPTION		SHEET NO.	DESCRIPTION		SHEET NO.	DESCRIPTION		SHEET NO.	DESCRIPTION		SHEET NO.	DESCRIPTION		SHEET NO.	DESCRIPTION
1	T-1	TITLE SHEET	34	AA1.3	SHOP BUILDING: ROOF PLAN			DLNR CABIN			MECHANICAL	126	EA1.6	SHOP BUILDING: POWER			
2	T-2	INDEX TO DRAWINGS	35	AA1.4	SHOP BUILDING: PARTIAL	65	AE1.1	DLNR CABIN: FLOOR PLAN	95	MO.0	LEGEND AND NOTES			AND SIGNAL ROOF PLAN			
3	T-3	MOUNTING HEIGHTS			DETAIL PLAN	66	AE1.2	DLNR CABIN: REFLECTED CEILING	96	MO.1	EQUIPMENT SCHEDULES	127	EB1.1	FUEL STATION: POWER AND			
4	T-4	MOUNTING HEIGHTS	36	AA1.5	SHOP BUILDING: PARTIAL			PLAN	97	MO.2	MECHANICAL SITE PLAN			SIGNAL PLAN			
					DETAIL PLAN	67	AE2.1	DLNR CABIN: INTERIOR ELEVATIONS	98	MO.3	DETAILS	128	EB1.2	FUEL STATION: LIGHTING			
		CIVIL	37	AA2.1	SHOP BUILDING: EXTERIOR	68	AE2.2	DLNR CABIN: INTERIOR ELEVATIONS	99	MO.4	DETAILS			PLAN			
5	C-1	LEGEND, ABBREVIATIONS,			ELEVATIONS	69	AE2.3	DLNR CABIN: EXTERIOR ELEVATIONS	100	MA1.1	SHOP BUILDING PLUMBING	129	EC1.1	DLNR CABIN: POWER AND			
		INDEX TO CIVIL DRAWINGS	38	AA2.2	SHOP BUILDING: CROSS	70	AE3.1	DLNR CABIN: ROOF PLAN	101	MA1.2	SHOP BUILDING PLUMBING			SIGNAL PLAN			
6	C-2	GENERAL NOTES			SECTION, EXTERIOR ELEVATION	71	AE4.1	DLNR CABIN: BUILDING SECTIONS	102	MA1.3	SHOP BUILDING RAINWATER	130	EC1.2	DLNR CABIN: LIGHTING PLAN			
7	C-3	WATER POLLUTION & EROSION	39	AA2.3	SHOP BUILDING: INTERIOR	72	AE4.2	DLNR CABIN: ROOF DETAILS			COLLECTION PLANS	131	E2.1	ONE LINE DIAGRAM I			
		CONTROL NOTES - 1			ELEVATIONS	73	AE6.1	DLNR CABIN: MILLWORK DETAILS	103	MA1.4	SHOP BUILDING RAINWATER	132	E2.2	ONE LINE DIAGRAM II			
8	C-4	WATER POLLUTION & EROSION	40	AA2.4	SHOP BUILDING: INTERIOR	74	AE7.1	DLNR CABIN: DOOR & WINDOW			COLLECTION SCHEMATIC	133	E2.3	THREE LINE DIAGRAM I			
		CONTROL NOTES - 2			ELEVATIONS			TYPES, DOOR DETAILS	104	MA2.1	SHOP BUILDING ACV	134	E2.4	HELCO DETAILS			
9	C-5	WATER POLLUTION & EROSION	41	AA2.5	SHOP BUILDING: INTERIOR	75	AE7.2	DLNR CABIN: WINDOW DETAILS	105	MA2.2	SHOP BUILDING ACV	135	E2.5	ROOF DETAILS			
		CONTROL NOTES - 3			ELEVATIONS	76	AE7.3	DLNR CABIN: DOOR & WINDOW	106	MA3.1	DIAGRAMS	136	E2.6	DETAILS AND DUCT SECTIONS			
10	C-6	BEST MANAEMENT PRACTICE	42	AA4.1	SHOP BUILDING: DETAILS,			SCHEDULES	107	MA3.2	DIAGRAMS	137	E2.7	AREA LIGHT DETAILS			
		& GRADING NOTES			PARTITION TYPES				108	MA3.3	DIAGRAMS	138	E2.8	ELEVATION DETAILS			
11	C-7	WATER NOTES	43	AA4.2	SHOP BUILDING: PARTITION TYPES			STRUCTURAL	109	MA3.4	DIAGRAMS	139	E2.9	PANEL SCHEDULES			
12	C-8	GENERAL PLAN	44	AA4.3	SHOP BUILDING: STAIR SECTIONS	77	SO.1	GENERAL NOTES	110	MB1.1	FUELING STATION						
13	C-9	EROSION CONTROL PLAN			& DETAILS	78	SO.2	GENERAL NOTES	111	MB2.1	FUELING DETAILS			LANDSCAPING			
14	C-10	TYPICAL SECTIONS	45	AA5.1	DOOR DETAILS	79	SO.3	GENERAL NOTES	112	ME1.1	DLNR CABIN: PLUMBING	140	L-1	PLANTING NOTES			
15	C-11	EXISTING CONDITIONS AND	46	AA5.2	DOOR & WINDOW DETAILS	80	SO.4	TYPICAL DETAILS	113	ME2.1	DIAGRAMS	141	L-2	TREE PROTECTING DETAIL			
		REMOVAL PLAN	47	AA5.3	SHOP BUILDING: ROOF DETAILS	81	SO.5	TYPICAL DETAILS				142	L-3	TREE RELOCATION - 1			
16	C-12	SITE PLAN	48	AA5.4	SHOP BUILDING: ROOF DETAILS	82	SO.6	TYPICAL DETAILS			ELECTRICAL	143	L-4	TREE RELOCATION - 2			
17	C-13	UTILITY PLAN	49	AA6.1	SHOP BUILDING: DOOR &	83	SA1.1	SHOP BUILDING: 1ST FLOOR	114	E0.1	SYMBOLS, ABBREVIATIONS,	144	L-5	PLANTING DETAILS			
18	C-14	GRADING & DRAINAGE PLAN			WINDOW SCHEDULES			FOUNDATION PLAN			GENERAL NOTES	145	L-6	TREE DISPOSITION PLAN			
19	C-15	CABIN SITE & UTILITY PLAN	50	AA6.2	SHOP BUILDING: DOOR &	84	SA1.2	SHOP BUILDING: MEZZANINE	115	E0.2	NOTES	146	L-7	PLANTING PLAN			
		(ADDITIVE ALTERNATE)			WINDOW TYPES			STORAGE FRAMING PLAN	116	E0.3	NOTES						
20	C-16	CABIN GRADING & DRAINAGE	51	AA7.1	SHOP BUILDING: MILLWORK	85	SA1.3	SHOP BUILDING: ROOF FRAMING	117	E0.4	NOTES						
		PLAN (ADDITIVE ALTERNATE)			DETAILS			PLAN	118	E0.5	NOTES						
21	C-17	PLAN & PROFILE ACCESS	52	AA8.1	SHOP BUILDING: SIGNAGE	86	SA2.1	SHOP BUILDING: BUILDING	119	E1.1	ELECTRICAL SITE						
		ROAD - 1			DETAILS			SECTIONS, DETAILS			DEMOLITION PLAN						
22	C-18	PLAN & PROFILE ACCESS	53	AB1.1	FUEL PUMPS: FLOOR PLAN	87	SA3.1	SHOP BUILDING: SCHEDULES,	120	E1.2	SITE PLAN						
		ROAD - 2	54	AB1.2	FUEL PUMPS: ROOF PLAN			DETAILS	121	EA1.1	SHOP BUILDING: 1ST FLOOR						
23	C-19	PLAN & PROFILE ACCESS	55	AB1.3	FUEL PUMPS: ELEVATION	88	SB1.1	FUELING STATION AND PUMPS:			POWER AND SIGNAL PLAN I						
		ROAD - 3	56	AB1.4	FUEL PUMPS: CROSS SECTION			FOUNDATION PLANS, ROOF	122	EA1.2	SHOP BUILDING: 1ST FLOOR						
24	C-20	PROFILE - CABIN ACCESS ROAD	57	AB2.1	FUEL TANKS: FLOOR PLAN	89	SB2.1	FRAMING PLANS			POWER AND SIGNAL PLAN II						
		(ADDITIVE ALTERNATE)	58	AB2.2	FUEL TANKS: ROOF PLAN			SECTIONS, DETAILS	123	EA1.3	SHOP BUILDING: 1ST FLOOR						
25	C-21	UTILITY PROFILES	59	AB2.3	FUEL TANKS: ELEVATION,	90	SC1.1	AGGREGATE STORAGE BINS:			LIGHTING PLAN						
26	C-22	DETAILS - 1			GENERAL NOTES			FOUNDATION, SECTION AND	124	EA1.4	SHOP BUILDING: MEZZANINE						
27	C-23	DETAILS - 2	60	AB2.4	FUEL TANKS: CROSS SECTION,			DETAILS			POWER AND SIGNAL PLAN						
28	C-24	DETAILS - 3			END ELEVATION	91	SD1.1	FLAMMABLE STORAGE BUILDING:	125	EA1.5	SHOP BUILDING: MEZZANINE						
29	C-25	DETAILS - 4	61	AC1.1	STORAGE BIN: FLOOR PLAN,			FOUNDATION PLAN, ROOF PLAN			LIGHTING PLAN						
30	C-26	CROSS SECTIONS			CROSS SECTION	92	SE1.1	DLNR CABIN: FOUNDATION PLAN,									
			62	AC1.2	WASHDOWN SLAB: FLOOR PLAN,			ROOF PLAN, BUILDING SECTIONS									
		ARCHITECTURAL			CORNER GUARD DETAIL	93	SE2.1	DLNR CABIN: FRAMING SECTIONS									
31	AA1.0	ARCHITECTURAL SITE PLAN,	63	AD1.1	FLAMMABLE STORAGE BUILDING:			AND DETAILS									
		GENERAL NOTES			ELEVATIONS, SECTION	94	SE3.1	DLNR CABIN: TRUSS ELEVATION,									
32	AA1.1	SHOP BUILDING: FLOOR PLAN	64	AD1.2	DETAILS			SHEARWALL FRAMING ELEVATION,									
33	AA1.2	SHOP BUILDING: PARTIAL						SHEARWALL SHEATHING ELEVATION									
		FLOOR PLAN, PARTIAL REFLECTED															
		CEILING PLAN															

T-2

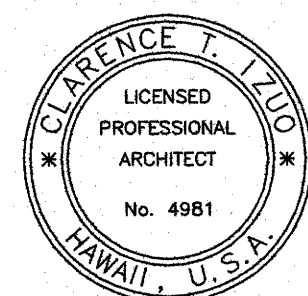


Signature: *Clarence T. Ito*  
EXP. DATE OF THE LICENSE: 04-30-20  
THIS WORK WAS PREPARED BY  
ME OR UNDER MY SUPERVISION

STATE OF HAWAII  
DEPARTMENT OF TRANSPORTATION  
HIGHWAYS DIVISION  
**INDEX TO DRAWINGS**  
**MAUNA KEA MAINTENANCE**  
**BASEYARD**  
**DANIEL K. INOUE HIGHWAY**


Project No. 200A-01-10  
Scale: No scale Date: April 2018  
SHEET No. T-2 OF 4 SHEETS




FED. ROAD DIST. NO.	STATE	PROJ. NO.	FISCAL YEAR	SHEET NO.	TOTAL SHEETS
HAWAII	HAW.	200A-01-10	2018	3	146

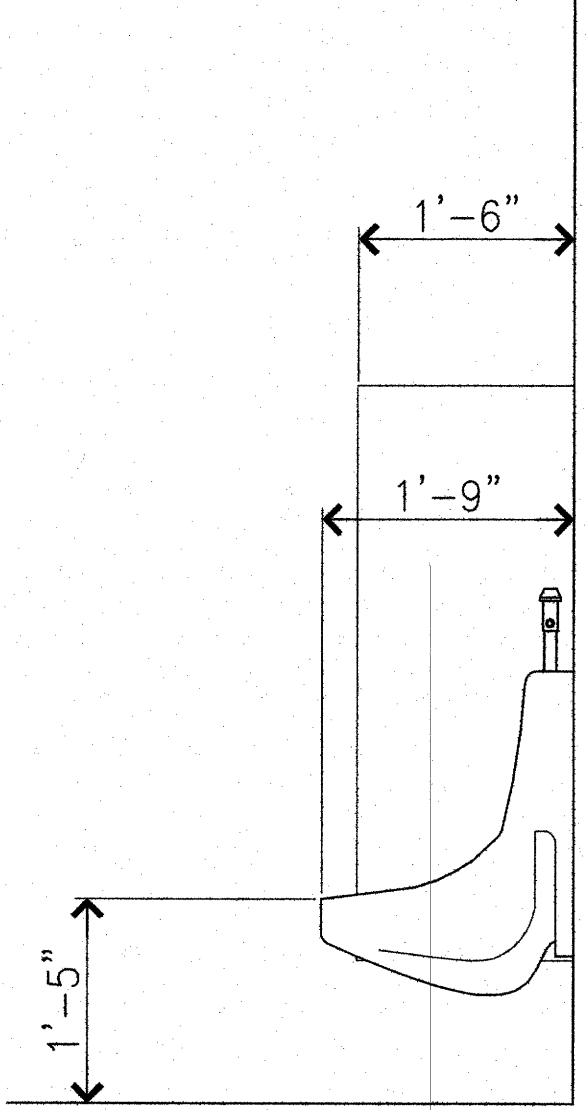


ACCESSIBLE URINAL  
(ELONGATED)  
SIDE ELEVATION

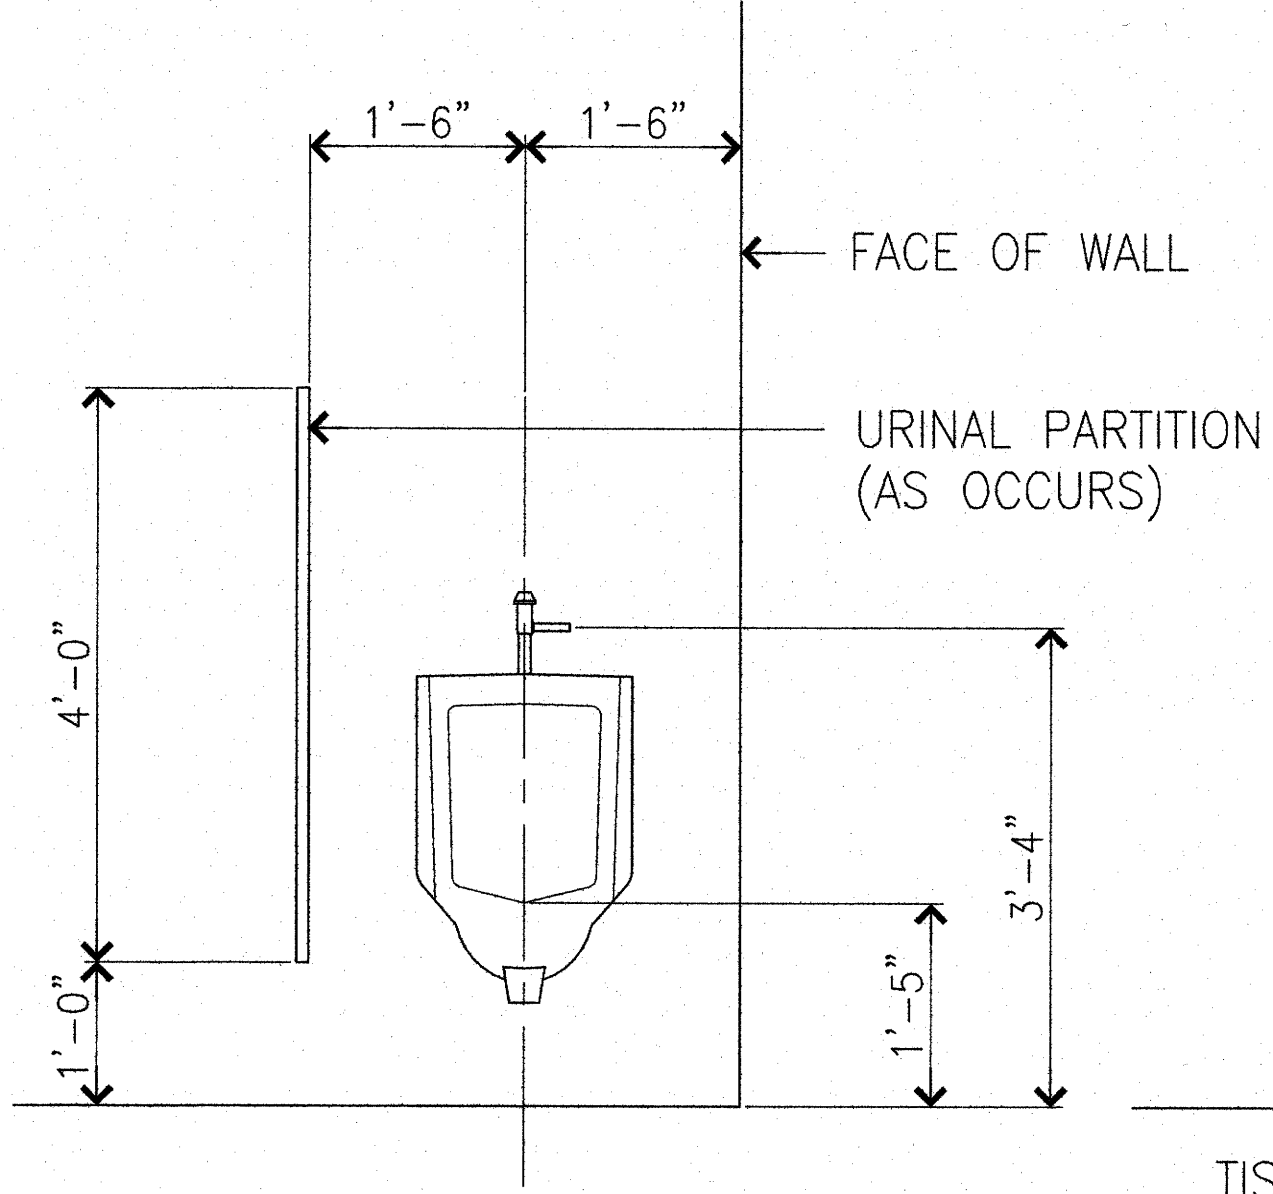


ACCESSIBLE URINAL  
(ELONGATED)  
FRONT ELEVATION

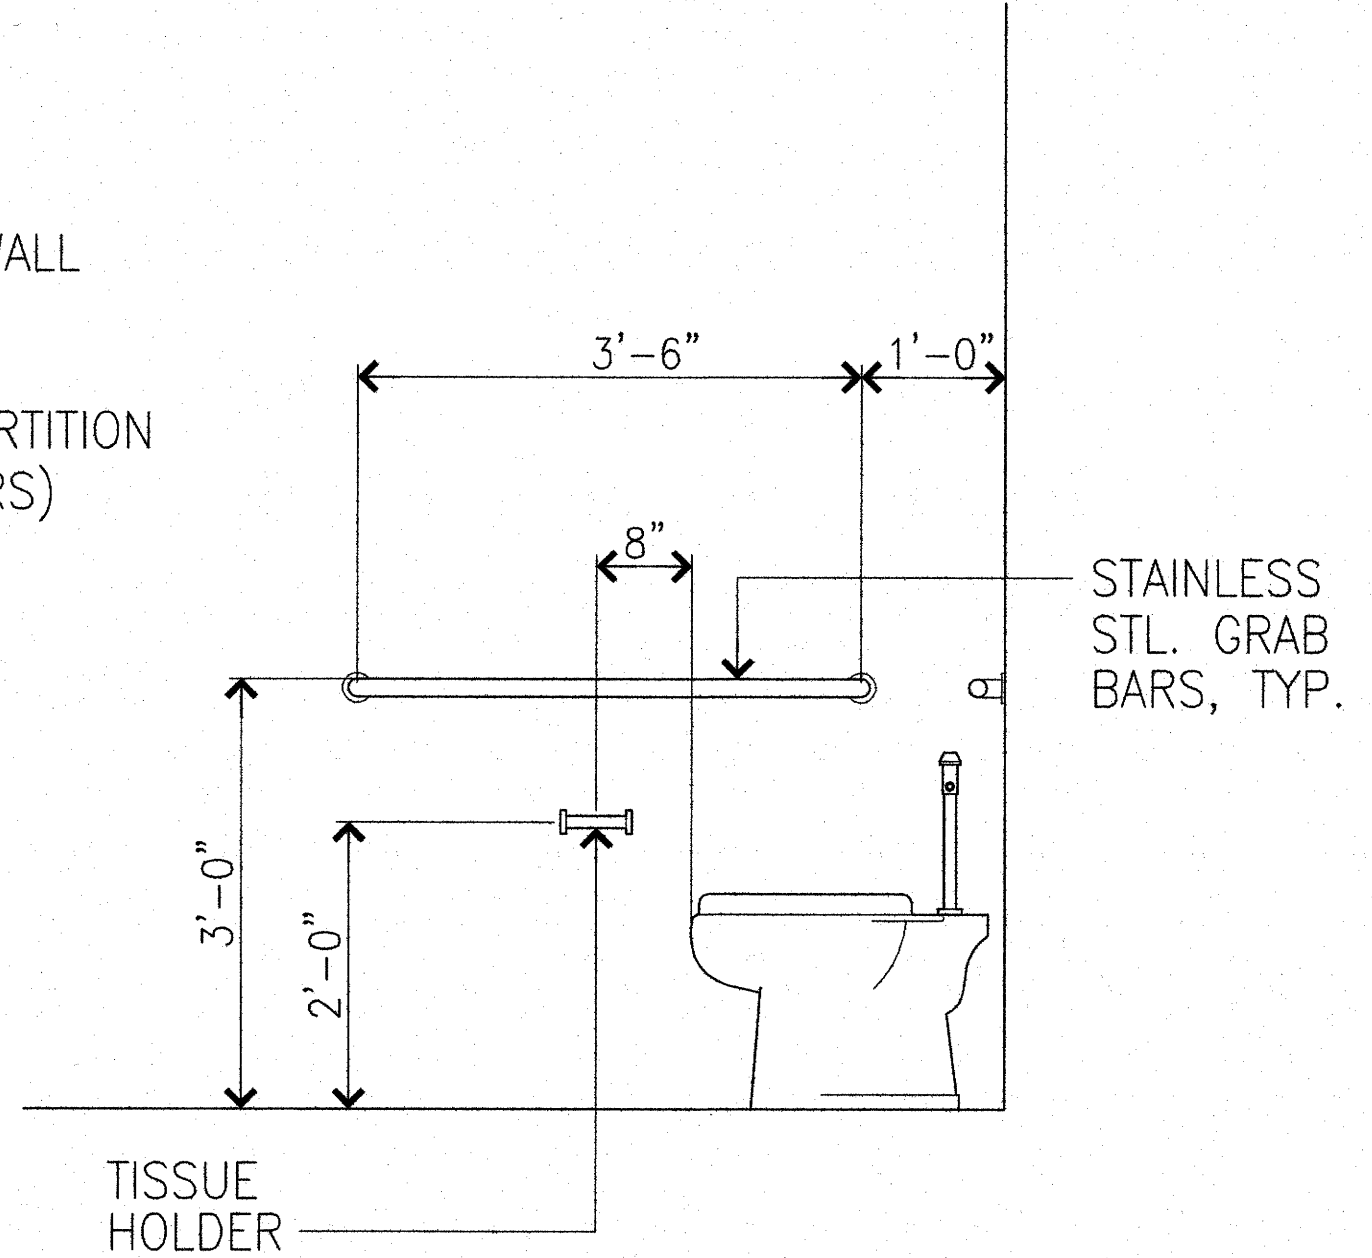


ACCESSIBLE TOILET  
SIDE ELEVATION

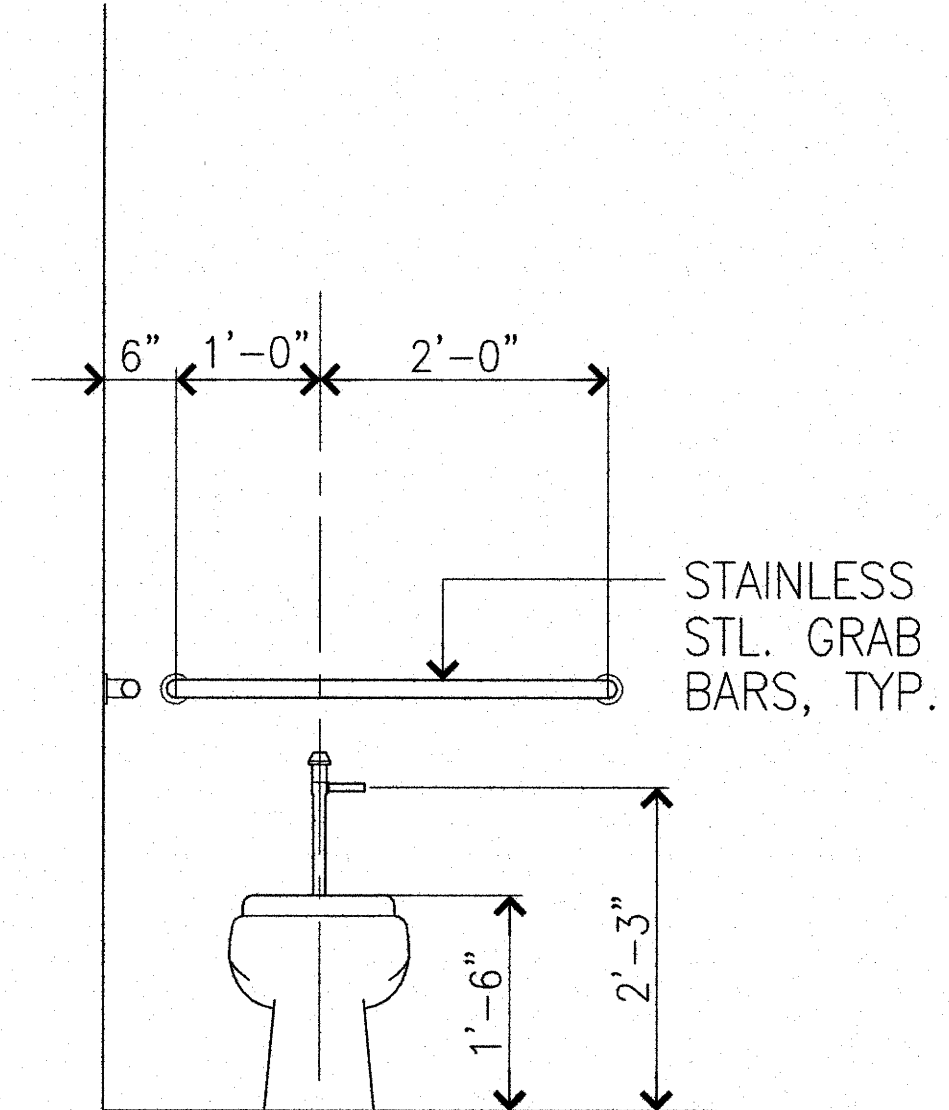


ACCESSIBLE TOILET  
FRONT ELEVATION

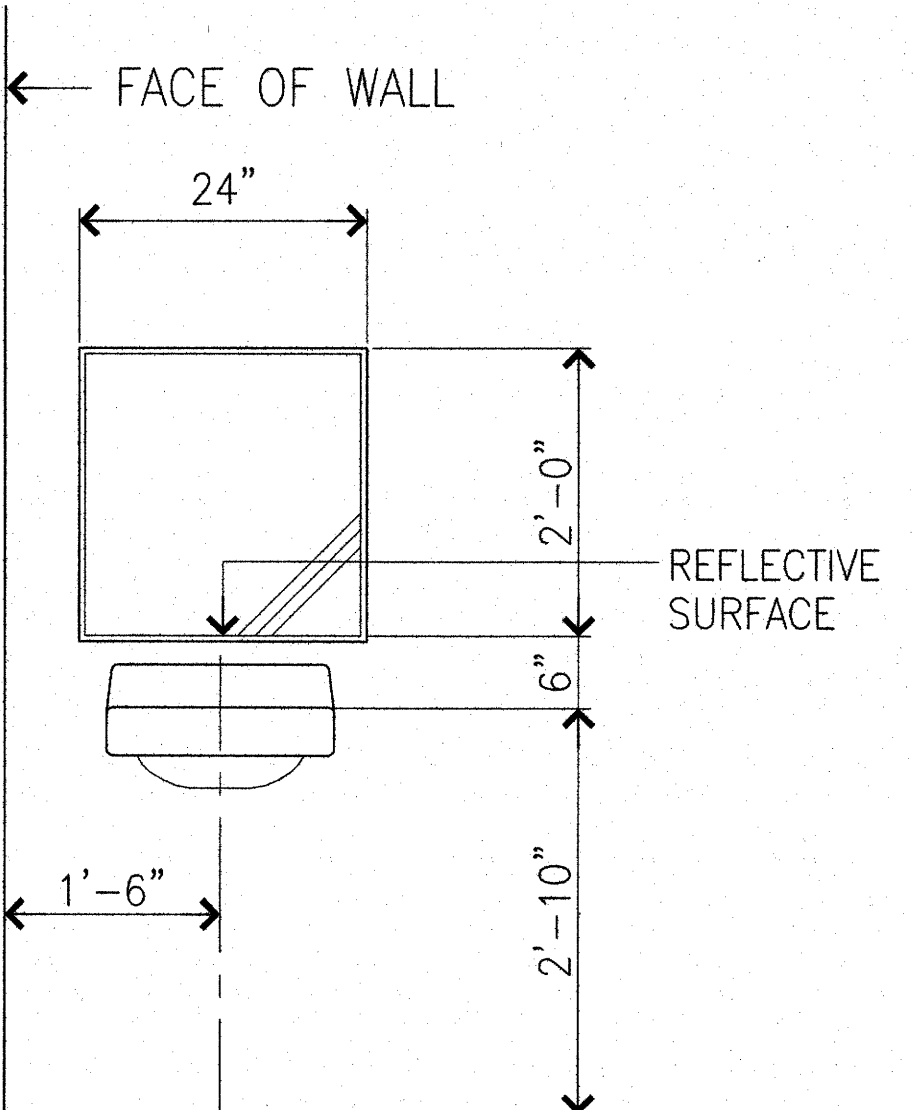


STANDARD LAV & MIRROR  
FRONT ELEVATION

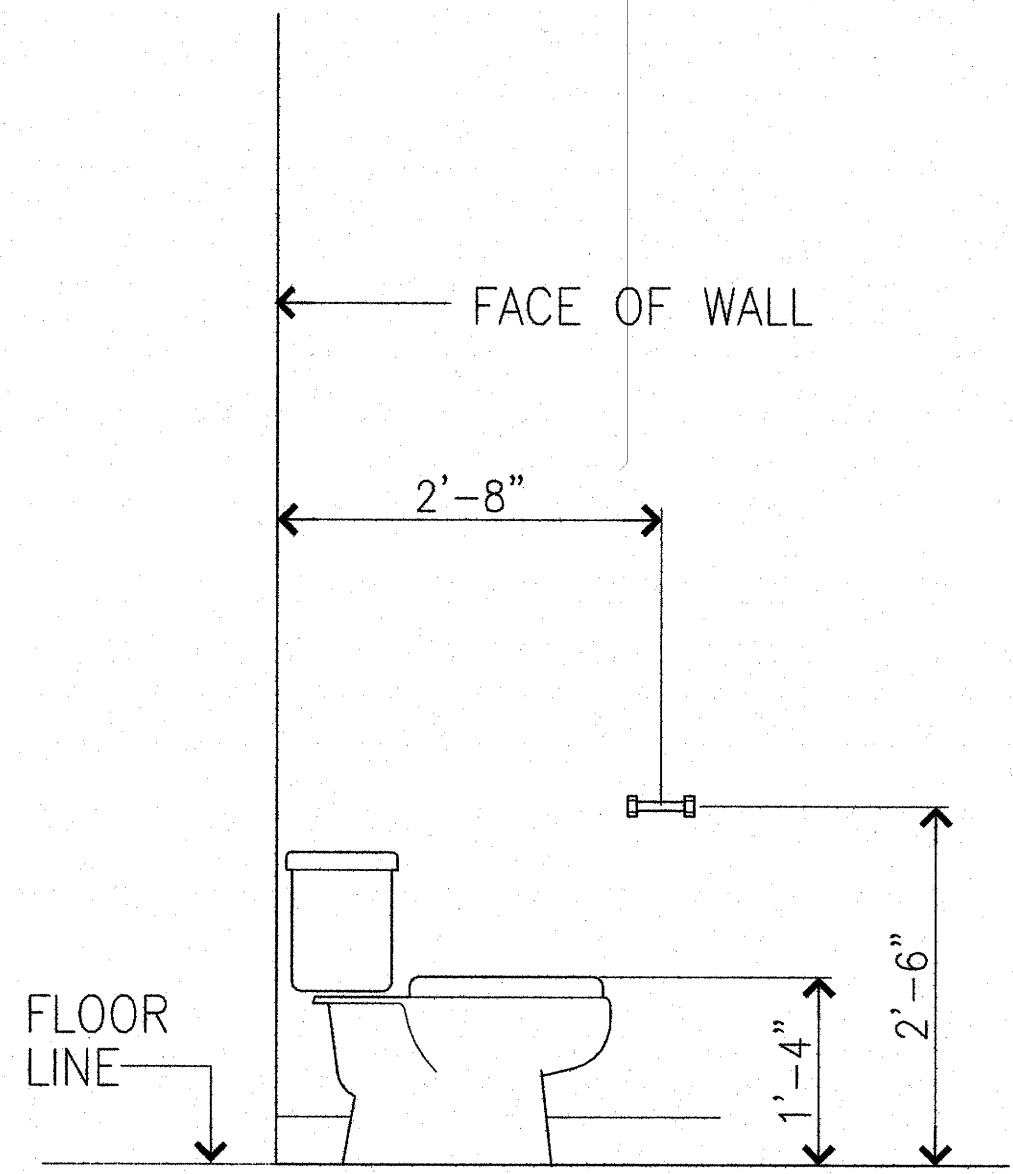


STANDARD WATER  
CLOSET SIDE  
ELEVATION

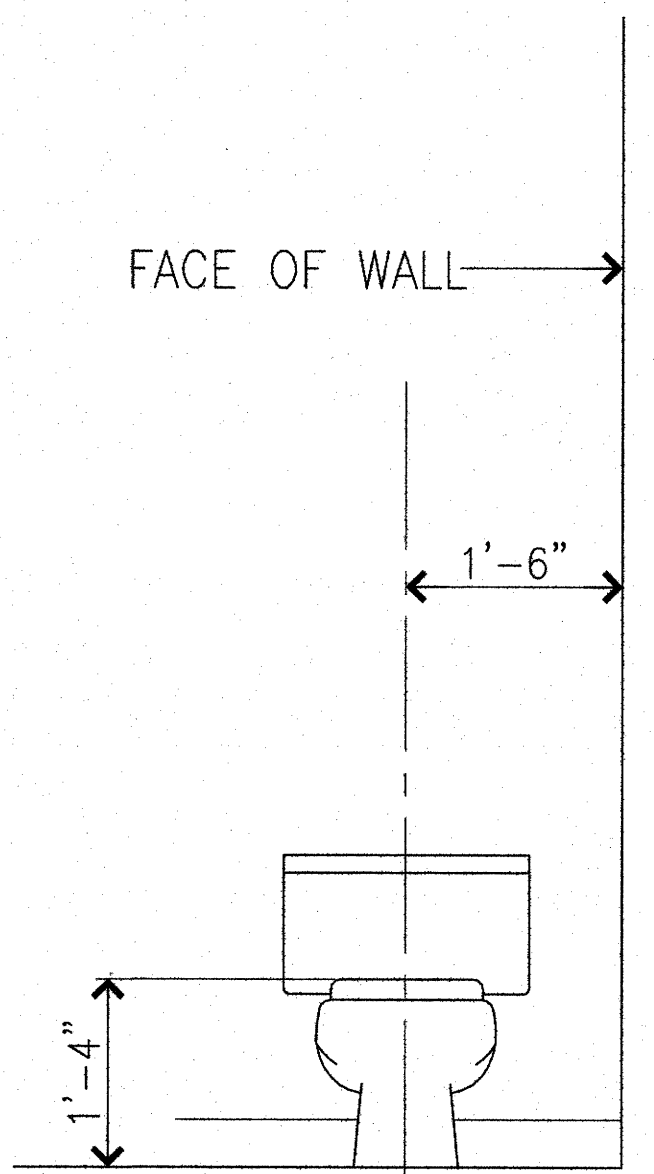


STANDARD WATER CLOSET  
FRONT ELEVATION

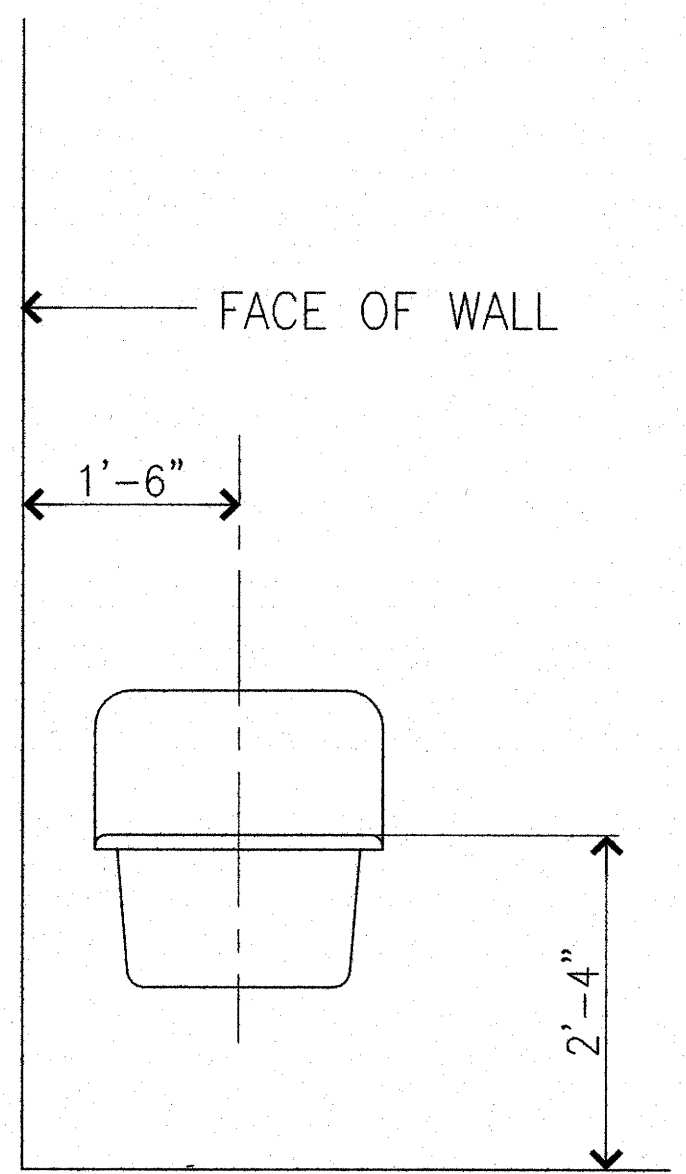


STANDARD UTILITY SINK  
FRONT ELEVATION

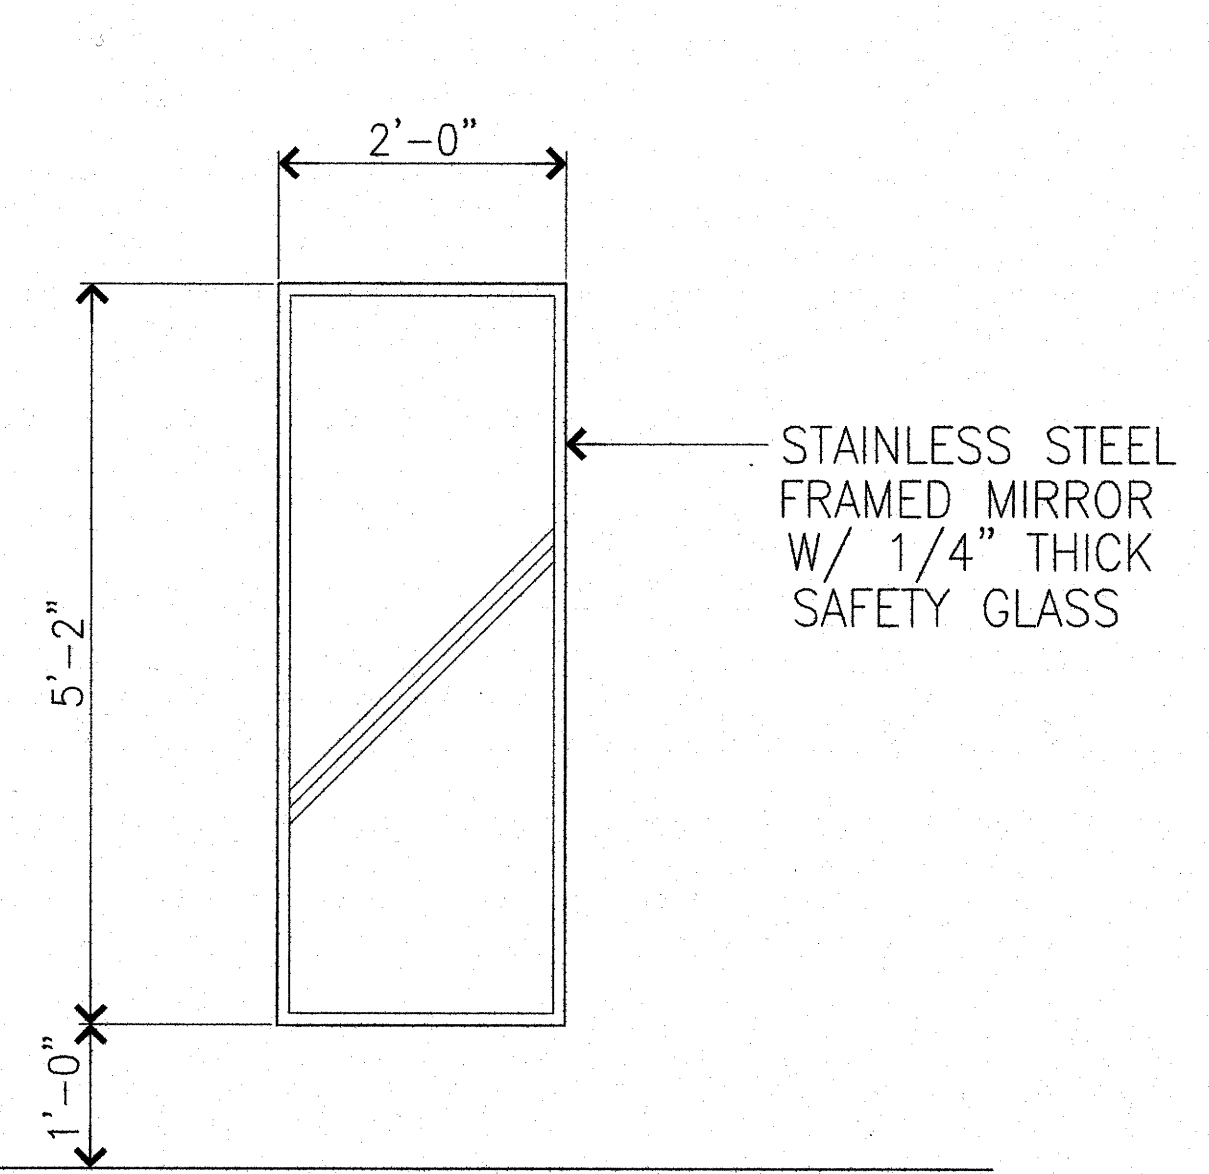

ACCESSIBLE MIRROR  
FRONT ELEVATION

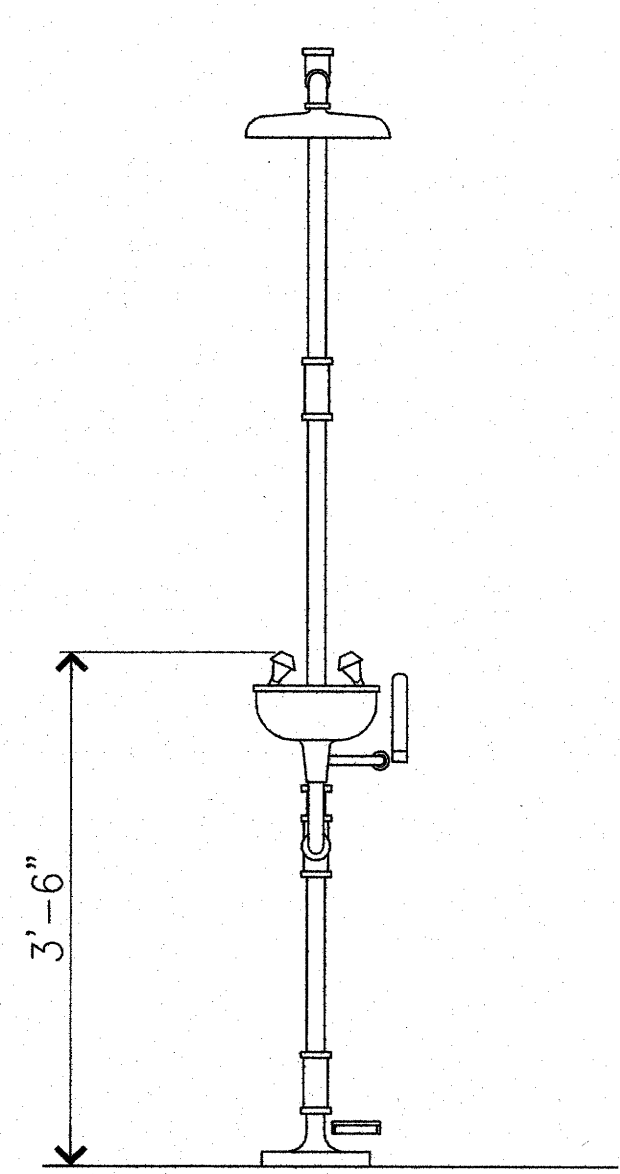


EMERGENCY SHOWER/EYEWASH  
FRONT ELEVATION

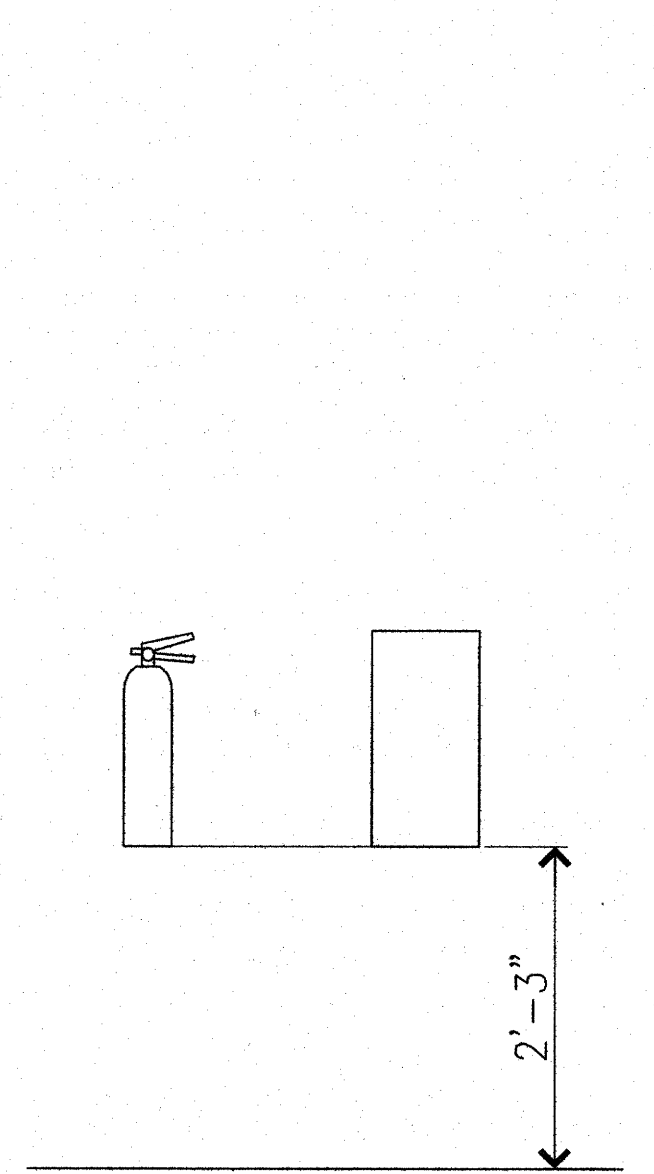


FIRE EXTINGUISHER &  
FIRE EXTINGUISHER CABINET

SURVEY PLOTTED BY	DATE
DESIGNED BY	
TRACED BY	
DESIGNED BY	
QUANTITIES BY	
CHECKED BY	
ORIGINAL PLAN	No.
NOTE BOOK	

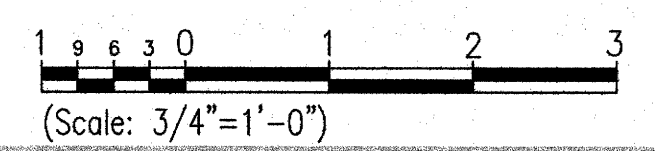

T-3

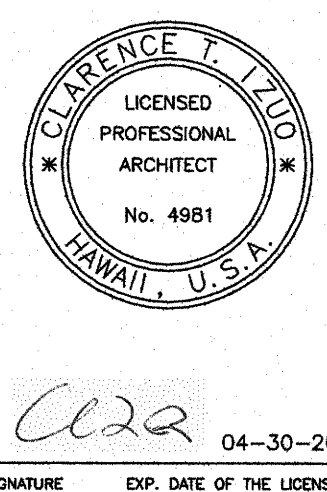


Signature: *CLT*  
EXP. DATE OF THE LICENSE: 04-30-20  
THIS WORK WAS PREPARED BY ME OR UNDER MY SUPERVISION

STATE OF HAWAII  
DEPARTMENT OF TRANSPORTATION  
HIGHWAYS DIVISION  
**MOUNTING HEIGHTS**  
MAUNA KEA MAINTENANCE  
BASEYARD  
DANIEL K. INOUE HIGHWAY

Project No. 200A-01-10  
Scale: 3/4" = 1'-0" Date: April 2018  
SHEET No. T-3 OF 4 SHEETS


FED. ROAD DIST. NO.	STATE	PROJ. NO.	FISCAL YEAR	SHEET NO.	TOTAL SHEETS
HAWAII	HAW.	200A-01-10	2018	4	146

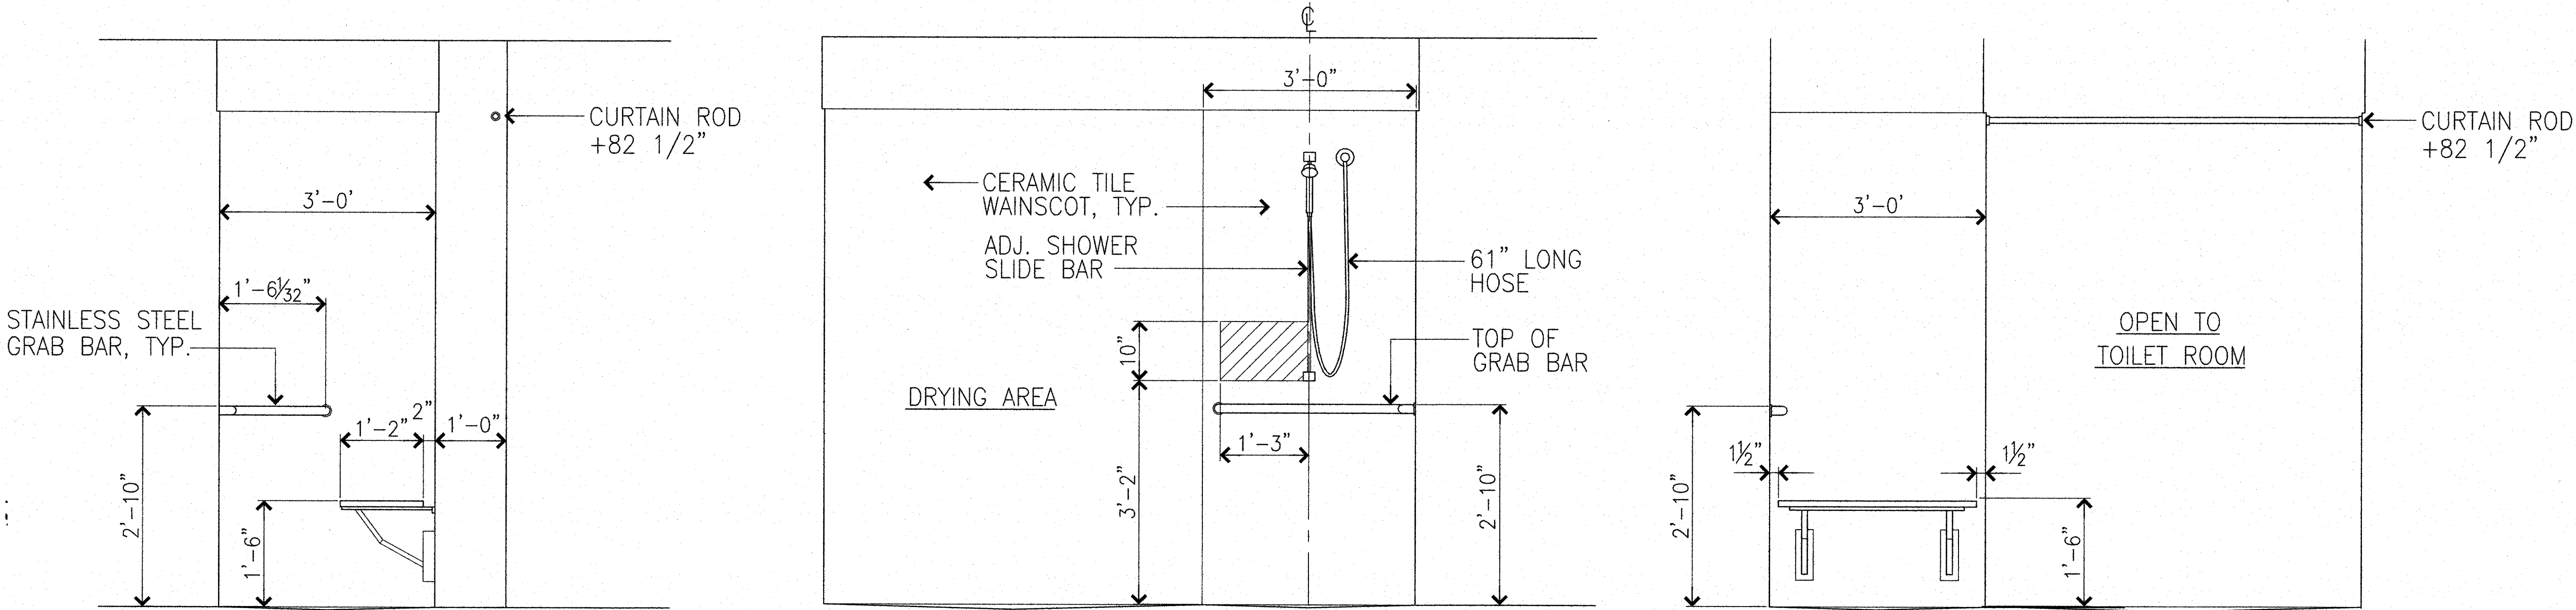

ACCESSIBLE TRANSFER SHOWER  
FRONT ELEVATION


ACCESSIBLE TRANSFER SHOWER  
CONTROL WALL

ACCESSIBLE TRANSFER SHOWER  
SEAT WALL

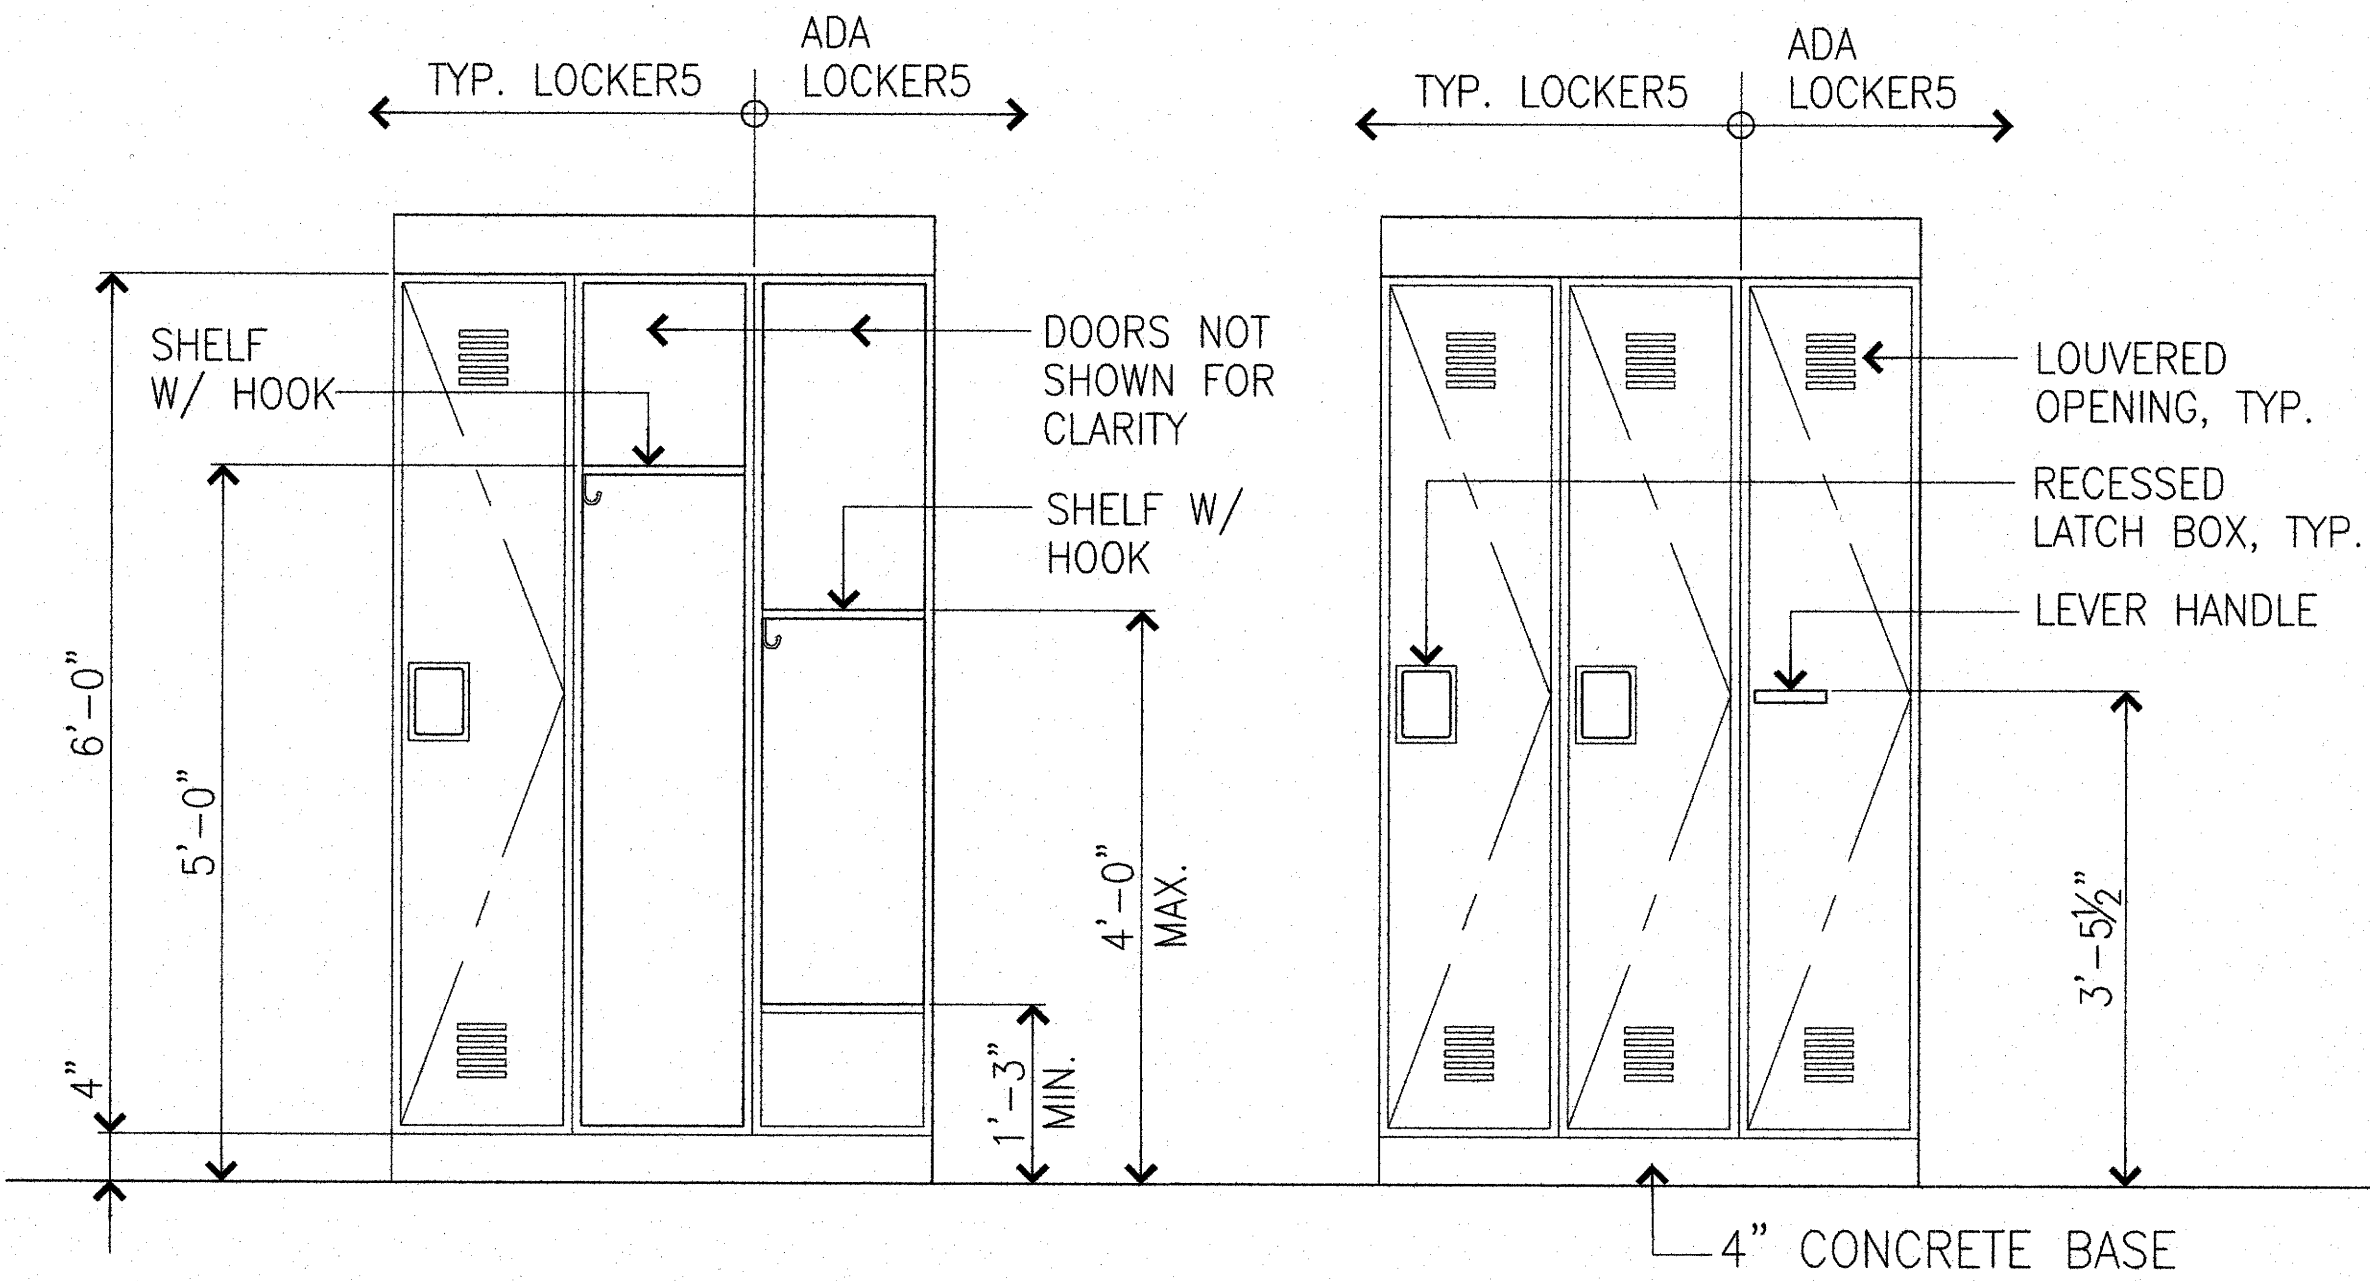


STANDARD LOCKER  
FRONT ELEVATION

ACCESSIBLE LOCKER  
FRONT ELEVATION

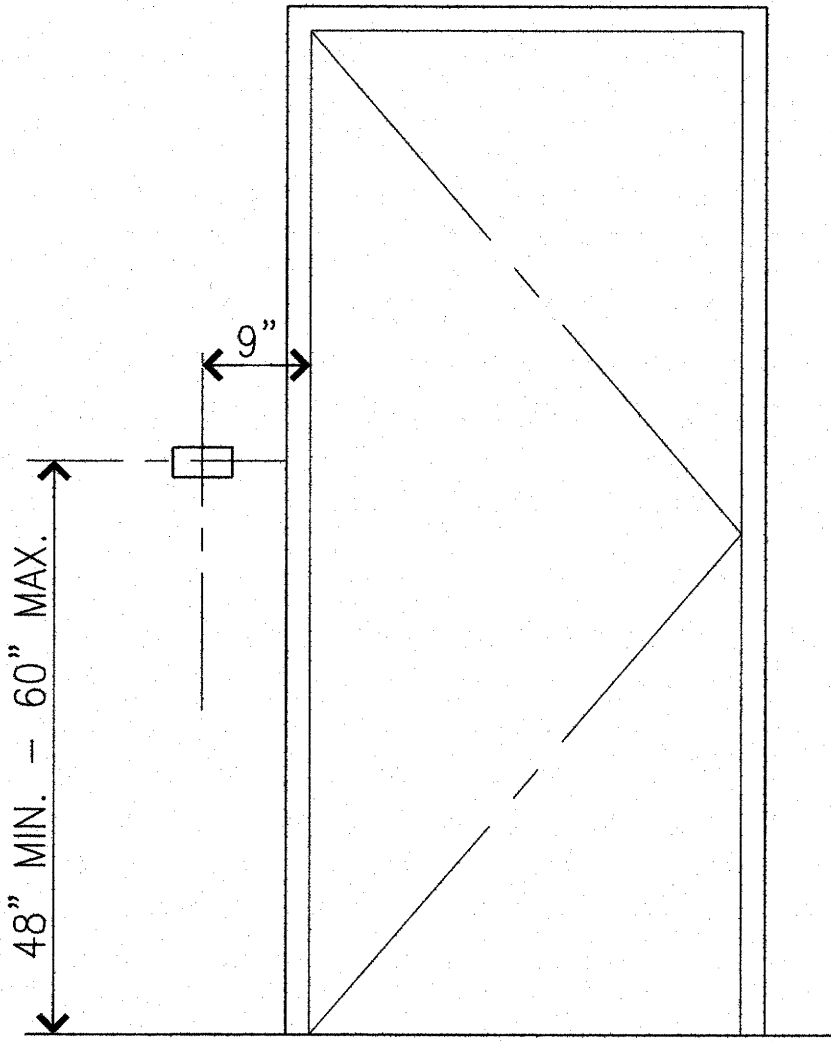

SIGNAGE HEIGHT

SURVEY PLOTTED BY	DATE
DRAWN BY	
DESIGNED BY	
CHECKED BY	
ORIGINAL PLAN	
NOTE BOOK	
No.	

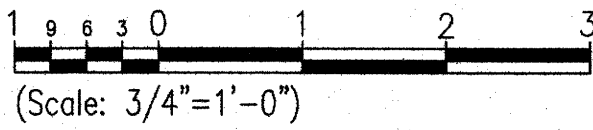

T-4

CLARENCE L. INOUE  
LICENSED PROFESSIONAL ARCHITECT  
No. 4981  
HAWAII, U.S.A.

04-30-20  
EXP. DATE OF THE LICENSE

SIGNATURE  
THIS WORK WAS PREPARED BY ME OR UNDER MY SUPERVISION

STATE OF HAWAII  
DEPARTMENT OF TRANSPORTATION  
HIGHWAYS DIVISION

**MOUNTING HEIGHTS**

MAUNA KEA MAINTENANCE  
BASEYARD  
DANIEL K. INOUE HIGHWAY

Project No. 200A-01-10  
Scale: 3/4" = 1'-0" Date: April 2018

SHEET No. T-4 OF 4 SHEETS