



FED. ROAD DIST. NO.	STATE	PROJ. NO.	FISCAL YEAR	SHEET NO.	TOTAL SHEETS
HAWAII	HAW.	200A-01-10	2012	0	0

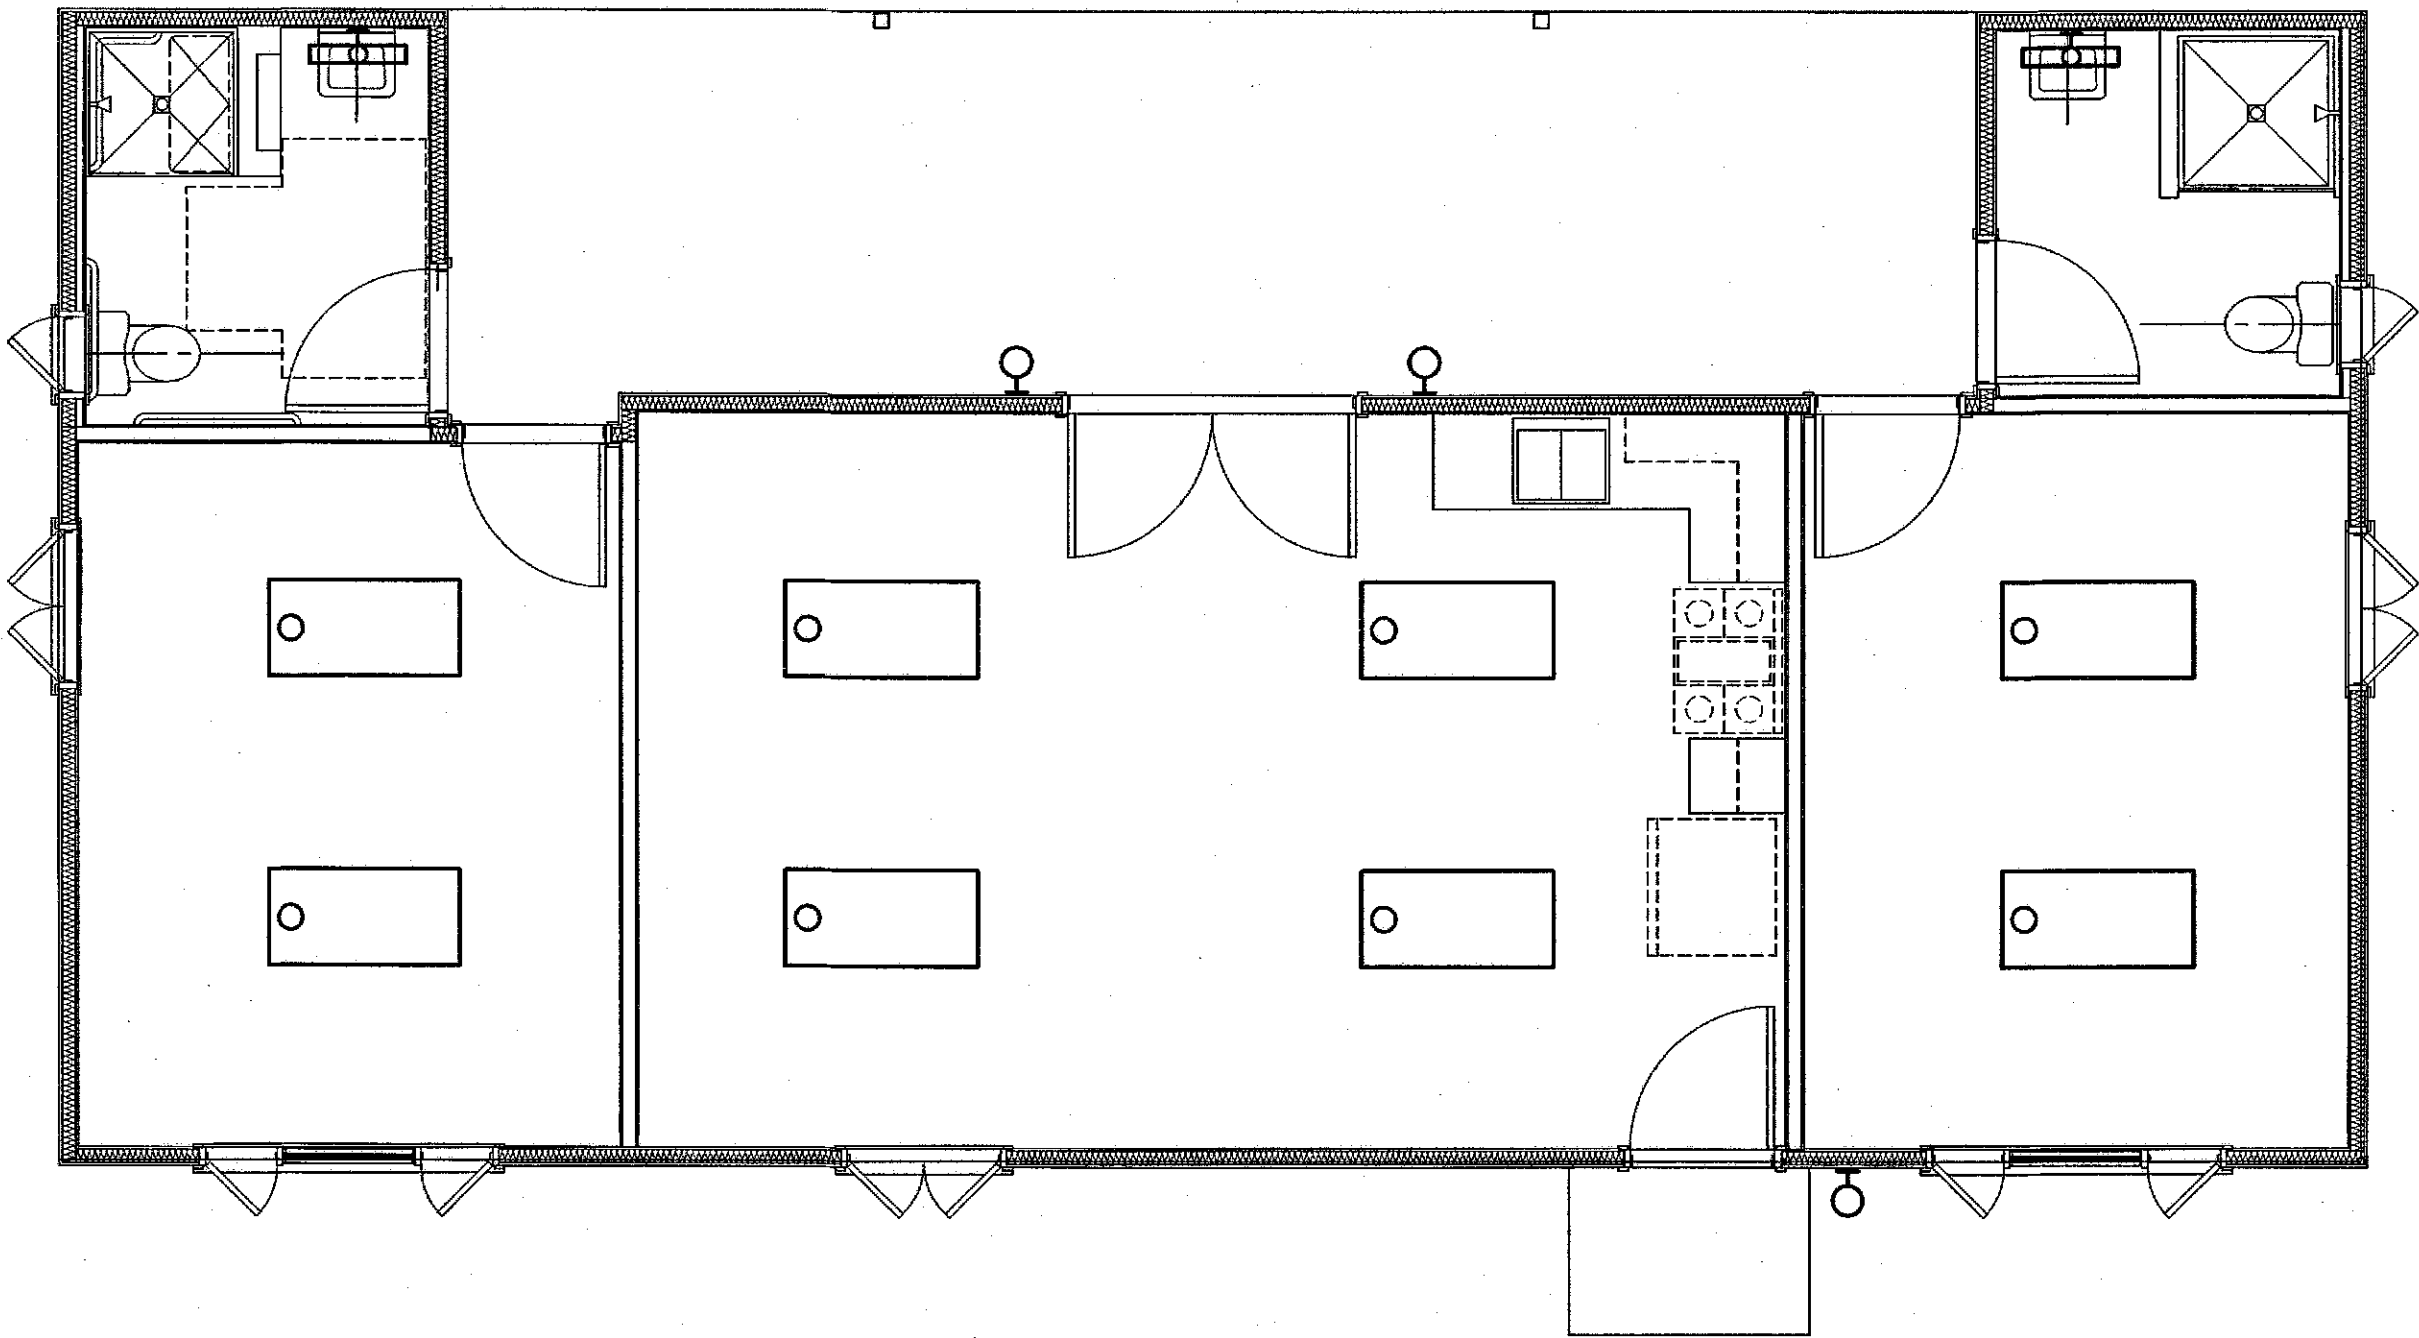

CABIN LIGHTING PLAN
SCALE: 1/4"=1'-0"

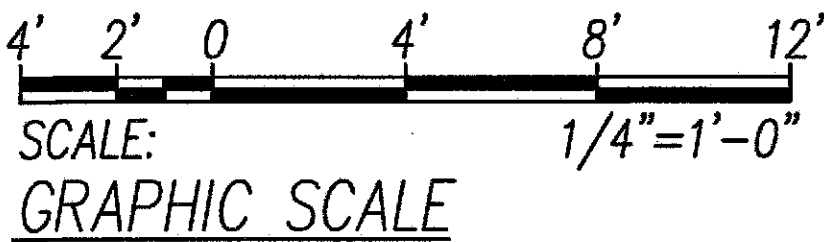

04-30-16

SIGNATURE

EXP. DATE OF THE LICENSE

THIS WORK WAS PREPARED BY

ME OR UNDER MY SUPERVISION

STATE OF HAWAII
DEPARTMENT OF TRANSPORTATION
HIGHWAYS DIVISION

CABIN

MAUNA KEA MAINTENANCE
BASEYARD
Saddle Road

Project No. 200A-01-10

Scale: As Noted Date: September, 2015

SHEET No.

OF

SHEETS

E-8