




FED. ROAD DIST. NO.	STATE	PROJ. NO.	FISCAL YEAR	SHEET NO.	TOTAL SHEETS
HAWAII	HAW.	200A-01-10	2012	0	0

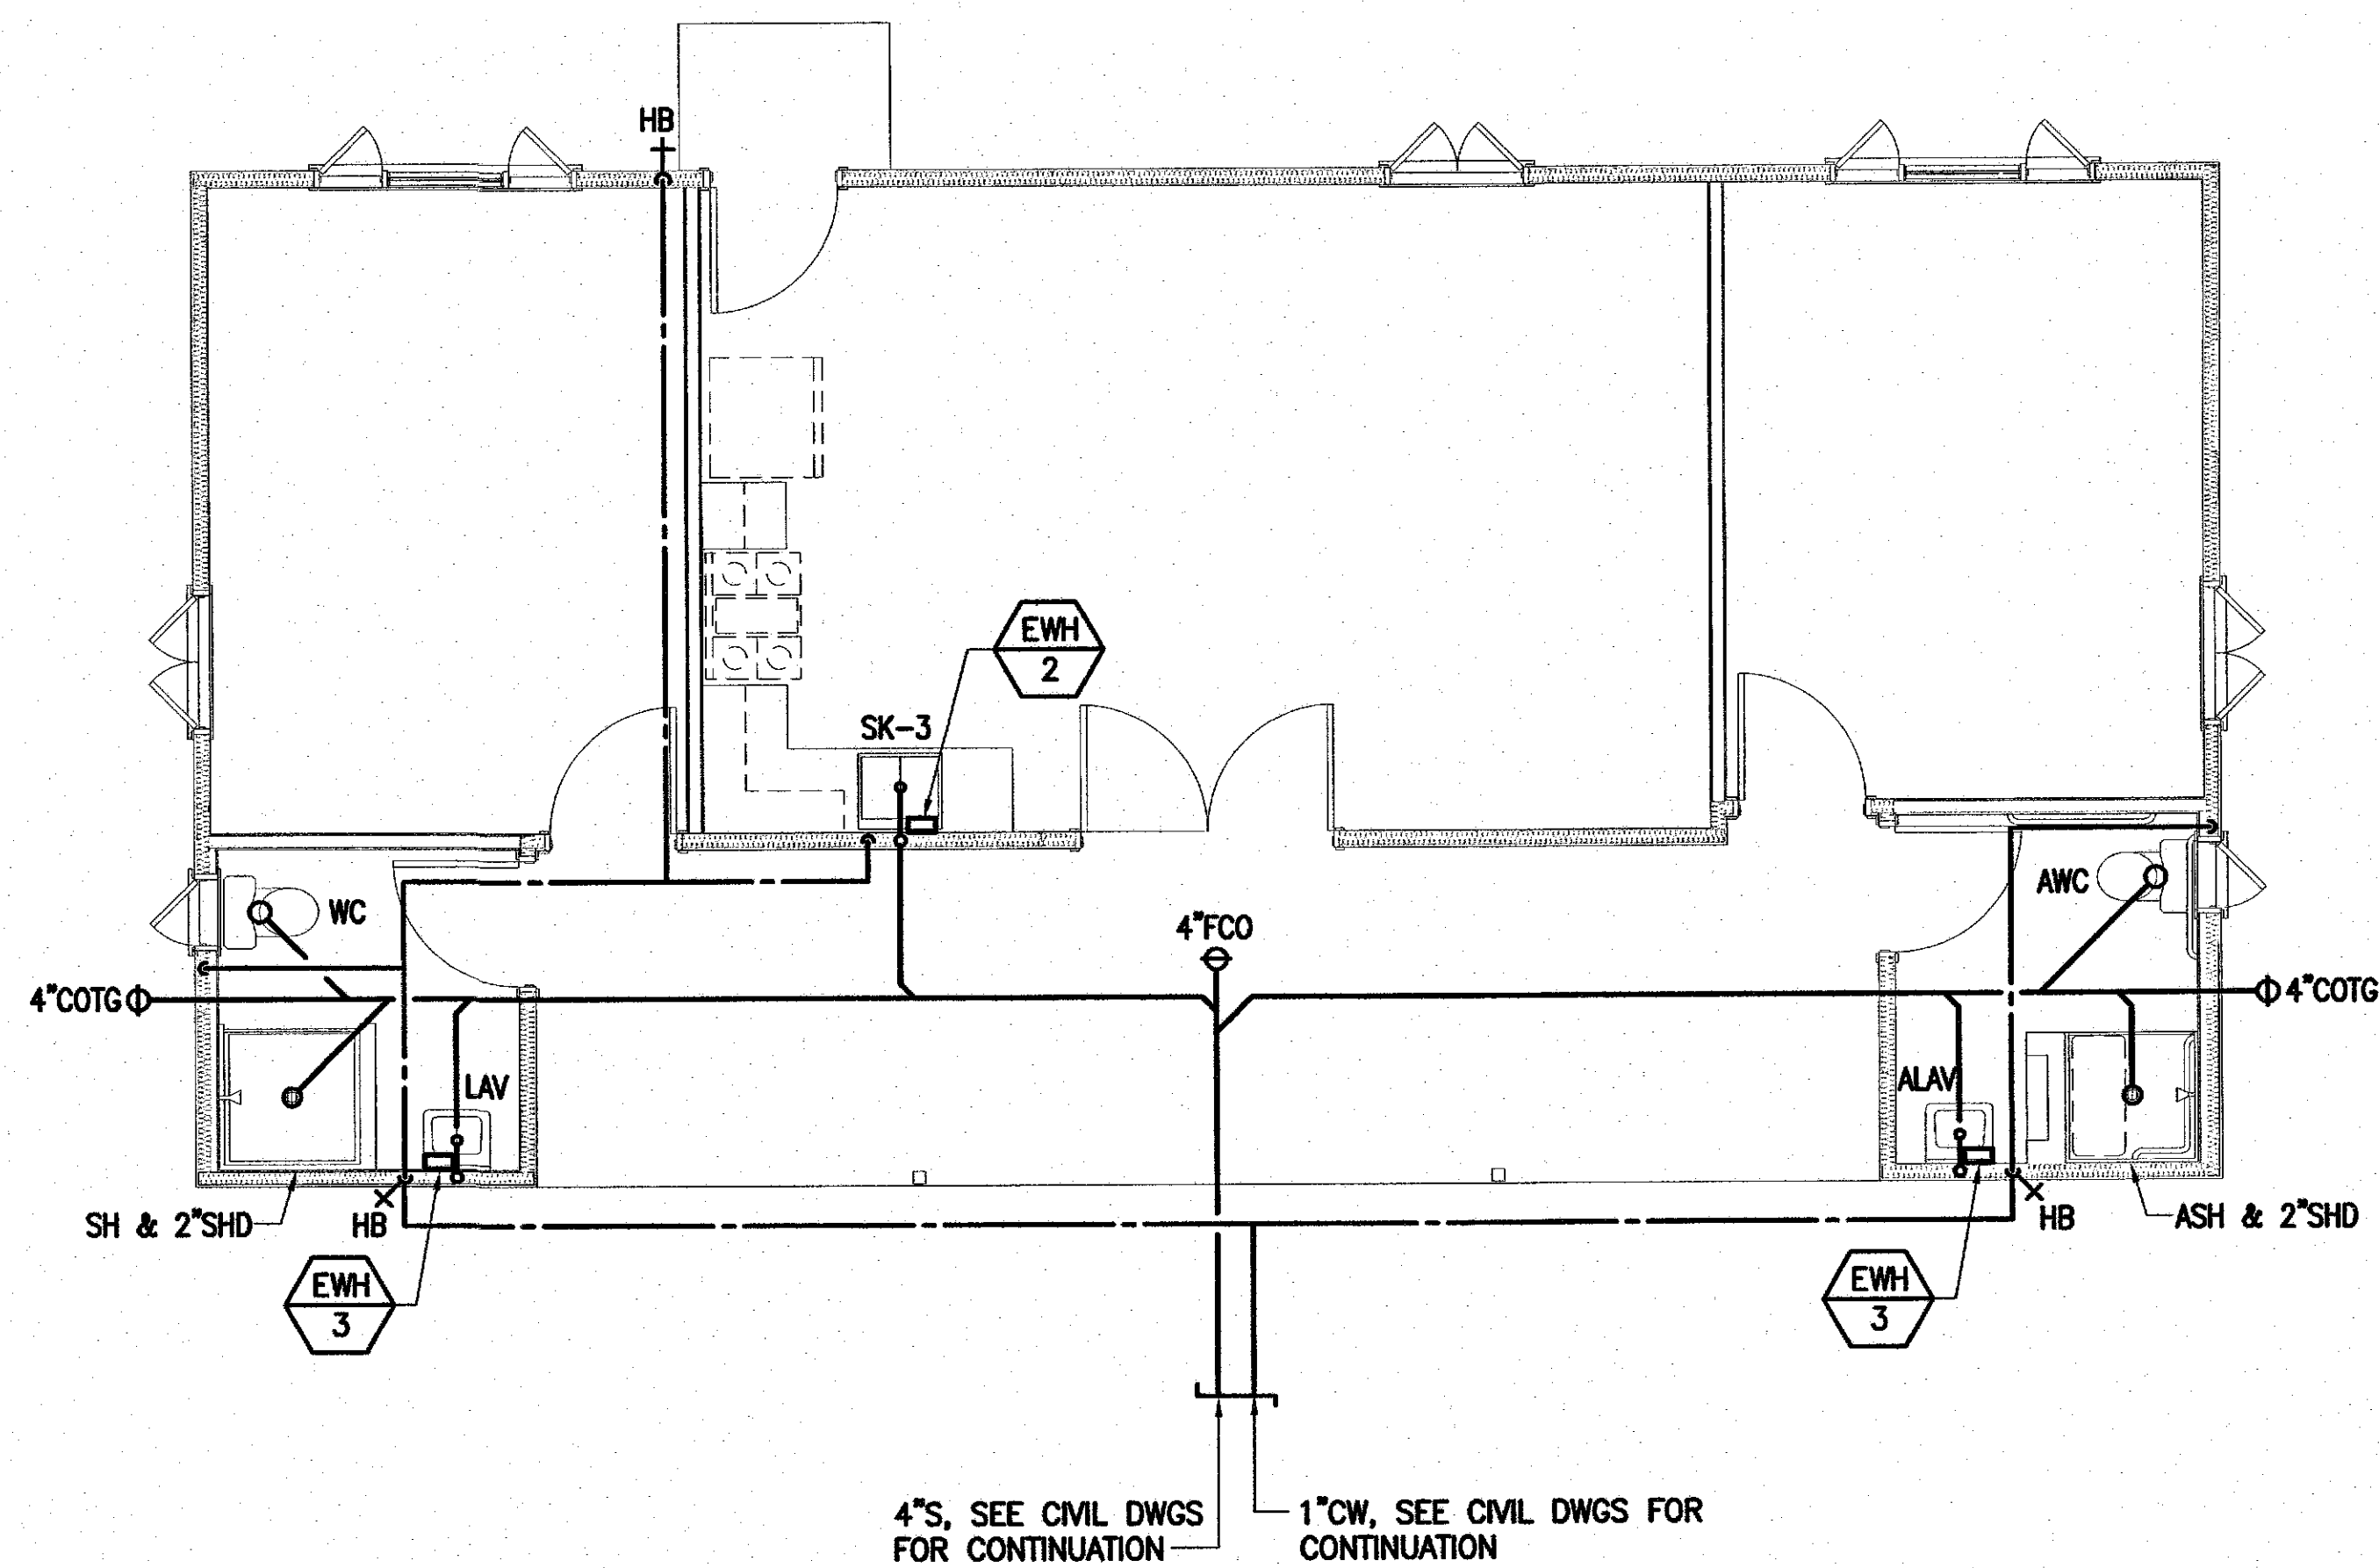

RENTAL CABIN

PLUMBING PLAN

SCALE: 1/4" = 1'-0"

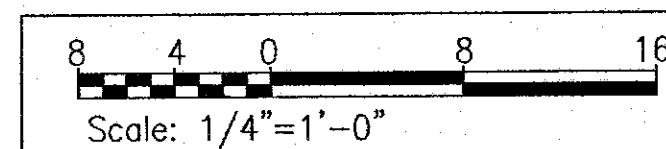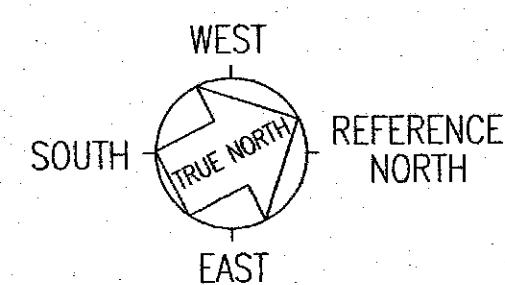

ME11

04-30-16
SIGNATURE EXP. DATE OF THE LICENSE
THIS WORK WAS PREPARED BY
ME OR UNDER MY SUPERVISION

STATE OF HAWAII
DEPARTMENT OF TRANSPORTATION
HIGHWAYS DIVISION

RENTAL CABIN
MAUNA KEA MAINTENANCE
BASEYARD
Saddle Road

Project No. 200A-01-10
Scale: As Noted Date: September, 2015
SHEET No. 1 OF X SHEETS