



FED. ROAD DIST. NO.	STATE	PROJ. NO.	FISCAL YEAR	SHEET NO.	TOTAL SHEETS
HAWAII	HAW.	200A-01-10	2012	0	0

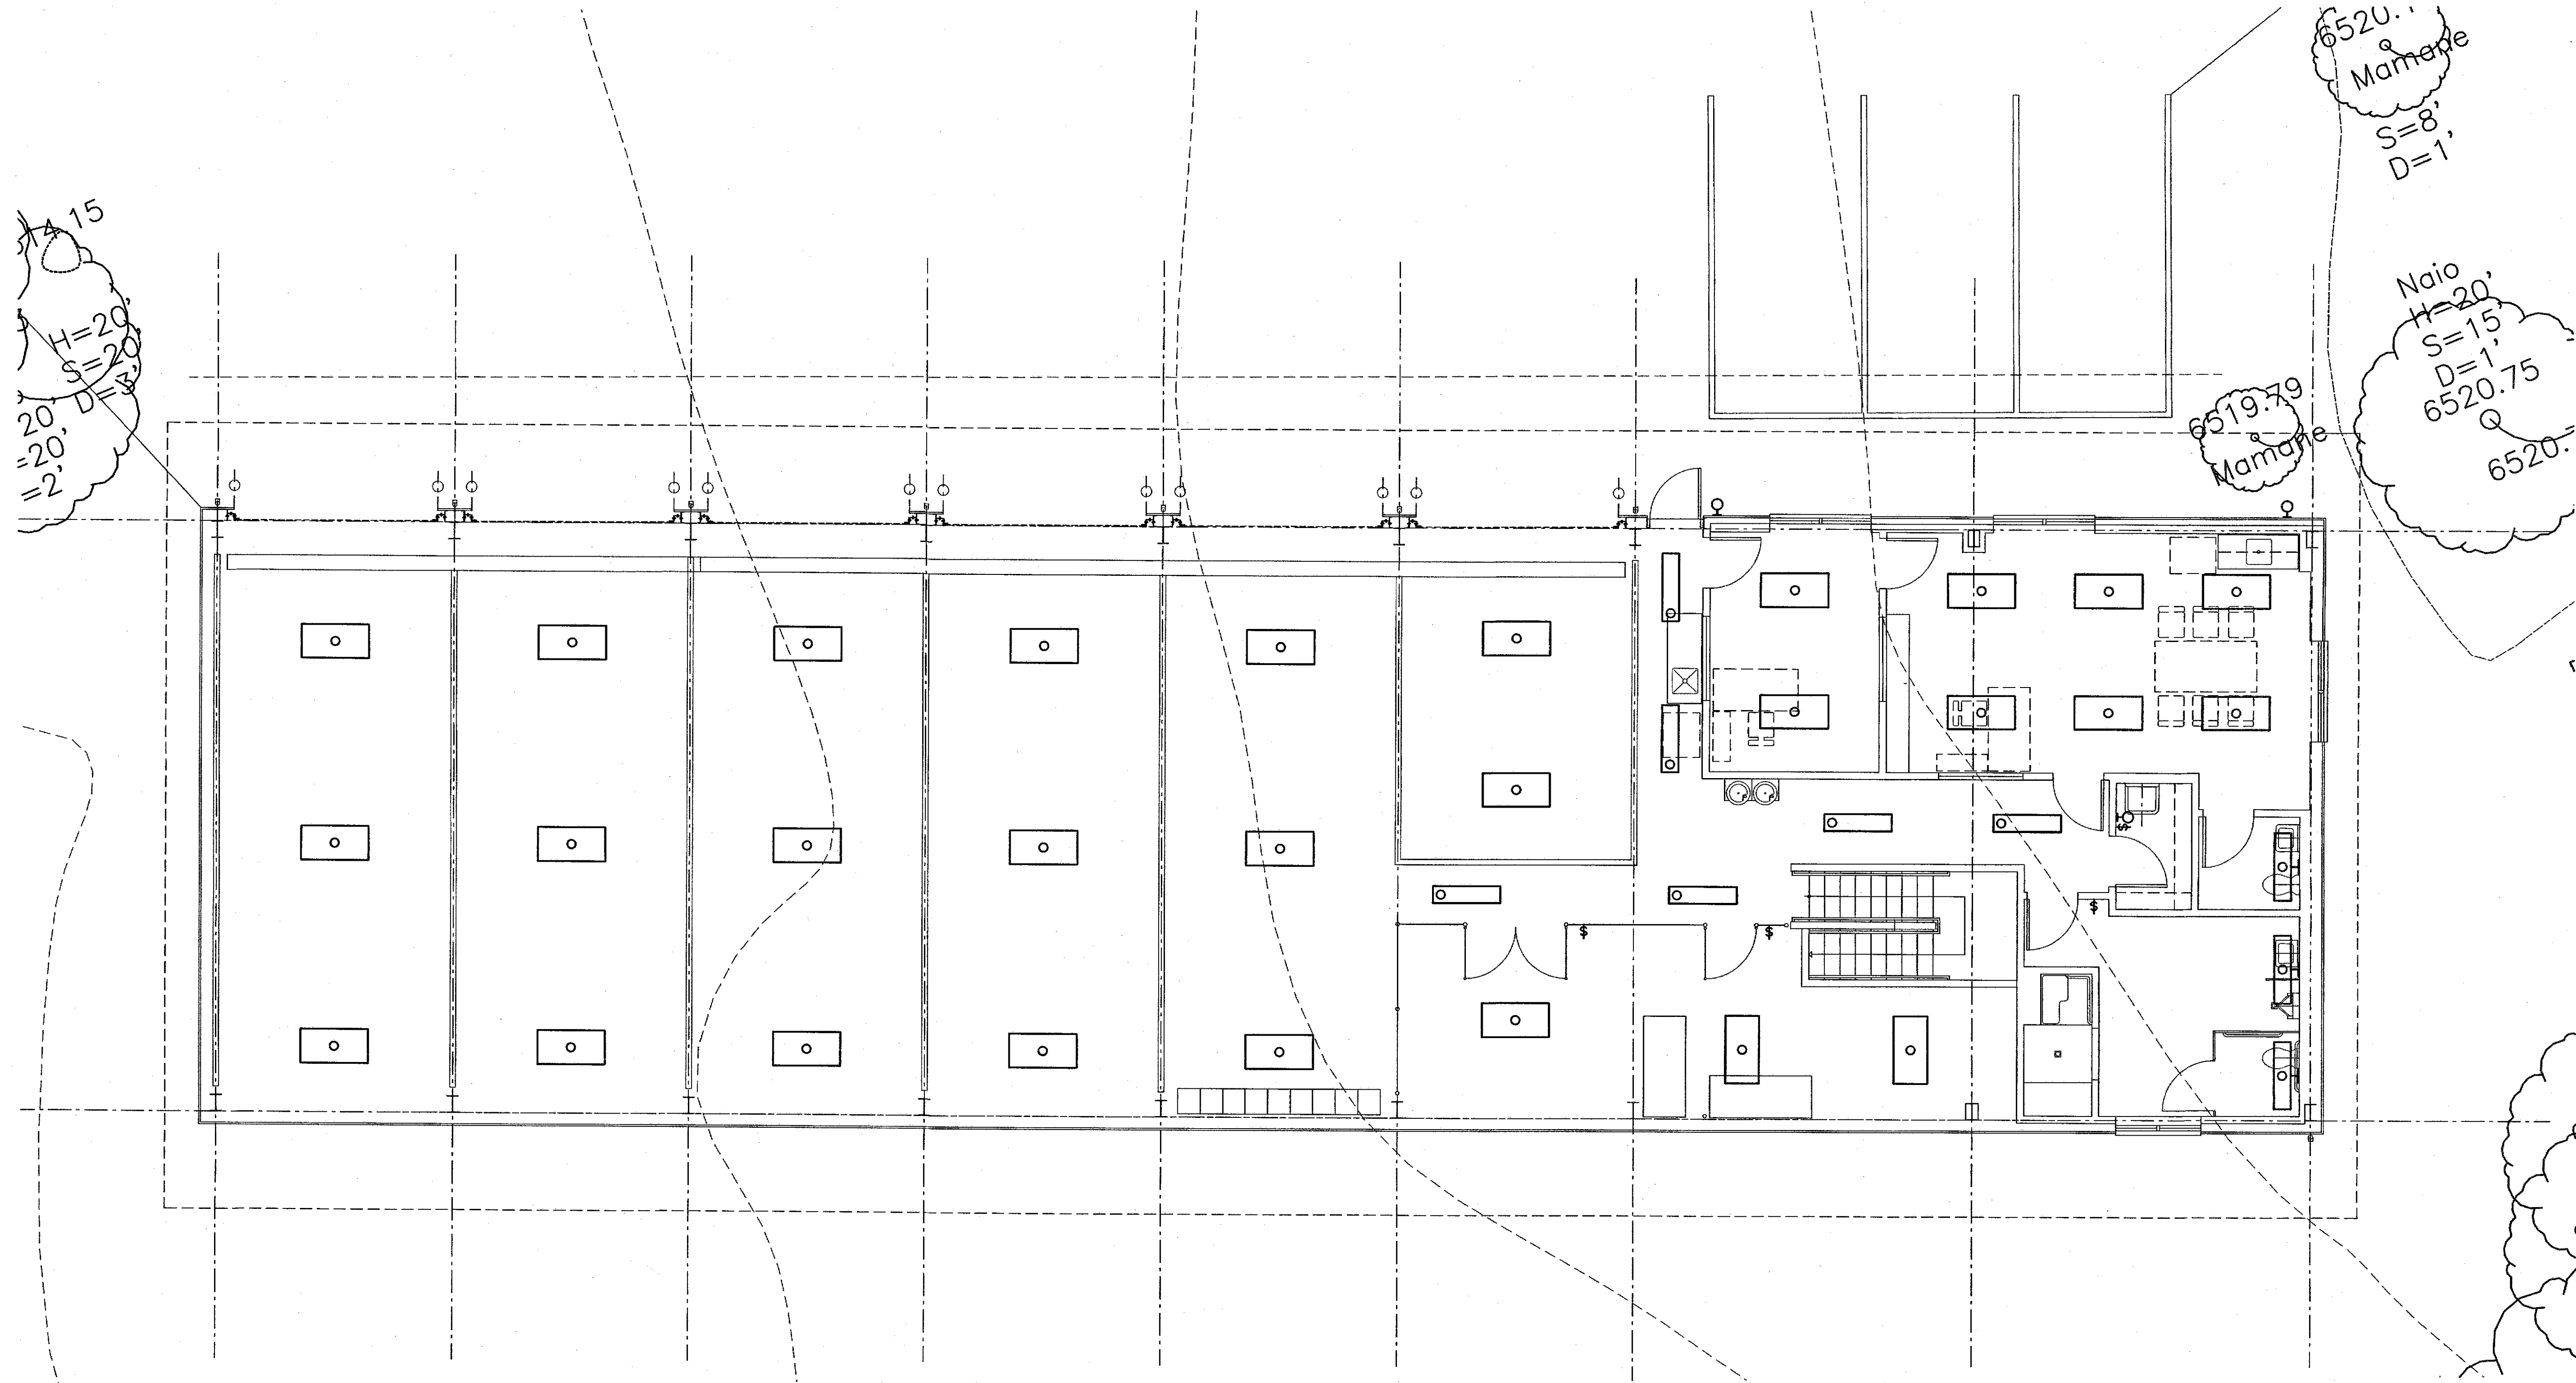

SHOP BUILDING LIGHTING PLAN
SCALE: 3/16"=1'-0"

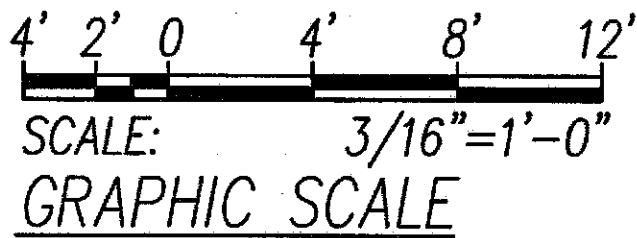

04-30-16
SIGNATURE EXP. DATE OF THE LICENSE
THIS WORK WAS PREPARED BY
ME OR UNDER MY SUPERVISION

STATE OF HAWAII
DEPARTMENT OF TRANSPORTATION
HIGHWAYS DIVISION

SHOP BUILDING
MAUNA KEA MAINTENANCE
BASEYARD
Saddle Road
Project No. 200A-01-10
Scale: As Noted Date: September, 2015
SHEET No. OF SHEETS