
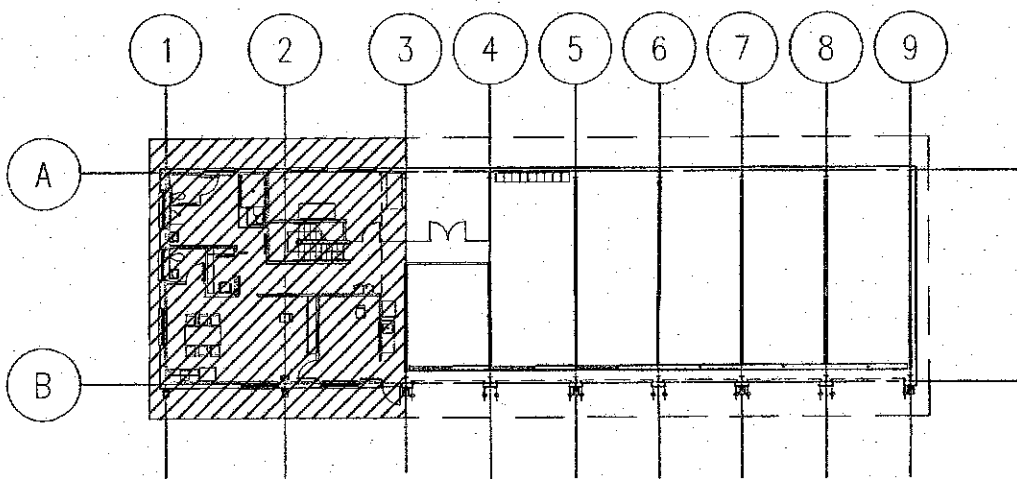


FED. ROAD DIST. NO.	STATE	PROJ. NO.	FISCAL YEAR	SHEET NO.	TOTAL SHEETS
HAWAII	HAW.	200A-01-10	2012	0	0

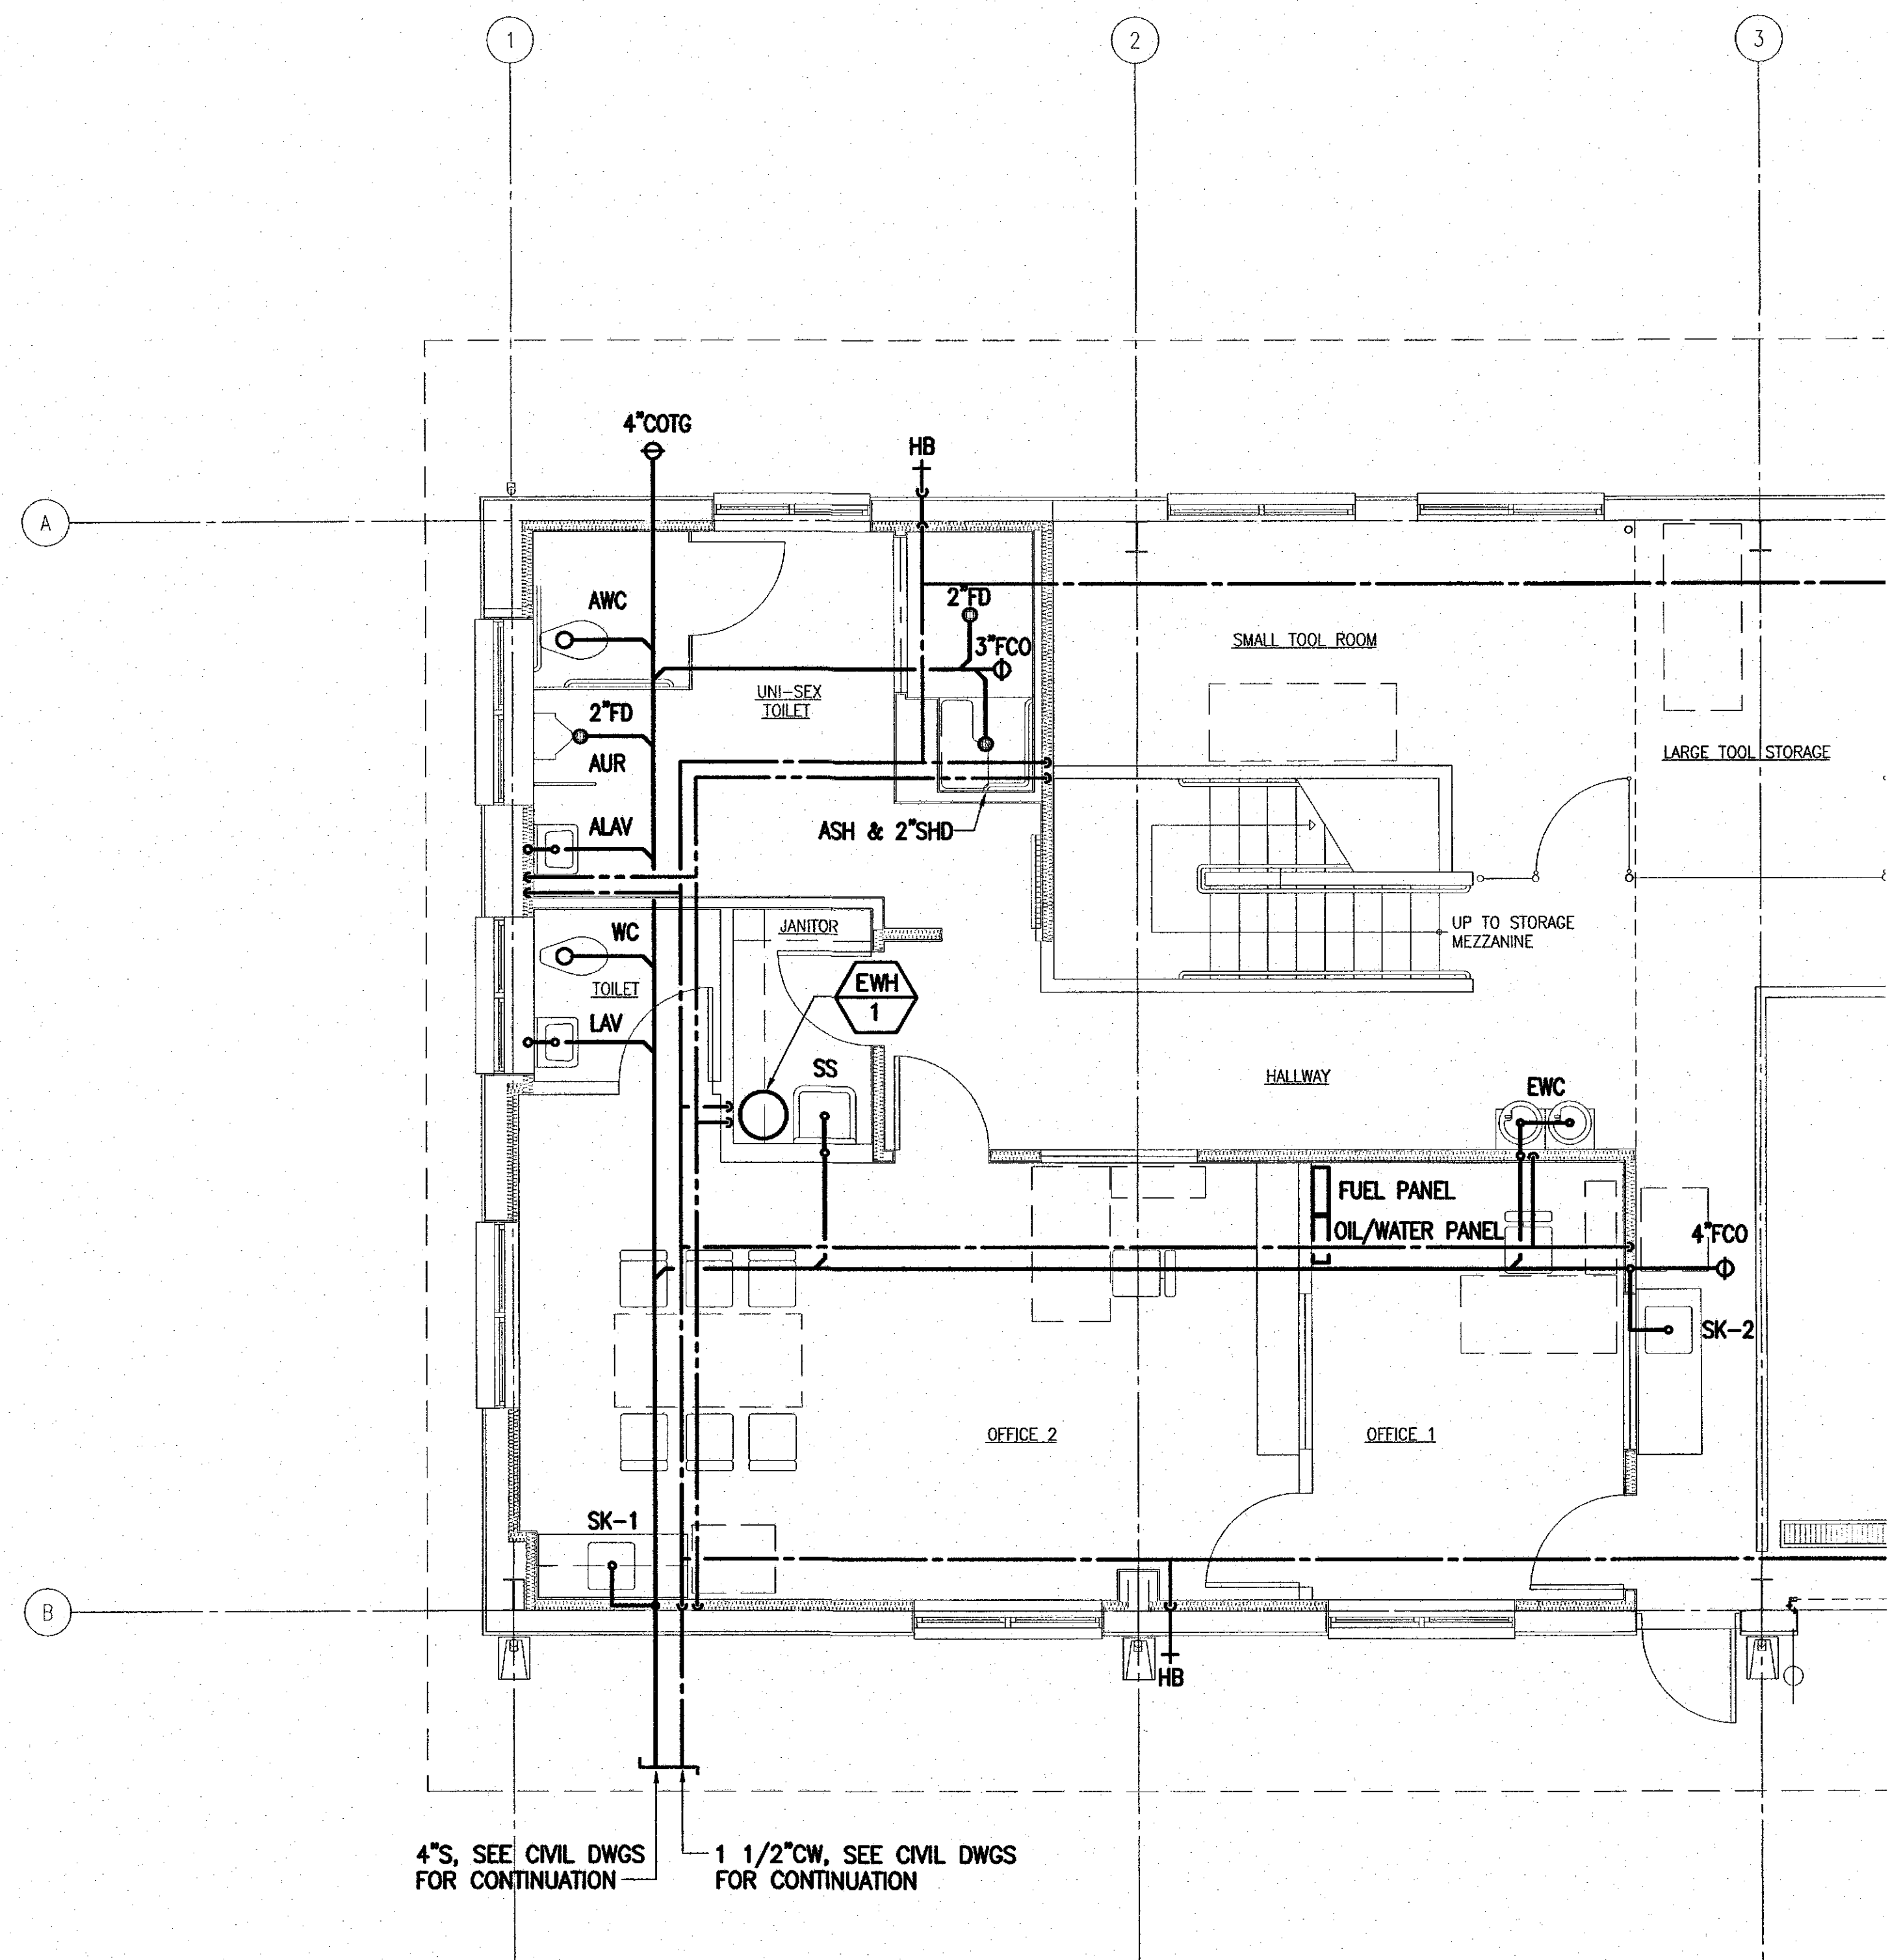

SHOP BUILDING


KEY PLAN

SCALE: NONE

SHOP BUILDING

PARTIAL PLUMBING PLAN

SCALE: 1/4" = 1'-0"

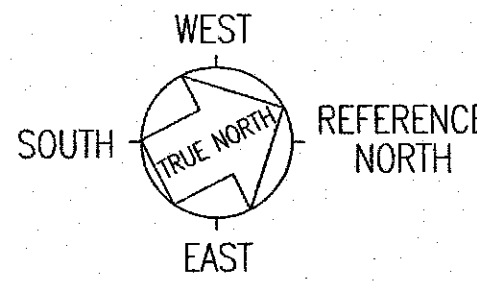

04-30-16
SIGNATURE EXP. DATE OF THE LICENSE
THIS WORK WAS PREPARED BY
ME OR UNDER MY SUPERVISION

MA11

STATE OF HAWAII
DEPARTMENT OF TRANSPORTATION
HIGHWAYS DIVISION



SHOP BUILDING
MAUNA KEA MAINTENANCE
BASEYARD
Saddle Road

Project No. 200A-01-10

Scale: As Noted Date: September, 2015

SHEET No. 1 OF X SHEETS

FED. ROAD DIST. NO.	STATE	PROJ. NO.	FISCAL YEAR	SHEET NO.	TOTAL SHEETS
HAWAII	HAW.	200A-01-10	2012	0	0

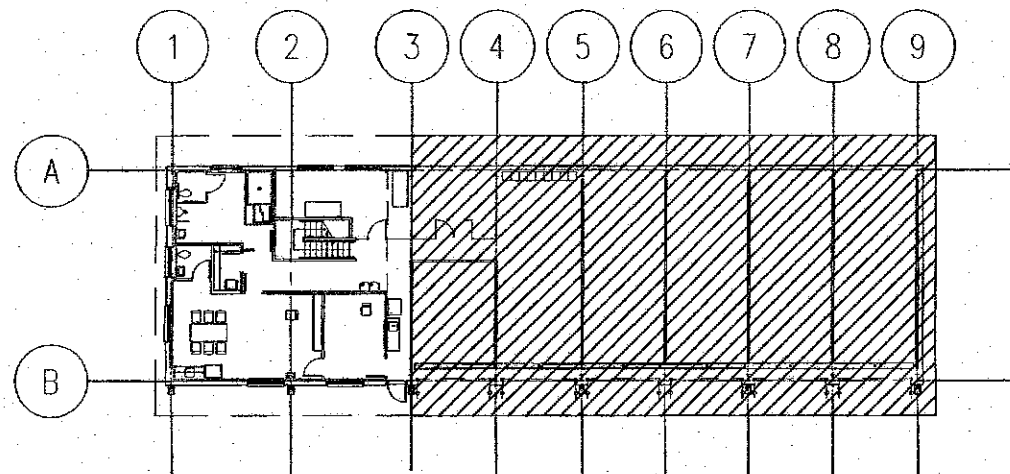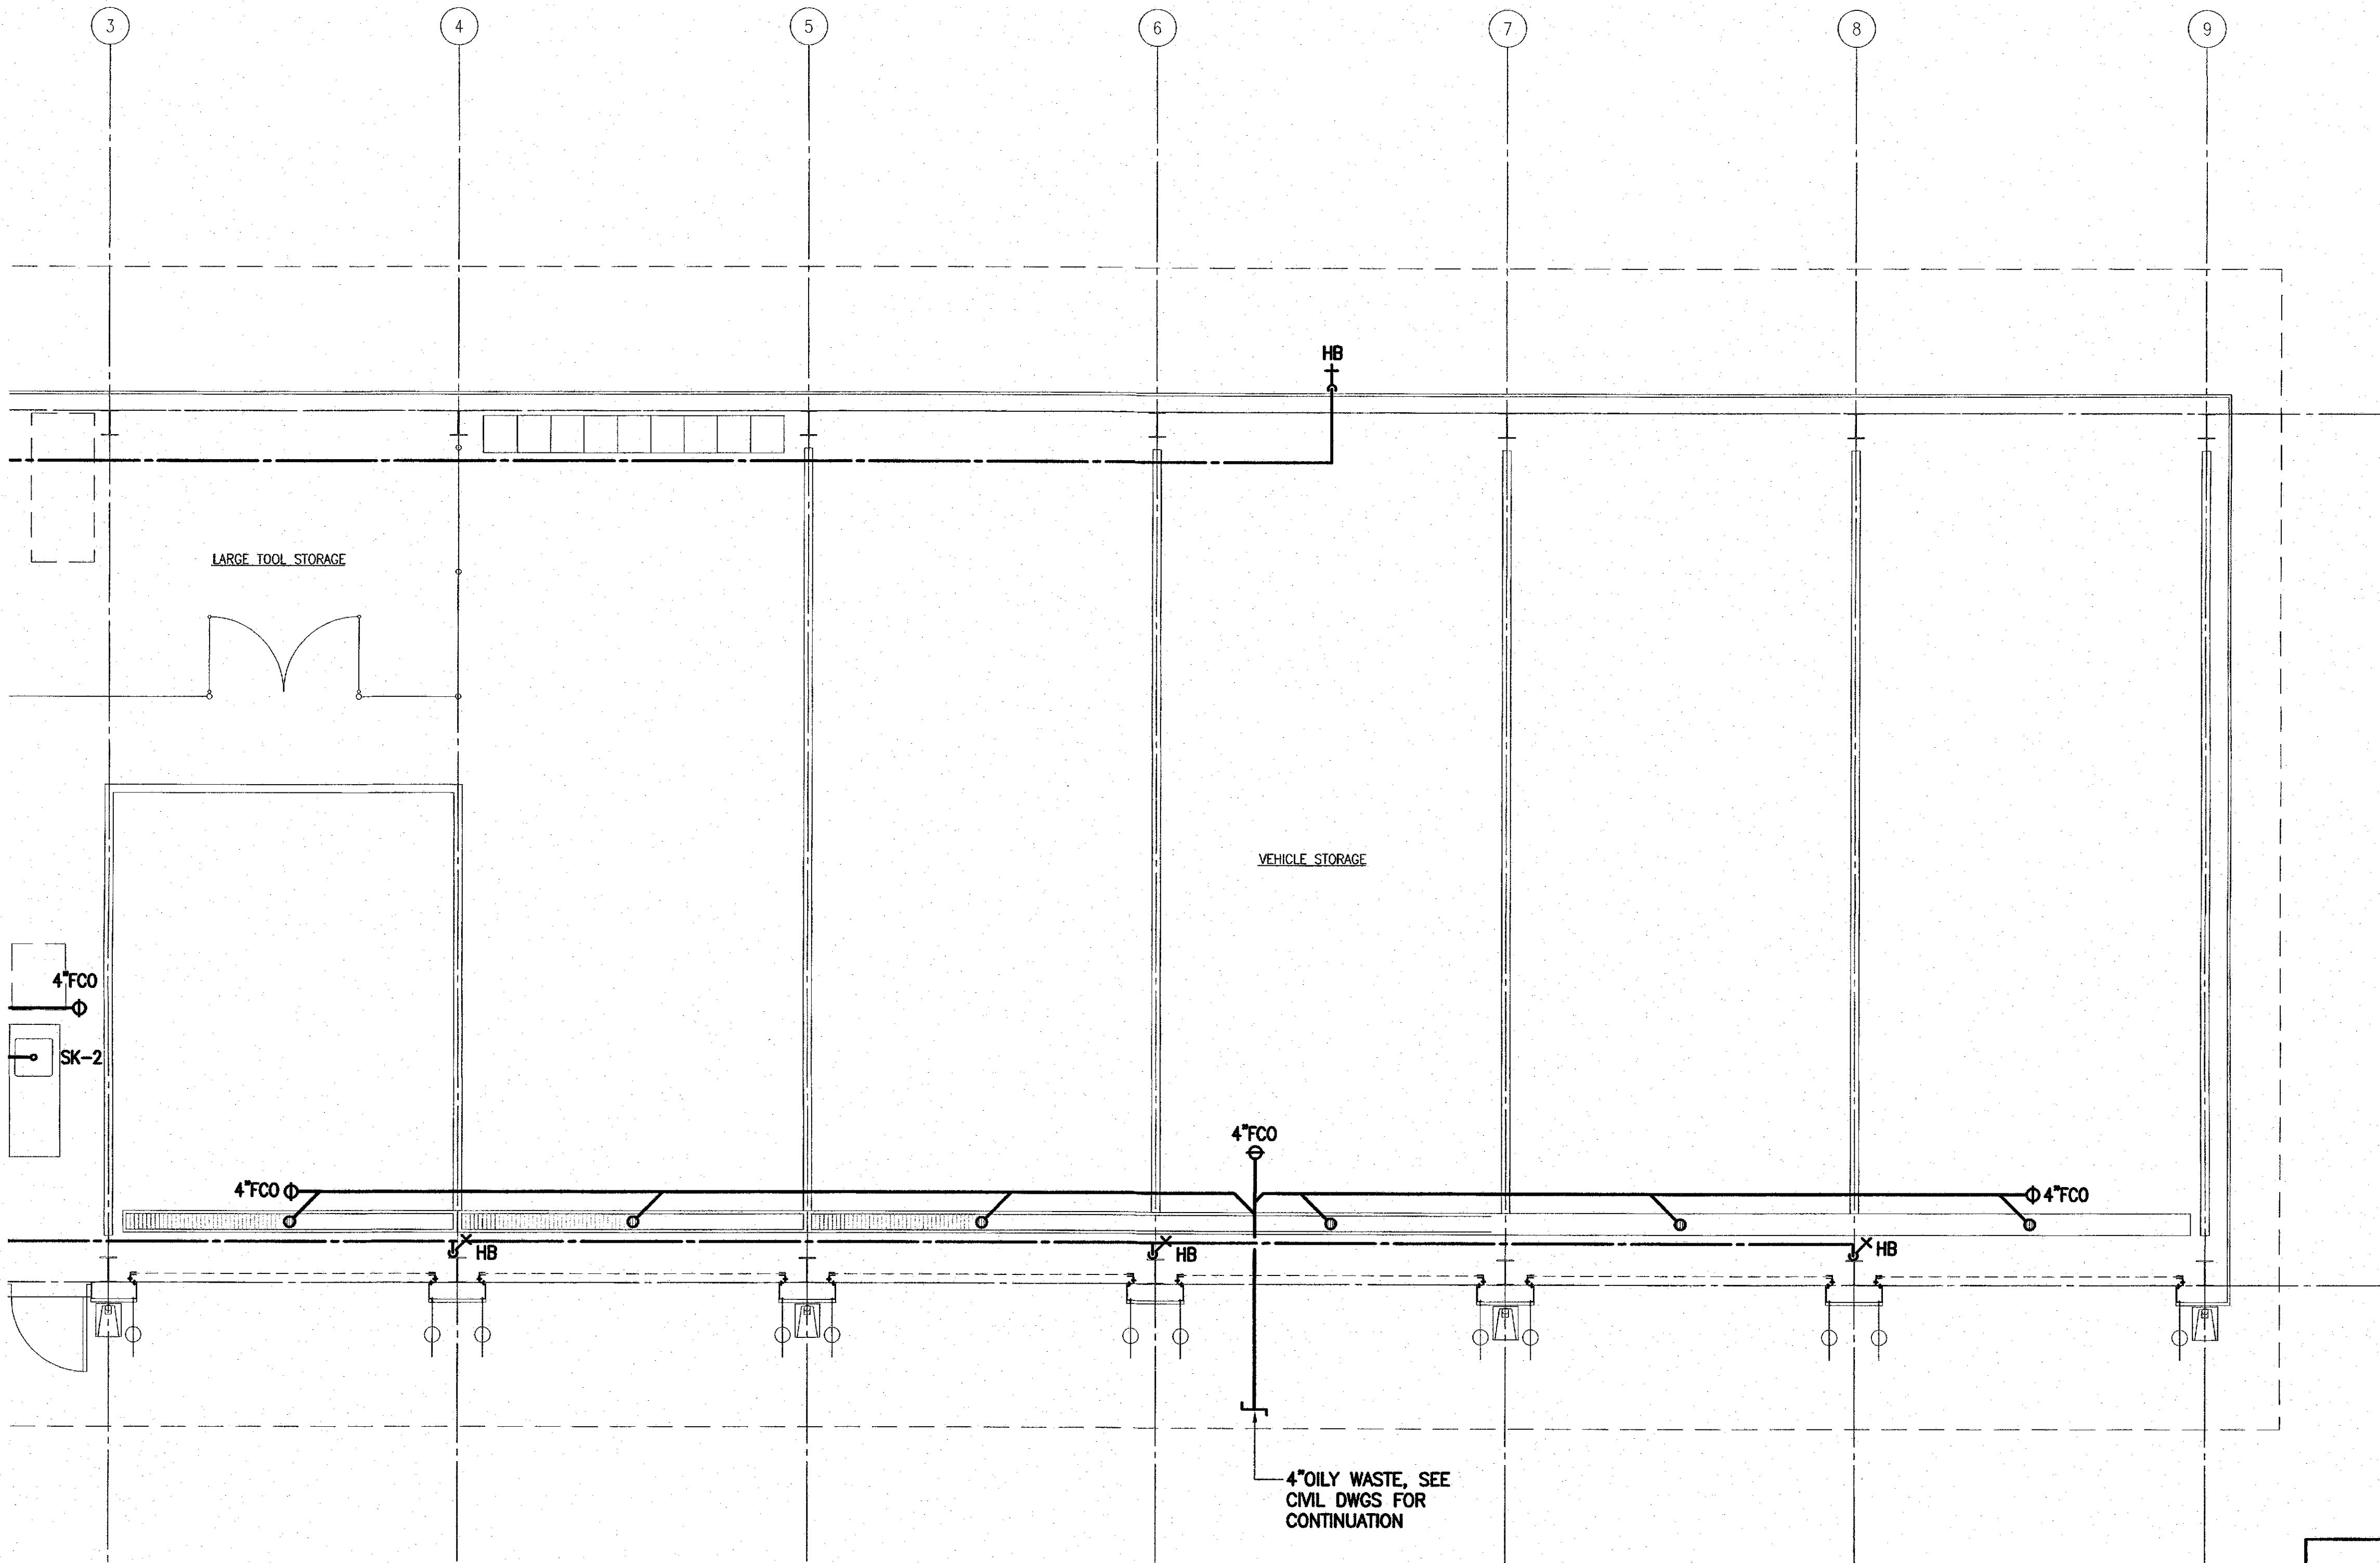

SHOP BUILDING



KEY PLAN

SCALE: NONE

SHOP BUILDING

PARTIAL PLUMBING PLAN

SCALE: 1/4" = 1'-0"

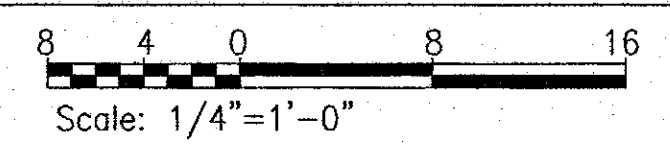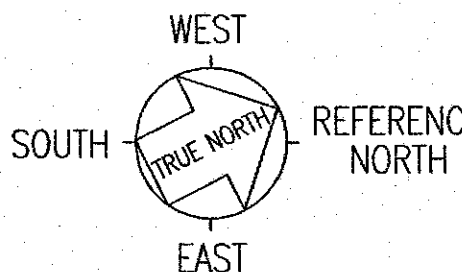

MA12

SIGNATURE: _____
EXP. DATE OF THE LICENSE: 04-30-16
THIS WORK WAS PREPARED BY ME OR UNDER MY SUPERVISION

STATE OF HAWAII
DEPARTMENT OF TRANSPORTATION
HIGHWAYS DIVISION

**SHOP BUILDING
MAUNA KEA MAINTENANCE
BASEYARD**

Saddle Road

Project No. 200A-01-10

Scale: As Noted Date: September, 2015

SHEET No. 1 OF X SHEETS