
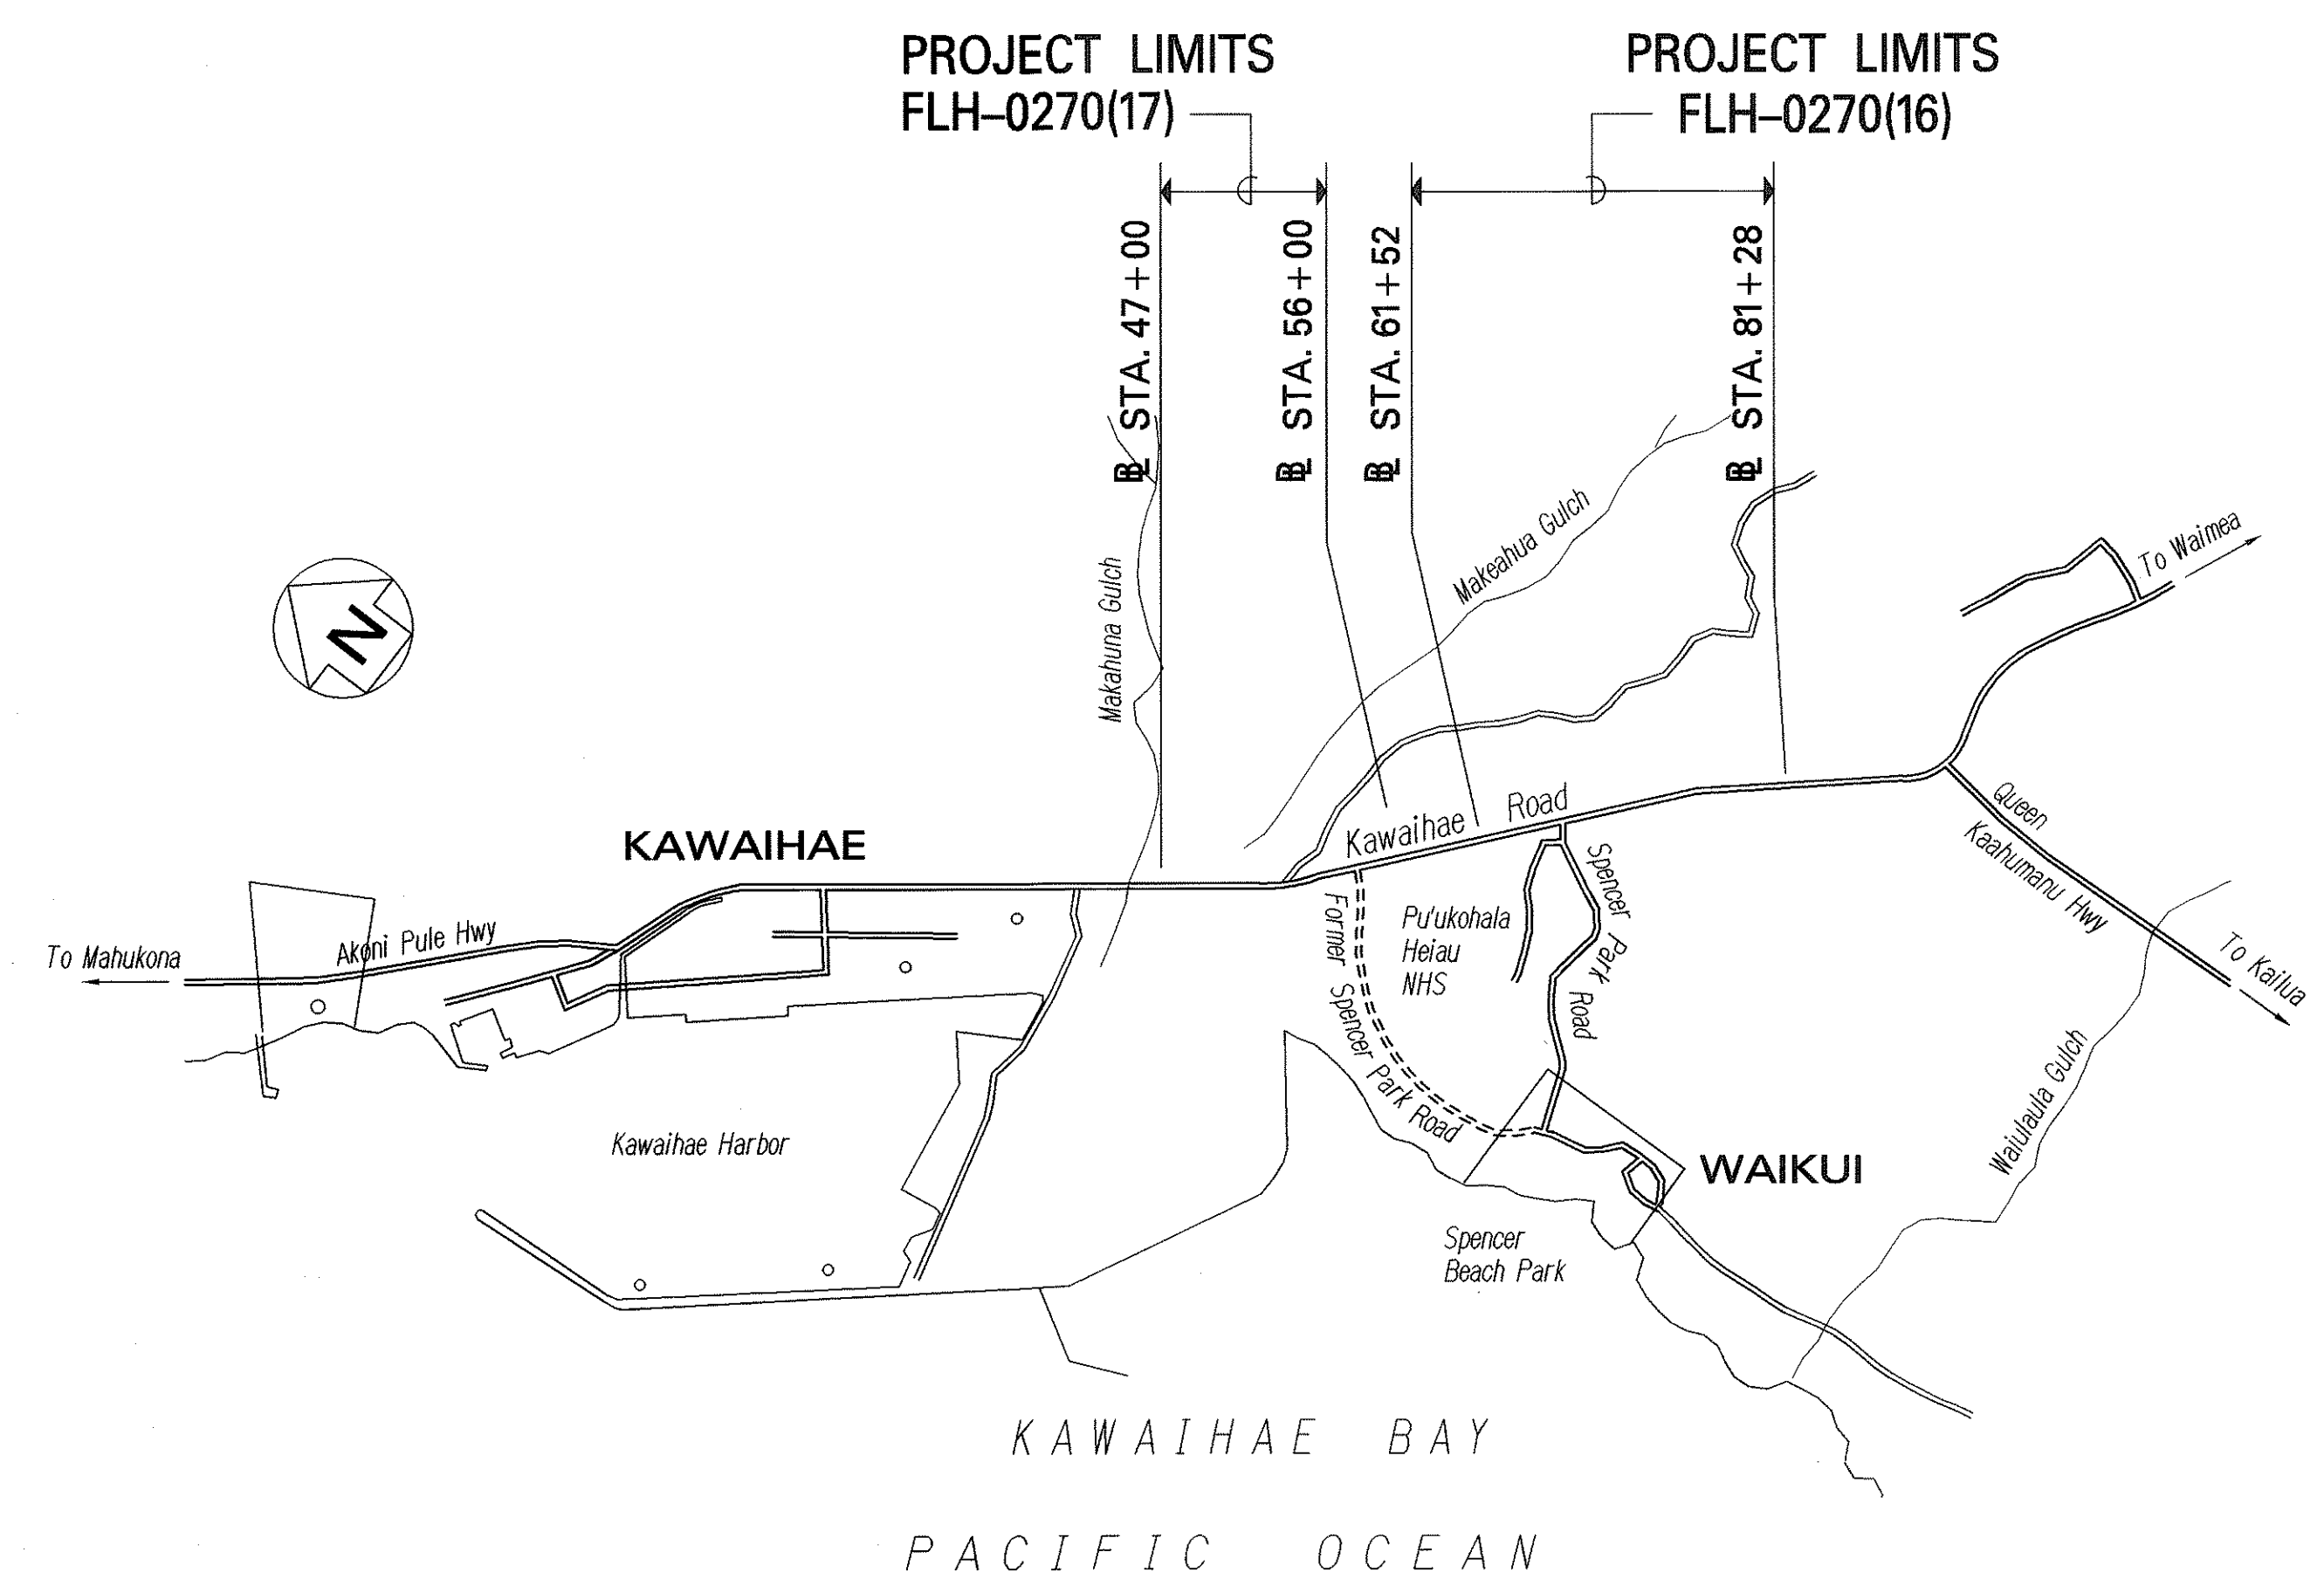
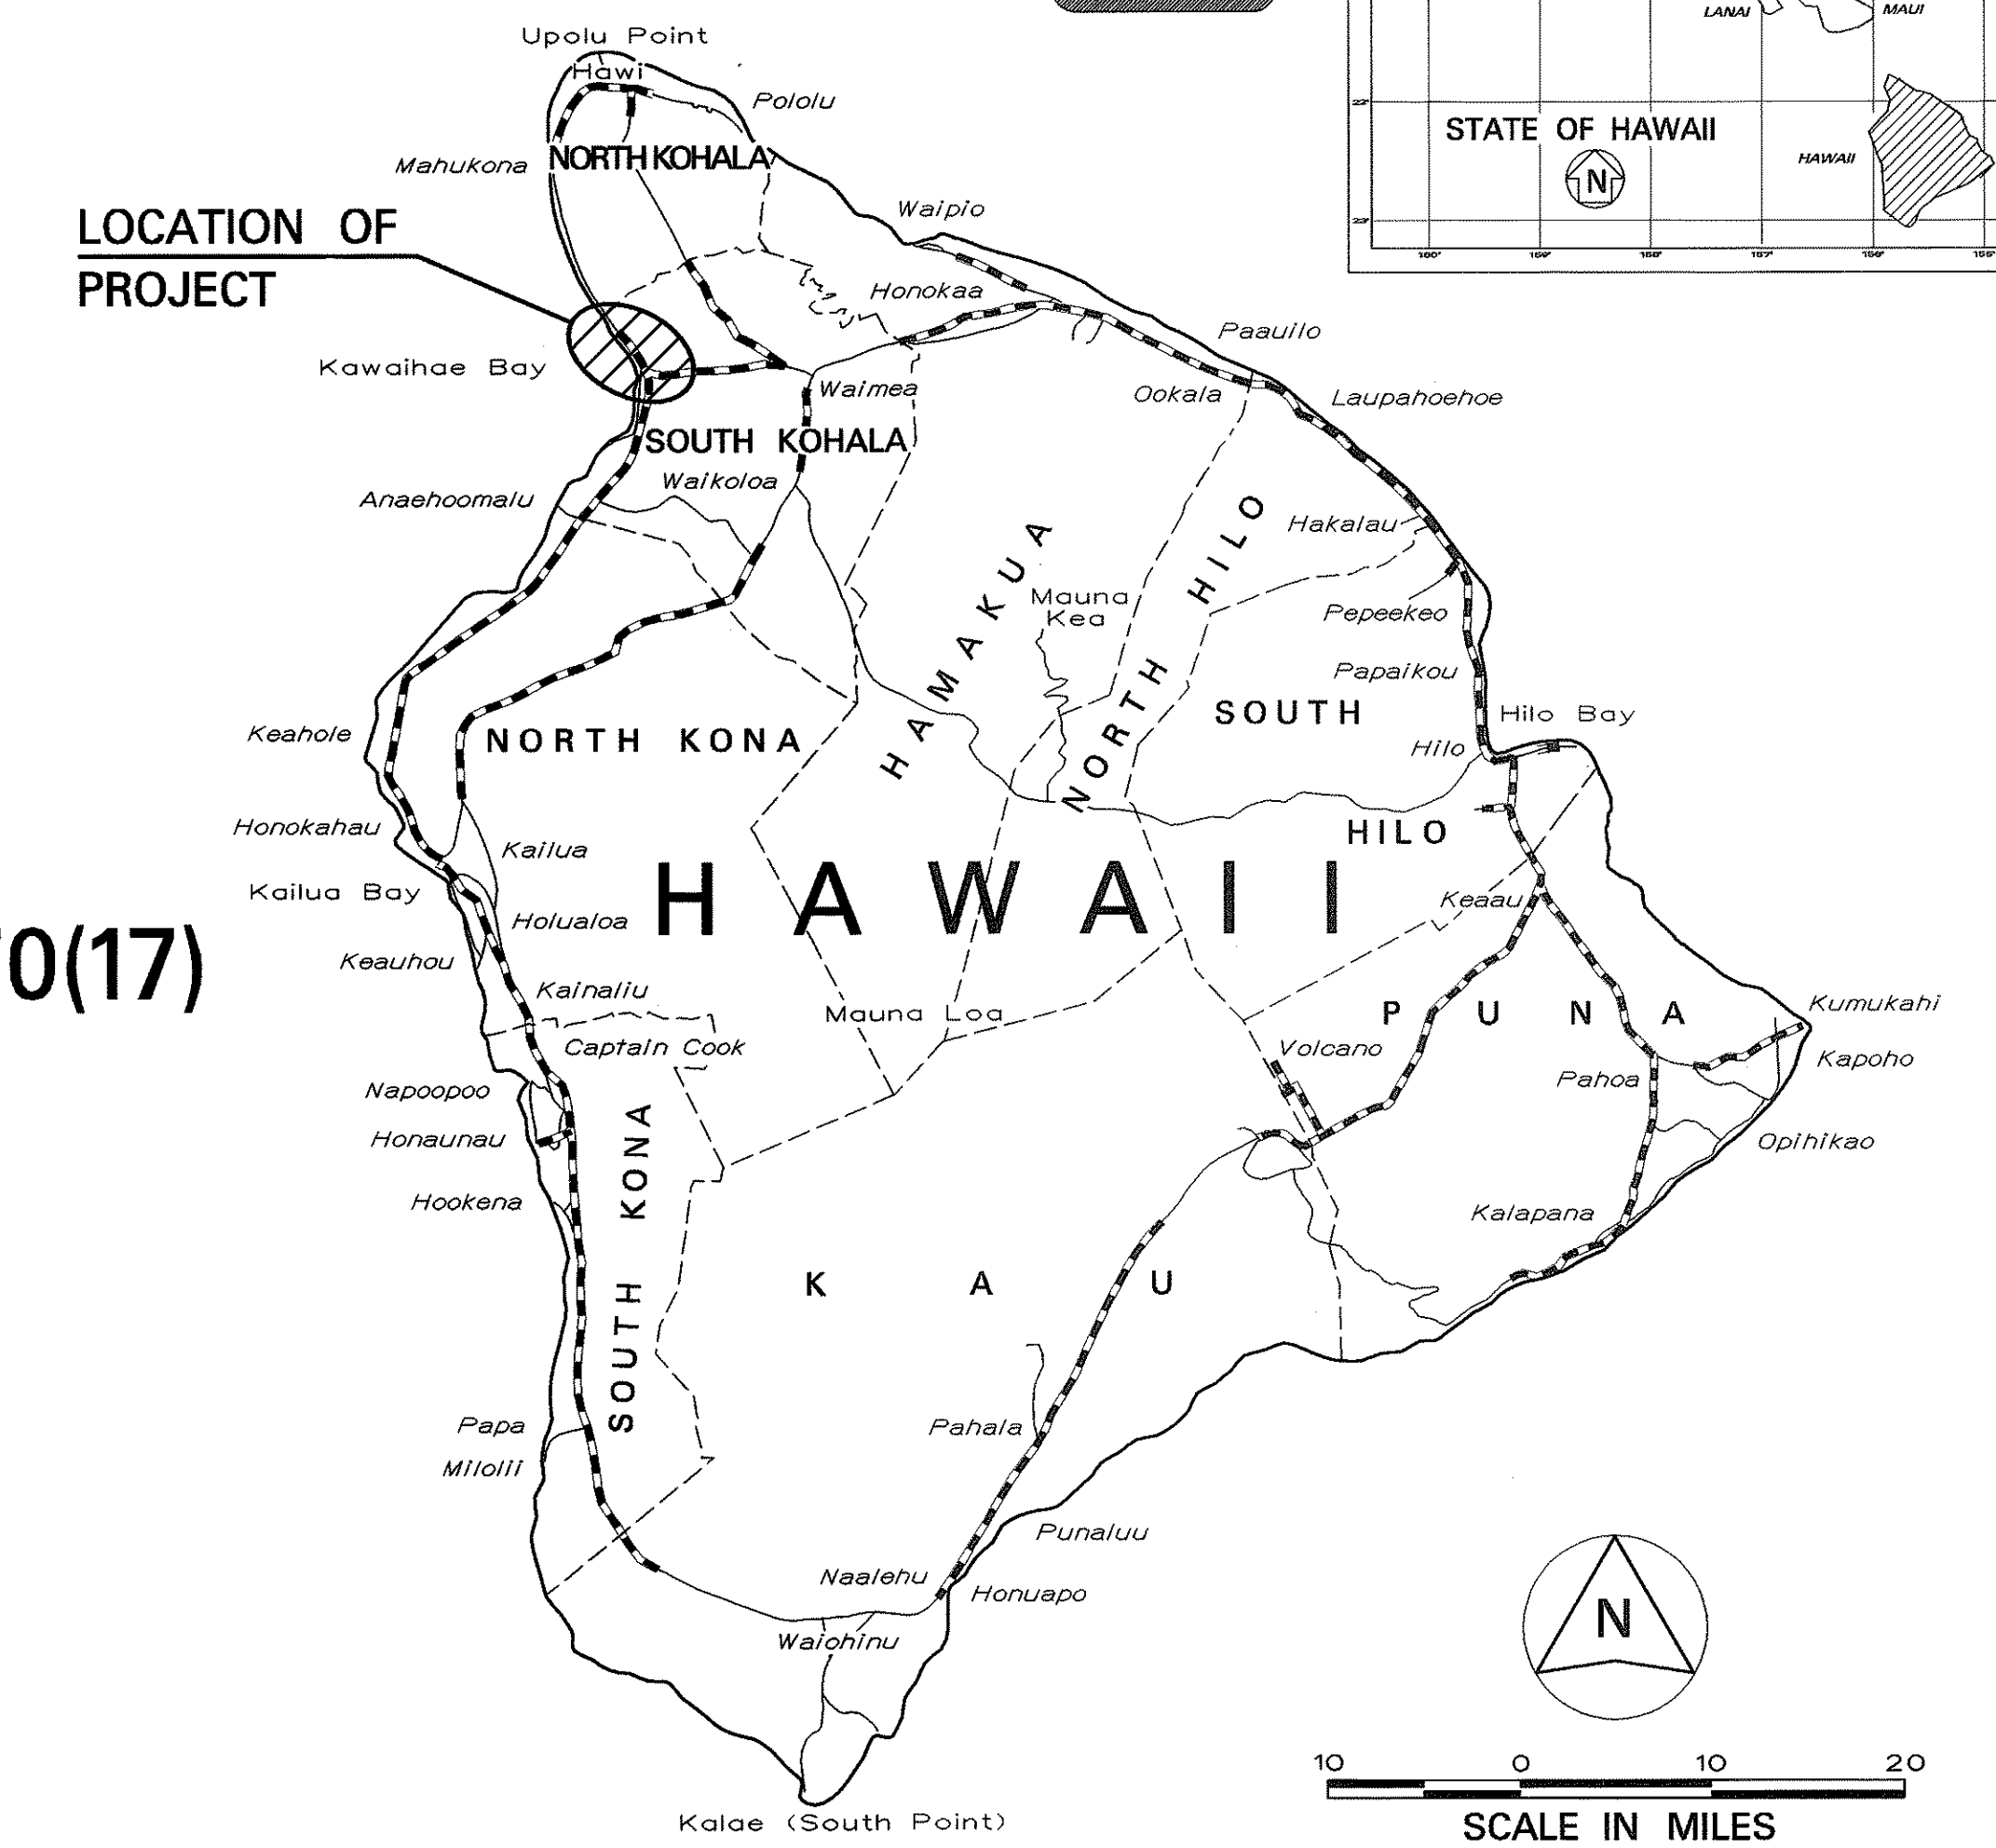
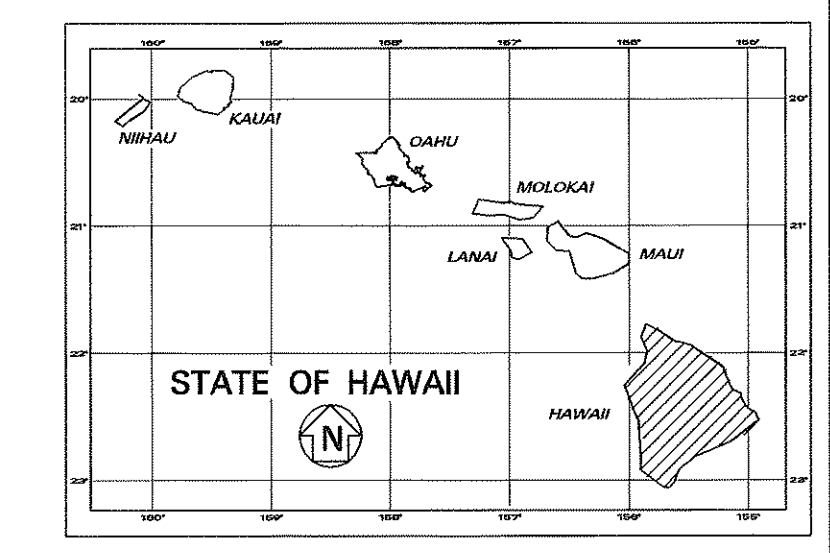


INDEX TO DRAWINGS	
SHEET NO.	DESCRIPTION
1	TITLE SHEET
2	STANDARD PLANS SUMMARY
3	GENERAL NOTES AND LEGEND
4 - 5	WATER POLLUTION & EROSION CONTROL NOTES
6 - 7	TYPICAL SECTIONS, DETAILS & PROFILES
8 - 9	MISCELLANEOUS DETAILS
10 - 12	ROADWAY CONSTRUCTION
13 - 19	GUARDRAIL DETAILS AND NOTES
20 - 21	GRADING AND DRAINAGE PLAN
22	PAVEMENT MARKINGS AND SIGNING LEGEND NOTES & DETAILS
23 - 24	PAVEMENT MARKINGS AND SIGNING
25 - 26	CONSTRUCTION PHASING
27 - 29	UTILITY SYSTEM SITE PLAN, NOTES AND SCHEDULE
30 - 32	LIGHT POLE DETAILS, ONE LINE DIAGRAM, AND DUCT SECTIONS
33 - 41	CROSS SECTIONS

STATE OF HAWAII
DEPARTMENT OF TRANSPORTATION
HIGHWAYS DIVISION
HONOLULU, HAWAII
"AS-BUILT" PLANS FOR
KAWAIHAE ROAD, PU'UKOHOLA HEIAU
NATIONAL HISTORIC SITE
INTERSECTION IMPROVEMENTS
FEDERAL-AID PROJECT NOS. FLH-0270(16) & FLH-0270(17)
DISTRICT OF SOUTH KOHALA
ISLAND OF HAWAII

FED. ROAD DIST. NO.	STATE	FED. AID PROJ. NO.	FISCAL YEAR	SHEET NO.	TOTAL SHEETS
HAWAII	HAW.	FLH-0270(16) & FLH-0270(17)	2001	1	41

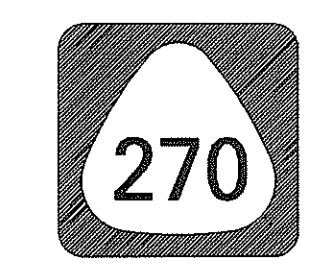

----- FEDERAL AID PROJECTS PREVIOUSLY CONSTRUCTED OR UNDER CONSTRUCTION

MILE POST 2.70 TO MILE POST 2.55
MILE POST 2.44 TO MILE POST 2.07

DESIGN DESIGNATION

ADT (1996) 5,900
ADT (2020) 11,000
DHV 894
D 50/50
T 10%
V 50 M.P.H.

CHANGES MADE DURING CONSTRUCTION HAVE BEEN INCORPORATED ON THESE PLANS EXCEPT CHANGES IN THE ORIGINAL THEORETICAL CROSSSECTIONS AND ACTUAL CROSSSECTIONS. REFER TO PROJECT RECORDS FOR CHANGES TO THESE PLANS.

APPROVED: _____
SUPERINTENDENT
PU'UKOHOLA HEIAU NATIONAL HISTORIC SITE
(For Site Grading and Work within NPS Right-of-Way Only)

DEPARTMENT OF TRANSPORTATION
STATE OF HAWAII
APPROVED: _____
DIR. OF TRANSPORTATION

LAYOUT PLAN
LENGTH OF PROJECT 0.64 MILES

