
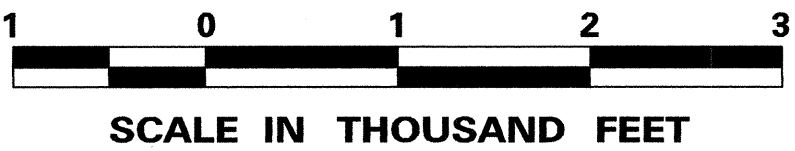
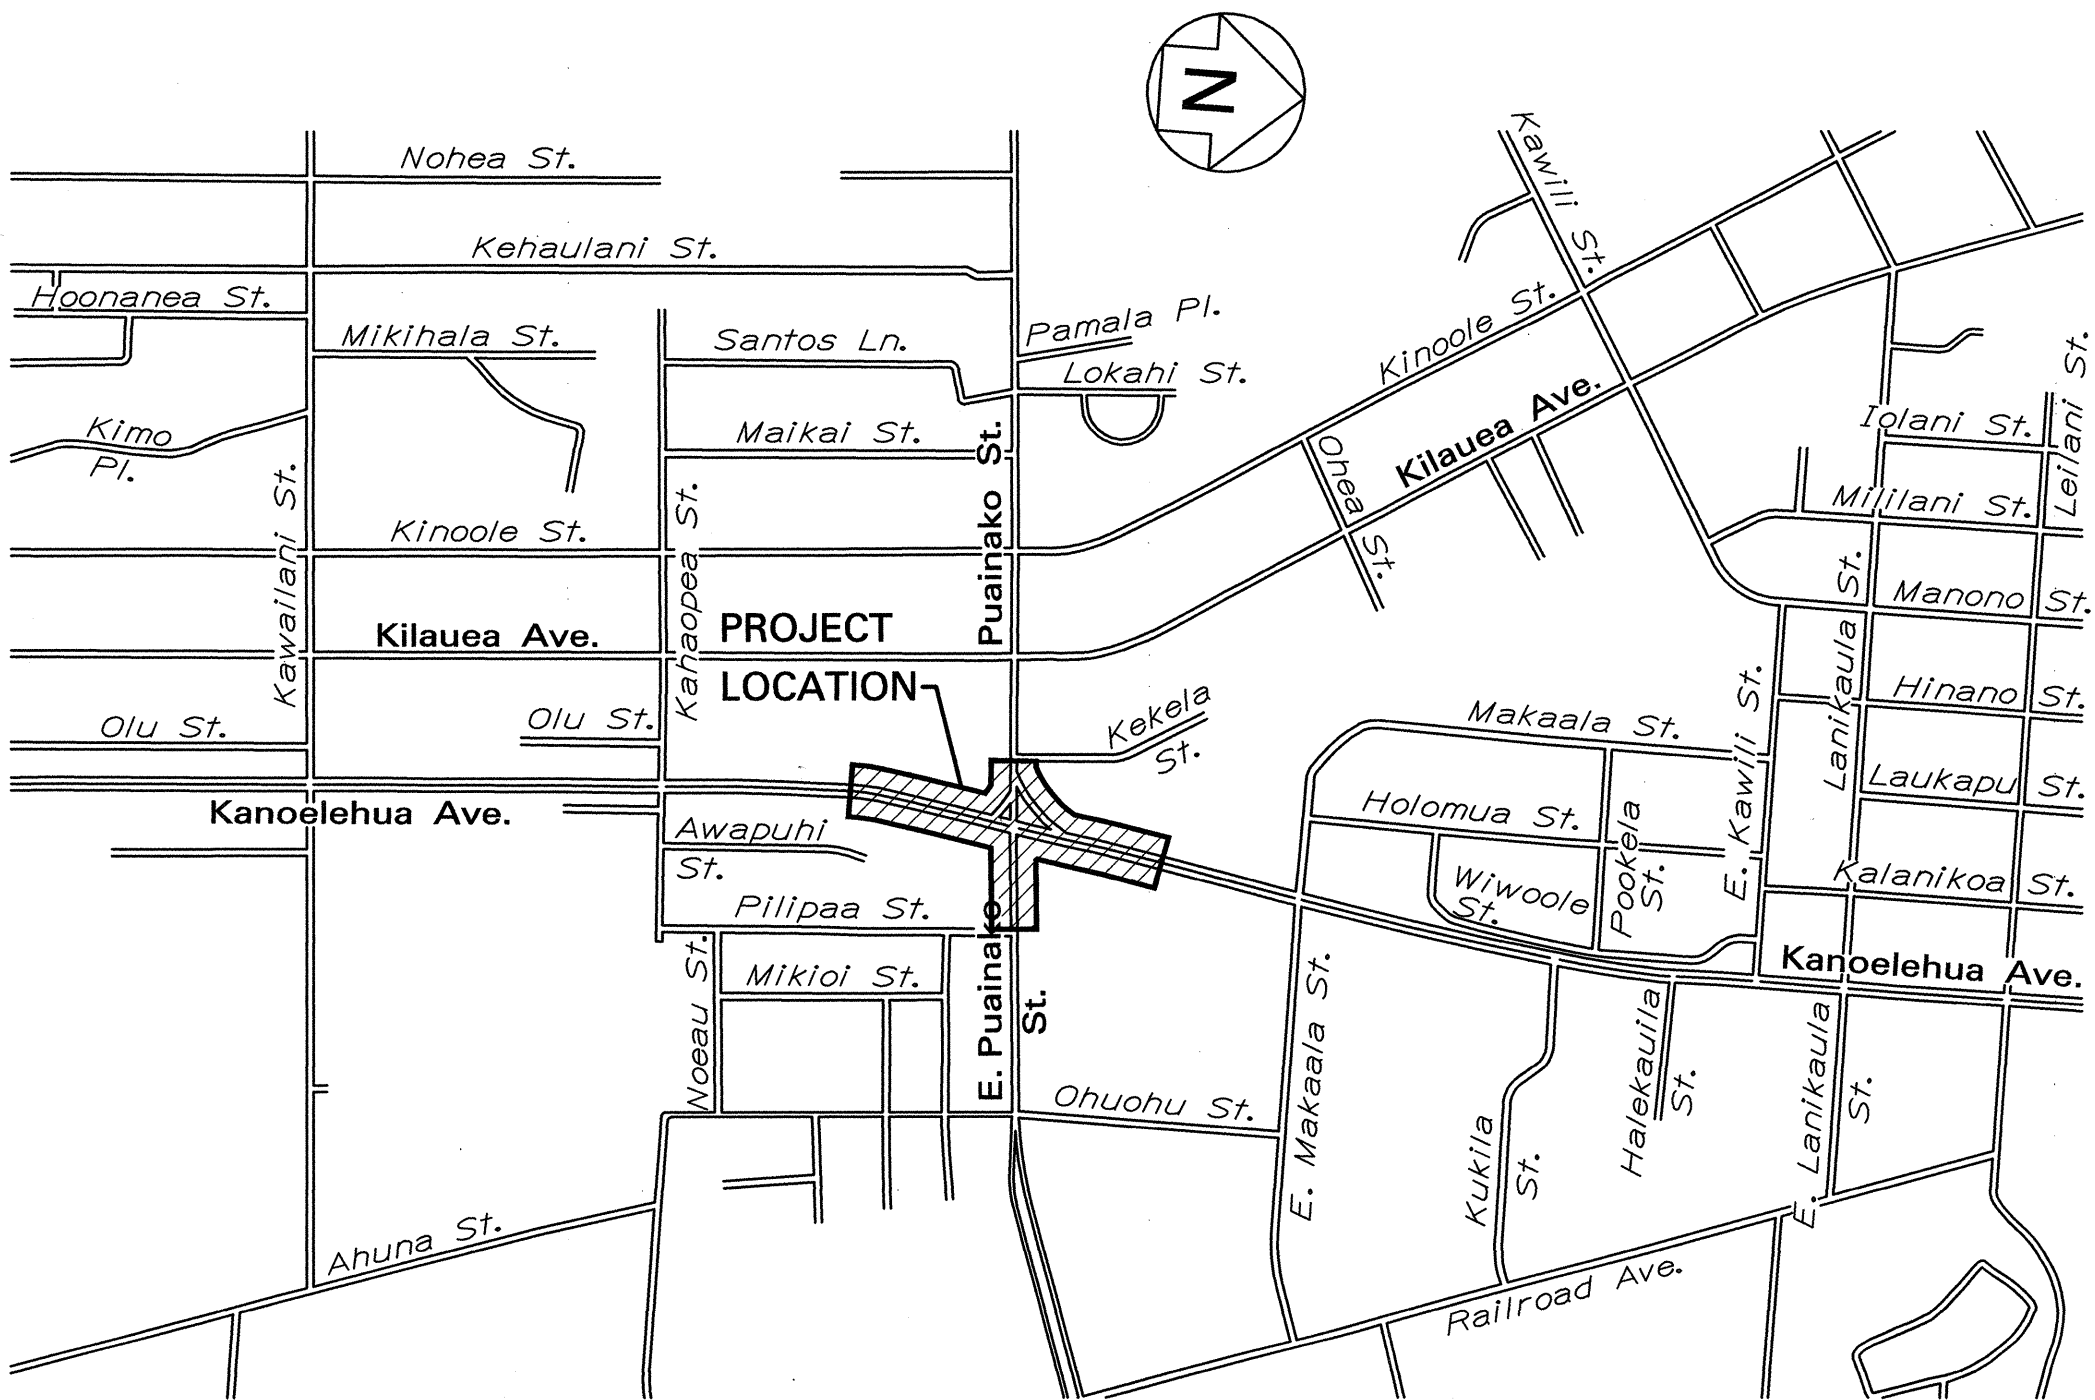
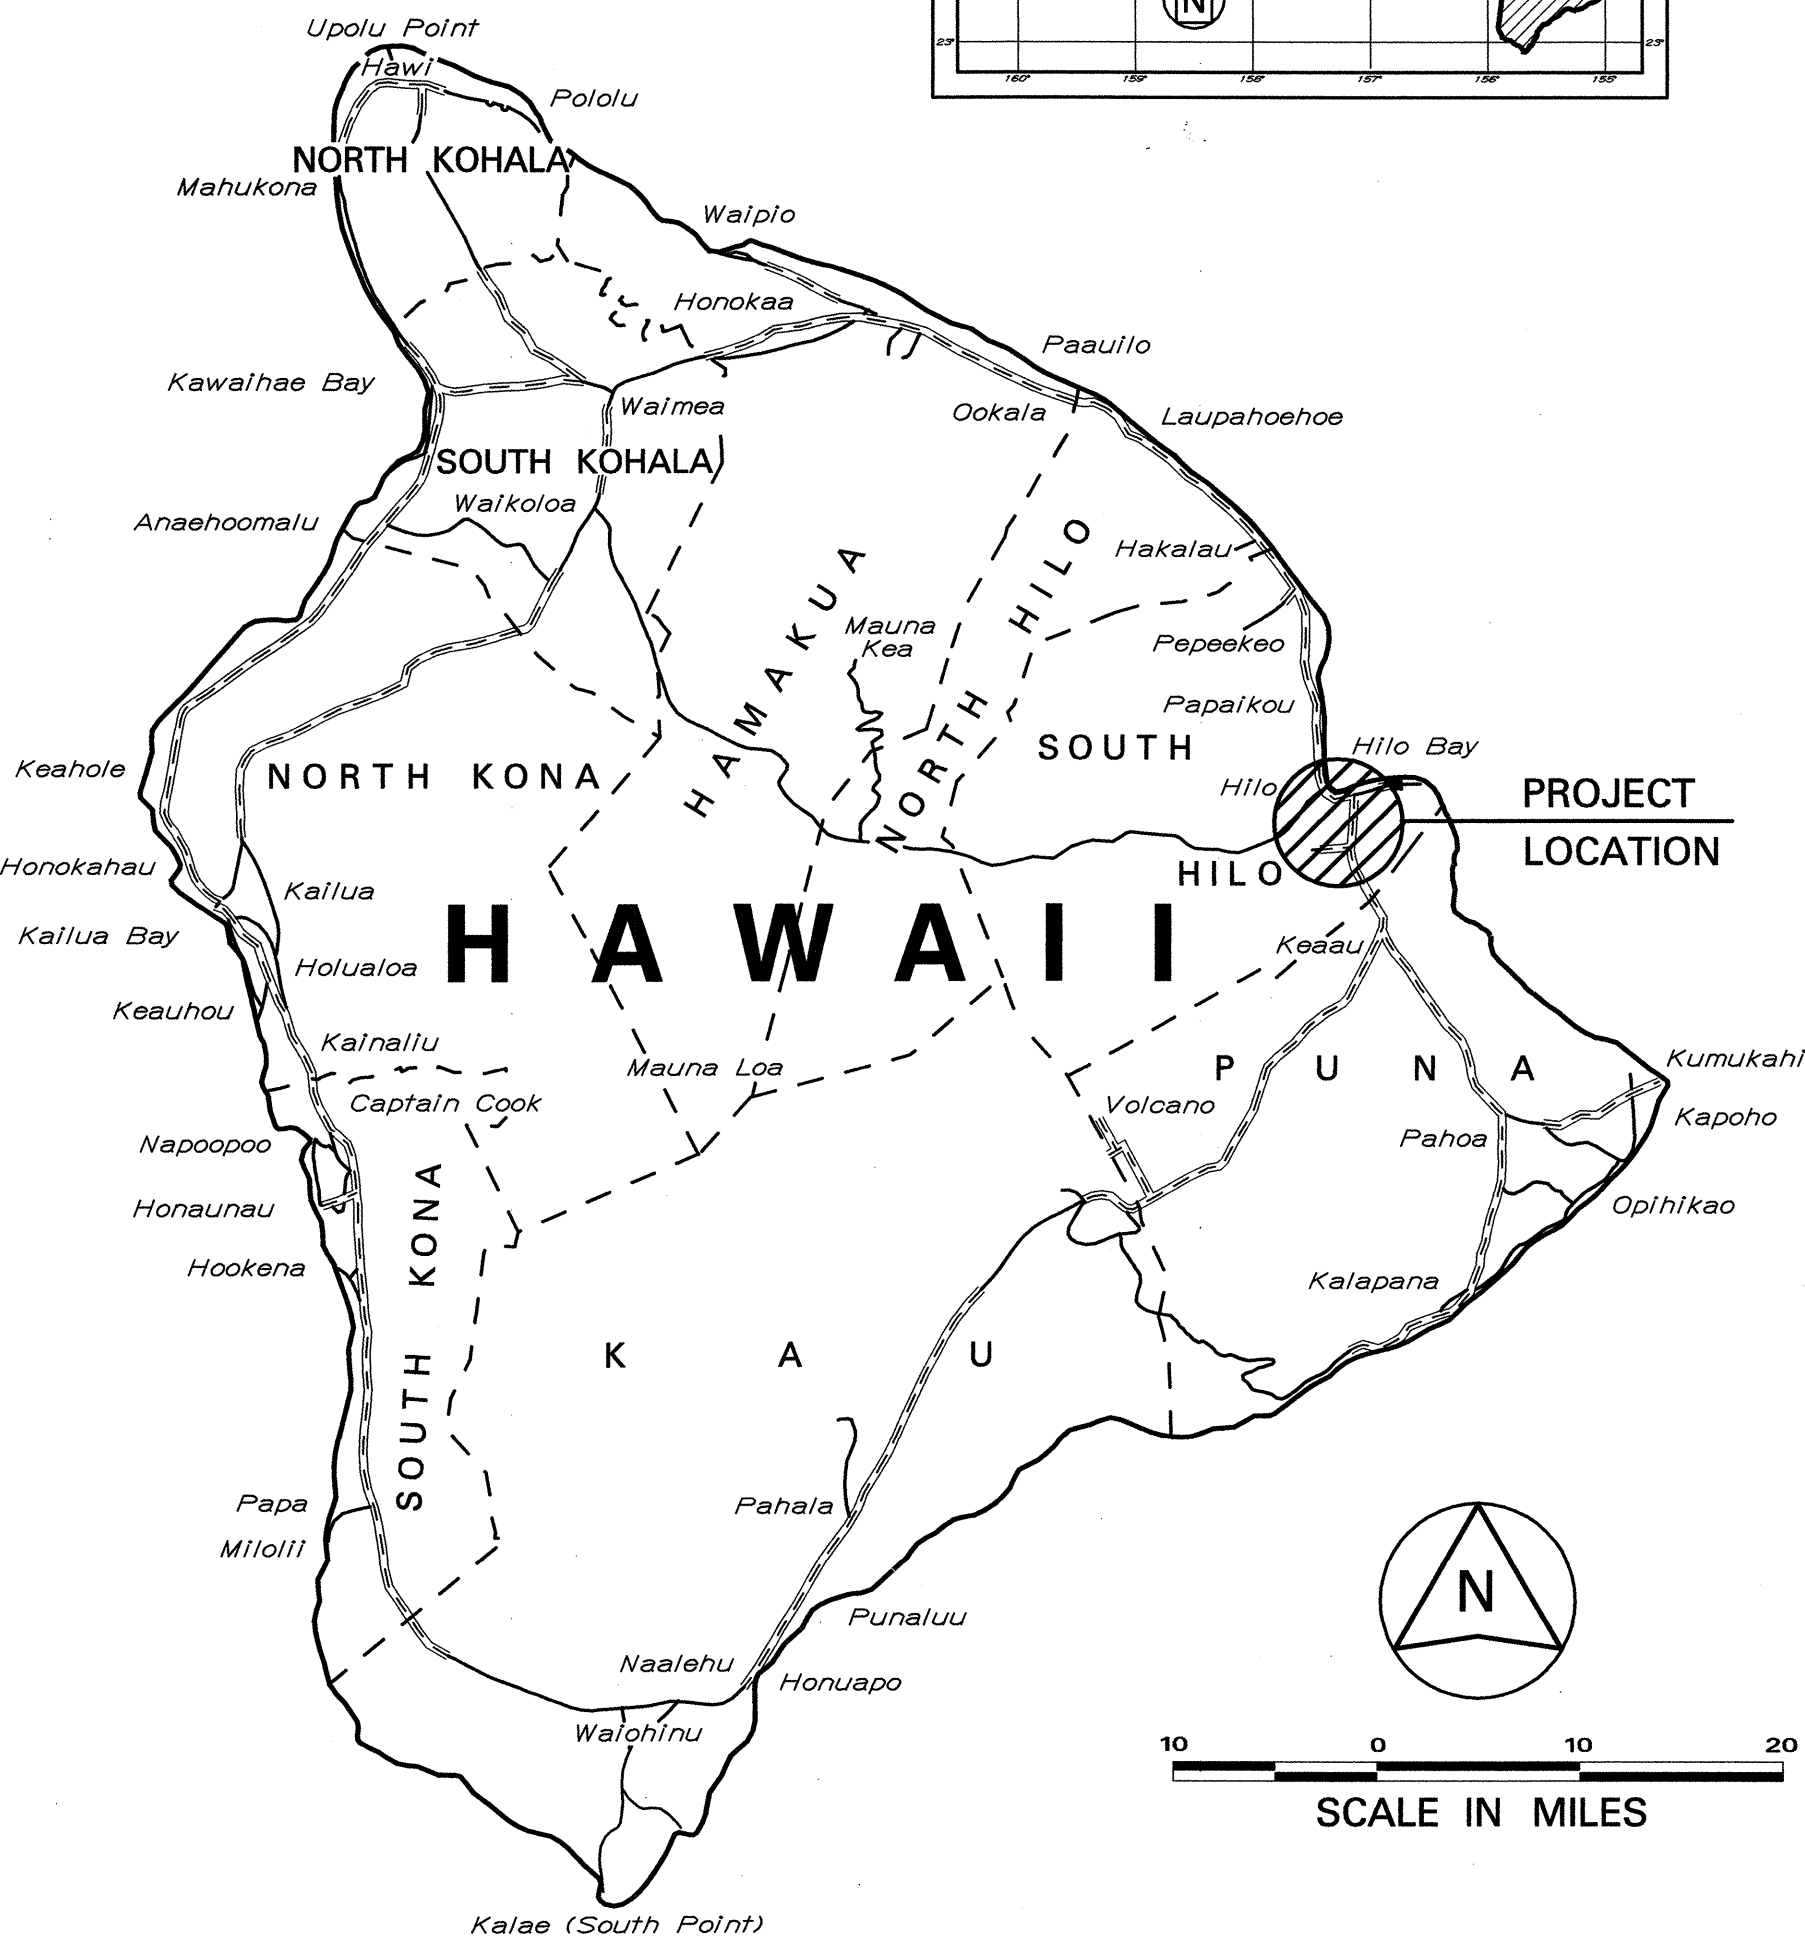


INDEX TO DRAWINGS	
SHEET NO.	DESCRIPTION
1	TITLE SHEET
2	KEY MAP
3	STANDARD PLANS SUMMARY
4-5	GENERAL NOTES, GRADING NOTES, AND LEGEND
6-9	TYPICAL SECTIONS AND DETAILS
10-12	DEMOLITION PLAN
13-17	ROADWAY PLAN
18-20	DRAINAGE DETAILS & NOTES
21-23	CURB RAMP DETAILS
24-27	GUARDRAIL DETAILS & NOTES
28	PAVEMENT MARKING, SIGNING LEGEND, & NOTES
29, 30	SIGN DETAILS & NOTES
31-35	SIGNING AND STRIPING PLAN
36-41	ROADWAY CROSS SECTIONS
42-46	TRAFFIC CONTROL PLANS
47-60	ELECTRICAL PLANS

FED. ROAD DIST. NO.	STATE	PROJ. NO.	FISCAL YEAR	SHEET NO.	TOTAL SHEETS
HAWAII	HAW.	2000E-01-00	2000	1	60

STATE OF HAWAII
DEPARTMENT OF TRANSPORTATION
HIGHWAYS DIVISION
HONOLULU, HAWAII
PLANS FOR
PUAINAKO STREET IMPROVEMENTS
KILAUEA AVENUE TO KANOELEHUA AVENUE
PROJECT NO. 2000E-01-00
DISTRICT OF SOUTH HILO
ISLAND OF HAWAII

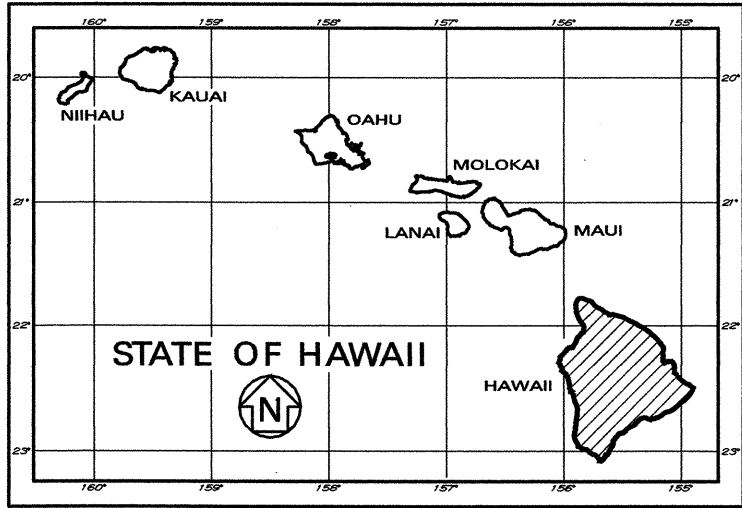

LAYOUT PLAN
NET LENGTH OF PROJECT..... 0.65 MILES

FEDERAL AID PROJECTS PREVIOUSLY CONSTRUCTED
OR UNDER CONSTRUCTION
ROUTE 11 (KANOELEHUA AVENUE) MILE POST 2.07
TO MILE POST 1.79

DEPARTMENT OF TRANSPORTATION
STATE OF HAWAII
APPROVED: *[Signature]* 8/10/00
DIR. OF TRANSPORTATION DATE

DMT CONSULTANT ENGINEERS
DESIGNED BY
R. TAIRA
P. S. & E. BY
933-8866
PHONE
MAY, 2000
DATE