
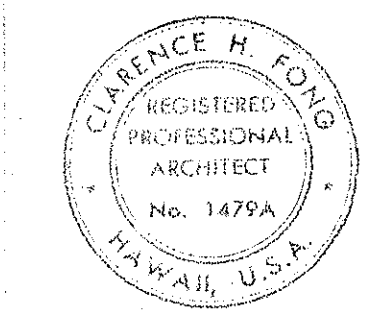
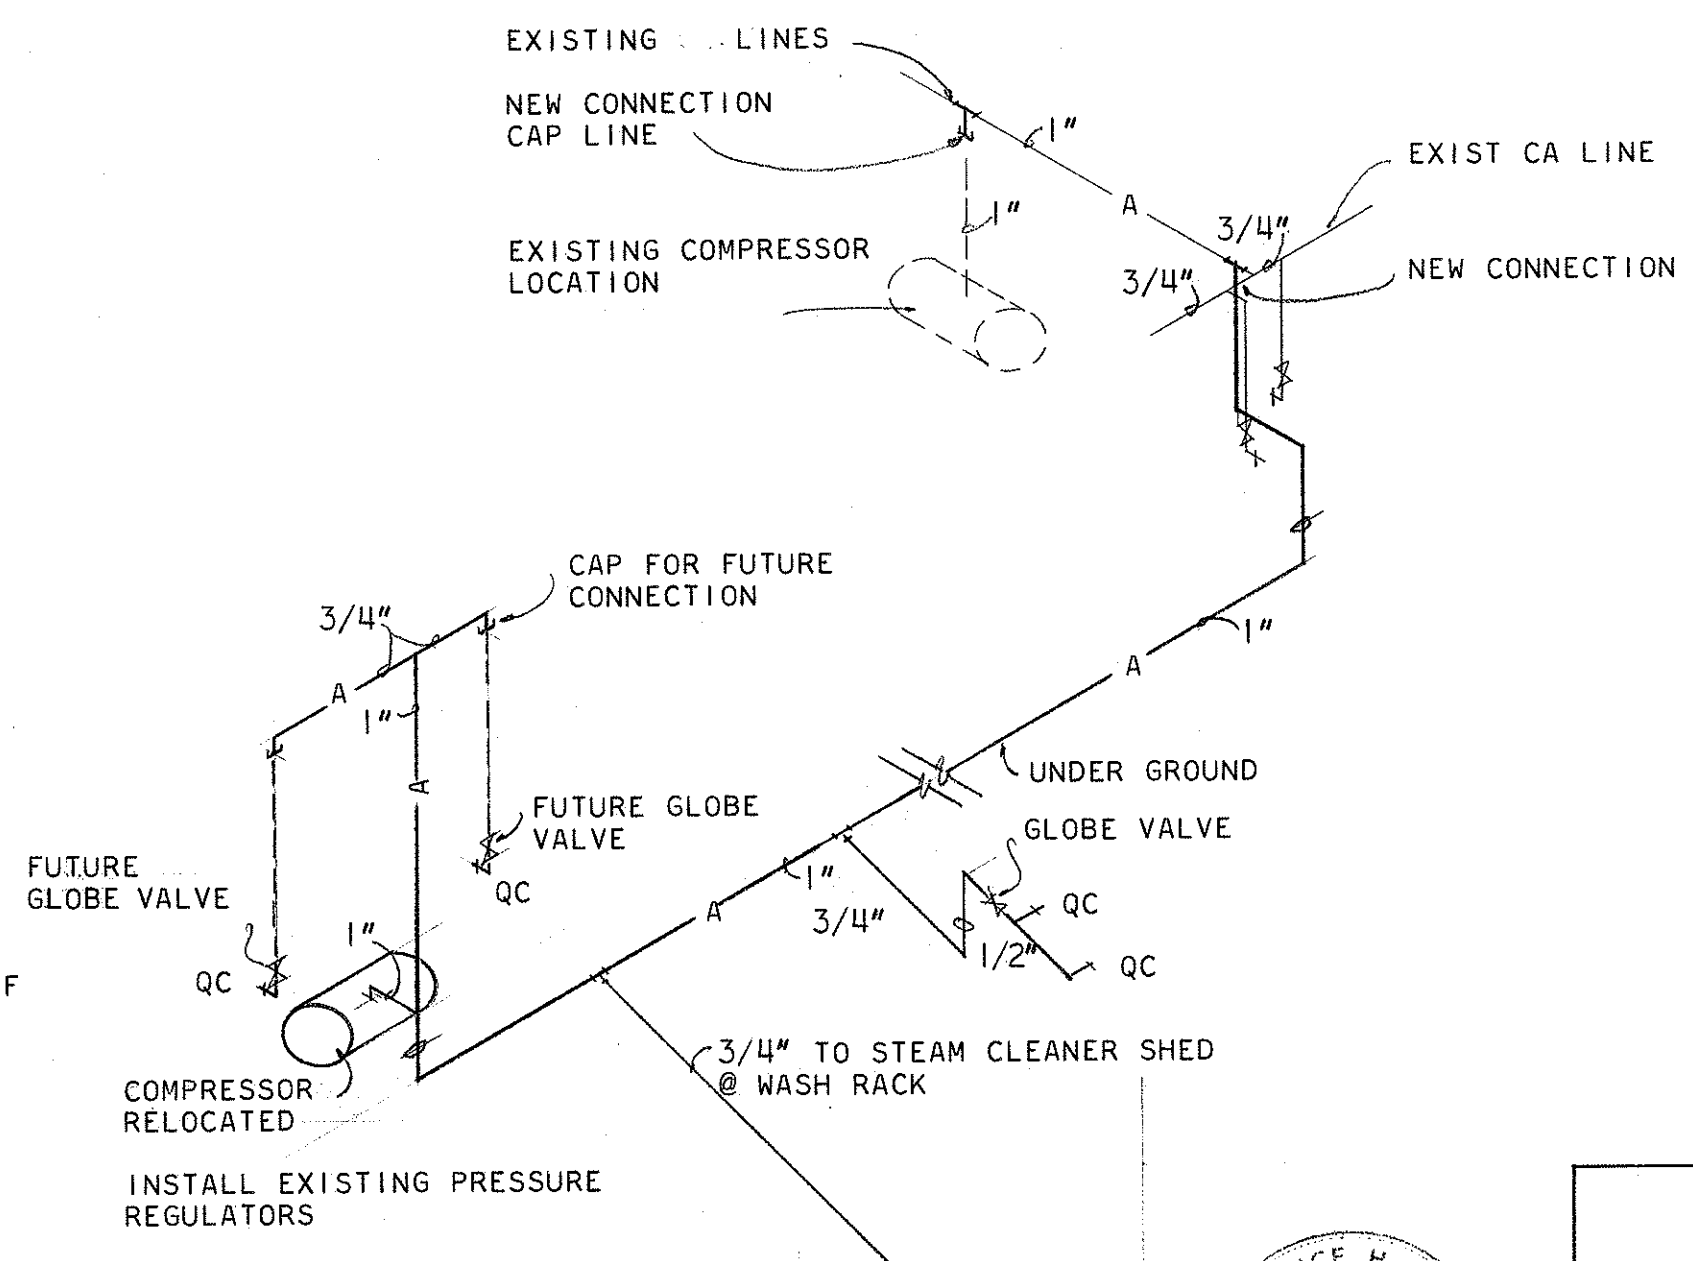
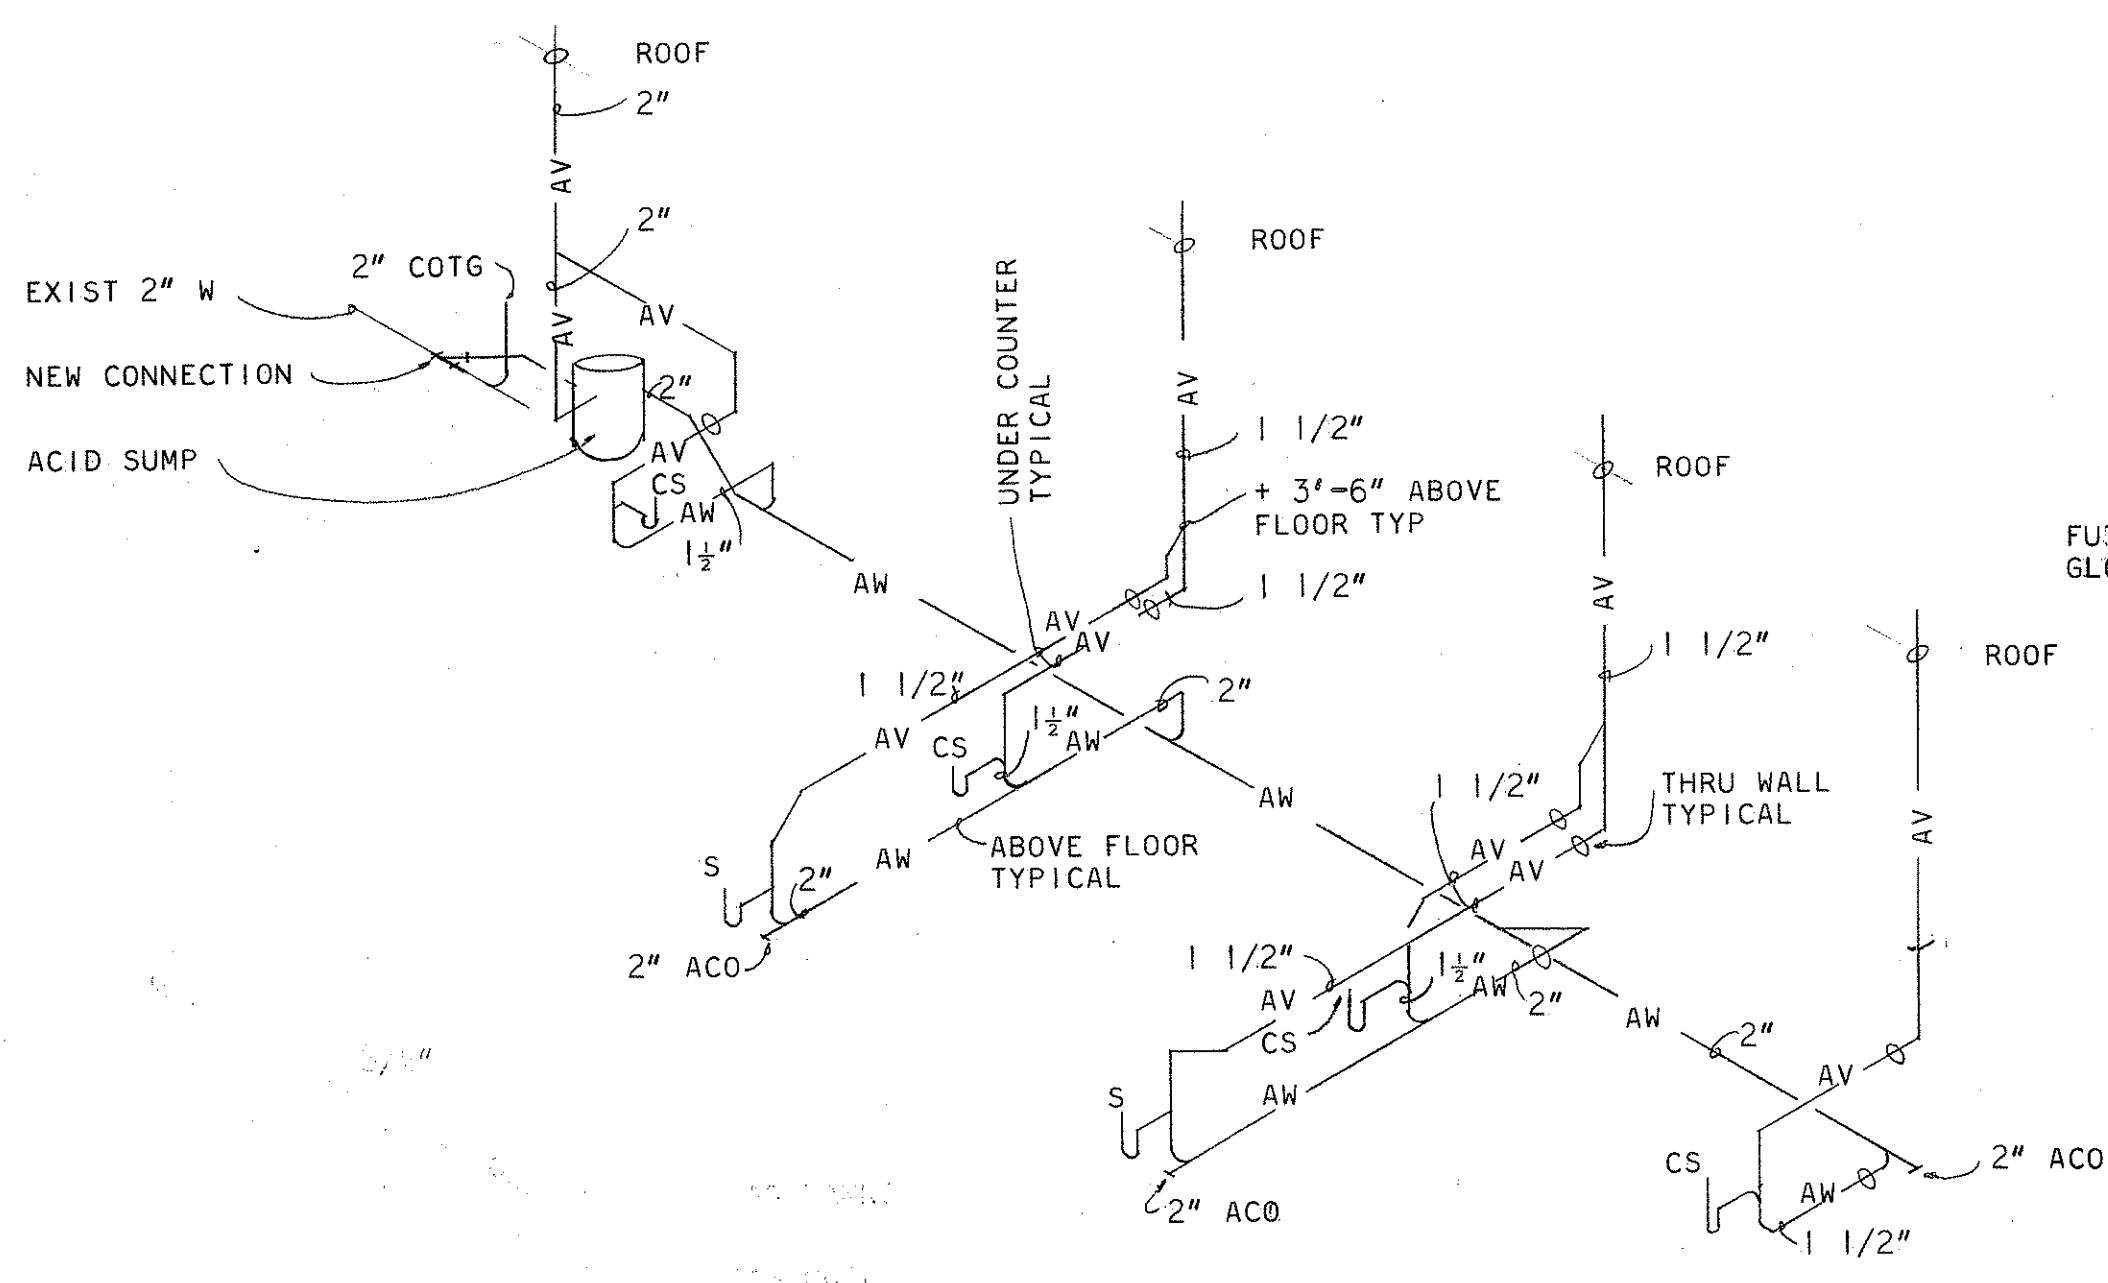
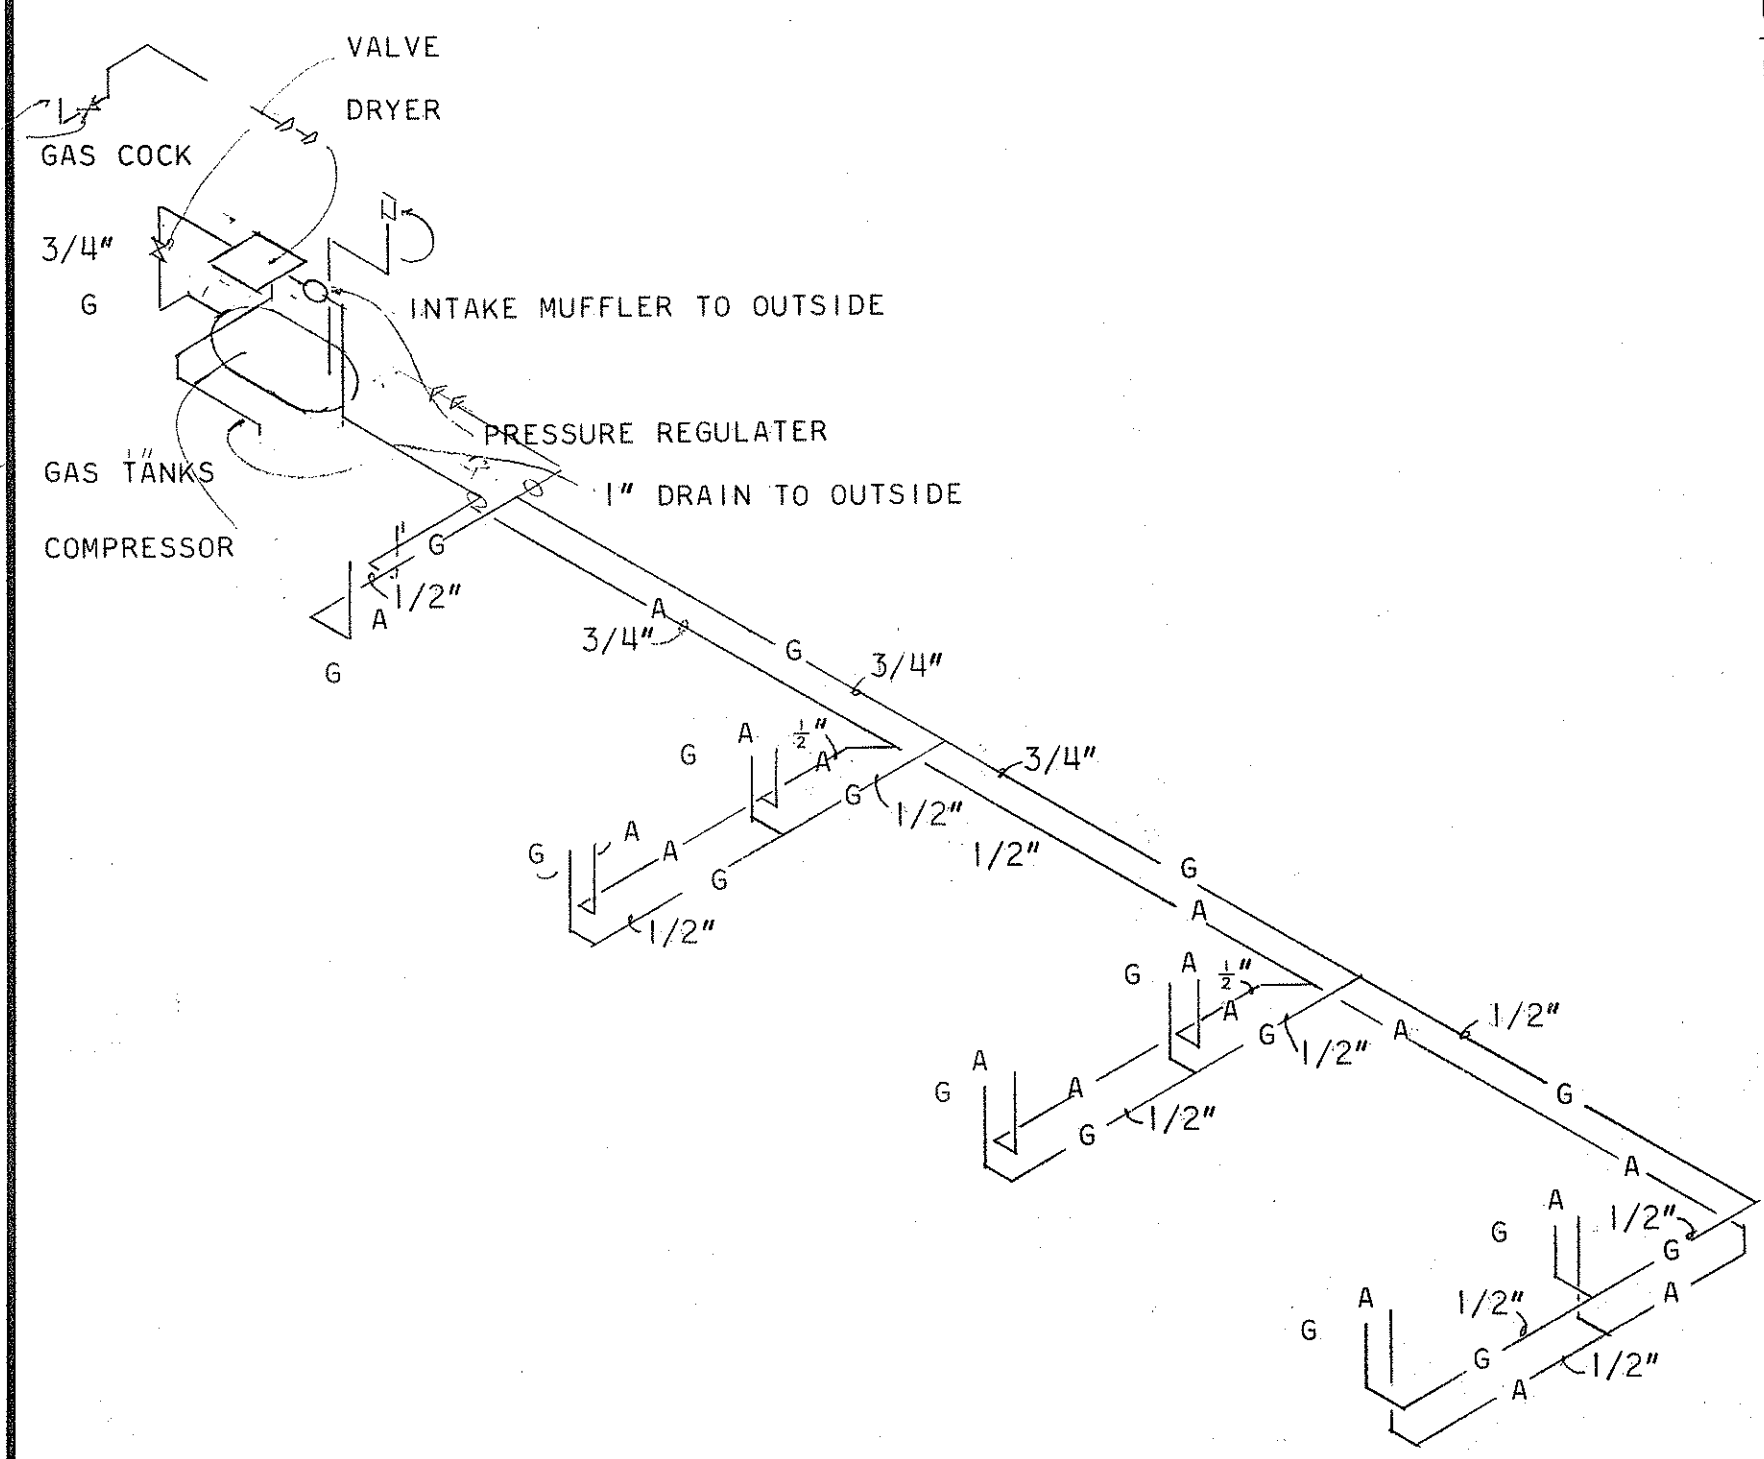
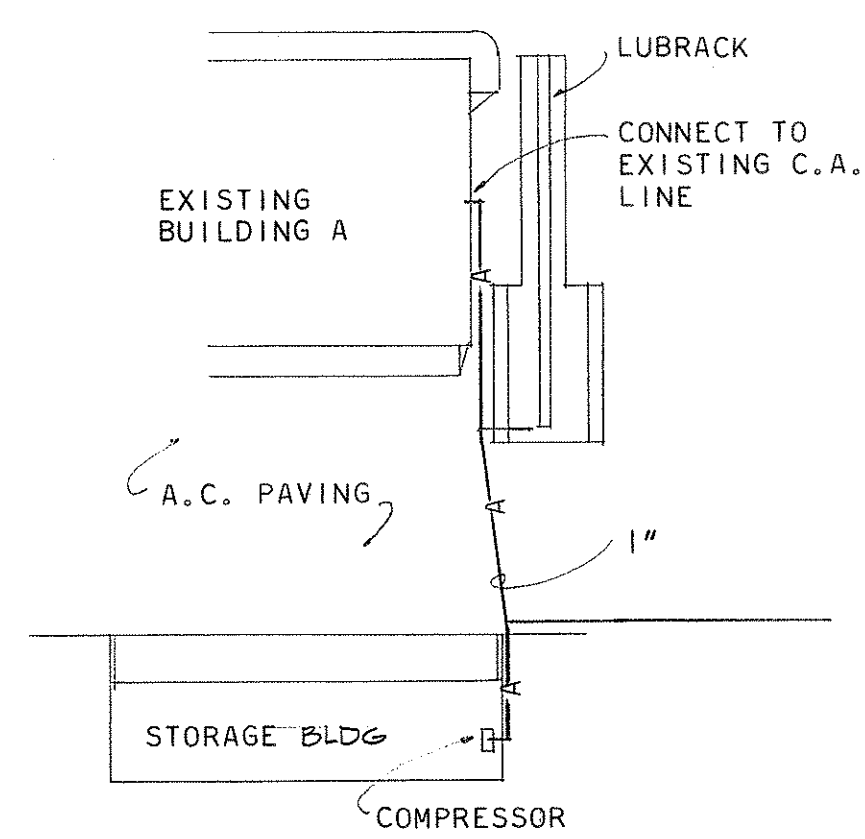
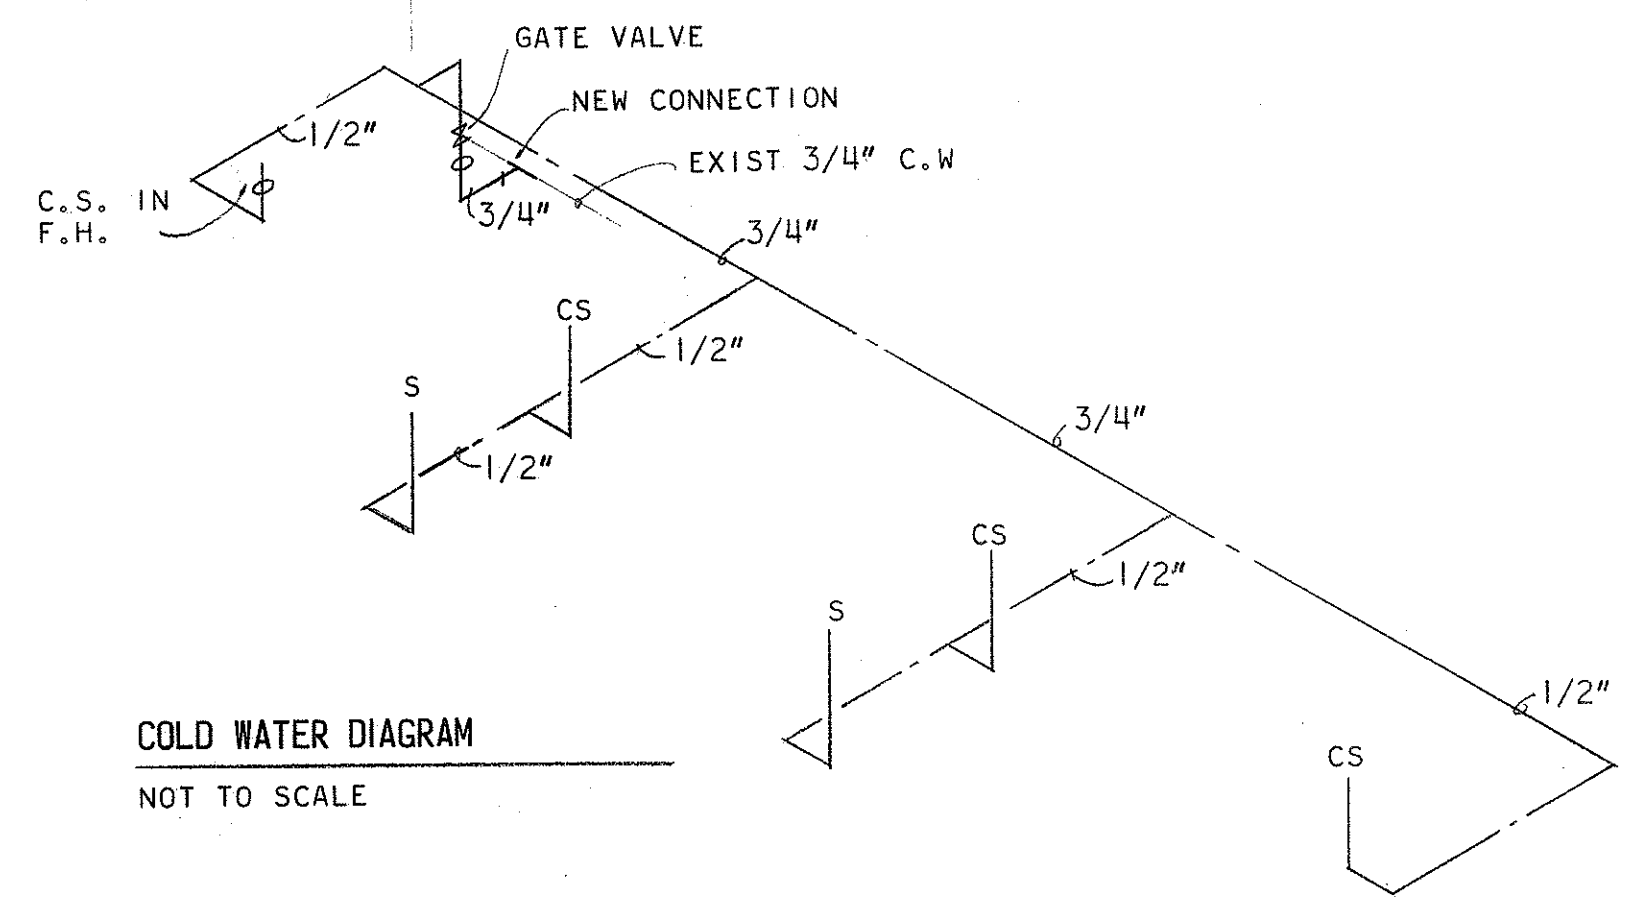
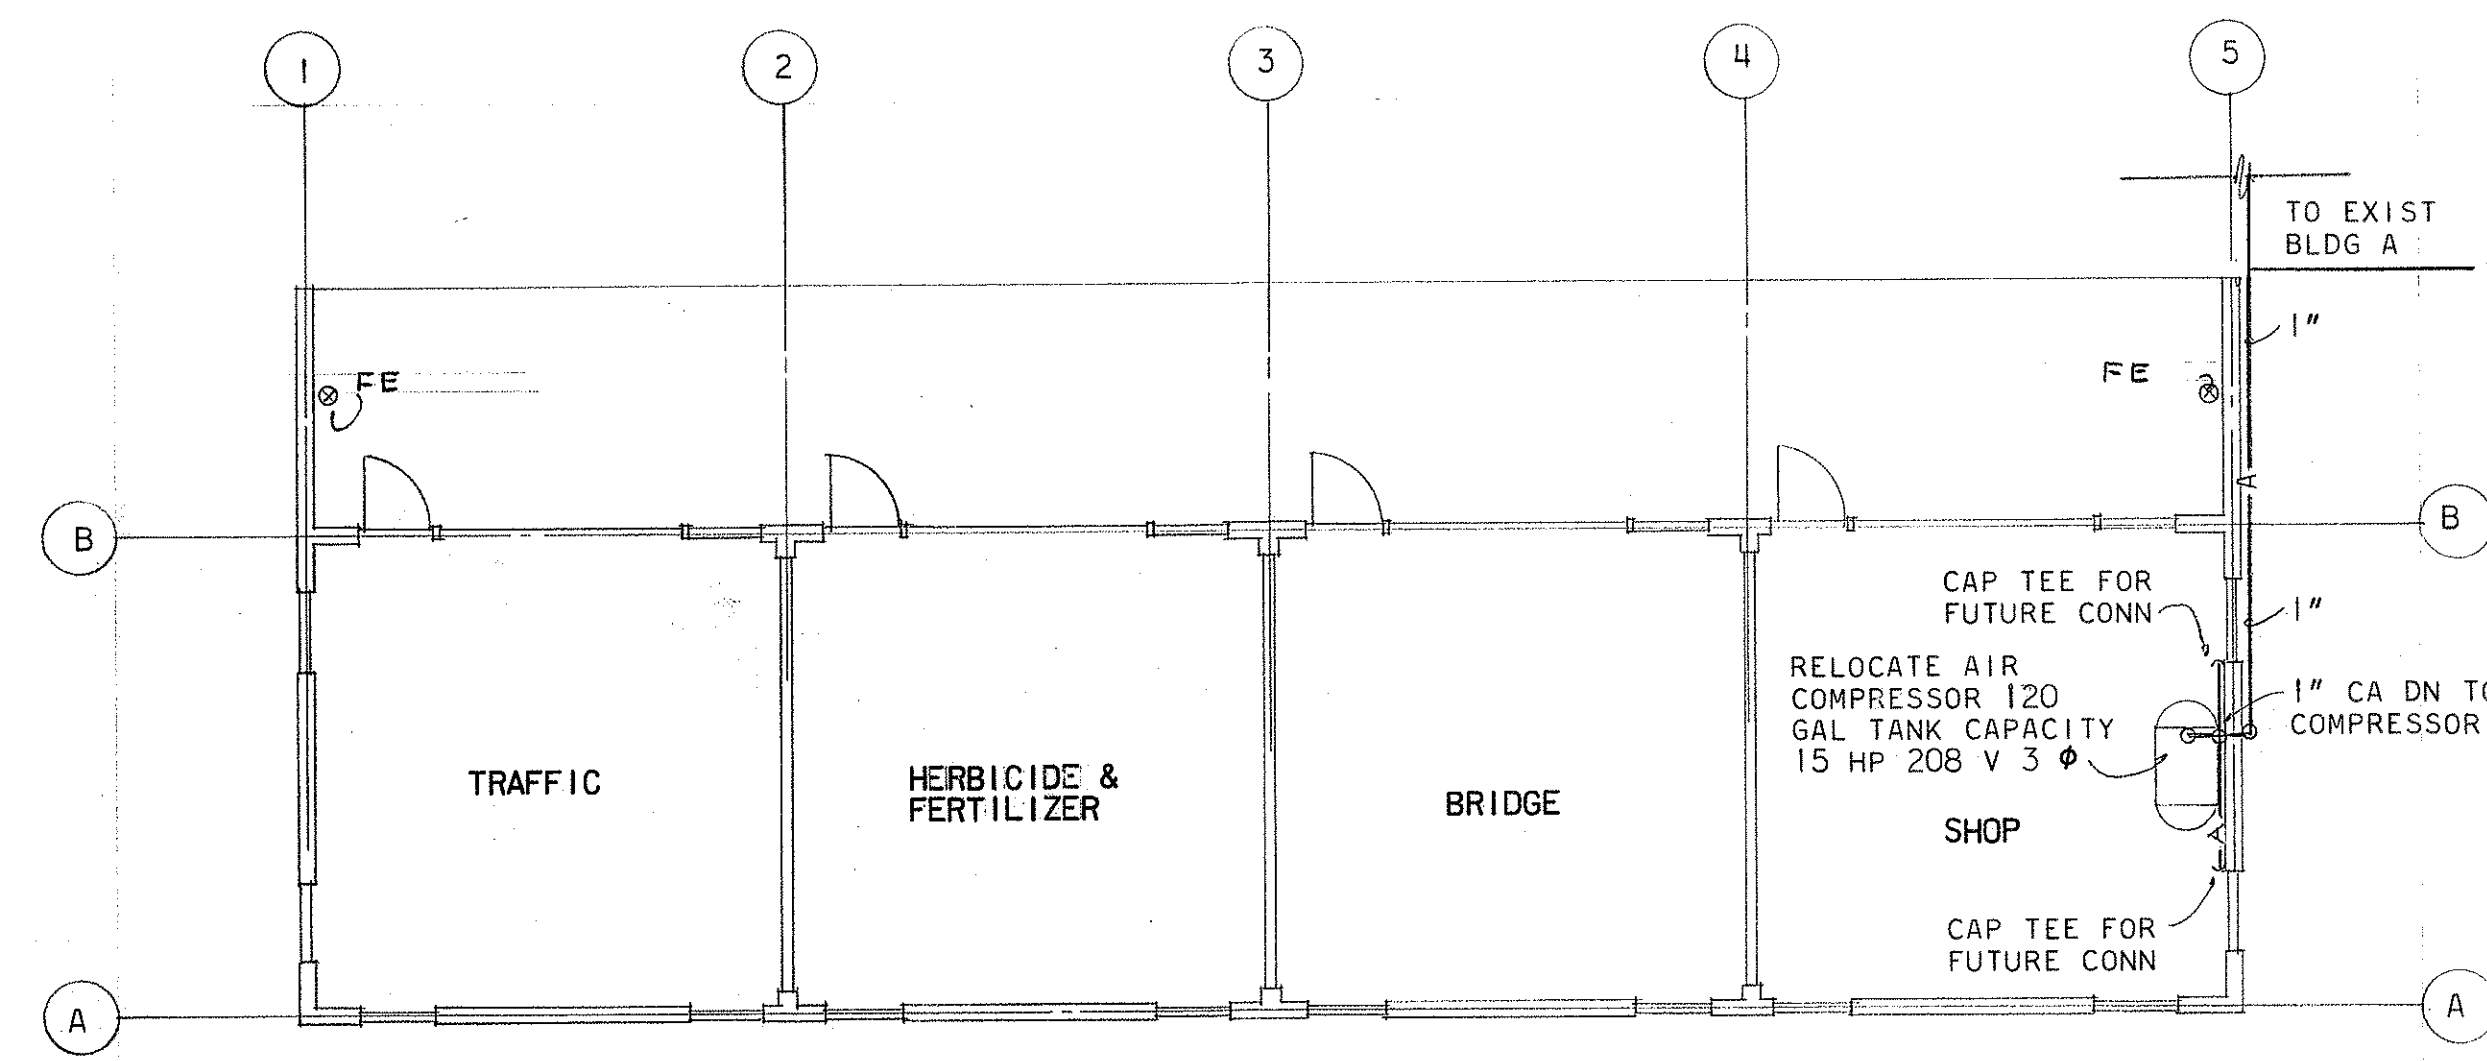
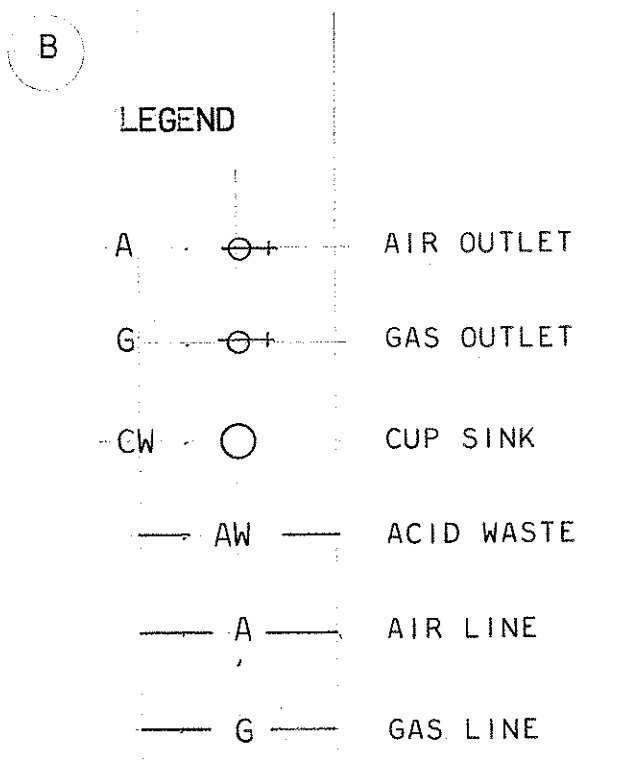


FED. ROAD DIST. NO.	STATE	FED-AID PROJ. NO.	FISCAL YEAR	SHEET NO.	TOTAL SHEETS
HAWAII	HAW.	HWY. K 01-75	1976	22	25

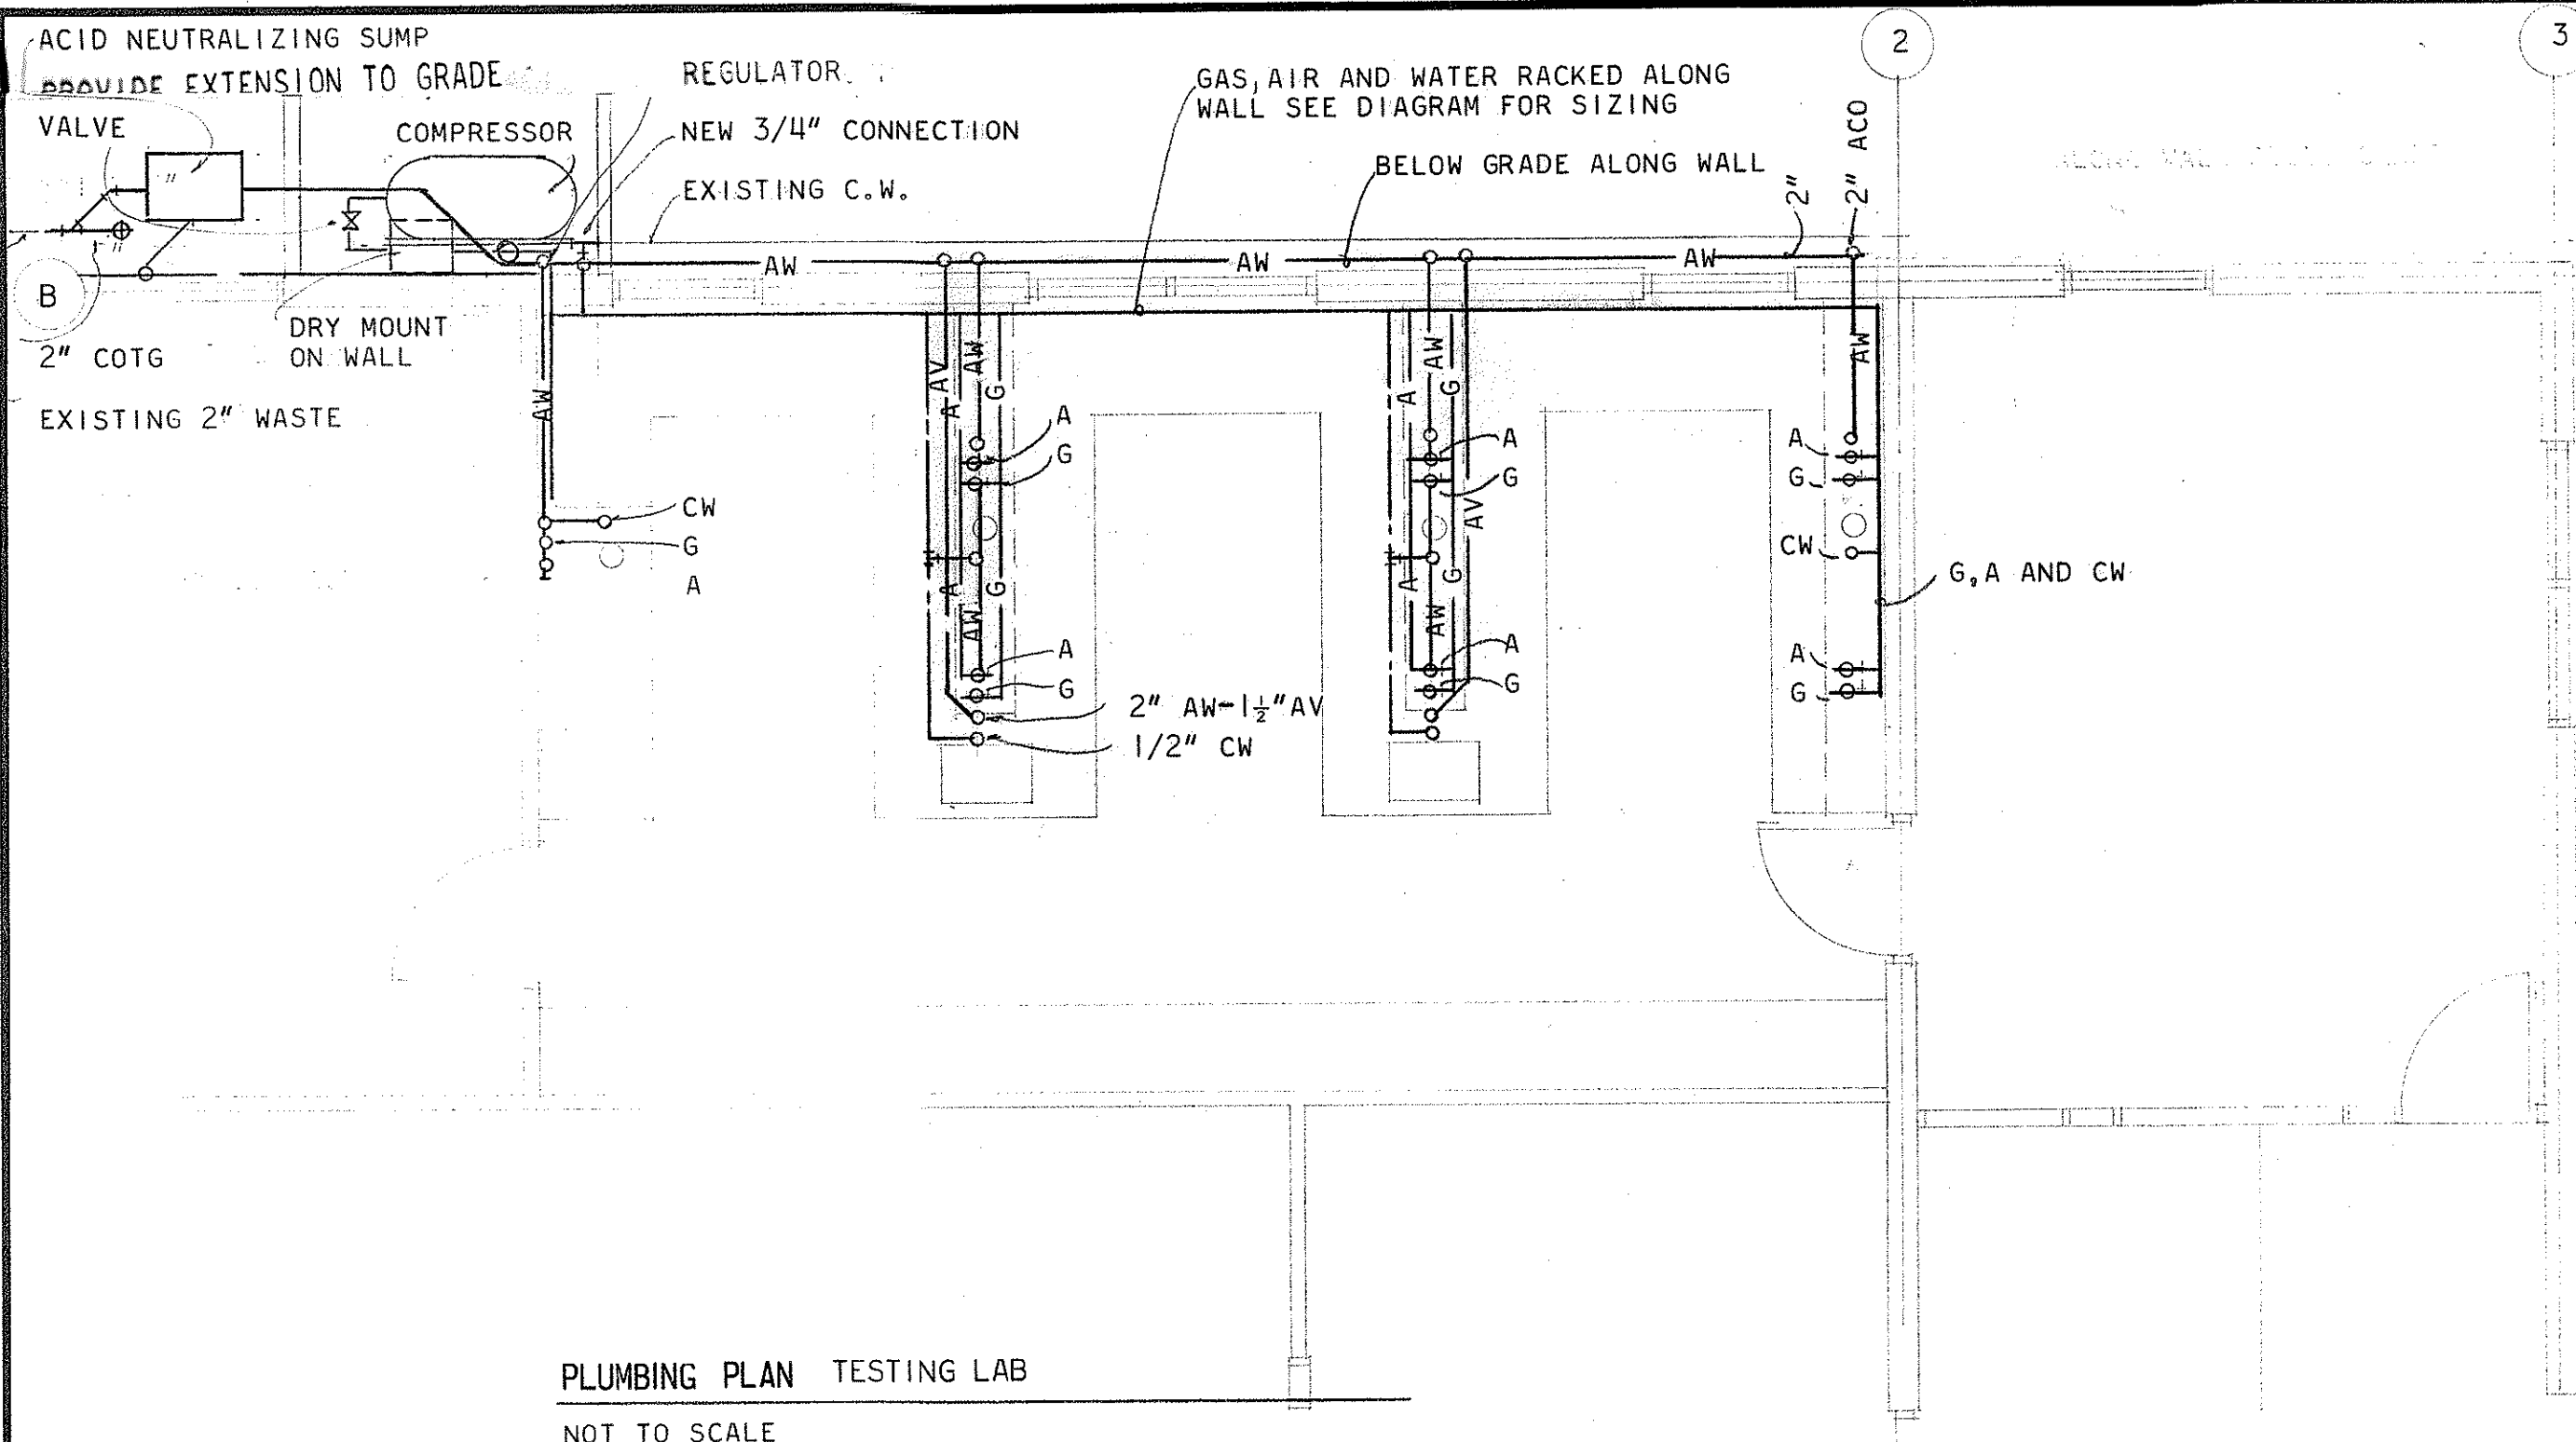

STATE OF HAWAII DEPARTMENT OF TRANSPORTATION HIGHWAYS DIVISION	
KAPAA BASEYARD PHASE II KAPAA KAUAI	
PLUMBING PLAN & DIAGRAM COMPRESSED AIR PLAN & DIAGRAM	
SCALE AS NOTED 7-1-76	HWY-K-01-75
SHEET NO. 1 OF 1 SHEETS	

P I