




FED. ROAD DIST. NO.	STATE	PROJ. NO.	FISCAL YEAR	SHEET NO.	TOTAL SHEETS
HAWAII	HAW.	HWY-K-01-94M	1994	9	10

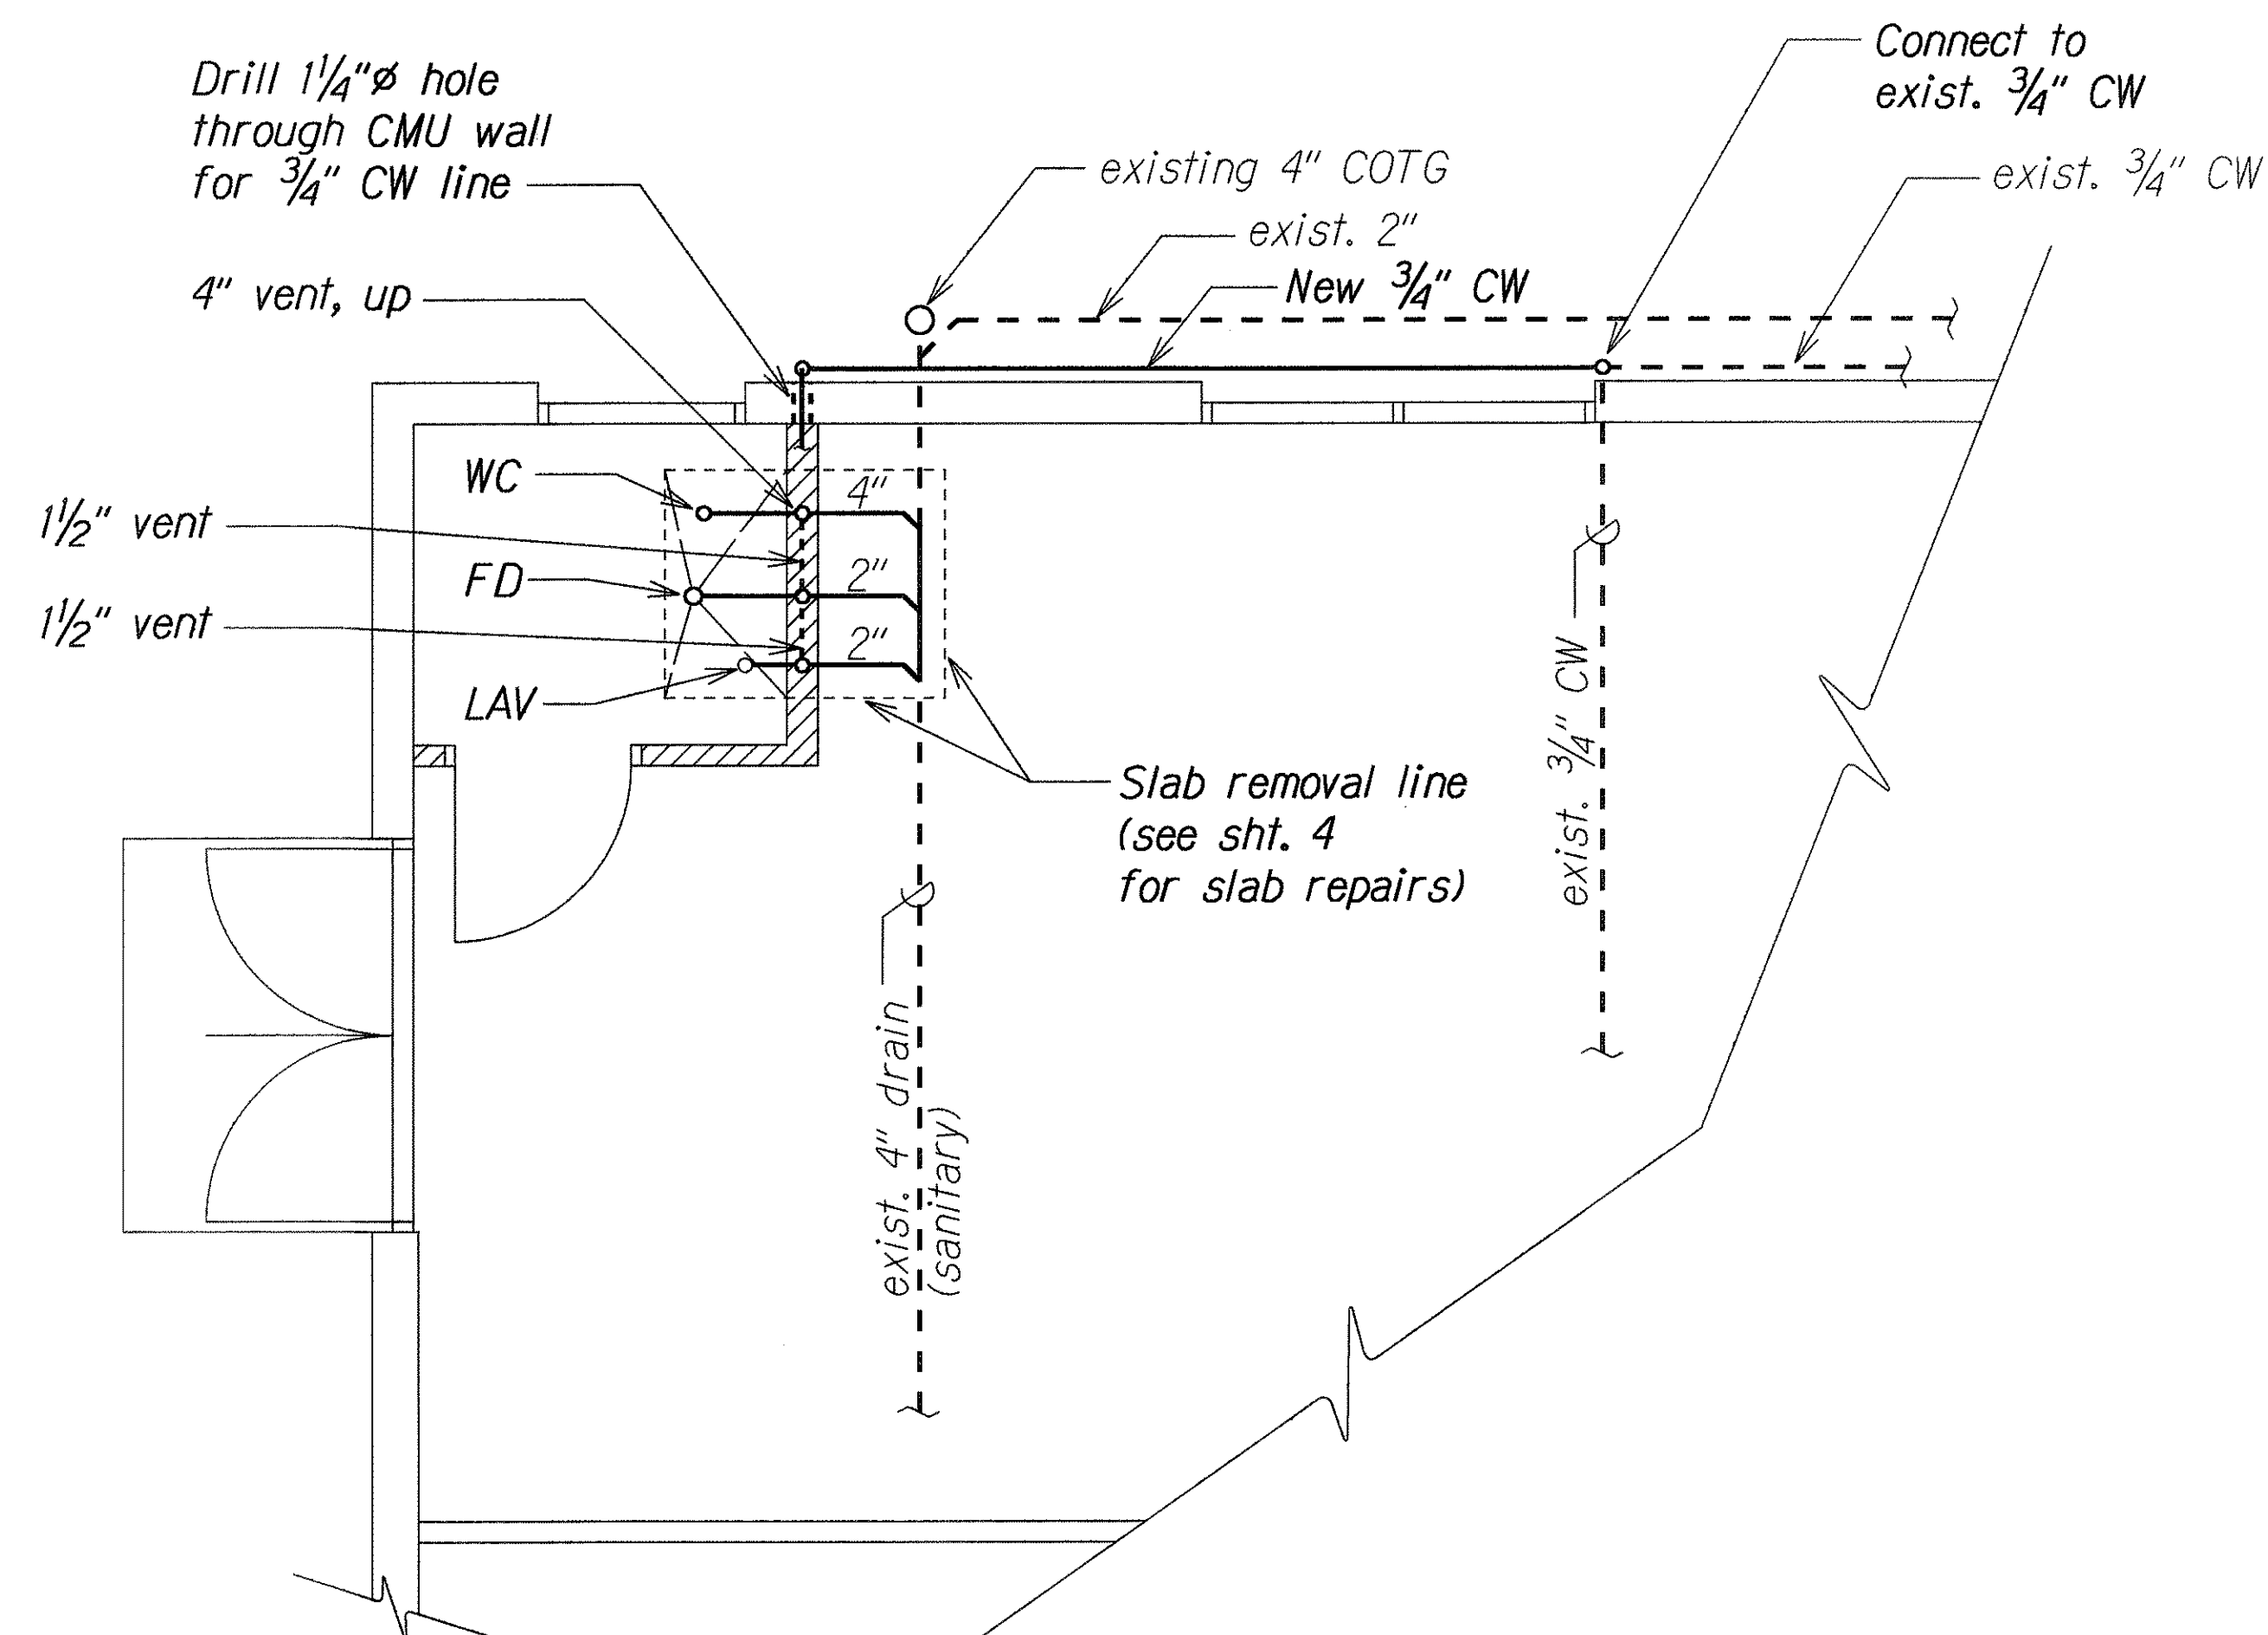


**PLUMBING PLAN**  
Scale:  $\frac{3}{8}"=1'$

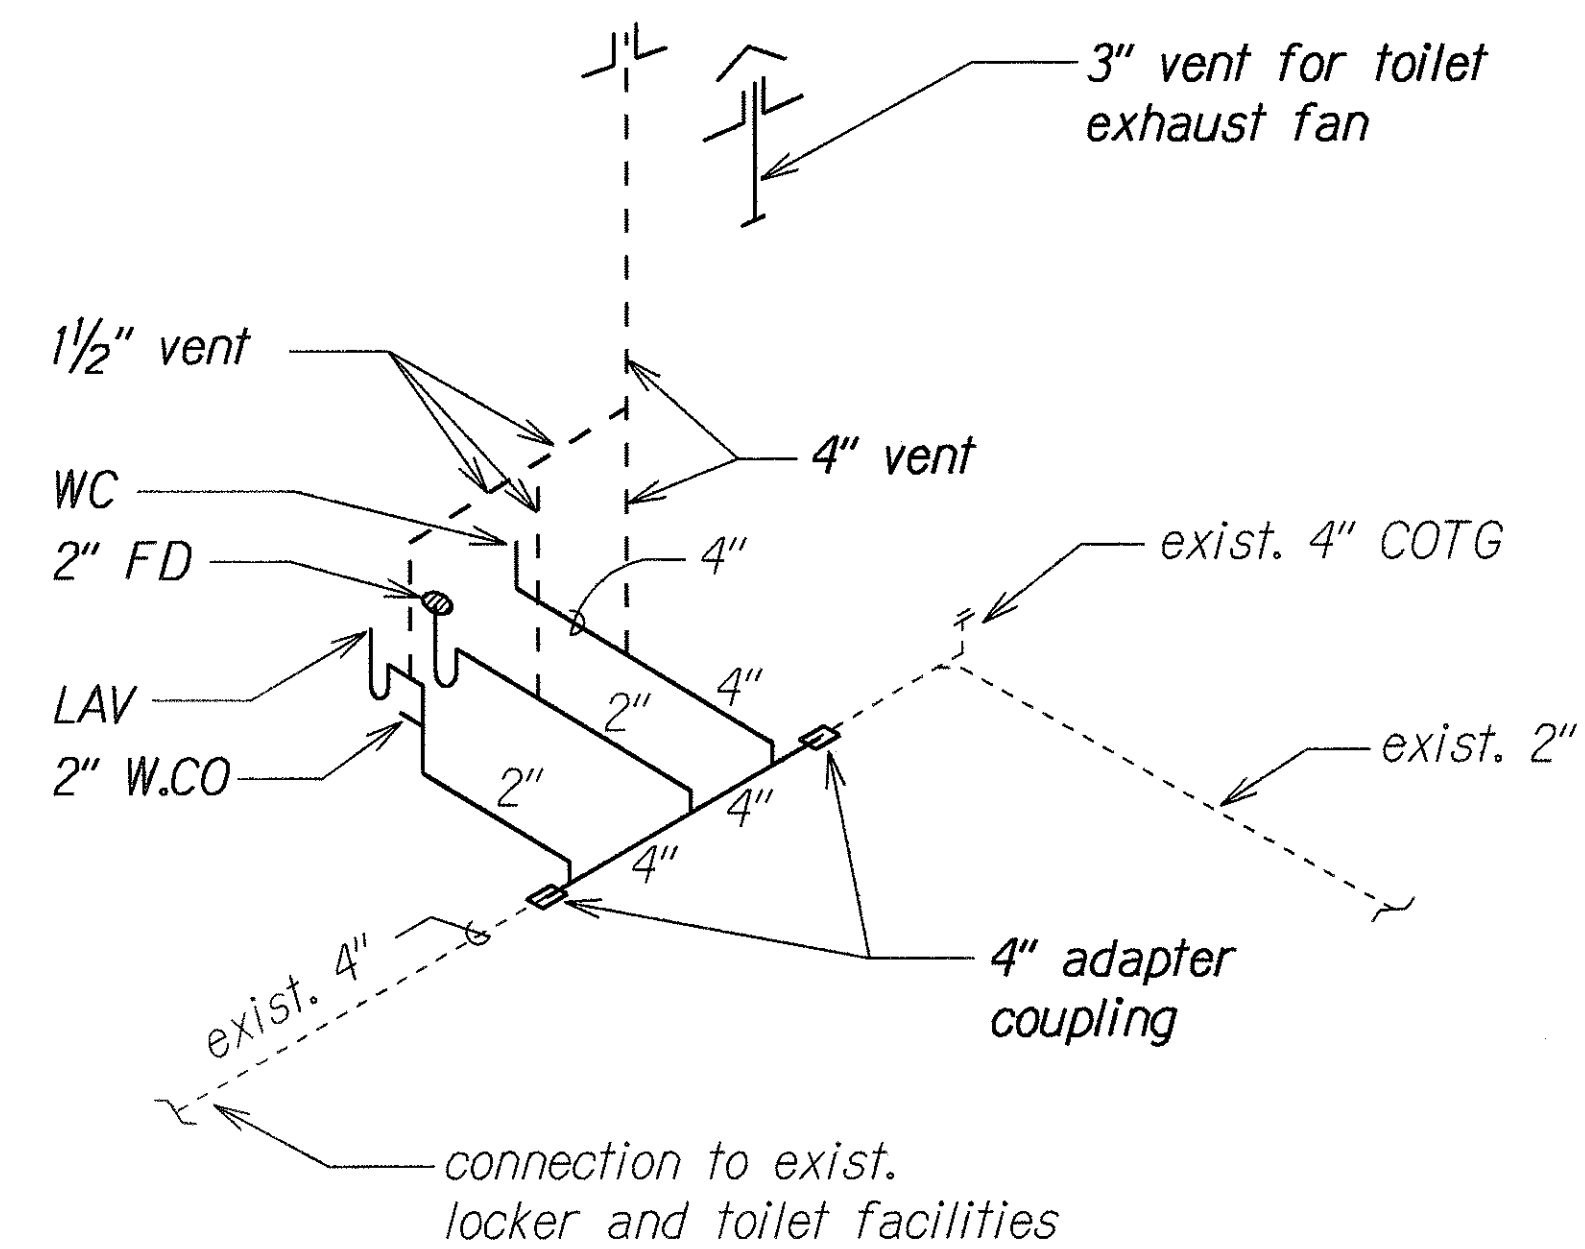

**SANITARY SEWER DIAGRAM**  
**FOR NEW BATHROOM (BUILDING C)**  
Not to Scale

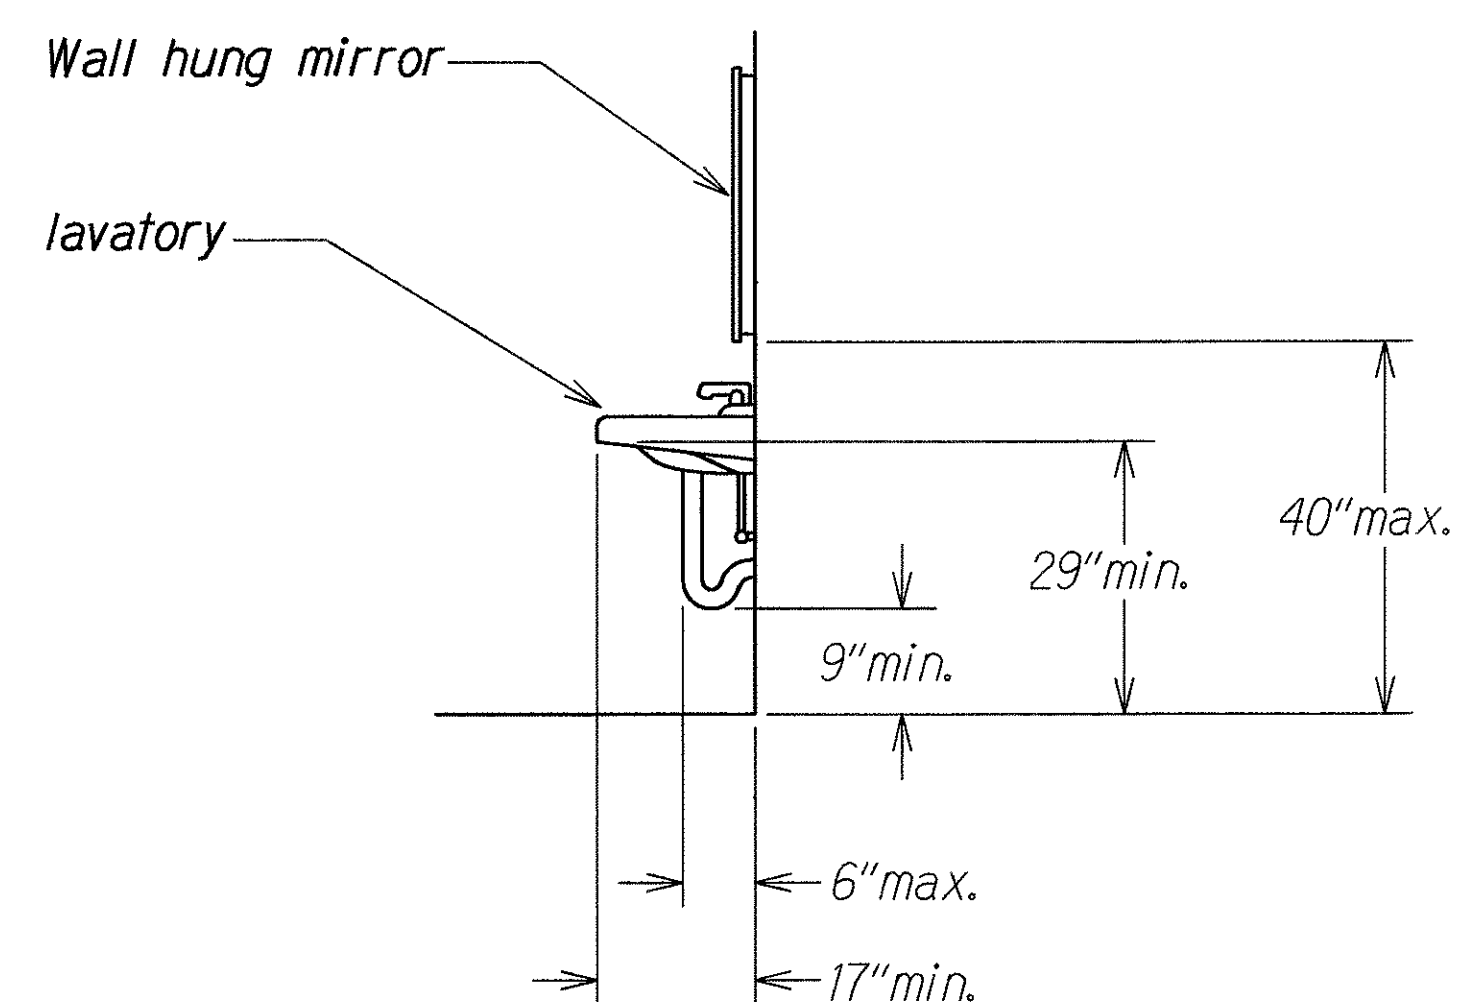

**LAVATORY CLEARANCES**  
Not to Scale

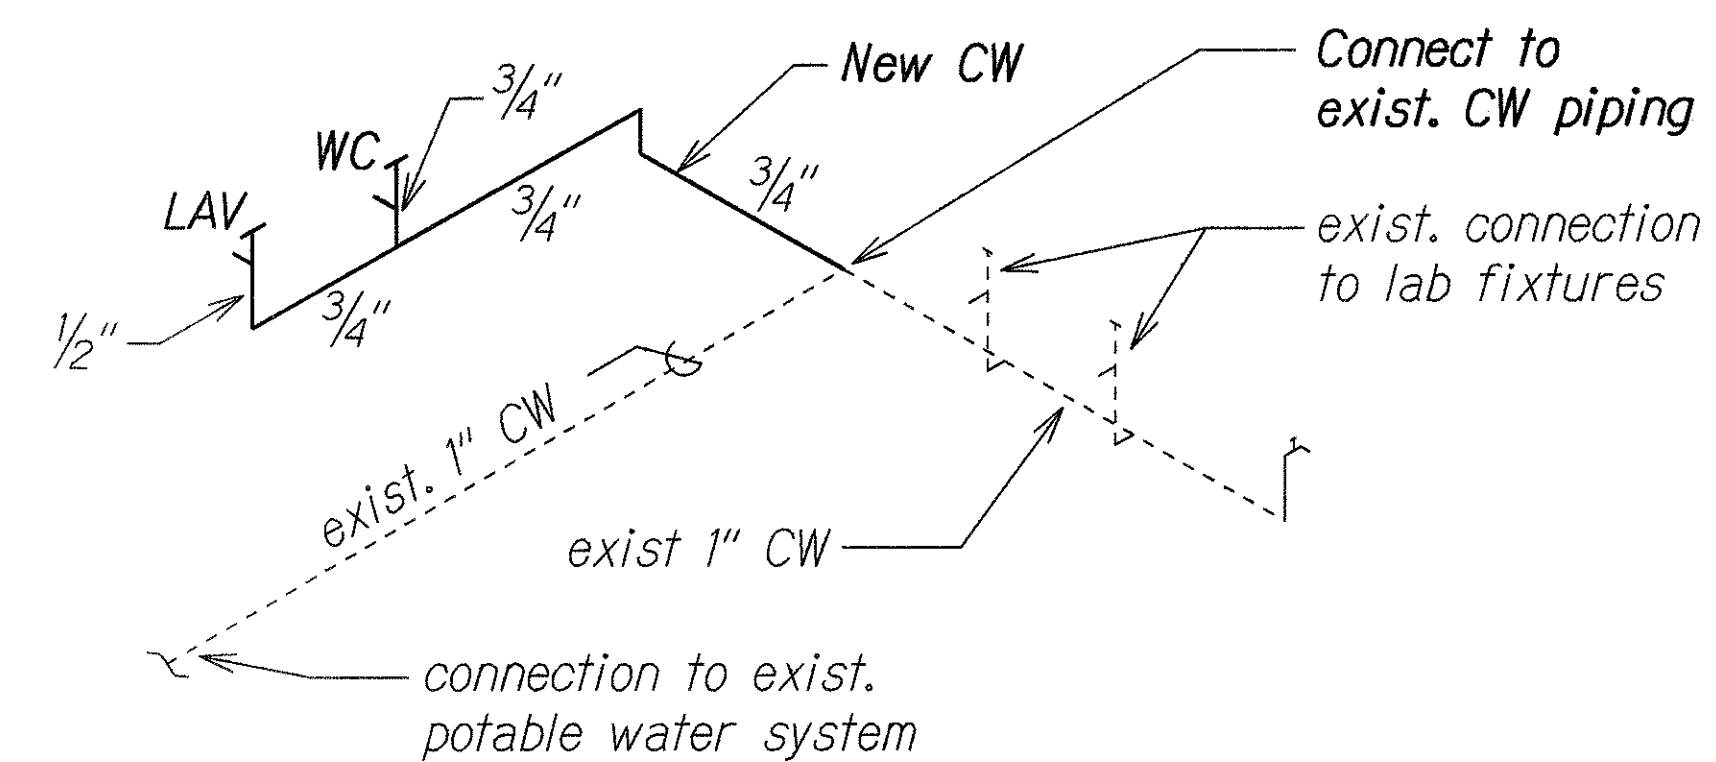

**COLD WATER PIPING DIAGRAM**  
**FOR NEW BATHROOM (BUILDING C)**  
Not to Scale

ORIGINAL PLAN	SURVEY PLOTTED BY	DATE
NOTE BOOK	DRAWN BY	
	DESIGNED BY	
	CHECKED BY	

STATE OF HAWAII  
DEPARTMENT OF TRANSPORTATION  
HIGHWAYS DIVISION

**PLUMBING DETAILS  
AND PIPING DIAGRAM**

**NEW RESTROOM**

KAPAA BASEYARD RENOVATIONS  
Project No. HWY-K-01-94M

Scale: As Shown Date: Sept., 1993

SHEET No. 5 OF 6 SHEETS