



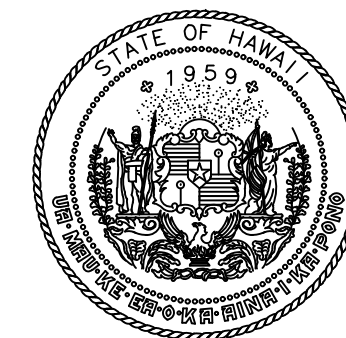

Airports Division
DEPARTMENT OF TRANSPORTATION
STATE OF HAWAII

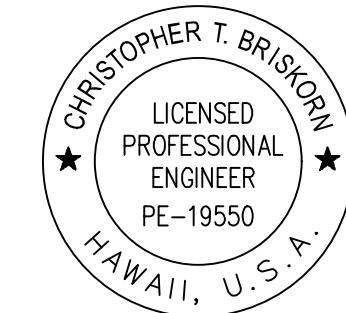

CHRIS BRISKORN, PE
ELECTRICAL ENGINEER
4/30/24
Expiration Date

DSGN.	DRWN.	CHKD.	APPD.
HF	HT	JB	DY

KEY PLAN / NOTES:

NO.	DATE	REVISIONS
-----	------	-----------

CONSTRUCTION DOCUMENTS
JULY 2022
DATE

PROJECT TITLE :

RELOCATE
RUNWAY 3-21

AT
LIHUE AIRPORT
LIHUE, KAUAI, HAWAII

PROJECT NO.:

AK1031-14


SHEET TITLE:

ONE-LINE DIAGRAM
FOR TAXIWAY LIGHTS



DATE :
07/2022
SHEET :
370 OF 376 SHEETS

DWG. NO.


E4.10

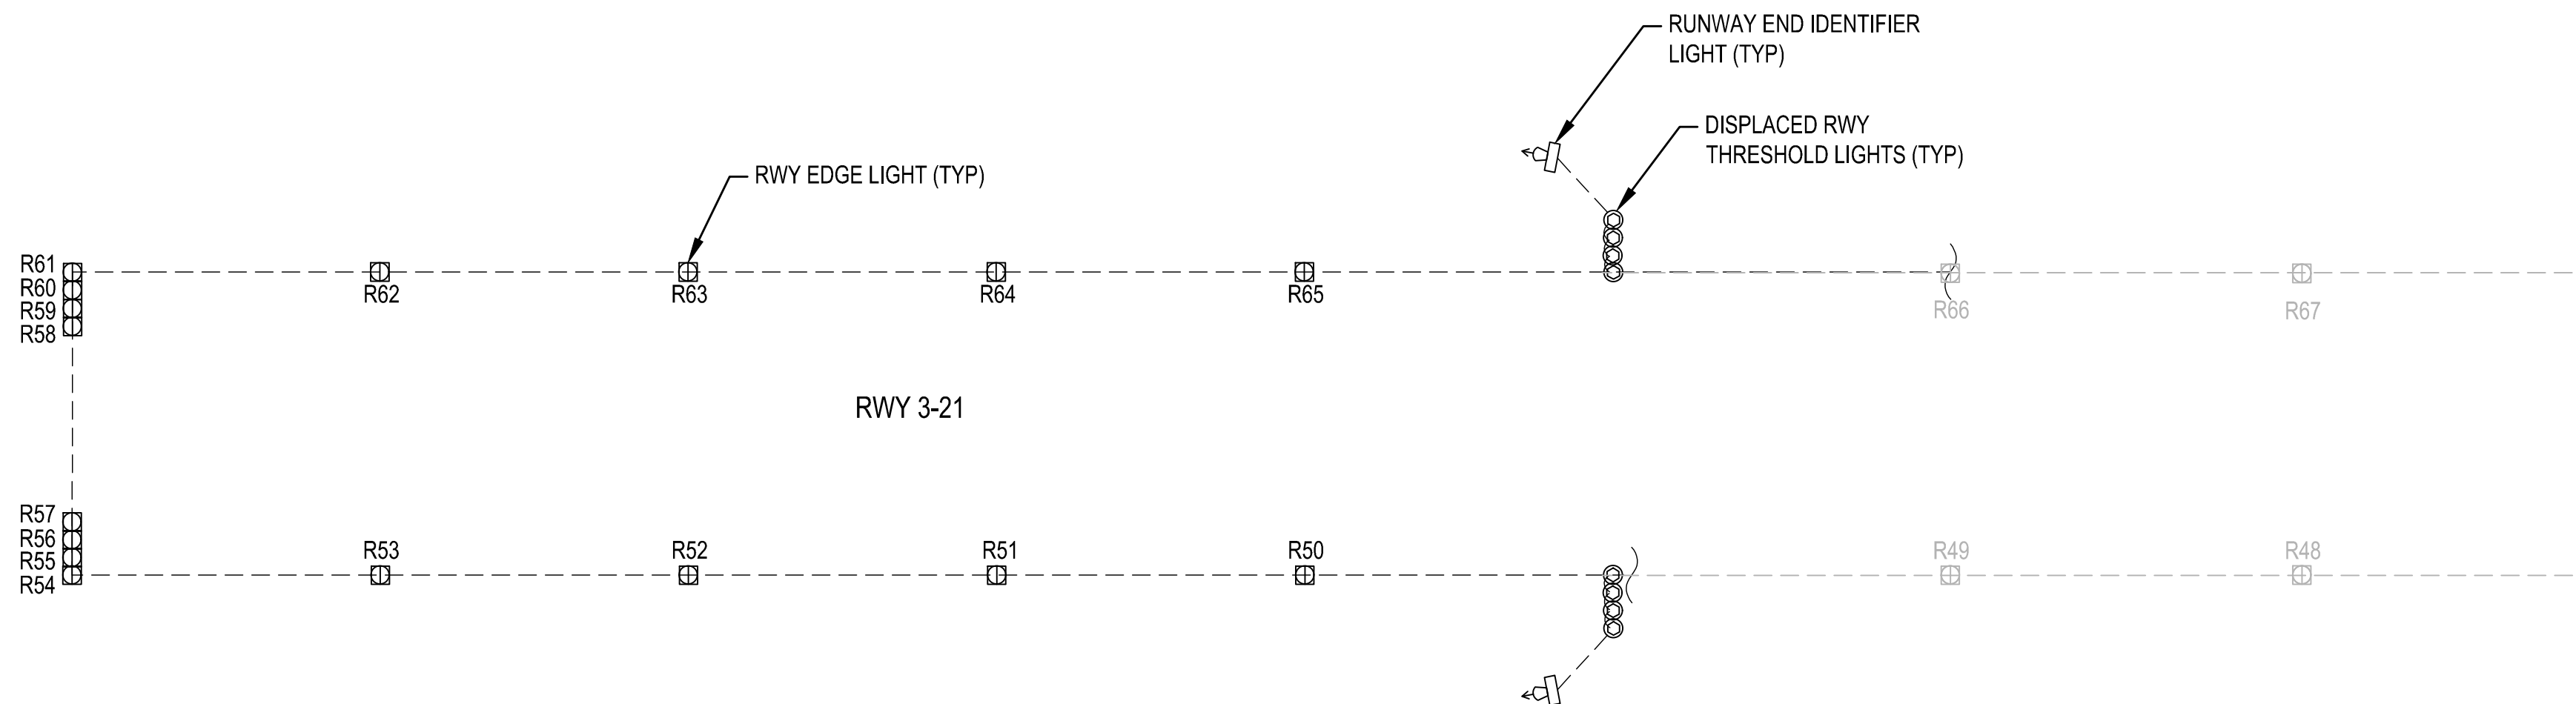

PARTIAL CIRCUIT DIAGRAM - RUNWAY R-2
SCALE: N.T.S.

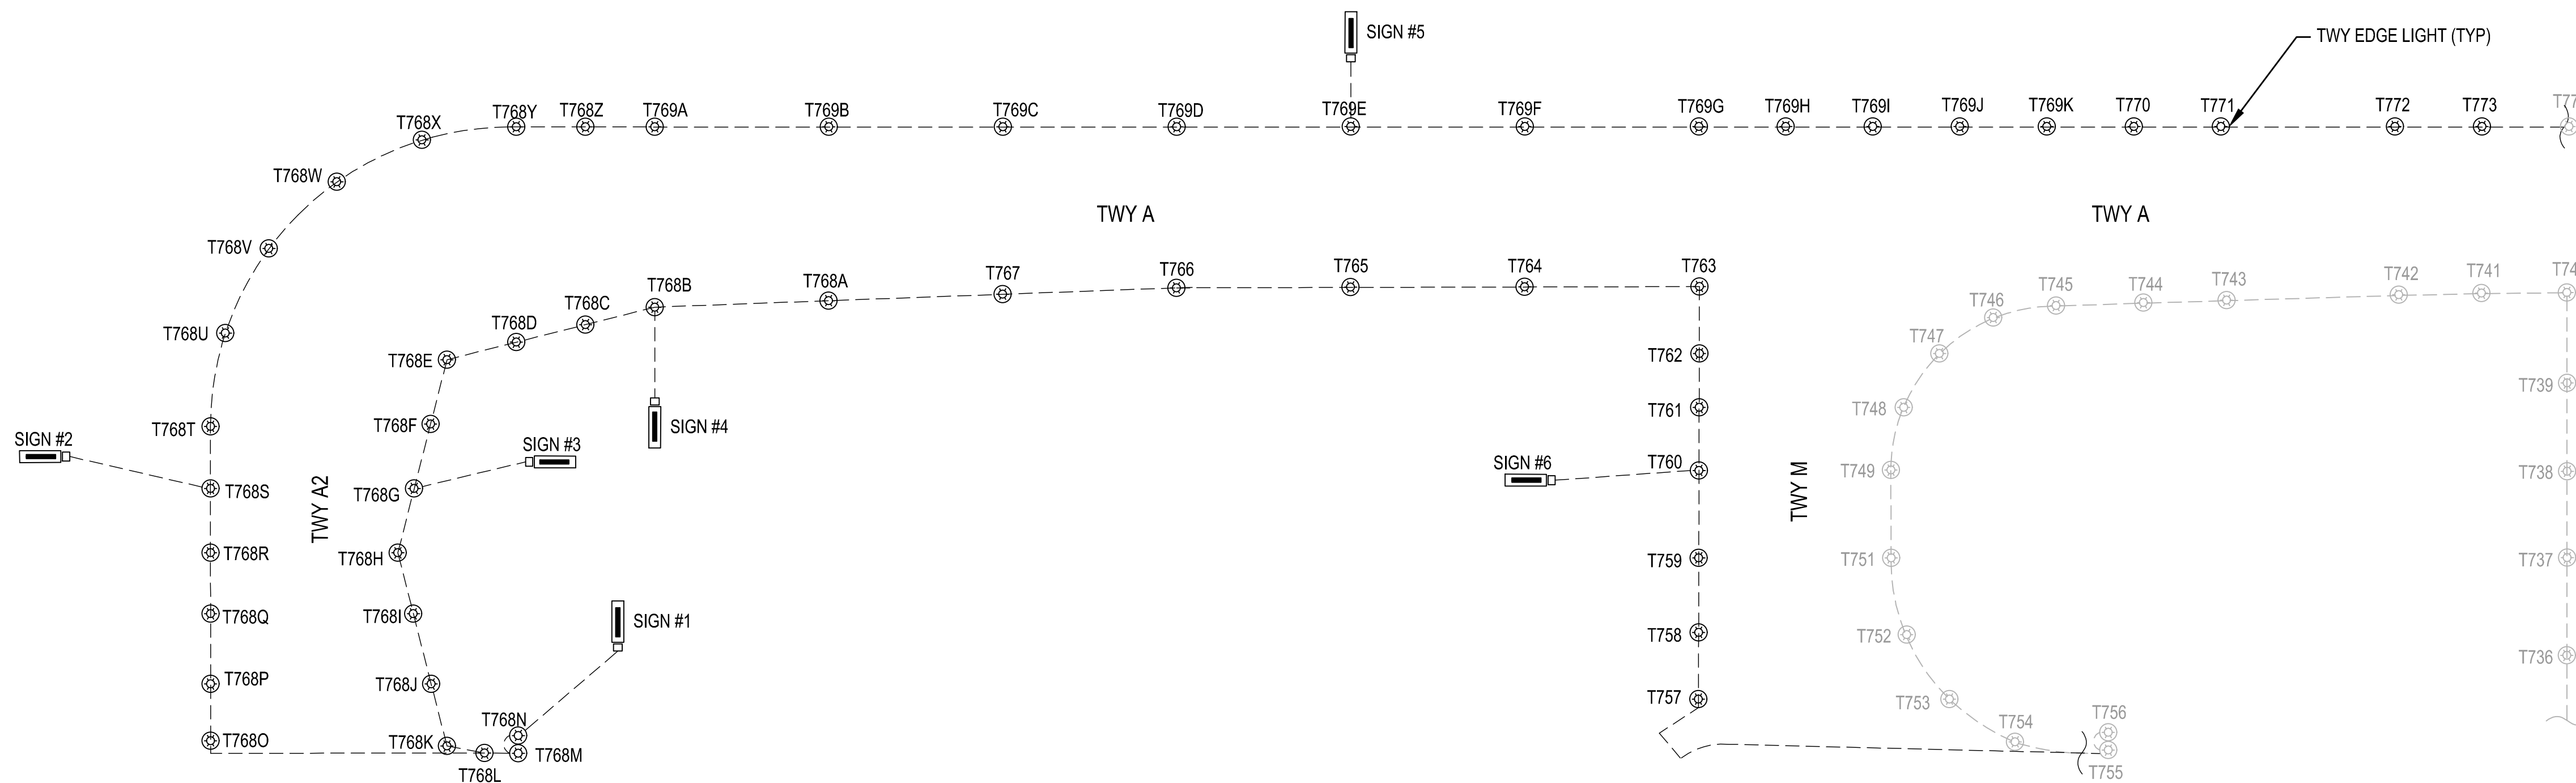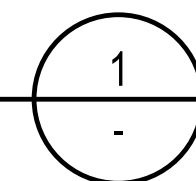

PARTIAL CIRCUIT DIAGRAM - TAXIWAY T-3
SCALE: N.T.S.

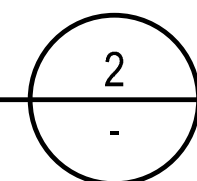

C:\USER\GALLARDO\BOX\LIHUE\RSA\900-CAD-GIS\900-CAD\20-SHEETS\E4.10.DWG