


EXISTING TRANSFORMER VAULT / ELECTRICAL & GENERATOR BUILDING

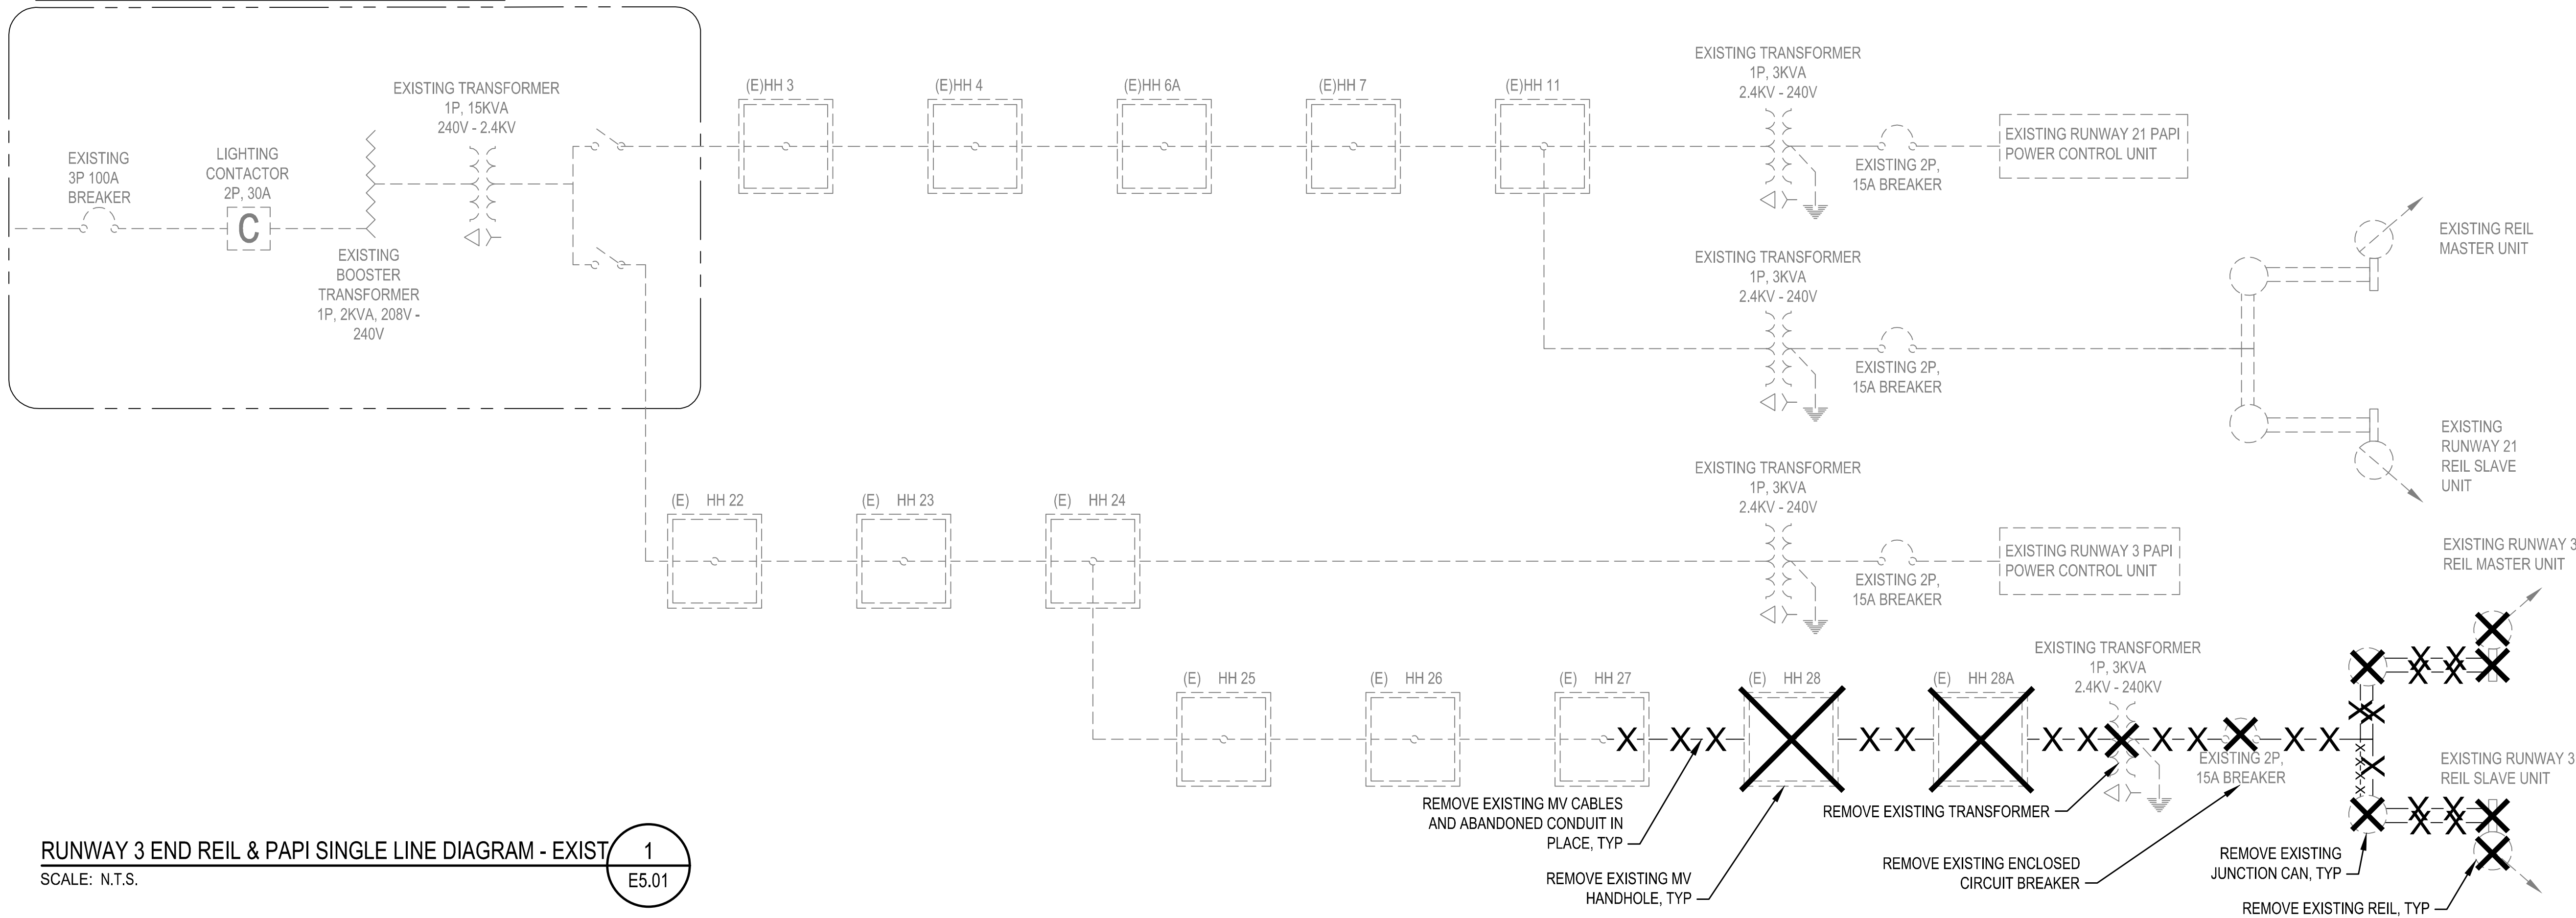


RUNWAY 3 END REIL & PAPI SINGLE LINE DIAGRAM - EXIST

SCALE: N.T.S.

1

E5.01

EXISTING TRANSFORMER VAULT / ELECTRICAL & GENERATOR BUILDING

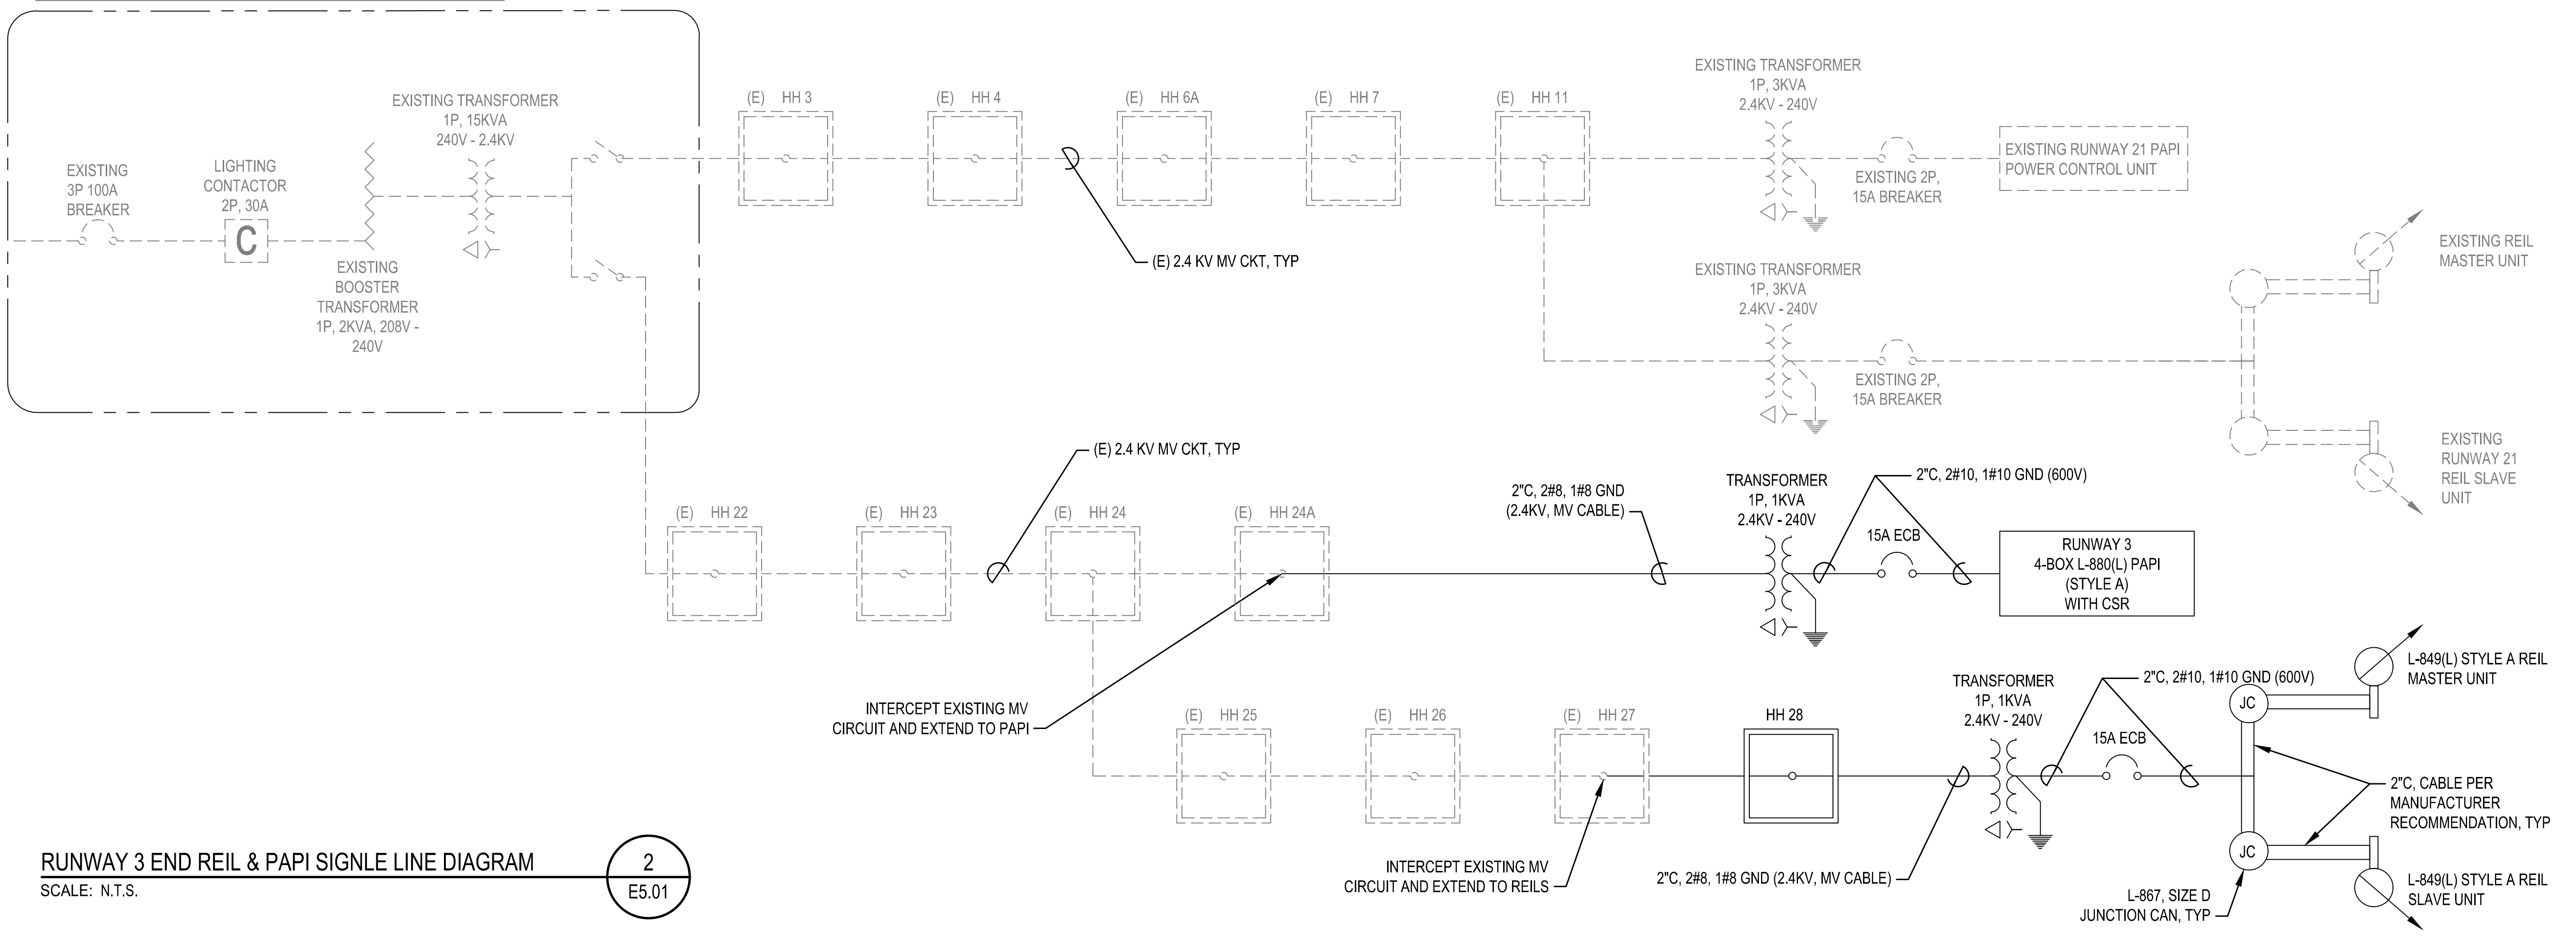


RUNWAY 3 END REIL & PAPI SIGNLE LINE DIAGRAM


SCALE: N.T.S.

2

E5.01

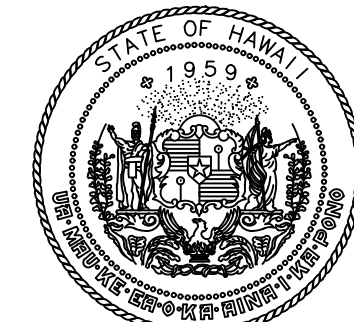

Airports Division
DEPARTMENT OF TRANSPORTATION
STATE OF HAWAII

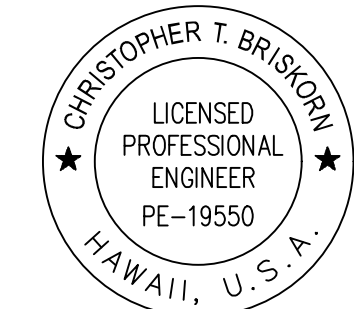

CHRIS BRISKORN, PE
ELECTRICAL ENGINEER

4/30/24
Expiration Date

DSGN.	DRWN.	CHKD.	APPD.
HF	HT	JB	DY

KEY PLAN / NOTES:

NO.	DATE	REVISIONS
-----	------	-----------

CONSTRUCTION DOCUMENTS

JULY 2022
DATE

PROJECT TITLE :

RELOCATE
RUNWAY 3-21

AT
LIHUE AIRPORT
LIHUE, KAUAI, HAWAII

PROJECT NO.:

AK1031-14

SHEET TITLE:

RUNWAY 3-21 REIL & PAPI SINGLE LINE DIAGRAM

DATE :	DWG. NO.
07/2022	E5.01
SHEET :	
373 OF 376 SHEETS	