



INDEX TO DRAWINGS			
SHEET NO.	TITLE	SHEET NO.	TITLE
T-1	TITLE SHEET, LOCATION AND VICINITY MAPS	M-1	GENERAL NOTES AND DETAILED DRAWING
T-2	INDEX TO DRAWINGS AND GENERAL PLAN	M-2	PARTIAL PLUMBING DEMOLITION PLAN
S-1	STRUCTURAL NOTES	M-3	PARTIAL PLUMBING DEMOLITION PLAN
S-2	PARTIAL PIER PLAN	M-4	PARTIAL NEW PLUMBING PLAN
S-3	PARTIAL PIER PLAN	M-5	PARTIAL NEW PLUMBING PLAN
S-4	TYPICAL PIER SECTIONS	M-6	WATER PIPING DIAGRAM
S-5	FENDER REPAIR PLAN		
S-6	FENDER REPAIR ELEVATIONS		
S-7	FENDER REPAIR DETAILS		
S-8	CORBEL AND FENDER REPAIR DETAILS		
S-9	SPLICE DETAIL		
S-10	STAIR DETAILS		
S-11	MISCELLANEOUS DETAILS		

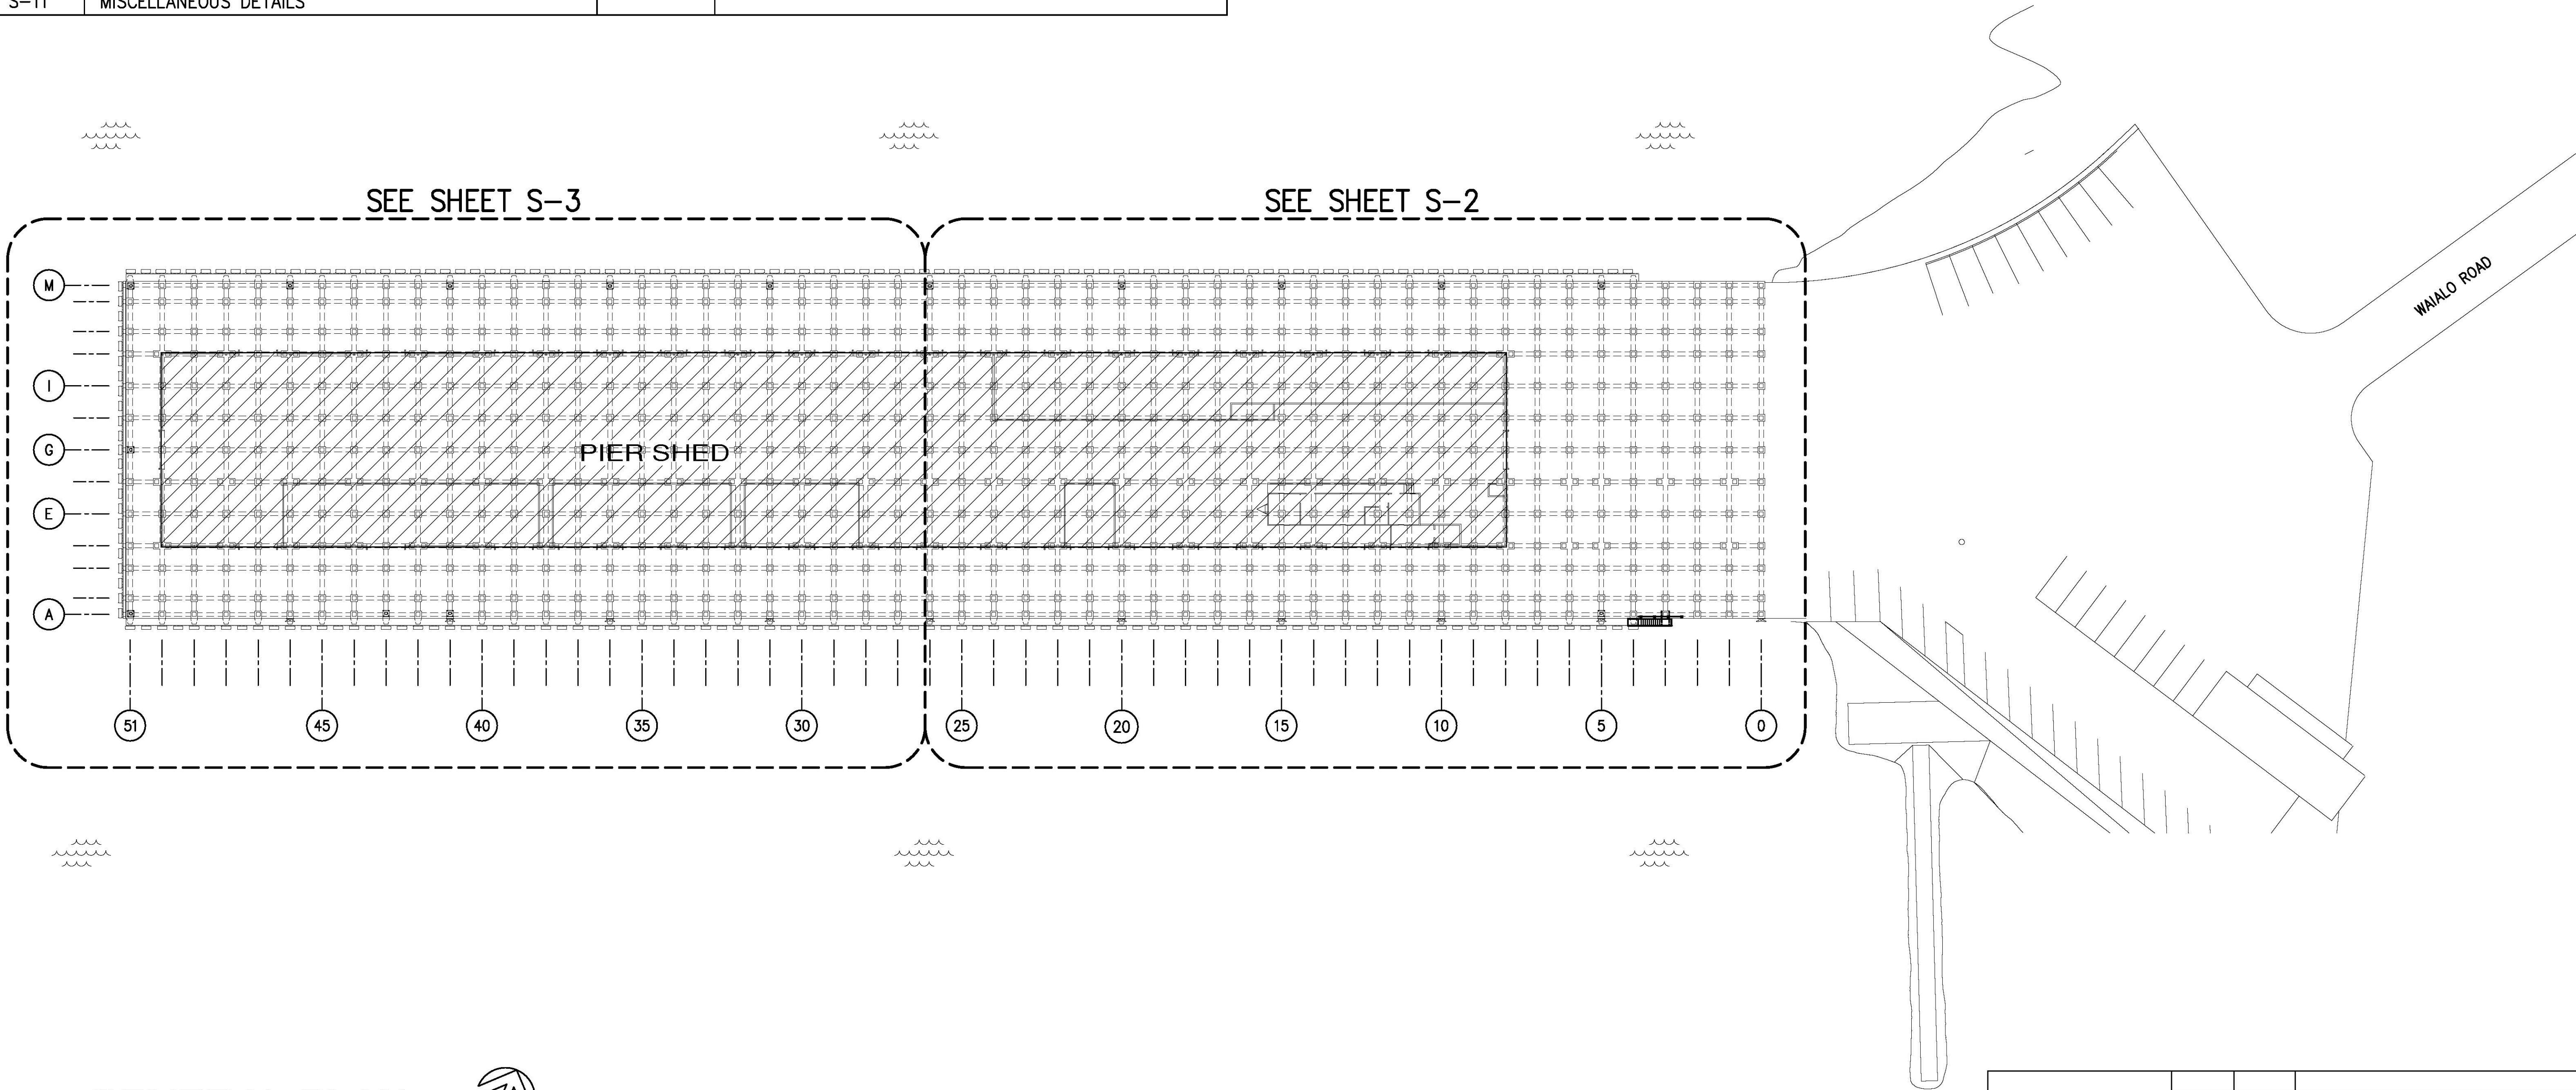

GENERAL PLAN
SCALE: 1" = 30'-0"

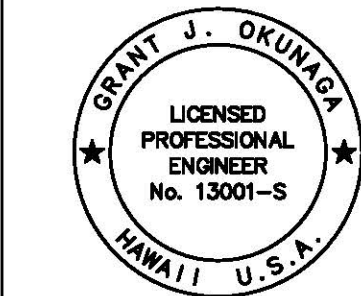

THIS WORK WAS PREPARED BY ME
OR UNDER MY SUPERVISION
EXP. 4-30-24
Grant J. Okunaka
MKE ASSOCIATES LLC

REVISION	DATE	DESCRIPTION	BY	APPROVED
STATE OF HAWAII DEPARTMENT OF TRANSPORTATION HARBORS DIVISION				
JOB TITLE FENDER AND WATERLINE REPAIRS AT PORT ALLEN, KAUAI, HAWAII				
SHEET TITLE INDEX TO DRAWINGS AND GENERAL PLAN				
DESIGNED BY: GO	JOB NUMBER S70145			SHEET T-2
DRAWN BY: DL				2 of 19 SHEETS
CHECKED BY: GM				
DATE: 04/2023 SCALE: AS SHOWN				