


1 PARTIAL NEW PLUMBING PLAN
M-4 SCALE: 1" = 10'

PLUMBING GENERAL NOTES:

CONTRACTOR SHALL FIELD VERIFY AND COORDINATE FINAL LOCATION OF NEW HOSE BIBBS WITH USERS AND STATE.

PLUMBING NEW WORK NOTES:


(P1) PROVIDE AND INSTALL NEW HOSE BIBB, ASSOCIATED PIPING, AND ACCESSORIES FROM POC AS INDICATED IN M-5. CONTRACTOR TO FIELD VERIFY. PATCH/REPAIR TO MATCH EXISTING.

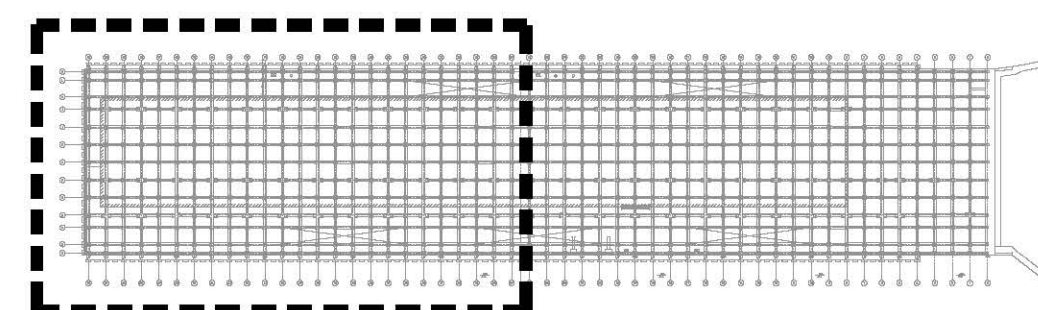

2 KEYPLAN
M-4 SCALE: NOT TO SCALE




0 10' 20'
SCALE: 1" = 10'-0"

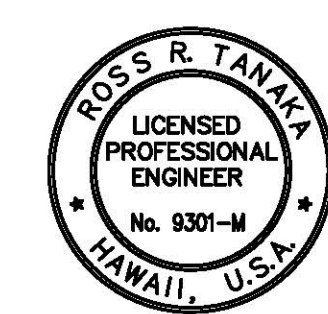

THIS WORK WAS PREPARED BY ME
OR UNDER MY SUPERVISION
EXP 4-30-24
MECHANICAL ENTERPRISE, INC.

REVISION	DATE	DESCRIPTION	BY	APPROVED
STATE OF HAWAII DEPARTMENT OF TRANSPORTATION HARBORS DIVISION				
JOB TITLE FENDER AND WATERLINE REPAIRS AT PORT ALLEN, KAUAI, HAWAII				
SHEET TITLE PARTIAL NEW PLUMBING PLAN				
DESIGNED BY: MEI		JOB NUMBER S70145	SHEET M-4	
DRAWN BY: MEI			17 of 19 SHTS.	
CHECKED BY: RRT				
DATE: 04/2023				
SCALE: AS SHOWN				

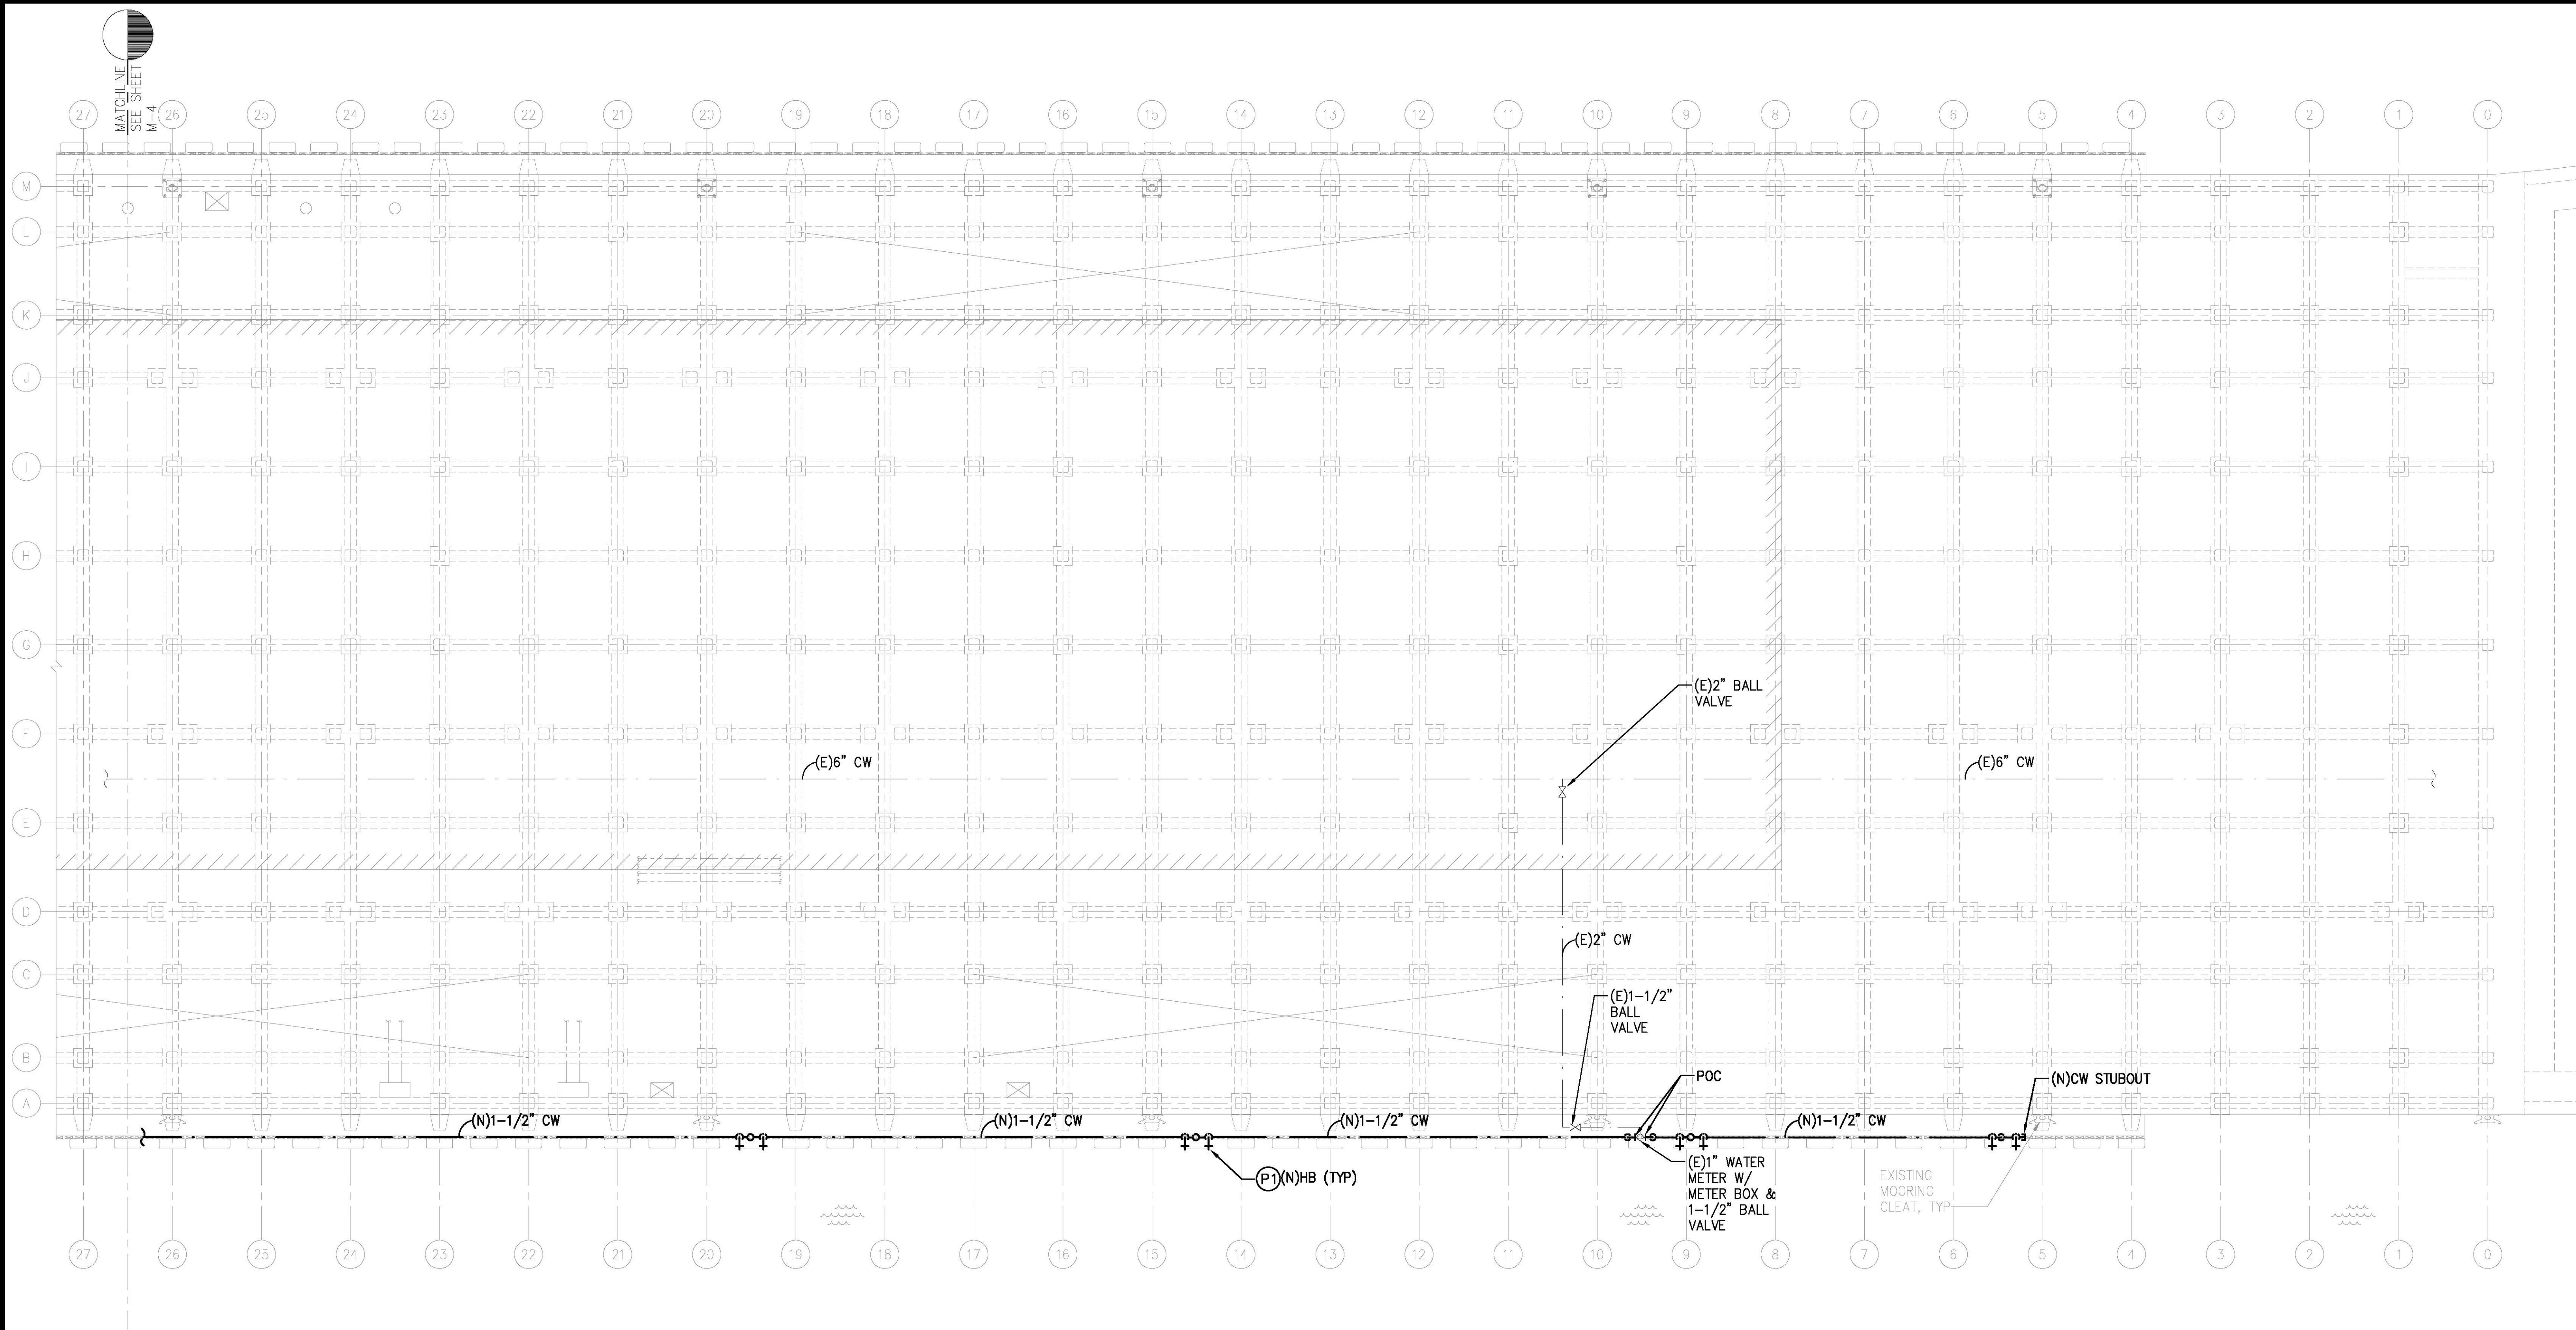


1 PARTIAL NEW PLUMBING PLAN
M-5 SCALE: 1" = 10'

PLUMBING GENERAL NOTES:

CONTRACTOR SHALL FIELD VERIFY AND COORDINATE FINAL LOCATION OF NEW HOSE BIBBS WITH USERS AND STATE.

PLUMBING NEW WORK NOTES:


- (P1) PROVIDE AND INSTALL NEW HOSE BIBB, ASSOCIATED PIPING, AND ACCESSORIES FROM POC AS INDICATED. CONTRACTOR TO FIELD VERIFY. PATCH/REPAIR TO MATCH EXISTING.

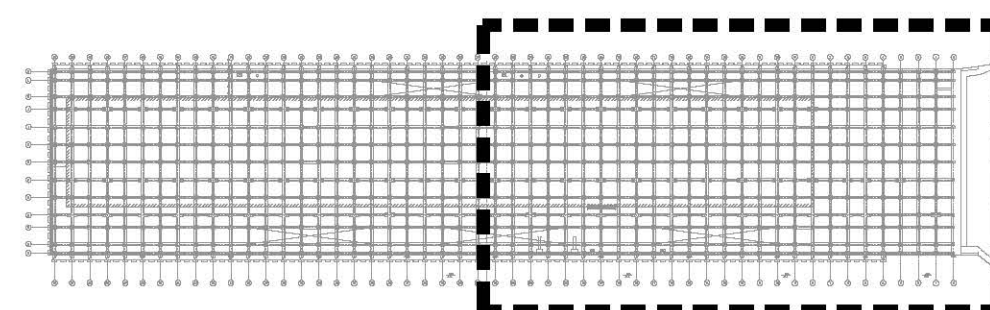

2 KEYPLAN
M-5 SCALE: NOT TO SCALE



0 10' 20'
SCALE: 1" = 10'-0"

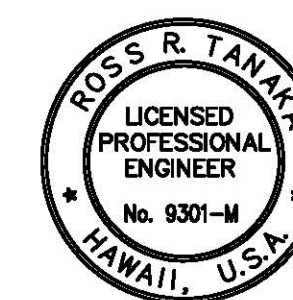

THIS WORK WAS PREPARED BY ME
OR UNDER MY SUPERVISION
EXP 4-30-24
MECHANICAL ENTERPRISE, INC.

REVISION	DATE	DESCRIPTION	BY	APPROVED
STATE OF HAWAII DEPARTMENT OF TRANSPORTATION HARBORS DIVISION				
JOB TITLE FENDER AND WATERLINE REPAIRS AT PORT ALLEN, KAUAI, HAWAII				
SHEET TITLE PARTIAL NEW PLUMBING PLAN				
DESIGNED BY: MEI		JOB NUMBER S70145	SHEET M-5	
DRAWN BY: MEI				
CHECKED BY: RRT				
DATE: 04/2023				
SCALE: AS SHOWN			18 of 19 sheets	