


4/25/23-11:50 V:\044\044.097 Nautical Piers 1 and 2\044.097 E-2 - E-301.dwg

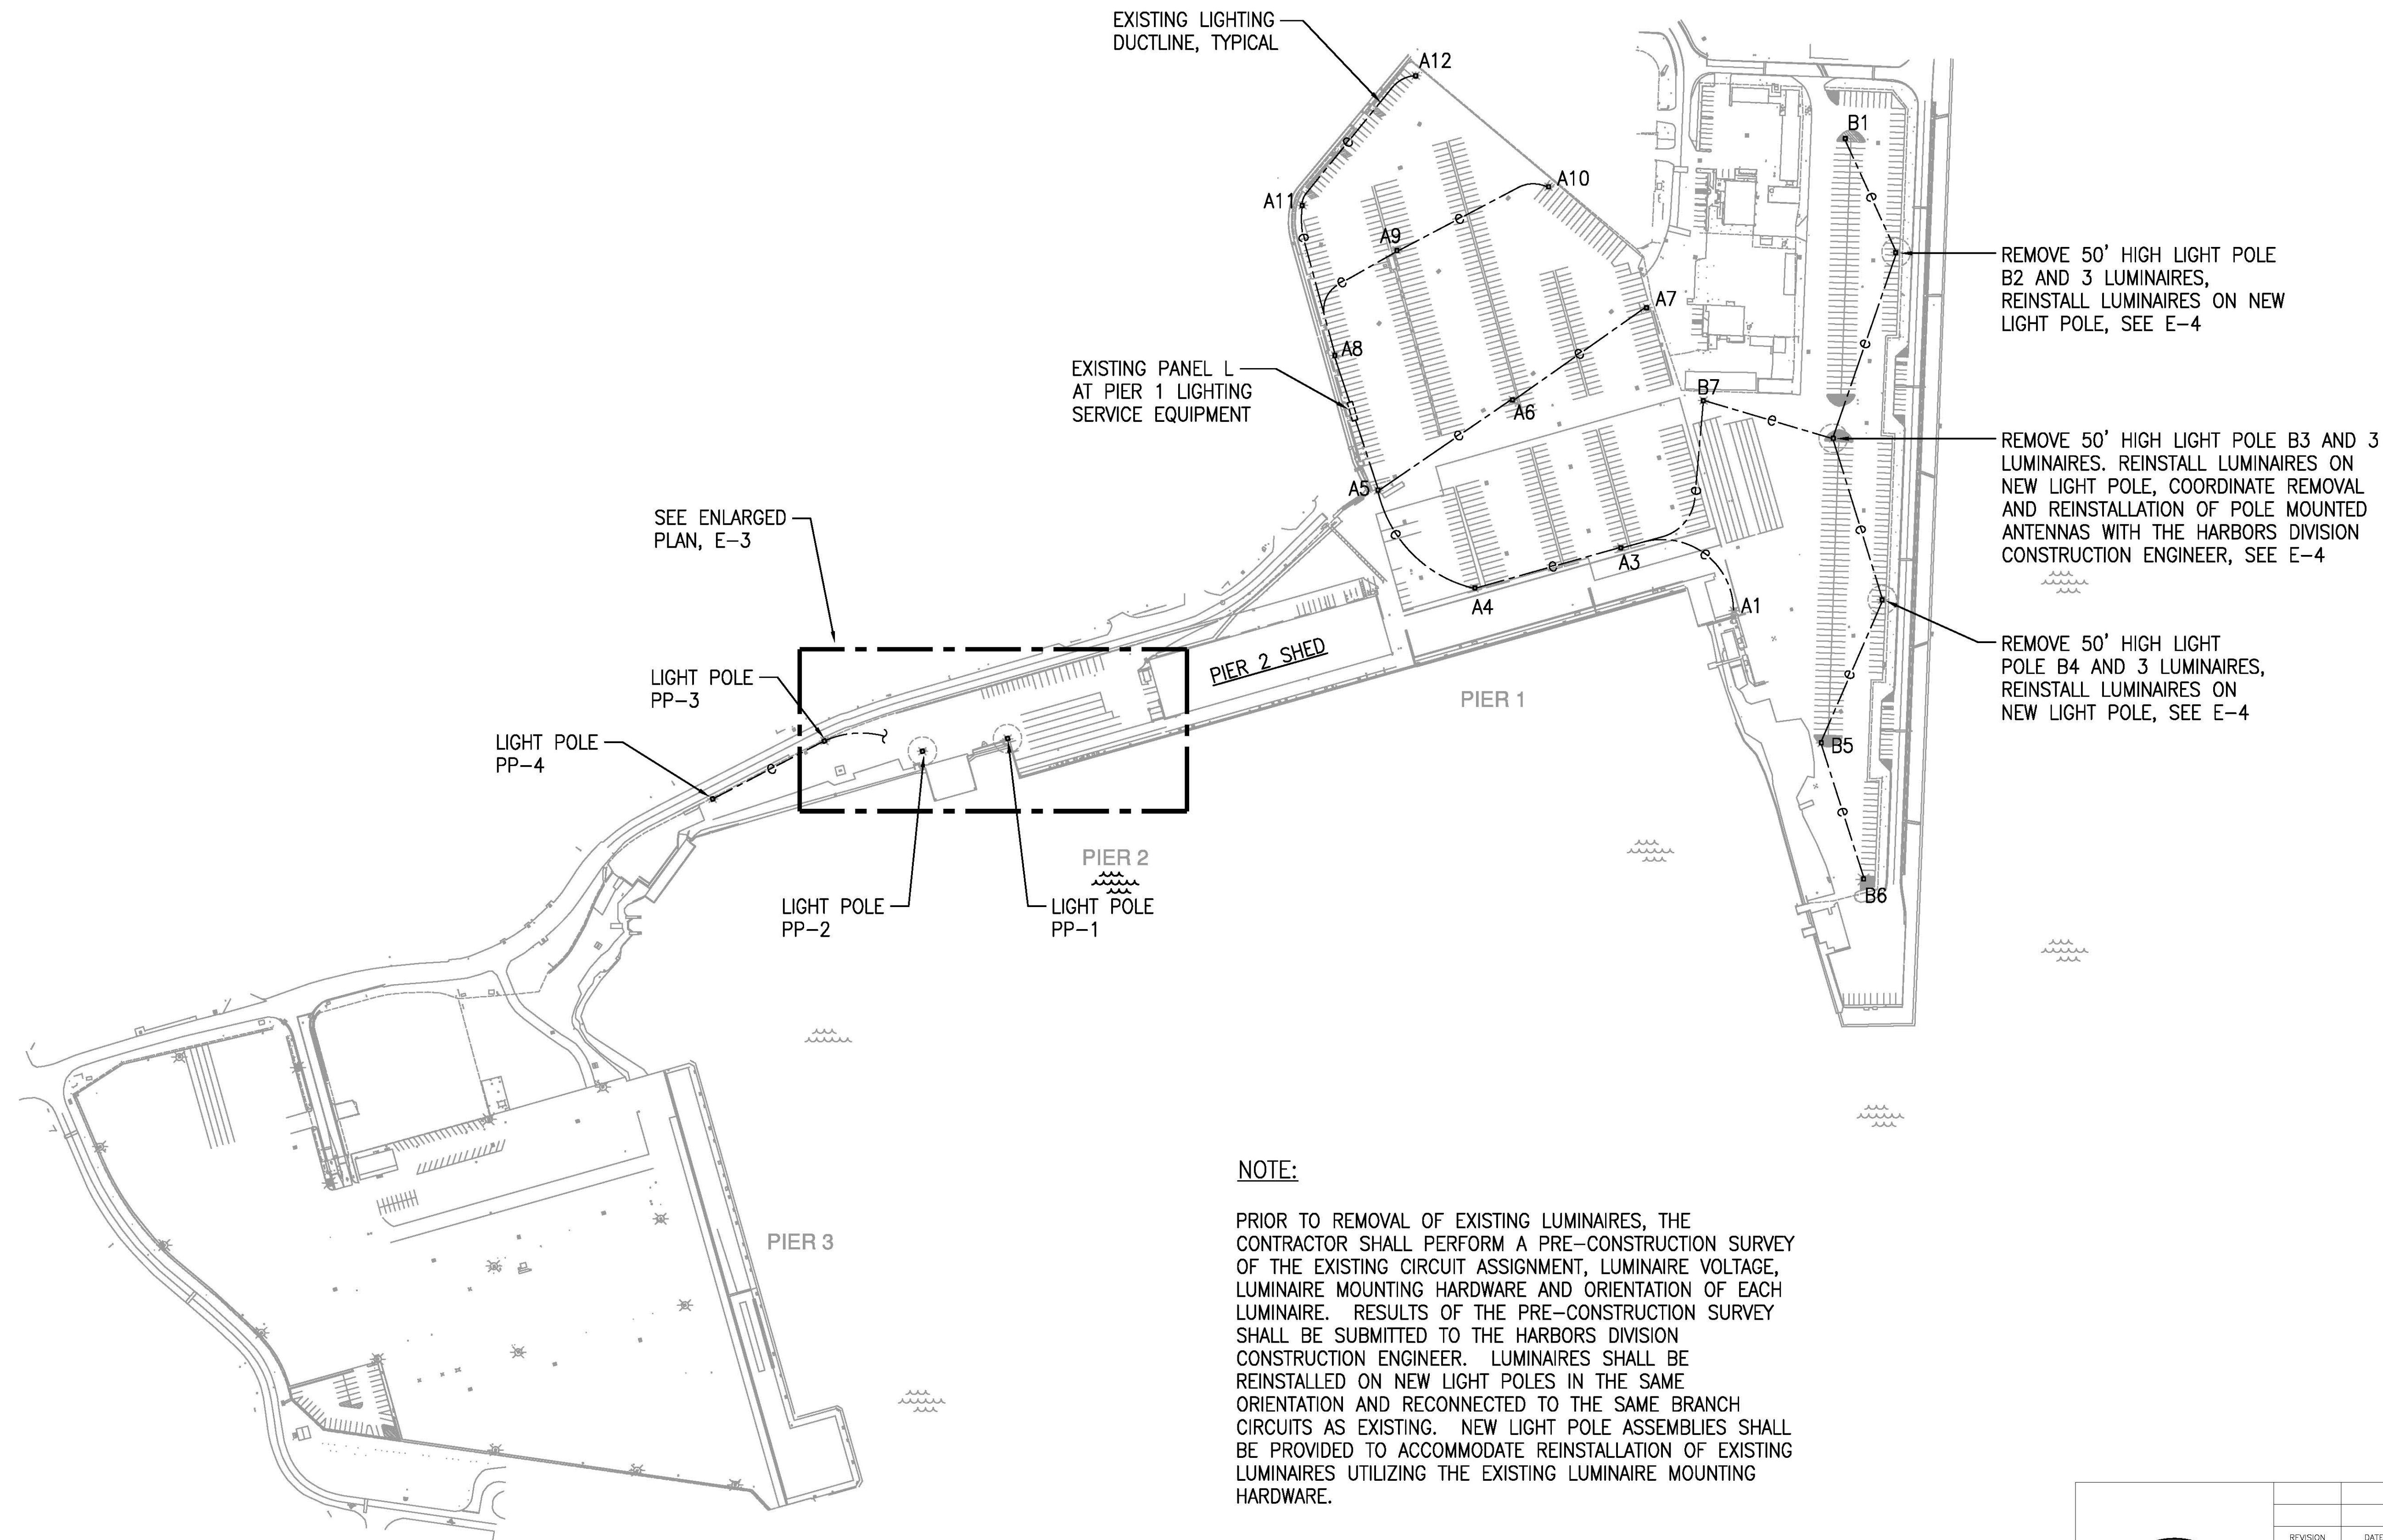



**NOTE:**

PRIOR TO REMOVAL OF EXISTING LUMINAIRES, THE CONTRACTOR SHALL PERFORM A PRE-CONSTRUCTION SURVEY OF THE EXISTING CIRCUIT ASSIGNMENT, LUMINAIRE VOLTAGE, LUMINAIRE MOUNTING HARDWARE AND ORIENTATION OF EACH LUMINAIRE. RESULTS OF THE PRE-CONSTRUCTION SURVEY SHALL BE SUBMITTED TO THE HARBORS DIVISION CONSTRUCTION ENGINEER. LUMINAIRES SHALL BE REINSTALLED ON NEW LIGHT POLES IN THE SAME ORIENTATION AND RECONNECTED TO THE SAME BRANCH CIRCUITS AS EXISTING. NEW LIGHT POLE ASSEMBLIES SHALL BE PROVIDED TO ACCOMMODATE REINSTALLATION OF EXISTING LUMINAIRES UTILIZING THE EXISTING LUMINAIRE MOUNTING HARDWARE.



1  
E-2 ELECTRICAL SITE PLAN  
SCALE: 1" = 150'-0"

**GRAPHIC SCALE**

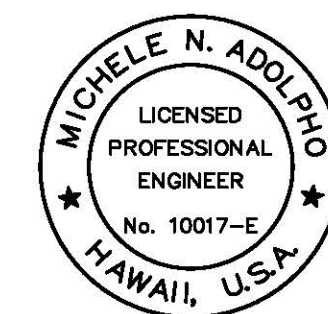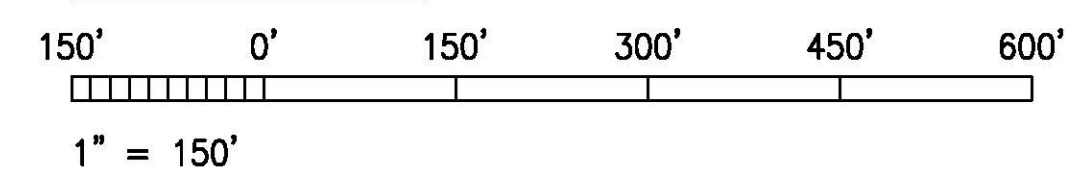

THIS WORK WAS PREPARED BY ME  
OR UNDER MY SUPERVISION  
EXP 4-30-24  
*Michele N. Adolp*  
ECS, INC.

REVISION	DATE	DESCRIPTION	BY	APPROVED
STATE OF HAWAII				
DEPARTMENT OF TRANSPORTATION				
HARBORS DIVISION				
JOB TITLE				
REPAIR LIGHT POLES AND PEDESTALS				
AT NAWILIWILI HARBOR, KAUAI, HAWAII				
SHEET TITLE				
ELECTRICAL SITE PLAN				
DESIGNED BY: MA	JOB NUMBER			SHEET
DRAWN BY: CAD				E-2
CHECKED BY: MA				
DATE: 04/2023				
SCALE: AS SHOWN	S70146			