

INDEX TO DRAWINGS	
SHEET NO.	DESCRIPTION
1	TITLE SHEET
2	STANDARD PLANS SUMMARY
3-4	TYPICAL SECTIONS
5	NOTES & LEGEND
6-8	PLAN & PROFILE
9	CRM RETAINING WALLS
10	MISCELLANEOUS DETAILS
11-15	PAVEMENT MARKING, STRIPING & SIGNING PLAN
16	PARKING LOT & HALEKO ROAD PROFILE
17	TRAFFIC SIGNAL PLAN AT KAUMUALII HWY.
18	TRAFFIC SIGNAL PLAN AT HALEKO ROAD
19	LOOP DETECTOR DETAILS
20-23	CROSS SECTIONS
24-29	ELECTRICAL PLANS

STATE OF HAWAII

DEPARTMENT OF TRANSPORTATION

HIGHWAYS DIVISION

HONOLULU, HAWAII

"AS BUILT"

PLANS FOR

NAWILIWILI ROAD REALIGNMENT



HALEHAKA ROAD TO KAUMUALII HIGHWAY

F.A. PROJECT NO. F-058-1(I)

DISTRICT OF LIHUE

ISLAND OF KAUAI

FED. ROAD DIST. NO.	STATE	FED. AID PROJ. NO.	FISCAL YEAR	SHEET NO.	TOTAL SHEETS
HAWAII	HAW.	F-058-1(I)	1990	1	29

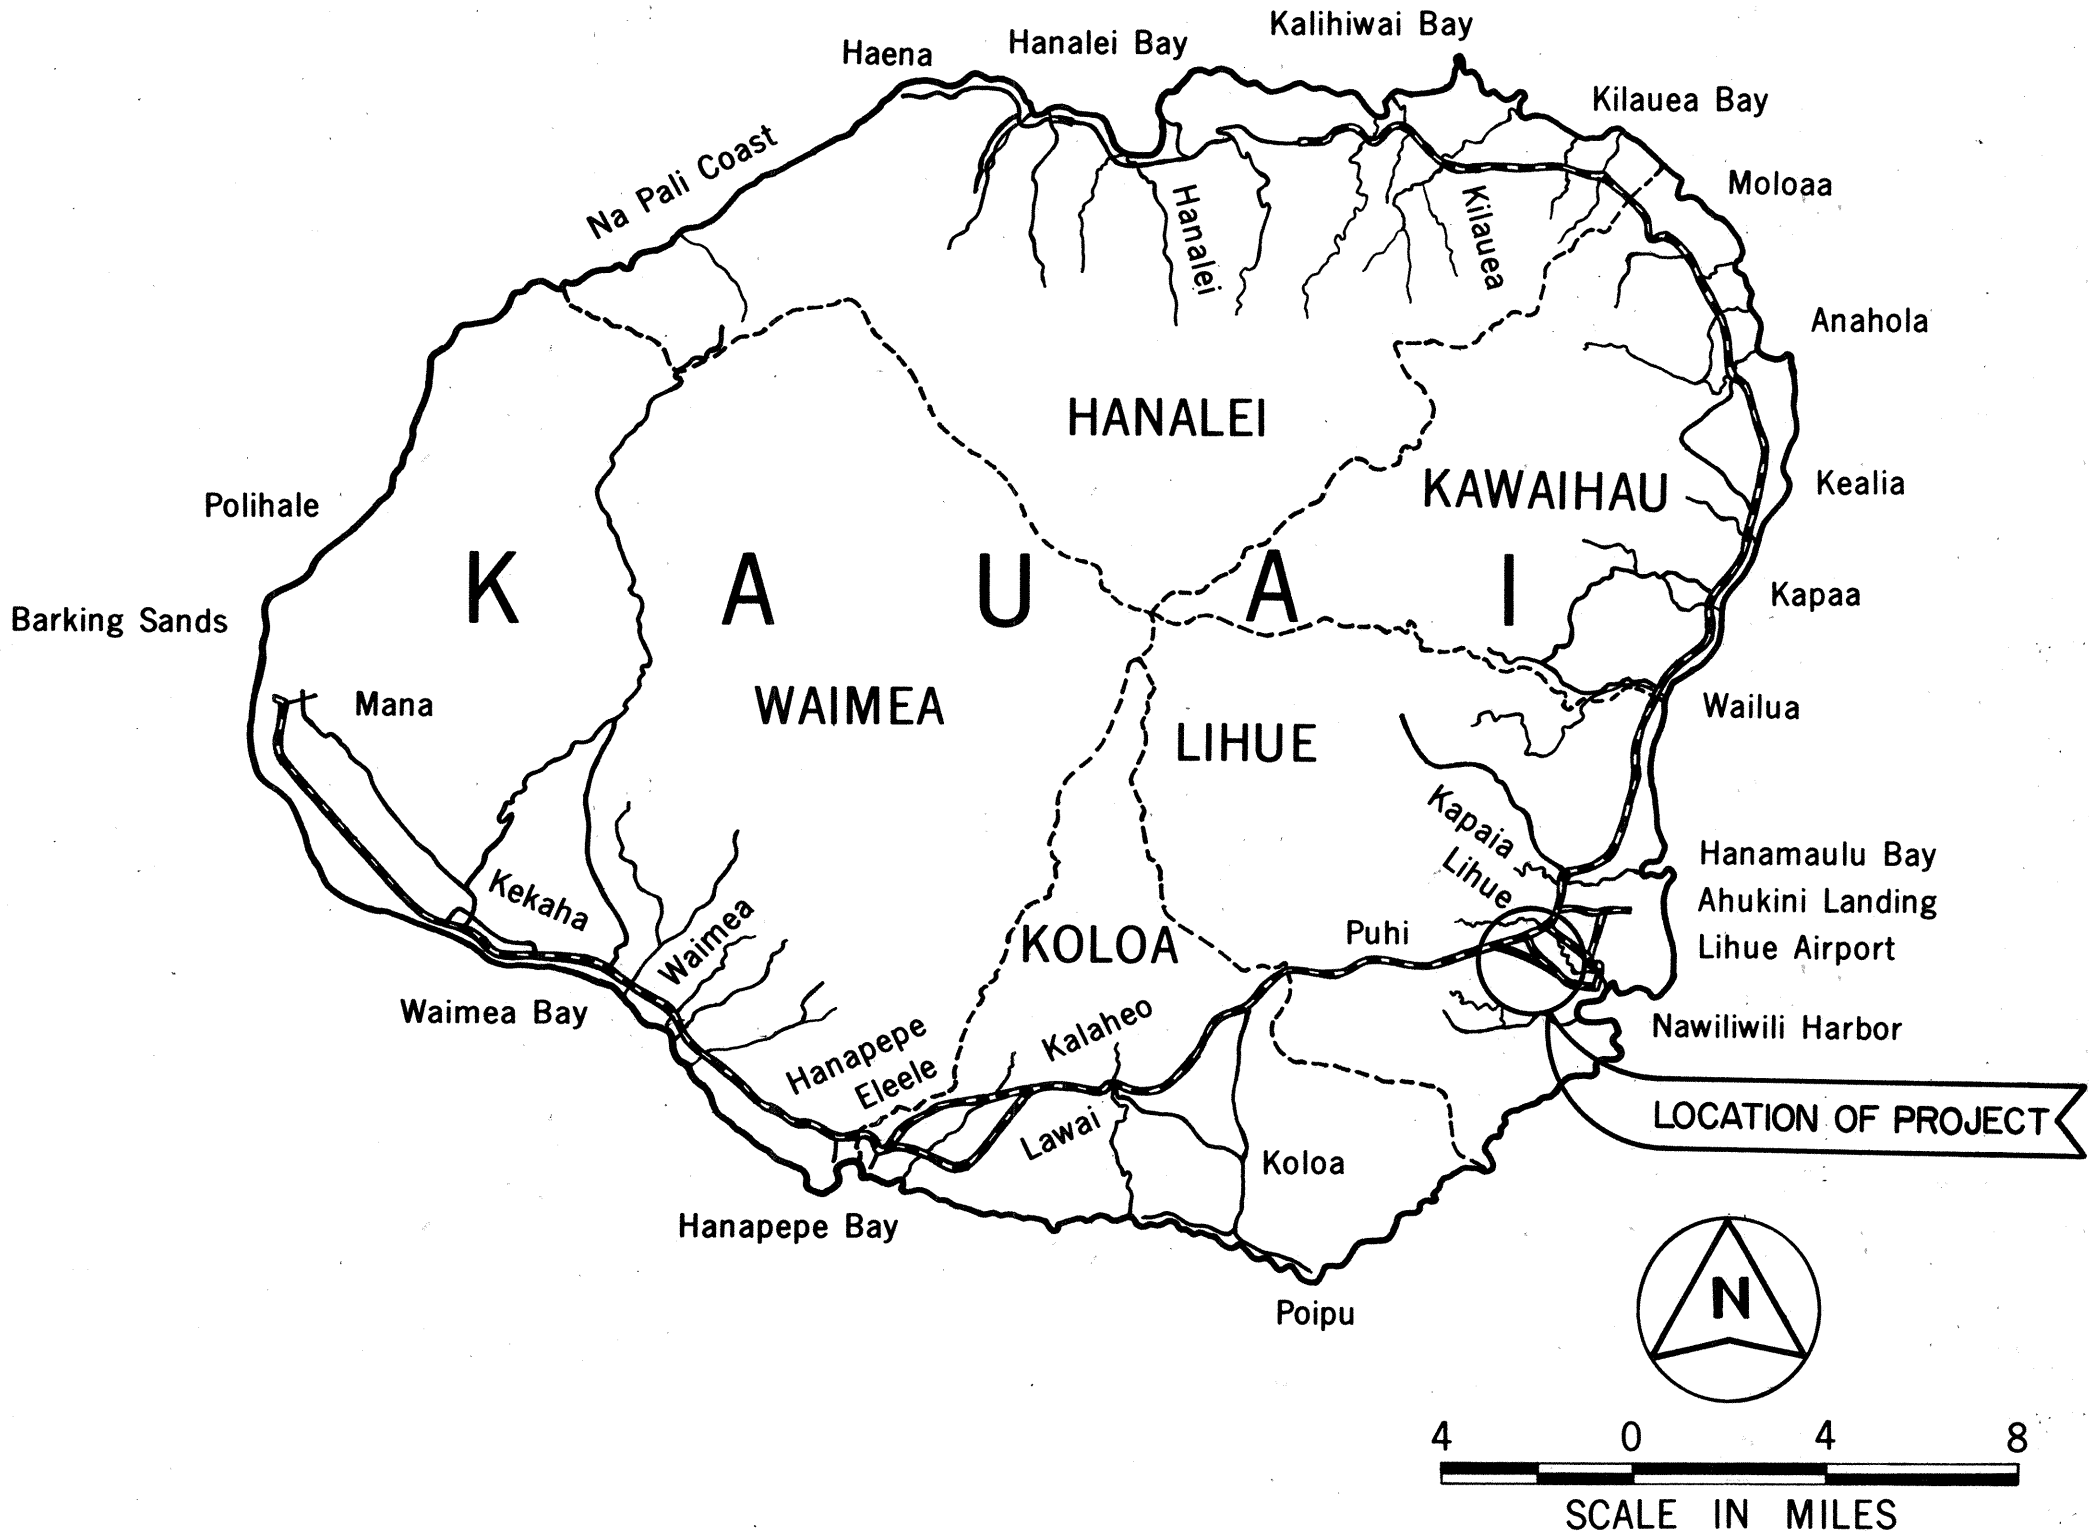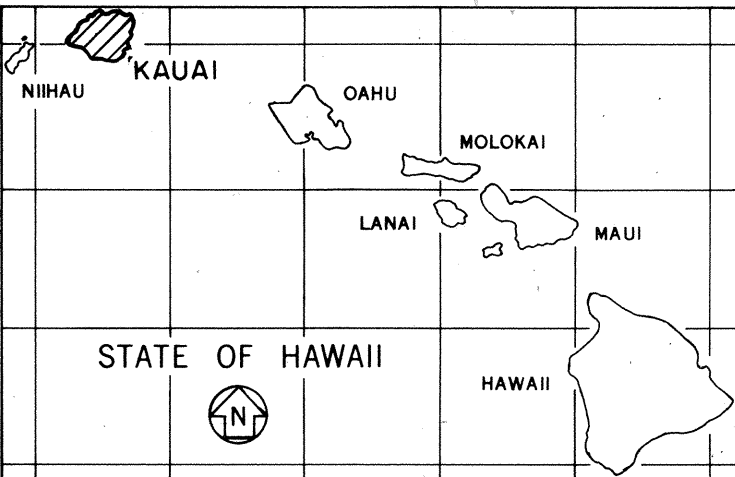

FEDERAL AID PROJECTS PREVIOUSLY CONSTRUCTED OR UNDER CONSTRUCTION

MILE POST 2.08 TO MILE POST 1.58

DESIGN CLASSIFICATION

CURRENT A D T (1989)	5,800
DESIGN A D T (2009)	7,500
D H V	900
D	70/30
T	14.5
V	35 MPH

CHANGES MADE DURING CONSTRUCTION HAVE BEEN INCORPORATED ON THESE PLANS EXCEPT CHANGES IN THE ORIGINAL THEORETICAL QUANTITIES.

RESIDENT ENGINEER

12-9-94

DATE

DEPARTMENT OF TRANSPORTATION
FEDERAL HIGHWAY ADMINISTRATION

APPROVED:

DIVISION ADMINISTRATOR

11/9/89

DATE

DEPARTMENT OF TRANSPORTATION
STATE OF HAWAII

APPROVED:

DIR. OF TRANSPORTATION

9/12/89

DATE

