


FED. ROAD DIST. NO.	STATE	FED. AID PROJ. NO.	FISCAL YEAR	SHEET NO.	TOTAL SHEETS
HAWAII	HAW.	F-058-1(1)	1990	17	29

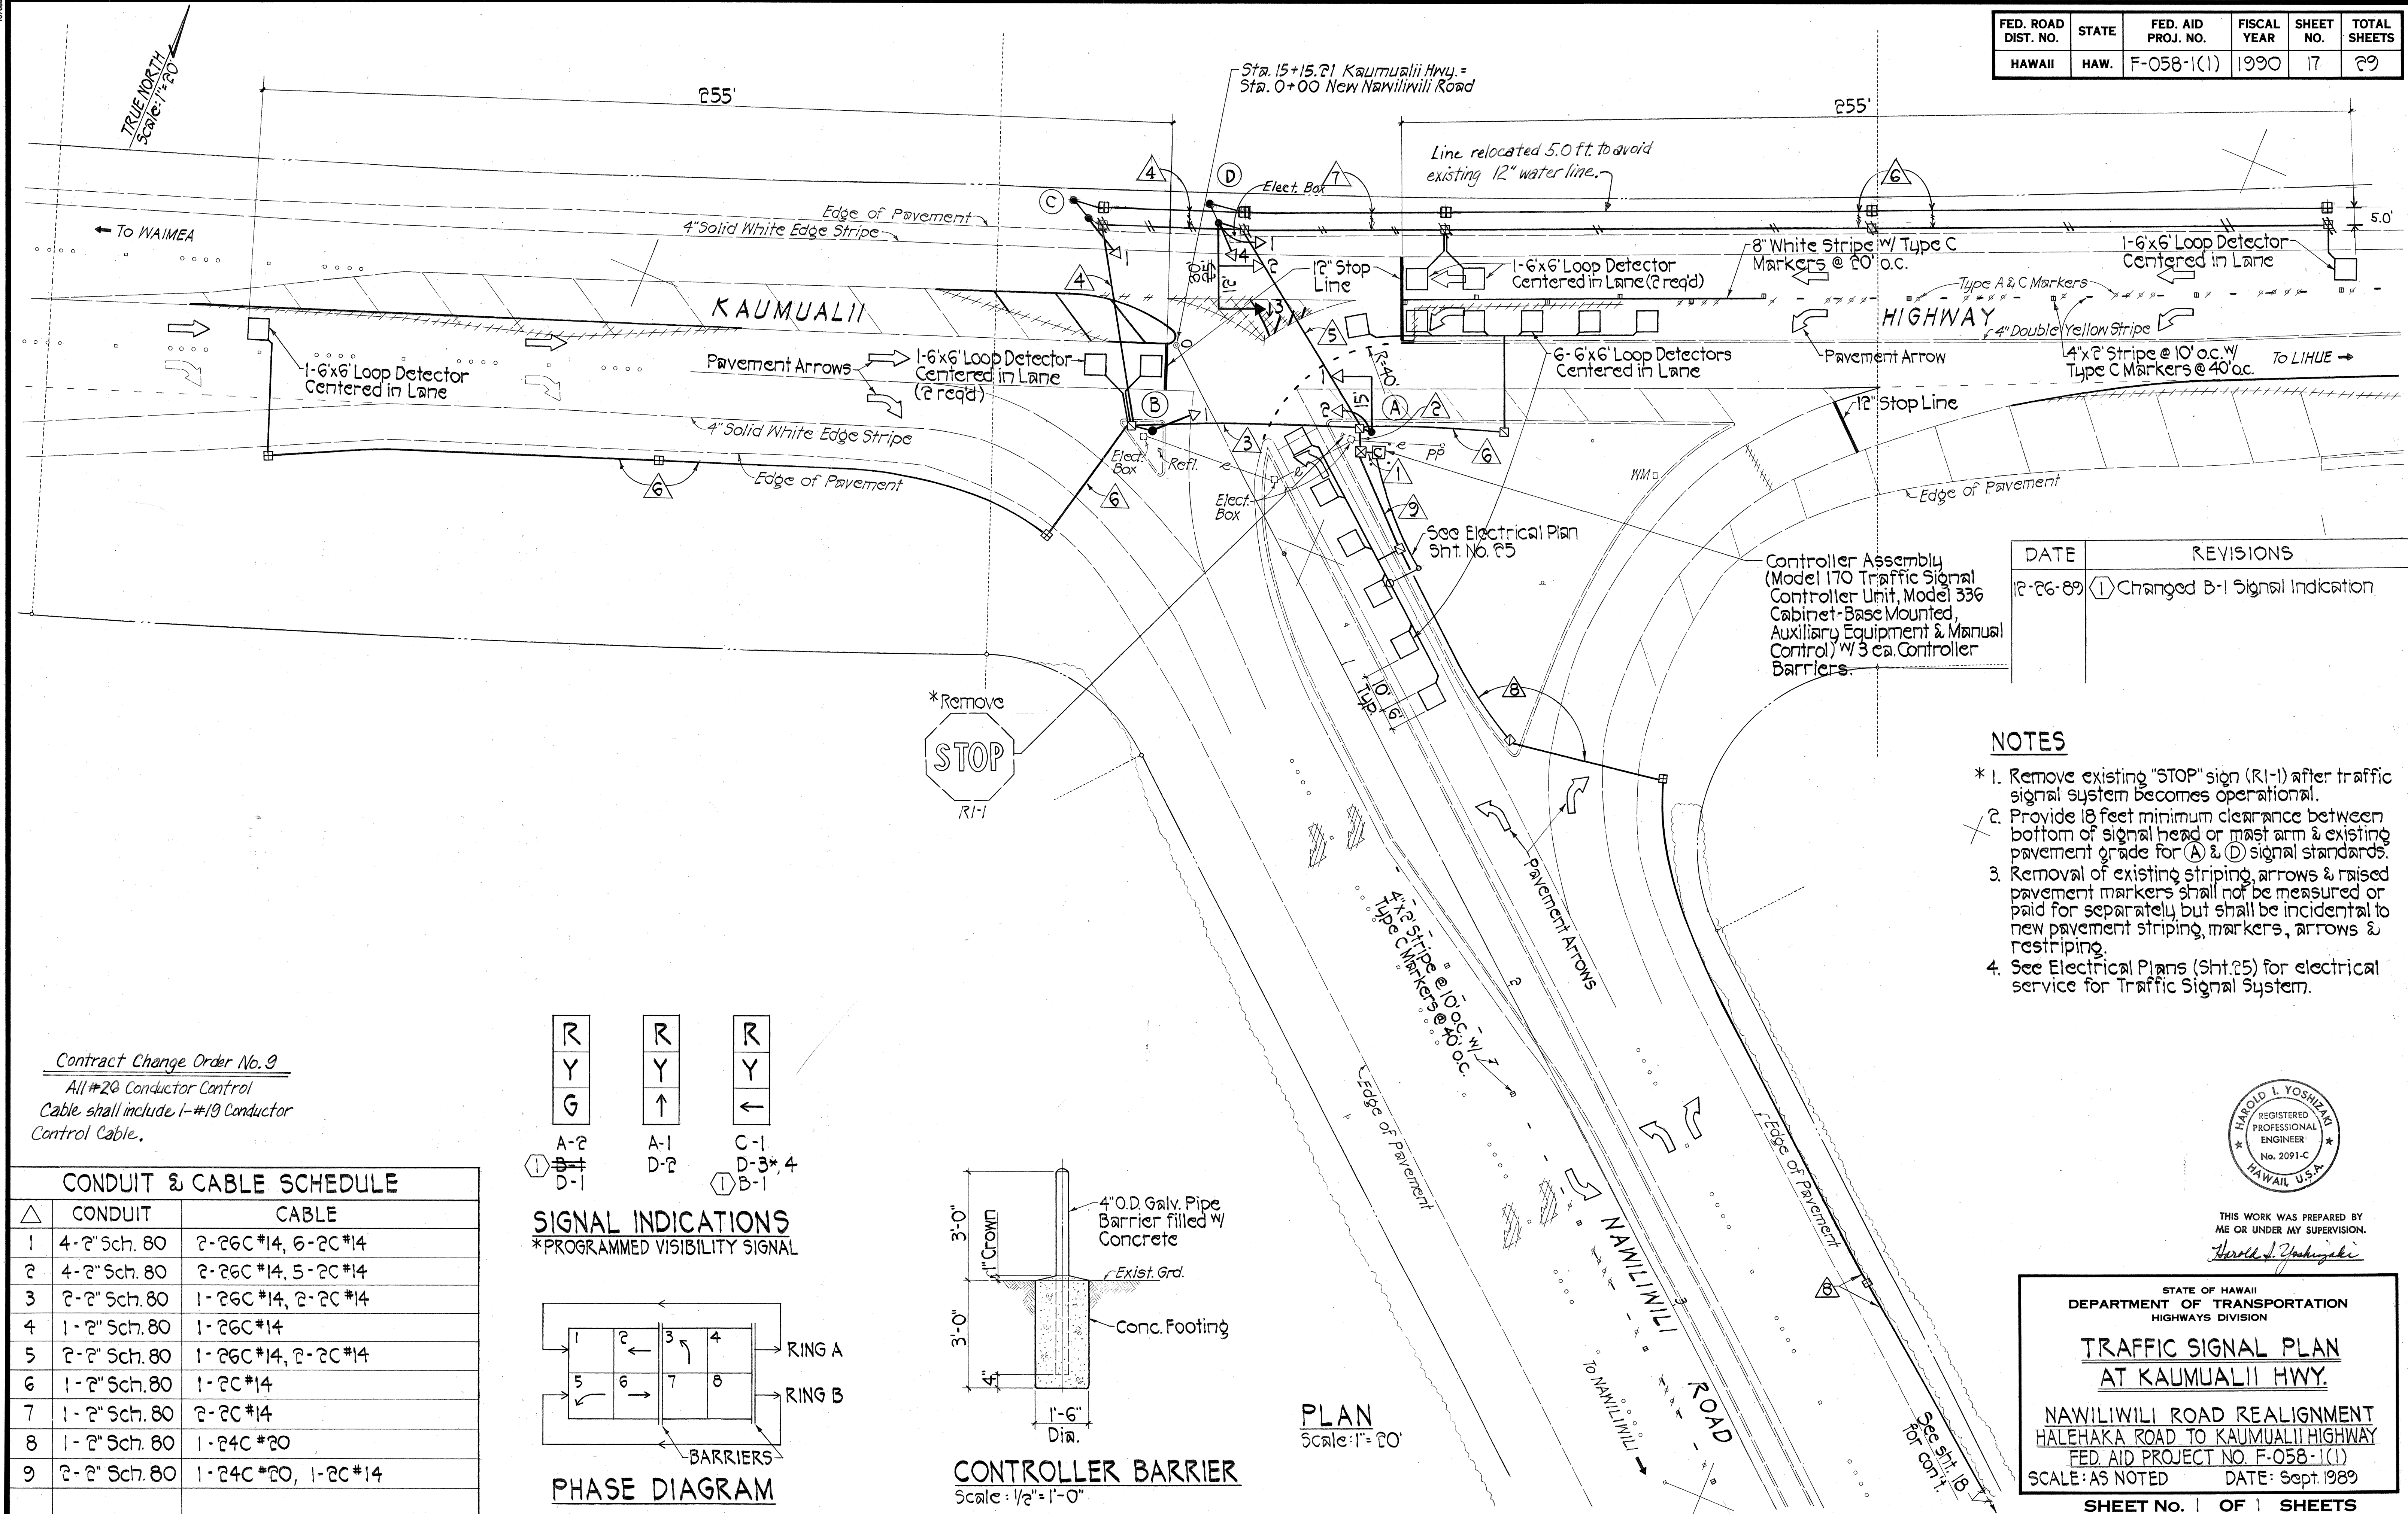



DATE	REVISIONS
12-26-89	① Changed B-1 Signal Indication.

- NOTES**
- * 1. Remove existing "STOP" sign (R1-1) after traffic signal system becomes operational.
 - 2. Provide 18 feet minimum clearance between bottom of signal head or mast arm & existing pavement grade for (A) & (D) signal standards.
 - 3. Removal of existing striping, arrows & raised pavement markers shall not be measured or paid for separately but shall be incidental to new pavement striping, markers, arrows & restriping.
 - 4. See Electrical Plans (Sht. 25) for electrical service for Traffic Signal System.

Contract Change Order No. 9
 All #20 Conductor Control
 Cable shall include 1-#19 Conductor
 Control Cable.

△	CONDUIT	CABLE
1	4-2" Sch. 80	2-26C #14, 6-2C #14
2	4-2" Sch. 80	2-26C #14, 5-2C #14
3	2-2" Sch. 80	1-26C #14, 2-2C #14
4	1-2" Sch. 80	1-26C #14
5	2-2" Sch. 80	1-26C #14, 2-2C #14
6	1-2" Sch. 80	1-2C #14
7	1-2" Sch. 80	2-2C #14
8	1-2" Sch. 80	1-24C #20
9	2-2" Sch. 80	1-24C #20, 1-2C #14

R	R	R
Y	Y	Y
G	↑	←
① A-2 D-1	A-1 D-2	C-1 D-3, 4 B-1

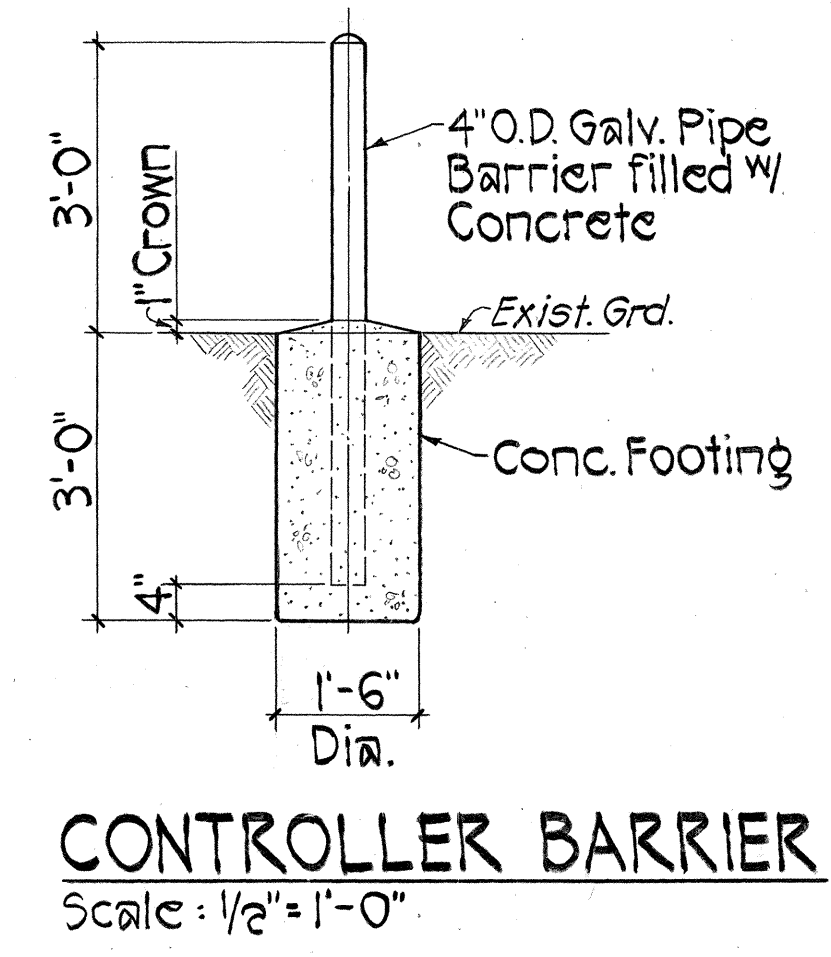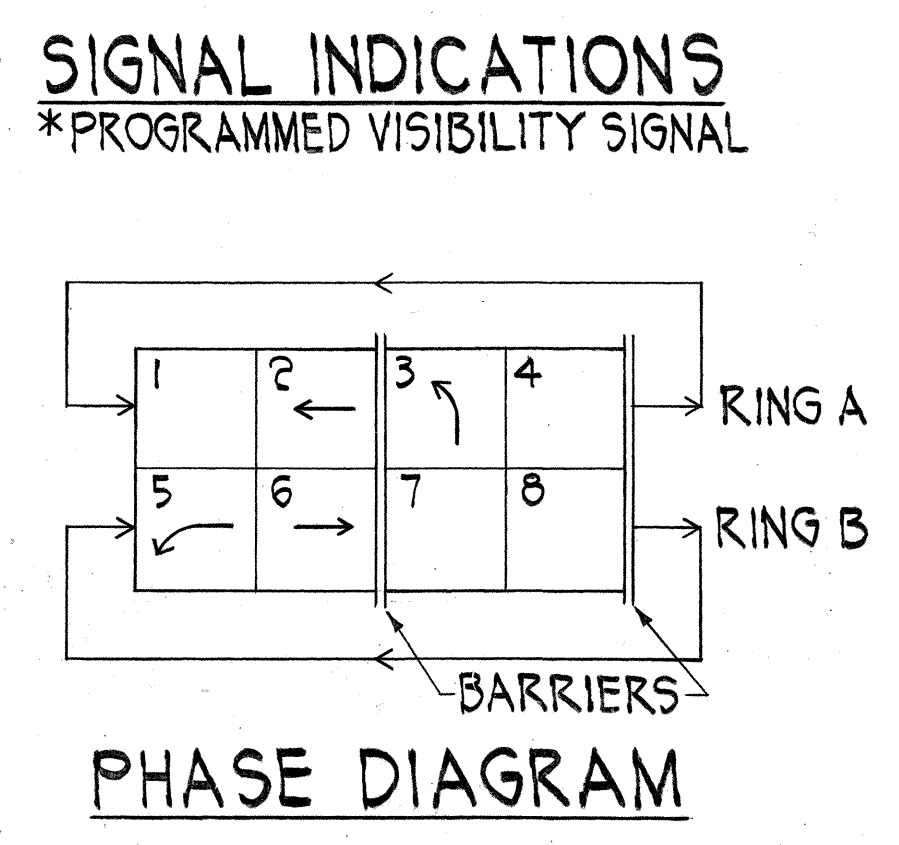

THIS WORK WAS PREPARED BY
ME OR UNDER MY SUPERVISION.
Harold I. Yoshizaki

STATE OF HAWAII
DEPARTMENT OF TRANSPORTATION
HIGHWAYS DIVISION

**TRAFFIC SIGNAL PLAN
AT KAUMUALII HWY.**

NAWILIWILI ROAD REALIGNMENT
HALEHAKA ROAD TO KAUMUALII HIGHWAY
FED. AID PROJECT NO. F-058-1(1)
SCALE: AS NOTED DATE: Sept. 1989

SHEET No. 1 OF 1 SHEETS

DATE	_____
SURVEY PLOTTED BY	_____
DRAWN BY	_____
DESIGNED BY	_____
CHECKED BY	_____
ORIGINAL PLAN	_____
NOTE BOOK	_____
NO.	_____