


FED. ROAD DIST. NO.	STATE	FED. AID PROJ. NO.	FISCAL YEAR	SHEET NO.	TOTAL SHEETS
HAWAII	HAW.	STP-050-1(9)	1995	11	29

ELECTRICAL SYMBOLS	
	250 High pressure sodium luminaire (I.E.S.M-N-III on light std. mtg. ht. 35'0" w/breakaway base)
	250 W high pressure sodium luminaire (I.E.S.M-N-IV on wood pole w/14'-0" bracket arm)
	Existing pole to remain (EP-Electric, TP-Telephone, ET/P Joint)
	New pole by Hawaiian Telephone Company
	Existing telephone pole to be relocated or removed by Hawaiian Telephone Company of Kauai
	Street light pullbox, (2' x 4') See sheet 14.
	Underground conduit per duct section as indicated
	Right-Of-Way demarcation line
	Duct section indicator
	Existing overhead electric lines
	Existing overhead telephone lines
	Relocated of new overhead telephone lines
	Overhead electric/telephone lines
	New/relocated, electric-telephone lines
	New overhead electric lines

- Notes:
- Contractor to provide & install all handholes, ductlines, & concrete bases for light standards.
  - Contractor shall furnish & install pole risers for conduit runs to electrical poles.
  - Spacing of street lights is shown on the plans.
  - Unless otherwise shown, concrete base for street light to be located 15' from the edge of travelway. (Typ.)
  - Telephone facilities :  
Removals and relocation work to be done by GTE Hawaiian Telephone Co.

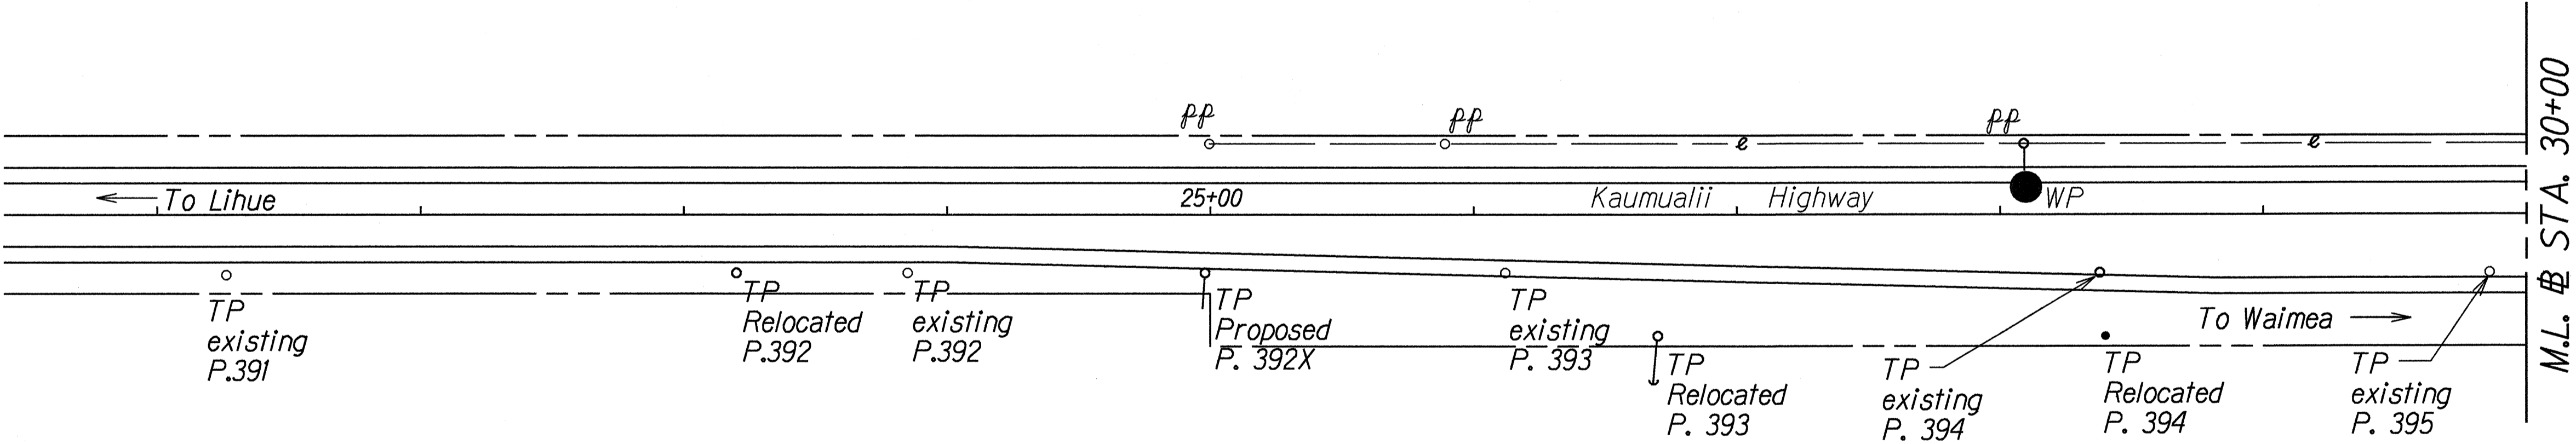

ORIGINAL PLAN	SURVEY PLOTTED BY	DATE
PLAN	DRAWN BY Gary Moulton	4/94
NOTE BOOK	DESIGNED BY S. Markwa	
REVISIONS	CHECKED BY	
REVISIONS	CHECKED BY	

STATE OF HAWAII  
DEPARTMENT OF TRANSPORTATION  
HIGHWAYS DIVISION


**ELECTRICAL PLAN**

KAUMUALII HIGHWAY IMPROVEMENTS  
AT HALEWILI ROAD  
Fed. Aid Proj. No. STP-050-1(9)

Scale: 1" = 40'      Date: Feb., 1995

SHEET No. 1 OF 2 SHEETS

FED. ROAD DIST. NO.	STATE	FED. AID PROJ. NO.	FISCAL YEAR	SHEET NO.	TOTAL SHEETS
HAWAII	HAW.	STP-050-1(9)	1995	12	29

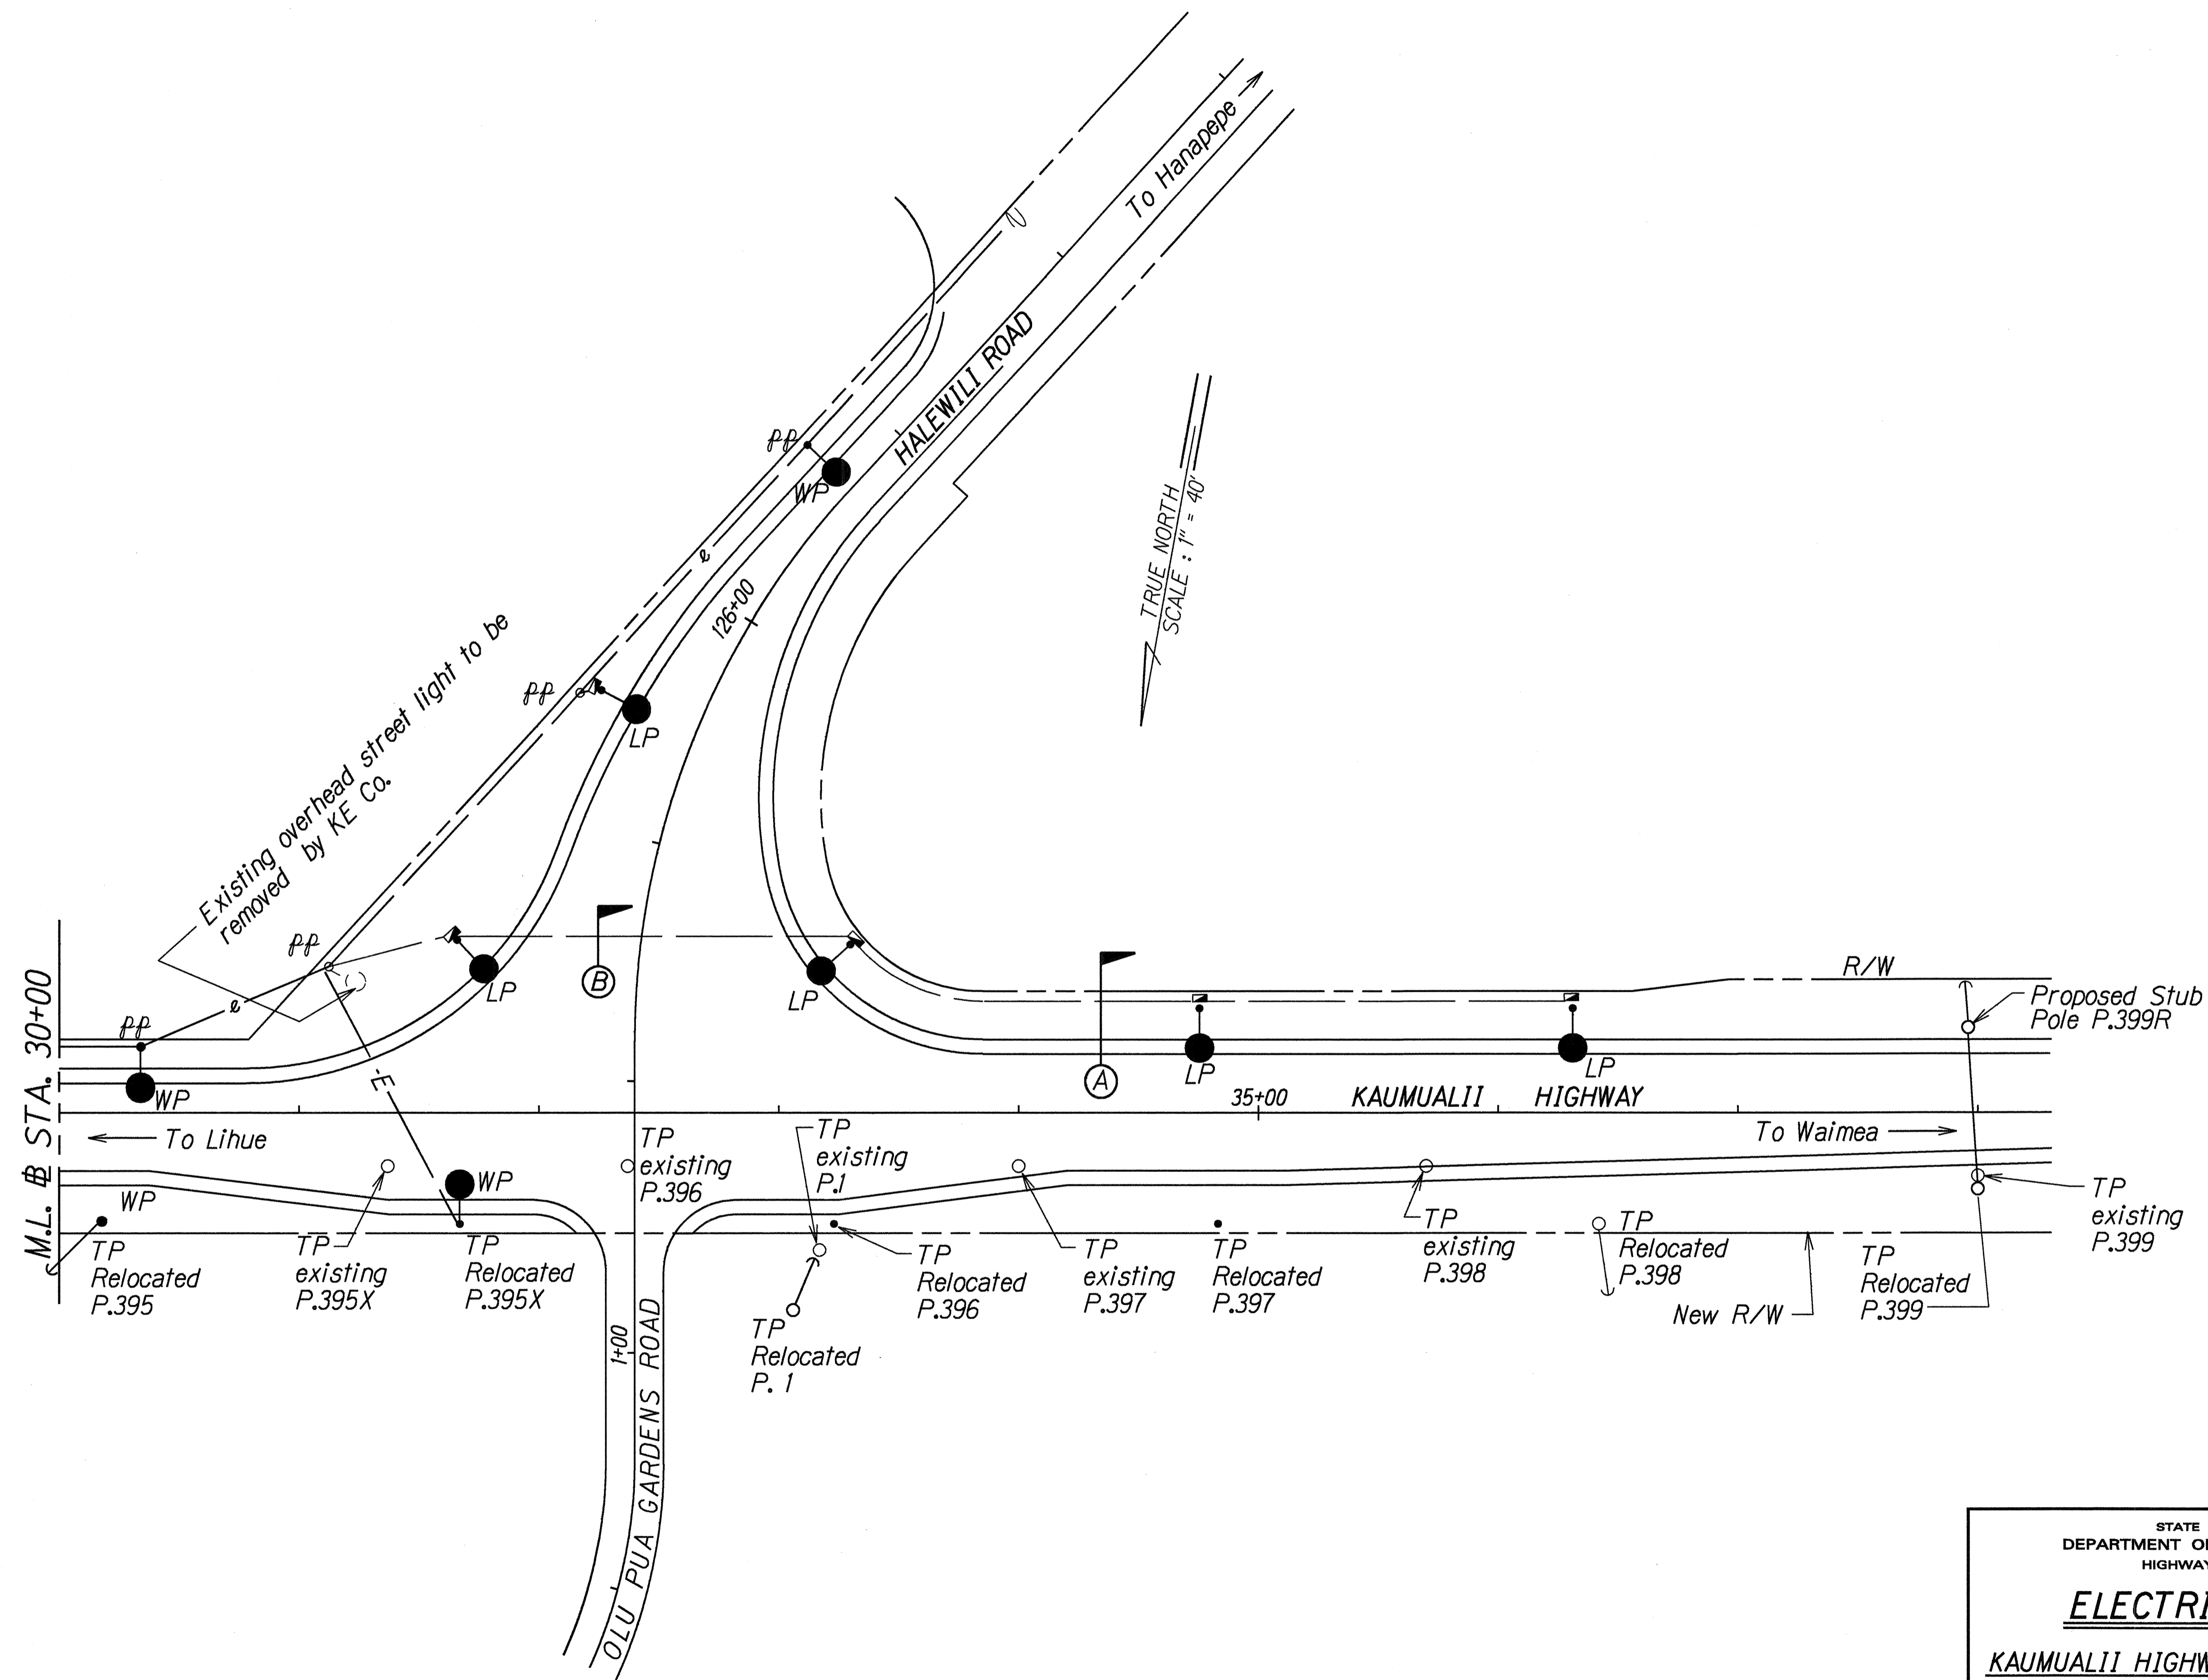

ORIGINAL PLAN	SURVEY PLOTTED BY	DATE
NOTE BOOK K22097	DRAWN BY Gary Moulton	4/94
CHECKED BY	TRACED BY S. Matkova	
	QUANTITIES BY	
	CHECKED BY	

STATE OF HAWAII  
DEPARTMENT OF TRANSPORTATION  
HIGHWAYS DIVISION

**ELECTRICAL PLAN**

**KAUMUALII HIGHWAY IMPROVEMENTS  
AT HALEWILI ROAD**

Fed. Aid Proj. No. STP-050-1(9)

Scale: 1" = 40' Date: Feb., 1995

SHEET No. 2 OF 2 SHEETS

