



FED. ROAD DIST. NO.	STATE	FED. AID PROJ. NO.	FISCAL YEAR	SHEET NO.	TOTAL SHEETS
HAWAII	HAW.	STP-0700 (43)	1998	134	141

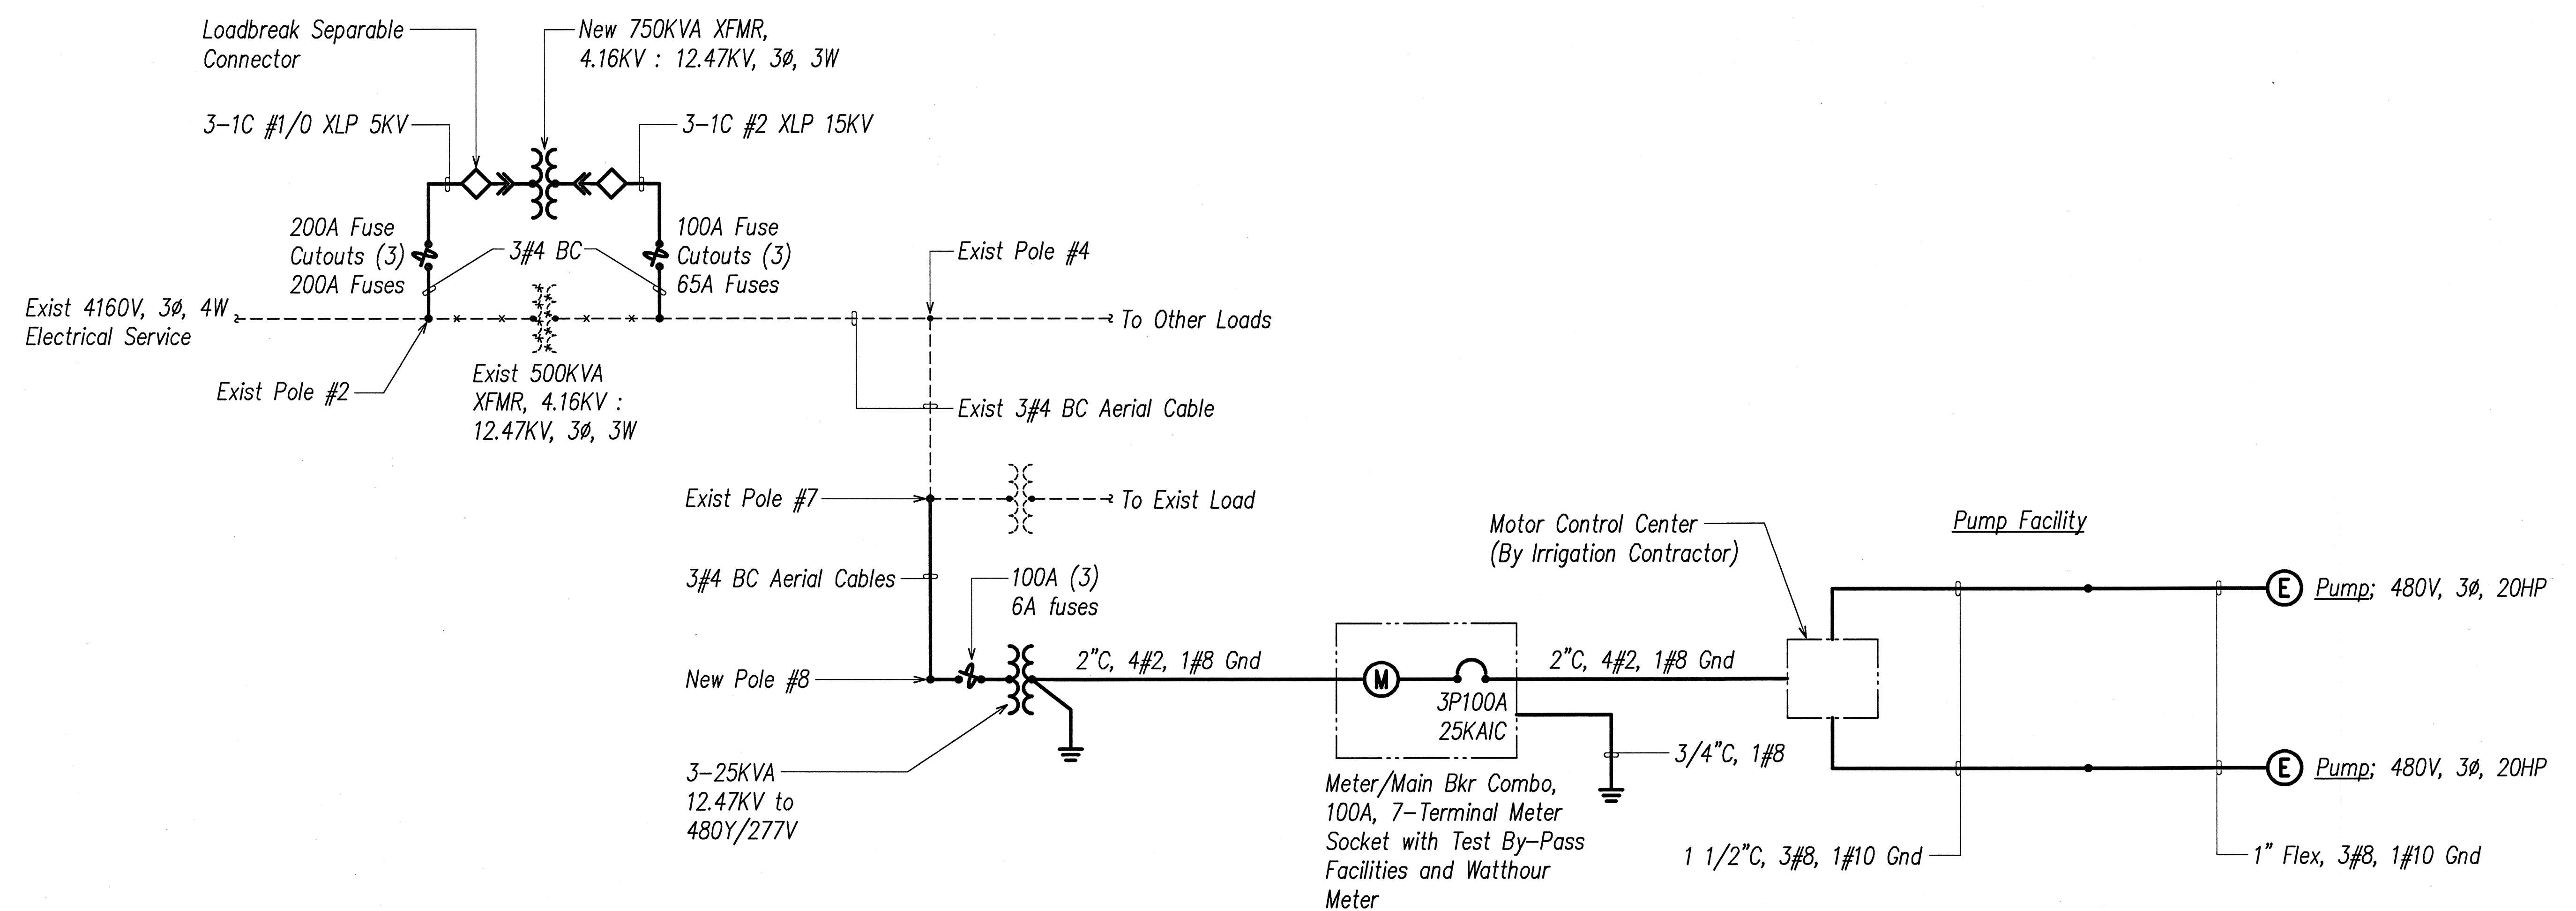

ELECTRICAL ONE-LINE DIAGRAM

DATE	10/1/98
SURVEY PLOTTED BY	...
DRAWN BY	...
DESIGNED BY	...
CHECKED BY	...
NOTE BOOK	...
No.	...

LAST REV. 10/1/98 BY 11/27/98 BY TM PLOT SC 11-02-11
Z:\MAD\PROJECTS\97\134\120042

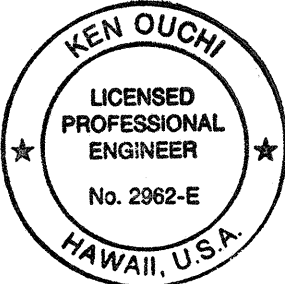

K. Ouchi
THIS WORK WAS PREPARED BY
ME OR UNDER MY SUPERVISION.

STATE OF HAWAII
DEPARTMENT OF TRANSPORTATION
HIGHWAYS DIVISION

ELECTRICAL DIAGRAM
IRRIGATION PUMP FACILITY

LIHUE GATEWAY LANDSCAPE
BEAUTIFICATION PROJECT

Scale: AS NOTED
Date: OCTOBER 1998
SHEET No. E-23 OF 30 SHEETS